


LEGEND	
	120V-20A-150W
	20A/15A
	150W/150VA
	150W/150VA
	150W/150VA
	150W/150VA
	150W/150VA

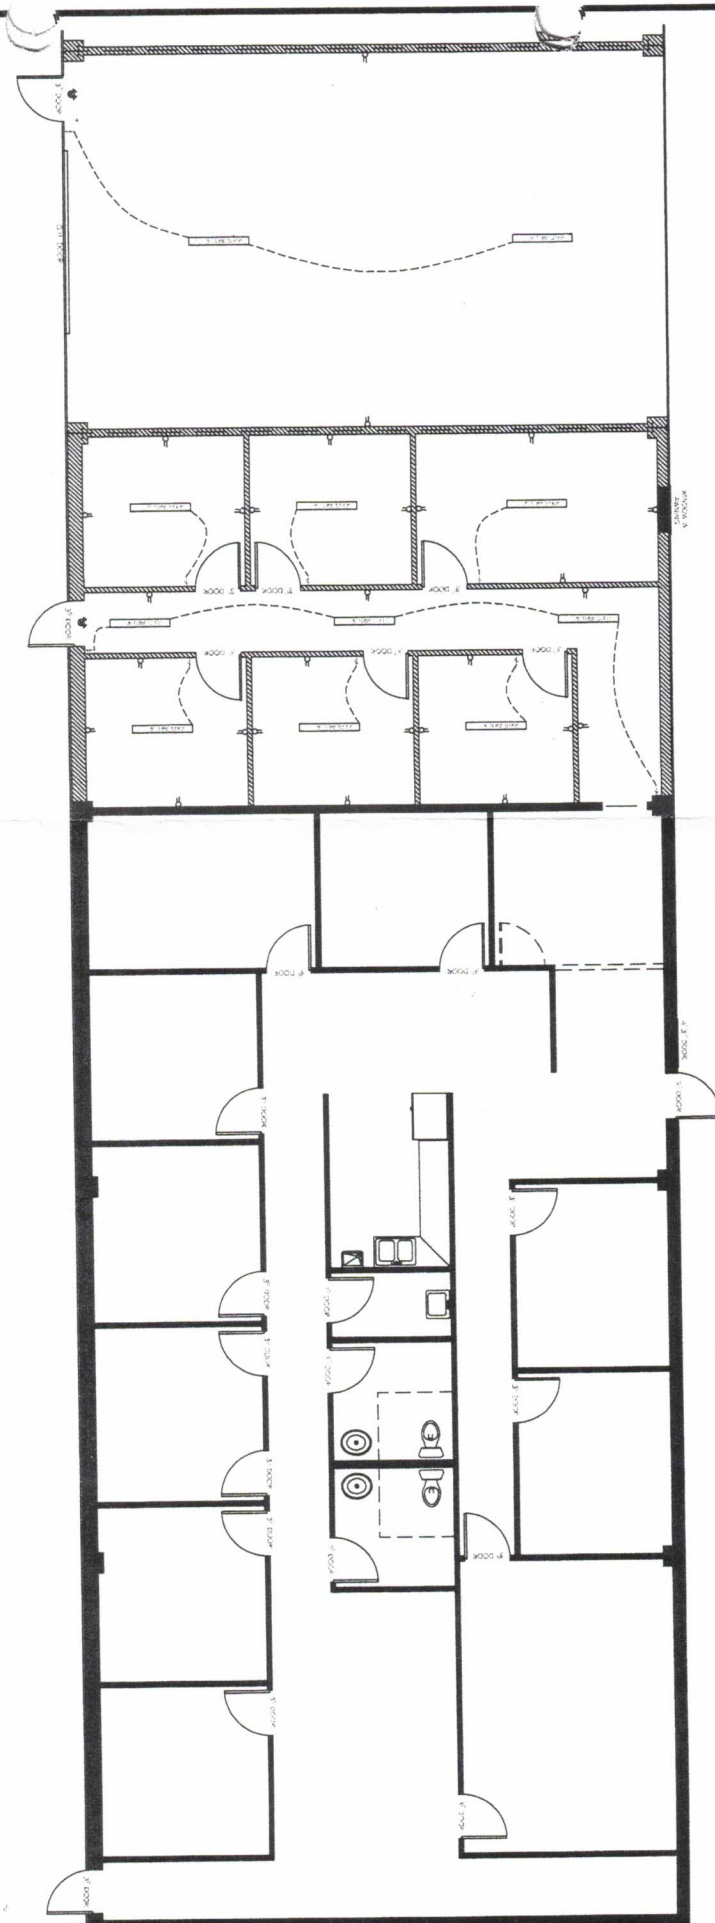

2 OF 4  
DATE: 05-22-18

GATEWAY RECRUITING ELECTRICAL LAYOUT  
KAYDEN PARK II - SUITE 109  
SCALE: 1/8" = 1'  
107 - 109