


SPRINKLERS								
QUANT.	SYMBOL	DESCRIPTION	TEMP.	K-FAC.	MAKE # MODEL	RESPONSE	SIN	COMMENTS
130	●	CONCEALED	165	5.6	RELIABLE G5-56	QUICK	RA3415	MEA # 258-93-E

NOTE: 1 SPRINKLER HEAD COVER 120 SQ.FT
SPRINKLER TABLE


SPRINKLERS		
FLOOR	CONCEALED	PENDENT
CELLAR	5	0
FIRST	125	0
TOTAL	130	0

SYMBOL LIST:	
SYMBOL	DEFINITION
—	STANDPIPE OR SPRINKLER PIPING
⌚	HEAT TRACED PIPING
●	CONCEALED SPRINKLER
○	UPRIGHT SPRINKLER
▶	SIWALL SPRINKLER
⊙	PENDENT SPRINKLER
∠	CHECK VALVE
OS#Y	OS#Y VALVE
Z	BUTTERFLY VALVE
⊠	SOLENOID VALVE
⊠	FLOOR CONTROL VALVE ASSEMBLY
⊠	2-1/2" FIRE HOSE VALVE, CHAIN & CAP
⊠	5 X 3 X 3 SIAMESE CONNECTION
⊠	BACKFLOW PREVENTER
⊠	PUMP
⊠	PRESSURE GAUGE

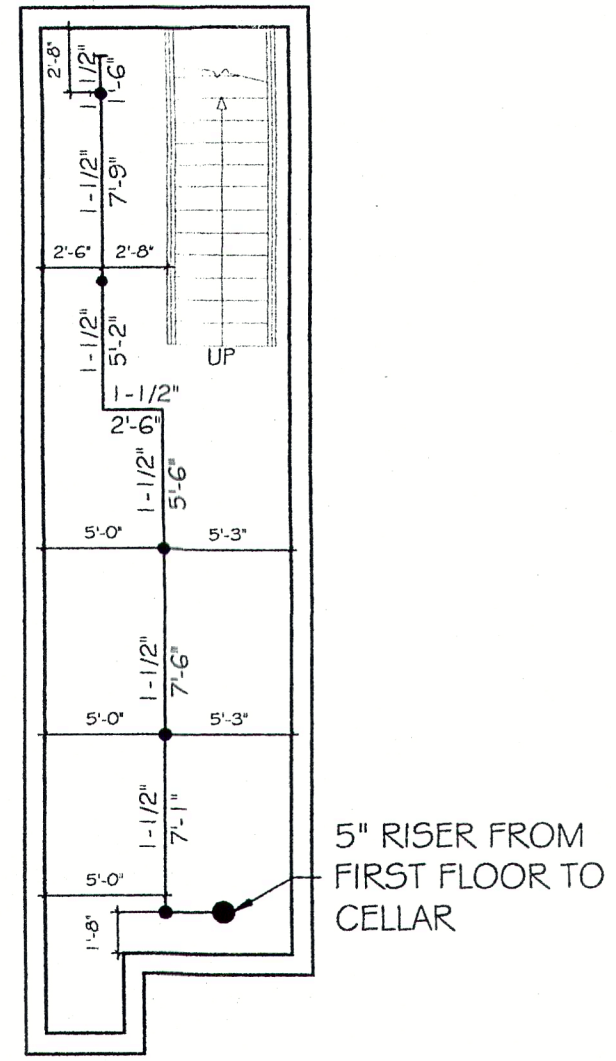

CELLAR FLOOR PLAN

SCALE: 1/8"=1'

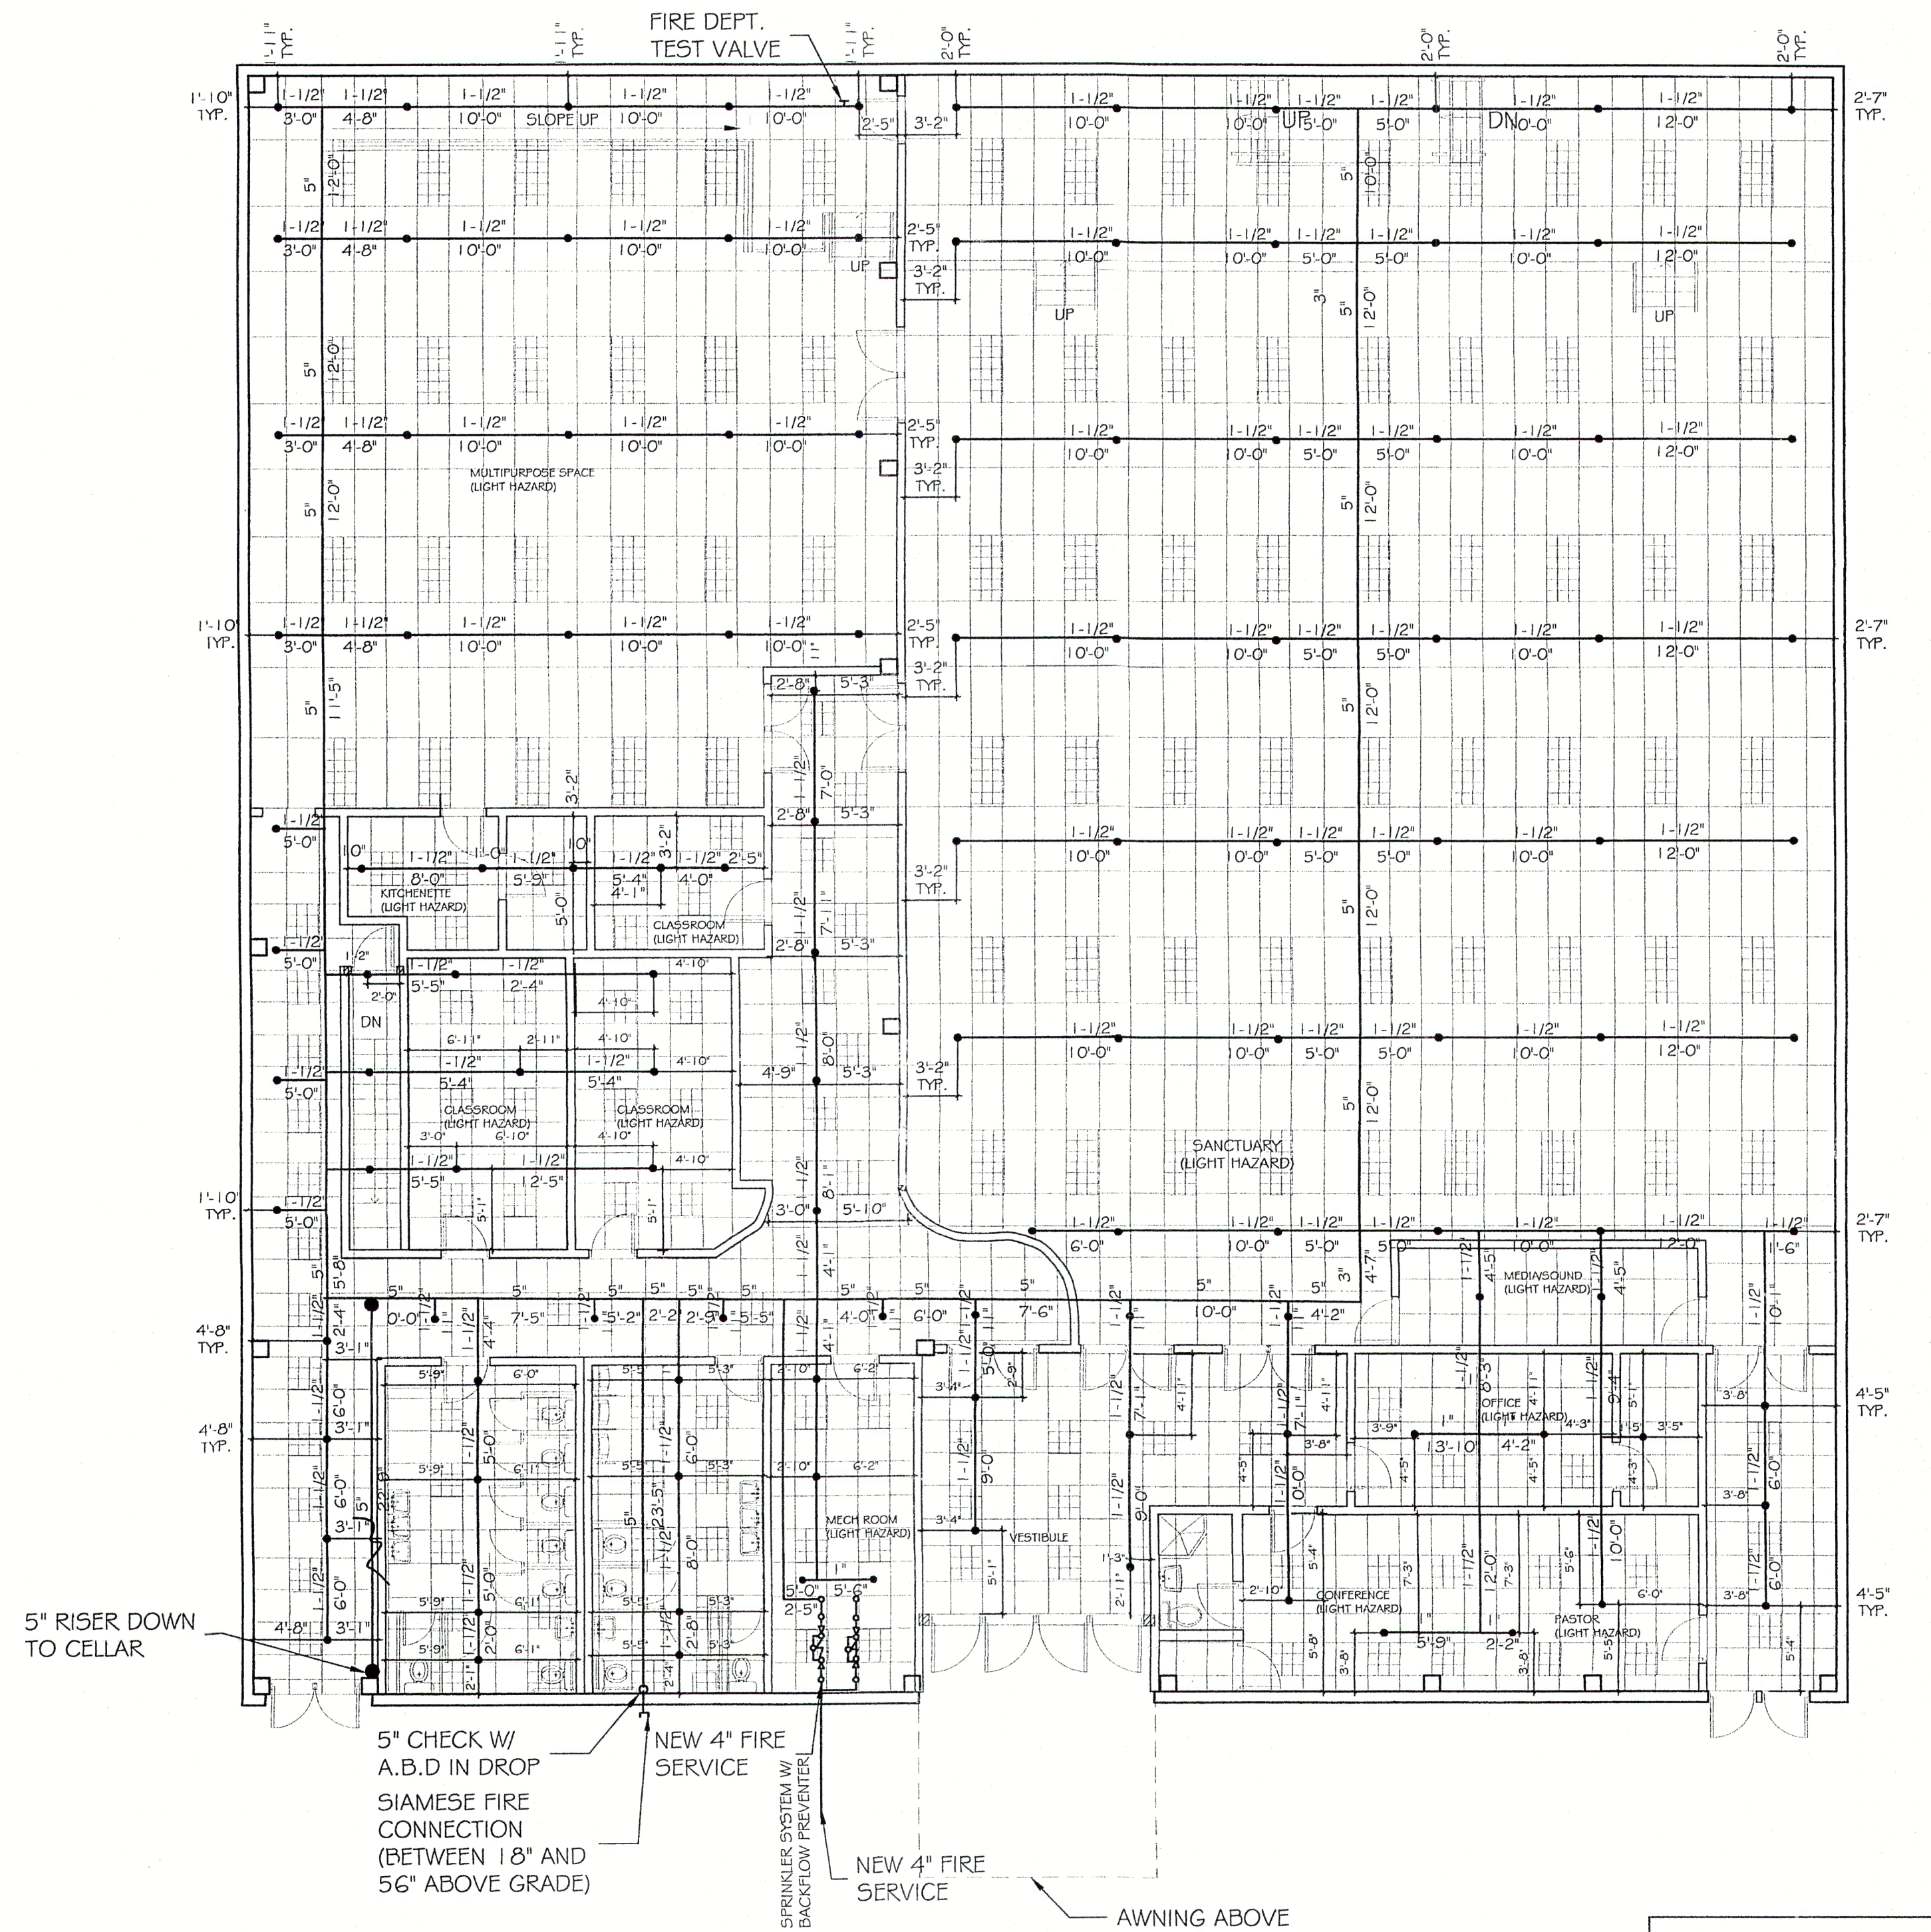

FIRST FLOOR PLAN


SCALE: 1/8"=1'

DOB STAMP:

ACCEPTABLE FOR PERMIT
UNDER DIRECTIVE NO. 14/75

AUG 01 2019

BOUBA CAR SOW

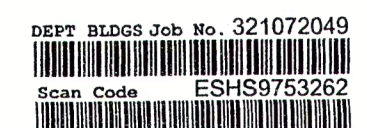

SCOPE OF WORK NEW FIRE SPRINKLER SYSTEM IN CONJUNCTION WITH ALT 1 APPLICATION 320548494.	WORK TYPE SP. PL.	CONTROLLED INSPECTION TRI-SPECIAL INSPECTION CATEGORIES - SPRINKLER SYSTEM CODE/SECTION: BC 1704.22 - FIRE PENETRATIONS CODE/SECTION: BC 1704.27	LEGEND 	H G LEE ARCHITECT P.C. DESIGN • ENGINEERING • INTERIORS CONSTRUCTION SUPERVISION 34-16 149TH STREET, FLUSHING, NY 11354 TEL: (718)461-9100 FAX: (718)460-0843	SEAL: 	ARCHITECT ASSUMES NO RESPONSIBILITY FOR ANY WORK FROM APPROVED PLANS THE CONTRACTOR MUST OBTAIN WRITTEN APPROVAL FOR ANY CHANGES FROM ARCHITECT BEFORE COMMENCING SUCH WORK	LOCATION: 471 UTICA AVE	SCALE: AS NOTED
		TRI-PROGRESS INSPECTIONS CATEGORIES - ENERGY CODE COMPLIANCE INSPECTIONS, BC 110.3.5					BLOCK # 4591 LOT # 63 ZONE # C8-2 MAP# 17B	DATE: 8/01/19
DRAWING TITLE: LEGEND, CELLAR FLOOR PLAN, FIRST FLOOR PLAN							DRAWN BY: J.M.	
							FLOOR #:	
							DRAWING No:	
							SP-002.00	
							SHEET No. 2 of 5	