

KEY NOTES

18710
HAMILTON POOL
DRIPPING SPRINGS, TX

JMA
10804 RUSH ROAD #4
AUSTIN, TEXAS 78732
512-965-1201

LEGEND

- FA

FIRE ALARM PULL
- ⊕

WALL MOUNTED, SINGLE RECEPTACLE
- ⊕

WALL MOUNTED, DUPLEX RECEPTACLE
- ⊕

WALL MOUNTED, QUADRAPLEX RECEPTACLE
- ▼

WALL MOUNTED, VOICE/DATA RECEPTACLE

Issue	Date & Issue Description	By	Check
01	12.06.22	JFM	JFM
EXISTING CONDITIONS			

EXISTING POWER AND COMMUNICATION PLAN - LEVEL 01

SHEET NOTES

Seal/Signature

RELEASED UNDER THE AUTHORITY OF
JOHN F MAPES, #19114
NOT FOR CONSTRUCTION OR
REGULATORY APPROVAL

Project Name
18710 HAMILTON POOL ROAD



Project Number
2022047
CAD File Name

Description
EXISTING POWER AND COMMUNICATION PLAN - LEVEL 01

Scale
1/8" = 1'-0"

A03.01

©2022 JOHN MAPES ARCHITECTS

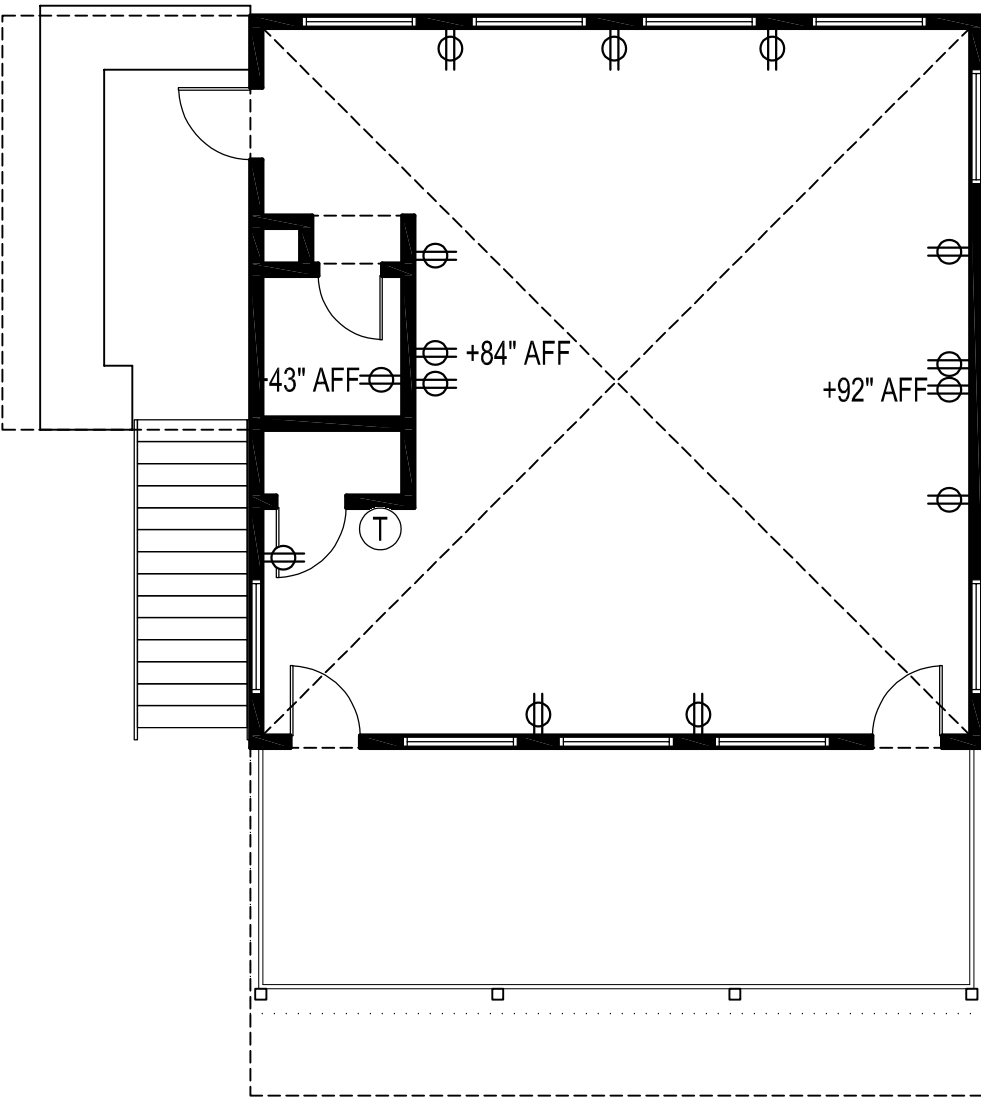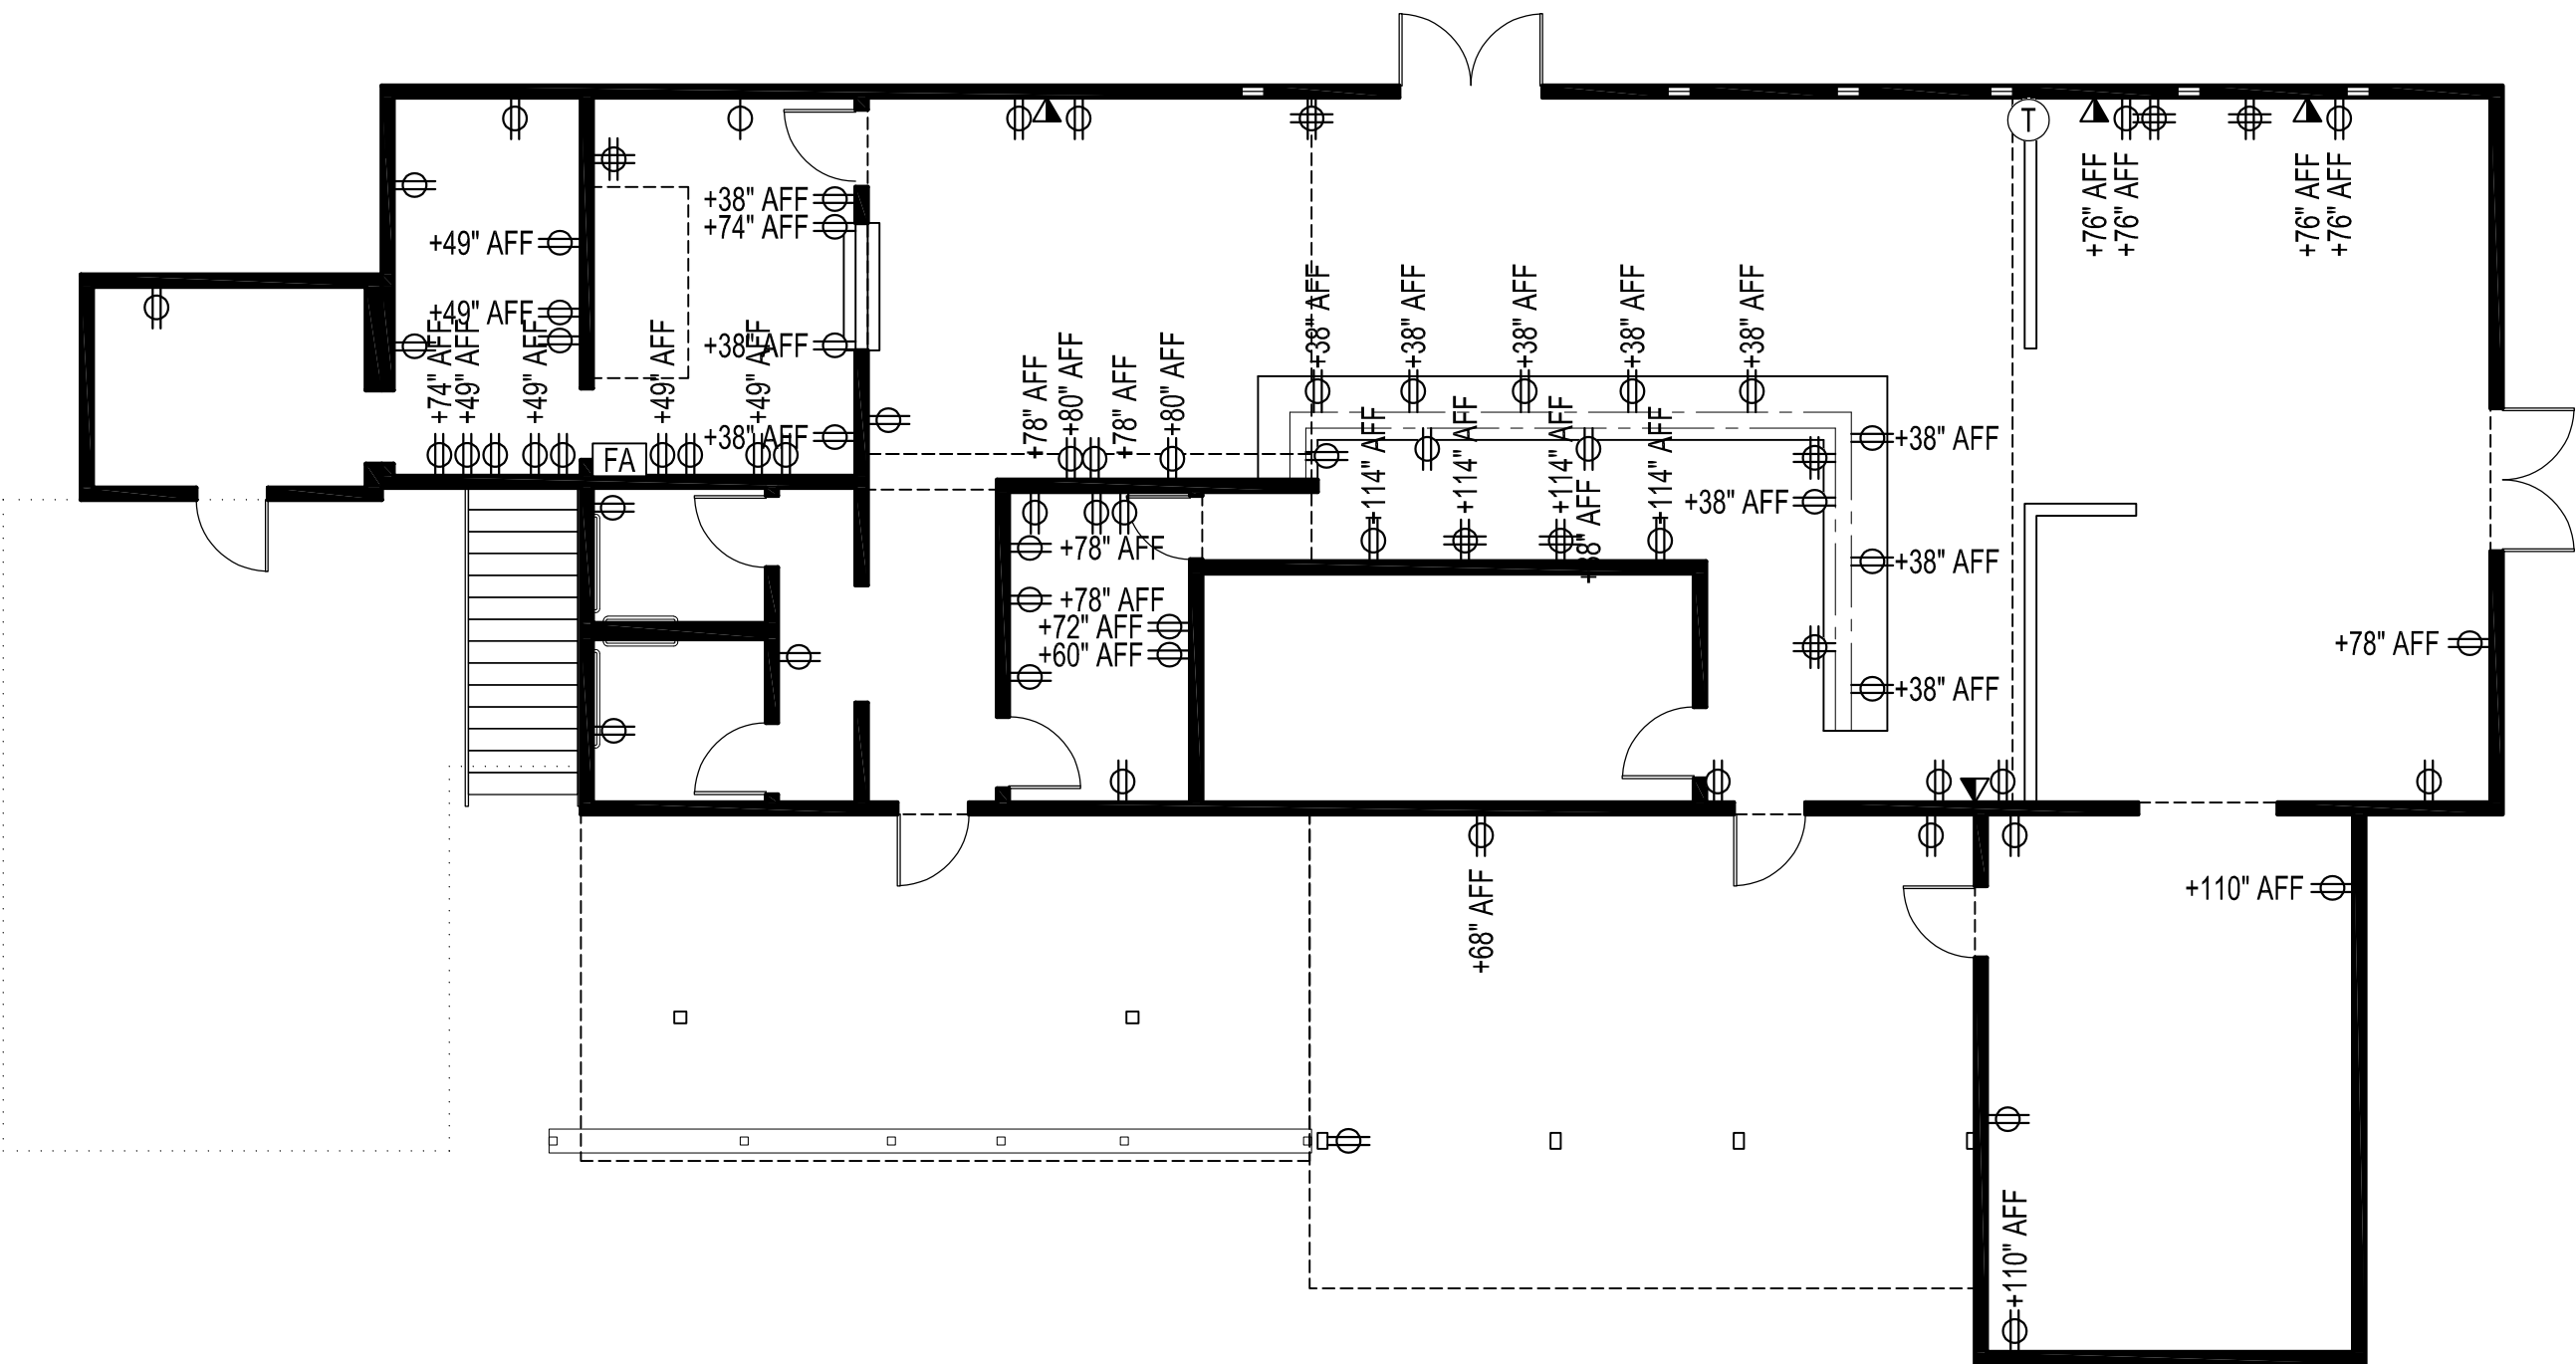

EXISTING POWER AND COMMUNICATION PLAN - LEVEL 02