



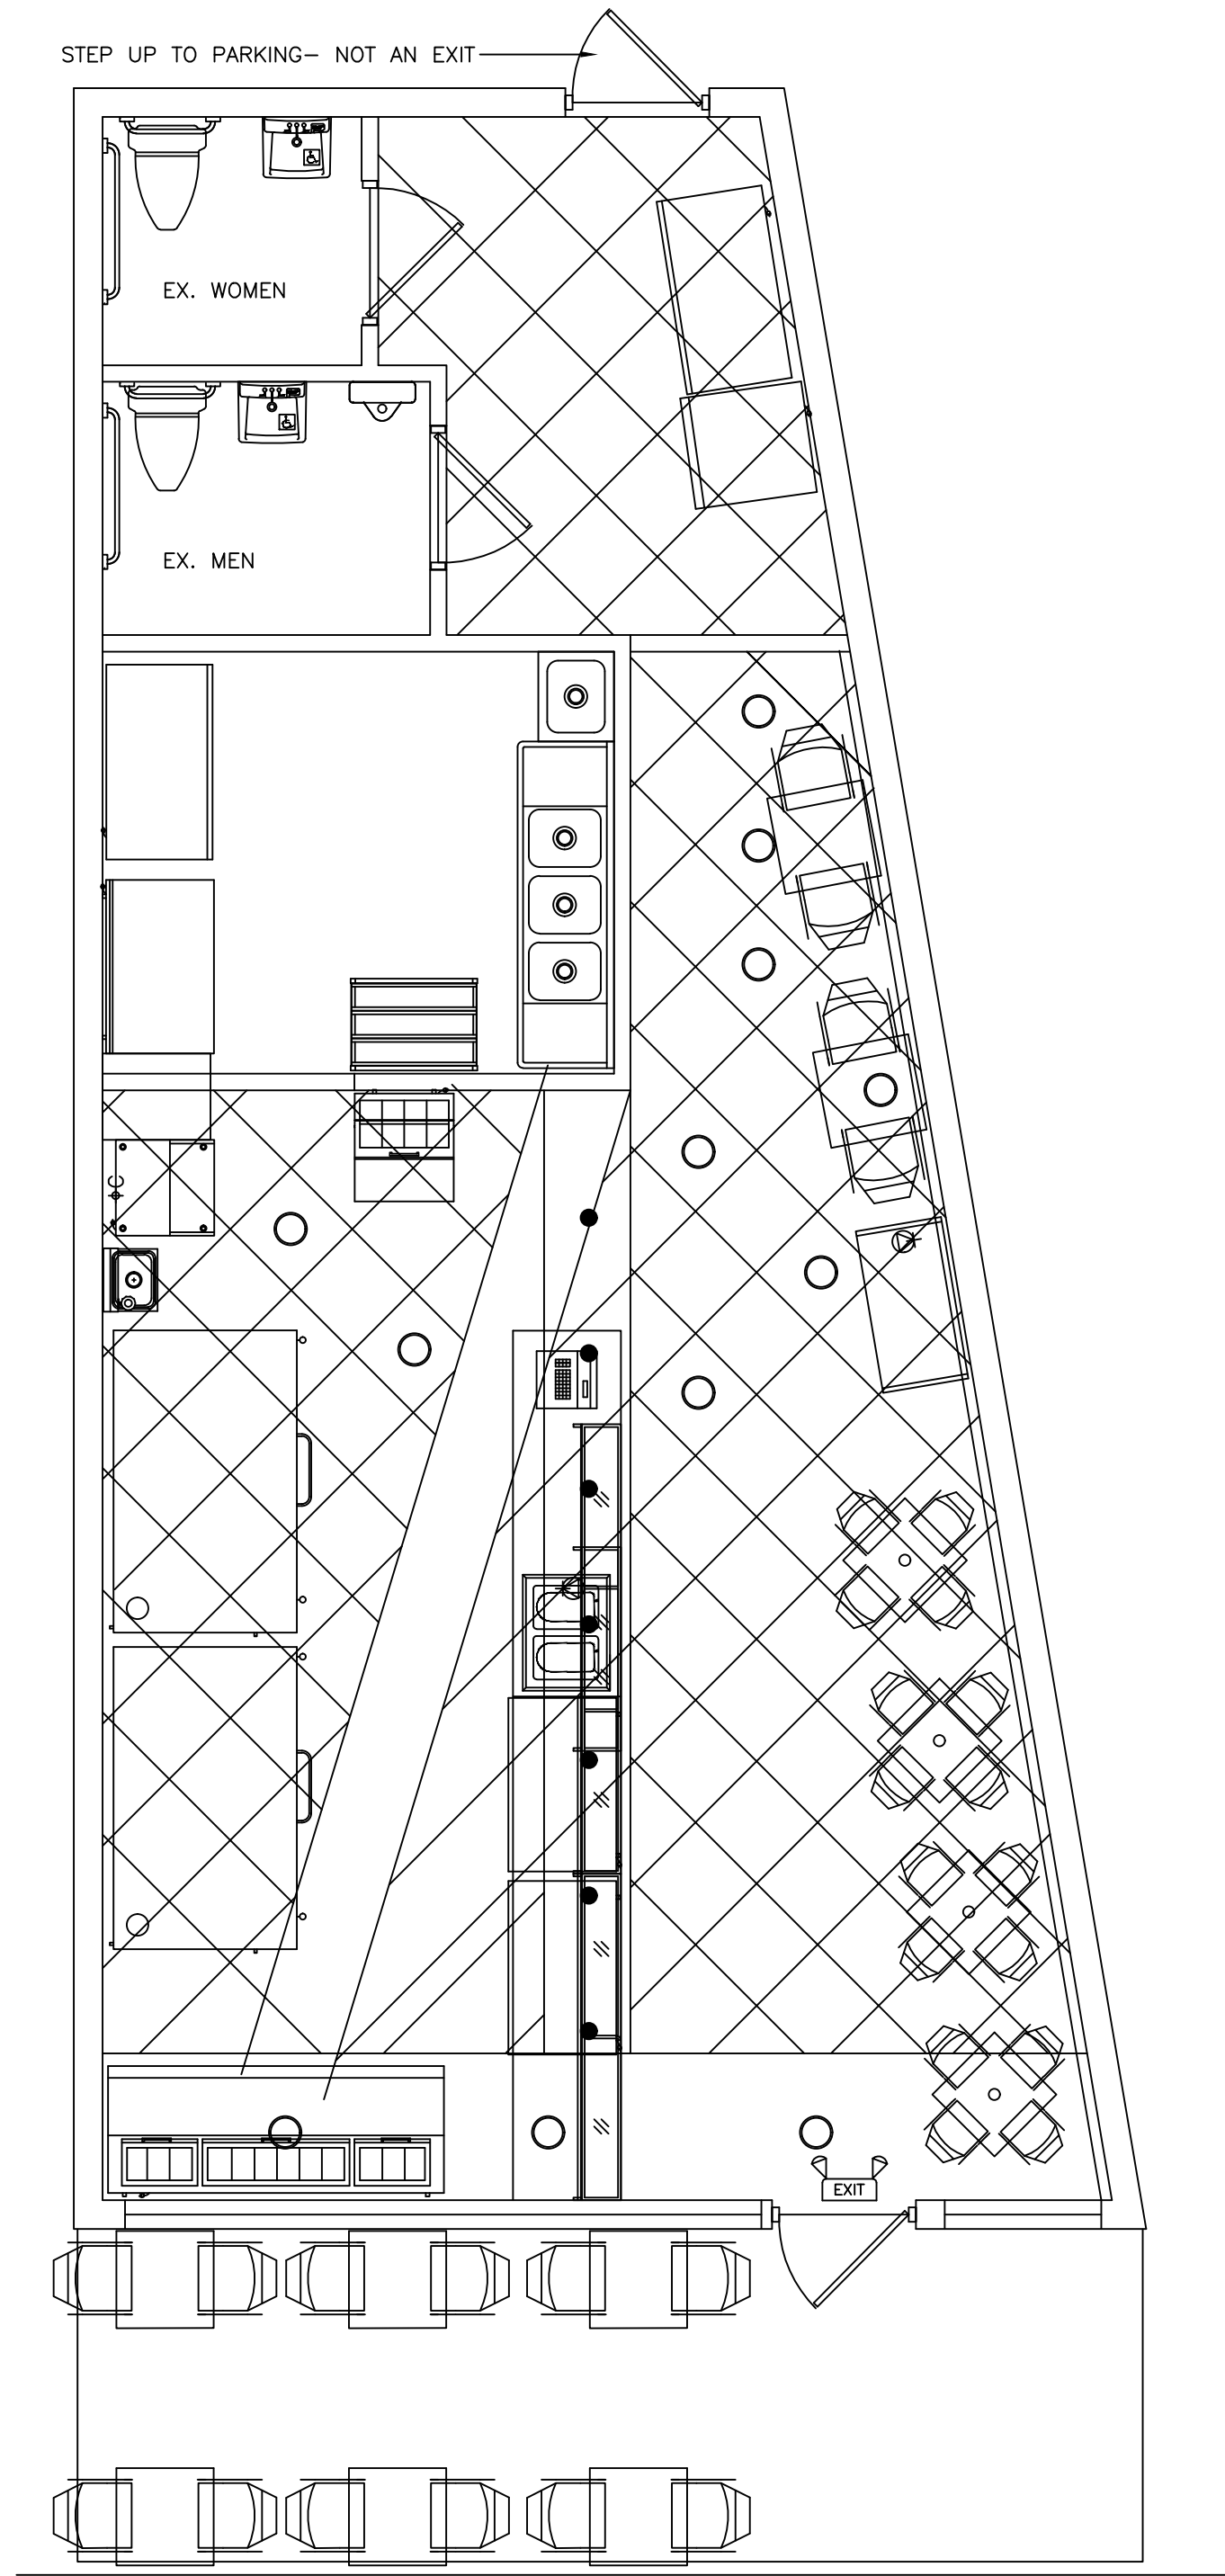

ELECTRICAL PLAN

1/4"=1'-0"

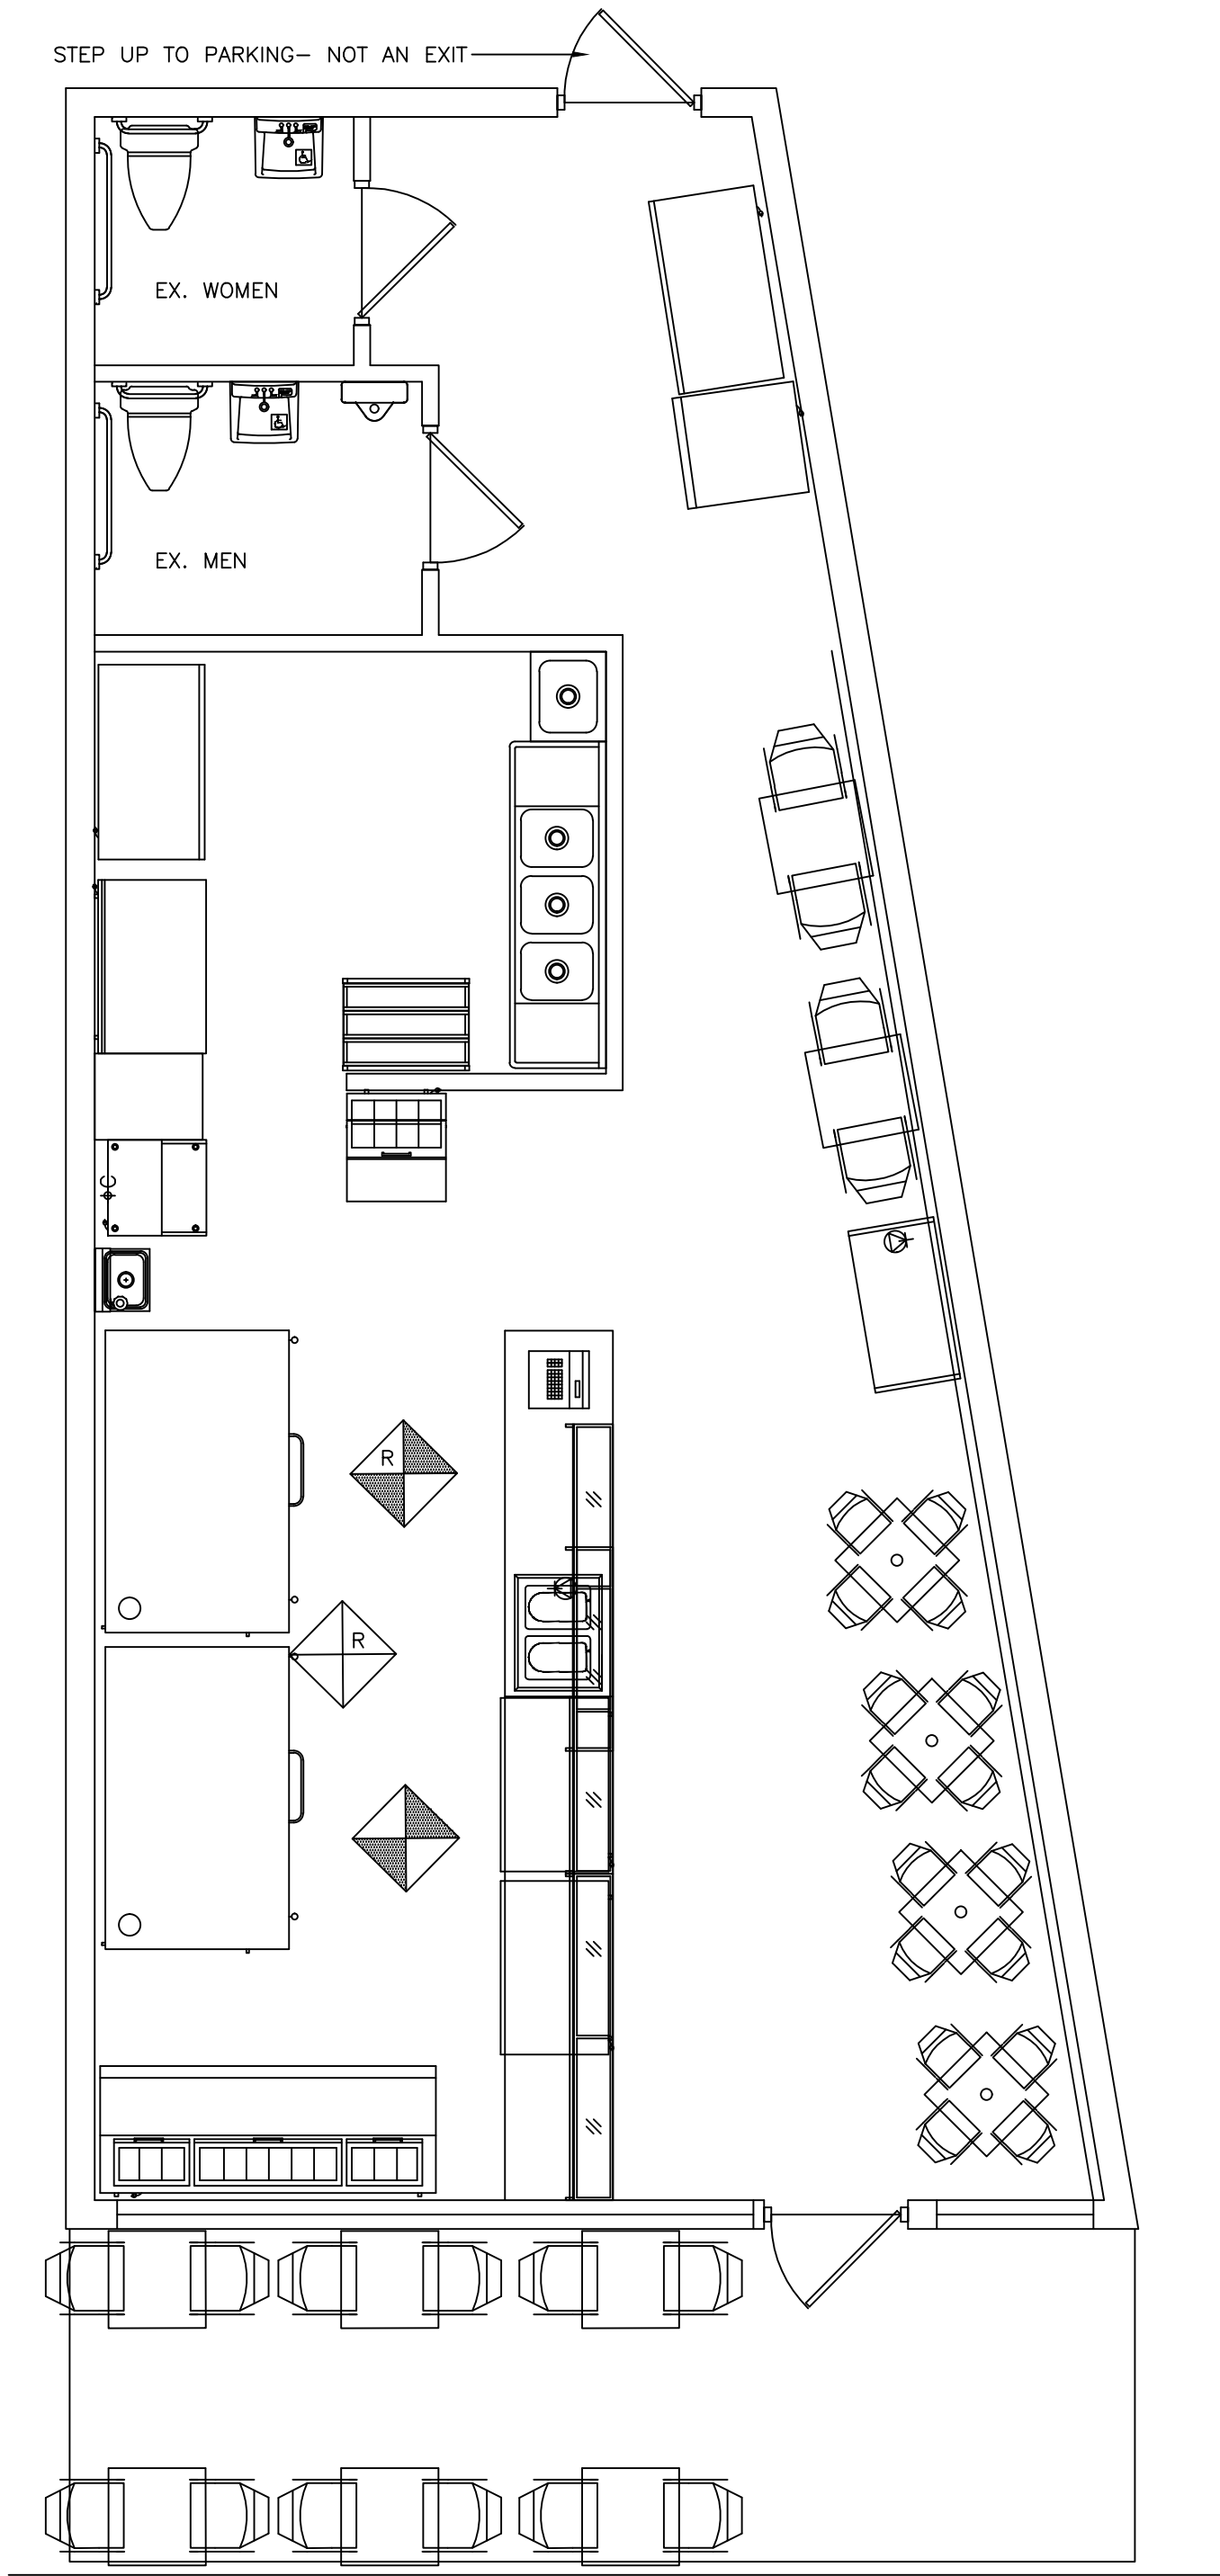

MECHANICAL PLAN

1/4"=1'-0"

SYMBOL LIST

- EXISTING 75W RECESSED DOWNLIGHTS
- NEW 50w MR 16 SURFACE CAN
- EXIT BATTERY BACKUP EXIT FLOOD

SYMBOL LIST

- RELOCATED MAKE-UP AIR DIFFUSER
- RELOCATED SUPPLY AIR DIFFUSER
- EXISTING RETURN
- EXISTING SUPPLY DIFFUSER

- SCOPE OF WORK:
1. REPLACE EXISTING FRONT SLIDING GLASS DOORS WITH NEW IMPACT RATED FIXED STOREFRONT.
 2. APPLY 3"x6" "SUBWAY" TILE TO FRONT OF EXISTING FACADE.
 3. INSTALL CANVAS AWNING OVER FRONT FACADE. UNDER SEPARATE PERMIT.

THIS DRAWING IS AN INSTRUMENT OF SERVICE AND AS SUCH SHALL REMAIN THE PROPERTY OF THE METRO DESIGN GROUP. UNAUTHORIZED USE OR REPRODUCTION WITHOUT WRITTEN PERMISSION OF THE METRO DESIGN GROUP IS PROHIBITED. THIS DRAWING IS FOR USE IN CONNECTION WITH THIS PROJECT AND SHALL NOT BE USED FOR ANY OTHER LOCATIONS. COPYRIGHT 12K2 METRO DESIGN GROUP

PIZZA GIRLS RENOVATIONS
114 CLEMATIS ST.
WEST PALM BEACH, FLORIDA 33401

REVISIONS:

DATE: 01JUL09
DRAWN: SLM/PTR
ACADFILE: PIZZAGIRLS_

SHEET #
2.0MEP
OF
1