

3600 West Main
Suite 200
Norman, Oklahoma
73072
405.364.4400 P
405.364.4287 F
tmapartn.com

Copyright © 2008 The McKinney Partnership Architects, P.C., All Rights Reserved

Sheet:

Project:

Tilted Kilt Pub & Eatery
26520 Ynez Road
Temecula, CA



Issue Date:
02/05/10 PERMIT SET

Revisions:

Project Number:
TK13109

Sheet Title:
LIFE SAFETY PLAN

Sheet Number:

LSF1.0

RESTAURANT BUILDING OCCUPANCY:

2,272 S.F. – DINING AT 1/15 NET S.F., OCCUPANCY = 152
326 S.F. – BAR STANDING AT 1/5 NET S.F., OCCUPANCY = 66
138 S.F. – WAITING AT 1/5 NET S.F. + SPACE FOR 6 ON BENCHES,
OCCUPANCY = 34
184 S.F. – BAR SEATING AT 1/7 NET S.F., OCCUPANCY = 27
715 S.F. – STORAGE/COOLERS/LIQUOR AT 1/300 GROSS S.F.,
OCCUPANCY = 3
106 S.F. – OFFICE AT 1/100 GROSS S.F., OCCUPANCY = 2
82 S.F. – LOCKER AT 1/90 GROSS S.F., OCCUPANCY = 2
1,423 S.F. – KITCHEN AT 1/200 GROSS S.F., OCCUPANCY = 8
TOTAL OCCUPANCY = 294

3 TOTAL MEANS OF EGRESS FROM RESTAURANT

ALL EXITS ARE TO BE PROVIDED WITH EMERGENCY LIGHTING. REFER MEP PLANS
FOR DETAILS.
= DESIGNATED AS ACCESSIBLE SEATING. ALL ACCESSIBLE TABLE SEATING
HEIGHTS ARE TO BE BETWEEN 28" AND 34".
FOR TOILET ACCESSIBILITY PLANS, REFER SHEET A.7.1.

MAIN ACCESSIBLE CIRCULATION AREAS BORROWING
DINING AREAS – MUST REMAIN A MINIMUM OF 44" CLR.
WIDTH

RESTAURANT PATIO OCCUPANCY:

2,216 S.F. – DINING AT 1/15 NET S.F., OCCUPANCY = 148
50 S.F. – BAR SEATING AT 1/7 NET S.F., OCCUPANCY = 8
TOTAL PATIO OCCUPANCY = 156

GENERAL NOTES:

REFER TO CODE INFORMATION TABLE ON SHEET A.0.0 FOR DETAILED CODE
CALCULATION INFORMATION. REFER TO SHEET A.0.1 FOR ADDITIONAL GENERAL
NOTES, FIRE NOTES, AND ACCESSIBILITY NOTES.

FE = FIRE EXTINGUISHER MOUNTED ON WALL HOOK

REFER MEP PLANS FOR LOCATIONS OF FIRE ALARM HORN / STROBE LOCATION
AND MANUAL PULL STATION BOXES.

BUILDING IS FULLY SPRINKLED – WITH A FIRE ALARM SYSTEM.
EXIT LIGHTS ARE SHOWN FOR REFERENCE ONLY – REFER TO ARCHITECTURAL
AND MEP PLANS FOR DETAILED LOCATIONS.

250' MAX. TRAVEL DISTANCE NOT EXCEEDED.

MINIMUM WIDTH OF EXIT ACCESS AISLES IS 44".

ALL APPROVED PLANS MUST BE AVAILABLE AT THE CONSTRUCTION SITE FOR
INSPECTION, PROCESS.

ALL EXITS ARE TO BE PROVIDED WITH EMERGENCY LIGHTING. REFER MEP PLANS
FOR DETAILS.


EXISTING AUTOMATIC SLIDING DOORS
NOT REQUIRED FOR EGRESS
EXISTING DOORS ARE EQUIPPED WITH EXISTING
SINGLE LEVER REARBY AND EMERGENCY
PUSH-TO-OPEN SAFETY FEATURE.
EXISTING SIGNAGE INDICATES
"DOOR IS TO REMAIN UNLOCKED WHEN BUILDING
IS OCCUPIED" AND
"AUTOMATIC DOOR, KEEP MOVING."

NORTH PATIO GATE EXIT
SECONDARY PATIO EXIT
EXISTING PANIC BAR EQUIPPED WITH
EXISTING PANIC BAR EXISTING SIGNAGE
AND IS DESIGNATED AS EMERGENCY
EXIT ONLY

GATE WIDTH/OCCUPANTS
SHOWN
ACTUAL
CAPACITY

KITCHEN EXIT
EXISTING DOORS EQUIPPED WITH
EXISTING PANIC HARDWARE
DOOR WIDTH/OCCUPANTS
SHOWN
ACTUAL
CAPACITY

EXISTING DOORS IN
ACCESSIBLE ROUTE
HAVE AN ACCESSIBLE,
EXISTING ARCHSWOUD,
HARDWARE, AND A
10" SMOOTH SURFACE
AT THE BOTTOM OF
PUSH SIDE OF DOOR.

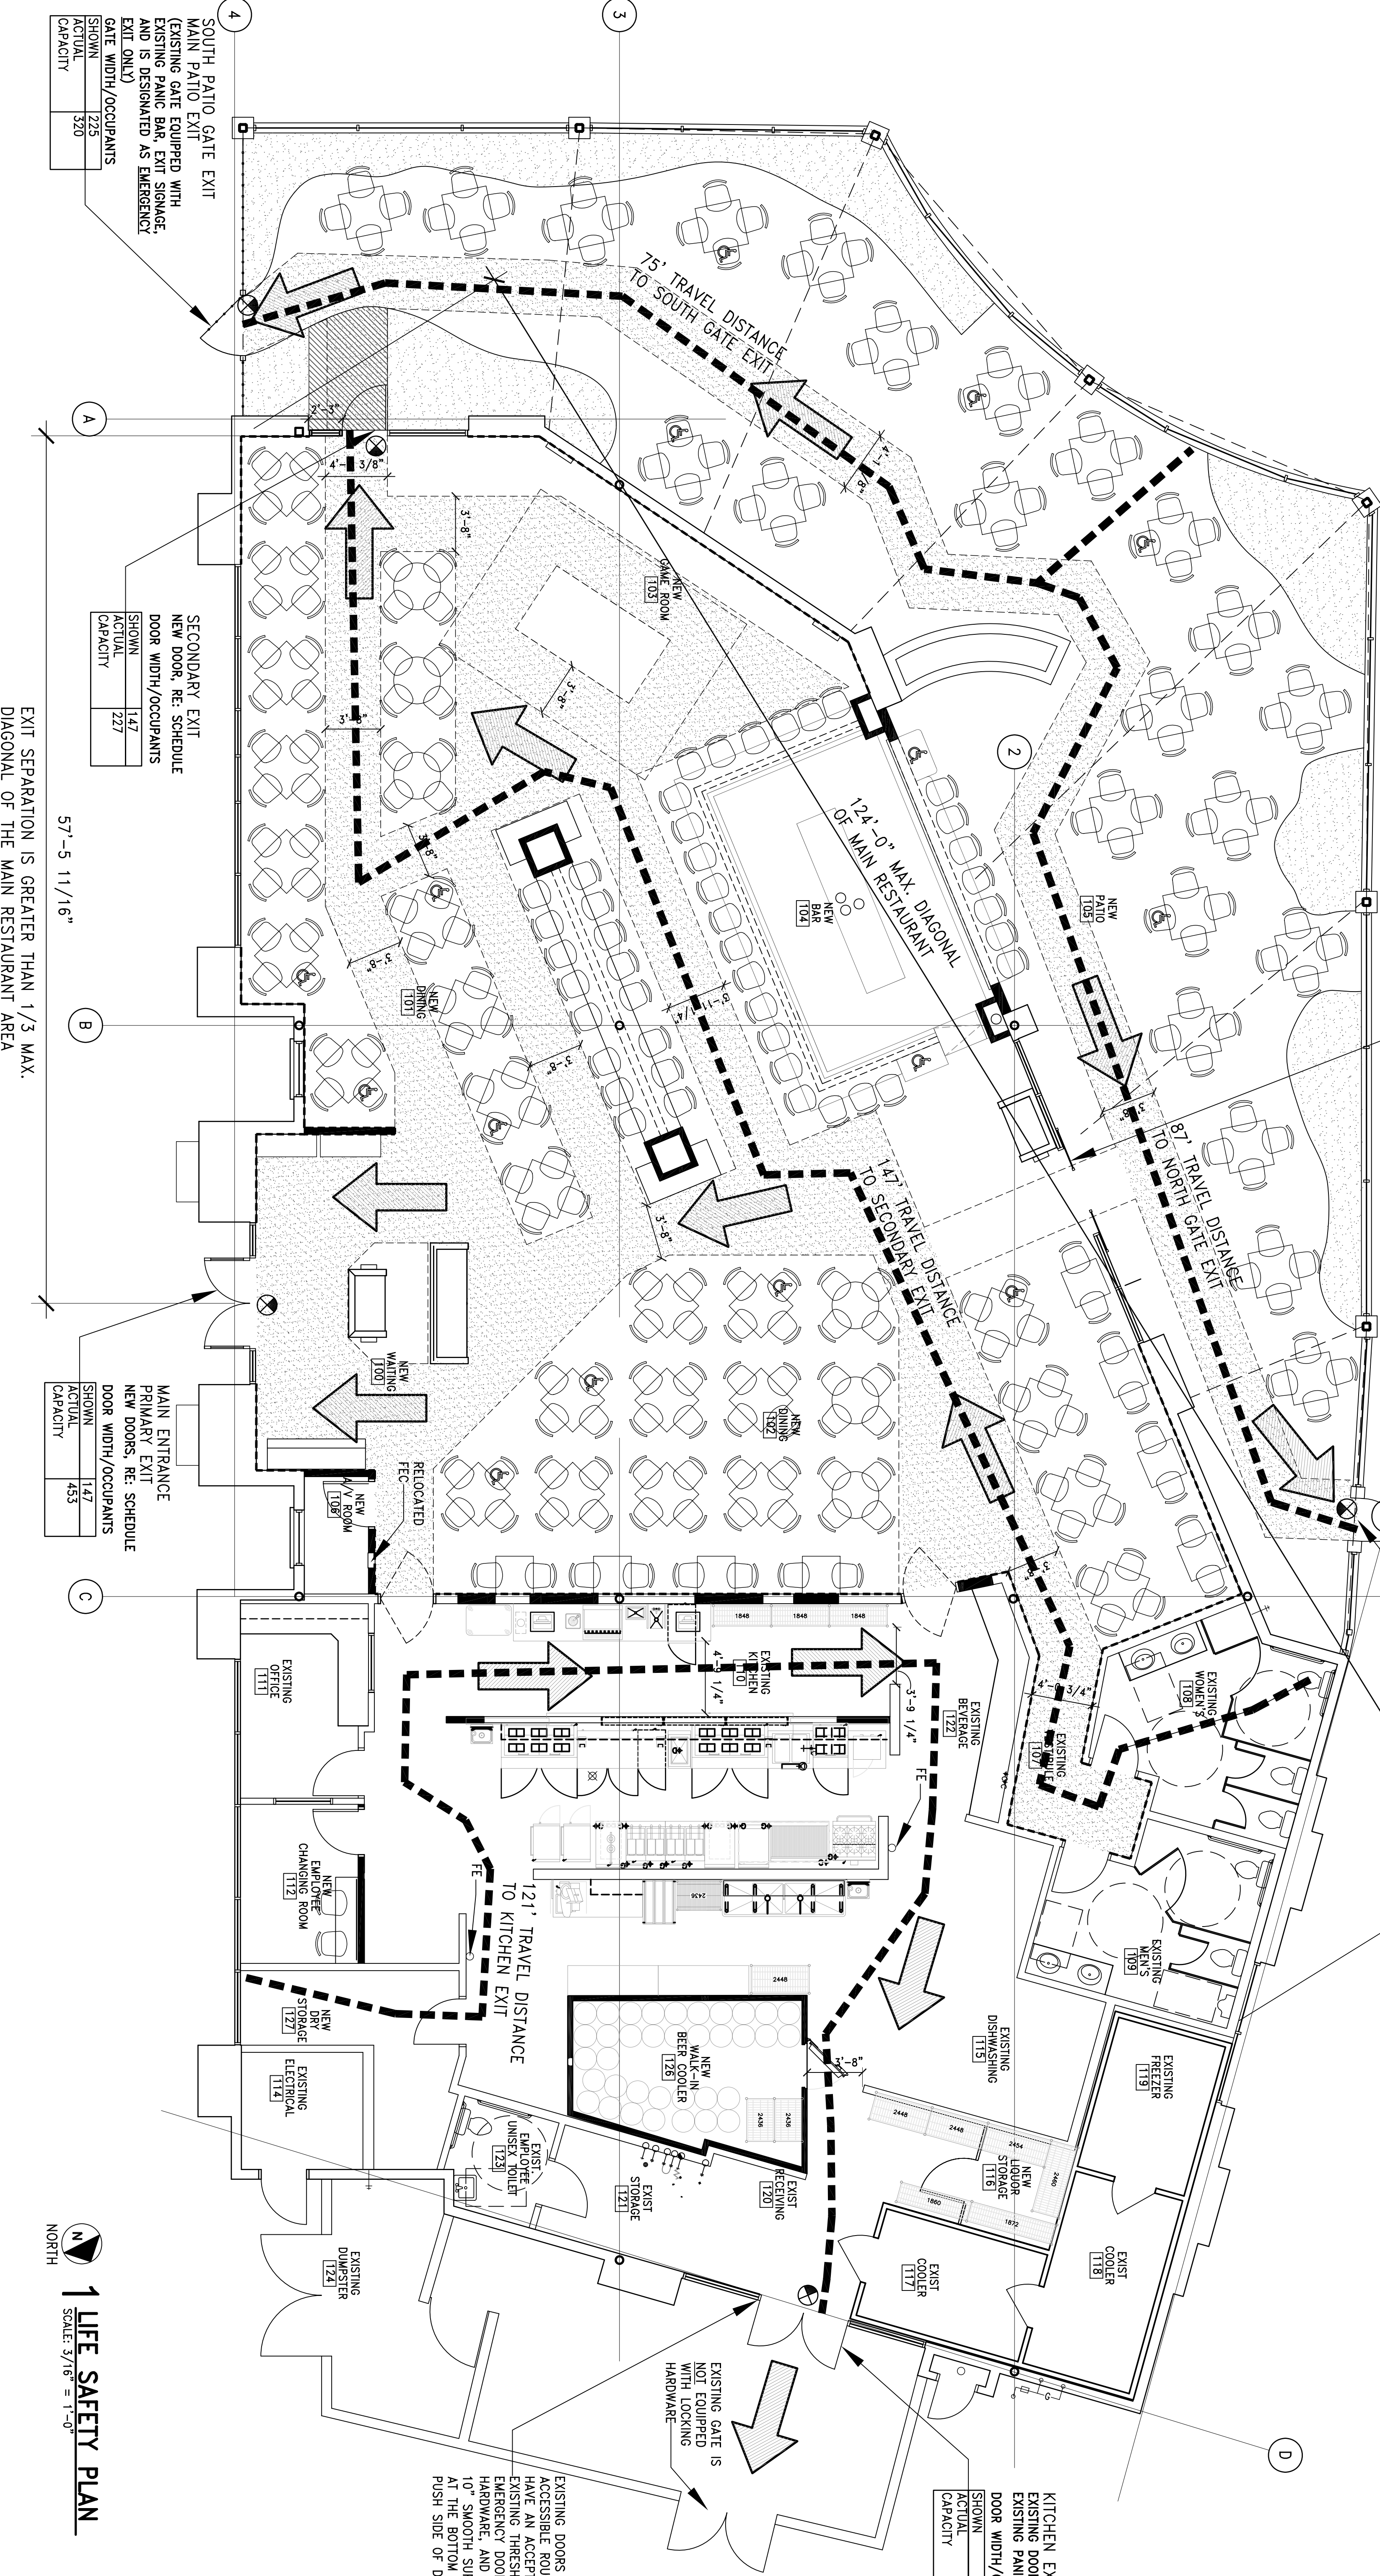

SOUTH PATIO GATE EXIT
MAIN PATIO EXIT
(EXISTING PANIC BAR, EXIT SIGNAGE,
AND IS DESIGNATED AS EMERGENCY
EXIT ONLY)
GATE WIDTH/OCCUPANTS
SHOWN
ACTUAL
CAPACITY

SECONDARY EXIT
NEW DOOR, RE-SCHEDULE
DOOR WIDTH/OCCUPANTS
SHOWN
ACTUAL
CAPACITY

MAIN ENTRANCE
PRIMARY EXIT
NEW DOORS, RE-SCHEDULE
DOOR WIDTH/OCCUPANTS
SHOWN
ACTUAL
CAPACITY

1 LIFE SAFETY PLAN
SCALE 3/8" = 1'-0"