



- LEGEND
- LED EXIT SIGN THERMOPLASTIC HOUSING, IMPACT AND SCRATCH RESISTANT, UV STABILIZED, REPLACEABLE CHEVRONS, AUTOMATIC RECHARGE - SIMILAR TO LITHONIA LQF500000 ELN.
 - THERMOPLASTIC EMERGENCY LIGHT, PROVIDES MIN. 90 MINUTES OF ILLUMINATION HIGH IMPACT THERMOPLASTIC HOUSING, MAINTENANCE FREE LEAD CALCIUM BATTERY, SIMILAR TO LITHONIA ELN2.
 - COMBINATION SMOKE/CARBON MONOXIDE DETECTOR HARDWIRED & INTERCONNECTED W/BATTERY BACKUP
 - WALL TYPE - REFERENCE SHEET A6
 - WINDOW TYPE - REFERENCE SHEET A13
 - DOOR TYPE - REFERENCE SHEET A13

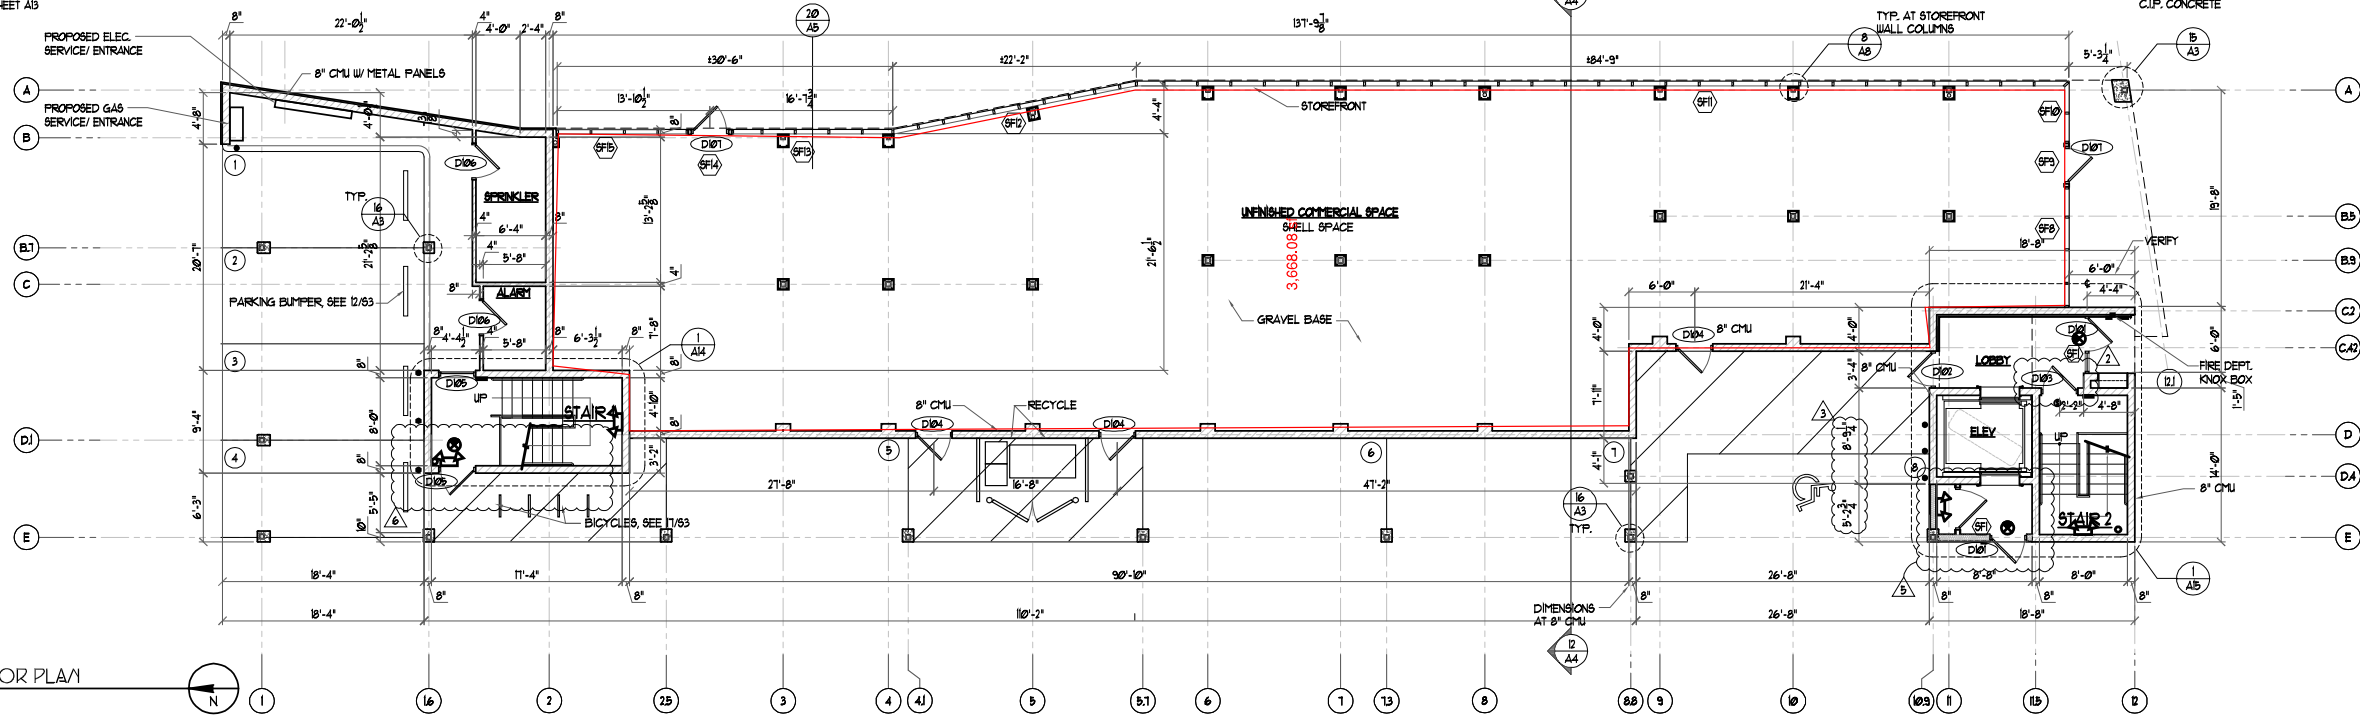

- LEGEND
- LED EXIT SIGN THERMOPLASTIC HOUSING, IMPACT AND SCRATCH RESISTANT, UV STABILIZED, REPLACEABLE CHEVRONS, AUTOMATIC RECHARGE - SIMILAR TO LITHONIA LQF500000 ELN.
 - THERMOPLASTIC EMERGENCY LIGHT, PROVIDES MIN. 90 MINUTES OF ILLUMINATION HIGH IMPACT THERMOPLASTIC HOUSING, MAINTENANCE FREE LEAD CALCIUM BATTERY, SIMILAR TO LITHONIA ELN2.
 - COMBINATION SMOKE/CARBON MONOXIDE DETECTOR HARDWIRED & INTERCONNECTED W/BATTERY BACKUP
 - WALL TYPE - REFERENCE SHEET A6
 - WINDOW TYPE W/ SILL HT. - REFERENCE SHEET A13
 - DOOR TYPE - REFERENCE SHEET A13

- GENERAL NOTES
- FRAME ALL DROPPED MECHANICAL CEILINGS TO DUCT WORK.
 - ALL DROPPED MECHANICAL CEILINGS & MECHANICAL SOFFITS TO MEET 1HR FIRE RATED FLOOR / CEILING ASSEMBLY. SEE 1/A8.
 - REFER TO STRUCTURAL SHEETS FOR BEARING WALL, STUD SPACING AND COLUMN LOCATIONS.
 - BALCONY AREA DRAIN TO BE (H/F) FLOOD C-112. FOLLOW ALL MANUFACTURER INSTALLATION INSTRUCTIONS. ARCHITECT TO APPROVE SUBSTITUTIONS.
 - GERON WINDOW TYPE - SEE 16/A11
- HEIGHT OF SILL AFF.

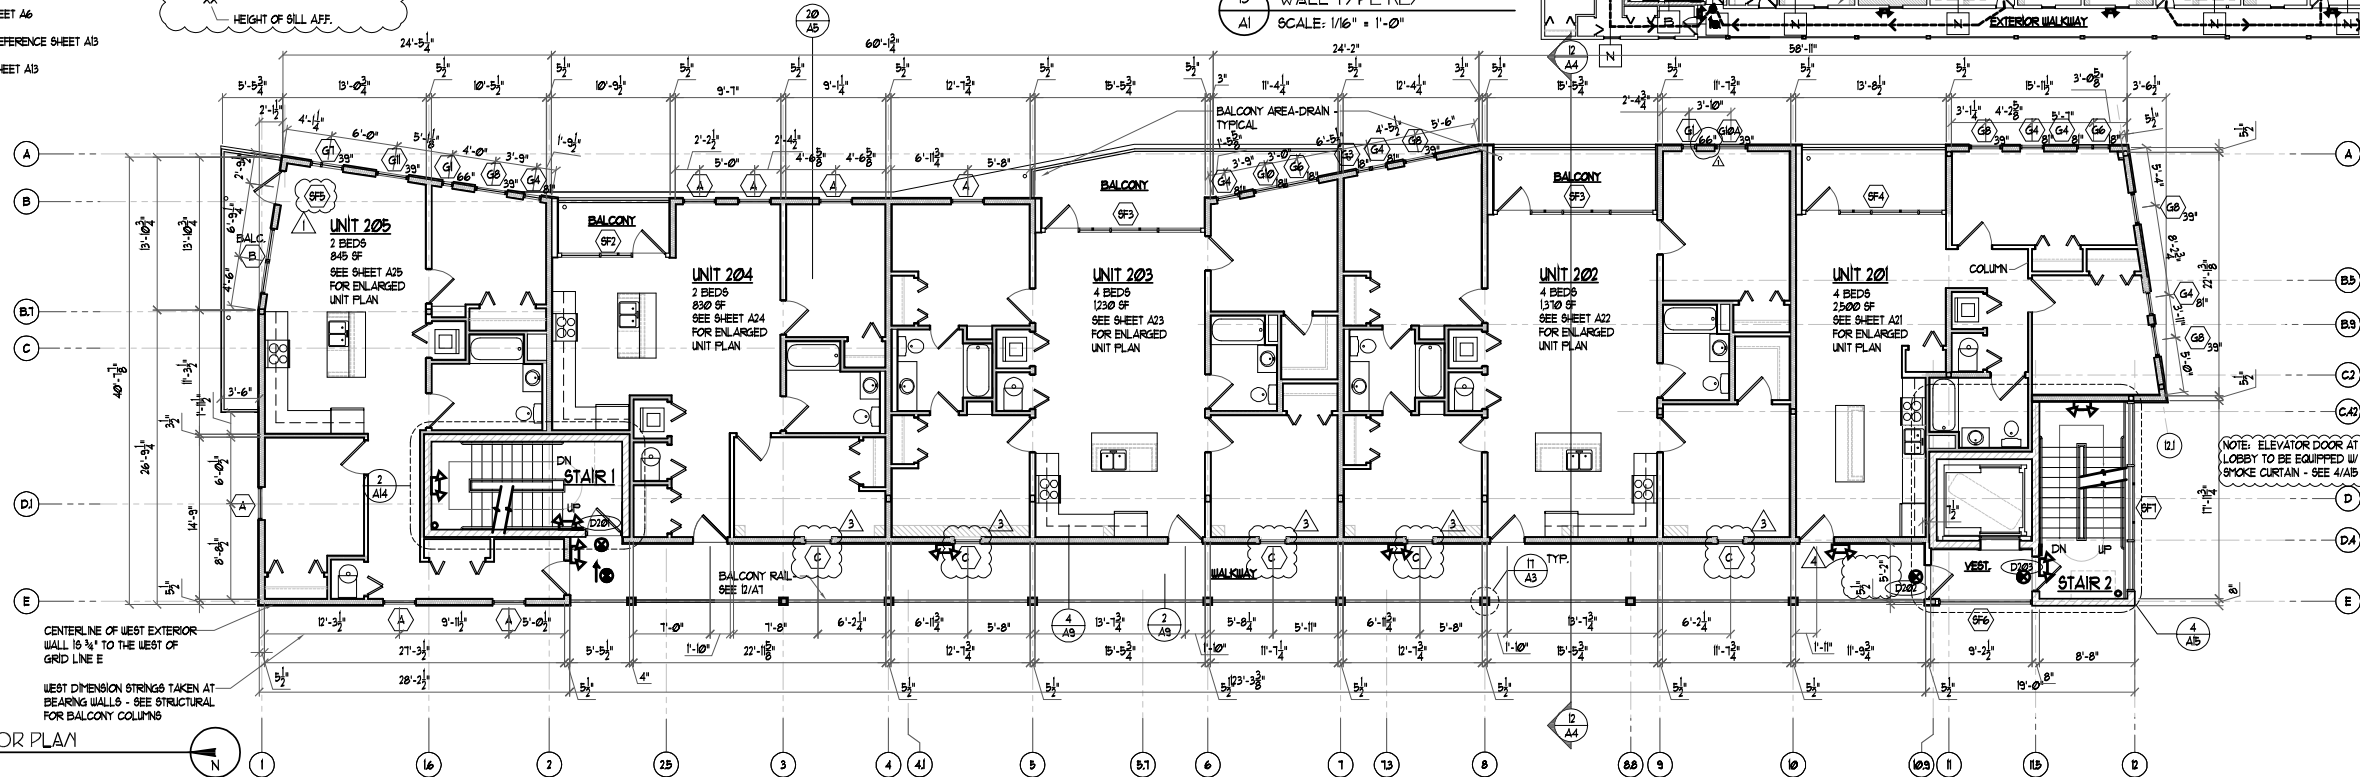

NOTE: REFER TO STRUCTURAL SHEETS FOR BEARING WALL STUD SPACING

2ND FL FIRE RATED WALL TYPE KEY

SCALE: 1/16" = 1'-0"

ANDREW FELL
ARCHITECTURE AND DESIGN

515 N HICKORY STREET, SUITE 101
CHAMPAIGN, ILLINOIS 61820
PHONE: 217.363.2890
FAX: 217.359.8493
EMAIL: andrewf@comcast.net

These drawings and specifications are the property of Andrew Fell Architecture and Design and shall not be used on any other work except by written agreement with the Architect. Only written dimensions shall be used. Do not scale drawings. Dimensions shall be verified on the field. The Architect shall be notified prior to the commencement of any work.

HEALEY APARTMENTS
NEW CONSTRUCTION

505 SOUTH FIRST STREET
CHAMPAIGN, ILLINOIS 61820

- LEGEND
- LED EXIT SIGN THERMOPLASTIC HOUSING, IMPACT AND SCRATCH RESISTANT, UV STABILIZED, REPLACEABLE CHEVRONS, AUTOMATIC RECHARGE - SIMILAR TO LITHONIA LQ15B0R00 ELN.
 - THERMOPLASTIC EMERGENCY LIGHT, PROVIDES MIN. 90 MINUTES OF ILLUMINATION HIGH IMPACT THERMOPLASTIC HOUSING, MAINTENANCE FREE LEAD CALCIUM BATTERY, SIMILAR TO LITHONIA ELN2.
 - COMBINATION SMOKE/CARBON MONOXIDE DETECTOR HARDWIRED & INTERCONNECTED W/BATTERY BACKUP
 - WALL TYPE - REFERENCE SHEET A6
 - WINDOW TYPE - REFERENCE SHEET A13
 - DOOR TYPE - REFERENCE SHEET A13

- GENERAL NOTES
- FRAME ALL DROPPED MECHANICAL CEILINGS TO DUCT WORK
 - ALL DROPPED MECHANICAL CEILINGS & MECHANICAL SOFFITS TO MEET 1HR FIRE RATED FLOOR / CEILING ASSEMBLY. SEE 2/A6.
 - REFER TO STRUCTURAL SHEETS FOR BEARING WALL, STUD SPACING AND COLUMN LOCATIONS.
 - BALCONY AREA DRAIN TO BE (MFAB F100-C-11G) FOLLOW ALL MANUFACTURER INSTALLATION INSTRUCTIONS. ARCHITECT TO APPROVE SUBSTITUTIONS.
 - GERKON WINDOW TYPE - SEE 16/A11
- HEIGHT OF BILL AFF.

NOTE: REFER TO STRUCTURAL SHEETS FOR BEARING WALL STUD SPACING

3RD FL FIRE RATED WALL TYPE KEY
SCALE: 1/16" = 1'-0"

2 THIRD FLOOR PLAN
A2 SCALE: 1/8" = 1'-0"

- LEGEND
- LED EXIT SIGN THERMOPLASTIC HOUSING, IMPACT AND SCRATCH RESISTANT, UV STABILIZED, REPLACEABLE CHEVRONS, AUTOMATIC RECHARGE - SIMILAR TO LITHONIA LQ15B0R00 ELN.
 - THERMOPLASTIC EMERGENCY LIGHT, PROVIDES MIN. 90 MINUTES OF ILLUMINATION HIGH IMPACT THERMOPLASTIC HOUSING, MAINTENANCE FREE LEAD CALCIUM BATTERY, SIMILAR TO LITHONIA ELN2.
 - COMBINATION SMOKE/CARBON MONOXIDE DETECTOR HARDWIRED & INTERCONNECTED W/BATTERY BACKUP
 - WALL TYPE - REFERENCE SHEET A6
 - WINDOW TYPE - REFERENCE SHEET A13
 - DOOR TYPE - REFERENCE SHEET A13

- GENERAL NOTES
- FRAME ALL DROPPED MECHANICAL CEILINGS TO DUCT WORK
 - ALL DROPPED MECHANICAL CEILINGS & MECHANICAL SOFFITS TO MEET 1HR FIRE RATED FLOOR / CEILING ASSEMBLY. SEE 2/A6.
 - REFER TO STRUCTURAL SHEETS FOR BEARING WALL, STUD SPACING AND COLUMN LOCATIONS.
 - BALCONY AREA DRAIN TO BE (MFAB F100-C-11G) FOLLOW ALL MANUFACTURER INSTALLATION INSTRUCTIONS. ARCHITECT TO APPROVE SUBSTITUTIONS.

NOTE: REFER TO STRUCTURAL SHEETS FOR BEARING WALL STUD SPACING

4TH FL FIRE RATED WALL TYPE KEY
SCALE: 1/16" = 1'-0"

4 FOURTH FLOOR PLAN
A2 SCALE: 1/8" = 1'-0"

PROJECT # 1438

DATE: 2/18/15

TH

REVISIONS

REV	DATE	DESCRIPTION
REV 1	15-10-19	TH
REV 2	15-10-26	TH
REV 3	15-11-09	TH
REV 4	15-11-30	TH
REV 5	16-03-23	TH
REV 6	16-07-26	TH
REV 7	16-08-03	TH

ANDREW FELL
ARCHITECTURE AND DESIGN

515 N HICKORY STREET, SUITE 101
CHAMPAIGN, ILLINOIS 61820
PHONE: 217.353.2890
FAX: 217.353.2493
EMAIL: andrewfell@comcast.net

These drawings and specifications are the property of Andrew Fell Architecture and Design and shall not be used on any other work except by written agreement with the Architect. Only written dimensions shall be used. Do not scale drawings. Dimensions shall be verified on the field. The Architect shall be notified of any discrepancies prior to the commencement of any work.

HEALEY APARTMENTS
NEW CONSTRUCTION

505 SOUTH FIRST STREET
CHAMPAIGN, ILLINOIS 61820

A2

