

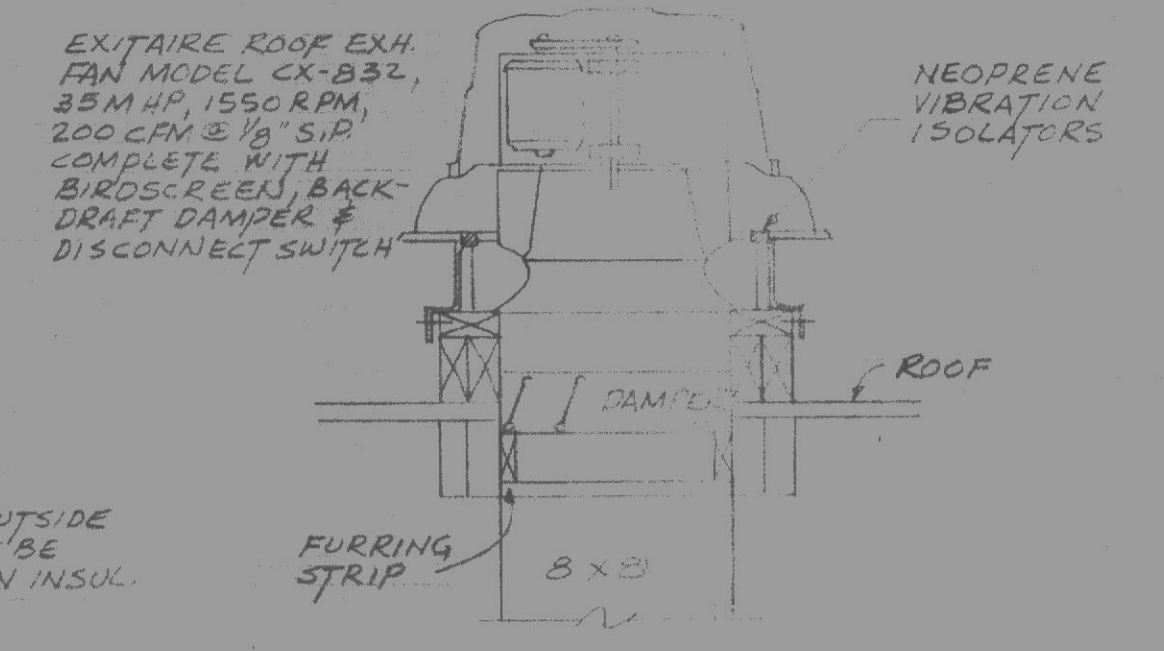


94 IN. TYPICAL TRANCE - 14" DIA. 1/2" WALL THICKNESS
 1/2" DIA. 1/2" WALL THICKNESS
 1/2" DIA. 1/2" WALL THICKNESS
 1/2" DIA. 1/2" WALL THICKNESS
 1/2" DIA. 1/2" WALL THICKNESS

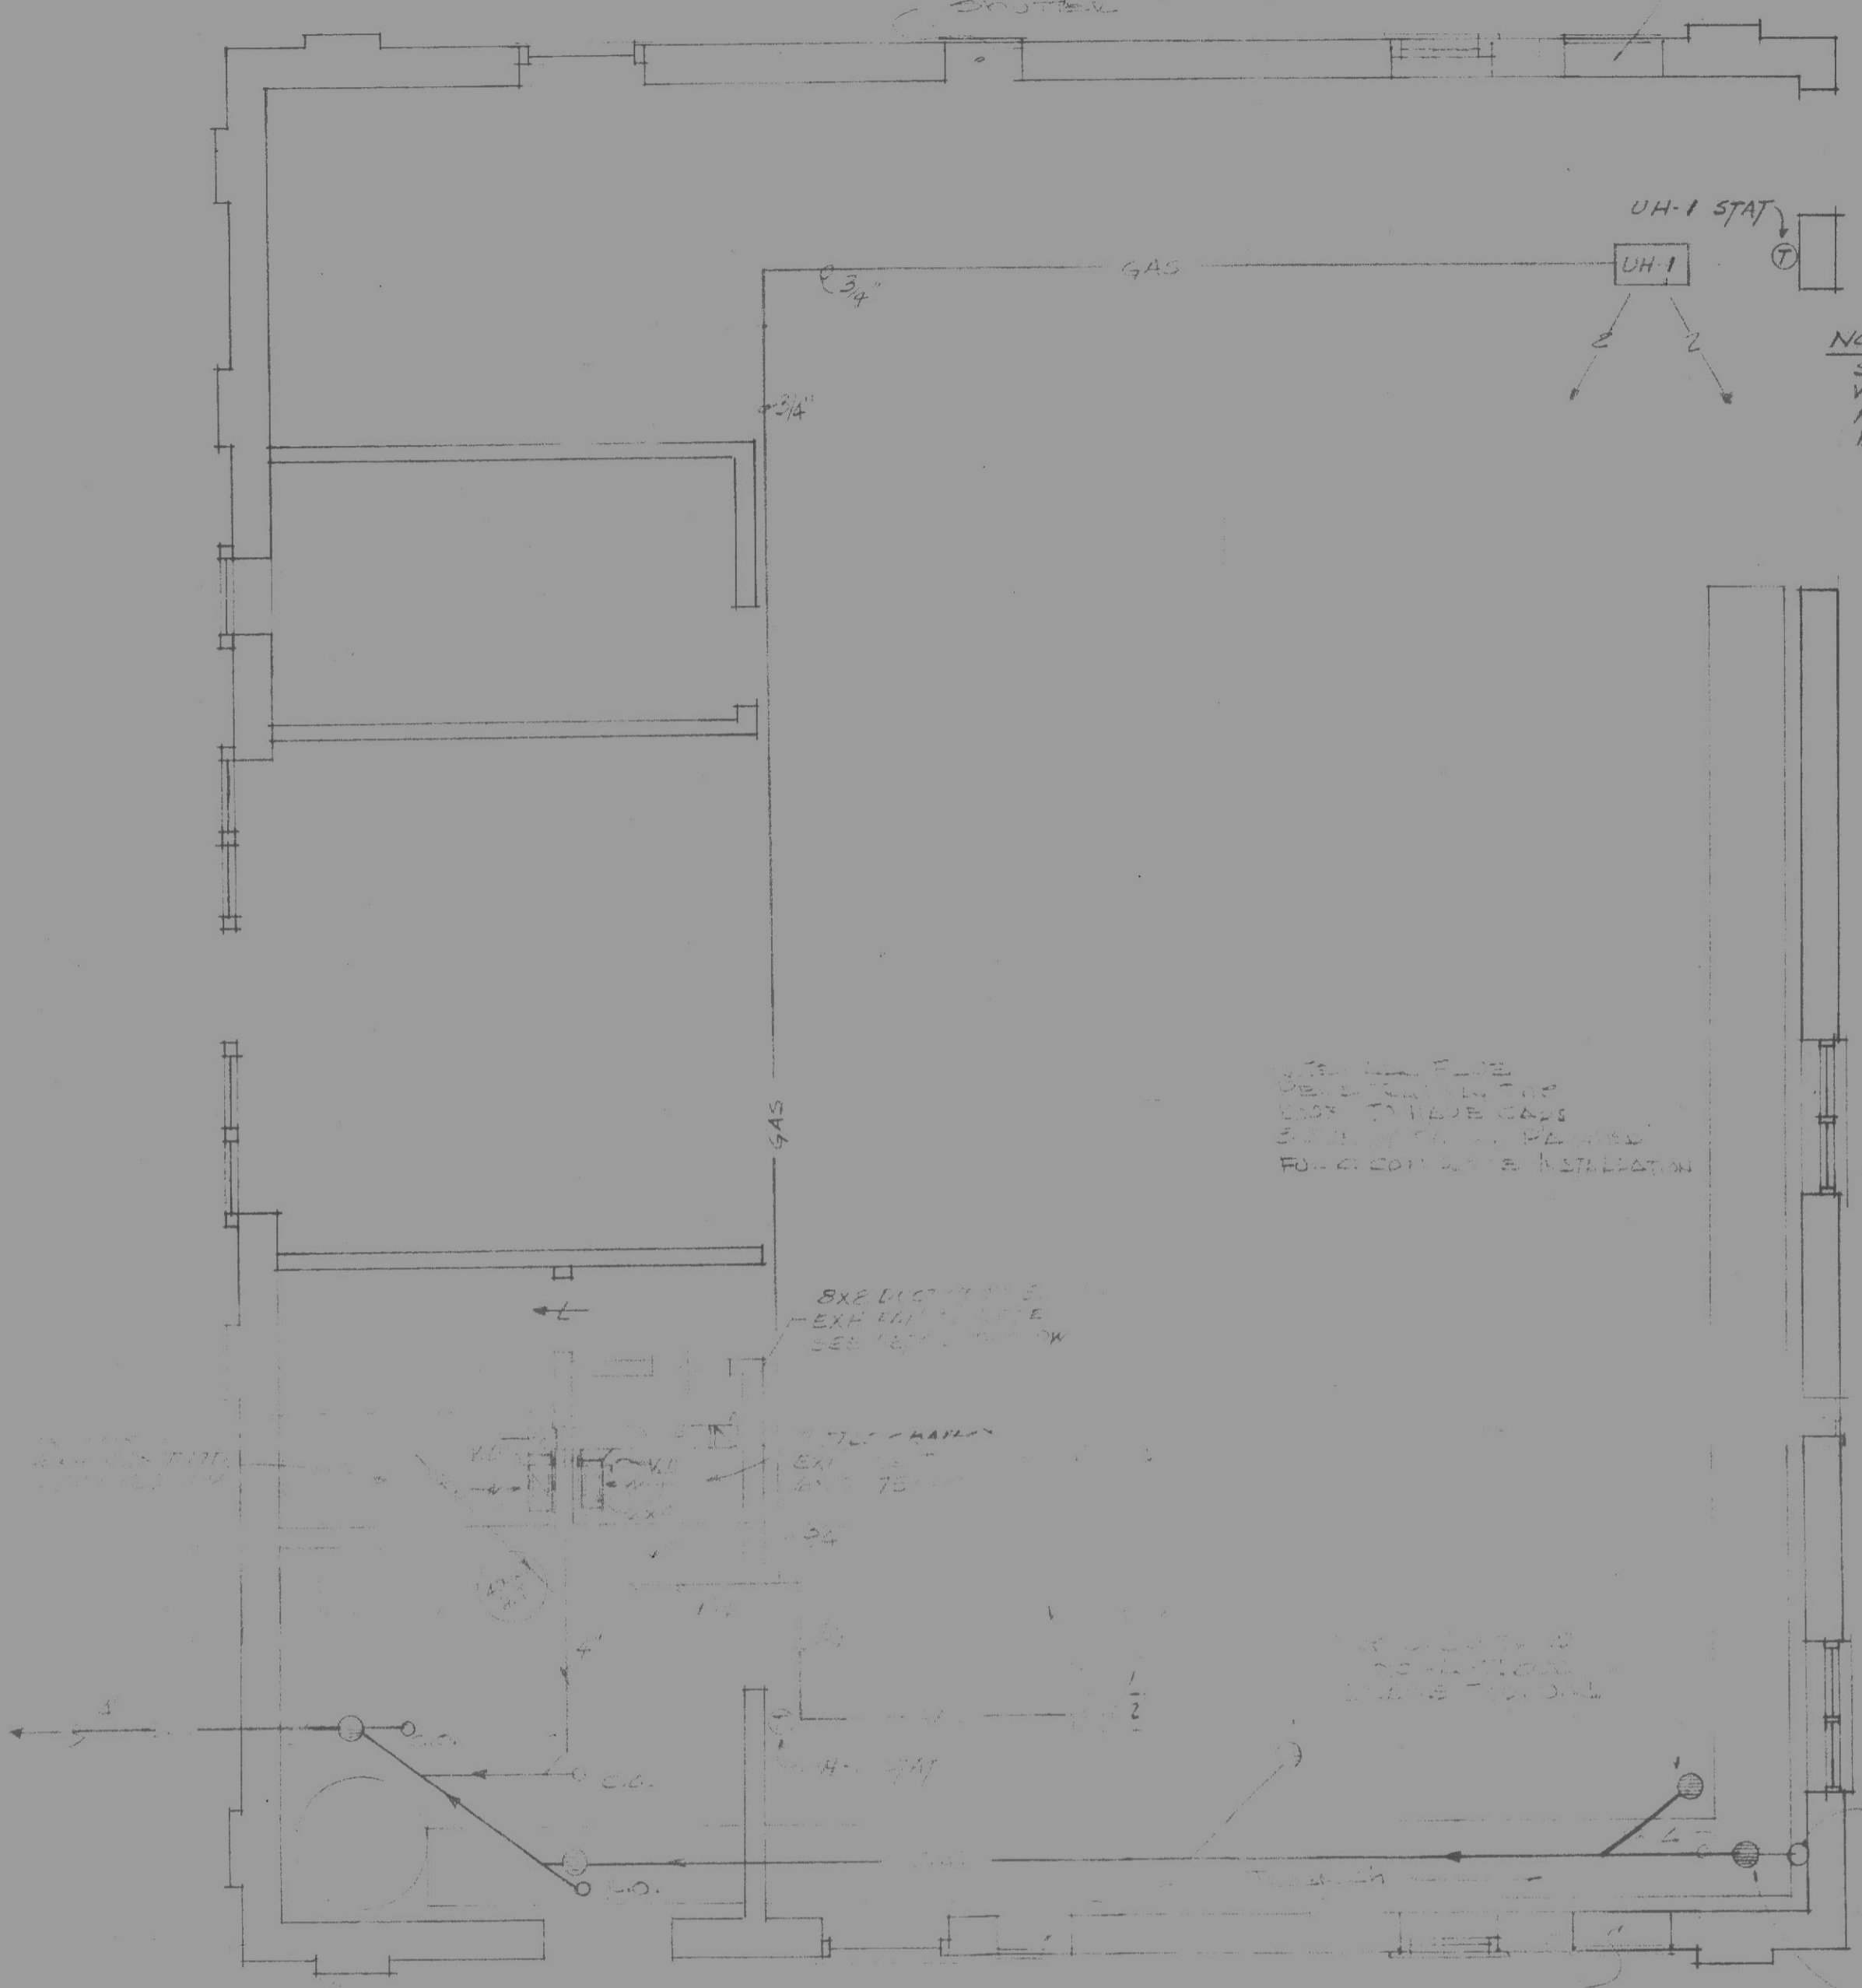


TOILET ROOM EXH. FAN DETAIL
 NO SCALE

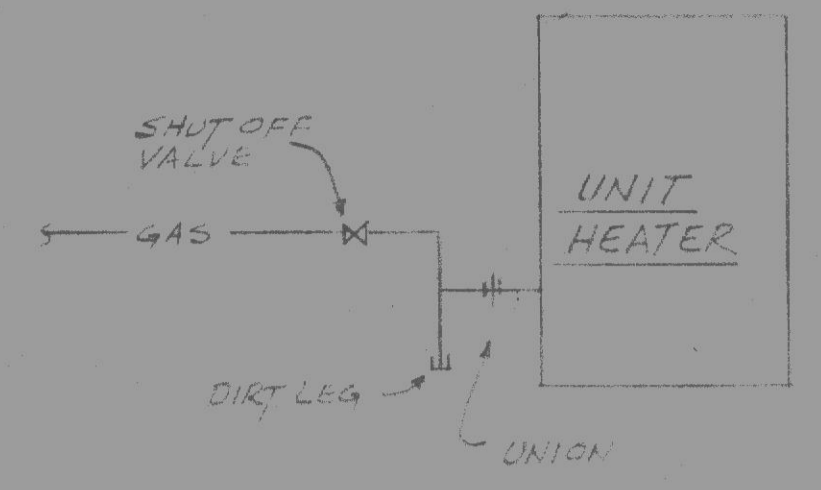

UNIT HEATER PIPING SCHEMA
 NO SCALE

UH-1 & UH-2
 TRANCE GAS PIPING WITH PLATYS MODEL 1/2" DIA. 1/2" WALL THICKNESS 1/2" DIA. 1/2" WALL THICKNESS INPUT & OUTPUT 1/2" DIA. 1/2" WALL THICKNESS HT. 10 FT. 45" TALL

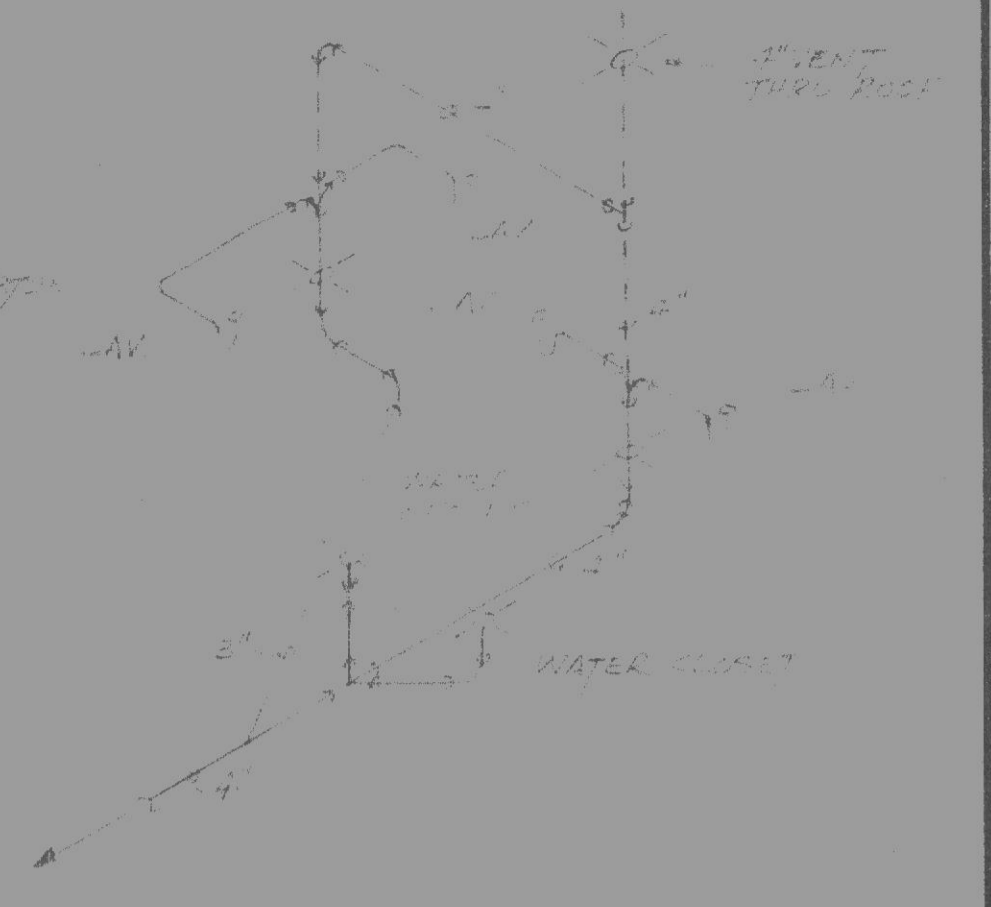

PLUMBING SYMBOLS
 NO SCALE

PLUMBING PLAN

TITLE PLUMBING PLAN	JOB MASTER CLEANERS & DYERS	REVISIONS	DRAWN [Signature]	SCALE AS SHOWN	DRAWING NO. M-1
OWNER [Faded]	26 FRONT ST. [Faded]		DATE [Faded]	CHECKED	
				JOB NO. [Faded]	