


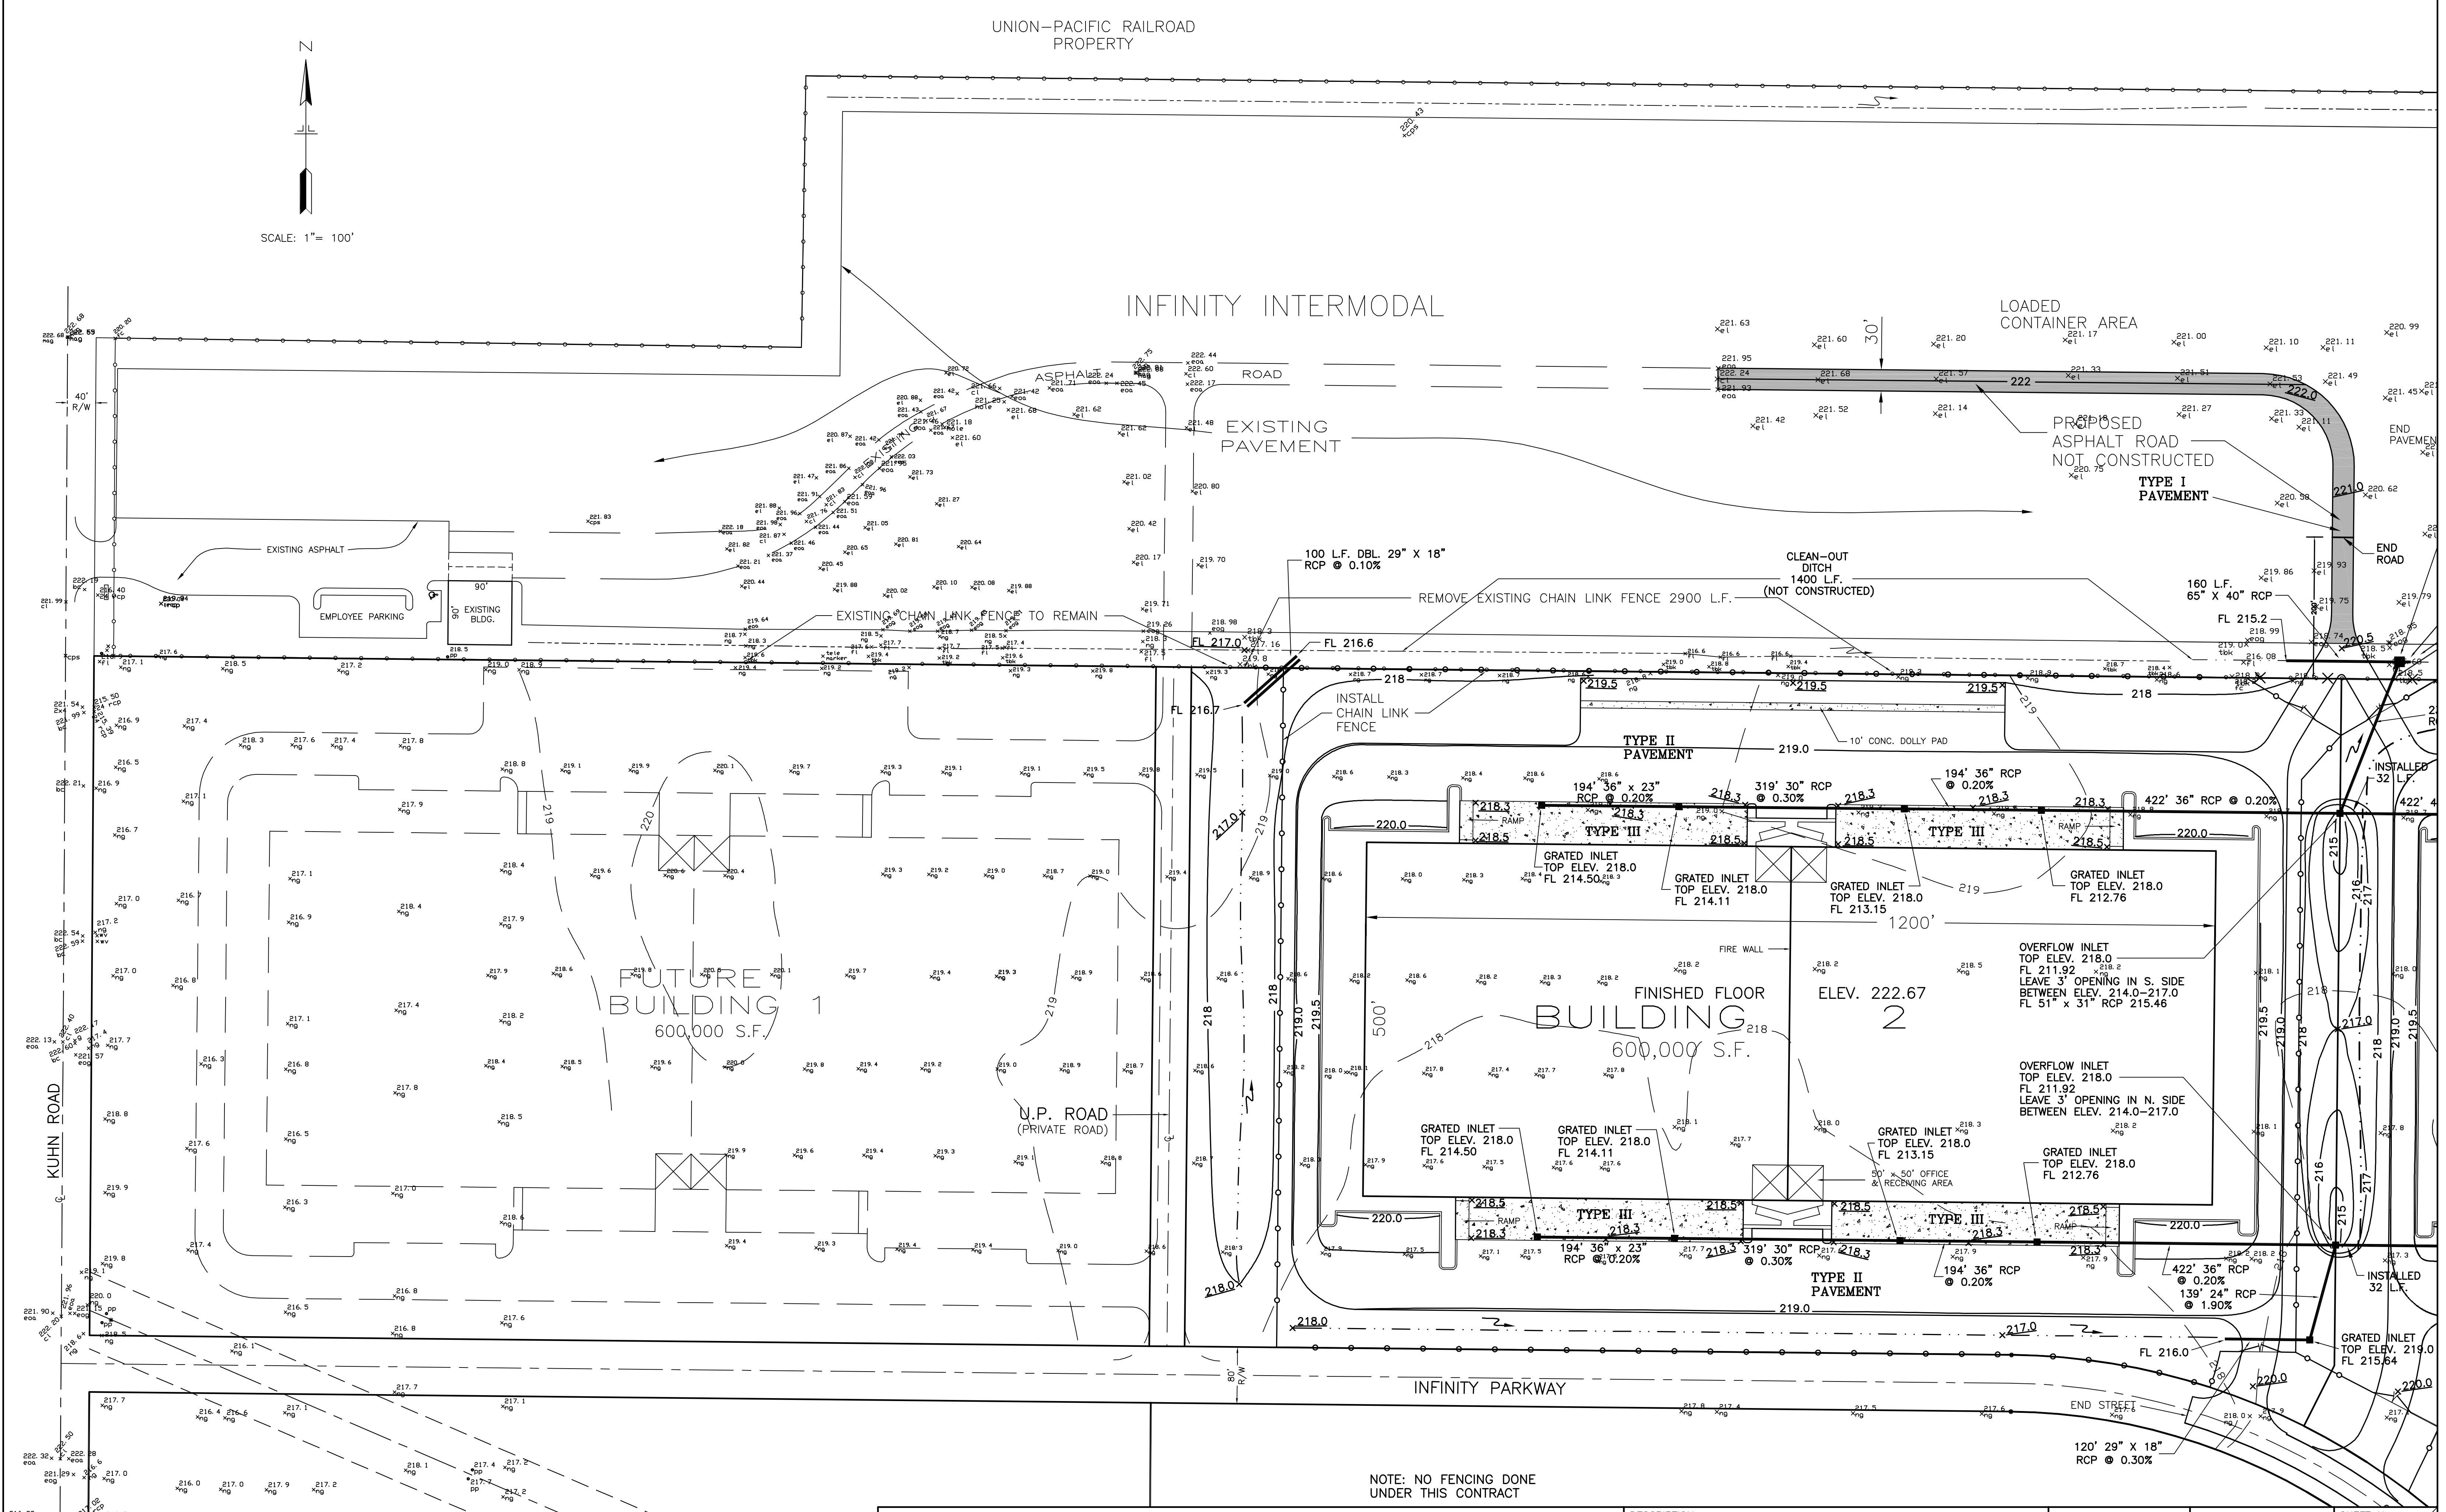

Sorrell Consulting Engineers
206 SHOPPINGWAY BLVD. * (870) 735-8084 * WEST MEMPHIS, ARKANSAS 72301
Civil Engineering

DESCRIPTION:
GRADING & DRAINAGE PLAN
INFINITY WAREHOUSE DEVELOPMENT
WEST MEMPHIS, ARKANSAS

REVISIONS: SEPT. 2006	DESIGNED: DRAWN: CHECKED: DATE: JUNE, 2005 SCALE: 1" = 100' PROJECT No.:	SHEET No. 13 OF 18
--------------------------	---	-----------------------