


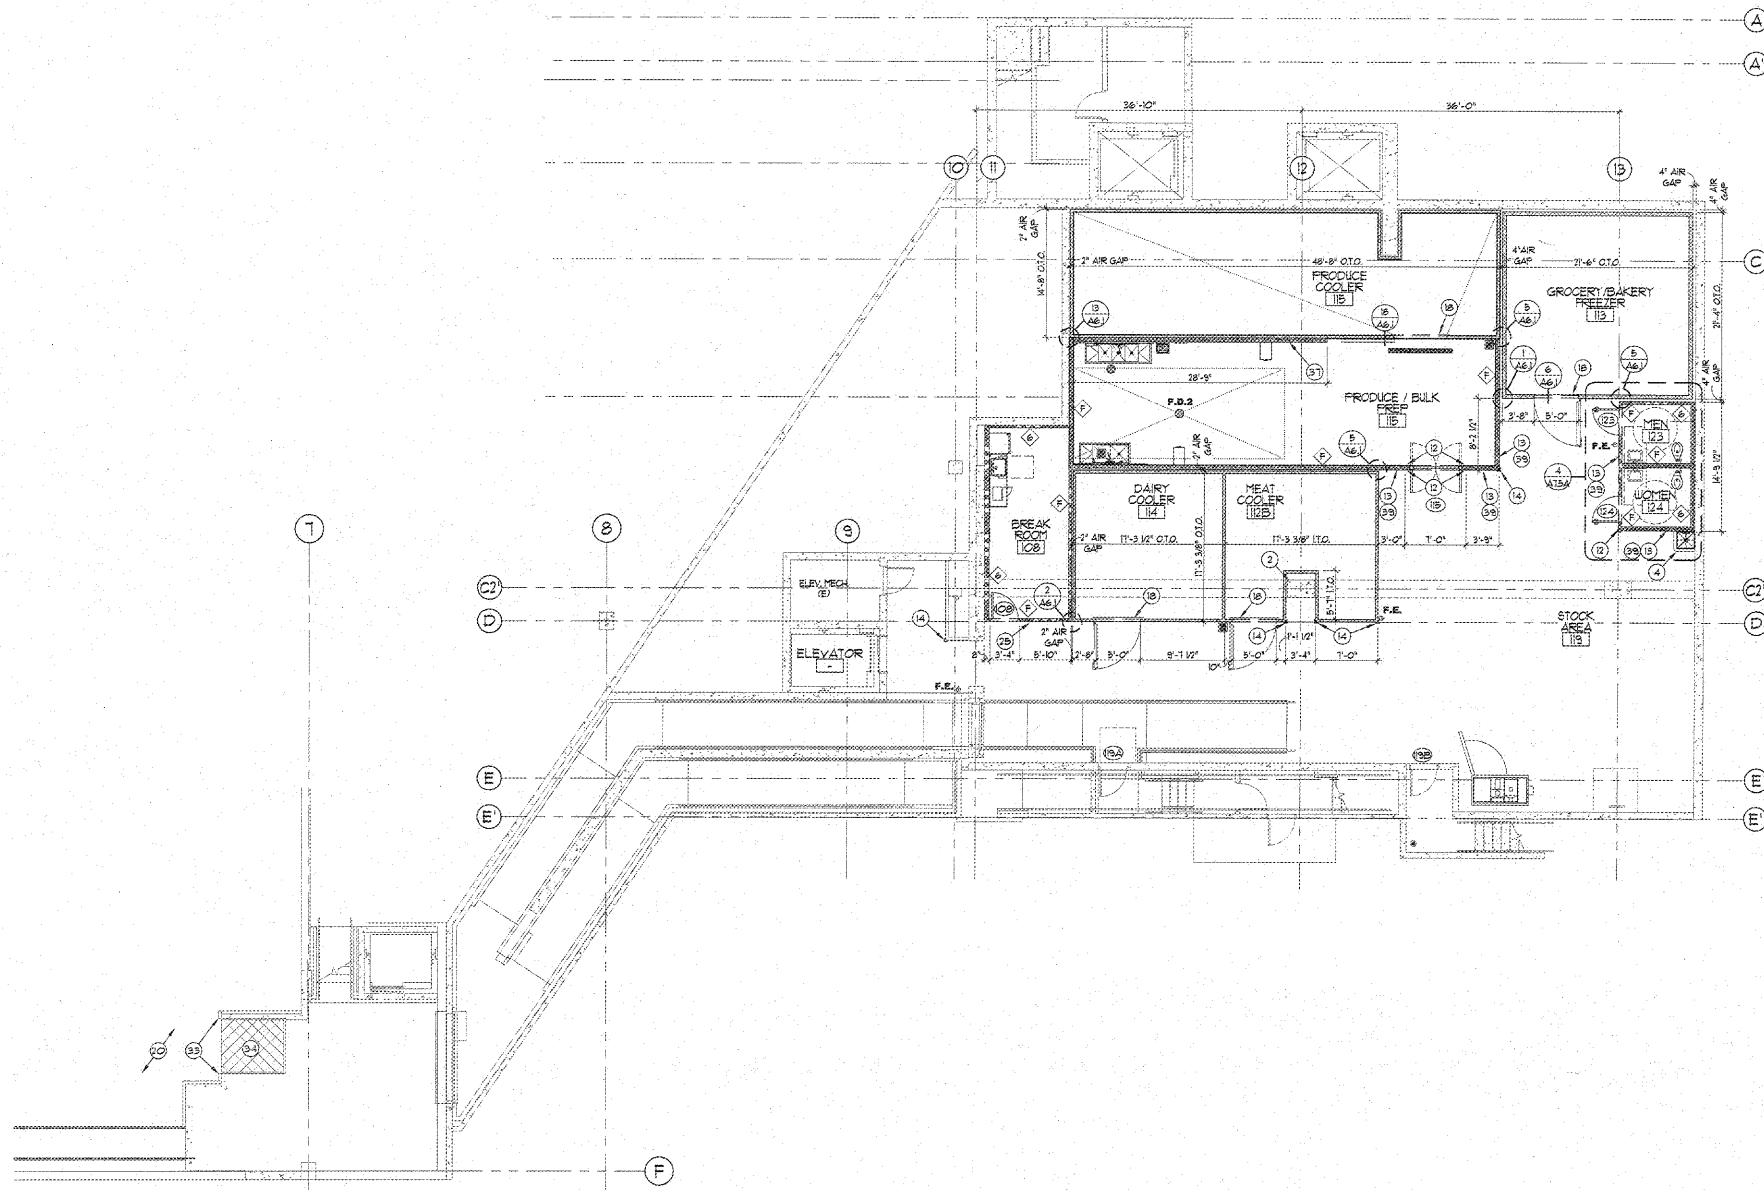

BASEMENT PLAN

SCALE: 1/8" = 1'-0"

WALL LEGEND:

- INDICATES FULL HEIGHT WALL. NO GYPSUM BOARD ABOVE CEILING AT SM CONDITION. REF DETAIL 5/14/5.
- INDICATES 6' ABOVE CEILING.
-

FLOOR PLAN WALL LEGEND:

- FLOOR SINK TWO PIECE HALF GRATE. VERIFY AND COORDINATE LOCATIONS WITH REFRIGERATION AND PLUMBING DRAWINGS.
- FLOOR DRAIN 6" (PREP AREAS).
- ACCESSIBLE DRINKING FOUNTAIN.
- PIPE BOLLARD, PAINT SAFETY YELLOW. SEE DETAIL 14/14/0.
- WATER HEATER. SEE DETAIL 24/14/0.
- ROOF LADDER. SEE DETAIL 34/14/4.
- SHIP'S LADDER. SEE DETAIL 41/14/4.
- STORAGE RACK (HOP SINK).
- FIRE DEPARTMENT CONNECTION.
- PUSH-ROOM BOTTOM DOOR BELL AT 5'-0" ABOVE EXTERIOR GRADE / LANDING. PAINT TO MATCH ADJACENT FINISHES - DOOR BELL ON ALUMINUM FINISH AT SM.
- RECESSED HOSE BIB WITH COVER.
- SURFACE MOUNTED HOSE BIB.
- PRODUCE CASE MISTING SYSTEM CONTROLLER. LOCATE ON TOP OF REFRIGERATION CASE UNDER JAWING.
- REVERSE OSMOSIS SYSTEM. COORDINATE LOCATION WITH REFRIGERATION, PLUMBING, ELECTRICAL AND FUTURE PLAN.
- KNOX BOX. LOCATE PER LOCAL FIRE DEPARTMENT REQUIREMENTS. GENERAL CONTRACTOR TO VERIFY INSTALLATION PRIOR TO BID.
- FIRE EXTINGUISHER. FINAL LOCATION TO BE COORDINATED WITH LOCAL FIRE AUTHORITY. PROVIDE 5 LB. ABC SERIES FIRE EXTINGUISHER NEAR DELI PREP EXHAUST HOOD. PROVIDE 10 LB. ABC SERIES EXTINGUISHERS TYPICAL THROUGHOUT.
- GREASE INTERCEPTOR. SEE PLUMBING DRAWINGS. COORDINATE REVER LINES WITH EXISTING FOOTINGS.
- BALER.
- SELF CONTAINED TRASH COMPACTOR. MAXIMUM SLOPE OF CONCRETE COMPACTOR PAD IS 1/8".
- HYDRAULIC CONTROLS FOR COMPACTOR.
- SERVICE ENTRY SECTION (SEE S).
- TRANSFORMER.
- FIRE SPRINKLER RISER.
- GAS METER.
- 3-COMPARTMENT SINK (LARGE) MEAT AND DELI PREP.
- 3-COMPARTMENT SINK (MEDIUM) PRODUCE PREP.
- 2-COMPARTMENT SINK PRODUCE SOAK AND RINSE.
- 1-COMPARTMENT PREP SINK WITH DRAIN BOARD.
- BREAK ROOM SINK.
- JANITORS SINK WITH 6'-0" HIGH FRP. EACH WALL.
- HAND SINK WITH SPLASH GUARD.
- TRENCH DRAIN. TO BE LOCATED 1/4" FROM FACE OF WALL PANEL, AND EXTEND 8" BEYOND DOOR JAMB.
- FLOOR SINK FULL GRATE. VERIFY AND COORDINATE LOCATIONS WITH REFRIGERATION AND PLUMBING DRAWINGS.

GENERAL NOTES:

1. DIMENSIONS ARE TO FACE OF MASONRY AND STUDS, AND CENTERLINE OF COLUMN UNLESS OTHERWISE INDICATED.
2. GENERAL CONTRACTOR SHALL VERIFY GOVERNMENTAL REQUIREMENTS PRIOR TO BID AND INCLUDE IN BID ALL COSTS ASSOCIATED WITH FIRE ALARM SYSTEM INCLUDING AUDIOVISUAL DEVICES AND FULL STATIONS WHERE REQUIRED.
3. * ASSUMED FINISH FLOOR ELEVATION = 100.00'.
4. UNLESS NOTED OTHERWISE PARTITION WALLS SHALL BE CONSTRUCTED OF 5/8" GYPSUM BOARD, BOTH SIDES TO 6" ABOVE FINISH CEILING, OVER 3/8" METAL STUDS AT 16" O.C. (BRACE TO STRUCTURE ABOVE OR AT MASONRY WALL, WHERE ADJACENT) AT 48" O.C. TYPICAL THROUGHOUT - SEE SPECIFICATIONS.
5. ALL ITEMS SUCH AS LIGHT SWITCHES, TEMPERATURE SENSORS, FIRE EXTINGUISHERS, FIRE ALARM PULLS AND OTHER ITEMS TO BE LOCATED AS CLOSE AS POSSIBLE TO THE ADJACENT DOOR FRAME.
6. PROVIDE SOLID BLOCKING AT ALL HARDWARE SECURED TO STUDS OR PARTED WALLS AT ALL COUNTERTOPS, SHELVING AND SUPPORTS, HOOKS, METAL PARTITIONS, GRAB BARS, CHANGING STATIONS, WALL MOUNTED SINKS AND LAVATORIES, AT EDGES OF FRP PANELS, DOOR HARDWARE, FAUCETS, FUTURE SHELVING AND WALL SUPPORTED AWNINGS.
7. AT HOP SINK AND 3-COMPARTMENT SINKS, ECOLAB TO PROVIDE 100 CLEANING SOLUTION DISPENSER ON HOSE BIB SIDE.
8. GENERAL CONTRACTOR SHALL OBTAIN THE APPROVED COOLER BOX DRAWINGS FROM THE COOLER BOX MANUFACTURER PRIOR TO CONSTRUCTION.
9. BUILDINGS SHALL BE PROVIDED WITH A CLASS V, AUTOMATIC FIRE SPRINKLER SYSTEM THROUGHOUT. GENERAL CONTRACTOR SHALL SUBMIT A COMPLETE SET OF SHOP DRAWINGS AS REQUIRED TO GOVERNMENTAL AUTHORITIES TO BE APPROVED PRIOR TO START OF INSTALLATION. GENERAL CONTRACTOR SHALL VERIFY GOVERNMENTAL REQUIREMENTS PRIOR TO BID AND ALL REQUIREMENTS FOR A COMPLETE FIRE SPRINKLER SYSTEM ARE TO BE INCLUDED IN BID (HOSE STREAM ALLOWANCES OF 250 GPM SHALL BE ADDED TO THE SPRINKLER SYSTEM WATER DEMAND WHERE LOCATED IN A RETAIL SHOPPING CENTER). FIRE SPRINKLER PLANS MUST BE APPROVED BY ARCHITECT, OWNER AND CITY PRIOR TO FABRICATION. SYSTEM SHALL COMPLY WITH NFPA 13. THINWALL FLOW RATES SHOULD BE VERIFIED AND SUBMITTED TO GOVERNMENTAL AUTHORITIES FOR A PRELIMINARY REVIEW OF THE AUTOMATIC FIRE SPRINKLER SYSTEM PRIOR TO DESIGN. SPRINKLER HEADS AT DROPPED CEILING AREAS ARE TO BE SET-RECESSED THROUGHOUT - SEE SPECIFICATIONS. SPRINKLER SYSTEM TO BE AS TIGHT TO ROOF DECK AS POSSIBLE AND NOT UNDER OR THROUGH SKYLIGHTS.
10. WALL AND CEILING MATERIALS SHALL NOT EXCEED THE FLAME SPREAD CLASSIFICATIONS IN IBC TABLE 603.3.

KEYED NOTES CONT.:


18. STRIP CURTAINS HANG TIGHT TO CEILING AND ROLL-UP FOR PROTECTION DURING CONSTRUCTION.
19. OPENINGS IN COOLER WALL FOR WINDOWS BY COOLER BOX MANUFACTURER.
20. LOADING DOCK, NOT SHOWN IN ITS ENTIRETY - REF. CIVIL DRAWINGS.
21. POWERWALL TO BE ON 4" HIGH CONCRETE PAD TO MATCH WIDTH AND LENGTH OF POWERWALL. SEE STRUCTURAL AND ELECTRICAL DRAWINGS.
22. NO KILN DRIED VERTICAL ROUGH-SAWN WESTERN RED CEDAR WOOD PANELING TO CEILING OVER 5/8" OSE.
23. TELEPHONE MOUNTING BOARD.
24. MILLWORK PROVIDED BY G.C. - SEE SHEET A8.0.
25. 4" x 8" SLAT WALL BY SPROUTS - TO BE MOUNTED ON TOP OF CHAIR RAIL.
26. COORDINATE UNDER GROUND UTILITIES IN THIS LOCATION.
27. 225 KVA TRANSFORMER (ABOVE).
28. DASHED LINE INDICATES FRP TO 48" ABOVE FINISH FLOOR TO EXTENTS SHOWN. VERIFY LOCATION WITH SPROUTS PRIOR TO INSTALLATION.
29. DASHED LINE INDICATES LOCATION OF MOISTURE RESISTANT GYPSUM BOARD 2'-0" MINIMUM FAST SINK AND 6" ABOVE CEILING IN ALL SET AREAS.
30. DASHED LINE INDICATES SPLIT ABOVE.
31. FRP, (TEXTURED) FLOOR TO CEILING.
32. ELECTRICAL PANEL(S) SURFACE MOUNTED AT SM CONDITION.
33. NEW TRUCK DOCK BUMPERS AND SEALS - DIRECT BUY - RITE HITE.
34. DOCK LEVELER - PAINT STEEL ANGLE FRAME AT FLOOR SAFETY YELLOW.
35. AIR CURTAIN.
36. G.C. TO PROVIDE STAINLESS STEEL CLOSURE AT CASE END CAP AND CASE TOP AS NEEDED. TYPICAL OF ALL WALL CASES.
37. PLUTWOOD ALONG FACE OF COOLER - PROVIDED BY COOLER BOX MANUFACTURER.
38. MILLWORK PROVIDED BY SPROUTS.
39. EXTEND WALL STUDS TO ROOF DECK PROVIDE 5/8" GYPSUM BOARD FULL HEIGHT ON STORAGE / RECEIVING SIDE OF WALL ONLY.
40. 1 x 6 SYNTHETIC LUMBER CHAIR RAIL - SEE DETAIL 14/14/0 - DO NOT PAINT.

KEYED NOTES:

1. DASHED LINE INDICATES 2X6 HORIZONTAL IN-WALL WOOD BACKING AT 6" AND 8'-0" AND 2X6 HORIZONTAL IN-WALL WOOD BACKING AT 6'-0" AT VITATIN WALL SHELVING.
2. EXISTING STRUCTURAL COLUMN - REF TO STRUCTURAL DRAWINGS. FURRING WRAP AT SM CONDITION.
3. AT ELECTRIC ADA CARTS, PROVIDE 1/2" SYNTHETIC LUMBER CHAIR RAIL AT 0' ABOVE FINISH FLOOR AND EXTEND CHAIR RAIL 6" BEYOND CARTS.
4. TOP OF STUD WALL TO 5'-0" ABOVE FINISH FLOOR OR AT TOP OF ADJACENT COOLER WALL.
5. PLUMBING VENT OR REFRIGERATION LINE CHASE, VERIFY LOCATIONS OF PLUMBING VENTS AND REFRIGERATION LINE CHASE WITH PLUMBING AND REFRIGERATION PLANS.
6. WALL MOUNTED DECOR FEATURE.
7. ALUMINUM AND GLASS STOREFRONT SYSTEM - EXISTING - BY OTHERS.
8. 5/8" GYF. BOARD OVER 3/8" METAL STUDS AT 16" O.C. - FULL HEIGHT.
9. DASHED LINE INDICATES 48" x 48" HIGH DIAMOND PLATE 09" ALUMINUM TREADBRITE TO 5" ABOVE FINISH FLOOR TO PROTECT COOLER BOX WALL FROM MEAT GRINDER. PROVIDED AND INSTALLED BY COOLER BOX MANUFACTURER.
10. UNDER FLOOR WALKER DUCT ELECTRICAL CHASE. SEE ELECTRICAL DRAWINGS. SEE SHEET A7.0 FOR FINISH.
11. D.S.A. PANEL.
12. STAINLESS STEEL CORNER GUARD TO 48" ABOVE FINISH FLOOR, AT END WALLS PROVIDE FULL WIDTH CAP GUARDS IN LIEU OF CORNER GUARDS AT SM CONDITION. EXTEND GUARD FROM TOP OF BASE TO CEILING.
13. LOCATION OF 5/8" CLEAR SEALED ACX PLYWOOD GLASSCOAT 1/4" HIGH (1/4" SIDE EXPOSED) OVER GYPSUM BOARD STUD WALL. PLUTWOOD INSTALLED EXCEPT WHERE SHELVING OCCURS. COORDINATE WITH FLO.
14. GALVANIZED STEEL CORNER GUARD 48" HIGH, AT SM CONDITION PROVIDE CAP GUARDS AT JAMBS AND HEADER, IN LIEU OF CORNER GUARDS AT ENDS OF WALLS.
15. STAINLESS STEEL FROM TOP OF BASE TO UNDERBASE OF WOOD. EXTEND 18" BEYOND FACE OF WOOD AND OVER AT SIDES - SEAL HOOD TIGHT TO WALL.
16. AUTOMATIC ENTRY DOOR WITH SENSORS TO MATCH SPROUTS REQUIREMENTS AND MANUFACTURER. SEE DOOR SCHEDULE.
17. PROVIDE 48" HIGH FRP AT ELECTRIC DRINKING FOUNTAIN AND RECESSED SIDE WALLS - EXTEND TO DOOR FRAMES IF NOT RECESSED.

SPROUTS FARMERS MARKET
8550 SANTA MONICA BLVD.
WEST HOLLYWOOD, CA 90069
BASEMENT FLOOR PLAN

DATE: 12-09-16
SCALE: AS NOTED
DRAWN BY: AAD
PROJECT NUMBER: 320104110
SHEET: A1.0A
REV:

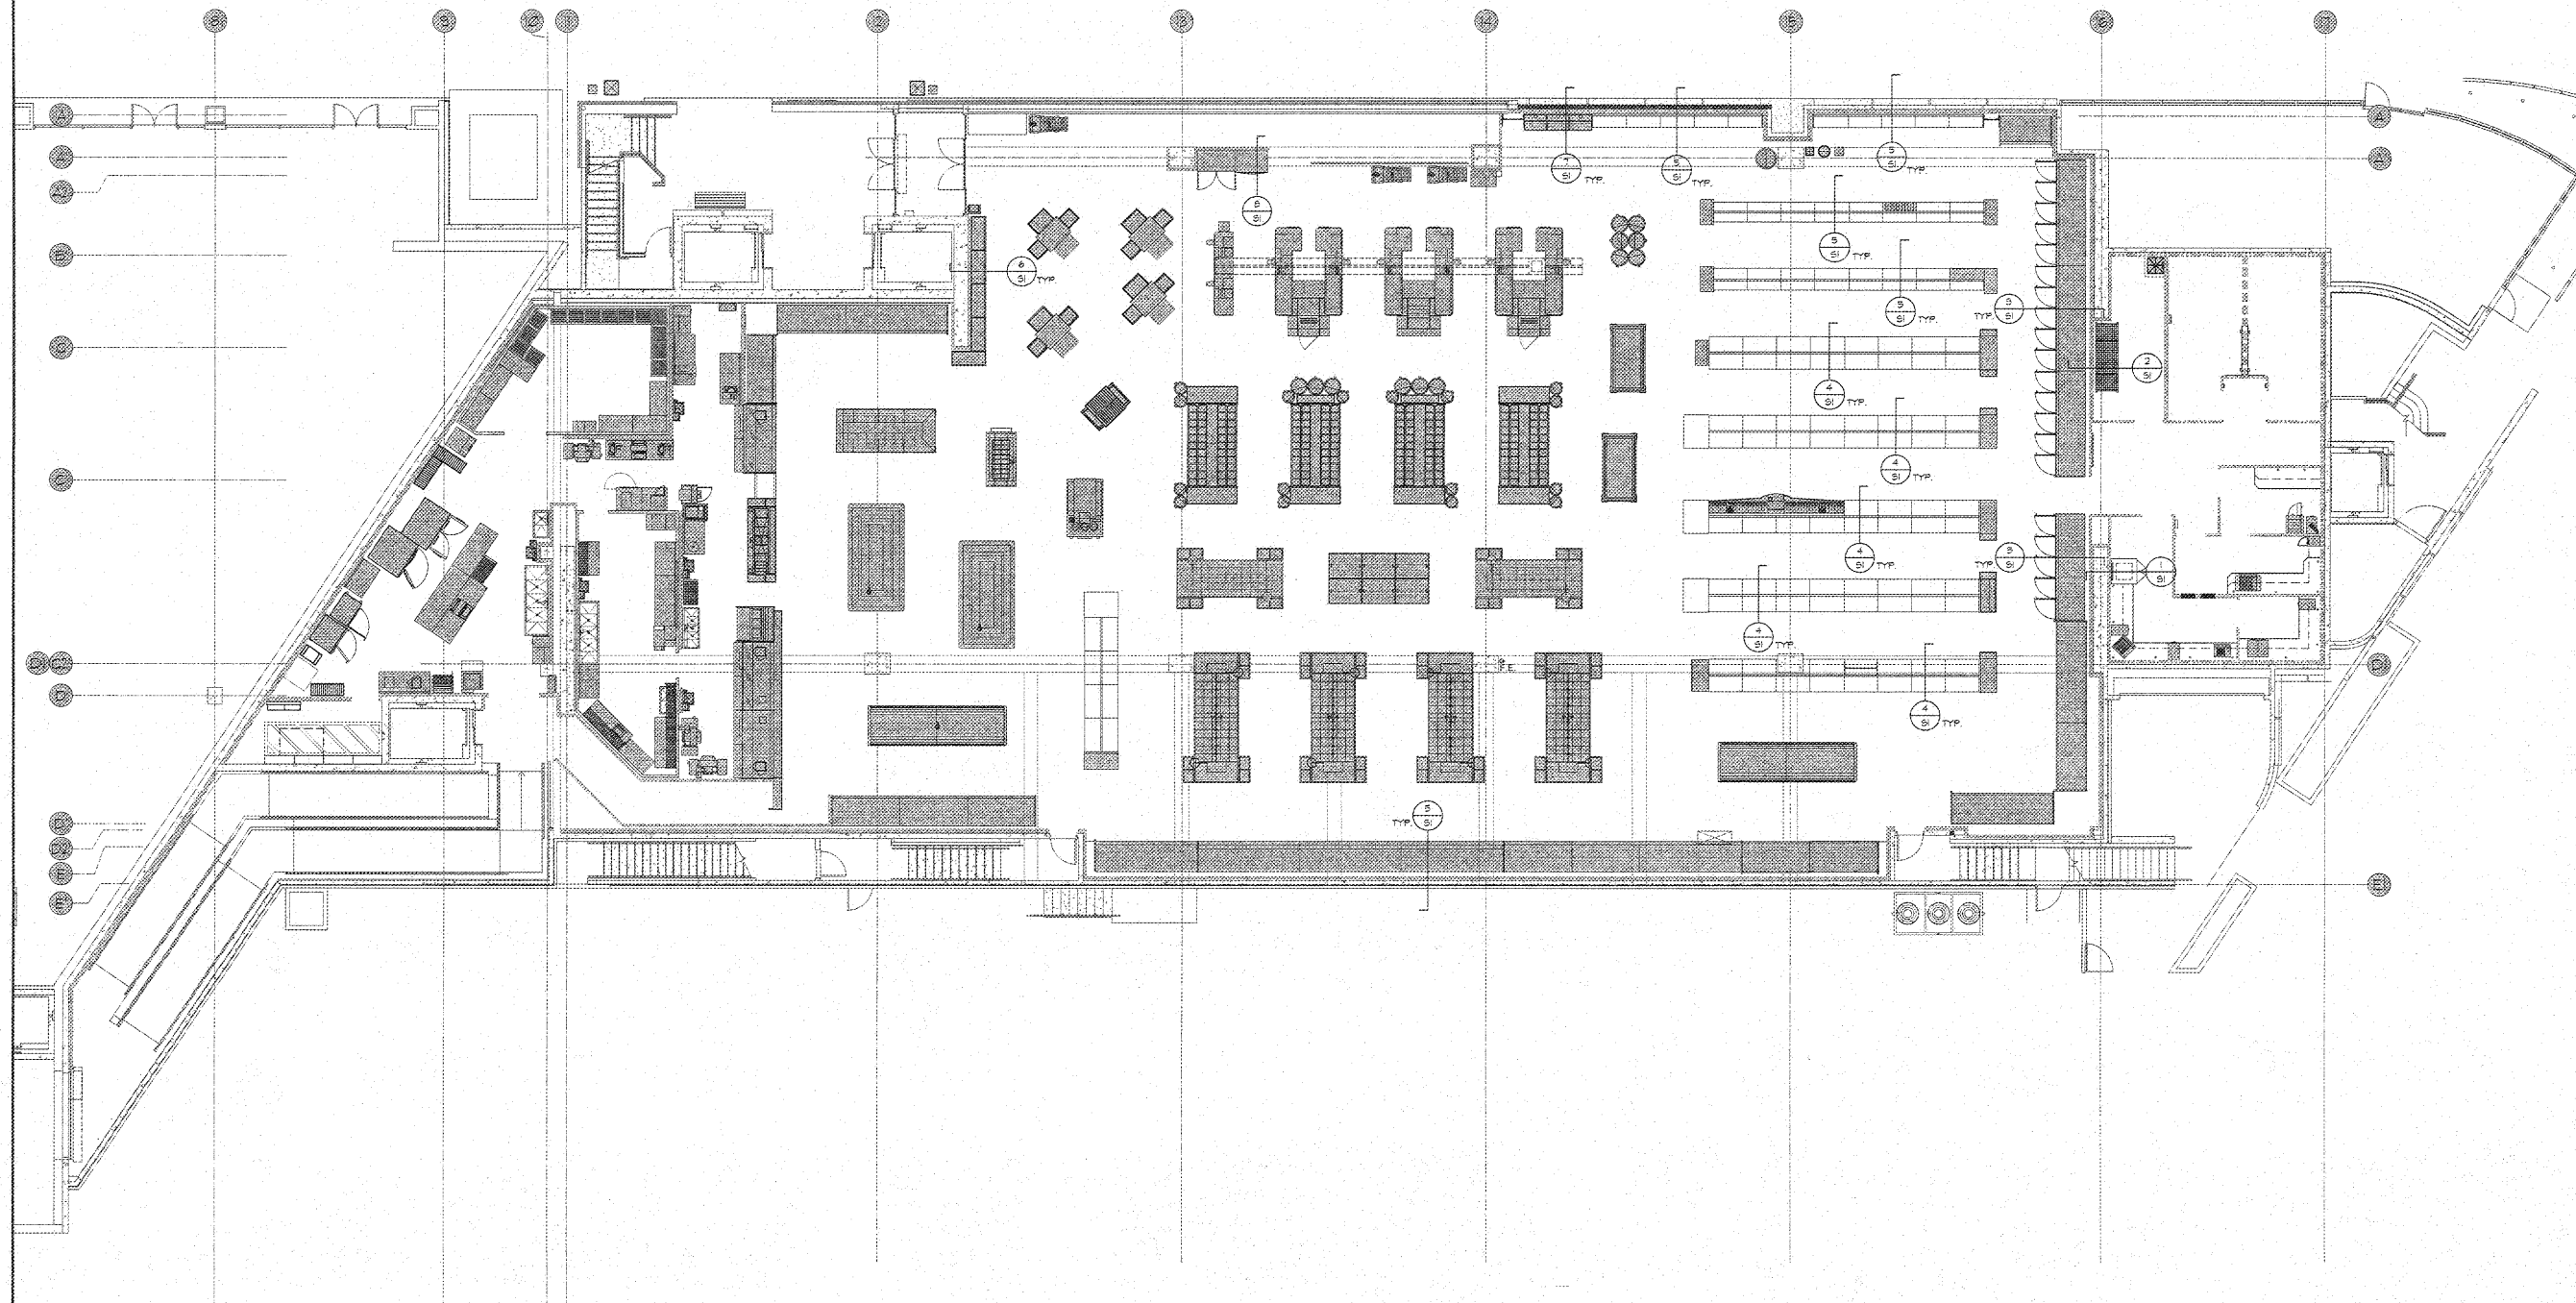

FIXTURE PLAN - 1ST LEVEL
SCALE: 1/8" = 1'-0"



320104110

COPYRIGHT NOTICE:
These drawings and specifications are
copyrighted and subject to copyright
protection as an "architectural work"
under sec. 102 of the copyright act,
17 U.S.C. as amended January 2003.
The protection includes, without
limitation, the overall form,
arrangement and composition of
drawings, and elements of the design.
Under such protection, unauthorized
use of these drawings and
specifications may result in cessation
of construction, building seizure, and/or
monetary penalty.

AAD/FITCH, Inc.
FITCH
10425 Van Sant Avenue, Suite 200
Van Nuys, California 91411
Tel: 818.709.0077
www.fitch.com

SPROUTS
FARMERS MARKET
SPROUTS of WEST HOLLYWOOD, CA
WEST HOLLYWOOD, CA


REVISION	REVISION	REVISION	REVISION	REVISION	REVISION
1	2	3	4	5	6
DATE	DATE	DATE	DATE	DATE	DATE
BY	BY	BY	BY	BY	BY

CONSULTING ENGINEER
REINFORCED CONCRETE
REINFORCED CONCRETE
2801 W. 10TH AVE. SUITE 100
LOS ANGELES, CA 90007
TEL: 310.441.1111
FAX: 310.441.1112

PRELIMINARY
NOT FOR
CONSTRUCTION

SPROUTS FARMERS MARKET
8550 SANTA MONICA BLVD.
WEST HOLLYWOOD, CA 90069

DATE: 12-04-18
SCALE: AAD
DRAWN BY: AAD
PROJECT NUMBER: 320104110
SHEET: **S2**
REV:

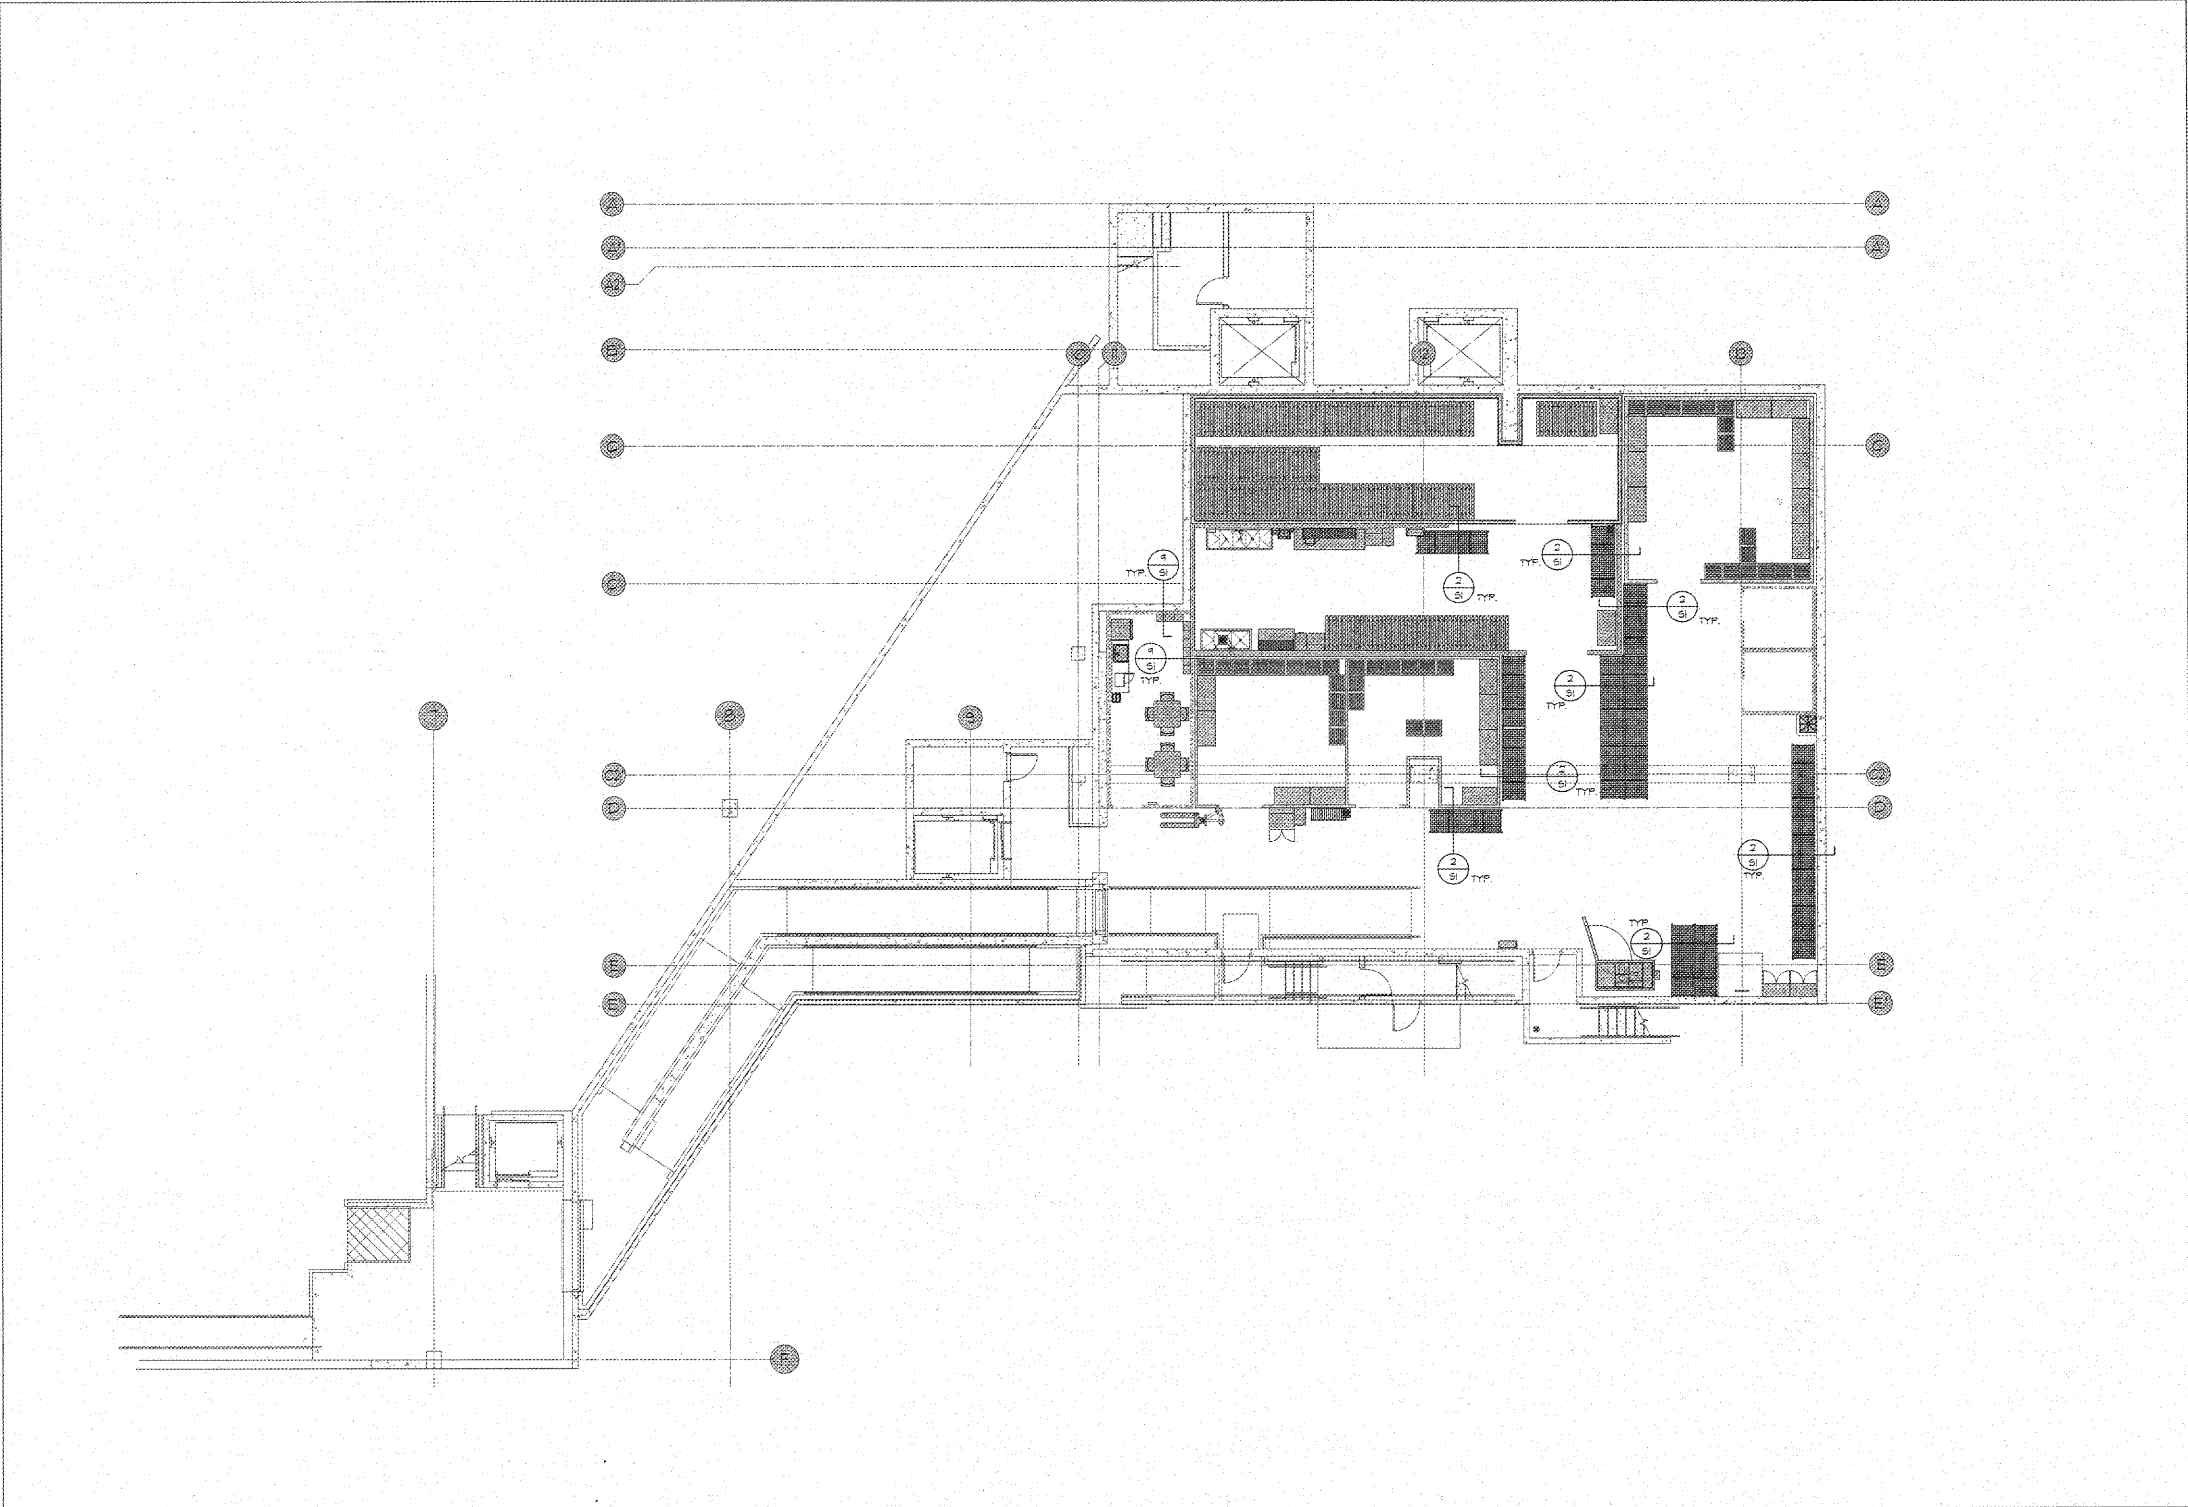

FIXTURE PLAN - BASEMENT LEVEL
SCALE: 1/8" = 1'-0"



320104110

COPYRIGHT NOTICE:
These drawings and specifications are
copyrighted and subject to copyright
protection as an architectural work
under sec. 102 of the copyright act
of 1976, U.S.C. As amended January 2002.
The protection includes, without
limitation, the overall form,
arrangement and composition of
spaces, and elements of the design.
Under such protection, unauthorized
use of these drawings and
specifications may result in violation
of copyright law, and /
or constitute a crime.

AAD:FITCH, Inc.
FITCH
1425 North Hollywood Blvd., Suite 100
North Hollywood, CA 91606
Tel: 818 506 6300 Fax: 818 506 6301
www.fitch.com


SPROUTS
FARMERS MARKET
SPROUTS OF WEST HOLLYWOOD
WEST HOLLYWOOD, CA

REVISION	DATE	BY	APP'D
1	12-04-15	AA	AA
2	12-04-15	AA	AA
3	12-04-15	AA	AA
4	12-04-15	AA	AA
5	12-04-15	AA	AA
6	12-04-15	AA	AA
7	12-04-15	AA	AA
8	12-04-15	AA	AA
9	12-04-15	AA	AA
10	12-04-15	AA	AA
11	12-04-15	AA	AA
12	12-04-15	AA	AA
13	12-04-15	AA	AA
14	12-04-15	AA	AA
15	12-04-15	AA	AA
16	12-04-15	AA	AA
17	12-04-15	AA	AA
18	12-04-15	AA	AA
19	12-04-15	AA	AA
20	12-04-15	AA	AA
21	12-04-15	AA	AA
22	12-04-15	AA	AA
23	12-04-15	AA	AA
24	12-04-15	AA	AA

PRELIMINARY
NOT FOR
CONSTRUCTION

SPROUTS FARMERS MARKET
8550 SANTA MONICA BLVD.
WEST HOLLYWOOD, CA 90069

DATE: 12-04-15
SCALE:
DRAWN BY: AAD
PROJECT NUMBER: 320104110
SHEET: S3
REV:

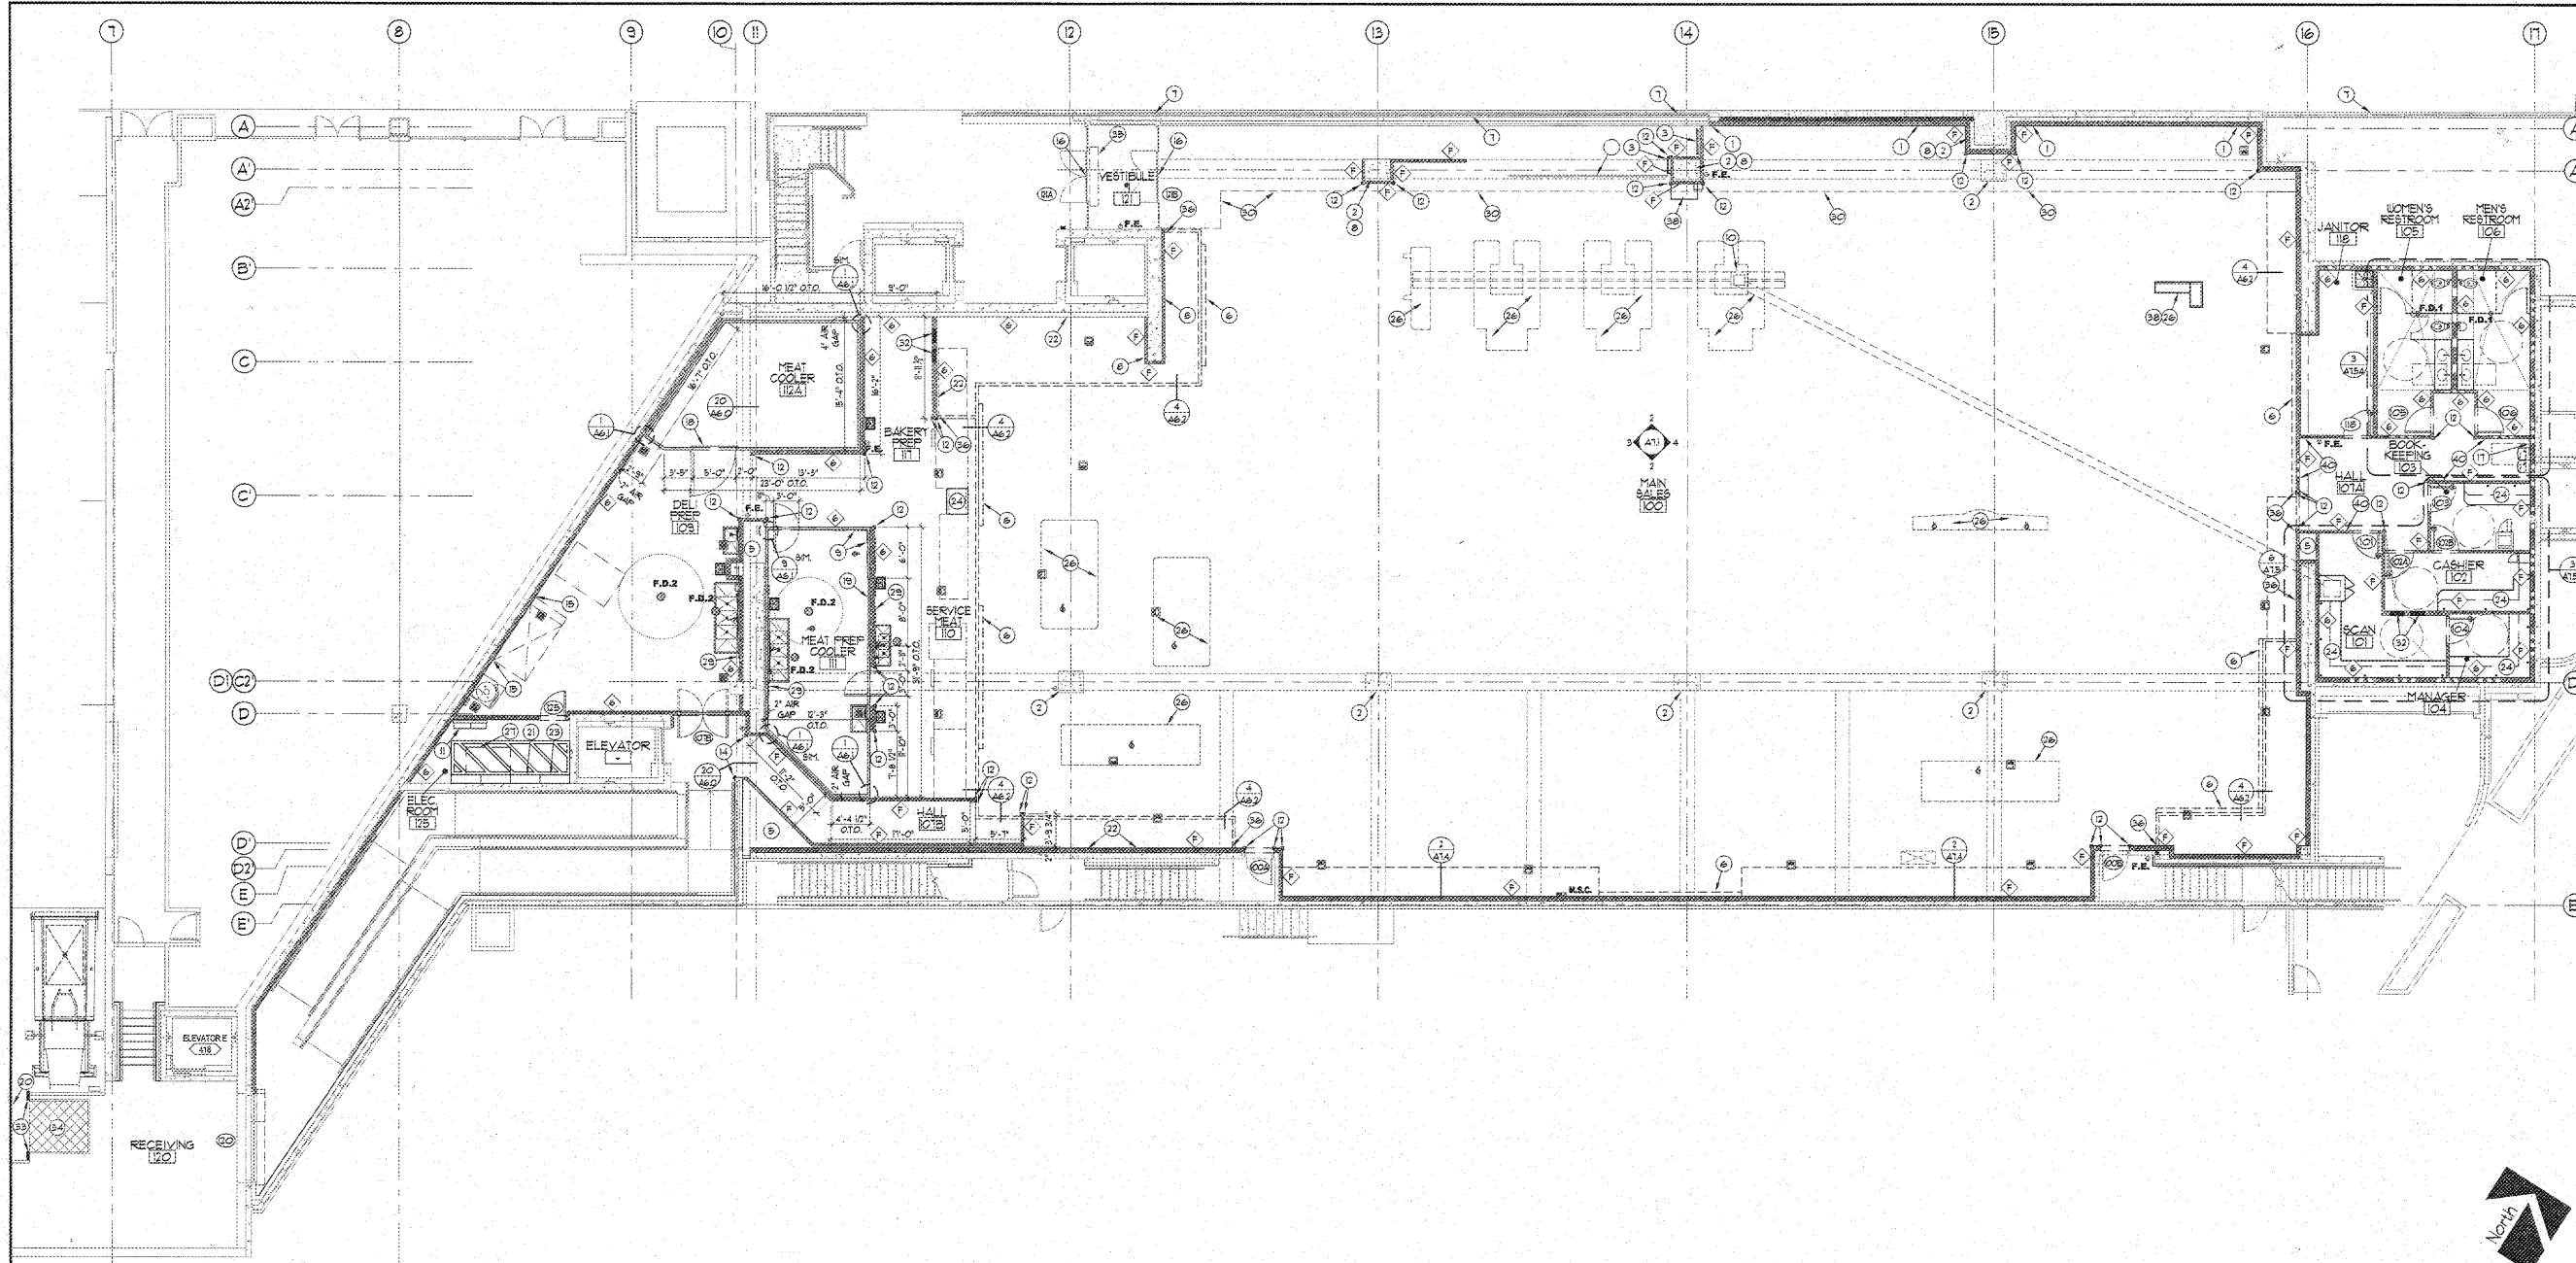

320104110

COPYRIGHT NOTICE:
These drawings and specifications are prepared and owned by Fitch, Inc. and are the property of Fitch, Inc. No part of these drawings and specifications may be reproduced or transmitted in any form or by any means electronic or mechanical, including photocopying, recording, or by any information storage and retrieval system, without the prior written permission of Fitch, Inc.

FITCH
AARFITCH, Inc.
14000 Wilshire Blvd., Suite 100
Beverly Hills, CA 90210
Tel: 310.274.1000
Fax: 310.274.1001

SPROUTS FARMERS MARKET
SPROUTS OF WEST HOLLYWOOD
WEST HOLLYWOOD, CA

REVISION

NO.	DESCRIPTION

BLAIR S. LEACH
C25788
12/13/17
STATE OF CALIFORNIA

1ST FLOOR PLAN

SCALE: 1/8" = 1'-0"

WALL LEGEND:

- INDICATES FULL HEIGHT WALL. NO GYPSUM BOARD ABOVE CEILING AT 8'0" CONDITION. REF DETAIL 314/6.5
- INDICATES 6" ABOVE CEILING.
- 3/8" METAL STUDS AT 16" O.C. WITH 5/8" BATT (R-13) INSULATION AND 5/8" GYPSUM BOARD ON BOTH SIDES UNLESS OTHERWISE NOTED
- 6" METAL STUDS AT 16" O.C. WITH 6" BATT (R-19) INSULATION AND 5/8" GYPSUM BOARD ON BOTH SIDES UNLESS OTHERWISE NOTED
- 8" METAL STUDS AT 16" O.C. AND MOISTURE RESISTANT GYPSUM BOARD REQUIRED FOR RETURN AIR BAYS TO UNDERSIDE OF ROOF DECK WITH DEEP LEE SLIP TRACK
- NEW CIVIL WALL
- CONCRETE TILT WALL
- COOLER / FREEZER WALL

FLOOR PLAN WALL LEGEND:

- F.D.1
- F.D.2
- P.B.
- F.D.C.
- D.S.
- H.B.1
- H.B.2
- M.S.C.
- R.O.
- K.E.
- F.E.

GENERAL NOTES:

- EXTERIOR WALLS TO FACE OF MASONRY AND STUDS AND CENTERLINE OF COLLUMS UNLESS OTHERWISE INDICATED.
- GENERAL CONTRACTOR SHALL VERIFY GOVERNMENTAL REQUIREMENTS PRIOR TO BID AND INCLUDE IN BID ALL COSTS ASSOCIATED WITH FIRE ALARM SYSTEM INCLUDING AUDIOVISUAL DEVICES AND PULL STATIONS WHERE REQUIRED.
- ASSIGNED PLAN FINISH FLOOR ELEVATION = 1000.0.
- UNLESS NOTED OTHERWISE, PARTITION WALLS SHALL BE CONSTRUCTED OF 5/8" METAL STUDS AT 16" O.C. (BRACE TO STRUCTURE ABOVE OR AT ADJACENT WALL) UNLESS OTHERWISE NOTED AT 48" O.C. TYPICAL THROUGHOUT - SEE SPECIFICATIONS.
- ALL ITEMS SUCH AS LIGHT SWITCHES, THERMOSTATS, SENSORS, FIRE EXTINGUISHERS, FIRE ALARM PULLS AND OTHER ITEMS TO BE LOCATED AS CLOSE AS POSSIBLE TO THE ADJACENT DOOR FRAME.
- PROVIDE SOLID BLOCKING AT ALL HARDWARE REQUIRED TO STUDS OR FURRED WALLS AT ALL CORNERS, BEVELS AND SUPPORTS INCLUDING METAL PARTITIONS, GRAB BARS, CHANGING STATIONS, WALL MOUNTED SINKS AND LAVATORIES, AT EDGES OF FIRST PANELS, DOOR HARDWARE, FALCES, FUTURE BEVELS AND WALL SUPPORTS INCLUDING.
- AT POP SINK AND 3-COMPARTMENT SINKS, ECLUSE TO PROVIDE TO CLEANING SOLUTION DISPENSER ON HOSE BOX SIDE.
- GENERAL CONTRACTOR SHALL OBTAIN THE APPROVED COOLER BOX DRAWINGS FROM THE COOLER BOX MANUFACTURER PRIOR TO CONSTRUCTION.
- BUILDING SHALL BE PROVIDED WITH A CLASS VI AUTOMATIC FIRE SPRINKLER SYSTEM THROUGHOUT. GENERAL CONTRACTOR SHALL SUBMIT A COMPLETE SET OF SHOP DRAWINGS AS REQUIRED TO GOVERNMENTAL AUTHORITIES TO BE APPROVED PRIOR TO START OF INSTALLATION. GENERAL CONTRACTOR SHALL VERIFY GOVERNMENTAL REQUIREMENTS PRIOR TO BID AND ALL REQUIREMENTS FOR A COMPLETE FIRE SPRINKLER SYSTEM ARE TO BE INCLUDED IN BID (HOSE STREAM ALLOWANCES OF 200 GPM SHALL BE ADDED TO THE SPRINKLER SYSTEM WATER DEMAND WHERE LOCATED IN A RETAIL, SHOPPING CENTER). FIRE SPRINKLER PLANS MUST BE APPROVED BY ARCHITECT, OWNER AND CITY PRIOR TO FABRICATION. SYSTEM SHALL COMPLY WITH NFPA 13. MINIMUM FIRE FLOW RATES SHOULD BE VERIFIED AND SUBMITTED TO GOVERNMENTAL AUTHORITIES FOR A PRE-INSURANCE REVIEW OF THE AUTOMATIC FIRE SPRINKLER SYSTEM PRIOR TO DESIGN. SPRINKLER HEADS AT PROPOSED CEILING AREAS ARE TO BE 60" RECESSED THROUGHOUT - SEE SPECIFICATIONS. SPRINKLER SYSTEM TO BE AS TIGHT TO ROOF DECK AS POSSIBLE AND NOT UNDER OR THROUGH RAILINGS.
- WALL AND CEILING MATERIALS SHALL NOT EXCEED THE FLAME SPREAD CLASSIFICATIONS IN IBC TABLE 803.3.

KEYED NOTES CONT.:

- STRIP CURTAINS HANG TIGHT TO CEILING AND ROLL-UP FOR PROTECTION DURING CONSTRUCTION.
- OPENING IN COOLER WALL FOR WINDOWS BY COOLER BOX MANUFACTURER.
- LOADING DOCK NOT SHOWN IN ITS ENTIRETY - REF. CIVIL DRAWINGS.
- POWERWALL TO BE ON 4" HIGH CONCRETE PAD TO MATCH WIDTH AND LENGTH OF POWERWALL - SEE STRUCTURAL AND ELECTRICAL DRAWINGS.
- NO KILL DRIED VERTICAL ROUGH BAIN WESTERN RED CEDAR WOOD PANELING TO CEILING OVER 5/8" O.S.B.
- TELEPHONE MOUNTING BOARD.
- MILLWORK PROVIDED BY GC - SEE SHEET A8.0.
- 4" x 8" SLAT WALL BY SPROUTS - TO BE MOUNTED ON TOP OF CHAIR RAIL.
- 225 KVA TRANSFORMER (ABOVE).
- DASHED LINE INDICATES PREP TO 48" ABOVE FINISH FLOOR TO EXTENDS SHOWN. VERIFY LOCATION WITH SPROUTS PRIOR TO INSTALLATION.
- DASHED LINE INDICATES LOCATION OF MOISTURE RESISTANT GYPSUM BOARD 4'-0" MINIMUM FAST SINK AND 6" ABOVE CEILING IN ALL WET AREAS.
- DASHED LINE INDICATES SCORRY ABOVE.
- FRP (EXTENDED) FLOOR TO CEILING.
- ELECTRICAL PANELS, SURFACE MOUNTED AT 8'0" CONDITION.
- NEW TRUCK DOCK BUMPERS AND SEALS - DIRECT BUY - RITE HITE.
- DOCK LEVELER - PAINT STEEL ANGLE FRAME AT FLOOR SAFETY YELLOW.
- AIR CURTAIN.
- G.C. TO PROVIDE STAINLESS STEEL CLOSURE AT CASE END CAP AND CASE TOP AS NOTED - TYPICAL OF ALL WALL CASES.
- PLYWOOD ALONG FACE OF COOLER - PROVIDED BY COOLER BOX MANUFACTURER.
- MILLWORK PROVIDED BY SPROUTS.
- EXTEND WALL STUDS TO ROOF DECK PROVIDE 3/8" GYPSUM BOARD ROLL HEIGHT ON STORAGE / RECEIVING SIDE OF WALL ONLY.
- 1/2" SYNTHETIC LUMBER CHAIR RAIL - SEE DETAIL 165/A6.2 - DO NOT PAINT.

KEYED NOTES:

- DASHED LINE INDICATES 2x4 HORIZONTAL N-WALL WOOD BACKING AT 6" AND 6'-0" AND 2x2 HORIZONTAL N-WALL WOOD BACKING AT 9'-0" AT VITAMIN WALL SHELVING.
- EXISTING STRUCTURAL COLLUM - REF TO STRUCTURAL DRAWINGS. FURRING WRAP AT 8'0" CONDITION.
- AT ELECTRIC ADD-A-CARTS, PROVIDE 1/2" SYNTHETIC LUMBER CHAIR RAIL AT 0" ABOVE FINISH FLOOR AND EXTEND CHAIR RAIL 6" BEYOND CARTS.
- TOP OF BUILD WALL TO 9'-0" ABOVE FINISH FLOOR OR AT TOP OF ADJACENT COOLER WALL.
- PLUMBING VENT OR REFRIGERATION LINE CHASE. VERIFY LOCATIONS OF PLUMBING VENTS AND REFRIGERATION LINE CHASE WITH PLUMBING AND REFRIGERATION PLANS.
- WALL MOUNTED DECOR FEATURE.
- ALUMINUM AND GLASS STOREFRONT SYSTEM - EXISTING - BY OTHERS.
- 5/8" GYP BOARD OVER 3/8" METAL STUDS AT 16" O.C. - FULL HEIGHT.
- DASHED LINE INDICATES 48" x 48" HIGH DIAMOND PLATE 20" ALUMINUM TREADS TO 5" ABOVE FINISH FLOOR TO PROTECT COOLER BOX WALL FROM MEAT GRINDER. PROVIDED AND INSTALLED BY COOLER BOX MANUFACTURER.
- UNDER FLOOR WALKER DUCT ELECTRICAL CHASE. SEE ELECTRICAL DRAWINGS. SEE SHEET A10 FOR FINISH.
- D.S.A. PANEL.
- STAINLESS STEEL CORNER GUARD TO 48" ABOVE FINISH FLOOR, AT END WALLS PROVIDE FULL WIDTH CAP GUARDS IN LIEU OF CORNER GUARDS AT 8'0" CONDITION. EXTEND GUARD FROM TOP OF BASE TO CEILING.
- LOCATION OF 5/8" CLEAR SEALED JACK PLYWOOD UNANCOAT (48" HIGH) (SIDE EXPOSED) OVER GYPSUM BOARD STUD WALL. PLYWOOD INSTALLED EXCEPT WHERE SHELVING OCCURS. COORDINATE WITH FIO.
- GALVANIZED STEEL CORNER GUARD 48" HIGH AT 8'0" CONDITION PROVIDE CAP GUARDS AT JABS AND HEADER IN LIEU OF CORNER GUARDS AT ENDS OF WALLS.
- STAINLESS STEEL FROM TOP OF BASE TO UNDERSIDE OF HOOD. EXTEND 8" BEYOND FACE OF HOOD AND OVER AT SEALS - SEAL HOOD TIGHT TO WALL.
- AUTOMATIC ENTRY DOOR WITH SENSORS TO MATCH SPROUTS REQUIREMENTS AND MANUFACTURER. SEE DOOR SCHEDULE.
- PROVIDE 48" HIGH FRP AT ELECTRIC DRINKING FOUNTAIN AND RECESSED SIDE WALLS - EXTEND TO DOOR FRAMES IF NOT RECESSED.

SPROUTS FARMERS MARKET
8550 SANTA MONICA BLVD.
WEST HOLLYWOOD, CA 90069
1ST FLOOR PLAN

DATE: 12-09-15
SCALE: AS NOTED
DRAWN BY: AAD
PROJECT NUMBER: 320104110
SHEET: A1.0
REV: