

ELECTRICAL LEGEND

SYMBOL	DESCRIPTION	SYMBOL	DESCRIPTION
⊙	SINGLE POLE SWITCH 46" AFF OR AS NOTED, a = SWITCH DESIGNATION	⊙	OUTLET, JUNCTION OR PULL BOX
⊙	THREE POLE SWITCH 46" AFF OR AS NOTED, a = SWITCH DESIGNATION	—(A)	HOME RUN TO PANEL (A)
⊙	SINGLE POLE DIMMER SWITCH 46" AFF OR AS NOTED, a = SWITCH DESIGNATION	⊙	PANELBOARD 208Y/120V OR 240V/120V, TOP 12" AFF
⊙	MANUAL MOTOR STARTER	⊙	2X4 LIGHT FIXTURE A = FIXTURE TYPE PER SCHEDULE 5 = CIRCUIT NUMBER b = SWITCH DESIGNATION DESIGNATIONS THE SAME FOR ALL LIGHT FIXTURES.
⊙	DUPLEX RECEPTACLE 18" AFF OR AS NOTED	—	LIGHT STRIP PER FIXTURE SCHEDULE
⊙	DUPLEX RECEPTACLE (MOUNTED ABOVE COUNTER) 46" AFF OR AS NOTED	⊙	HID LIGHT FIXTURE, SEE SCHEDULE FOR SPEC'S
⊙	SINGLE RECEPTACLE 125V, 20A, 18" AFF OR AS NOTED (2)	⊙	EXHAUST FAN
⊙	DUPLEX GFI RECEPTACLE 18" AFF OR AS NOTED	⊙	EXIT LIGHT
⊙	DUPLEX GFI RECEPTACLE (MOUNTED ABOVE COUNTER) 46" AFF OR AS NOTED	⊙	EMERGENCY LIGHT
⊙	(2) DUPLEX RECEPTACLES IN 2 GANG BOX WITH COMMON COVERPLATE, 18" AFF OR AS NOTED	⊙	TELEVISION OUTLET
⊙	COMMUNICATIONS/DATA OUTLET 18" AFF OR AS NOTED, CAT 6 CABLE TO OFFICE	⊙	ABBREVIATIONS
⊙	TELEPHONE OUTLET	GFI	GROUND FAULT INTERRUPTER
⊙	DISCONNECT SWITCH, AMPERAGE/POLE/VOLTAGE/USE/NEHA TYPE (NEHA 1 UN) AS INDICATED	UP	WEATHER PROOF
		ST	SHUNT TRIP BREAKER
		NL	NIGHT LIGHT - WIRE SO THAT LIGHTS CAN BE DIMMED BUT ALWAYS ON
			LEGEND GENERAL NOTES:
			(1) ALL MOUNTING HEIGHTS ARE TO CENTERLINE UN
			(2) ALL SYMBOLS MAY NOT BE USED

GENERAL NOTE:

CONTRACTOR SHALL CONSTRUCT AN ON SITE MEETING WITH THE ELECTRICAL CONTRACTOR TO VERIFY EXISTING ELECTRICAL CONDITIONS. MINUTES OF SUCH MEETING AND FINDINGS SHALL BE SUBMITTED TO THE ARCHITECT PRIOR TO CONSTRUCTION.

ISSUED FOR:
PERMIT

CURTIS T. LATZO
FLORIDA STATE BOARD
OF ENGINEERING
PE#2005

N.O.F.
CORPORATE OFFICE
6130 22nd AVE. NORTH
ST. PETERSBURG, FLORIDA 33710

PROJECT:

SKA
SOFARELLI & ASSOCIATES ARCHITECTURE
MICHAEL F. SOFARELLI JR. A.I.A.
6365 42nd AVENUE NORTH
CLEARWATER, FLORIDA 33760 1727 530-3835
EMAIL: sofarell@mikenet.com

Revisions:

06/26/18	OWNER REVISION
07/13/18	OWNER REVISION
07/18/18	REVIEW COMMENTS
08/10/18	OWNER REVISION
07/26/18	OWNER REVISION
07/15/18	OWNER REVISION
07/15/18	TENANT BUILD OUT

Content:

NEW FIRST FLOOR POWER PLAN


Filename: NOF

Date: 05-10-2018

Proj. no. 17070

Sheet:

E-2

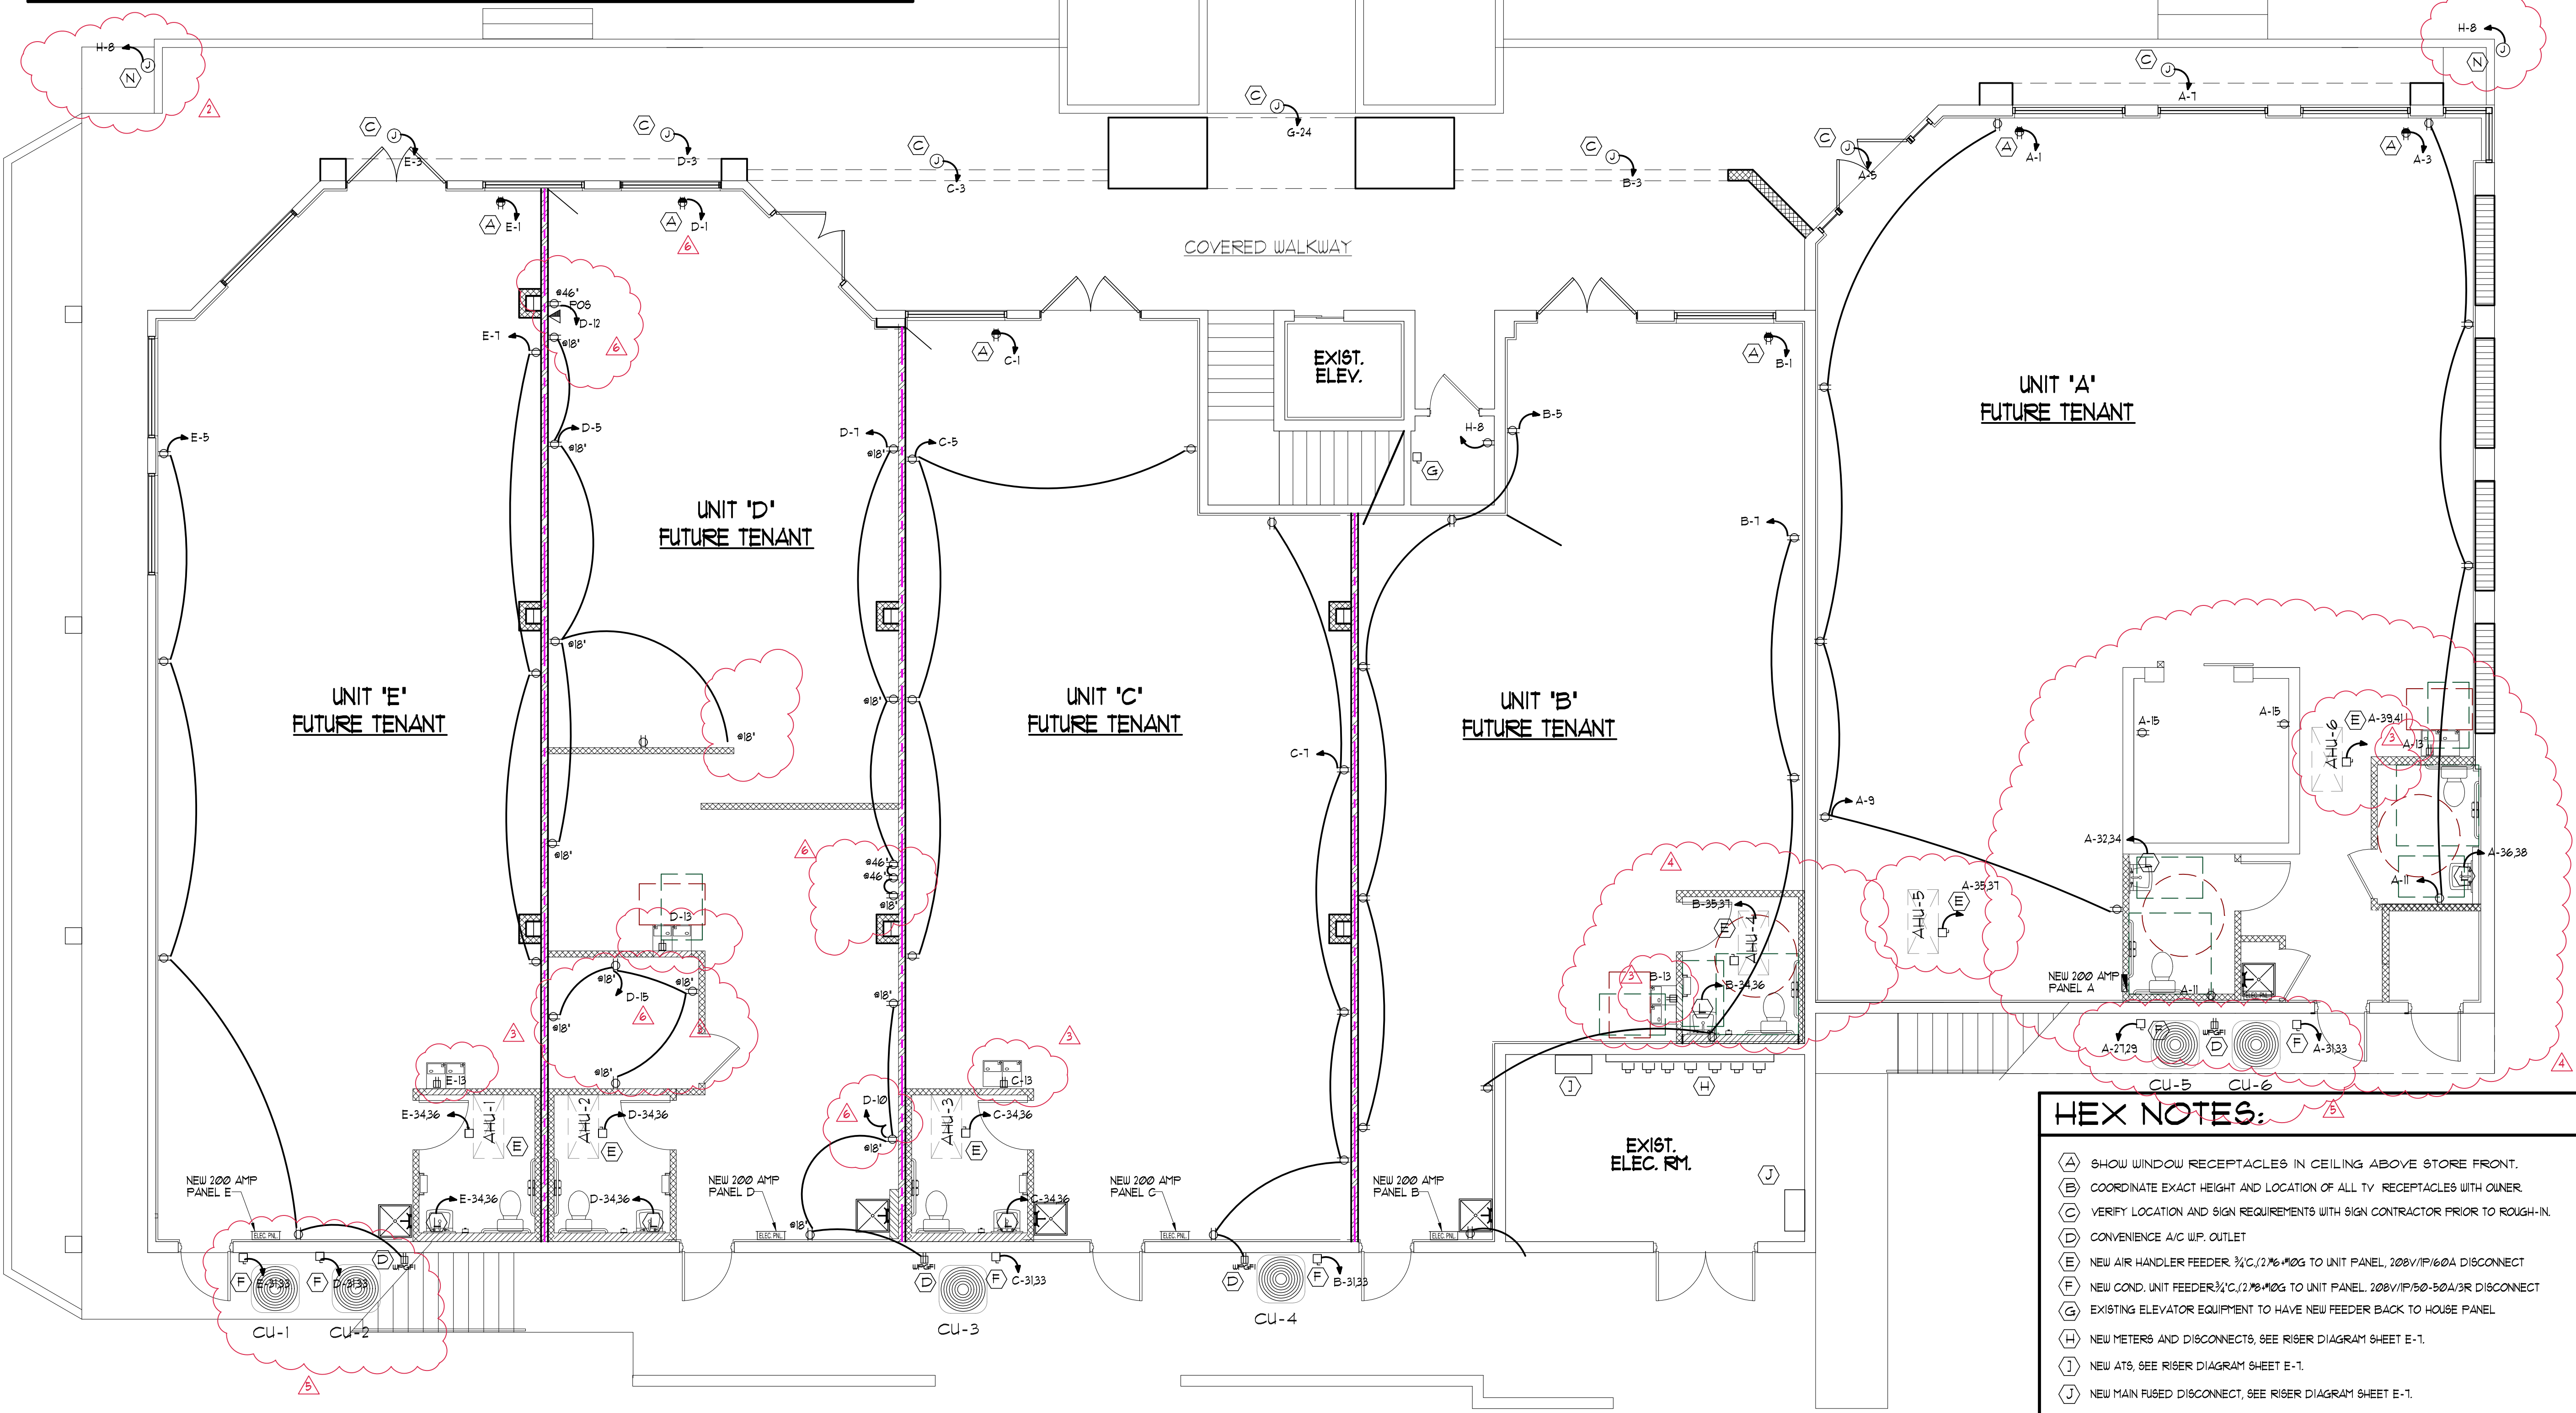

HEX NOTES:

- (A) SHOW WINDOW RECEPTACLES IN CEILING ABOVE STORE FRONT.
- (B) COORDINATE EXACT HEIGHT AND LOCATION OF ALL TV RECEPTACLES WITH OWNER.
- (C) VERIFY LOCATION AND SIGN REQUIREMENTS WITH SIGN CONTRACTOR PRIOR TO ROUGH-IN.
- (D) CONVENIENCE A/C W/P. OUTLET
- (E) NEW AIR HANDLER FEEDER 3/4" C, 120V, 100G TO UNIT PANEL, 208V/1P/60A DISCONNECT
- (F) NEW COND. UNIT FEEDER 3/4" C, 120V, 100G TO UNIT PANEL, 208V/1P/50-50A/3R DISCONNECT
- (G) EXISTING ELEVATOR EQUIPMENT TO HAVE NEW FEEDER BACK TO HOUSE PANEL
- (H) NEW METERS AND DISCONNECTS, SEE RISER DIAGRAM SHEET E-1.
- (I) NEW ATS, SEE RISER DIAGRAM SHEET E-1.
- (J) NEW MAIN FUSED DISCONNECT, SEE RISER DIAGRAM SHEET E-1.
- (K) DISCONNECT / POWER FOR STEAM SHOWER CONTROLS
- (L) INSTA-HOT WATER HEATER 3/4" C, 120V, 100G TO UNIT PANEL
- (M) DISCONNECT / POWER FOR WASHER & DRYER
- (N) OUT DOOR W/P. OUTLET

NEW FIRST FLOOR POWER PLAN

SCALE : 3/16" = 1'-0"