


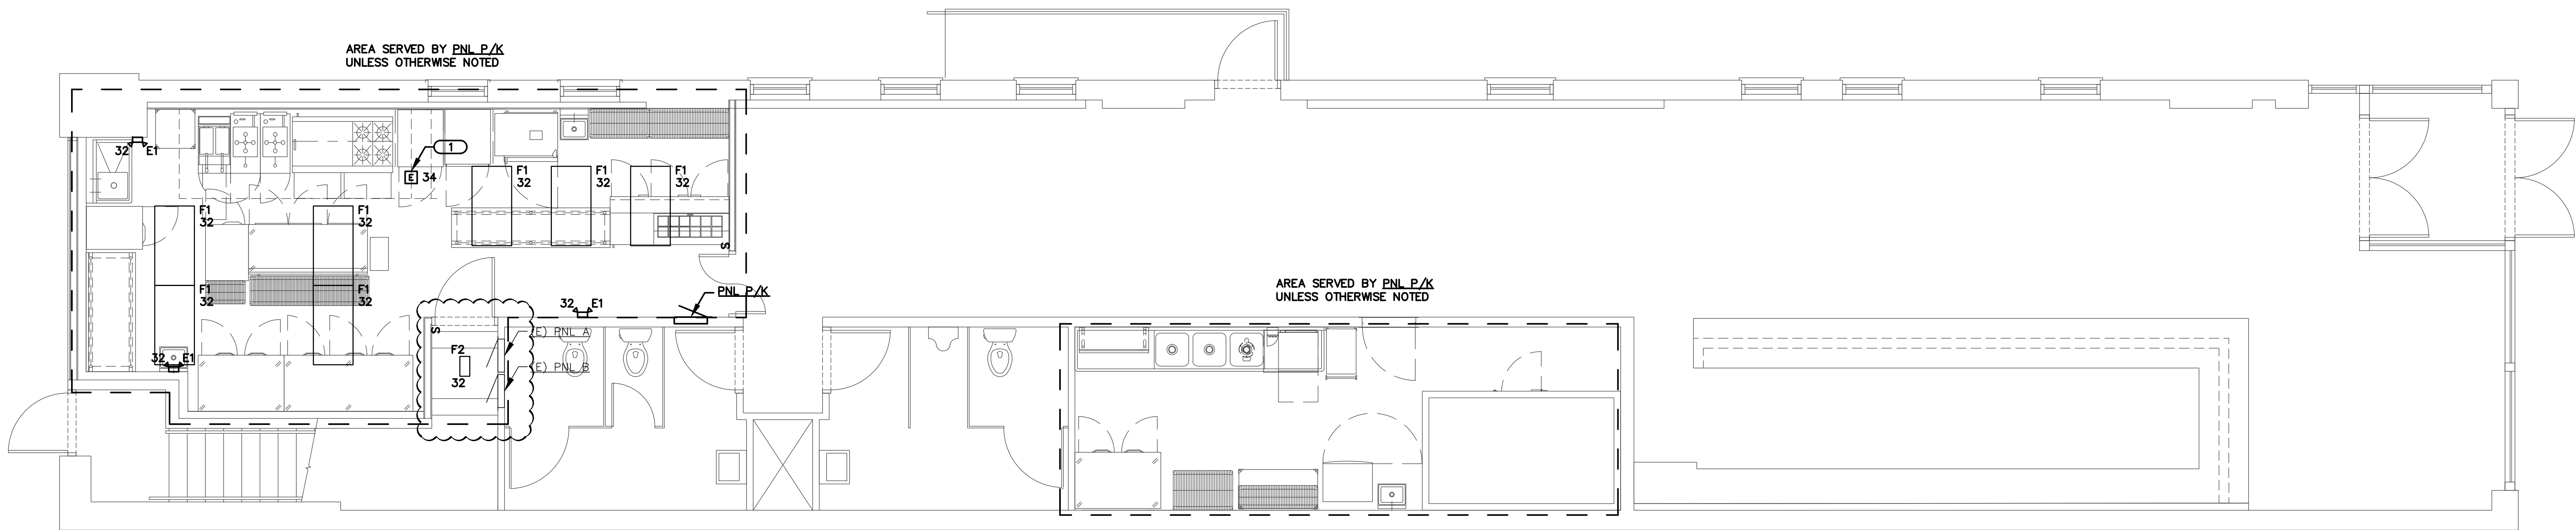

1

FIRST FLOOR PLAN - LIGHTING

SCALE: 1/4" = 1'-0"

0 12" 2' 4' 8'



GENERAL DEMOLITION NOTES:

1. REFER TO THIS SHEET E0.1 FOR "GENERAL DEMOLITION NOTES."

KEYNOTES:

1. ELECTRICAL CONNECTION TO HOOD. PROVIDE ALL FINAL CONNECTIONS.

ENGINEER
ENGINEERING CONCEPTS & SOLUTIONS, INC.
2919 CROSSING COURT, SUITE 11
CHAMPAIGN, IL 61822
217.355.9864
ECS # 15-15

ARCHITECT
STUDIO COPEL, AIA
CHAMPAIGN, IL 61821

WATSON'S CHICKEN

211 N. NEIL STREET
CHAMPAIGN, IL 61820

ISSUED FOR BIDDING
JULY 28, 2015



FIRST FLOOR PLANS
ELECTRICAL

E-1