


**RICHARD M. BITTIKOFFER**  
CIVIL ENGINEER  
134 E. PONTIAC WAY  
FRESNO, CA 93704  
PH 559 438-4432 FAX 559 438-1593  
E-MAIL: richard\_bittikoffer@earthlink.net

**OWNER**  
FADHLE MOHSIN  
2270 EAST EL MONTE WAY  
DINUBA, CALIF. 93618  
OFFICE: (559) 397-2688

**PROJECT TITLE:**  
STORAGE WAREHOUSE  
FADHLE MOHSIN  
2270 EAST EL MONTE WAY  
DINUBA, CA. 93618  
CELL 559 397-2688

JOB NO. 17039  
DRAWN BY JAL  
SHEET NO. 1  
DATE 03/20/23

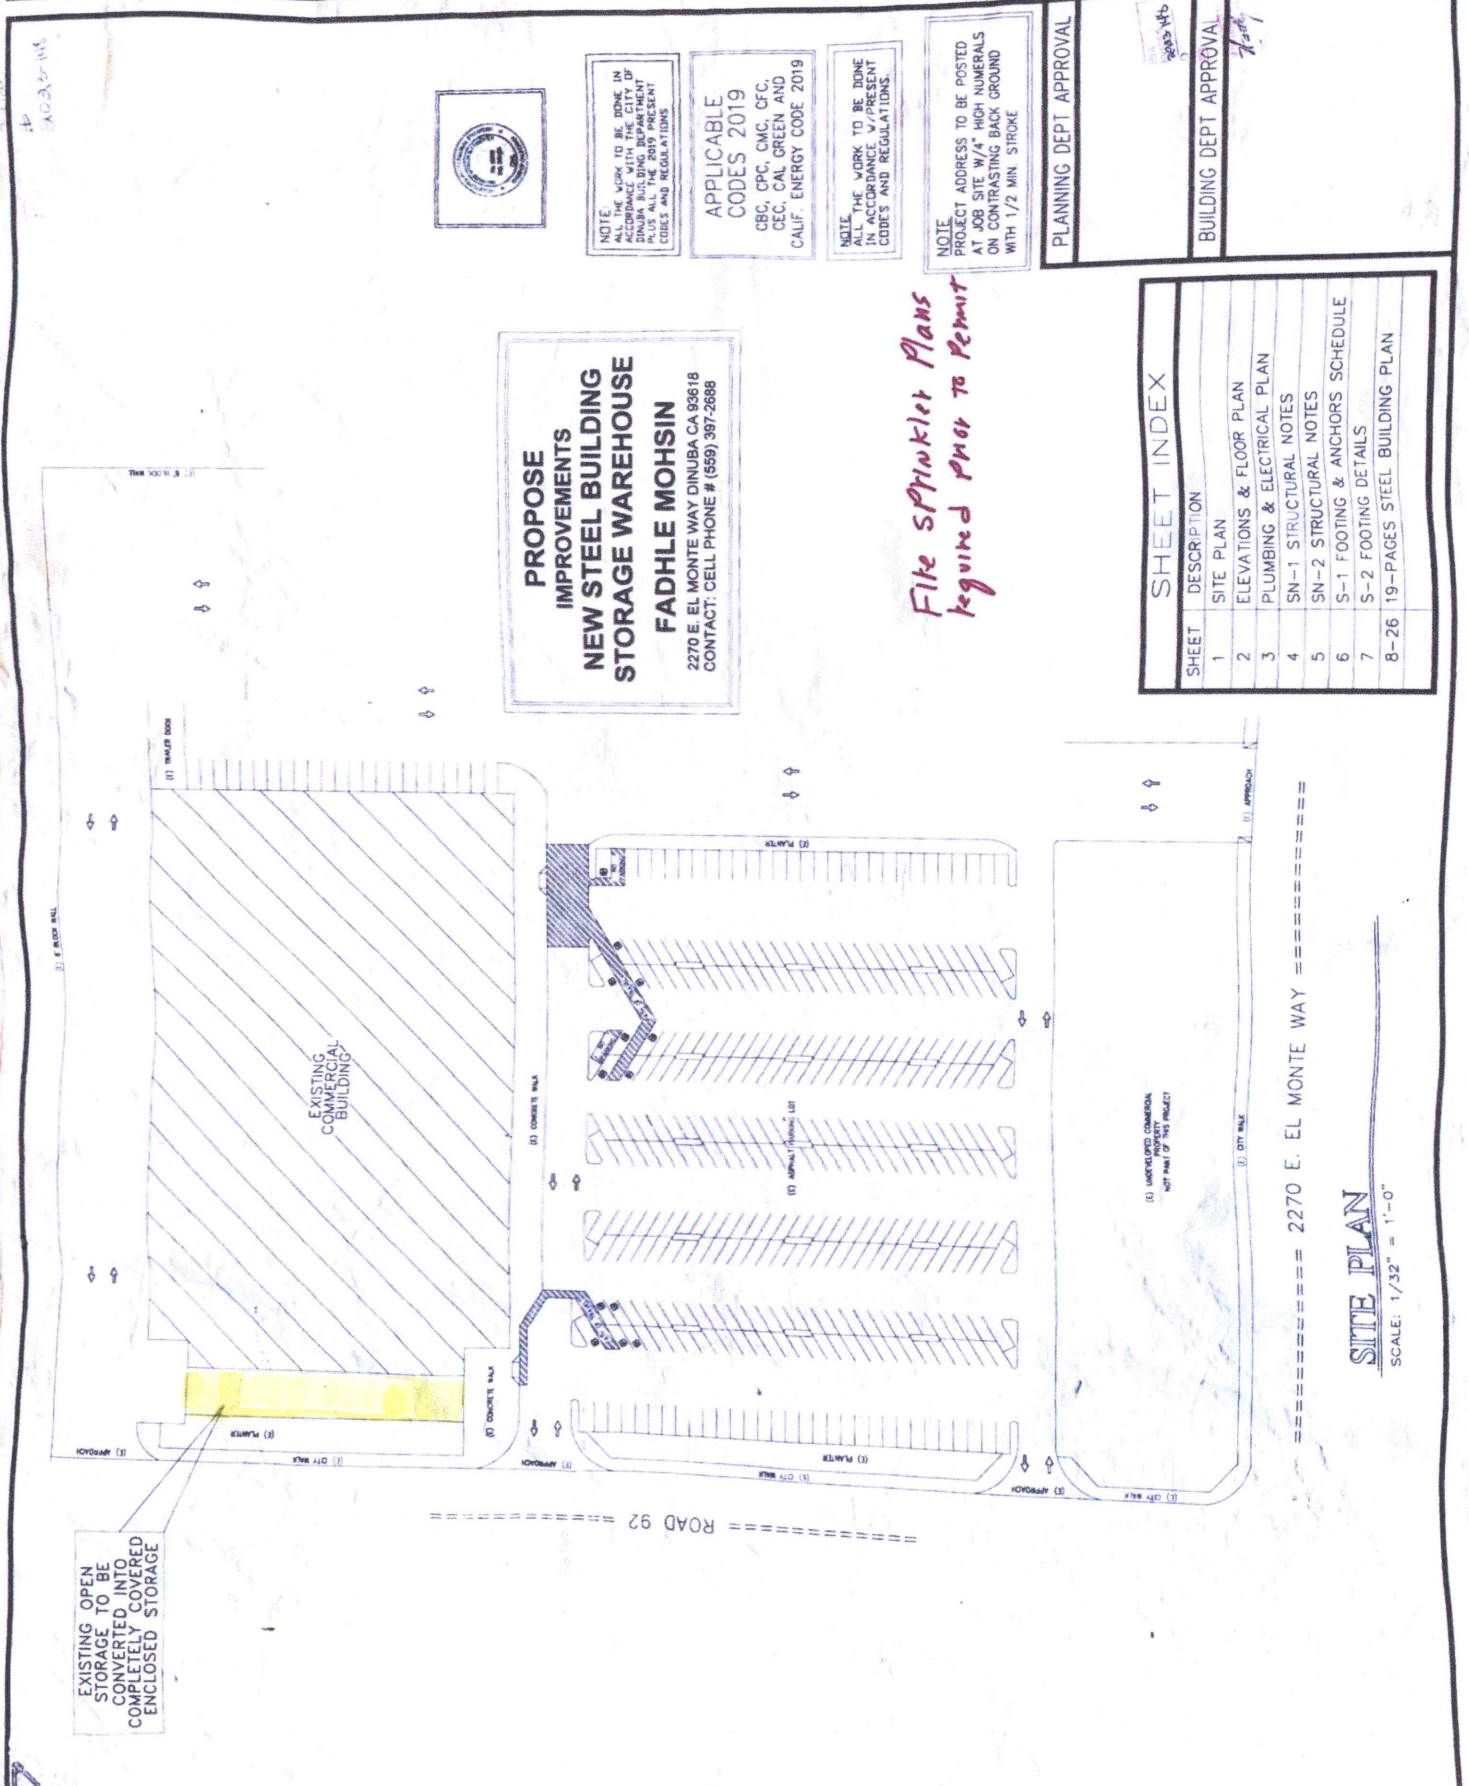

**PROPOSED IMPROVEMENTS  
NEW STEEL BUILDING  
STORAGE WAREHOUSE  
FADHLE MOHSIN**  
2270 E. EL MONTE WAY DINUBA CA 93618  
CONTACT: CELL PHONE # (559) 397-2688

*File Sprinkler Plans  
Required prior to Permit*

| SHEET | DESCRIPTION                    |
|-------|--------------------------------|
| 1     | SITE PLAN                      |
| 2     | ELEVATIONS & FLOOR PLAN        |
| 3     | PLUMBING & ELECTRICAL PLAN     |
| 4     | SN-1 STRUCTURAL NOTES          |
| 5     | SN-2 STRUCTURAL NOTES          |
| 6     | S-1 FOOTING & ANCHORS SCHEDULE |
| 7     | S-2 FOOTING DETAILS            |
| 8-26  | 19-PAGES STEEL BUILDING PLAN   |

**SITE PLAN**  
SCALE: 1/32" = 1'-0"

PLANNING DEPT APPROVAL  
BUILDING DEPT APPROVAL

**NOTE**  
PROJECT ADDRESS TO BE POSTED AT JOB SITE W/4" HIGH NUMERALS ON CONTRASTING BACK GROUND WITH 1/2 MIN. STROKE

**NOTE**  
ALL THE WORK TO BE DONE IN ACCORDANCE WITH THE CITY OF DINUBA'S ORDINANCES, PLUS ALL THE 2019 PRESENT CODES AND REGULATIONS

**APPLICABLE CODES 2019**  
CBC, CPC, CMC, CFC, CEC, CAL GREEN AND CALIF. ENERGY CODE 2019

**NOTE**  
ALL THE WORK TO BE DONE IN ACCORDANCE WITH THE CITY OF DINUBA'S ORDINANCES, PLUS ALL THE 2019 PRESENT CODES AND REGULATIONS

