


SITE PLAN 1"=20'

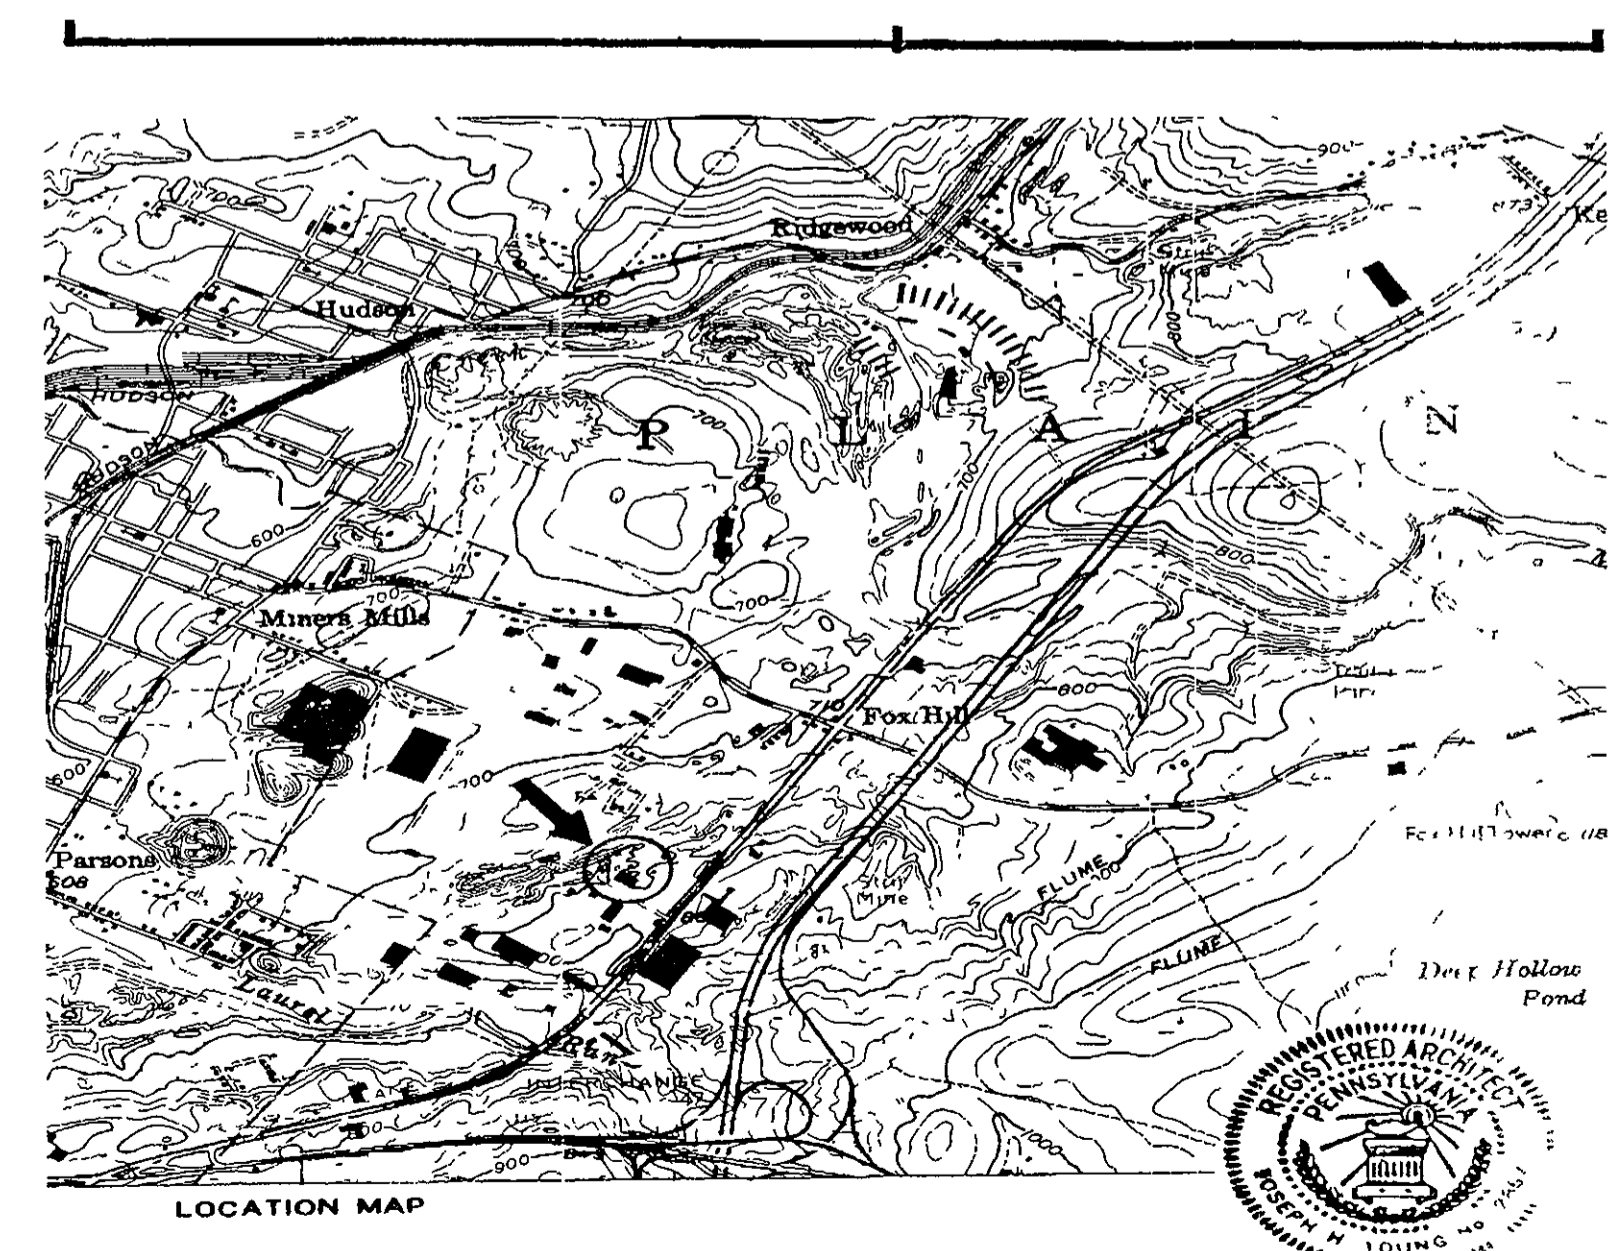

LOCATION MAP

RECEIVED TIM NOV 19 4 14PM

PRINT TIM NOV 19 4 16PM

PRELIMINARY
NOT TO BE USED FOR CONSTRUCTION



JOSEPH H YOUNG ARCHITECT SUITE 33 205-207 N WASHINGTON AVENUE P.O. BOX 688 SCRANTON PA 18501 PHONE: (570) 348-6000 FAX: (570) 348-6210	SC. NOTED	DWG.
	DT. 11-1-01	2/2
	DR. JHY	

INSTRUCTIONS
RENAL CONSULTANTS OF WYOMING VALLEY, P.C.
 PLAINS TOWNSHIP, WILKES-BARRE, PA.