


# PLUMBING SYMBOLS

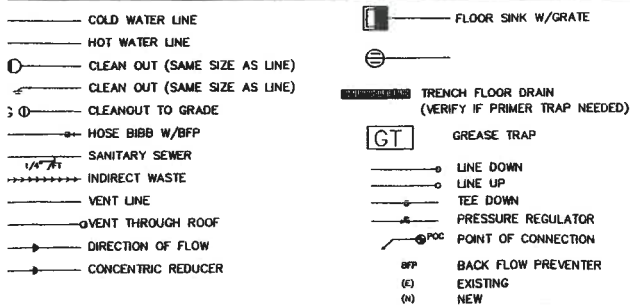

1. SODA MACHINE TO AT LEAST 10 DOWN STREAM FROM THE DISPENSER. PIPE SHALL BE APPROVED BY THE ENGINEER.
2. VENT PIPE ROUTING TO RISE VERTICALLY NOT LESS THAN 6" ABOVE FLOOD LEVEL RIM OF THE FIXTURE BEING SERVED BEFORE OFFSETTING HORIZONTALLY.
3. CONTRACTOR TO RUN VENT PIPE FOR HAND SINK, FLOOR SINK AND FLOOR DRAIN SERVING BAR AREA TO THE NEAREST APPROPRIATE LOCATION, PROVIDE CLEANOUTS AS NEEDED.
4. CONTRACTOR TO RUN 1/2" CW LINE TO ALL FLOOR DRAINS P-TRAPS PRIMERS.
5. CONTRACTOR TO VERIFY THE HEIGHT OF THE FIXTURE DRAIN CONNECTION WITH RESPECT TO FLOOD LEVEL. ALSO TO VERIFY ON SITE LOCATION OF BACKFLOW VALVES AND EJECTOR PUMPS AND COORDINATE THAT WITH ENGINEER AND BUILDING DEPARTMENT.

**INC.**  
 522 SECOND ST.  
 SAN FRANCISCO  
 CALIF. 94107  
 TEL (415) 512-7566  
 FAX (415) 546-6415

**BaySide Mechanical, Inc.**  
 2178 SO. B. CAMINO REAL  
 SAN MATEO, CA 94403  
 650-574-4000  
 FAX 650-574-4005  
 MECHANICAL, PLUMBING, CONTRACTORS

No.	Date	Revision
1	08/27/04	Plan check
2		
3		
4		



ISSUED DATE NO.

**2021**  
 Broadway  
 Street

TI Remodeling  
 Redwood City • California




DATE 6/17/05  
 SCALE 1/4"=1'-0"  
 DRAWN AH/MT  
 JOB

CHECKED MT  
 SHEET DESCRIPTION  
**MAIN FLOOR  
 WASTE AND  
 VENT PLAN**  
 SHEET

**P2.11**

OF SHEET

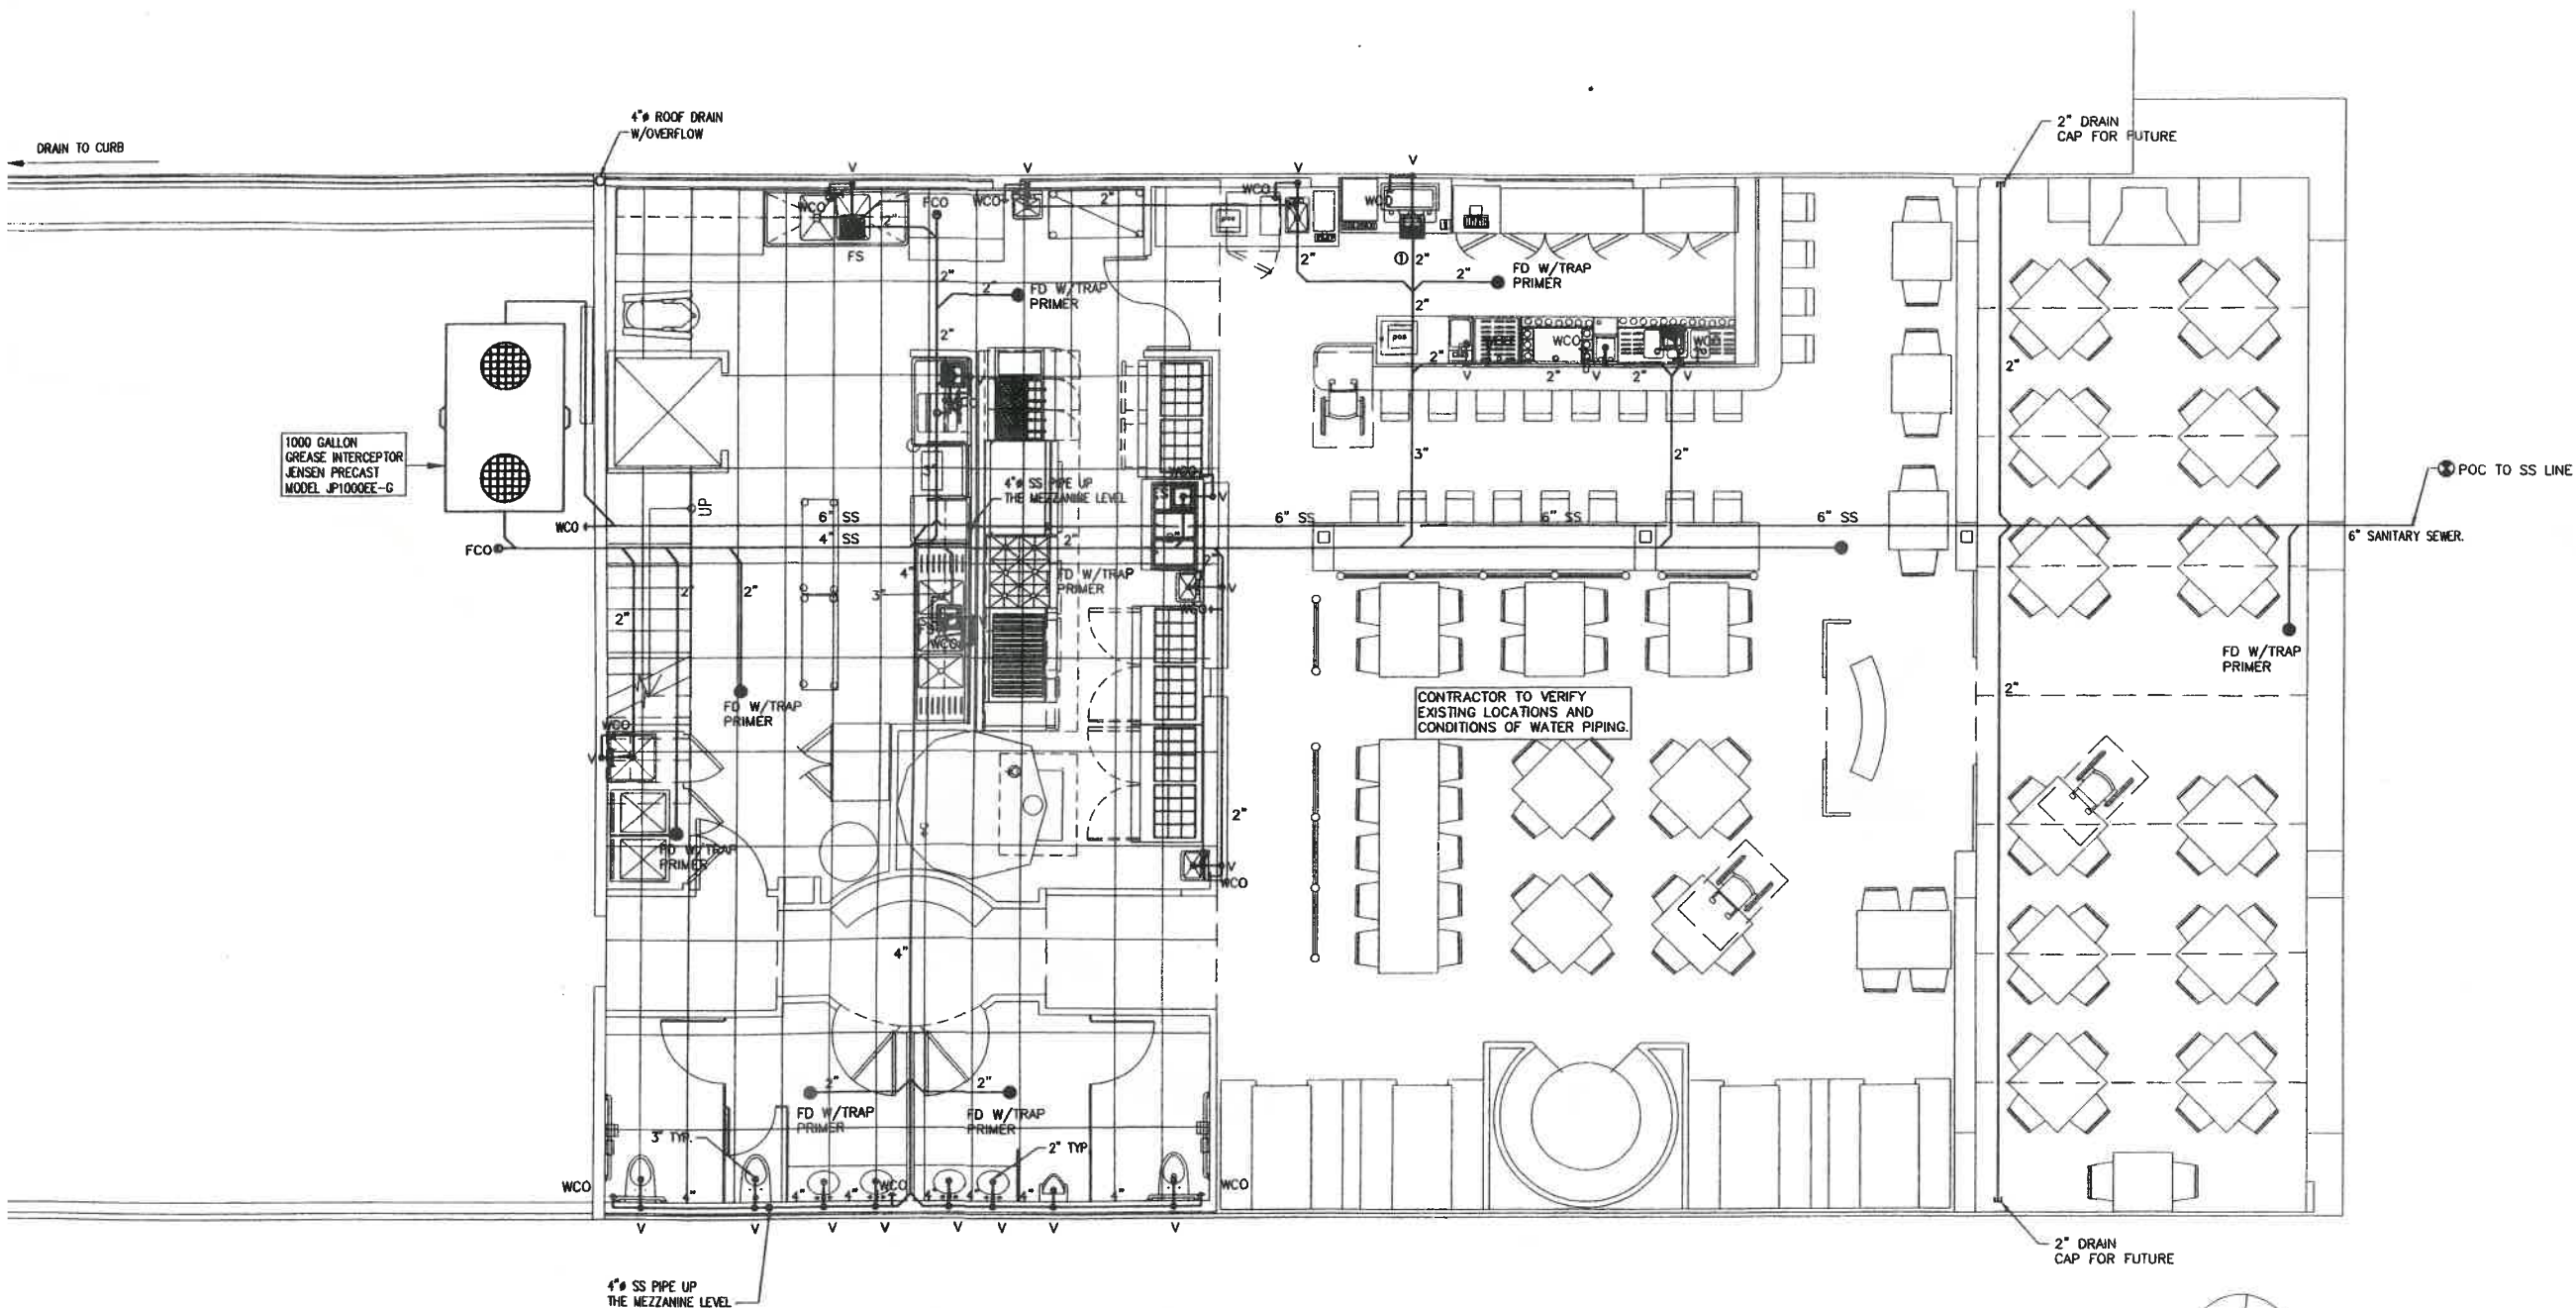

**MAIN FLOOR PLAN**  
 SCALE 1/4" = 1'-0"