



Floor Plan

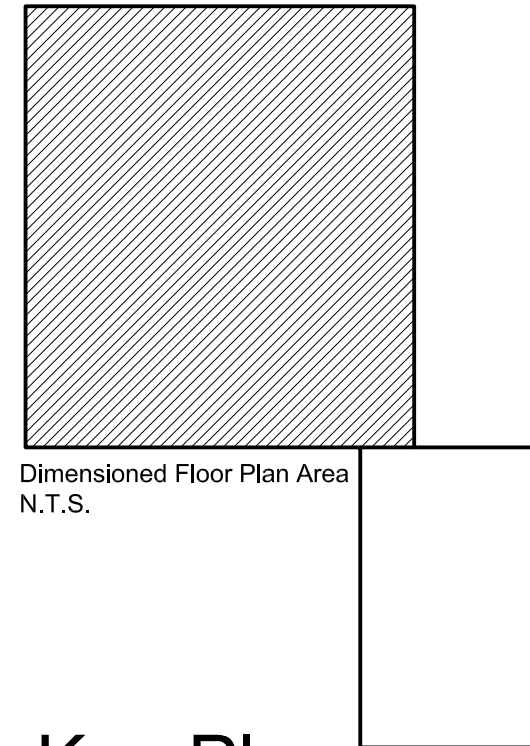

Key Plan

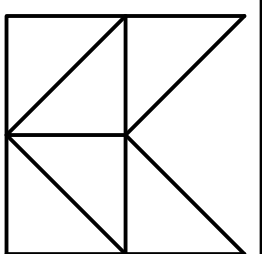

K.L. Kane Consulting, LLC
606 Charmouth Drive
Syracuse, NY 13207
Phone: (315) 263-3687
kkane@klkllc.com

REVISION NUMBER & REVISION DATE:
No. 1 - 2023.03.02

Leasing Floor Plan
1290 BLOSSOM DRIVE
ROCHESTER, NY

DRAWN BY:
KLK

CHECKED BY:
P.GILLETTE

DATE:
February 28, 2023

SCALE:
1/16" = 1'-0"

DRAWING NAME:
Dimension Control Plan

DRAWING NUMBER:

A-1