


FOR REVIEW ONLY

**STEWART ENGINEERING AND CONSTRUCTION**  
 40680 STATE HWY 59  
 BAY MINETTE, ALABAMA 36507  
 (251) 937-4313 (251) 937-1782 FAX  
 vstewart@stewartengineering.net

Revisions:

No.	Date	Description

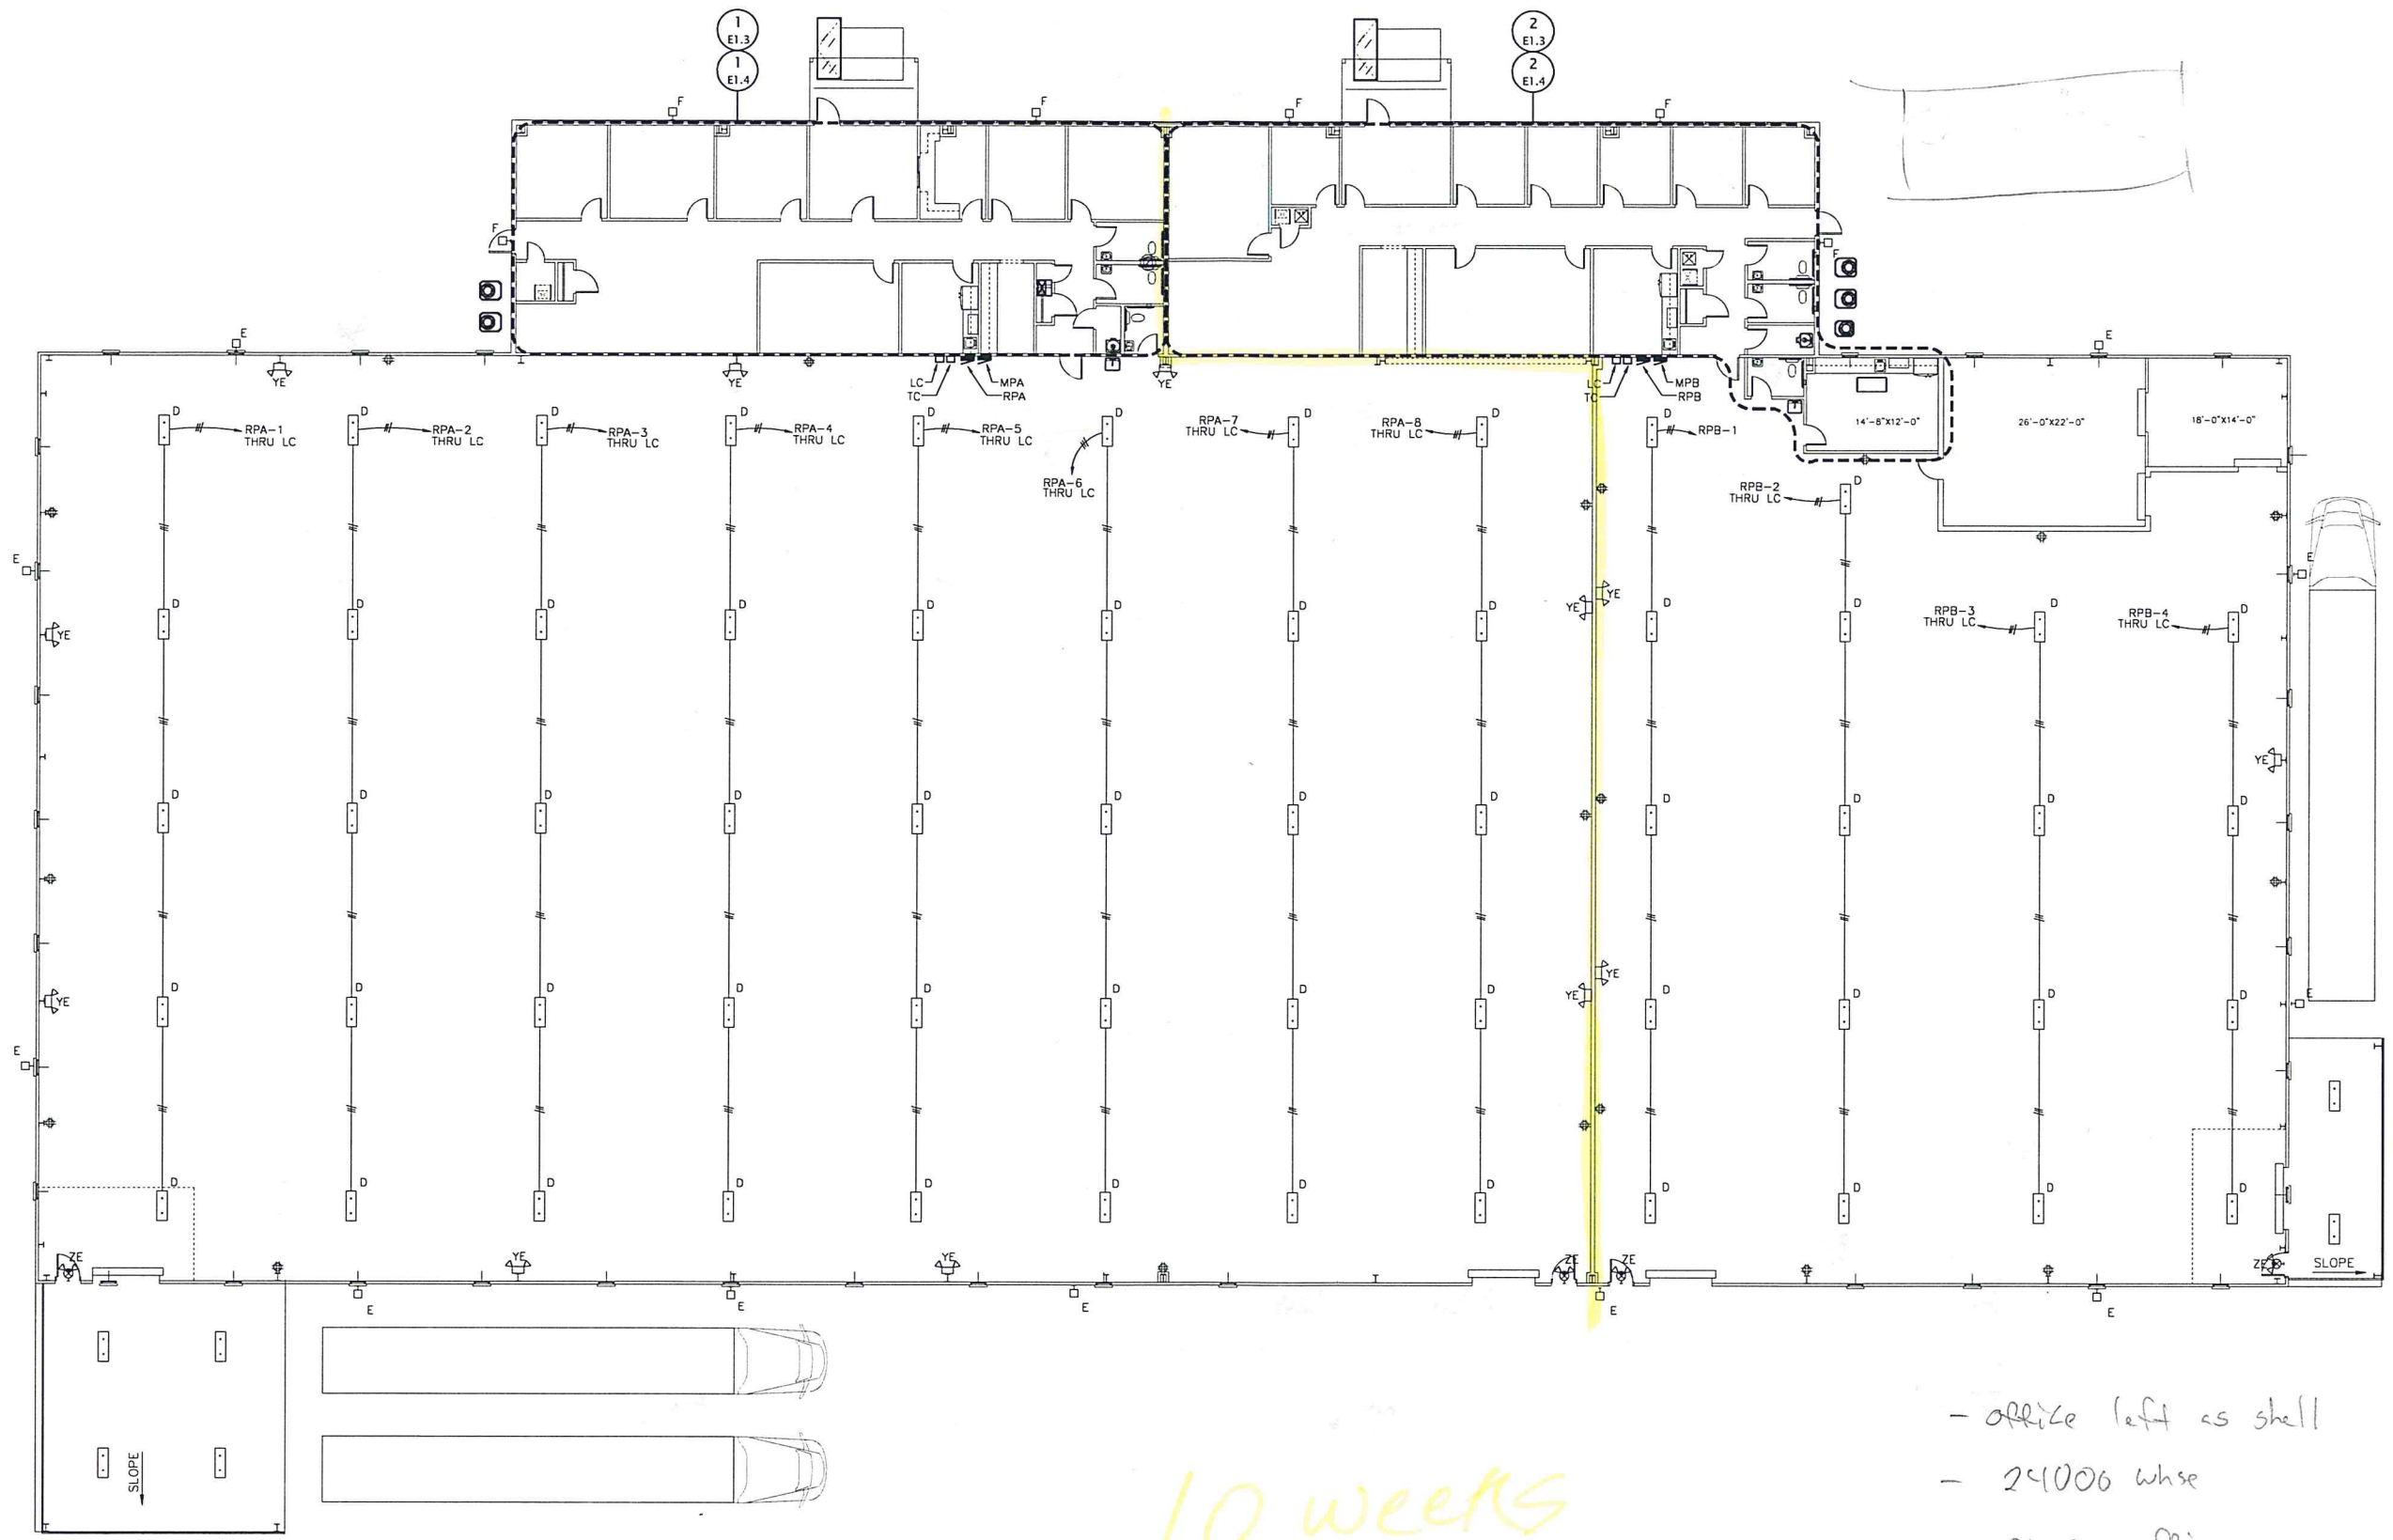

- office left as shell
- 24006 whse
- 2500 office


10 weeks

**14TH STREET INDUSTRIAL FACILITY**  
 345 14TH STREET  
 PANAMA CITY, FLORIDA

**OVERALL ELECTRICAL PLAN**

Project No.: -  
 Drawn By: Wade Stewart  
 Checked: Wade Stewart  
 Date: February, 2020  
 Sheet Number:

**E1.2**

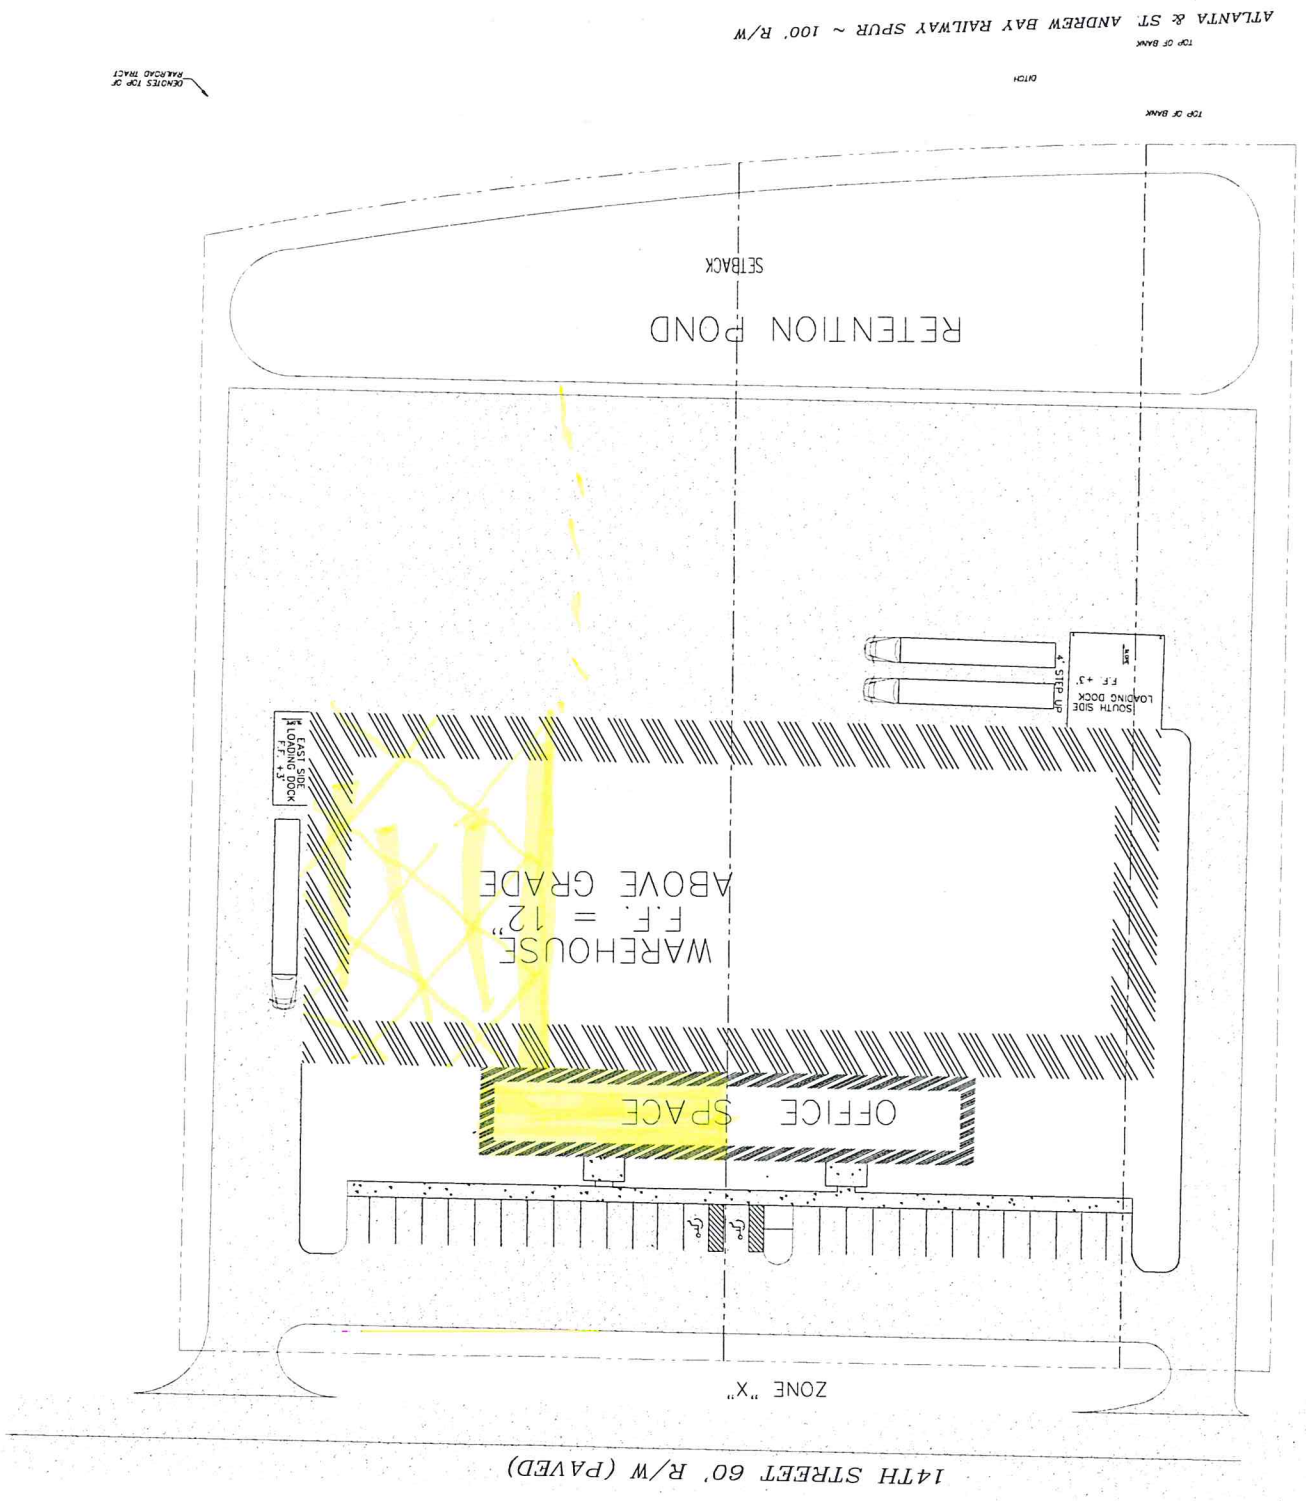

STATE AVENUE  
60' R/W (PAVED)

14TH STREET 60' R/W (PAVED)

ZONE "X"

OFFICE SPACE

WAREHOUSE  
F.F. = 12"  
ABOVE GRADE

RETENTION POND

SETBACK

TOP OF BANK

DITCH

ATLANTA & ST. ANDREW BAY RAILWAY SPUR ~ 100' R/W

LOCATES TOP OF  
PAVED TRACT

SITE  
ELECTRICAL  
PLAN

14TH STREET INDUSTRIAL FACILITY  
345 14TH STREET  
PANAMA CITY, FLORIDA

E1.1

Project No.: -  
Drawn By: Wade Stewart  
Checked: Wade Stewart  
Date: February, 2020  
Sheet Number:

No.	Date	Description

STEWART ENGINEERING  
AND CONSTRUCTION  
40680 STATE HWY 59  
BAY MINETTE, ALABAMA 36507  
(251) 937-4313 (251) 937-1782 FAX  
stewart@stewartengineering.net

FOR  
REVIEW  
ONLY




M1.1

Project No.: -  
 Drawn By: Wade Stewart  
 Checked: Wade Stewart  
 Date: February, 2020  
 Sheet Numbers:

HVAC  
 OVERALL FLOOR  
 PLAN

14TH STREET INDUSTRIAL FACILITY  
 345 14TH STREET  
 PANAMA CITY, FLORIDA

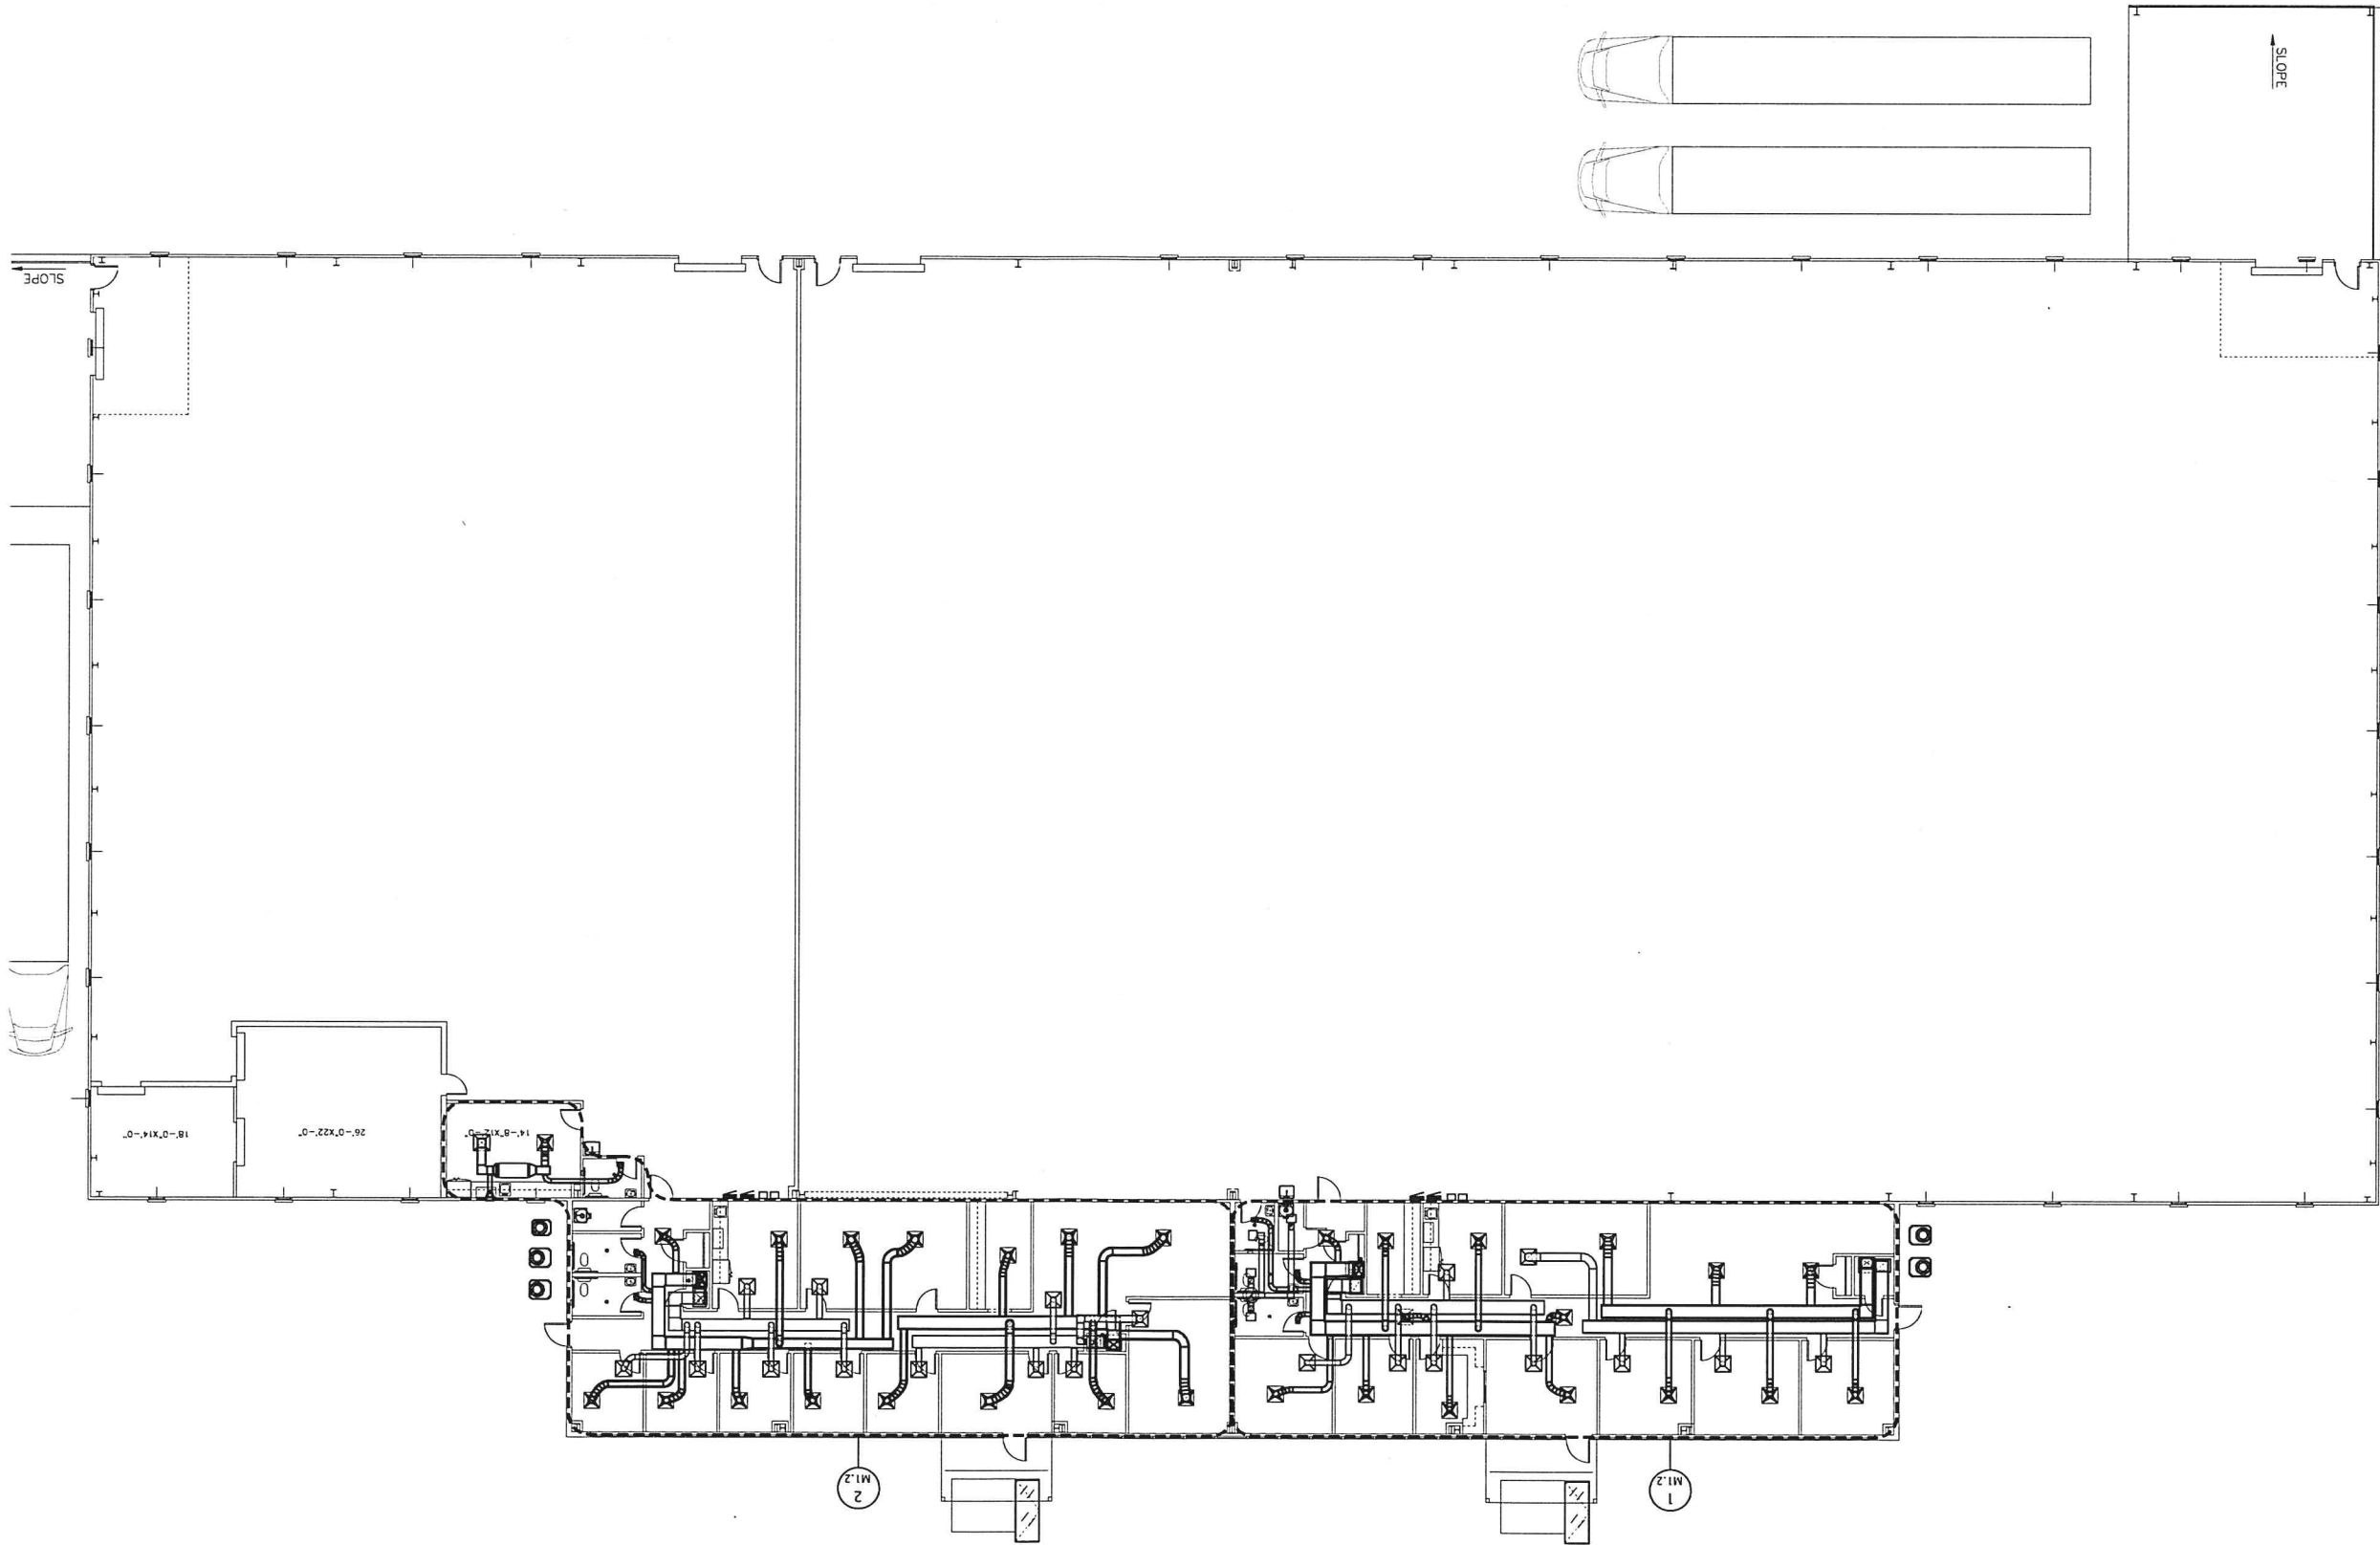

No.	Date	Description

STEWART ENGINEERING  
 AND CONSTRUCTION  
 40680 STATE HWY 59  
 BAY MINETTE, ALABAMA 36507  
 (251) 937-6313 (251) 937-1782 FAX  
 stewart@stewartengineering.net

FOR  
 REVIEW  
 ONLY

FOR  
REVIEW  
ONLY

STEWART ENGINEERING  
AND CONSTRUCTION  
40680 STATE HWY 59  
BAY MINETTE, ALABAMA 36507  
(251) 337-4313 (251) 337-1782 FAX  
stewart@stewartengineering.net

No.	Date	Description

No.	Date	Description


14TH STREET INDUSTRIAL FACILITY  
345 14TH STREET  
PANAMA CITY, FLORIDA

PLUMBING PLAN

Sheet Number:  
P1.2

Project No.:  
Drawn By: Wade Stewart  
Checked: Wade Stewart  
Date: February, 2020

COPYRIGHT 2020 STEWART ENGINEERING. THIS DOCUMENT IS FURNISHED FOR A SINGLE USE AND REMAINS THE PROPERTY OF THE ENGINEER.

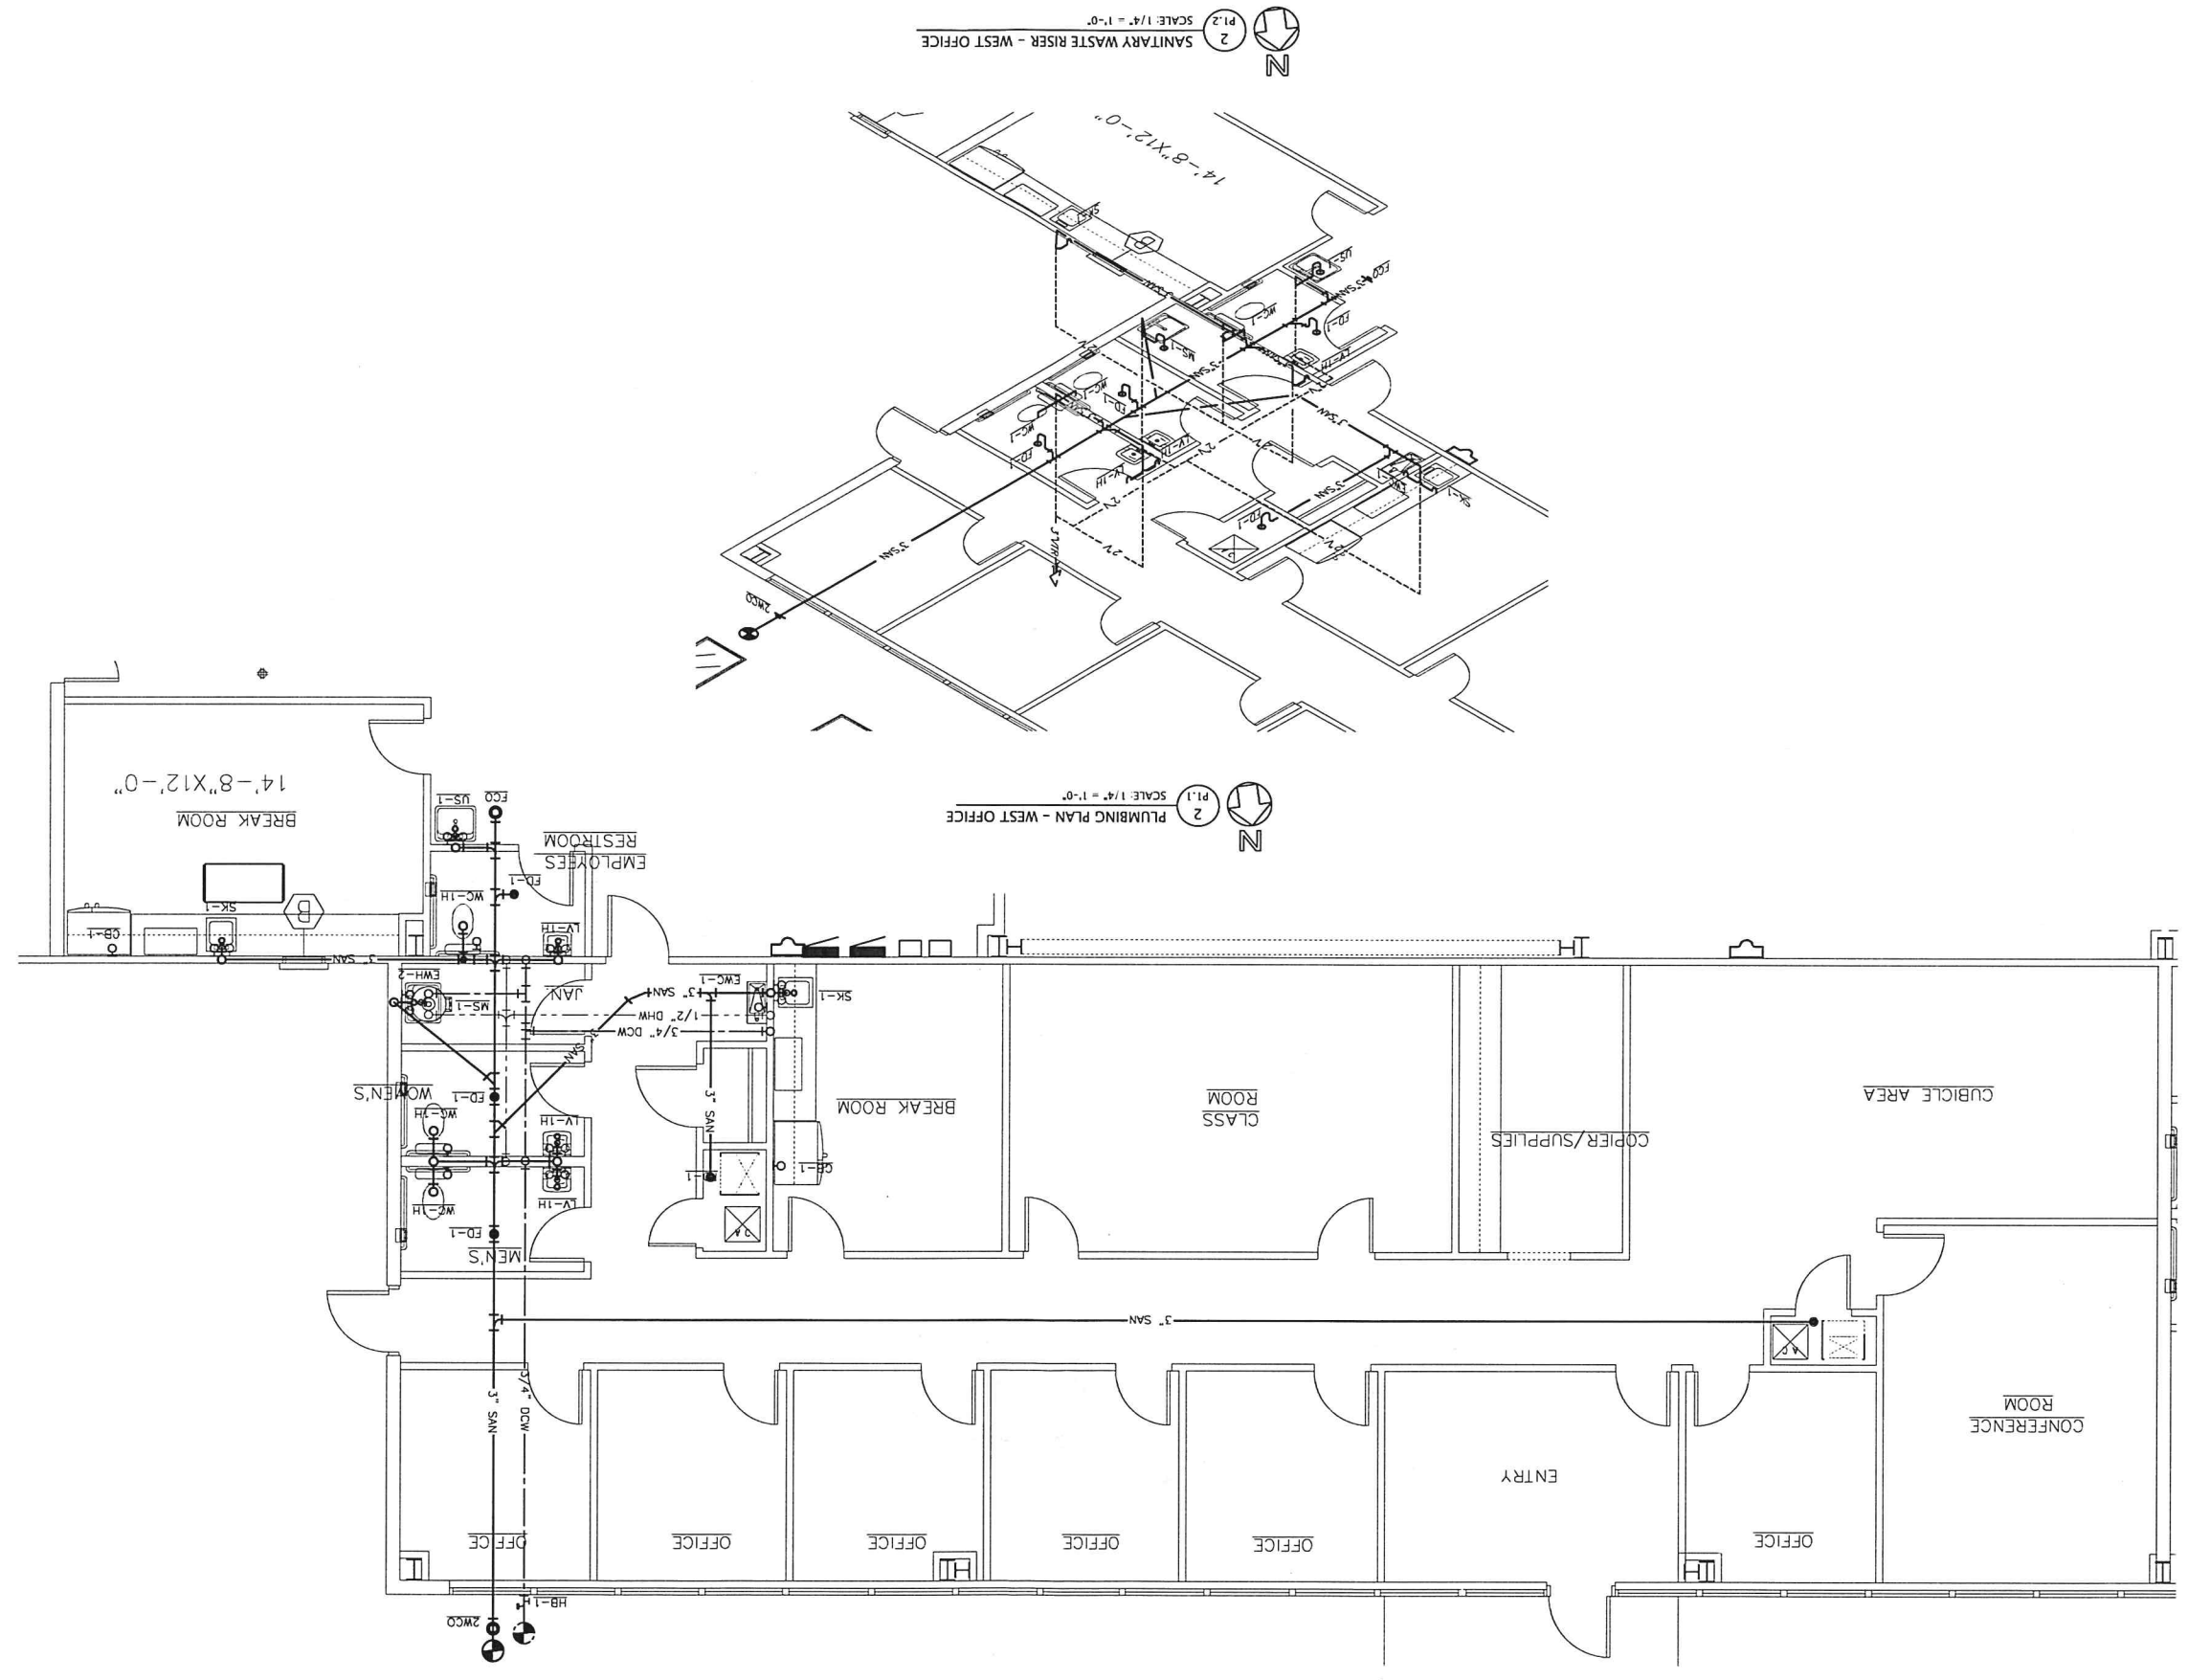

2  
P1.2  
SCALE: 1/4" = 1'-0"  
SANITARY WASTE RISER - WEST OFFICE

2  
P1.1  
SCALE: 1/4" = 1'-0"  
PLUMBING PLAN - WEST OFFICE