



LIGHT FIXTURE SCHEDULE				
SYMBOLS	MANUFACTURER BY	CATALOG NO	LAMPS	REMARKS
A	LIGHTOLIER	11600	4-40W	RECESSED FLOURESCENT
B	LIGHTOLIER	80615	4-40W	SURFACE MTD. FLOURESCENT
C	HALO	H-2920ICT	1-25W	STEP LIGHTS
D	LIGHTOLIER	11500	2-40W	RECESSED FLOURESCENT
E	LIGHTOLIER	10124	1-40W	WALL MTD. FLOURESCENT
F	LIGHTOLIER	3401	12-40W	CHANDLIER
G	LIGHTOLIER	6724	1-100W	WALL MTD. UP-DOWN LIGHTS
H	LIGHTOLIER	40995	2-13W	WALL MTD. UP-DOWN LIGHTS
I	HALO	H7600T-1600G	1-100W	DOWN LIGHTS
J	NUTONE/STERLING	6710-01	25T6 1/2 IF	EXIT LIGHT - SINGLE FACE
K	NUTONE/STERLING	6722-01	25T6 1/2 IF	EXIT LIGHT - DOUBLE FACE
L	LIGHT CRAFT	914-71-76	4-60W	24" INCANDESCENT
M	LIGHT CRAFT	944-71-76	4-60W	24" INCANDESCENT
N	KENALL	5780	M-57	175W METAL HALIDE WALL MTD.
O			1-100W	INCANDESCENT FIXTURE
P				

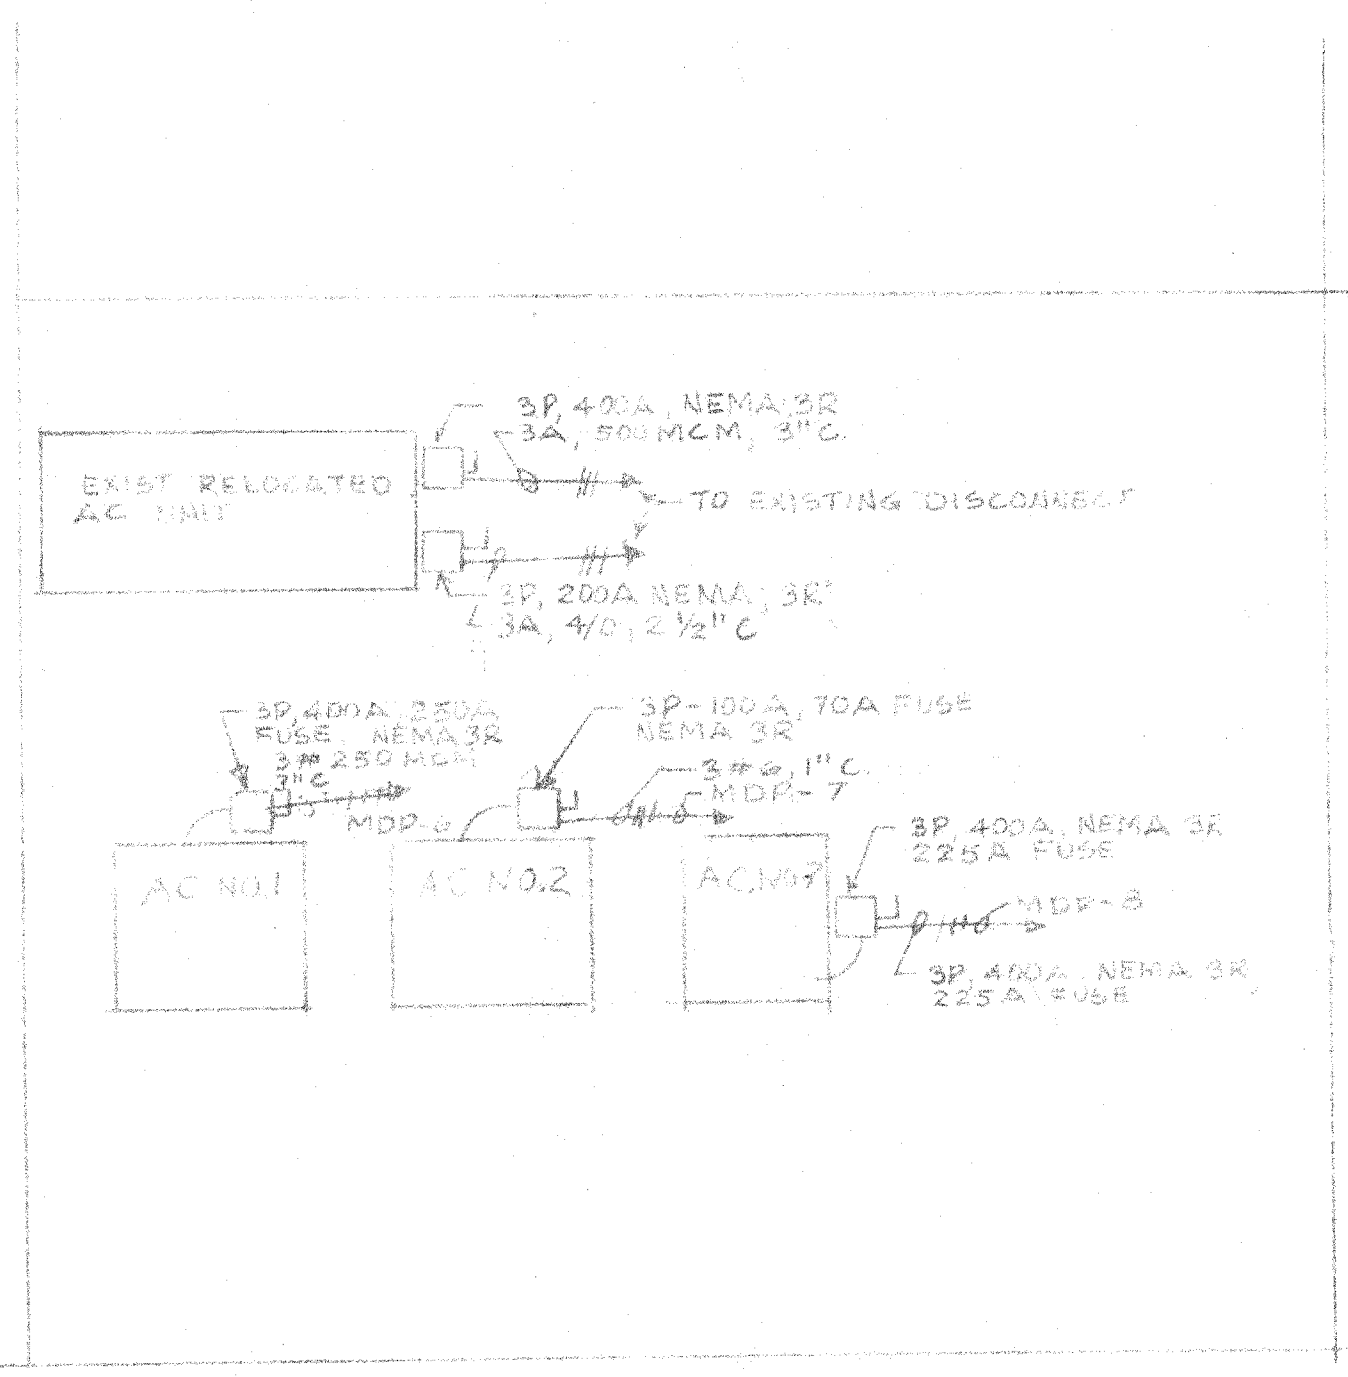

PARTIAL ROOF PLAN  
SCALE 1/4" = 1'-0"

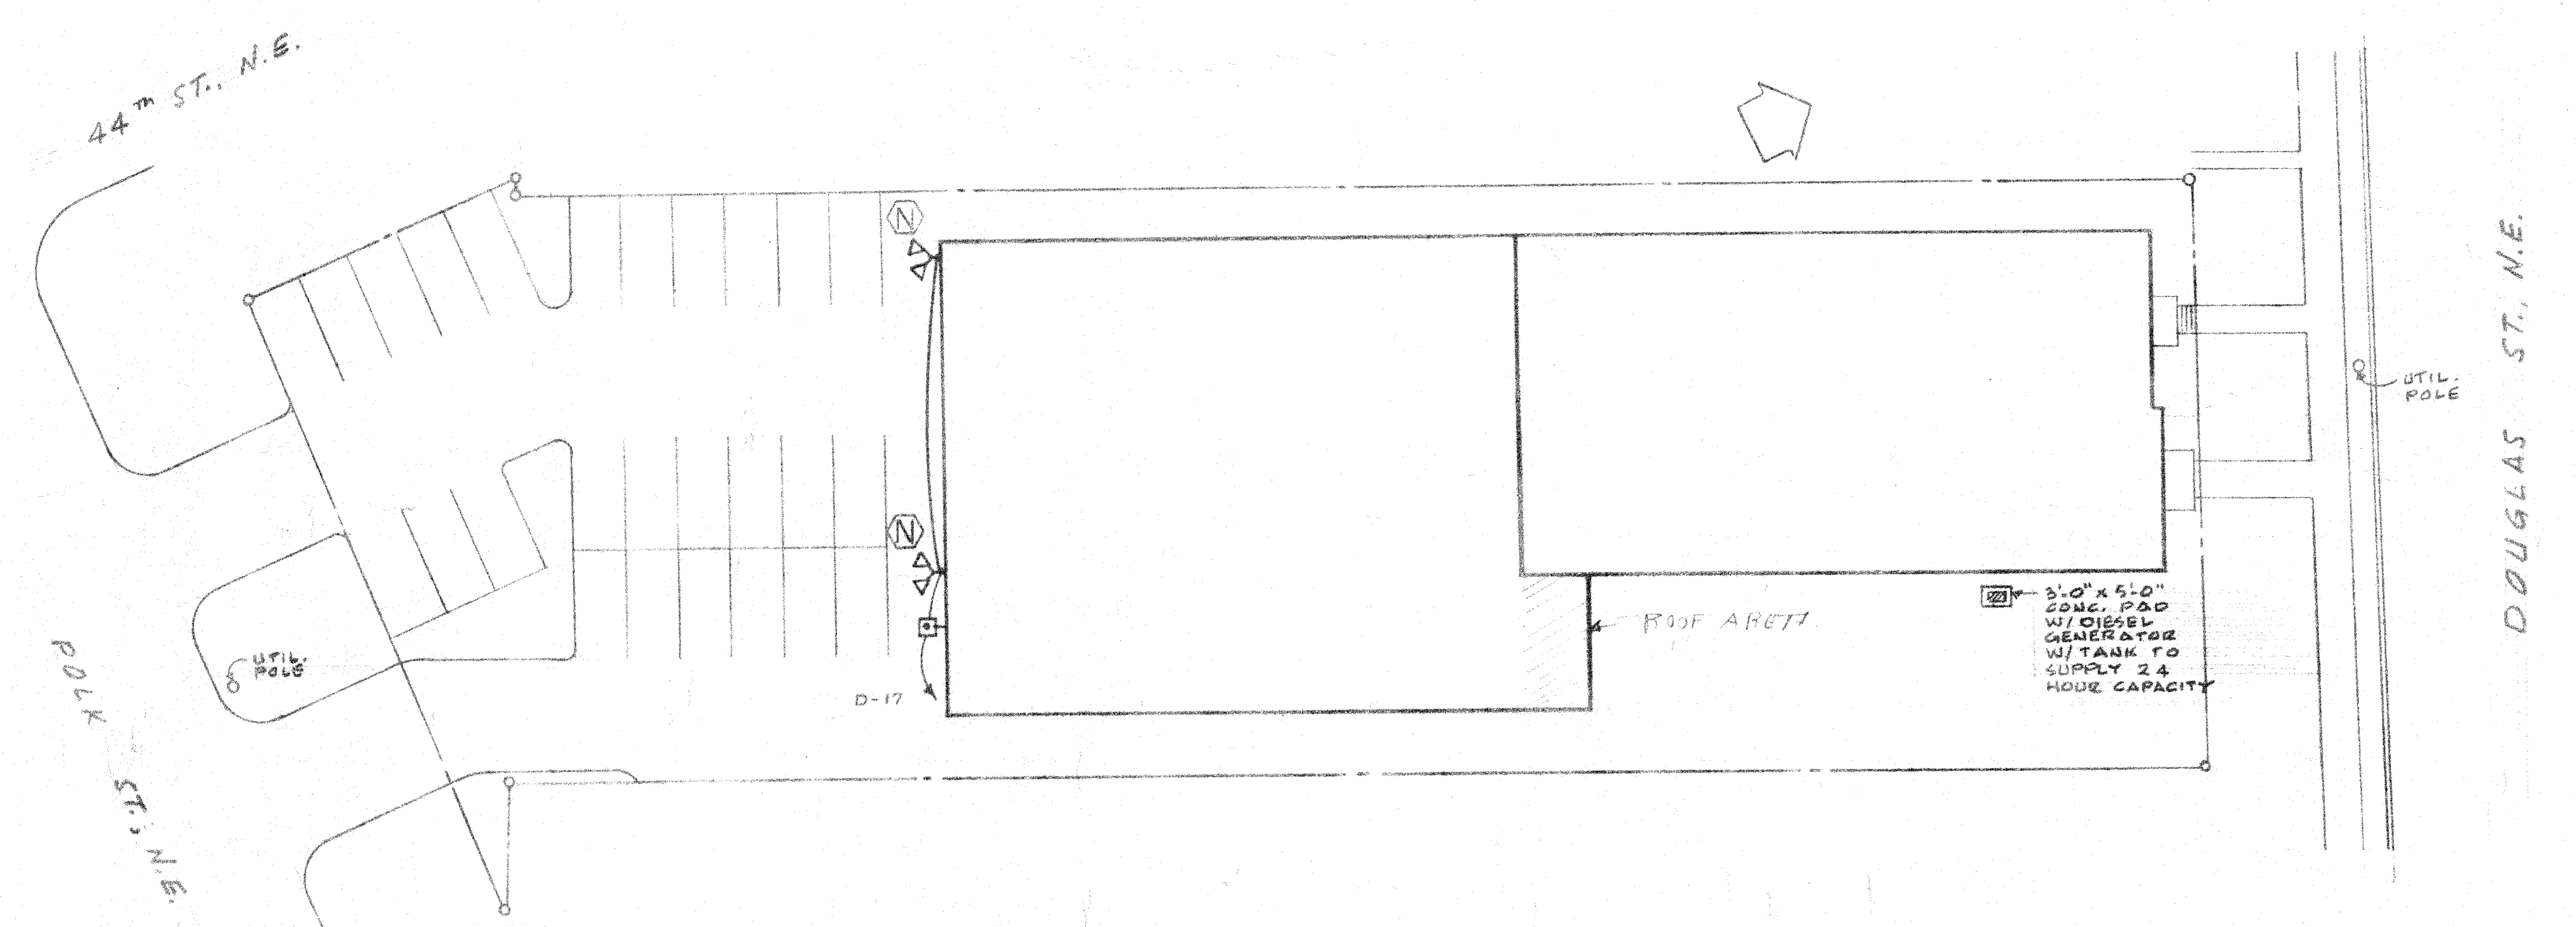

ELECTRICAL SITE PLAN  
SCALE 1/8" = 1'-0"

PROPOSED JERICO CHURCH 4418 DOUGLAS ST., N.E. WASHINGTON, D.C. LOT 38			
SCALE: AS NOTED	APPROVED BY: [Signature]	DRAWN BY: W.G.R.	
DATE:		REVISED:	
QEWORRELL ASSOCIATES		DRAWING NUMBER: E-7	