


3175 HILLSIDE DRIVE

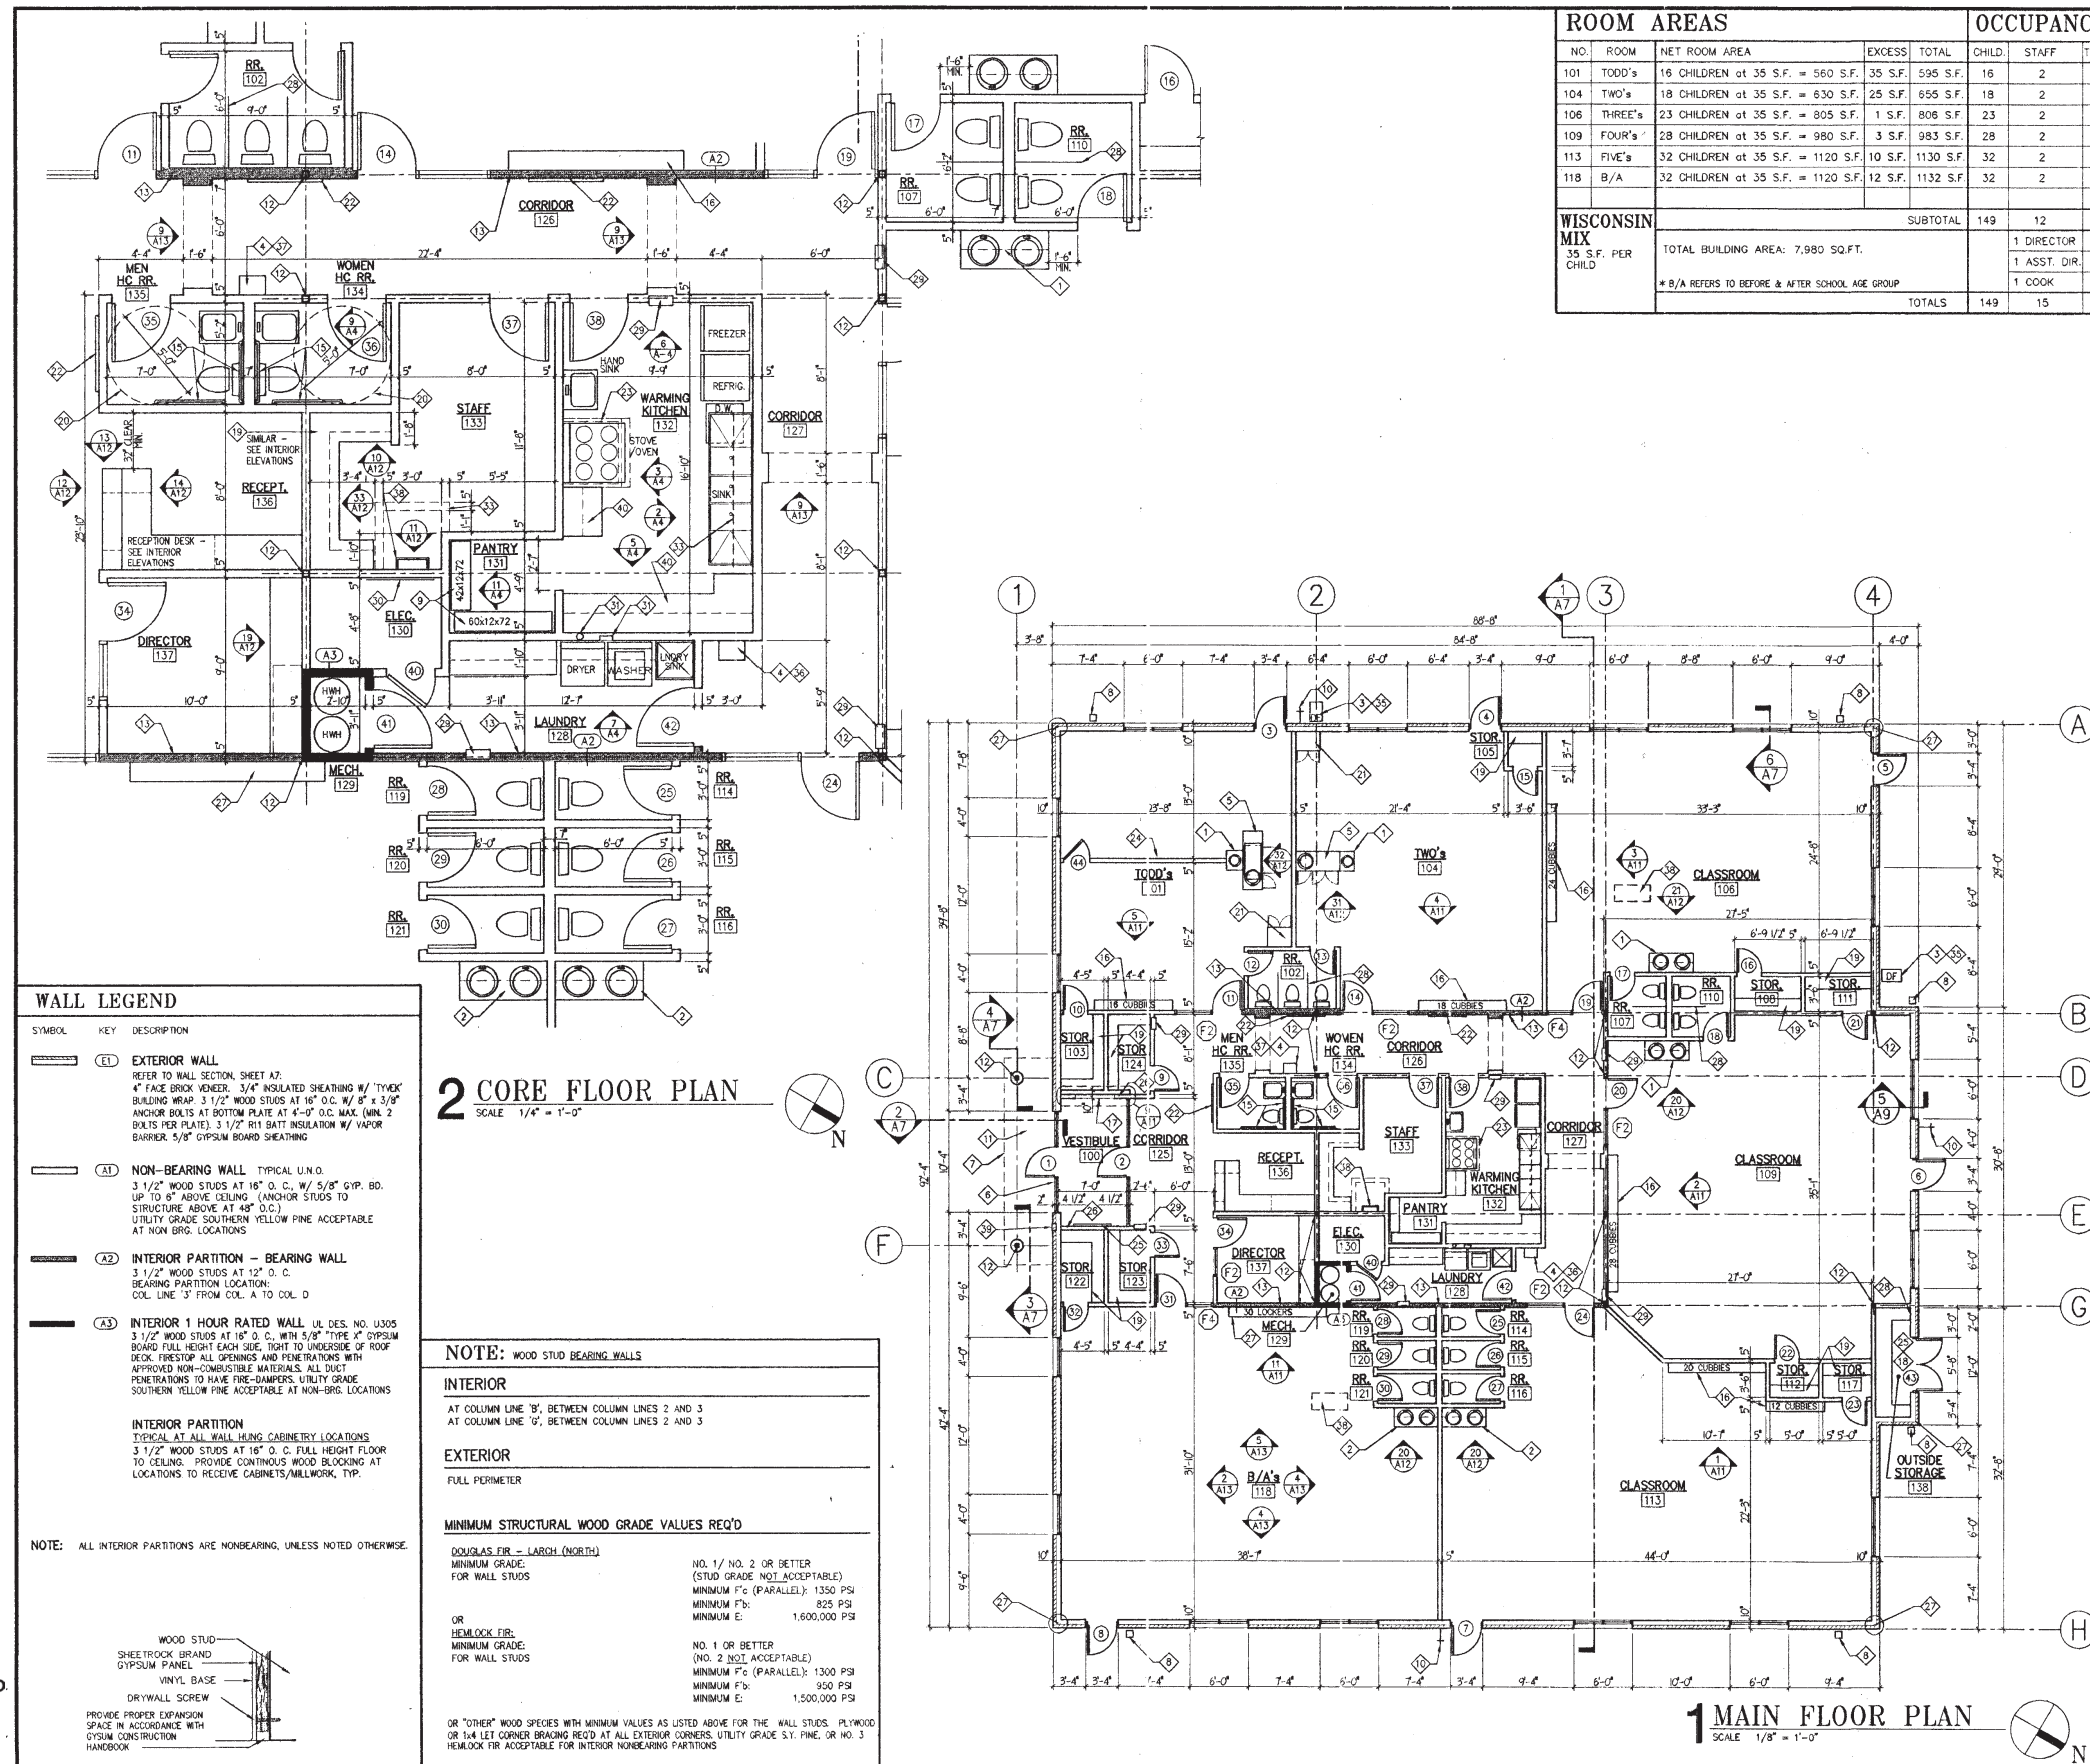

ROOM AREAS					OCCUPANCY		
NO.	ROOM	NET ROOM AREA	EXCESS	TOTAL	CHILD	STAFF	TOTAL
101	TODD's	16 CHILDREN at 35 S.F. = 560 S.F.	35 S.F.	595 S.F.	16	2	18
104	TWO's	18 CHILDREN at 35 S.F. = 630 S.F.	25 S.F.	655 S.F.	18	2	20
106	THREE's	23 CHILDREN at 35 S.F. = 805 S.F.	1 S.F.	806 S.F.	23	2	25
109	FOUR's	28 CHILDREN at 35 S.F. = 980 S.F.	3 S.F.	983 S.F.	28	2	30
113	FIVE's	32 CHILDREN at 35 S.F. = 1120 S.F.	10 S.F.	1130 S.F.	32	2	34
118	B/A	32 CHILDREN at 35 S.F. = 1120 S.F.	12 S.F.	1132 S.F.	32	2	34
SUBTOTAL					149	12	161
WISCONSIN MIX 35 S.F. PER CHILD					TOTAL BUILDING AREA: 7,980 SQ.FT.		
					1 DIRECTOR = 1		
					1 ASST. DIR. = 1		
* B/A REFERS TO BEFORE & AFTER SCHOOL AGE GROUP					1 COOK = 1		
TOTALS					149	15	164

- 1 PLASTIC LAMINATE BASE & WALL CABINET, 21" HIGH -
SEE SPECS FOR LAVATORY SELECTION - SEE DETAIL 21/A12
 - 2 PLASTIC LAMINATE BASE & WALL CABINET, 30" HIGH -
SEE SPECIFICATIONS FOR LAVATORY SELECTION - SEE DETAIL 21/A12
 - 3 EXTERIOR DRINKING FOUNTAIN - SEE SPECIFICATIONS
 - 4 WATER FOUNTAIN - SEE SPECIFICATIONS
 - 5 CHANGING TABLE W/ SINK AND WALL CABINET - SEE S/A12
 - 6 ANODIZED ALUMINUM STORE FRONT SYSTEM W/ INSULATED SAFETY
GLAZING AS REQUIRED BY CODE
 - 7 EDGE OF CANOPY ABOVE
 - 8 2 x 4 DOWNSPOUT, 28 GA. G.I. (OR ALUM.) CORRUGATED RECTANGULAR
 - 9 STAINLESS STEEL WIRE RACKS, 12" DEEP (SEE SHEET A4 FOR ELEV.)
 - 10 FROST PROOF HOSE BIB
 - 11 5" THICK CONCRETE INTERIOR SLAB, REINFORCED W/ #2 x 1 #2.1 WVF
BROOM FINISH AT EXTERIOR WALKS (REFER TO SITEMPLAN FOR DETAILS)
 - 12 STEEL COLUMN (TYPICAL) - REFER TO FRAMING PLAN
 - 13 3 1/2" WOOD STUD BEARING WALL FROM COL. NO. 2 THRU 3
 - 14 DECORATIVE FIBERGLASS COLUMN ENCLOSURE - SEE DETAIL 4/A7
 - 15 HANDICAPPED ACCESSIBLE GRAB BARS -
REFER TO INTERIOR ELEVATIONS FOR MOUNTING HEIGHT
 - 16 WALL MOUNTED "OVBIES" - REFER TO INTERIOR ELEVATIONS ON
SHEET A-11 FOR MOUNTING HEIGHT
 - 17 WALL MOUNTED RECESSED DISPLAY CASE - REFER TO INTERIOR
DETAIL 9/A11. FOR MOUNTING HEIGHT, INTERIOR SURFACE
TO CORN BOARD (MINIMUM CLASS B MATERIAL). CONTRACTOR TO
SUBMIT TEST DATA AND MANUF. CUT SHEET INDICATING ICBO CLASS II
MATERIAL TO BUILDING DEPARTMENT PRIOR TO INSTALLATION
 - 18 THERMAL INSULATED INTERIOR WALLS AND CEILING ABOVE
 - 19 5 HEAVY DUTY SHELVES - 15" DEEP - 3/4" THICK PARTICLE BOARD,
PAINTED. TYP. ALL STORAGE ROOMS (SEE SHEET A12 FOR MOUNTING
HEIGHTS) VERIFY HEIGHTS WITH OWNER BEFORE CONSTRUCTION.
 - 20 5'-0" DIAMETER WHEELCHAIR TURNING RADIUS
 - 21 STORAGE CABINET - SEE DWG. 16/A12
 - 22 SURFACE MOUNTED BULLETIN BOARD
 - 23 EXHAUST HOOD W/ GYP. BD. ENCLOSURE AT HOOD TO CONCEAL
DUCTWORK (VERIFY SIZE REQUIREMENTS W/ HOOD MANUF.) PROVIDE
ONE HOUR RATED DUCT SHAFT TO ROOF - SEE DETAIL 4/A10
 - 24 HALF HEIGHT PARTITION, TOP OF PARTITION AT 36" A.F.F. PROVIDE HARDWOOD
CAP
 - 25 5/8" EXTERIOR GYPSUM BOARD WITH 4" VINYL BASE, TAPE AND SAND FOR
PAINT
 - 26 FULL HEIGHT PARTITION AT ENTRY PERIMETER
 - 27 3 TIER METAL LOCKERS - SEE ELEVATION 13/A11
 - 28 48" HIGH x 42" LONG LOUVER PARTITION
 - 29 POTTER-ROEMER TYPE 2A-10-BG, MODEL 3005 FIRE EXTINGUISHER IN
SEMI-RECESSED STEEL CABINET IN ACCORDANCE WITH NFPA 10. VERIFY
LOCATION WITH LOCAL FIRE DEPARTMENT PRIOR TO INSTALL. CABINET TO BE
POTTER-ROEMER MODEL #7002-B-R (7004-B-R INST. AT KITCHEN) (OR
APPROVED EQUIV.) - TO BE PAINTED
 - 30 PROVIDE PLYWOOD BASE ON WALL IF REQUIRED BY PHONE COMPANY. VERIFY
WITH PHONE CO. (PAINT TO MATCH WALL)
 - 31 SHEET METAL DRYER VENT PIPE
 - 32 "GUT - GREY" BOX FOR WASHER SUPPLY AND WASTE
 - 33 12" WIDE SOLID STAINLESS STEEL SHELF
 - 34 HAND SINK CABINET WITH ADJUSTABLE REFRIGERATOR - SEE DETAIL 32/A12
 - 35 MOUNTING HEIGHT OF SPOUT SHALL BE 30" A.F.F.
 - 36 MOUNTING HEIGHT OF SPOUT SHALL BE 34" A.F.F.
 - 37 MOUNTING HEIGHT OF SPOUT SHALL BE 36" A.F.F.
 - 38 ATTIC ACCESS - SEE DETAIL 3/A10
 - 39 FIRE DEPARTMENT "TOMB BOX" SECURITY KEY BOX LOCKED AS PER FIRE
DEPARTMENT DIRECTOR
 - 40 PLASTIC LAMINATE BASE & WALL CABINETS - REFER TO INTERIOR
ELEVATIONS, SHEET A4

FLOOR PLAN GENERAL NOTES

1. 12" x 48" 1/2" - 3/4" piece of CARPET LAY LOOSE OVER VINYL COMPOSITION TILE FLOORING - ONE SECTION - TYPICAL OF EACH CLASSROOM. INSURE EDGES OF CARPET ARE BOUND.
2. PROVIDE RUBBER STRIPER STATION AT ALL FIXED CARPET / VCT
3. PROVIDE PLYWOOD BACKING FOR PHONE EQUIPMENT AS REQUIRED. VERIFY REQUIREMENTS WITH UTILITY COMPANY.
4. AT GYP. BD. PARTITIONS, ALL GYP. BD. SHALL BE INSTALLED IN ACCORDANCE WITH THE "GYPSUM HANDBOOK" TO ALLOW FOR PROPER EXPANSION/ CONTRACTION OF BLDG. COMPONENTS.
5. PROVIDE FLOOR DRAINS IN ALL TOILET ROOM AND PUBLIC RESTROOMS - REF. TO PLUMBING PLAN, SHEET M1, FOR EXACT LOCATIONS

3 DISPLAY CASE DETAIL



NEW DAY CARE FACILITY FOR:
CHILDREN'S WORLD LEARNING CENTERS
HILLSIDE MARKET CENTER
DELAFIELD, WISCONSIN

BASIL ASSOCIATES, INC.
architects planners
PHONE (847) 441 - 9600 FAX: (847) 441 - 9631
495 CENTRAL AVE. NORTHELD, IL 60063 © 2000
WWW.BASILCOMPANIES.COM EMAIL: BA@BASILCOMPANIES.COM

DO NOT SCALE
DRAWINGS

REV	DATE
-----	------

TABLE 1

--	--

--	--

--	--

--	--

--	--

--	--

--	--

FOR BIDDING
9-29-00

7-27-00	FOR PERMIT
---------	------------

9-29-00

DRAWN:

108 NO

0025

0023

SHEET

A O

A3

AS

5-6

5 01