


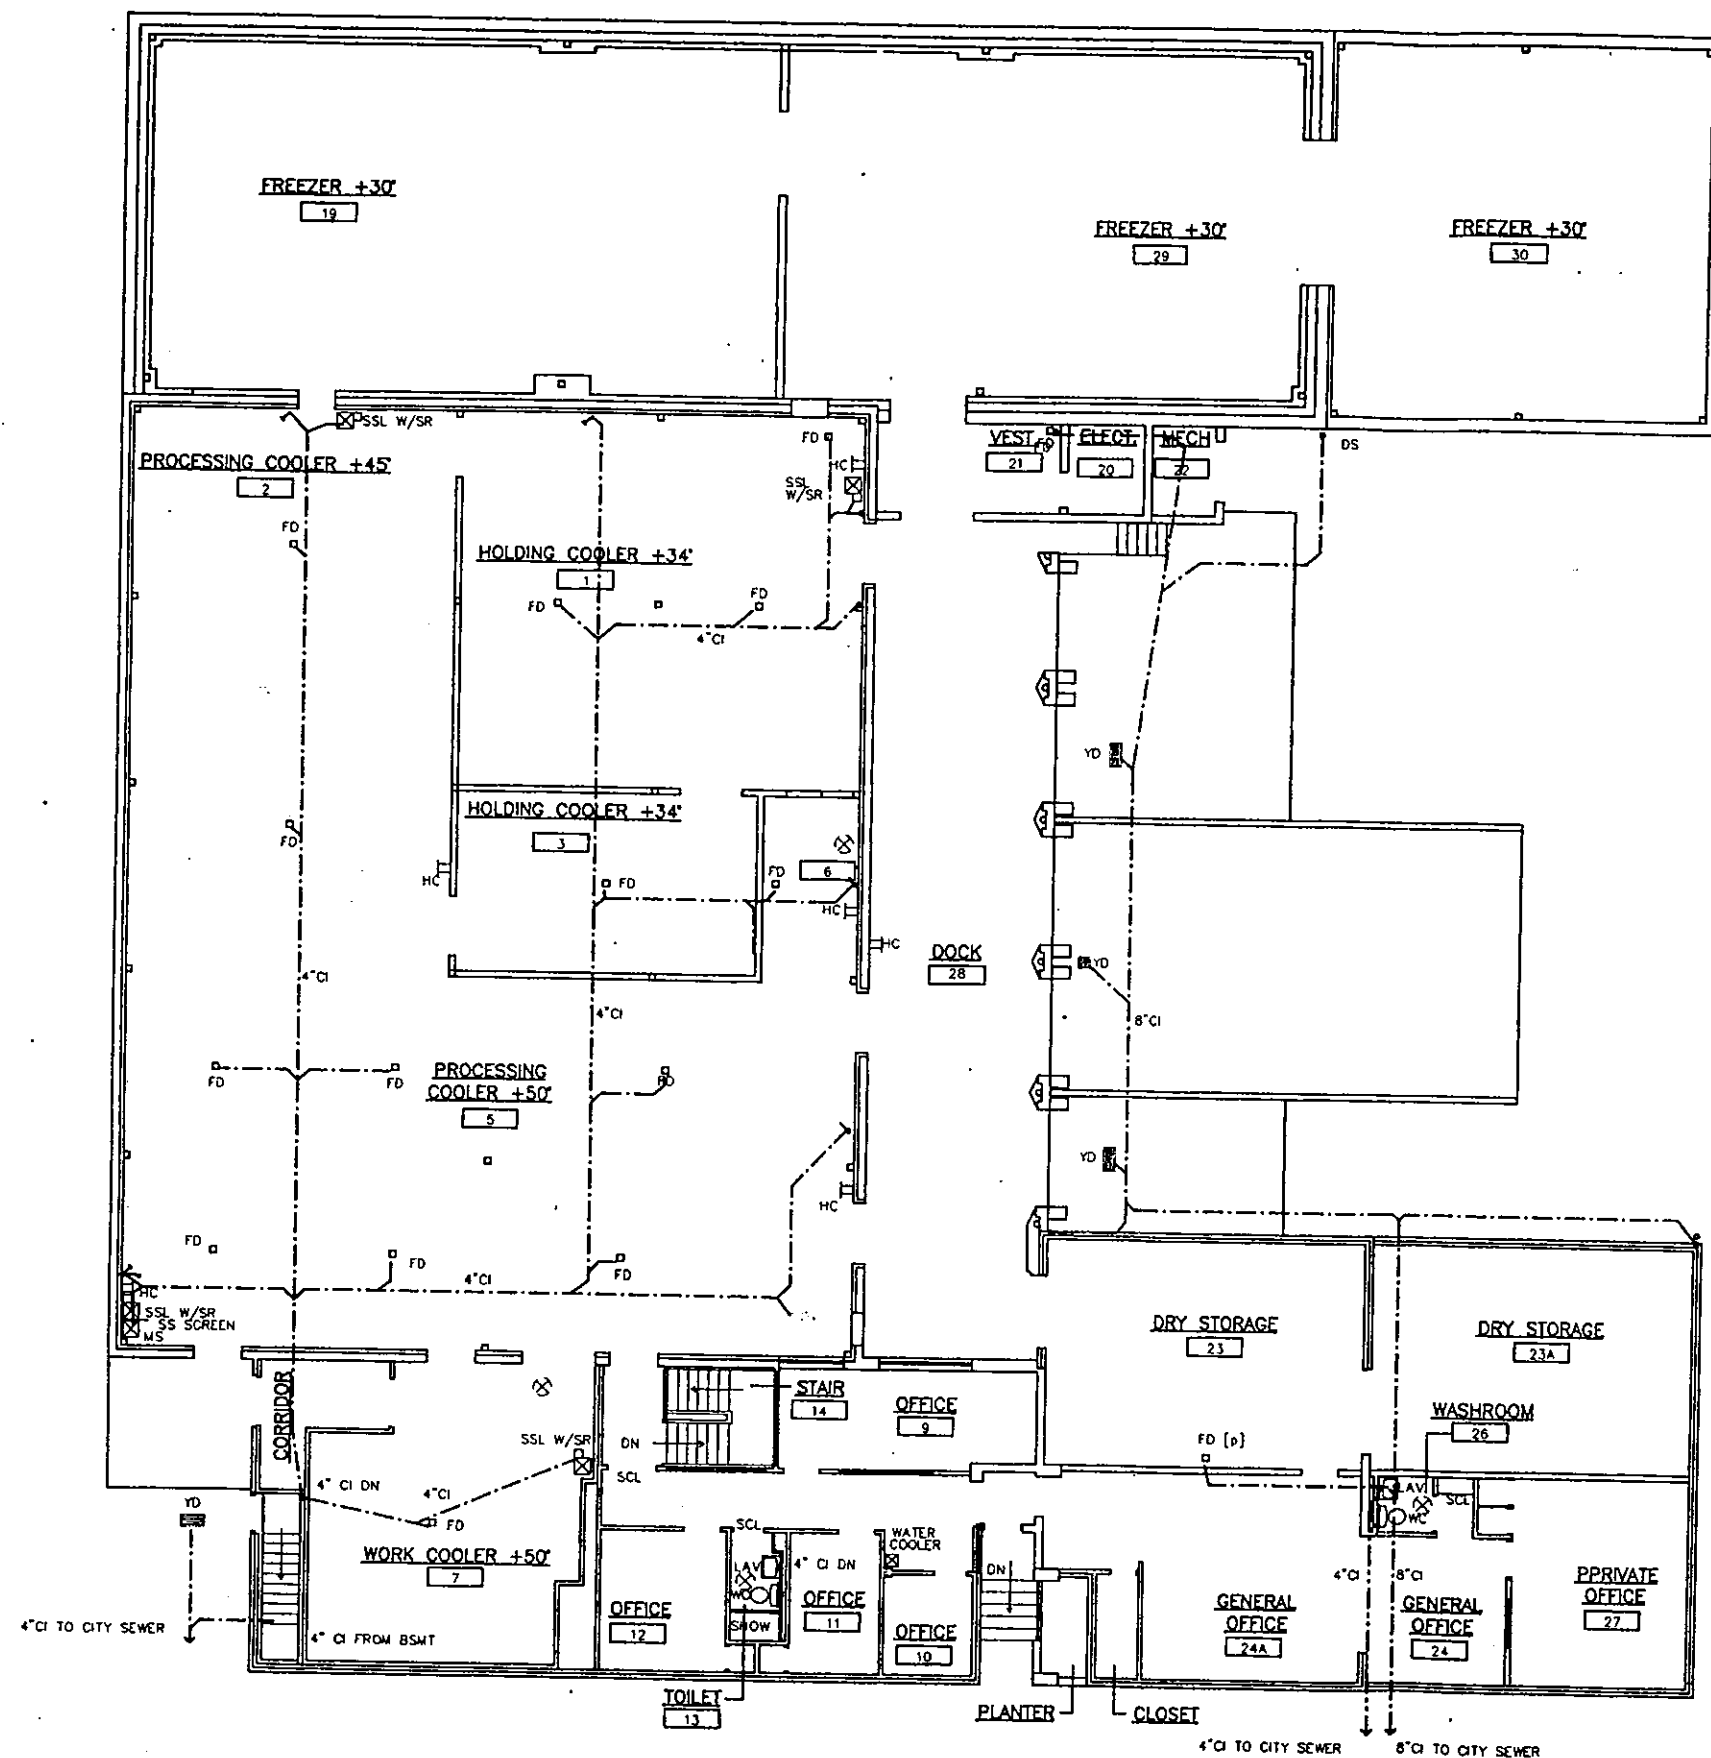

LEGEND		
PLANT WASTE		---
SANITARY SEWER		---
STORM SEWER		---
		S
FD	FLOOR DRAIN, [PL] PLUGGED	⊗
MS	MEAT SINK	⊗
SSL	STAINLESS STEEL FOOT PEDAL	⊗
	OPERATED SINK, [DF] DRINKING	⊗
	FOUNTAIN, [S] STERILIZER	⊗
	REFRIGERATION UNIT	▨
	ROOF EXHAUST FAN	⊗
	FLUE	⊗
	WALL EXHAUST FAN	⊗

CAD #9403-P1M

VERIFY ALL CONDITIONS AND DIMENSIONS



ISSUED: 05-01-94

JOB #9403

ESTABLISHMENT: 2510
FRED OPPENHEIMER CO.
2150 WEST CAROL AVE.
CHICAGO, IL 60612

P1M

ALAN R. SCHNEIDER, ARCHITECT P.C.
1110 TRINITY AVENUE

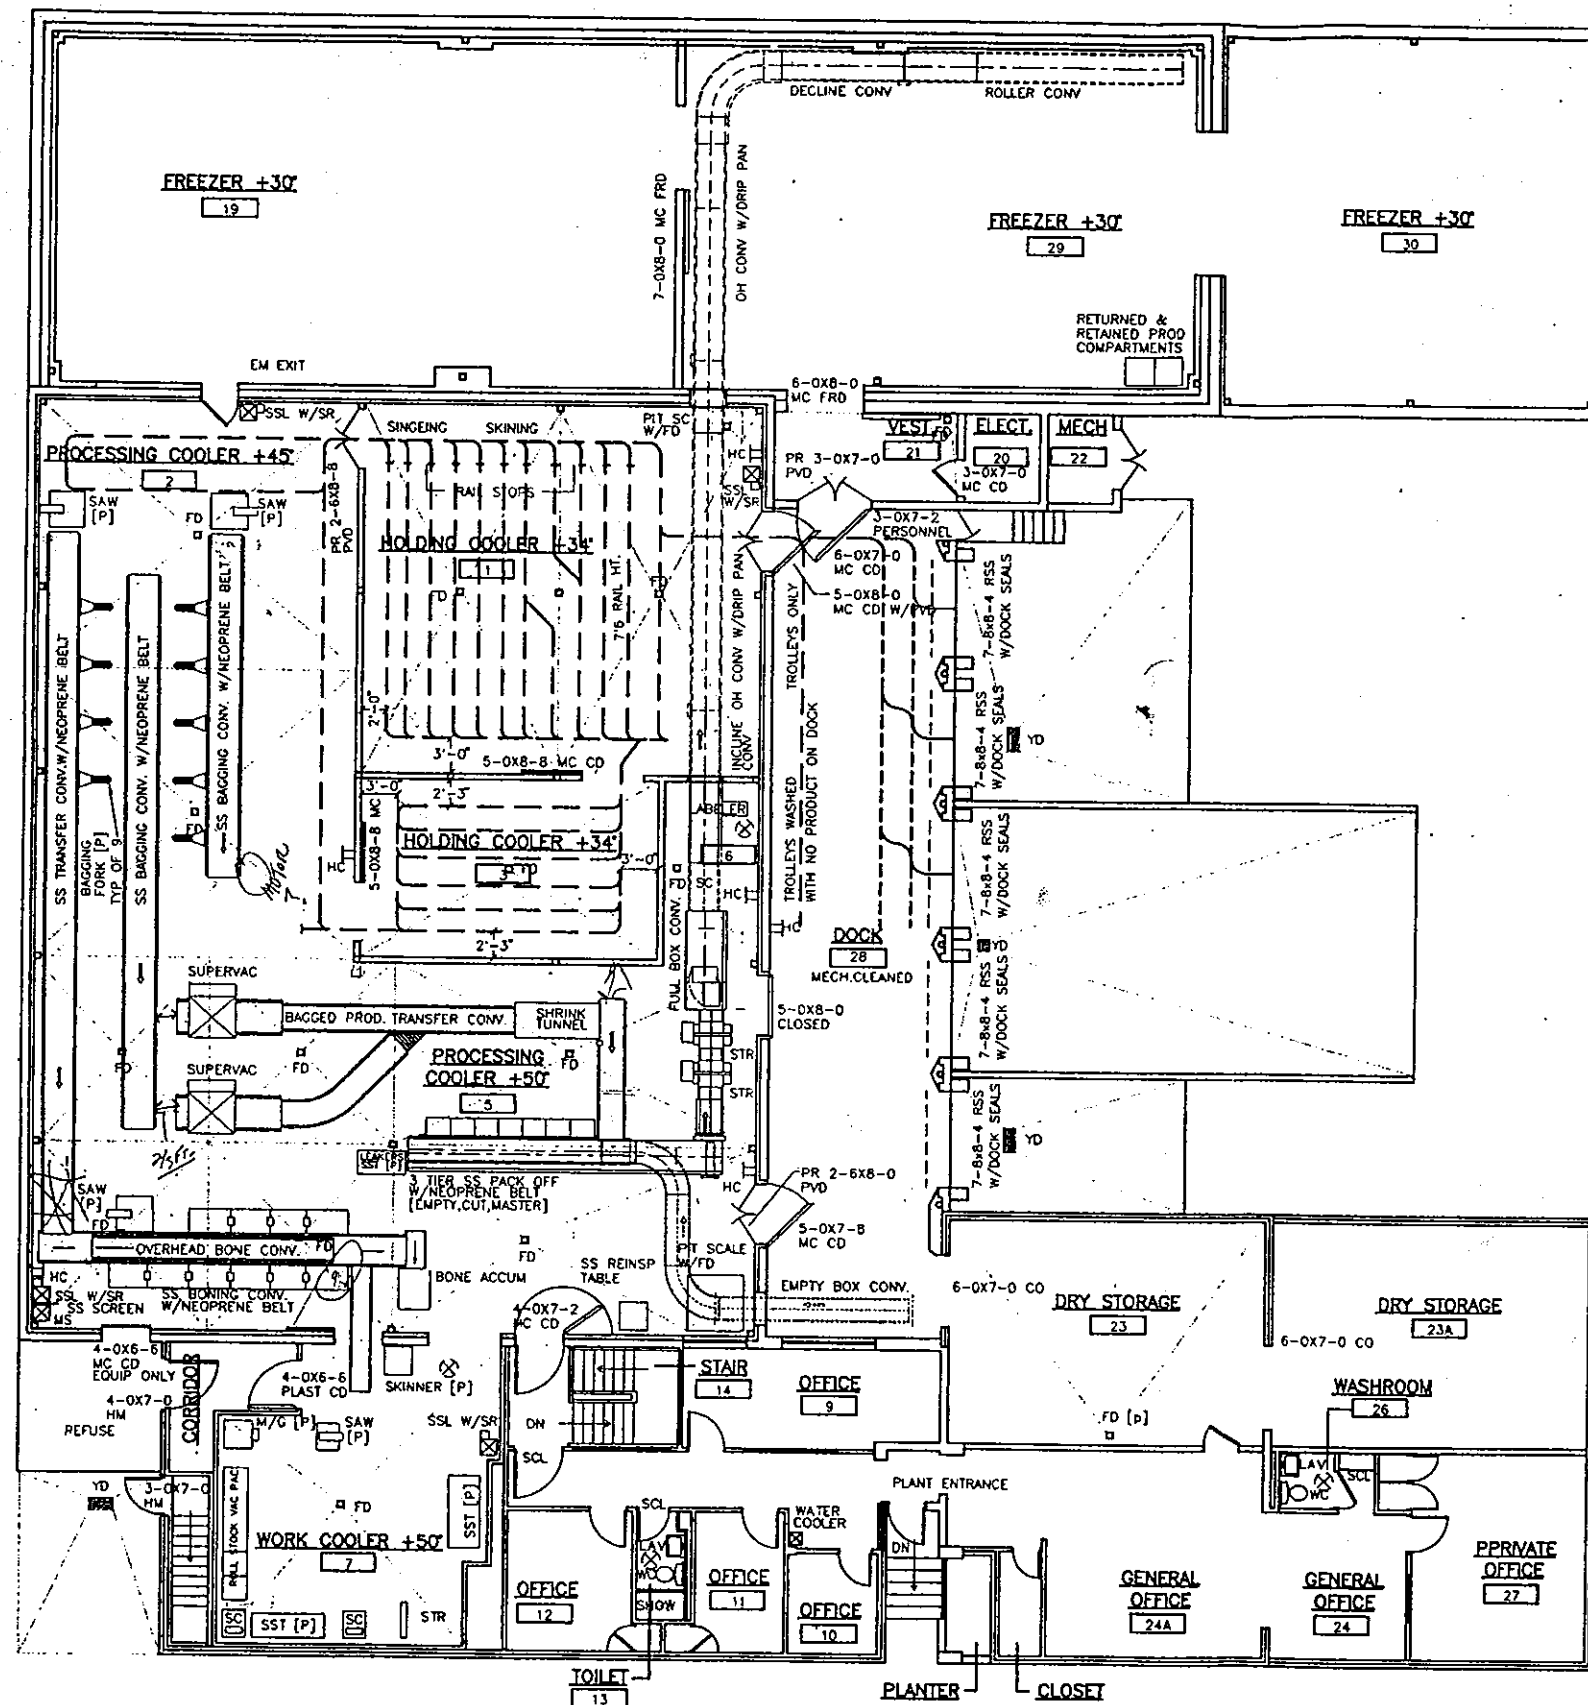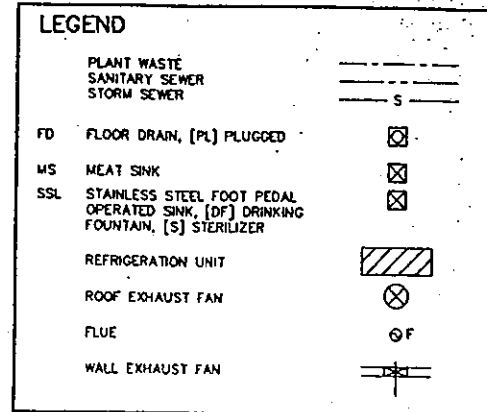

FIRST FLOOR PLAN
SCALE (1/8" = 1'-0")