


	RETURN AIR		RECESSED FIXTURE		EMERGENCY LIGHTING
	DIFFUSER		NIGHT LIGHT		EXIT SIGN
	THERMOSTAT		RECESSED 2'X4' LIGHT FIXTURE		FIRE ALARM
	BACKDRAFT DAMPER		WALL SCONCE		SMOKE DETECTOR
	VOLUME DAMPER		TRACK LIGHTING		AUDIO SPEAKER/ VISUAL STROBE DEVICE
	ELECTRICAL PANEL		JUNCTION BOX		SPRINKLER HEAD
	OUTDOOR SPEAKER		DUPLEX ELECTRICAL OUTLET		
	SPEAKER		QUADRUPLUX ELECTRICAL OUTLET		
	DATA OUTLET		MOTOR		
	TELEPHONE OUTLET				

RTU SCHEDULE				
NO.	ROOM NAME	AREA (SQFT)	TONS	RTU
101		1961	4.9	13
102		1861	4.7	12
103		1861	4.7	11
104		1861	4.7	9
105		1861	4.7	6
106		1861	4.7	4
107		1928	4.8	5
108		1638	4.1	1, 2
109	CORRIDOR	1087	2.7	7
110		1037	2.6	3, 0
111		4474	11.2	8, 14, 15
112		395	1.0	16
113	JANITOR	130	0.3	16
114	PHONE/DATA	118	0.3	16
115	RECEIVING AREA	472	1.2	16

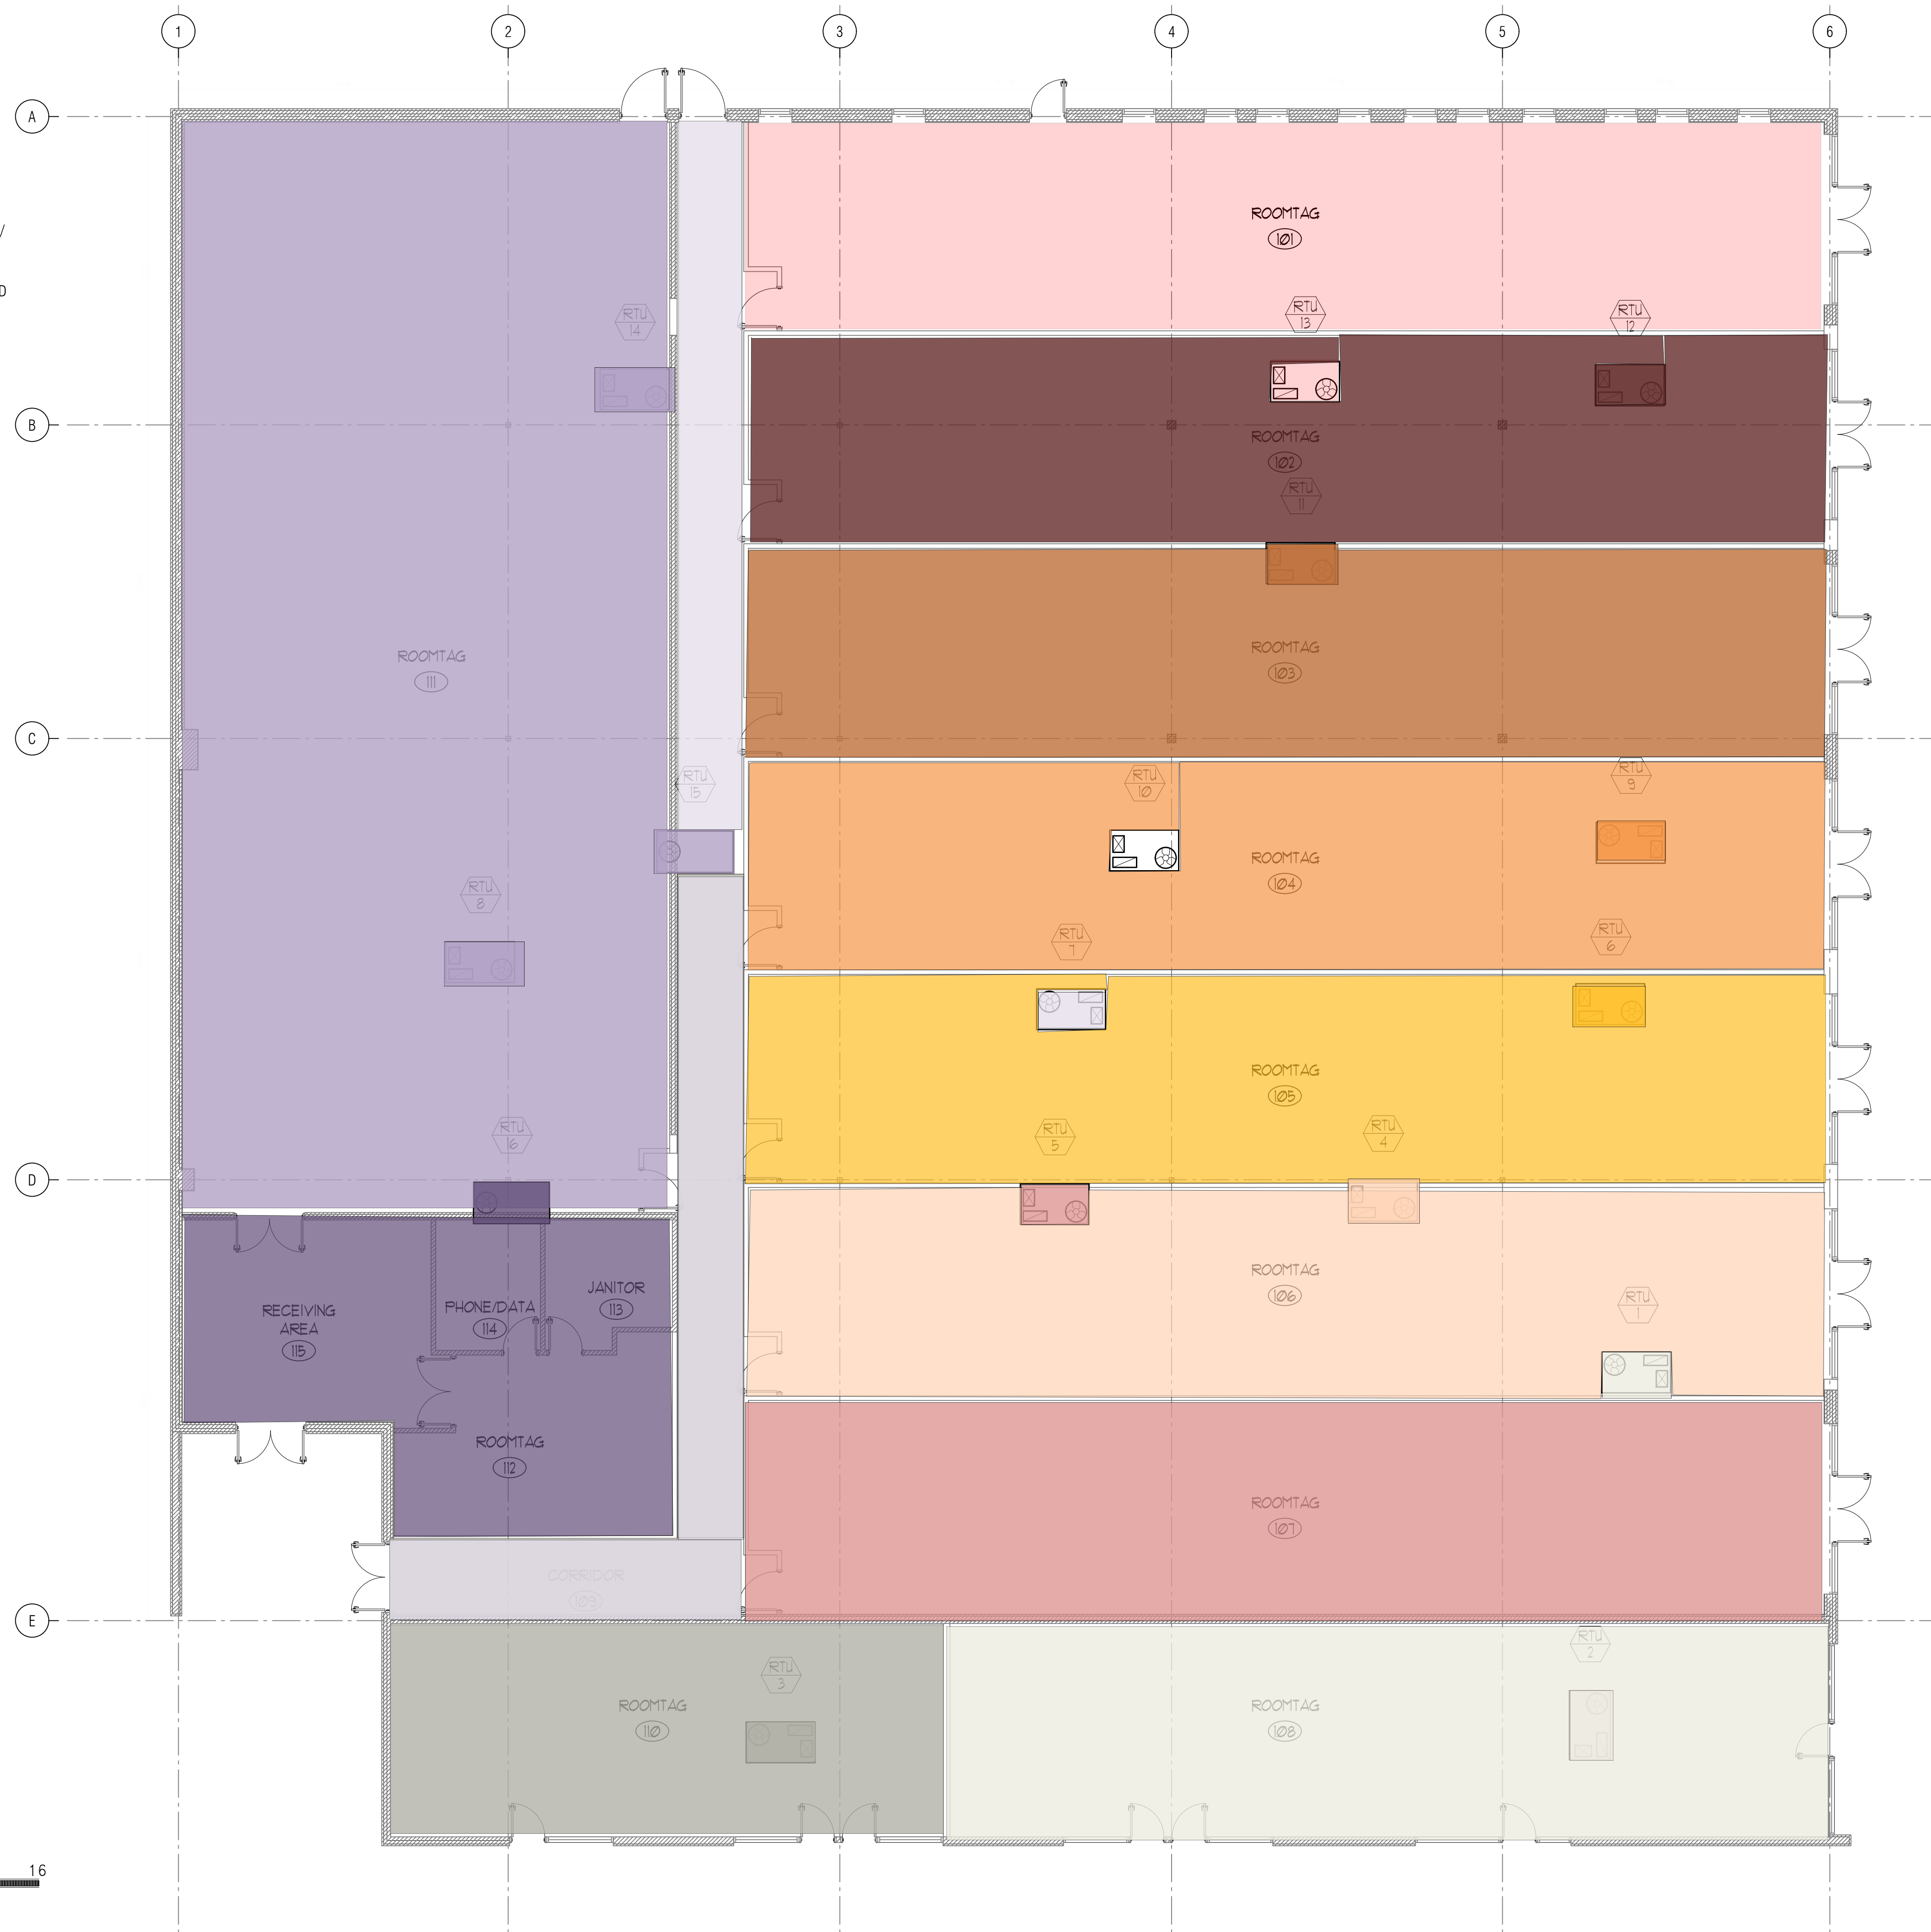

THESE DRAWINGS ARE PREPARED FOR THIS PROJECT AND ARE SPECIFIC TO THIS LOCATION ONLY. RE-USE OF THESE DRAWINGS IS STRICTLY PROHIBITED.

THIS DRAWING IS NOT A STAND-ALONE ITEM BUT PART OF A SET OF CONSTRUCTION DOCUMENTS. OTHER ITEMS NECESSARY FOR THE PROPER EXECUTION AND COMPLETION OF THE WORK BY THE CONTRACTOR MAY BE SHOWN ON OTHER SHEETS OR IN WRITTEN SPECIFICATIONS. HENCE, IF AN ITEM IS SHOWN ON ONE DRAWING IT SHALL BE AS BINDING AS IF IT WAS SHOWN ON ALL DRAWINGS REGARDLESS OF WHETHER IT BE A STRUCTURAL, MECHANICAL, ELECTRICAL, OR PLUMBING DRAWING.

PERFORMANCE BY THE CONTRACTOR SHALL BE REQUIRED ONLY TO THE EXTENT CONSISTENT WITH THE DRAWINGS AND SPECIFICATIONS AND REASONABLY INFERRABLE FROM THEM AS BEING NECESSARY TO PRODUCE THE INDICATED RESULTS.

[illegible]

SHEET NAME:

MECHANICAL PLAN

SHEET NUMBER:

M101