


5/10/2017 9:20:11 AM C:\Users\jholloway\AGNEW\ASSOCIATES\Documents\2217028.3 BEE CAVES Podiatry\_Jholloway.rvt

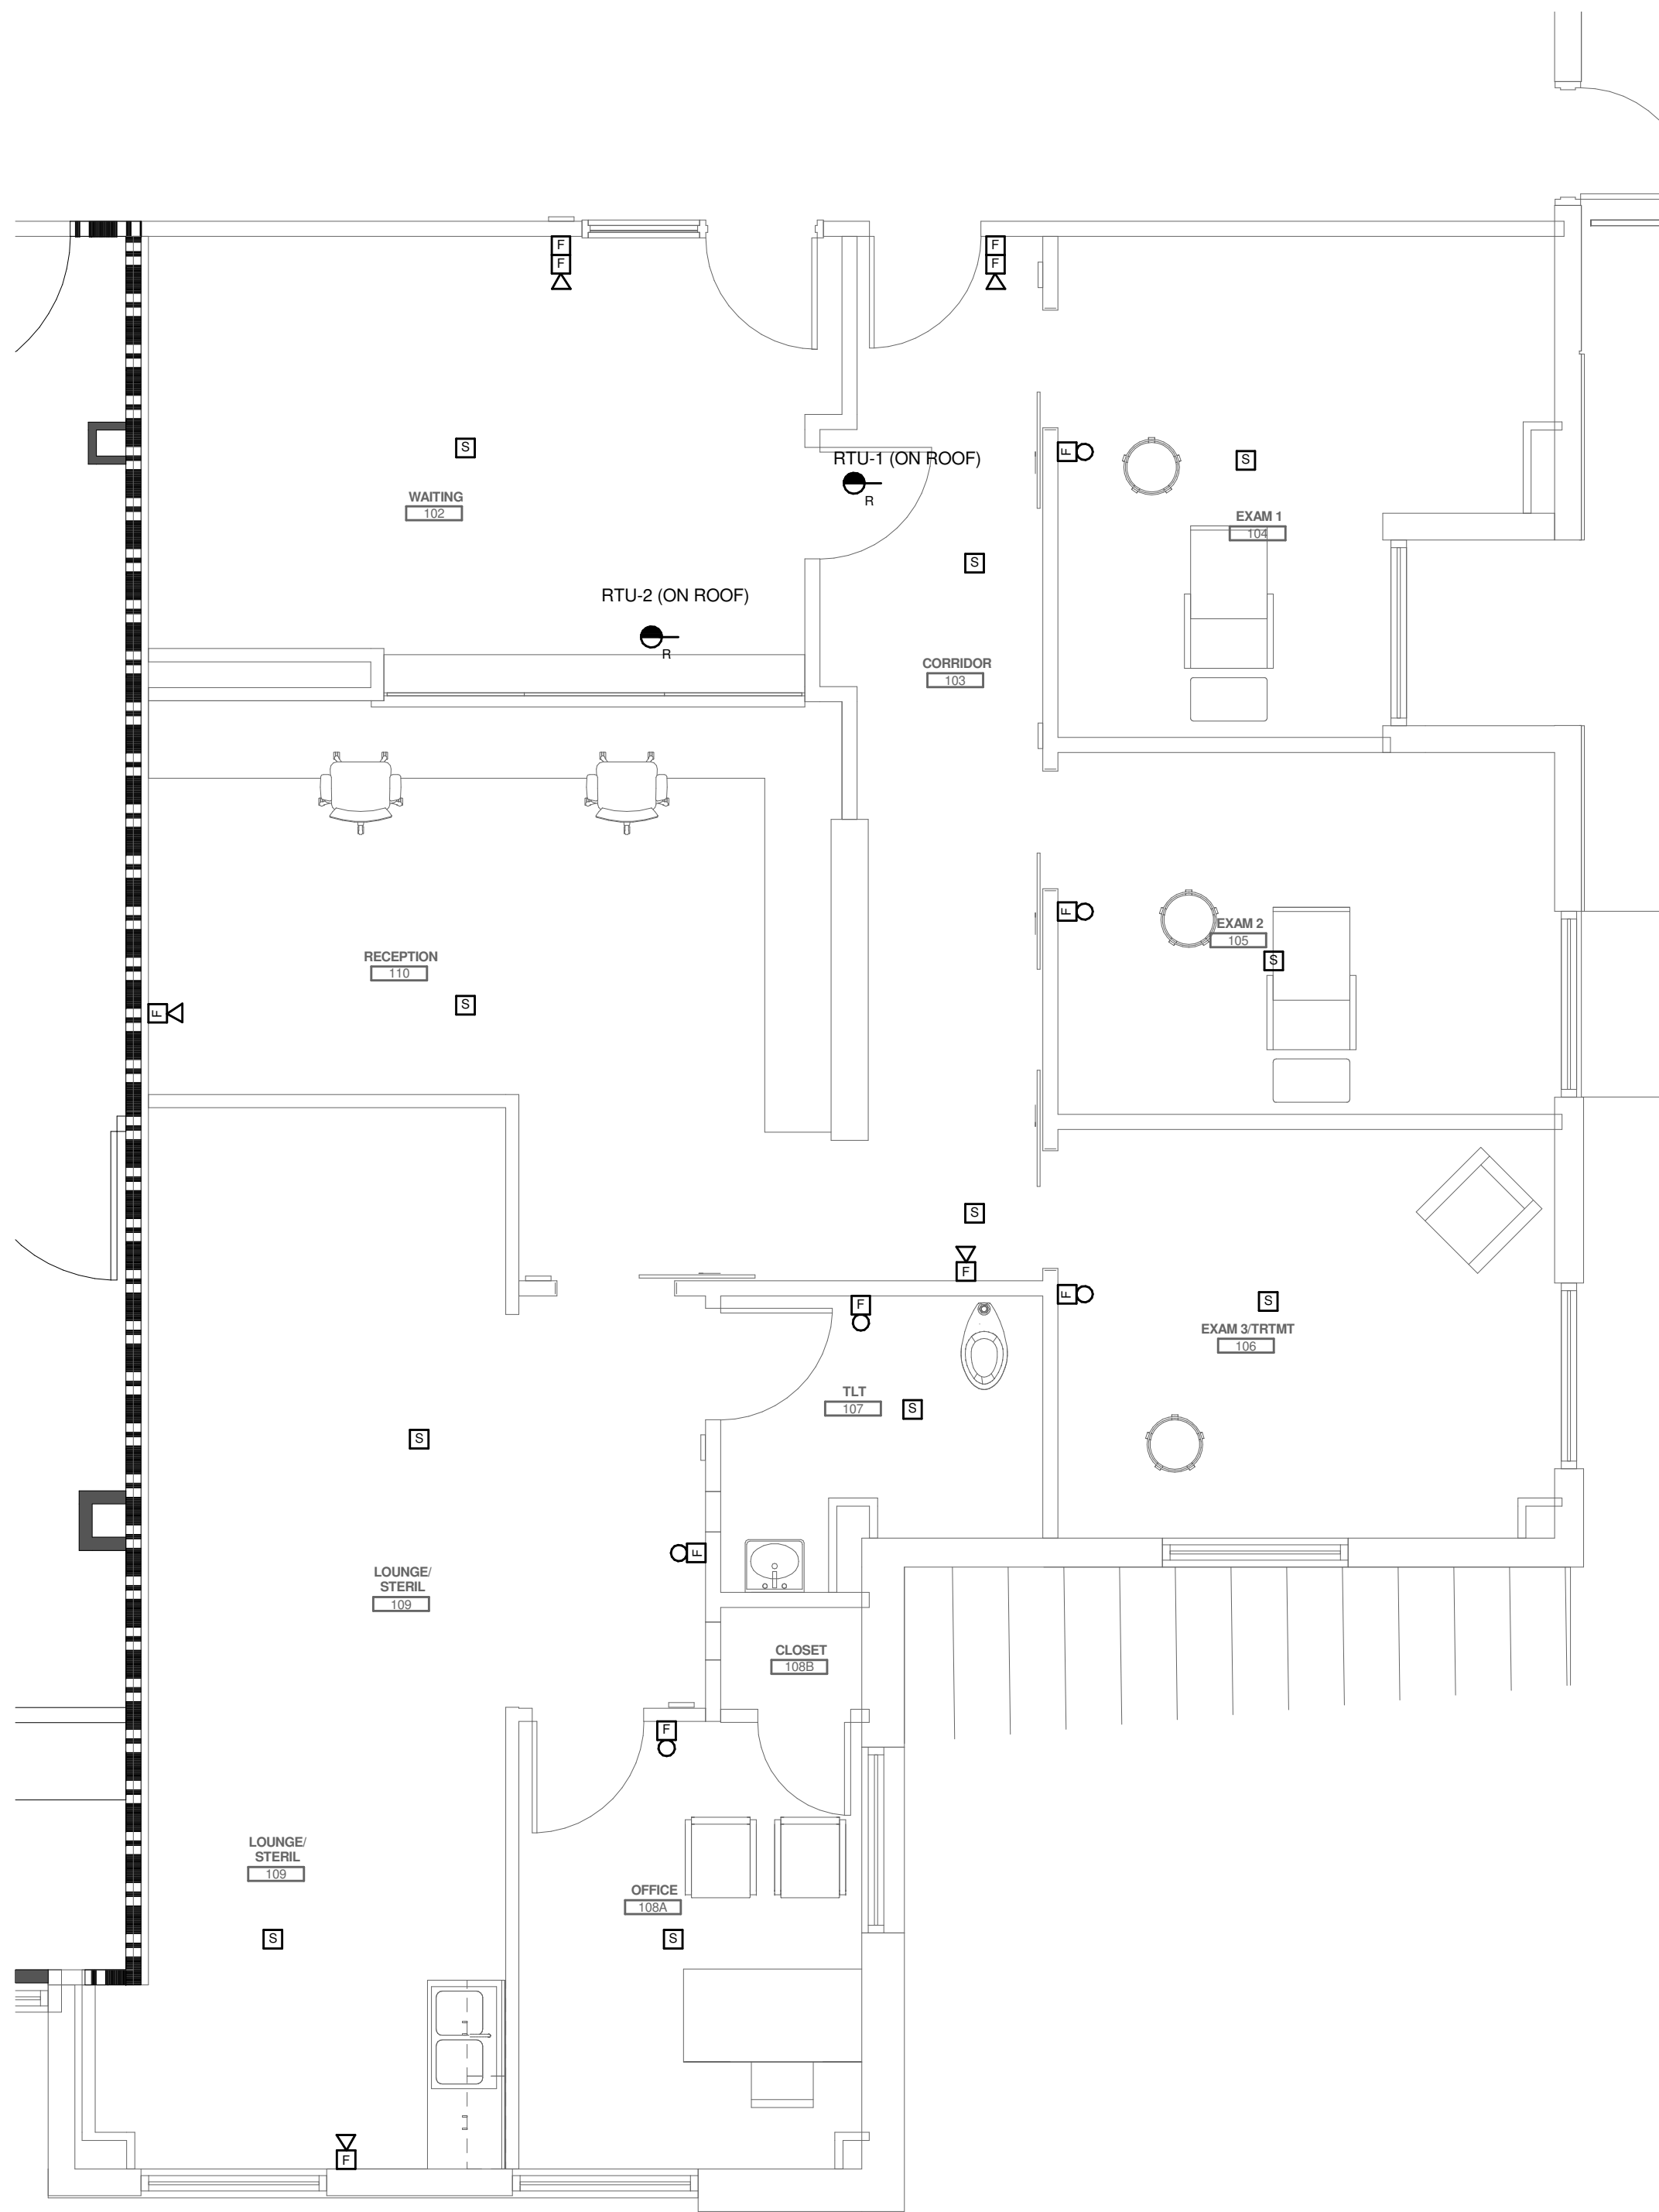

FLOOR PLAN - FIRE ALARM - POD  
SCALE: 1/4" = 1'-0"



GENERAL NOTES

- A PROVIDE A COMPLETE AND OPERATIONAL FIRE ALARM SYSTEM AS INDICATED ON THE DRAWINGS AND AS DETAILED IN THE SPECIFICATIONS.
- B PROVIDE 3/4" CONDUIT FROM EACH FIRE ALARM DEVICE TO 6" ABOVE THE CEILING IN RECESSED CEILING AREAS. IN OPEN STRUCTURE AREAS, INSTALL CONDUIT FROM EACH DEVICE TO ABOVE THE NEAREST RECESSED CEILING AREA. INSTALL PLENUM RATED FIRE ALARM WIRING FROM EACH DEVICE TO THE FIRE ALARM CONTROL PANEL. BUNDLE AND NEATLY ROUTE WIRING IN CEILING SPACE PERPENDICULAR AND PARALLEL TO WALLS.
- C VERIFY THE EXACT LOCATION OF ALL SPRINKLER SYSTEM FLOW AND TAMPER SWITCHES WITH MECHANICAL DRAWINGS. CONNECT ALL SPRINKLER SYSTEM FLOW AND TAMPER SWITCHES TO THE FIRE ALARM CONTROL SYSTEM.
- D REFER TO MECHANICAL DRAWINGS FOR LOCATIONS OF ALL TEMPERATURE CONTROL DEVICES.
- E FIRE ALARM DEVICES SHALL INTEGRATE WITH EXISTING SHELL BUILDING SYSTEM. ANY NEEDED POWER SUPPLIES SHALL BE LOCATED IN ELECTRICAL ROOM AND BE POWERED FROM PANEL L2A. FIRE ALARM SHALL BE LEFT WITH AT LEAST 20% AVAILABLE CAPACITY FOR FUTURE EXPANSION.

**BSA**  
*LifeStructures.*

5113 Southwest Pkwy, Suite 100  
Austin, TX 78735

ph 512.531.9075  
www.bsallifestructures.com

LONE STAR PODIATRY

3944 S. RANCH ROAD 620S, #203  
BEE CAVE, TEXAS 78738

Project Number: 19680002.02A


Project Team:

**OWNER**  
LONE STAR PODIATRY  
11614 FM2244 # 150  
Austin, TX 78738  
CONTACT: Dr. Andrew Cassidy  
(512) 253-5418

**ARCHITECT**  
BSA LIFESTRUCTURES  
5113 Southwest Pkwy  
Suite One Hundred  
Austin, TX 78735  
CONTACT: CRAIG PUCCHETTI  
P: 512.531.9075  
F: 512.531.9076

**MEP**  
AGNEW ASSOCIATES, INC.  
14205 BURNET ROAD SUITE 200  
AUSTIN, TX 78728  
JAMES HOLLOWAY, P.E.  
P: 512.628.0753

Professional Seal:

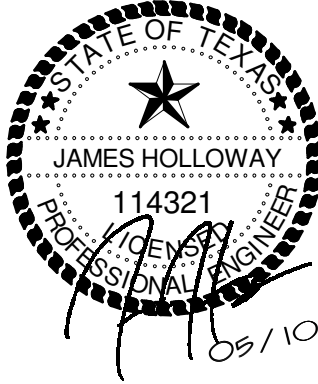

No.	Issue Description	Date
Project Status		04.21.17

Drawn By:	Checked By:
BJS	JAH

Sheet Title:

FLOOR PLAN - FIRE ALARM  
& EQUIPMENT - POD

Sheet Number:

E4.1

**AGNEW ASSOCIATES, INC.**  
MECHANICAL & ELECTRICAL CONSULTING ENGINEERS  
LUBBOCK, TEXAS TEXAS REGISTERED ENGINEERING FIRM F-1005 AUSTIN, TEXAS  
PHONE: (806) 799-0753 A/E PROJECT NO. 2217028.3 PHONE: (512) 838-0753  
FAX: (806) 799-2014 WWW.AGNEWASSOCIATES.COM FAX: (512) 310-0750