


RECEIVED
VILLAGE OF HEMPSTEAD
2006 SEP -8 AM 10:13
BUILDING DEPARTMENT


BUILDING DEPARTMENT
VILLAGE OF HEMPSTEAD
THESE PLANS ARE ACCEPTED AS PROPOSALS FOR CONSTRUCTION BUT EXAMINATION MEAN APPROVAL OR ANY LIABILITY THEREFORE THEY MUST MEET ALL REQUIREMENTS OF ALL APPLICABLE LAWS OR ORDINANCES WHETHER OR NOT CORRECTLY OR INCORRECTLY SHOWN.

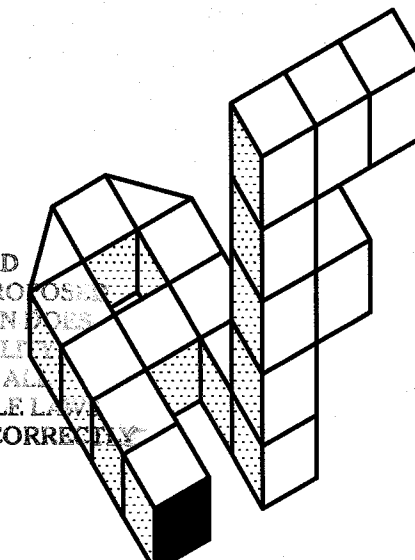

ART OF FORM
ARCHITECTURE
55 Broadway (Route 10)
Amityville, NY 11701
631-264-899 FAX 631-264-899
E-mail: admin@artofform.com

THESE PLANS ARE AN INSTRUMENT OF SERVICE AND OR THE PROPERTY OF THE ARCHITECT. INFRINGEMENTS WILL BE PROSECUTED.


NO.	DATE	DESCRIPTION	BY	CHK.
1	08-24-06	ISSUED TO BUILDING DEPT.	JCM	
2	09-11-06	ISSUED TO PLANNING BOARD	JCM	

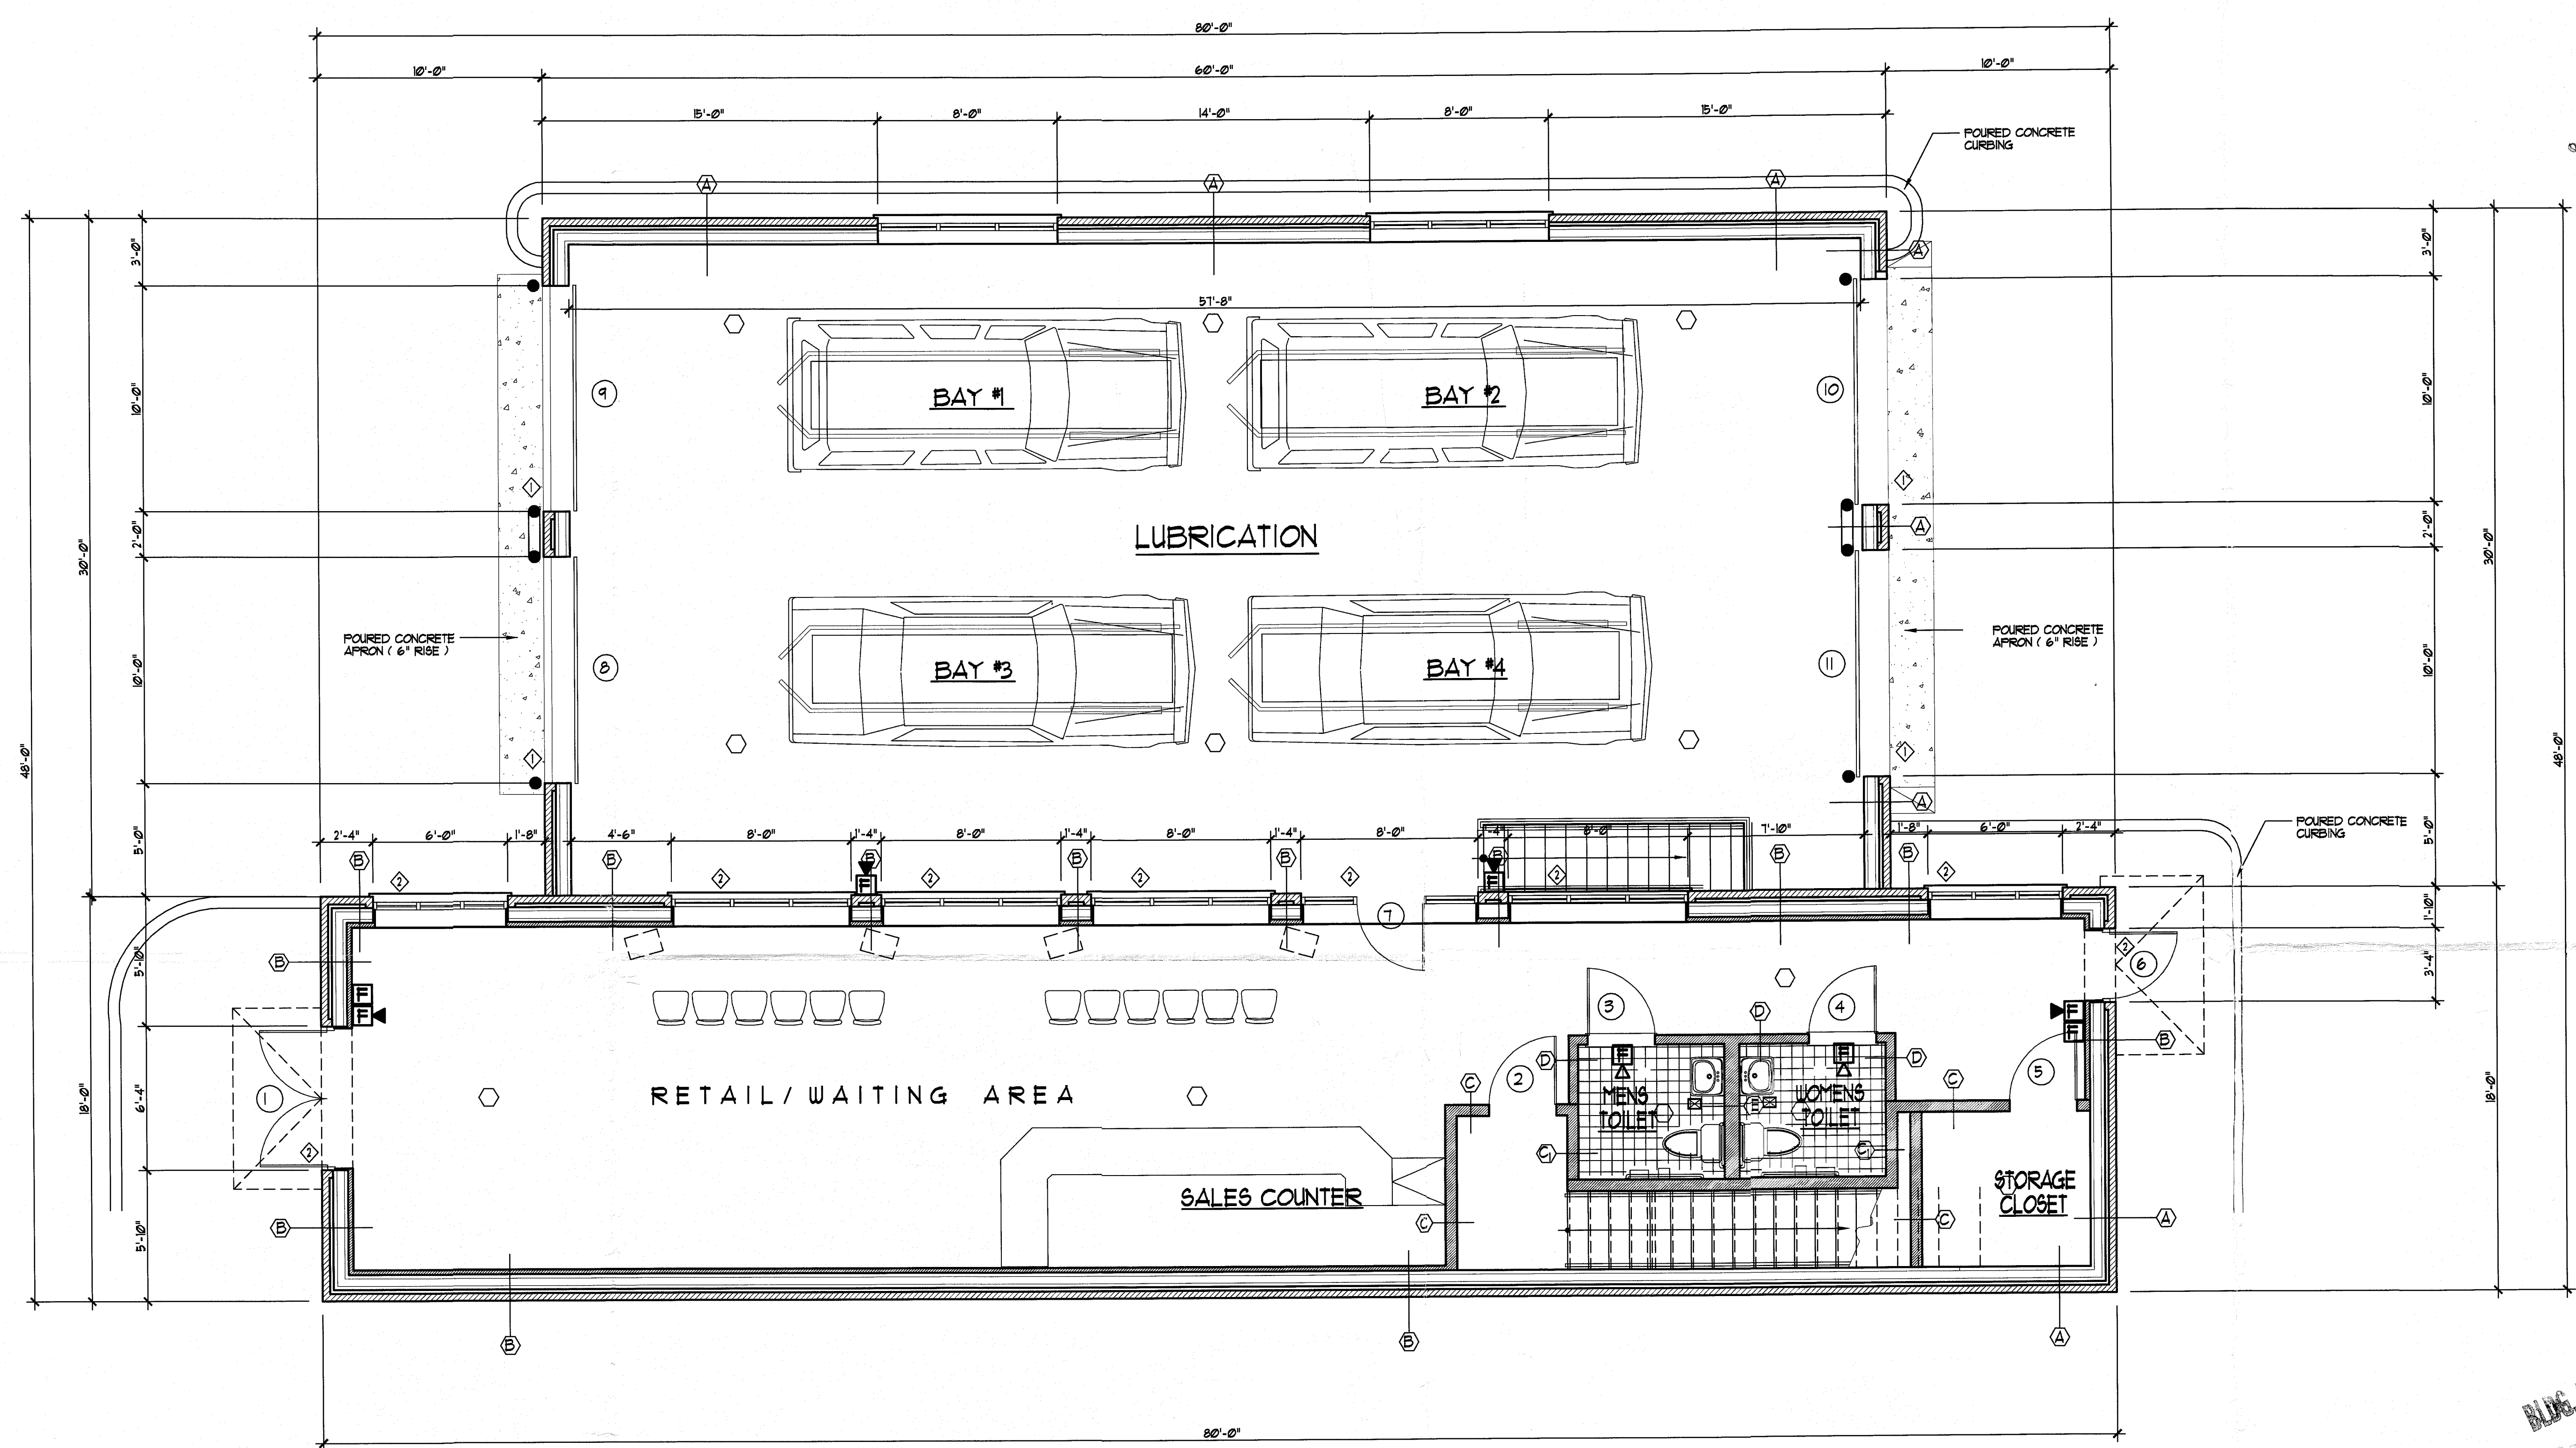

FLOOR PLAN

SCALE 1/4" = 1'-0"

PARTITION LEGEND

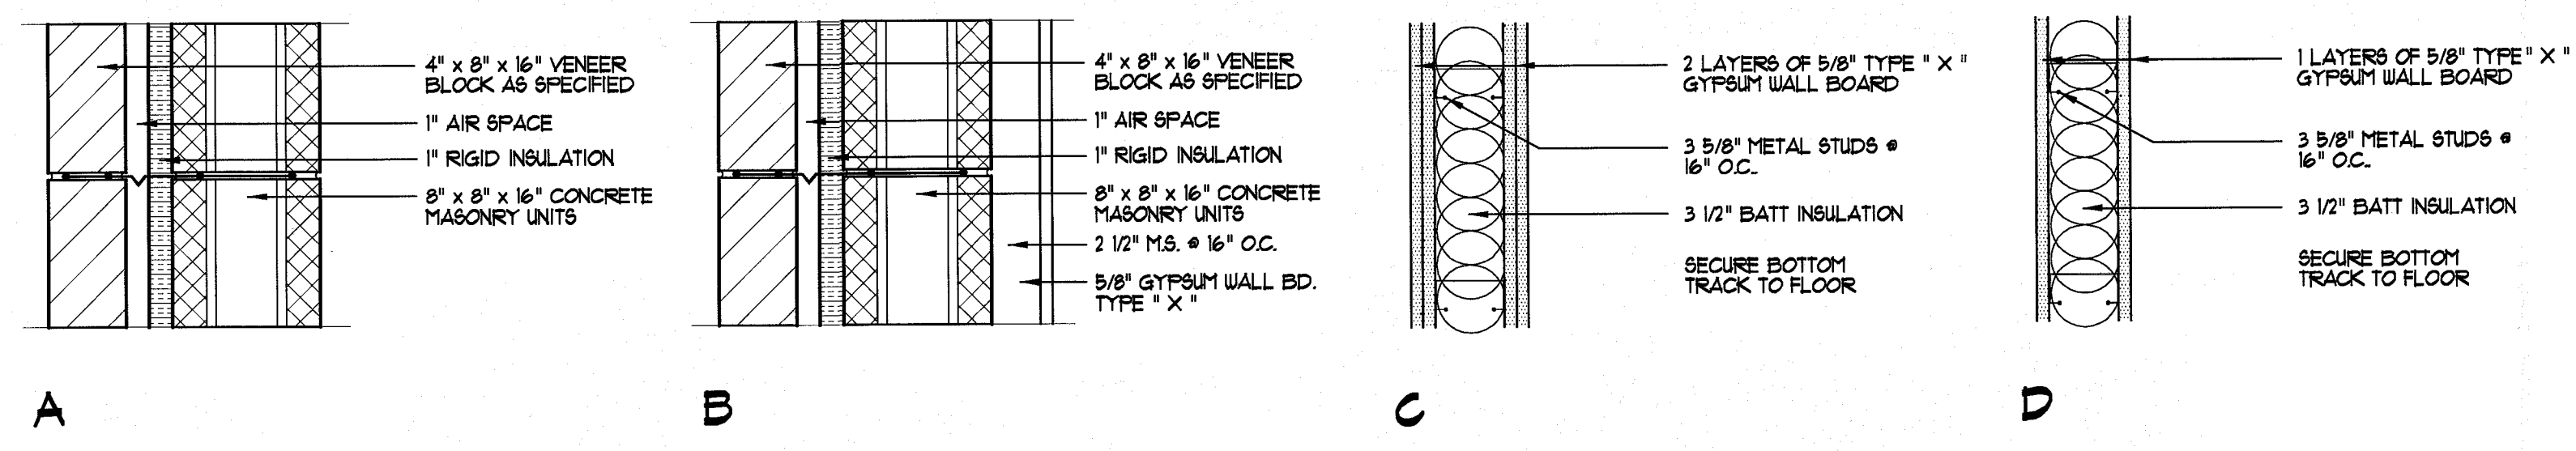

LINTEL SCHEDULE


- ◆ I 18x15 1/2"x12" CONTINUOUS BEARING PLATE MINIMUM 8" BEARING @ EACH END
- ◆ LL (3) 3 1/2"x3 1/2"x5/16" MINIMUM 4" BEARING @ EACH END

BLDG. DEPT. COPY
CROSS CONNECTION CONTROL DEVICE
REQUIRED AT WATER SERVICE
BACKFLOW PREVENTER
NEW YORK STATE DEPT. OF HEALTH

SPRINKLER SYSTEM
REQUIRED
ELECTRICAL PERMIT REQUIRED
PLUMBING PERMIT REQUIRED
SMOKE AND FIRE
ALARM SYSTEM
REQUIRED

THIS DRAWING IS APPROVED
FOR CONSTRUCTION
DATE: SEP 11 2006
BUILDING DEPARTMENT
VILLAGE OF HEMPSTEAD, NY

PROPOSED NEW BUILDING FOR :
CENTRAL AUTO SERVICE
PENINSULA BOULEVARD
HEMPSTEAD, NEW YORK

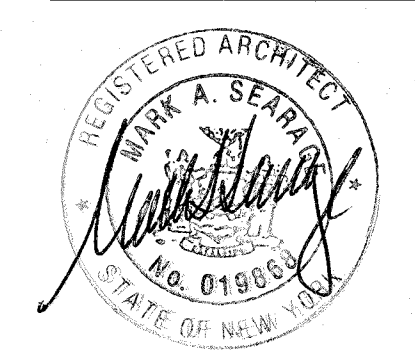

DRAWN BY: JCM
CHECKED BY: M.A.S.
DATE: 08-16-05
PROJECT: 04012
DRAWING TITLE: