

No.	REVISIONS	DATE	BY	SEAL

**90% DESIGN**  
FOR REVIEW ONLY

**CJS**  
Conveyance, PLLC  
320 S. ACADEMY ST  
CARY, NC 27511  
NC LICENSE #P-1611    WWW.CJS.CONVEYANCE.COM

**WATER RESOURCES DEPARTMENT**  
**TOWN OF APEX**  
**BIG BRANCH 2 PUMP STATION -**  
**FORCE MAIN**




**FORCE MAIN PLAN AND PROFILE**  
**STA 194+00 TO STA 205+50**

CJS PROJ. #:	100-005
DATE:	11-20-2023
SCALE:	1" = 20'
PROJECT ENGINEER:	SDL
DESIGNED BY:	JJS
DRAWN BY:	JJS
CHECKED BY:	SDL

C17

SHEET NUMBER  
**19 OF 51**

NOTES:  
 1. PRIOR TO BORING ACTIVITIES CONTACT PAUL LUSK AT LARRY.LUSK@DOMINIONENERGY.COM OR (919) 819-6983

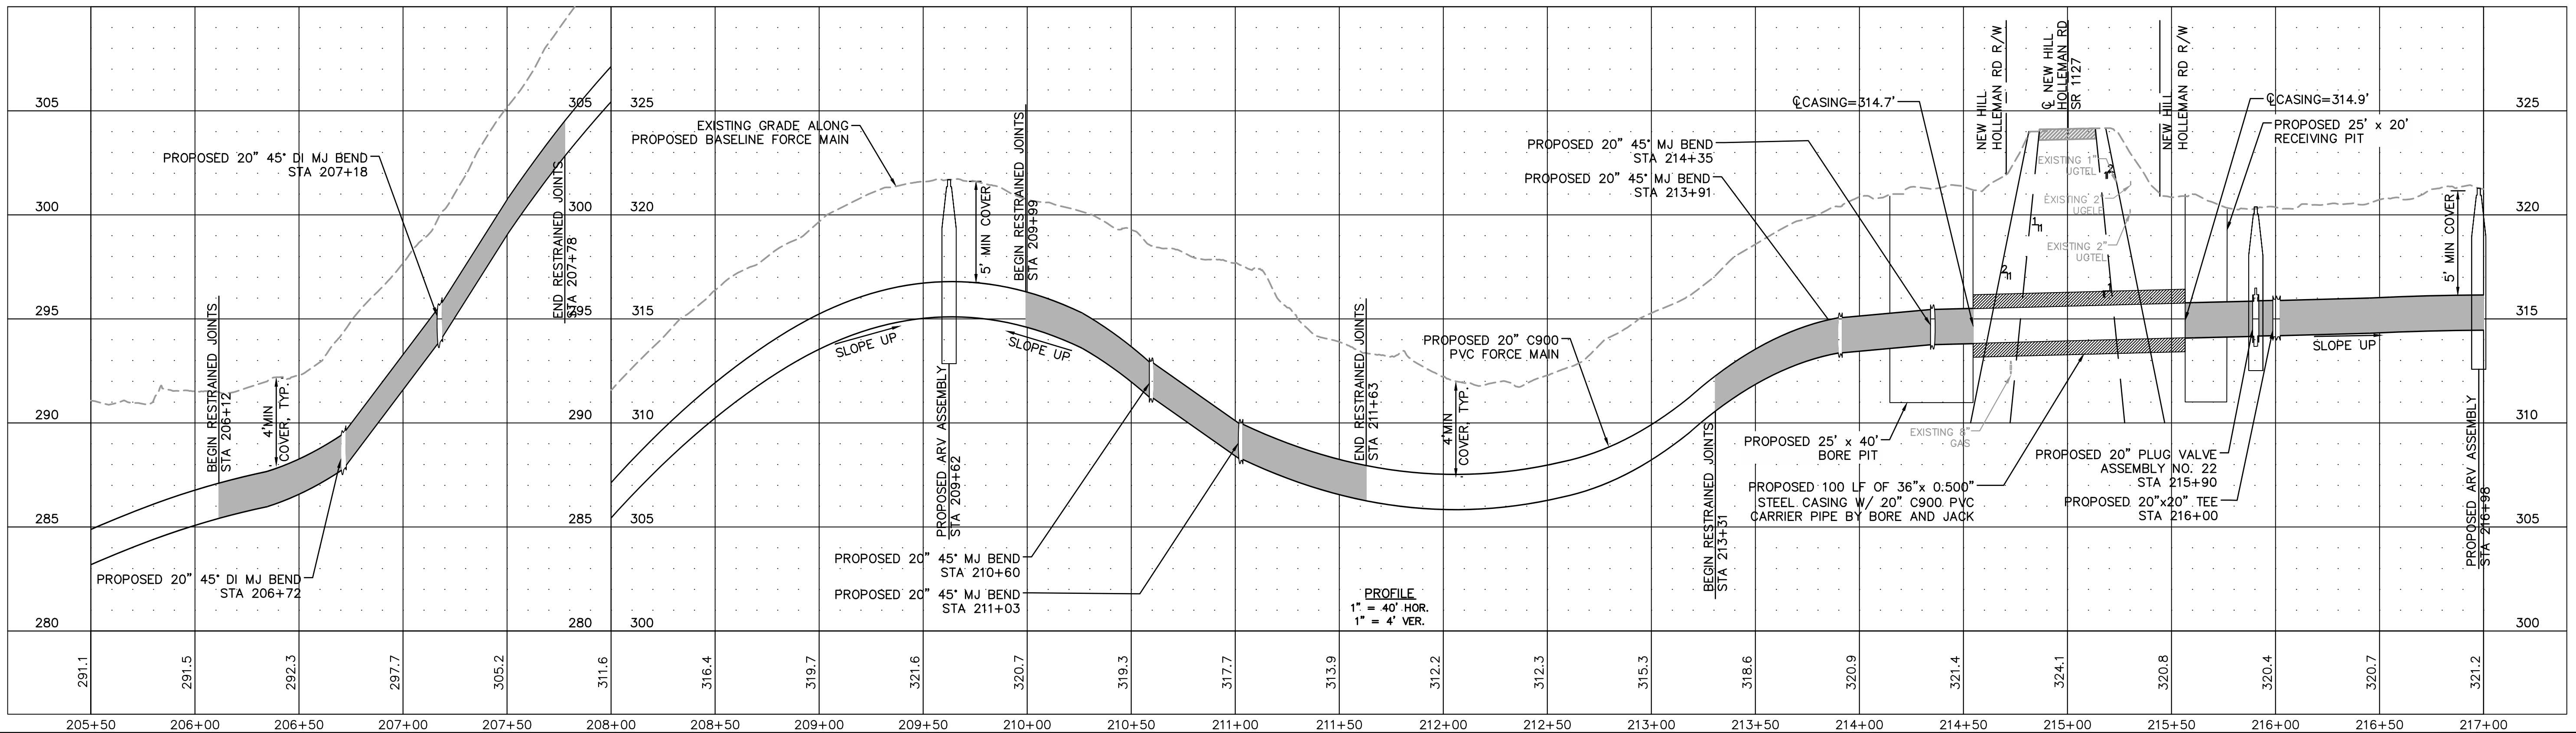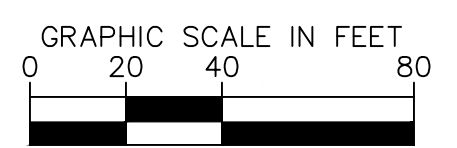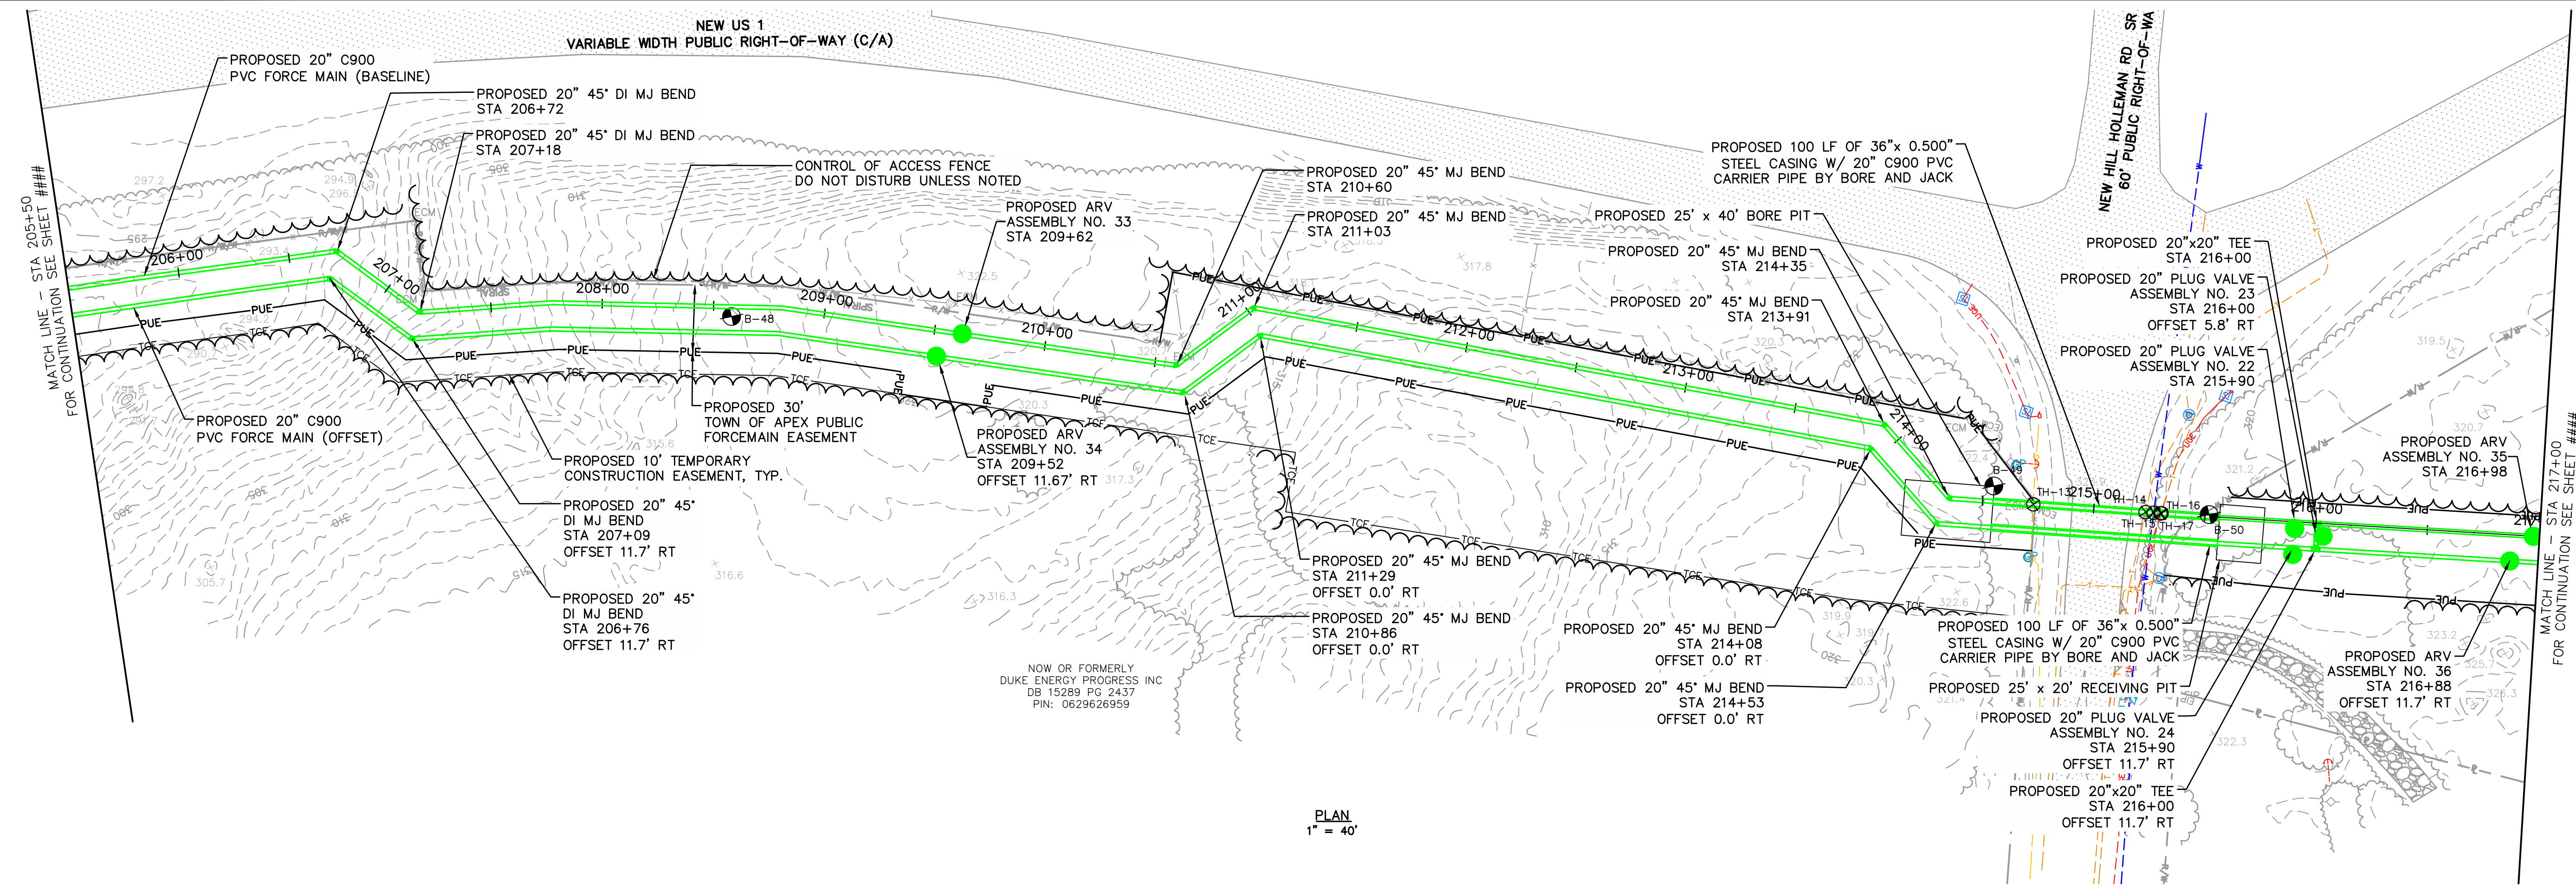

Plotted By: J. Speers Layout: 20 FORCE MAIN PLAN AND PROFILE STA 205+50 TO STA 217+00 December 01, 2023 10:30:55am S:\100 Hazen and Sawyer\100-005 Apex Big Branch 2 PS\B0 - Drawings\Plan Sheets\C-SHT-BIG BRANCH-4.dwg

**90% DESIGN**  
 FOR REVIEW ONLY



**WATER RESOURCES DEPARTMENT**  
**TOWN OF APEX**  
**BIG BRANCH 2 PUMP STATION -**  
**FORCE MAIN**

**FORCE MAIN PLAN AND PROFILE**  
**STA 205+50 TO STA 217+00**

CJS PROJ. #:	100-005
DATE:	11-20-2023
SCALE:	1" = 20'
PROJECT ENGINEER:	SDL
DESIGNED BY:	JJS
DRAWN BY:	JJS
CHECKED BY:	SDL

**C18**  
 SHEET NUMBER  
**20 OF 51**