


FLOOR PLAN
SCALE 1/4" = 1'-0"

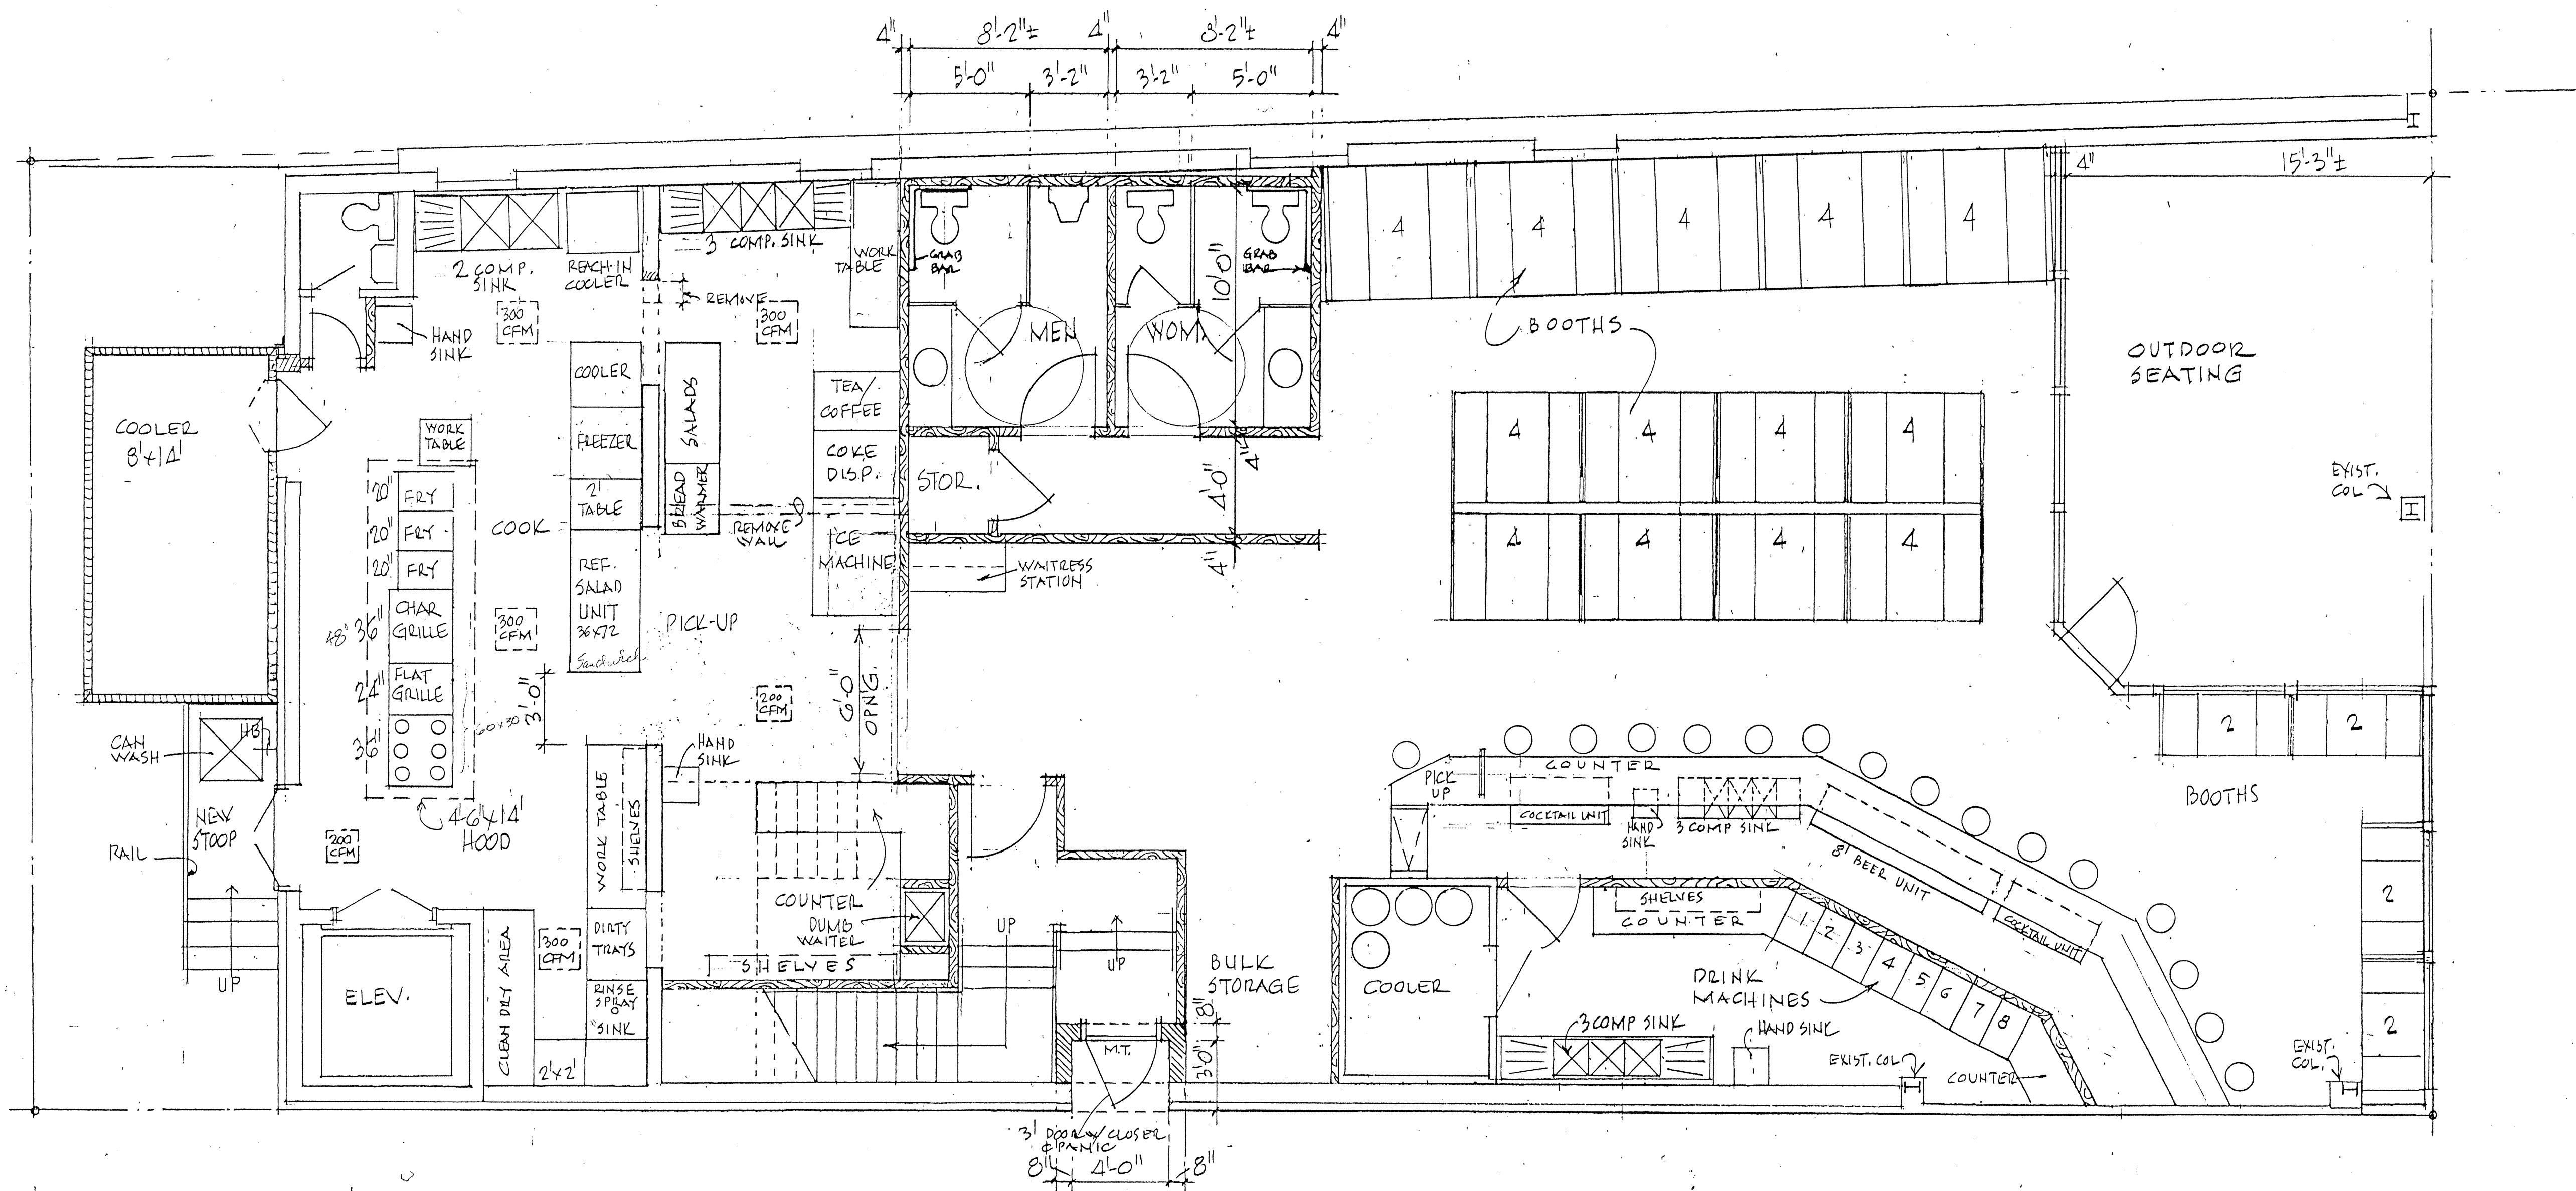

FLOOR PLAN
SCALE: 1/4" = 1'-0"

← EAST NORTH STREET →

↑ NORTH MAIN STREET ↓


	TASSEY'S TAVERN GREENVILLE, SOUTH CAROLINA	
	CONSTANTINE & CONSTANTINE ARCHITECTS, INC. 1975 SAN. HWY., SUITE 4 CHARLESTON, S.C. 29407 (803) 402-0101	
JOB NO: BY: E.A.C.	DATE: AUG. 1997 DRAWING: 1 OF 1	SHEET 1/1

PLUMBING FIXTURES

MARK	FIXTURE	MODEL, MFG TYPE	FURNISHED BY	INSTALLED BY	CW	HN	WASTE	NOTES
P-1	HANDICAP WC	AME STD 210BB, OSB W/OPEN RISE SEAT	PLUMBER	PLUMBER	1/2"		4"	
P-2	WATER CLOSET	STANDARD RAINCE	"	"	1/2"		4"	
P-3	EXISTING W.C.							
P-4	URINAL	AME STD TRIM DOOR W/TANK	PLUMBER	PLUMBER	3/4"		2"	
P-5	HANDICAP LAV	OVAL BUILT INTO COUNTER ONLY W/LEVER FAUC	PLUMBER	PLUMBER	1/2"	1/2"	2"	
P-6	EXISTING LAV							
P-7	LAVATORY	14" x 17" WALL MOUNT W/LEVER FAUCET	PLUMBER	PLUMBER	1/2"	1/2"	2"	
P-8	3 COMP SINK W/DR BD		OWNER	PLUMBER	1/2"	1/2"	2"	
P-9	3 COMP SINK		OWNER	PLUMBER	1/2"	1/2"	2"	
P-10	12" x 12" FLOOR SINK		PLUMBER	PLUMBER			2"	
P-11	PREMASH SINK		OWNER	PLUMBER				
P-12	DISHWASHER		OWNER	PLUMBER	3/4"	1/2"	4"	
P-13	3 COMP SINK W/DR BD		OWNER	PLUMBER	1/2"	1/2"	2"	
P-14	2 COMP POT SINK W/DR BD		OWNER	PLUMBER	1/2"	1/2"	2"	
P-15	CAN WASH SINK		PLUMBER	PLUMBER	1/2"	1/2"	4"	
P-16	COKE MCH.		EQUIP SUPPLIER	EQUIP SUP & PLUMBER	1/2"			
P-17	TEA		OWNER	PLUMBER	1/2"			
P-18	COFFEE		OWNER	PLUMBER	1/2"			
	FLOOR DRAINS 4" & PRIMED WHERE NOTED		PLUMBER	PLUMBER				
	WATER HEATER OF SIZE AGREED TO BETWEEN OWNER-PLUMBER, LOCATED ON 2ND FLR & FURNISHED & INSTALLED BY PLUMBER							
P-19	CAPPUCCINO MCH		OWNER	PLUMBER	1/2"		2"	

HANDICAP REQUIREMENTS


- AT FIXTURE P-1 USE CORNER TYPE HANDICAP RAIL. MOUNT CENTER OF RAIL 33"-36" A.F.F.
- WATER CLOSET SEAT MIN 19" A.F.F.
- BOTTOM RAIL AT COUNTER TOP OF FIXTURE P-5 SHALL BE MIN 29" A.F.F.
- ALL FIXTURES & ACCESSORIES IN PUBLIC REST ROOMS SHALL BE IN COMPLETE ACCORDANCE W/ANSI 117.1 & LATEST A.D.A. ACT.

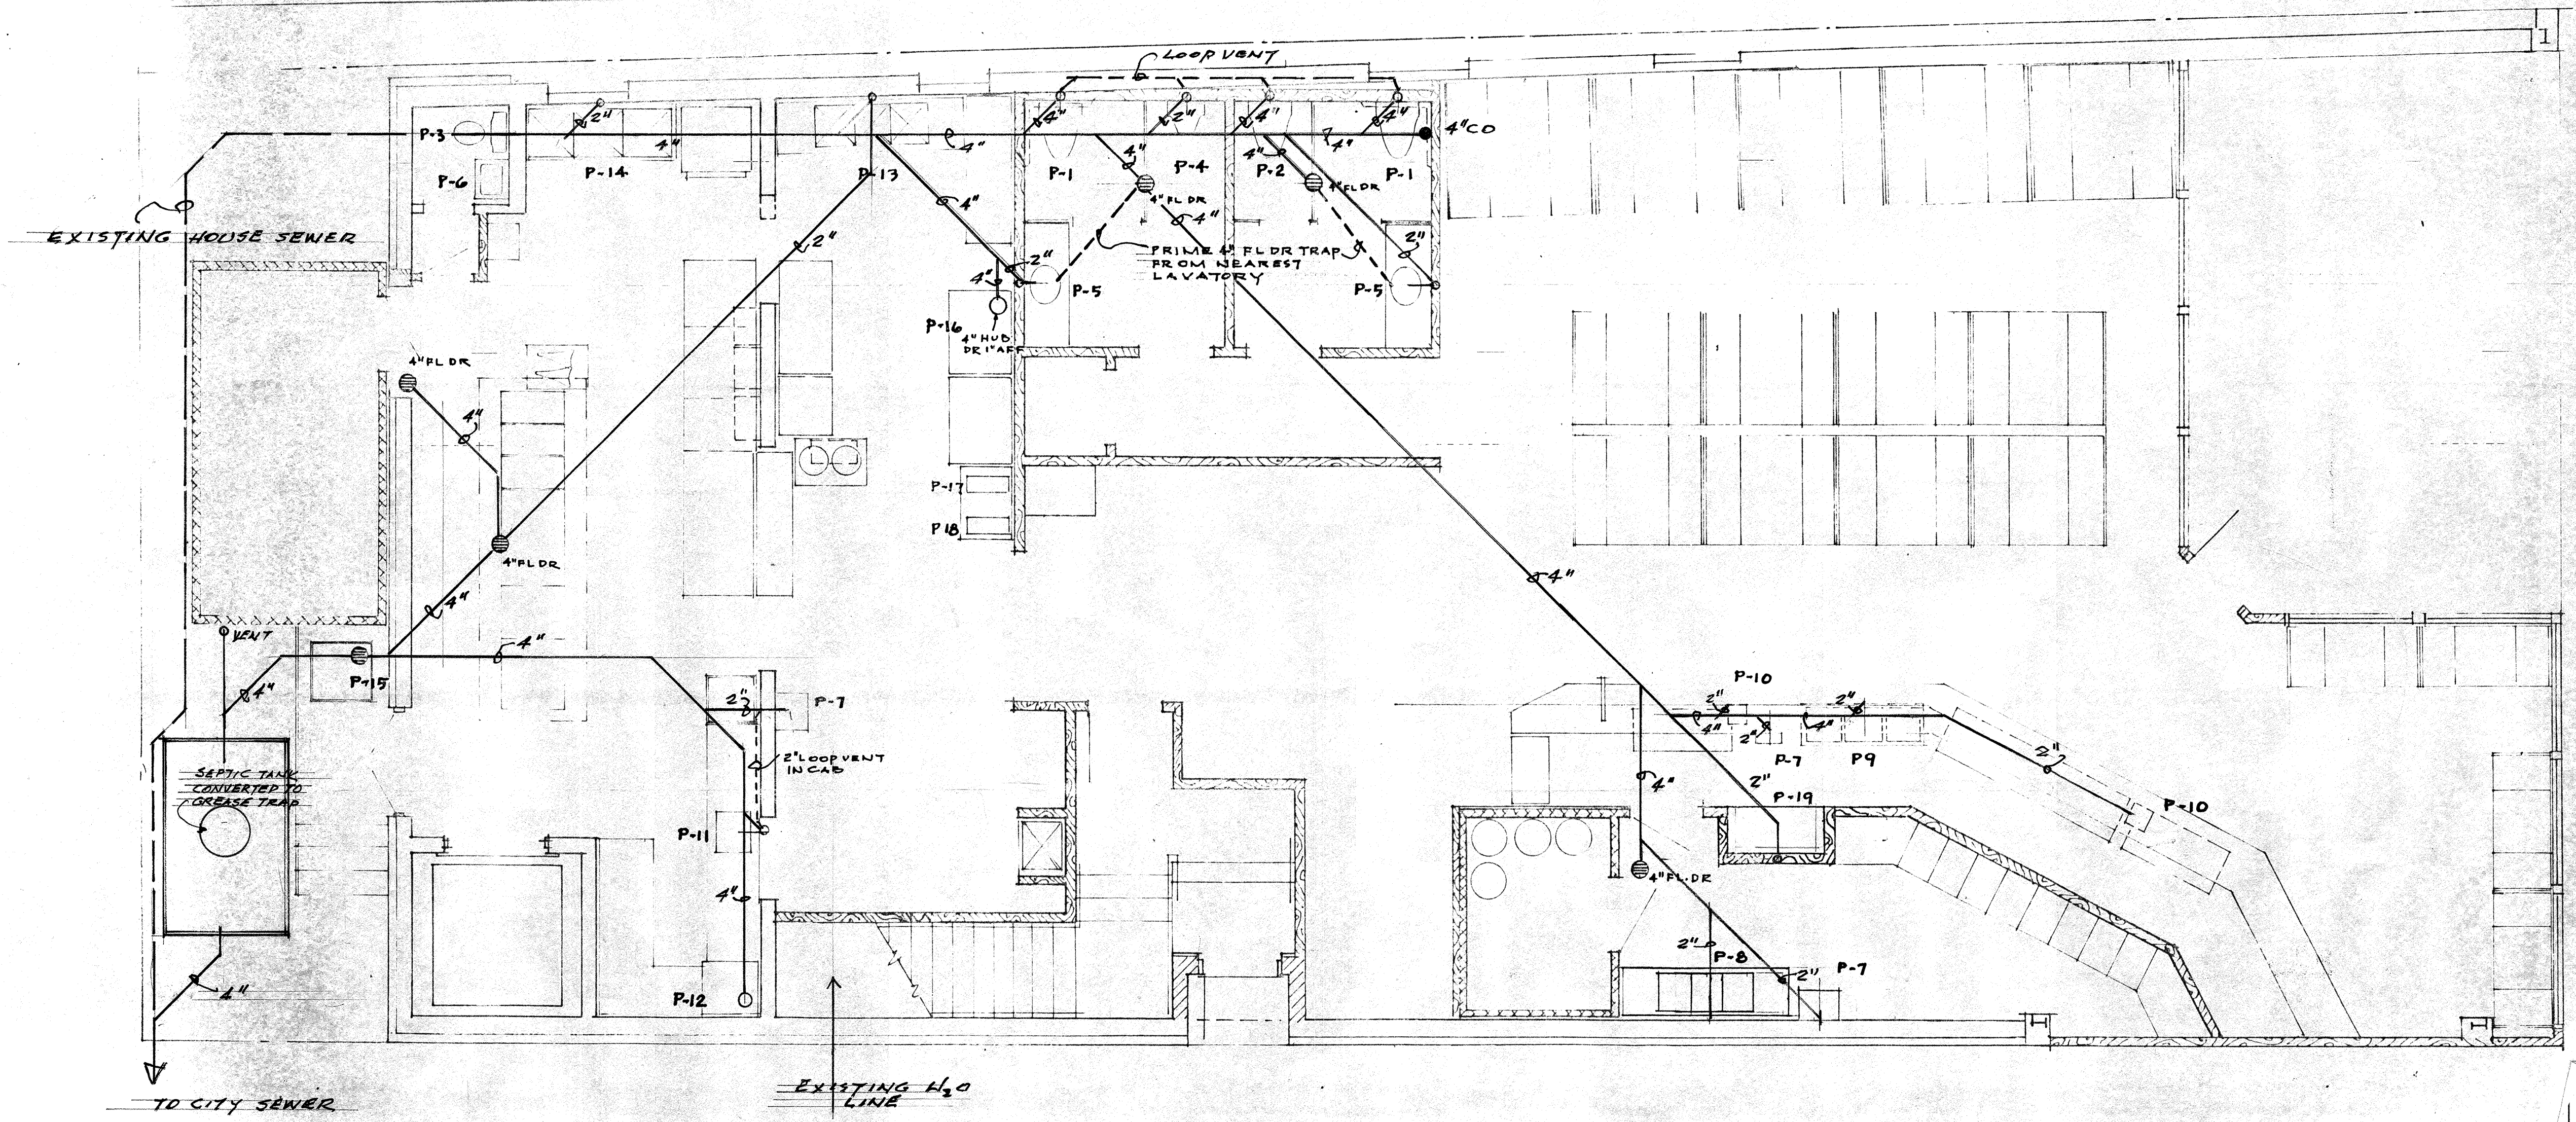

FLOOR PLAN
SCALE 1/4" = 1'-0"

	TASSEY'S TAVERN GREENVILLE, SOUTH CAROLINA	
	CONSTANTINE & CONSTANTINE ARCHITECTS, INC. 1975 SAN. HWY., SUITE 4 CHARLESTON, S.C. 29407 (803) 402-0101	SHEET OF
JOB NO: BY: E.A.C.	DATE: AUG. 1997 DRAWING: 1 OF 1	

PLUMBING CHANGES NOV 4/97

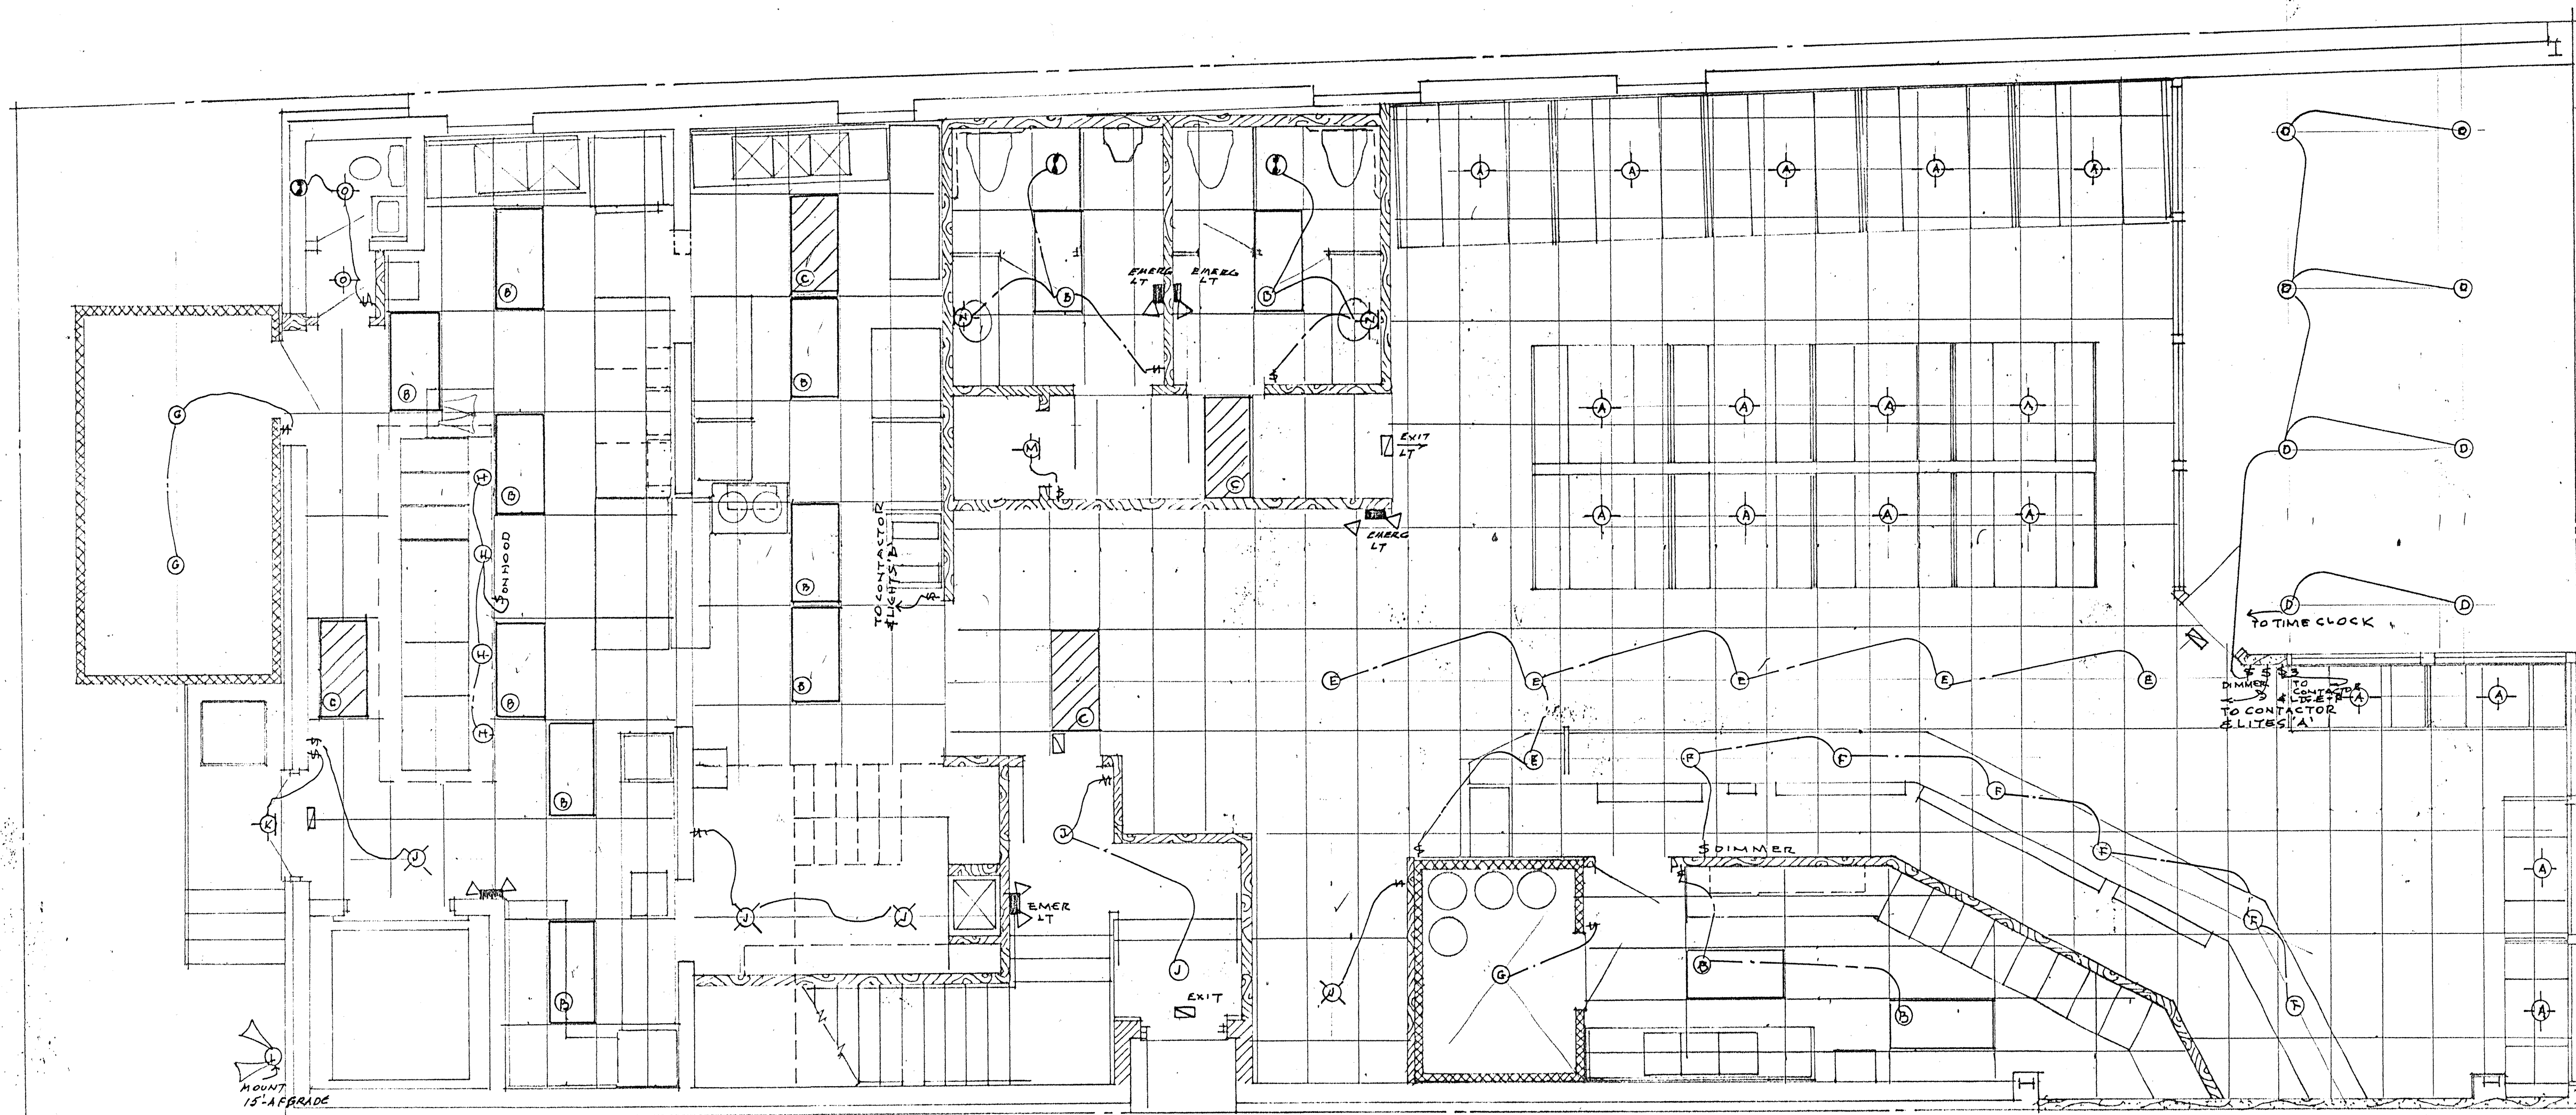


FLOOR PLAN
SCALE 1/4" = 1'-0"

	TASSELY'S TAVERN GREENVILLE, SOUTH CAROLINA	
	<small>CONSTANTINE & CONSTANTINE ARCHITECTS, INC. Charleston, South Carolina</small>	
JOB NO: BY: E.A.C.	DATE: AUG 1997 DRAWING:	OF

PANEL "B" FLUSH MT OR RECESSED						
200 AMP MAIN LUGS ONLY 120/208 3Ø 4W/1Ø						
REMARKS	KN	BRK	CIRCUIT	BRK	KW	REMARKS
DRINK BOX	20/1	1	2	20/1		CASH REG
COFFEE	20/1	3	4	20/1		TEA
SPARE	20/1	5	6	20/1		SPARE
SPARE	20/1	7	8	20/1		SPARE
BEER COOLER	20/1	9	10	20/1		FOOD WARR
CORR MCH	20/1	11	12	20/1		MICRO
SLAD RFG	20/1	13	14	20/1		MICRO
MIXER	20/1	15	16	20/1		MICRO
BLENDER	20/1	17	18	20/1		MICRO
TOASTER	20/1	19	20	20/1		SPARE
SPARE	20/1	21	22	20/1		SPARE
SPARE	20/1	23	24	20/1		CONV OUT
FREER	20/1	25	26	20/1		CONV OUT
COOLER	20/1	27	28	20/1		WALL OUT
SPARE		29	30			SPARE
		31	32			
		33	34			
		35	36			
		37	38			
		39	40			
		41	42			

PANEL A FLUSH MT OR RECESSED						
200 AMP MAIN LUGS ONLY 120/208 3Ø 4W/1Ø						
REMARKS	KN	BRK	CIRCUIT	BRK	KW	REMARKS
CONV OUTLET	20/1	1	2	20/1		CONV OUT
CORR MCH	20/1	3	4	20/1		WALL OUT
FRIG MCH	20/1	5	6	20/1		WALL OUT
ICE MCH		7	8	20/1		SANITICH
HEAT LTS	20/1	9	10	20/1		FRY
FREER	20/1	11	12	20/1		FRY
COOLER	20/1	13	14	20/1		HOOD
DISHWASH	50/1	15	16	20/1		SPARE
		17	18	20/1		SPARE
		19	20	20/1		DUMBWAIT
SPARE		21	22			SPARE
		23	24			
		25	26			
		27	28			
		29	30			
		31	32			
		33	34			
		35	36			
		37	38			
		39	40			
		41	42			

EXIST PANEL TO REMAIN. ADD PROSTY MCH (DISP & COMP TO IT)
 ALSO 1ST FLOOR LIGHTING
 NEW AIR CONDITIONING AT FRONT ADDED TO CIRC AVAILABLE

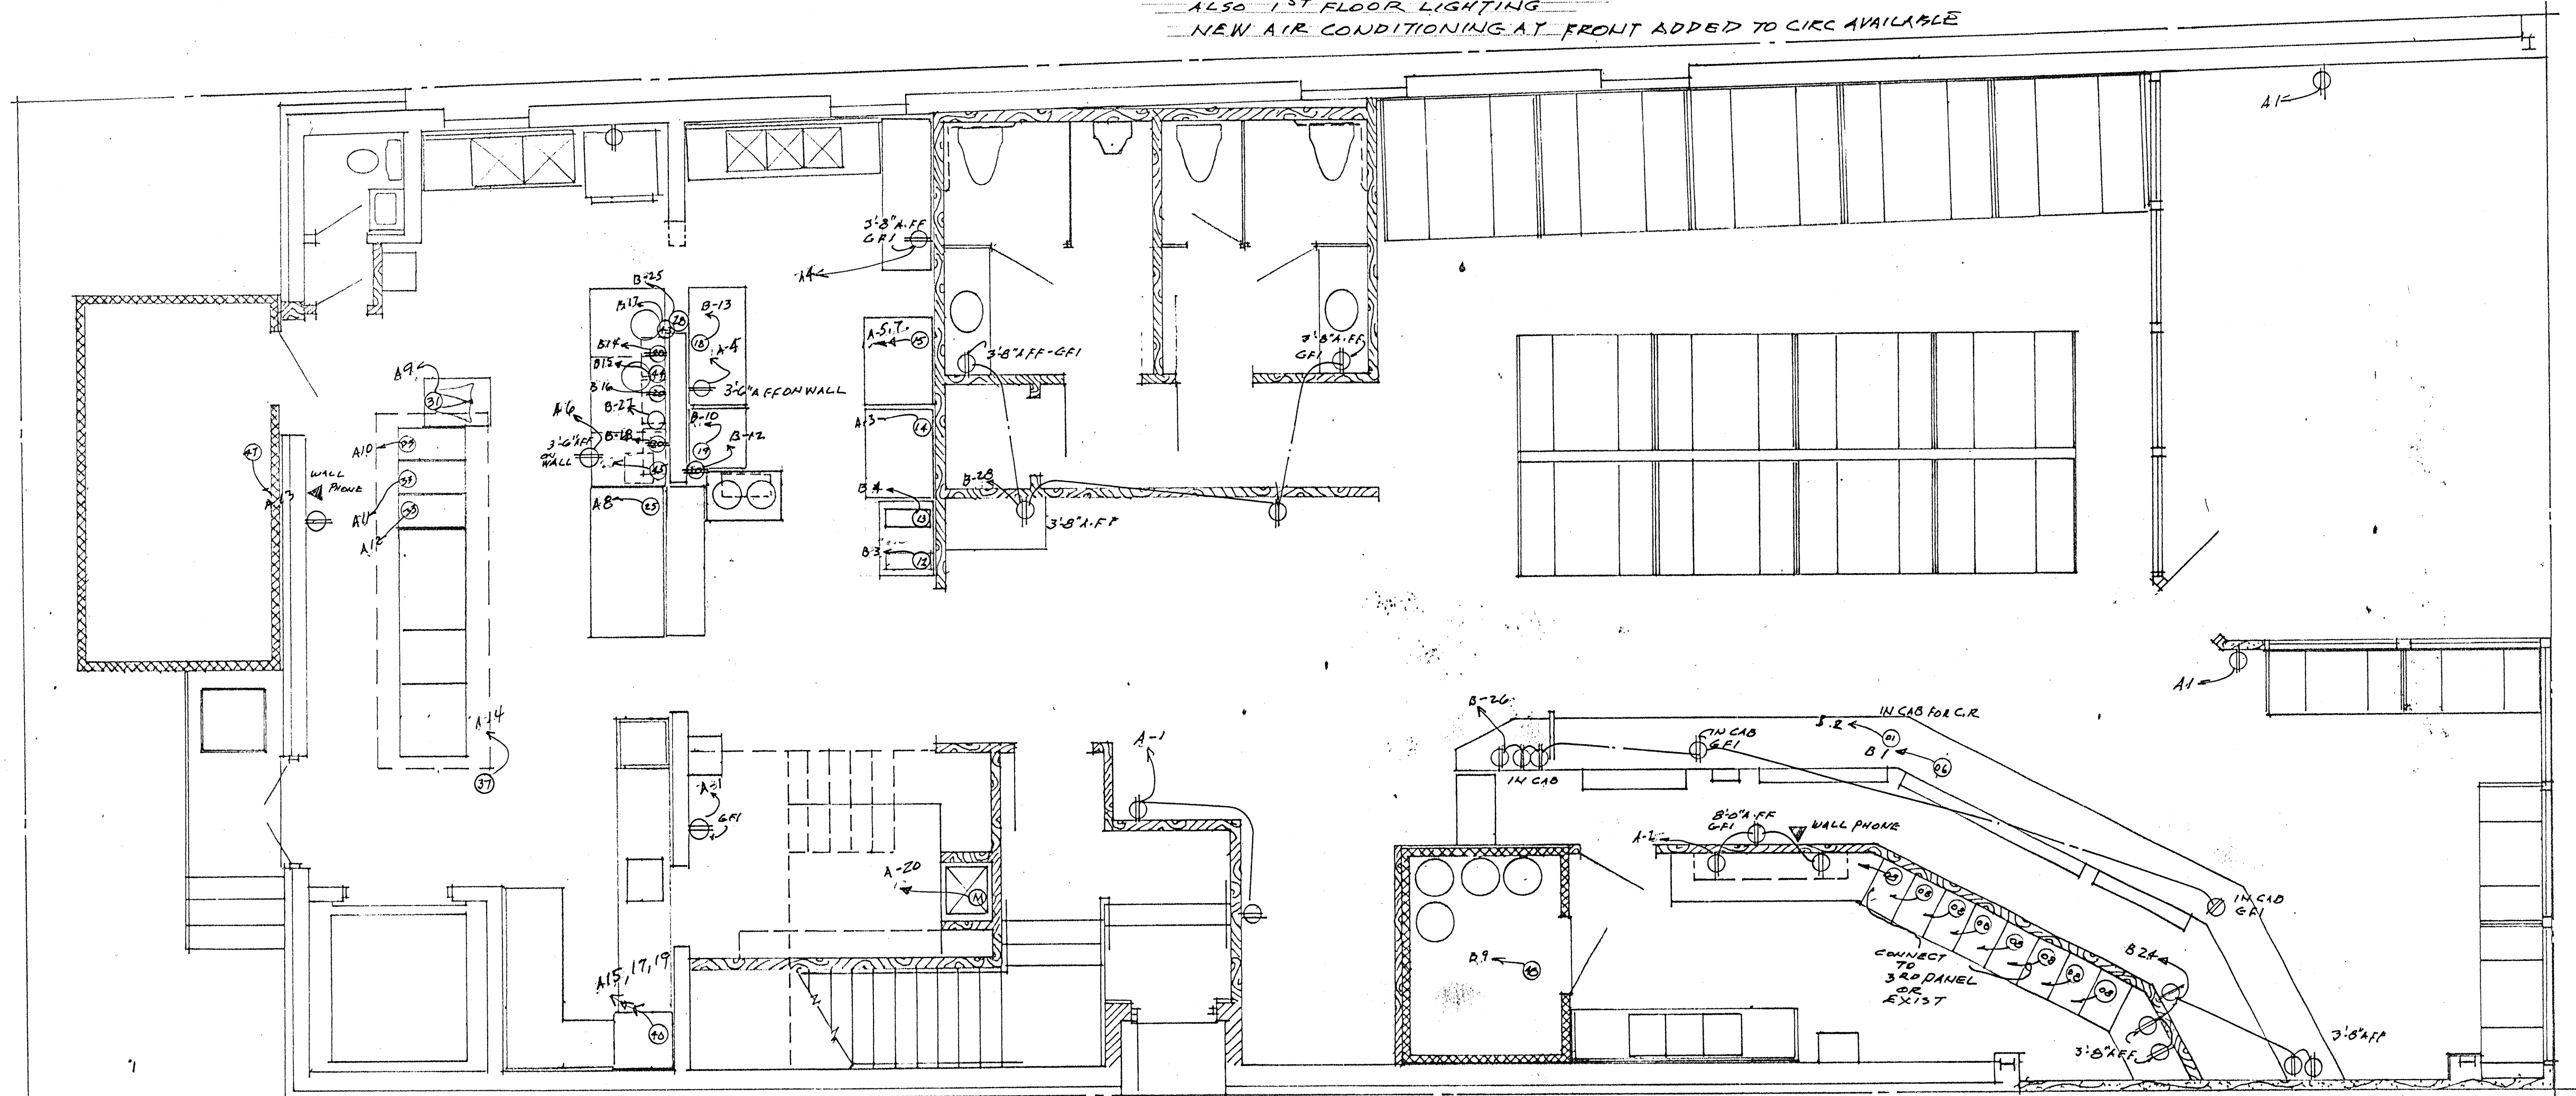

ELECTRICAL OUTLET PLAN
 FLOOR PLAN
 SCALE 1/4" = 1'-0"

TASSEY'S TAVERN
 GREENVILLE, SOUTH CAROLINA

CONSTANTINE & CONSTANTINE ARCHITECTS, INC.
 Charleston, South Carolina

JOB NO: 1371 DATE: AUG 1997
 DRAWING: 02