


FLOOR PLAN - KEY PLAN  
1/8" = 1'-0"

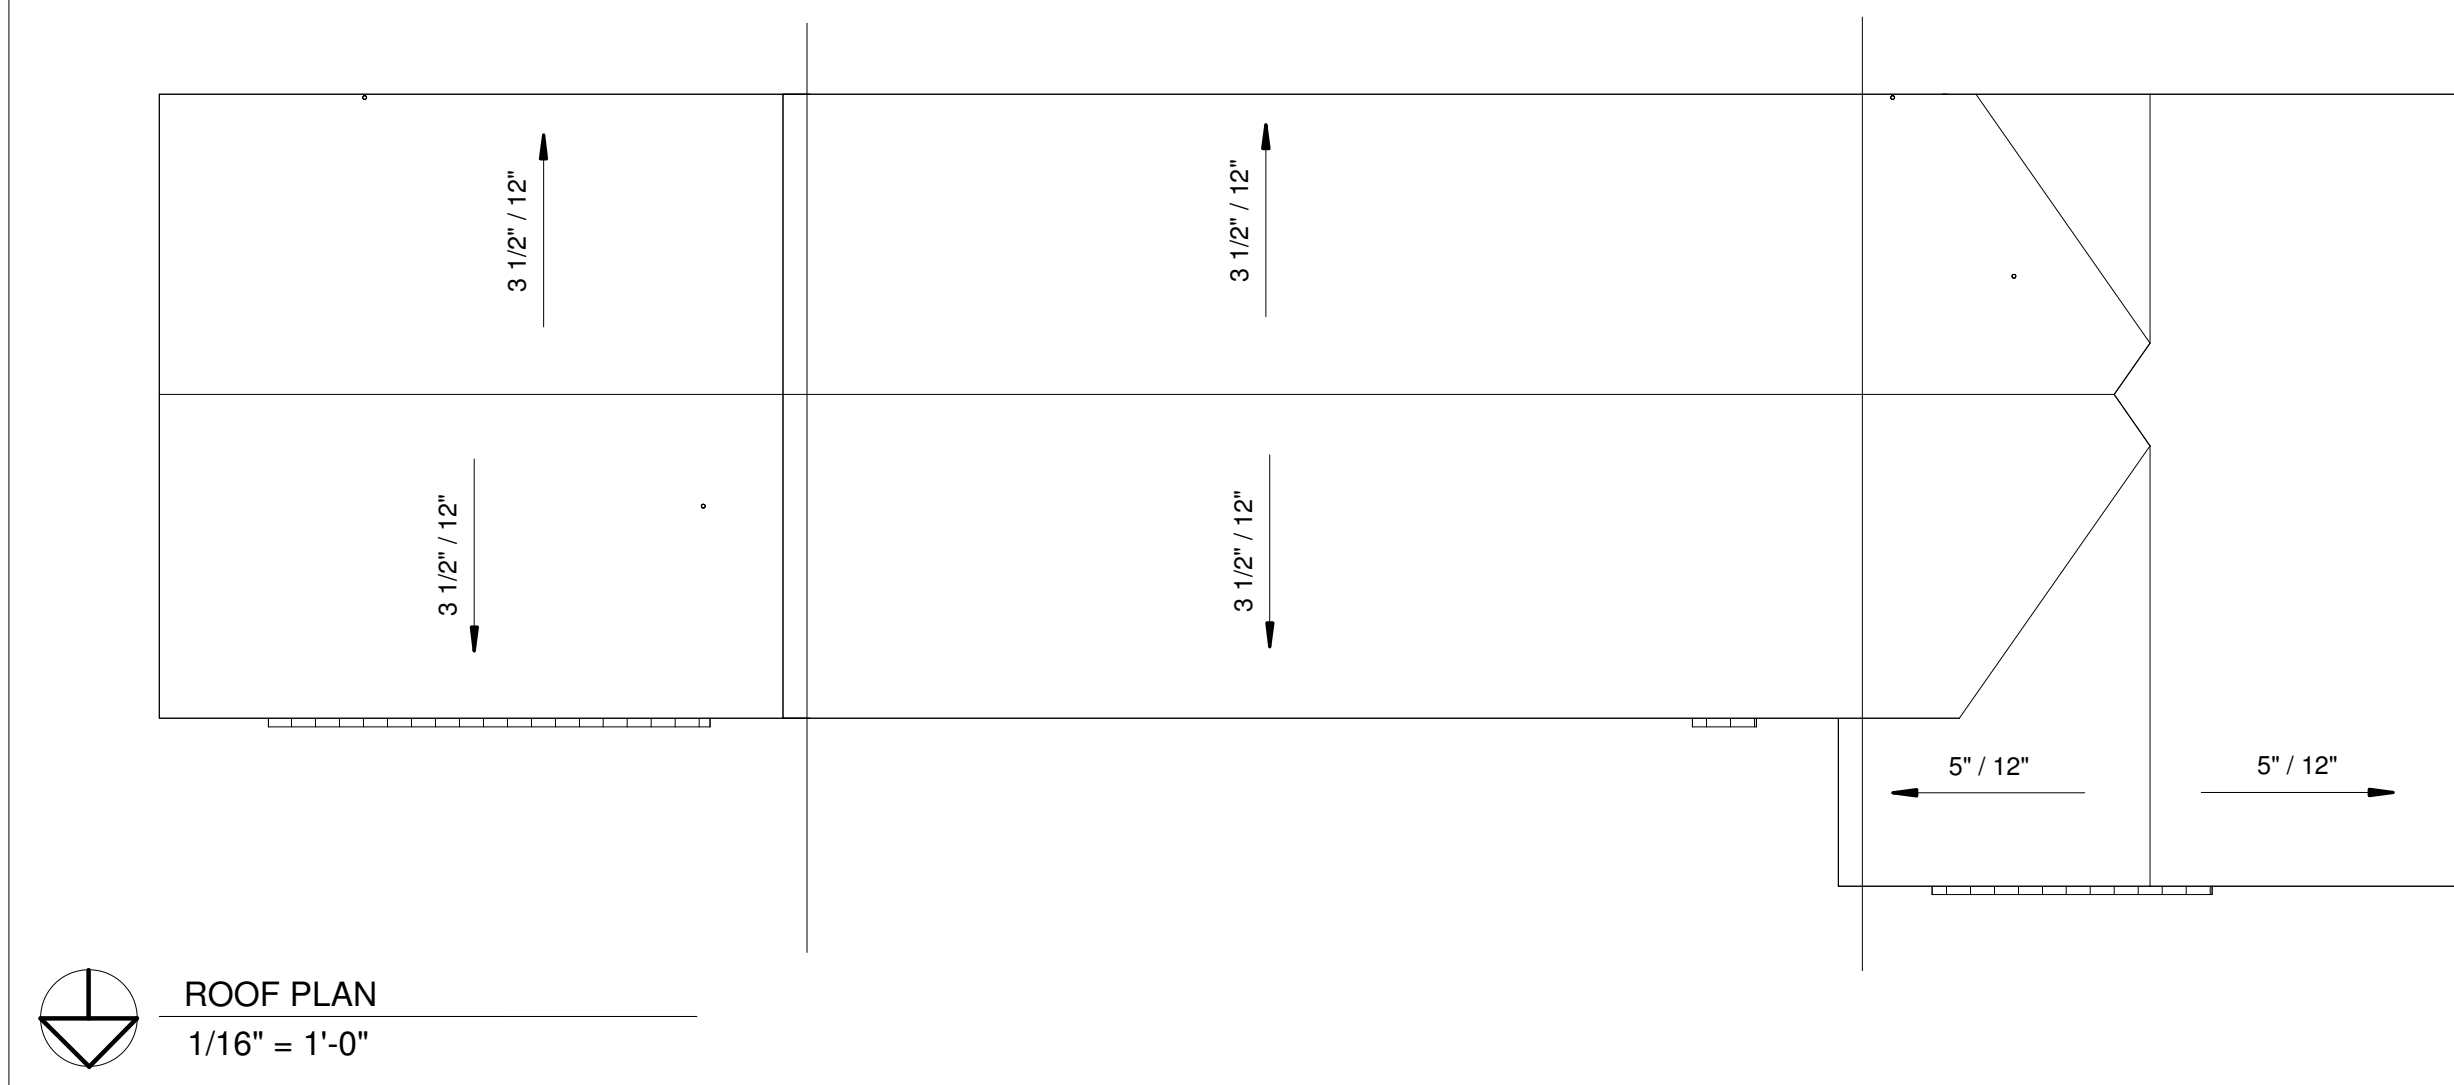

FINISH SCHEDULE				
ROOM	FLOOR	WALL	CEILING	
NAME	MATERIAL	MATERIAL	MATERIAL	HEIGHT
RECEPTION AREA	OWNER OPTION CONCRETE OR VCT	5/8" GWB TEXTURED PRIMED AND PAINTED	ACOUSTICAL TILE DROP CEILING	9' - 0"
OFFICE	OWNER OPTION CONCRETE OR VCT	5/8" GWB TEXTURED PRIMED AND PAINTED	ACOUSTICAL TILE DROP CEILING	9' - 0"
WHITE ROOM	OWNER OPTION CONCRETE OR VCT	FRP OVER 5/8" GWB PRIMED AND PAINTED	ACOUSTICAL TILE DROP CEILING	9' - 0"
ADA RESTROOM @ RESTROOM	OWNER OPTION CONCRETE OR VCT	5/8" GWB TEXTURED PRIMED AND PAINTED FRP ON BOTTOM 4'-0" OF WALL	5/8" TEXTURED PRIMED AND PAINTED ON CEILING JOISTS	9' - 0"
SALES FLOOR	OWNER OPTION CONCRETE OR VCT	5/8" GWB TEXTURED PRIMED AND PAINTED	5/8" GWB TEXTURED PRIMED AND PAINTED	UNDERSIDE STRUCTURE
RECEPTION AREA	OWNER OPTION CONCRETE OR VCT	5/8" GWB TEXTURED PRIMED AND PAINTED	5/8" TEXTURED PRIMED AND PAINTED ON CEILING JOISTS	9' - 0"
WAREHOUSE	SEALED CONCRETE	5/8" GWB TEXTURED PRIMED AND PAINTED	5/8" GWB TEXTURED PRIMED AND PAINTED	UNDERSIDE STRUCTURE
STORAGE/MECHANICAL & MECHANICAL	SEALED CONCRETE	5/8" GWB TEXTURED PRIMED AND PAINTED	5/8" GWB TEXTURED PRIMED AND PAINTED	UNDERSIDE STRUCTURE
BREAK ROOM	OWNER OPTION CONCRETE OR VCT	5/8" GWB TEXTURED PRIMED AND PAINTED	ACOUSTICAL TILE DROP CEILING	9' - 0"
CONFERENCE ROOM	OWNER OPTION CONCRETE OR VCT	5/8" GWB TEXTURED PRIMED AND PAINTED	ACOUSTICAL TILE DROP CEILING	9' - 0"
STORAGE ROOM	OWNER OPTION CONCRETE OR VCT	5/8" GWB TEXTURED PRIMED AND PAINTED	5/8" GWB TEXTURED PRIMED AND PAINTED	UNDERSIDE STRUCTURE
SHOWROOM	OWNER OPTION CONCRETE OR VCT	5/8" GWB TEXTURED PRIMED AND PAINTED	5/8" GWB TEXTURED PRIMED AND PAINTED	UNDERSIDE STRUCTURE

NOTES:  
1) ACOUSTICAL TILE CEILING AND SUSPENDED LIGHTING FIXTURES SHALL BE INSTALLED PER MANUFACTURER STANDARD DETAILS FOR SEISMIC DESIGN CATEGORY C.

FRIESEN NUTRITION NEW BUILDING  
FRIESEN NUTRITION  
GREATFALLS, MONTANA

THIS DRAWING IS PROPERTY OF TETON DRAFTING SERVICES. IT IS TO BE USED ONLY FOR THE PROJECT AND SITE SPECIFICALLY INDICATED WITHIN THE DRAWING. NO PART OF THIS DRAWING IS TO BE REPRODUCED OR TRANSMITTED IN ANY FORM OR BY ANY MEANS, ELECTRONIC OR MECHANICAL, INCLUDING PHOTOCOPYING, RECORDING, OR BY ANY INFORMATION STORAGE AND RETRIEVAL SYSTEM, WITHOUT THE EXPRESS WRITTEN CONSENT OF TETON DRAFTING SERVICES. TETON DRAFTING SERVICES ASSUMES NO LIABILITY BEYOND THE PRODUCTION OF THESE PRINTS. ALL DIMENSIONS AND NOTES ARE TO BE INTERPRETED AS SHOWN UNLESS OTHERWISE PROVIDED BY THE CUSTOMER AND HAVE BEEN ACCEPTED AS IS.

CHECKED BY	DATE	REVISIONS	BY
MDG	10/19/16		
EVB			


TETON DRAFTING SERVICES  
136 SOUTH STATE STREET SHELLEY, IDAHO 83274  
PHONE (208) 357-2420 FAX (208) 357-2419

PROJECT NO. 216059  
SHEET NO. **A1.0**  
OF SIXTEEN

Door Schedule					
Mark	Height	Width	Count	U/R FACTOR	Comments
101	8' - 0"	6' - 0"	1	0.320	
102	6' - 8"	3' - 0"	1	N/A	
103	6' - 8"	3' - 0"	1	N/A	
104	6' - 8"	3' - 0"	1	N/A	
105	6' - 8"	3' - 0"	1	N/A	
106	6' - 8"	3' - 0"	1	N/A	
107	6' - 8"	3' - 0"	1	N/A	
107a	6' - 8"	3' - 0"	1	N/A	
108	6' - 8"	3' - 0"	1	N/A	
109	6' - 8"	3' - 0"	1	N/A	
109a	6' - 8"	3' - 0"	1	N/A	
110	6' - 8"	3' - 0"	1	N/A	
111	6' - 6"	6' - 0"	1	N/A	
112	6' - 8"	3' - 0"	1	0.300	
113	12' - 0"	12' - 0"	1	0.390	
114	10' - 0"	9' - 0"	1	0.390	
115	12' - 0"	10' - 0"	1	N/A	
116	6' - 8"	3' - 0"	1	N/A	
117	6' - 8"	3' - 0"	1	N/A	
118	6' - 8"	3' - 0"	1	N/A	
119	6' - 8"	3' - 0"	1	N/A	
120a	6' - 8"	3' - 0"	1	0.320	
120b	6' - 8"	3' - 0"	1	0.320	
121	6' - 8"	3' - 0"	1	0.320	
122	6' - 8"	3' - 0"	1	N/A	
123	6' - 8"	3' - 0"	1	N/A	
124	6' - 8"	3' - 0"	1	N/A	
125	6' - 8"	3' - 0"	1	0.300	
126	6' - 8"	3' - 0"	1	0.300	

NOTE: ALL MAN DOORS, HARDWARE, AND FINISHES SHALL MEET ACCESSIBILITY REQUIREMENTS OF ICC A117.1.

Window Schedule					
Type Mark	Width	Height	Count	U/R	Comments
A	4' - 0"	4' - 0"	11	0.320	
B	4' - 0"	2' - 0"	3	0.320	

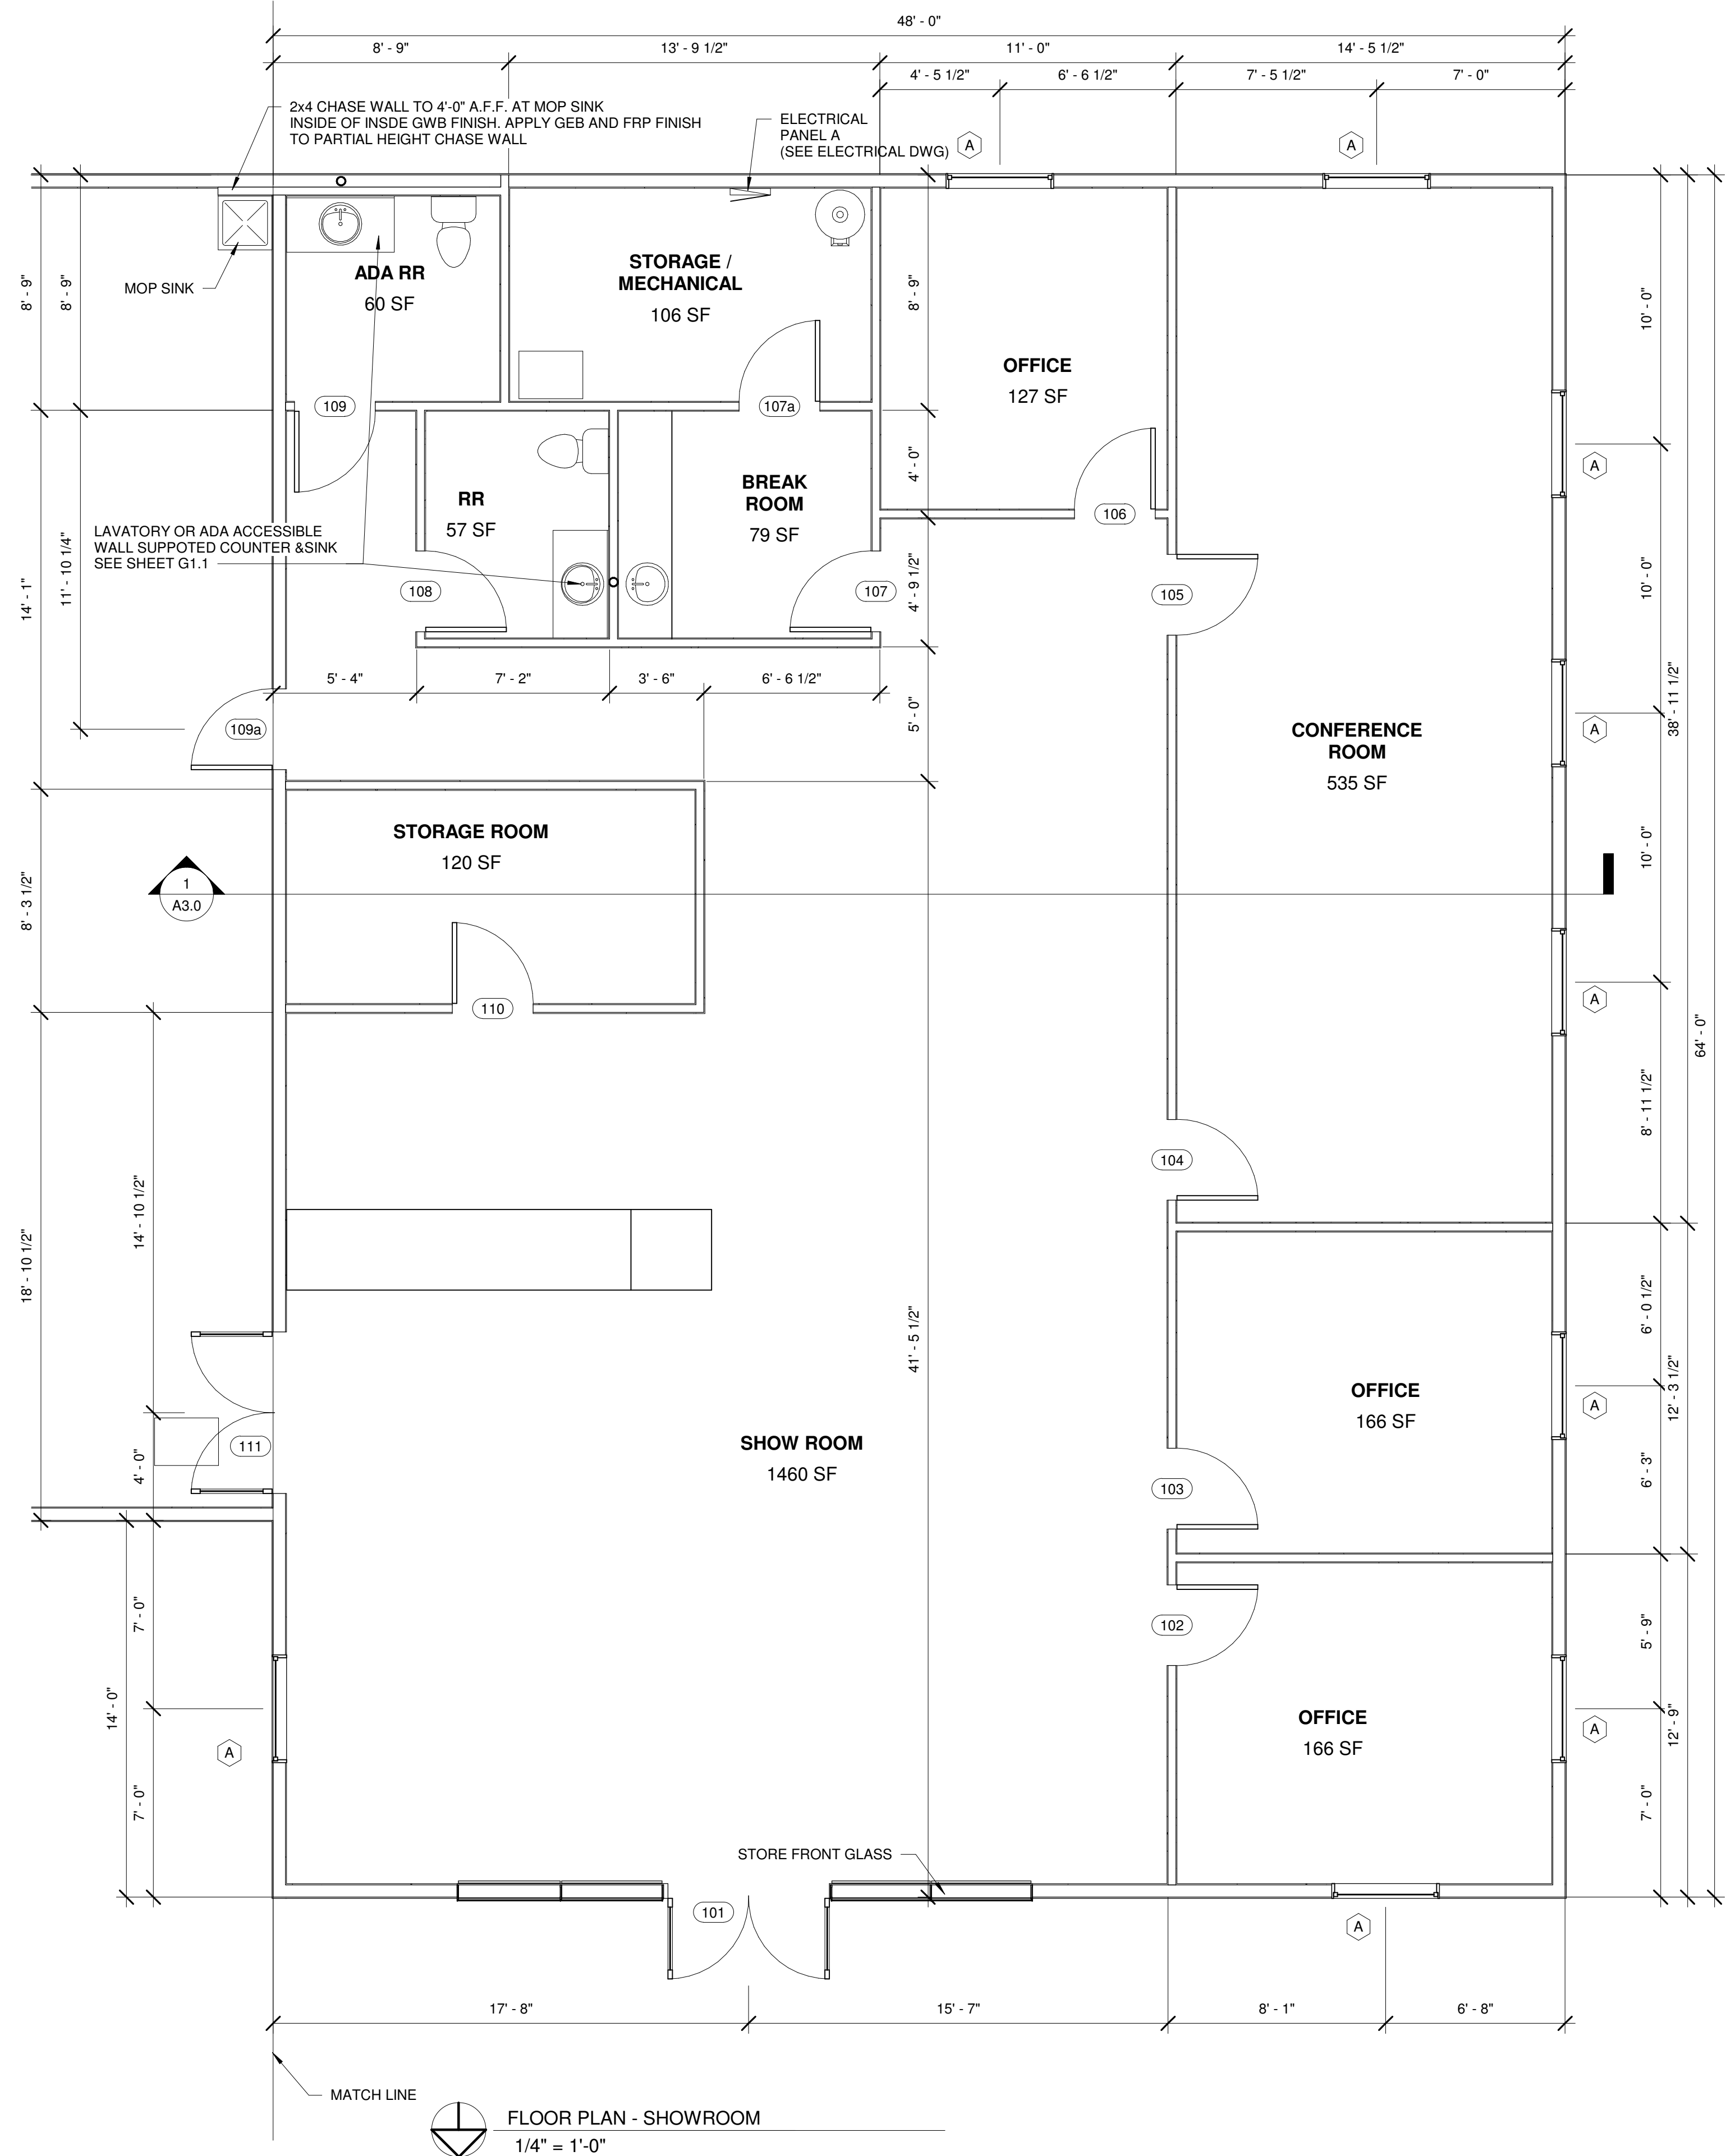

FRIESEN NUTRITION NEW BUILDING  
FRIESEN NUTRITION  
GREATFALLS, MONTANA

THIS DRAWING IS PROPERTY OF TETON DRAFTING SERVICES. IT IS TO BE USED ONLY FOR THE PROJECT AND SITE SPECIFICALLY INDICATED WITHIN THE EXPLICIT WRITTEN CONSENT OF TETON DRAFTING SERVICES. TETON DRAFTING SERVICES ASSUMES NO LIABILITY BEYOND THE PRODUCTION OF THESE PRINTS. ALL INFORMATION AND SERVICES ARE PROVIDED AS IS. ACCEPTED AS IS.

CHECKED BY	DATE	REVISIONS	BY
MDG	10/19/16		
EVB			
DATE	12/22/16	ISSUED FOR REV	EVB


TETON DRAFTING SERVICES  
136 SOUTH STATE STREET SHELLEY, IDAHO 83274  
PHONE (208) 357-2420 FAX (208) 357-2419

PROJECT NO. 216059  
SHEET NO. A1.1  
OF SIXTEEN

FLOOR PLAN - SHOWROOM  
1/4" = 1'-0"

Window Schedule					
Type Mark	Width	Height	Count	U/R	Comments
A	4' - 0"	4' - 0"	11	0.320	
B	4' - 0"	2' - 0"	3	0.320	

Door Schedule					
Mark	Height	Width	Count	U/R FACTOR	Comments
101	8' - 0"	6' - 0"	1	0.320	
102	6' - 8"	3' - 0"	1	N/A	
103	6' - 8"	3' - 0"	1	N/A	
104	6' - 8"	3' - 0"	1	N/A	
105	6' - 8"	3' - 0"	1	N/A	
106	6' - 8"	3' - 0"	1	N/A	
107	6' - 8"	3' - 0"	1	N/A	
107a	6' - 8"	3' - 0"	1	N/A	
108	6' - 8"	3' - 0"	1	N/A	
109	6' - 8"	3' - 0"	1	N/A	
109a	6' - 8"	3' - 0"	1	N/A	
110	6' - 8"	3' - 0"	1	N/A	
111	6' - 6"	6' - 0"	1	N/A	
112	6' - 8"	3' - 0"	1	0.300	
113	12' - 0"	12' - 0"	1	0.390	
114	10' - 0"	9' - 0"	1	0.390	
115	12' - 0"	10' - 0"	1	N/A	
116	6' - 8"	3' - 0"	1	N/A	
117	6' - 8"	3' - 0"	1	N/A	
118	6' - 8"	3' - 0"	1	N/A	
119	6' - 8"	3' - 0"	1	N/A	
120a	6' - 8"	3' - 0"	1	0.320	
120b	6' - 8"	3' - 0"	1	0.320	
121	6' - 8"	3' - 0"	1	0.320	
122	6' - 8"	3' - 0"	1	N/A	
123	6' - 8"	3' - 0"	1	N/A	
124	6' - 8"	3' - 0"	1	N/A	
125	6' - 8"	3' - 0"	1	0.300	
126	6' - 8"	3' - 0"	1	0.300	

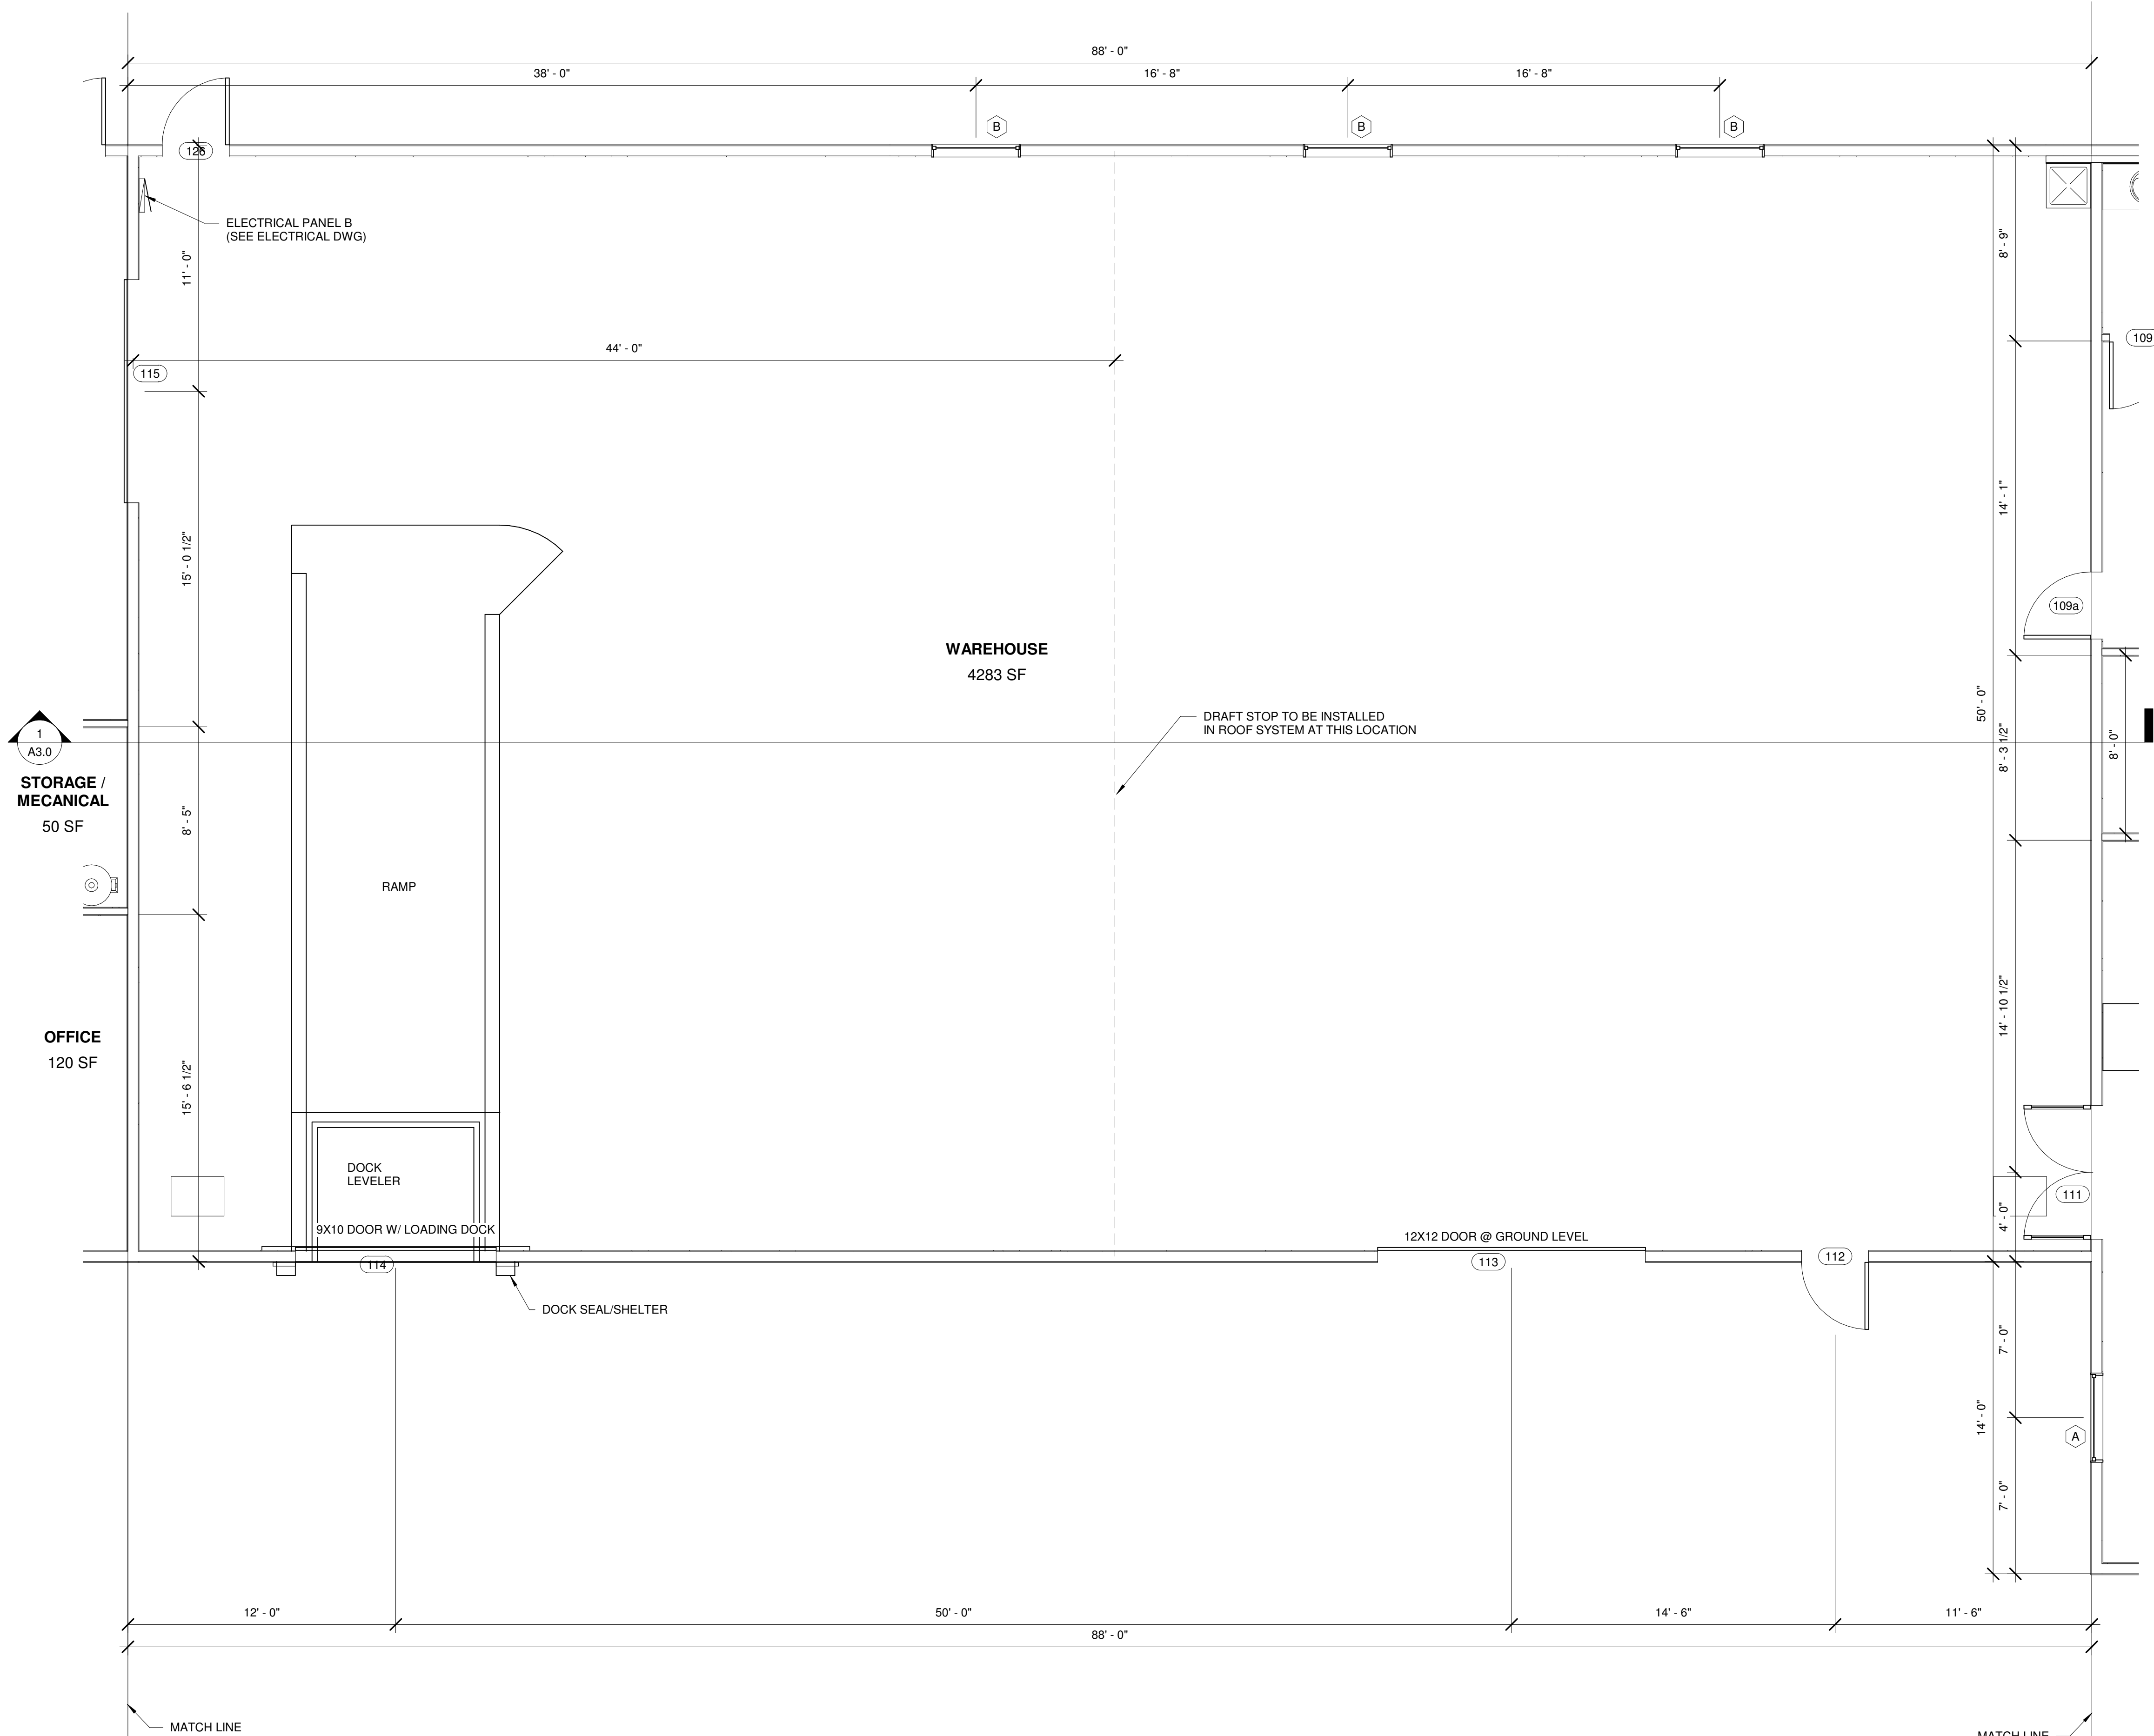

FLOOR PLAN - WAREHOUSE  
1/4" = 1'-0"

FRIESEN NUTRITION NEW BUILDING  
FRIESEN NUTRITION  
GREATFALLS, MONTANA

THIS DRAWING IS PROPERTY OF TETON DRAFTING SERVICES. IT IS TO BE USED ONLY FOR THE PROJECT AND SITE SPECIFICALLY INDICATED WITHIN THE EXPLICIT WRITTEN CONSENT OF TETON DRAFTING SERVICES. NO LIABILITY IS ASSUMED BEYOND THE PRODUCTION OF THESE PRINTS. ALL INFORMATION IS PROVIDED AS IS. THE CUSTOMER HAS ACCEPTED AS IS.


CHECKED BY	DATE	REVISIONS	BY
MDG	10/19/16		
EVB			
	12/22/16	ISSUED FOR REV	EVB

TETON DRAFTING SERVICES  
136 SOUTH STATE STREET SHELLEY, IDAHO 83274  
PHONE (208) 357-2420 FAX (208) 357-2419

PROJECT NO. 216059  
SHEET NO. A1.2  
OF SIXTEEN




FIRST FLOOR  
T.O.W.  
116'-0"  
TOP OF WALL  
112'-0"  
FLOOR PLAN  
100'-0"

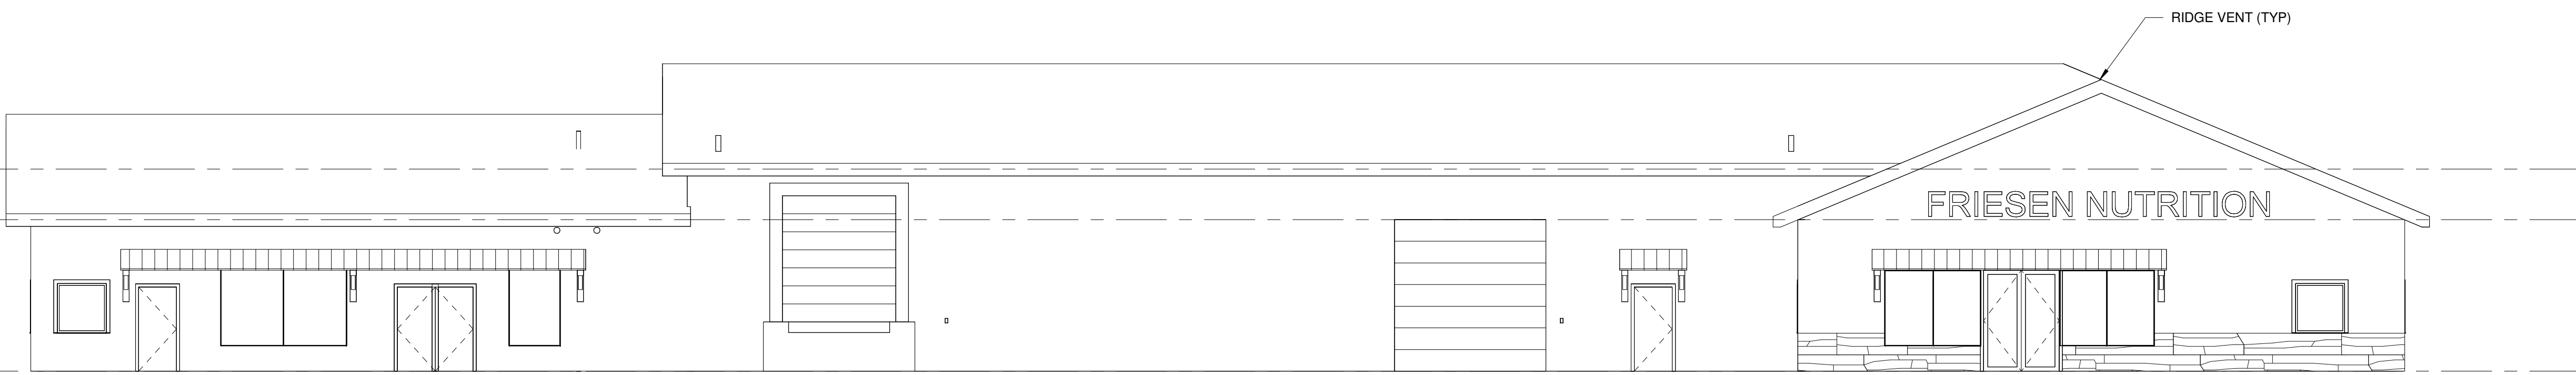


Front Elevation  
1/8" = 1'-0"

FIRST FLOOR  
T.O.W.  
116'-0"  
TOP OF WALL  
112'-0"  
FLOOR PLAN  
100'-0"

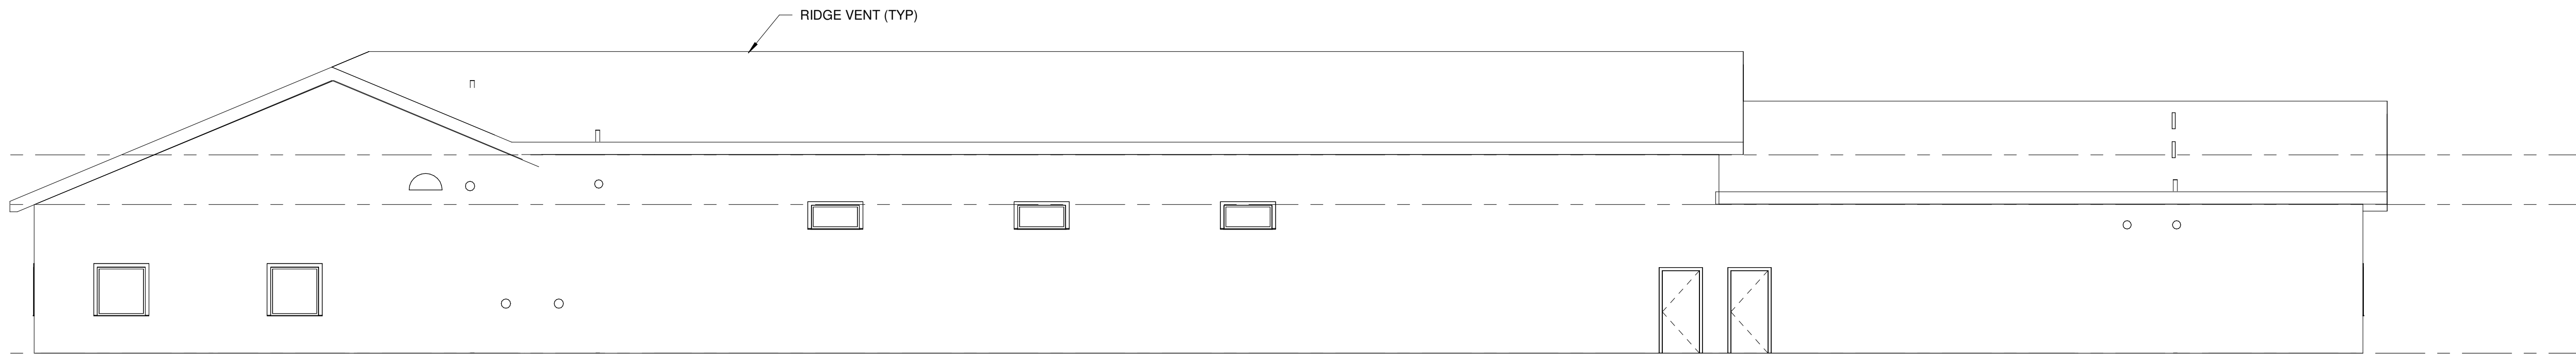


Rear Elevation  
1/8" = 1'-0"

FIRST FLOOR  
T.O.W.  
116'-0"  
TOP OF WALL  
112'-0"  
FLOOR PLAN  
100'-0"

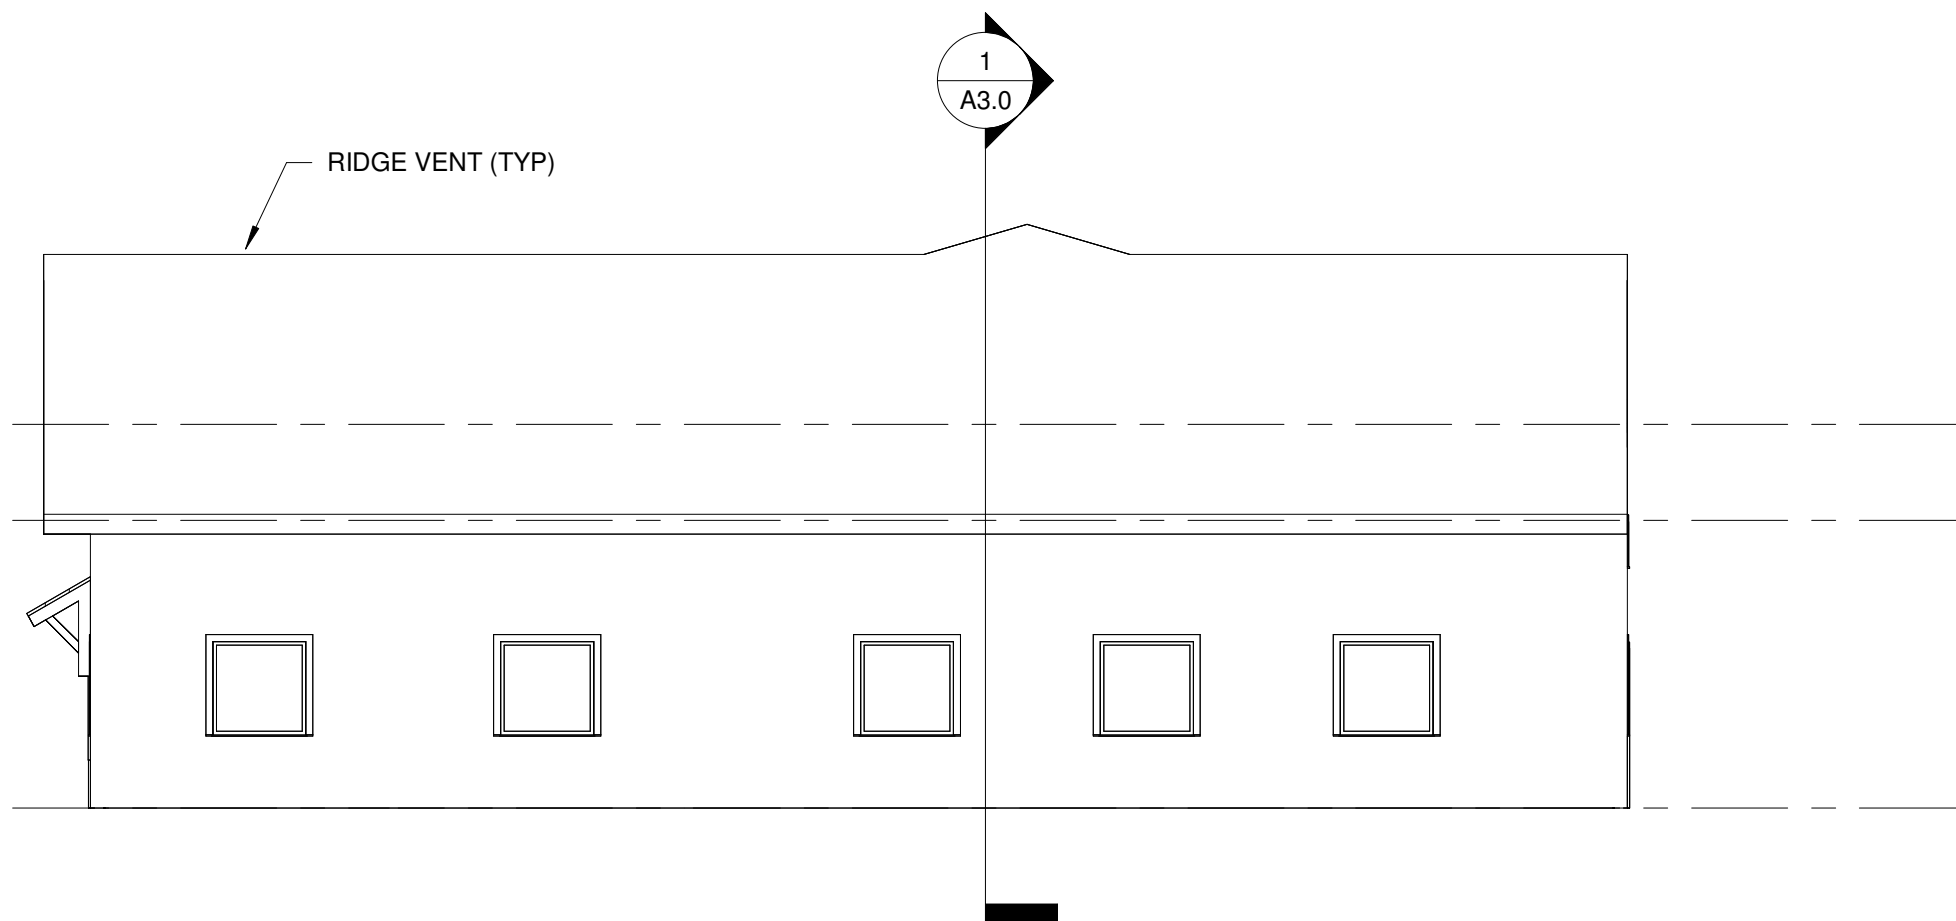

Left Elevation  
1/8" = 1'-0"

FIRST FLOOR  
T.O.W.  
116'-0"  
TOP OF WALL  
112'-0"  
FLOOR PLAN  
100'-0"

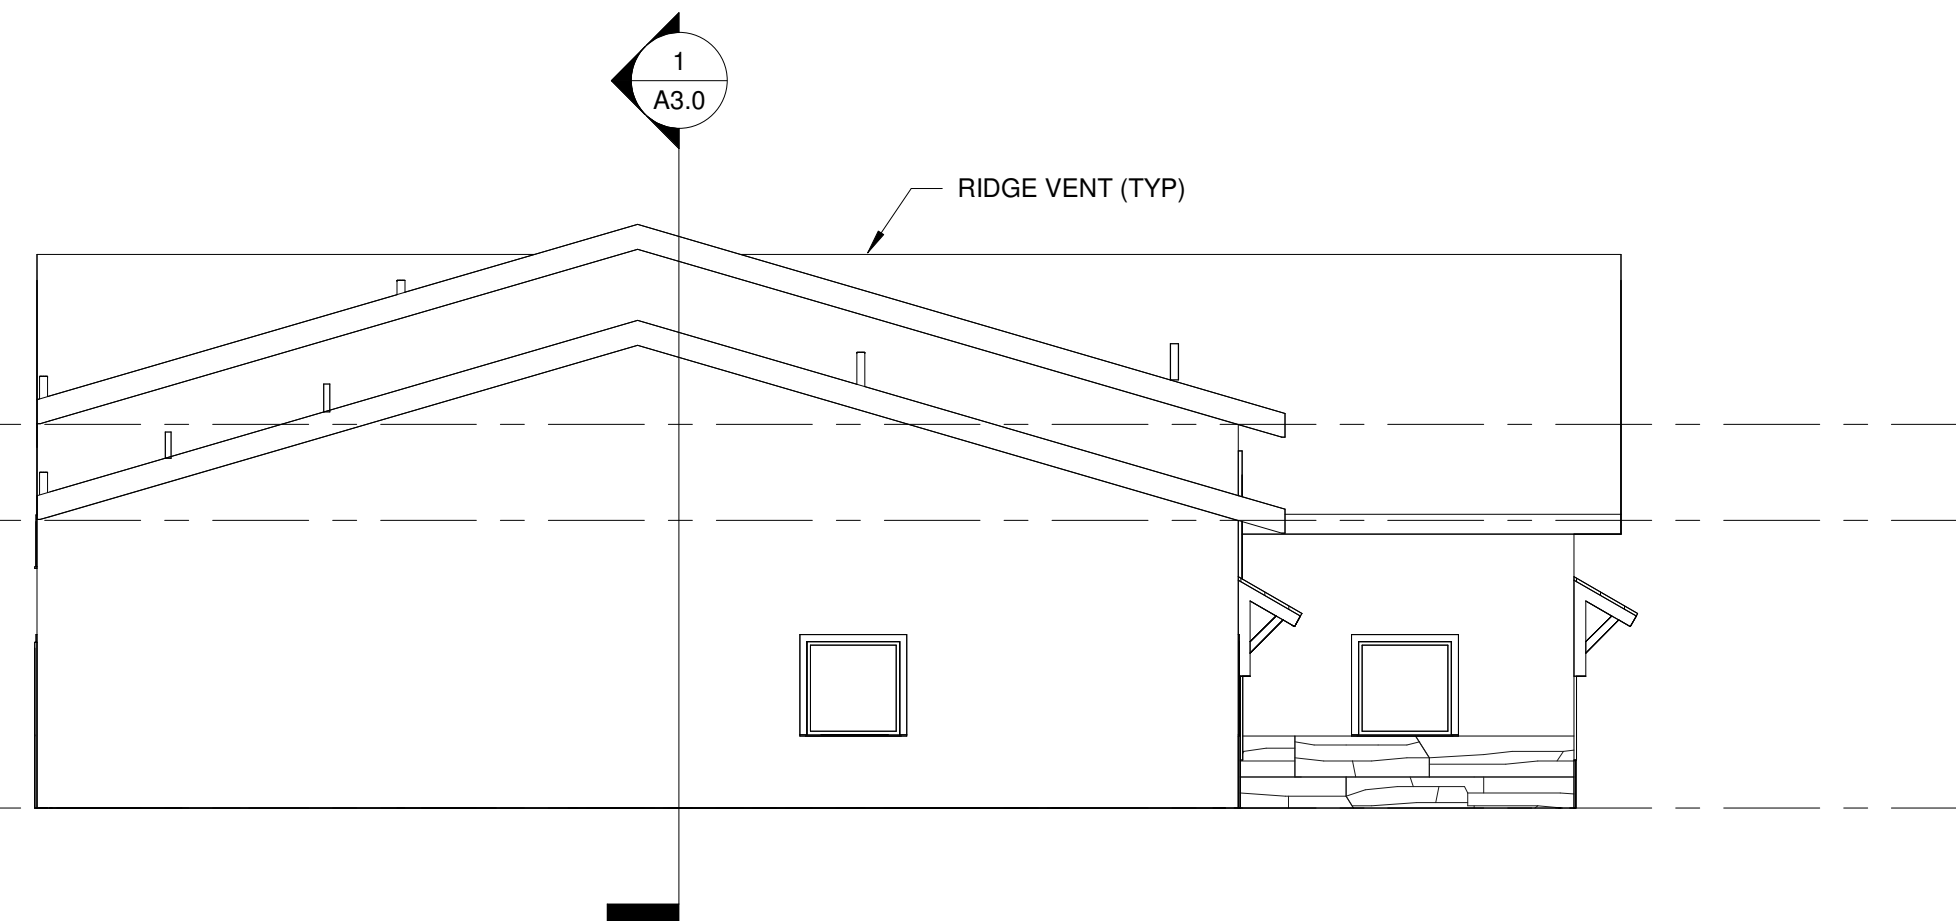

Right Elevation  
1/8" = 1'-0"


FRIESEN NUTRITION NEW BUILDING  
FRIESEN NUTRITION  
GREATFALLS, MONTANA

THIS DRAWING IS PROPERTY OF TETON DRAFTING SERVICES. IT IS TO BE USED ONLY FOR THE PROJECT AND SITE INDICATED WITHOUT THE EXPRESS WRITTEN CONSENT OF TETON DRAFTING SERVICES. NO LIABILITY IS ASSUMED FOR ANY ERRORS OR OMISSIONS. THIS DRAWING HAS BEEN REVIEWED AND APPROVED BY THE CUSTOMER AND HAS BEEN ACCEPTED AS IS.

CHECKED BY	DATE	REVISIONS	BY
MDG	10/19/16		EVB
EVB		ISSUED FOR REV	EVB

TETON DRAFTING SERVICES  
136 SOUTH STATE STREET SHELLEY, IDAHO 83274  
PHONE (208)-357-2420 FAX (208)-357-2419

PROJECT NO.  
216059  
SHEET NO.  
**A2.0**  
OF SIXTEEN

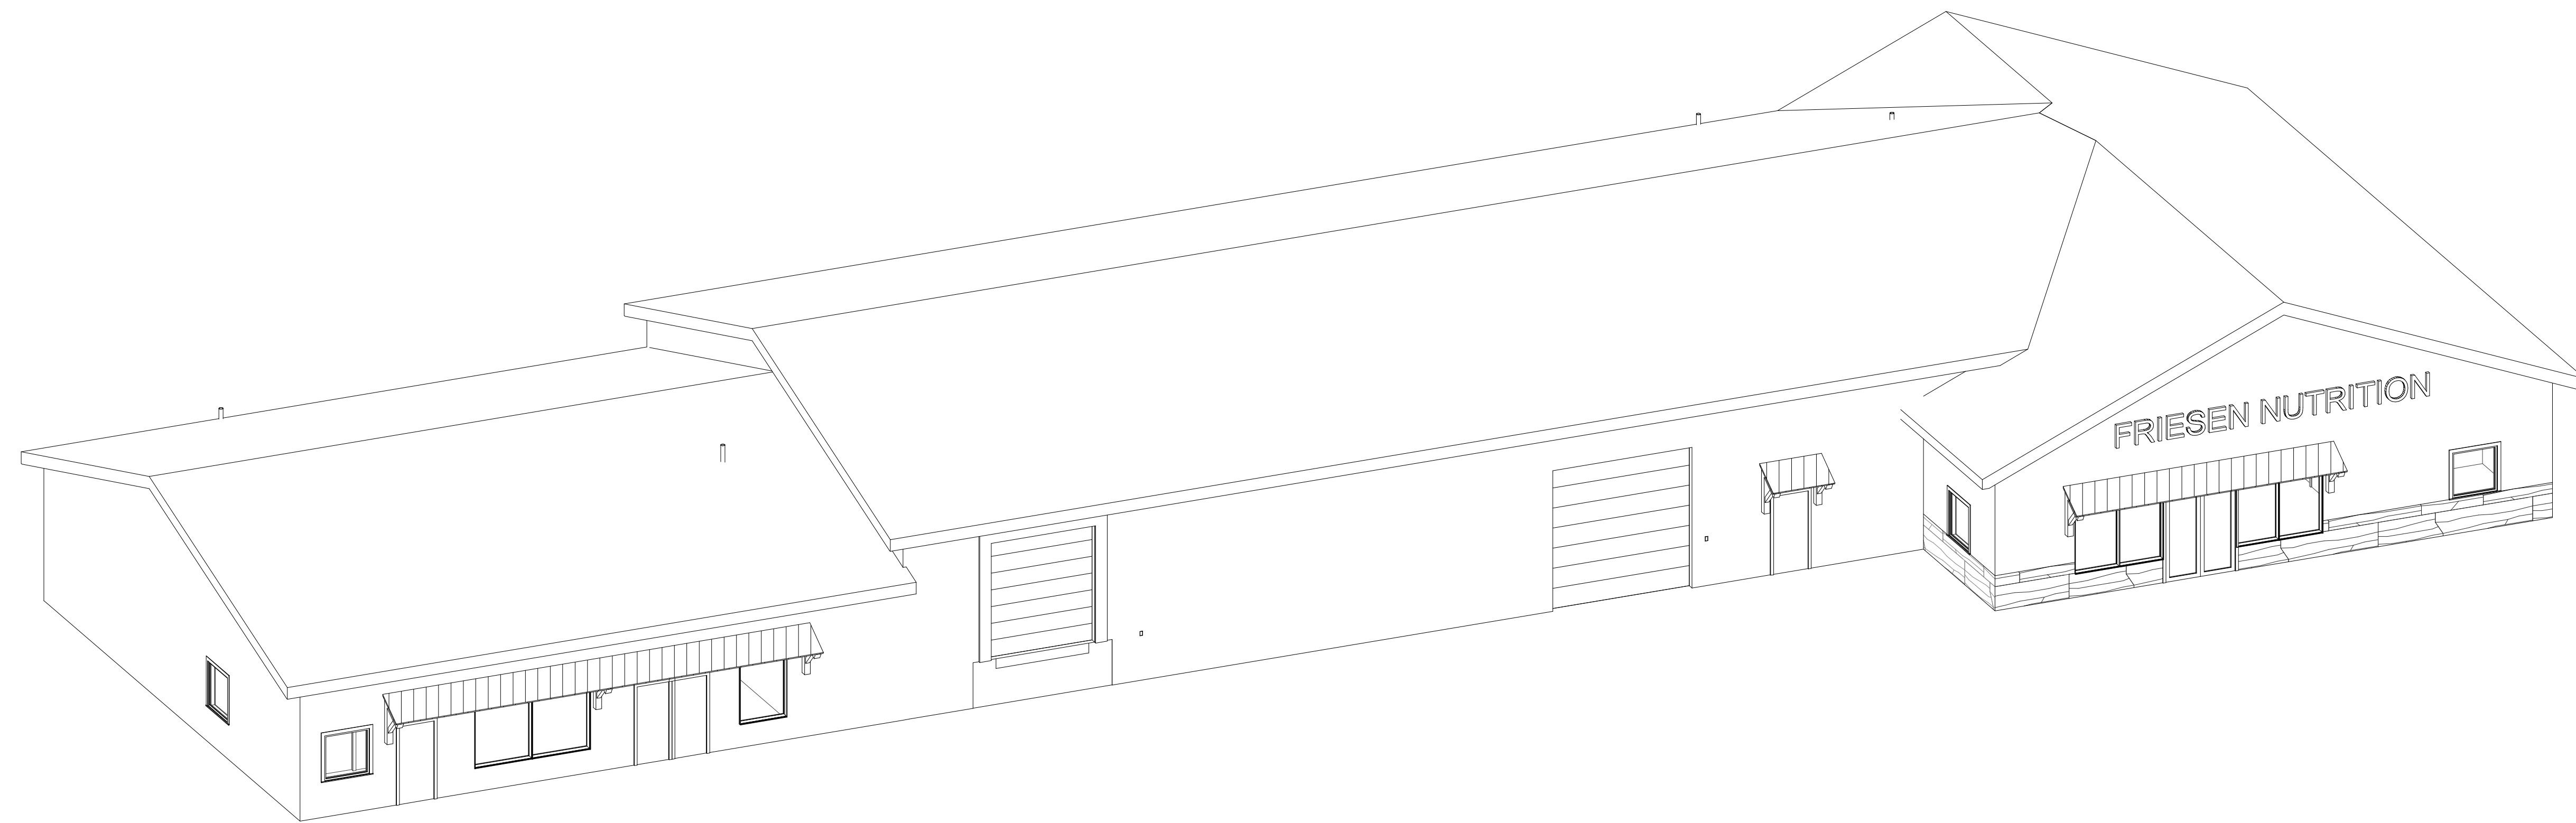

FRIESEN NUTRITION NEW BUILDING  
 FRIESEN NUTRITION  
 GREAT FALLS, MONTANA

THIS DRAWING IS PROPERTY OF TETON DRAFTING SERVICES. IT IS TO BE USED ONLY FOR THE PROJECT AND SITE INDICATED WITHIN THE EXPLICIT WRITTEN CONSENT OF TETON DRAFTING SERVICES. NO LIABILITY IS ASSUMED FOR ANY REVISIONS OR CHANGES MADE TO THIS DRAWING AFTER IT HAS BEEN PROVIDED BY THE CUSTOMER AND HAS BEEN ACCEPTED AS IS.

CHECKED BY: MDG	DATE:
DRAWN BY: EVB	10/19/16
DATE	REVISIONS
12/22/16	ISSUED FOR REV
	BY
	EVB


TETON DRAFTING SERVICES  
 136 SOUTH STATE STREET SHELLEY, IDAHO 83274  
 PHONE (208) 357-2420 FAX (208) 357-2419

PROJECT NO.  
 216059  
 SHEET NO.  
**A3.0**  
 OF SIXTEEN

FIRST FLOOR  
 T.O.W.  
 116' - 0"

TOP OF WALL  
 112' - 0"

FLOOR PLAN  
 100' - 0"

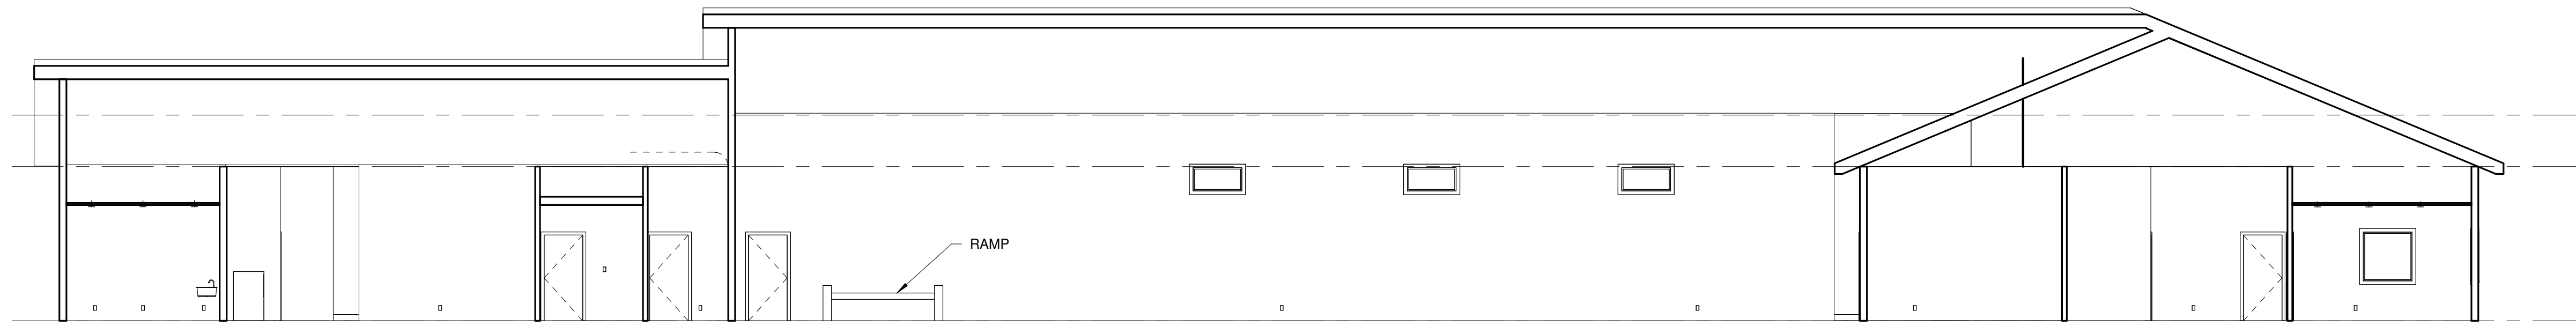


1 SECTION  
 A3.0 DO NOT SCALE

**SALES FLOOR**


 
 

 
 

 
 
 
 

 

**WAREHOUSE**


**SHOWROOM**

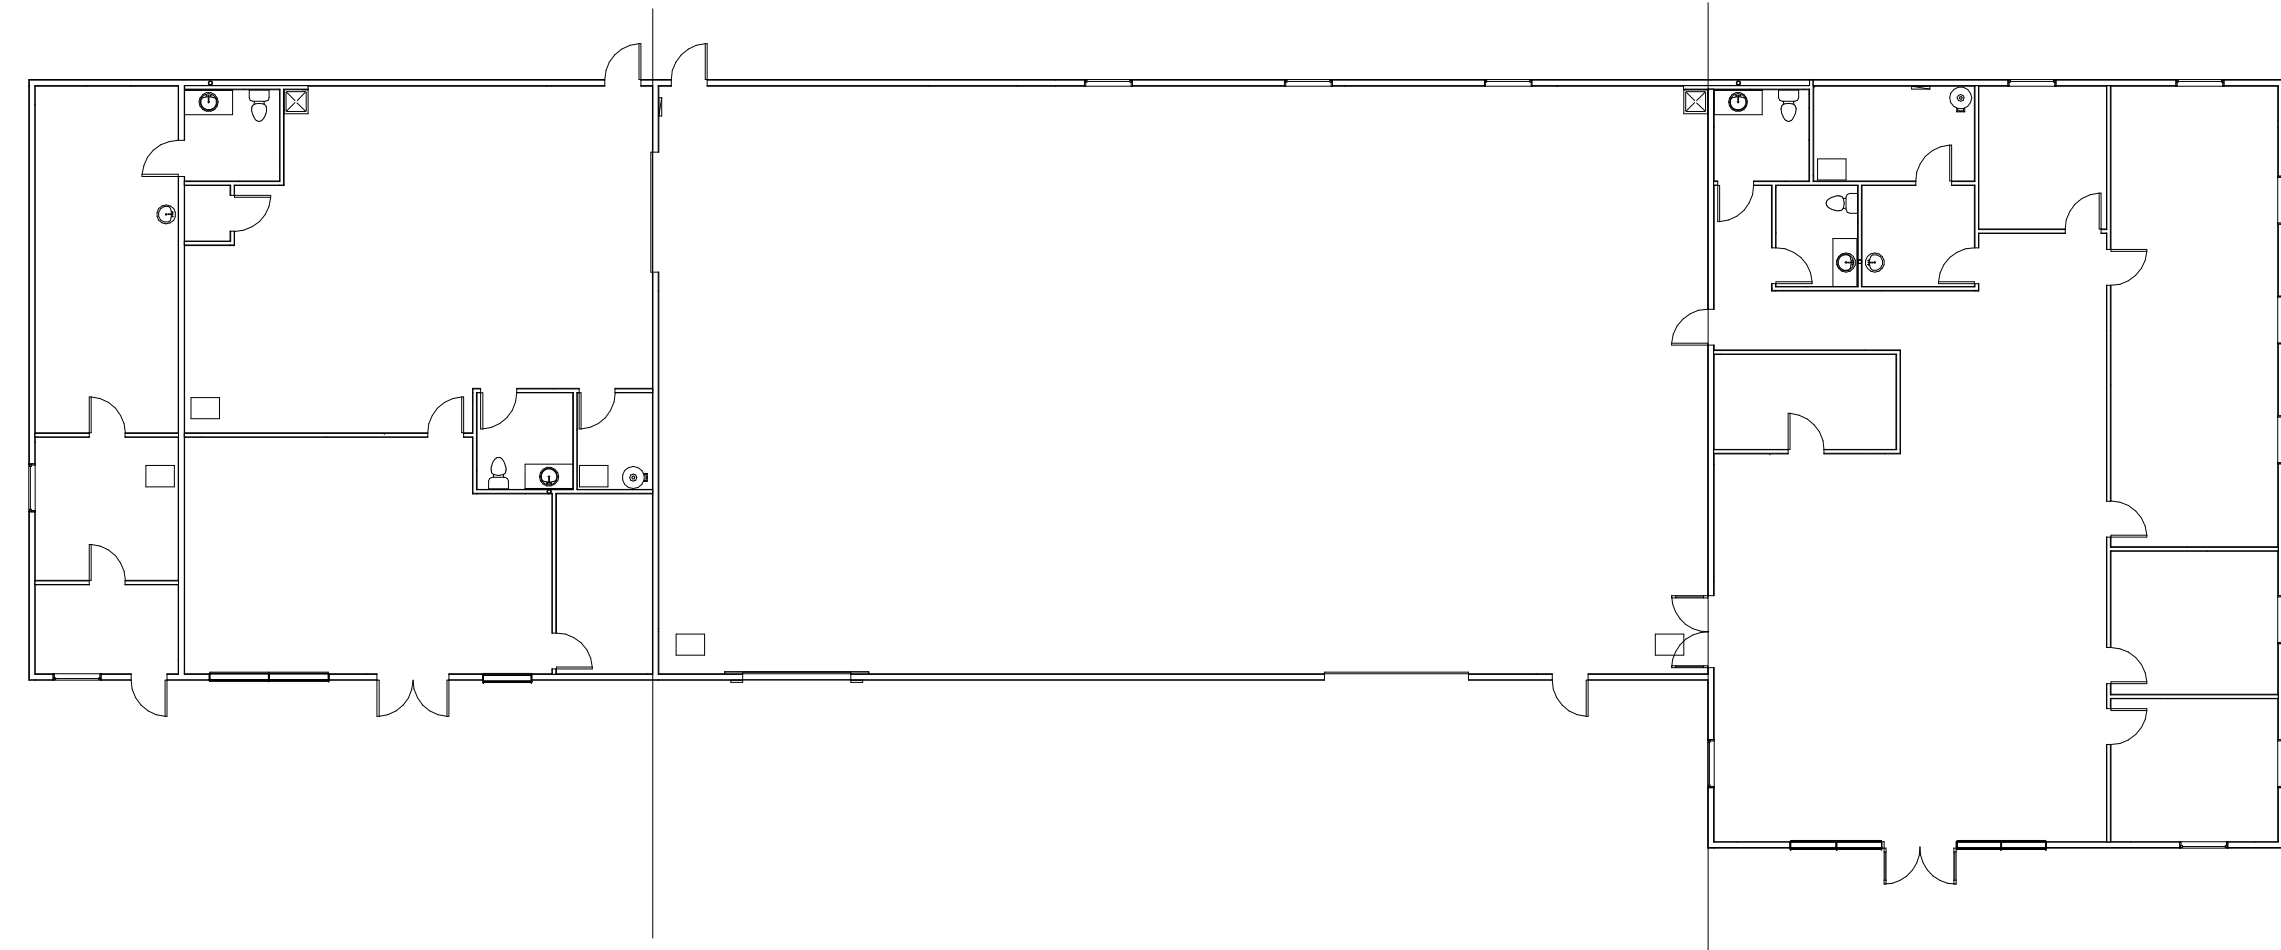

ELECTRICAL KEY PLAN  
1/16" = 1'-0"

**ELECTRICAL LEGEND**

-  OCCUPANCY SENSOR
-  EXHAUST FAN FQ-80
-  EMERGENCY BACK UP LIGHT
-  CAN LIGHT
-  EMERGENCY LIGHT
-  EXTERIOR LIGHT
-  JUNCTION BOX
-  FLOOR OUTLET
-  DUPLEX OUTLET
-  GFI OUTLET
-  SINGLE SWITCH
-  THREE WAY SWITCH
-  T-8 LIGHT
-  T-5 LIGHT

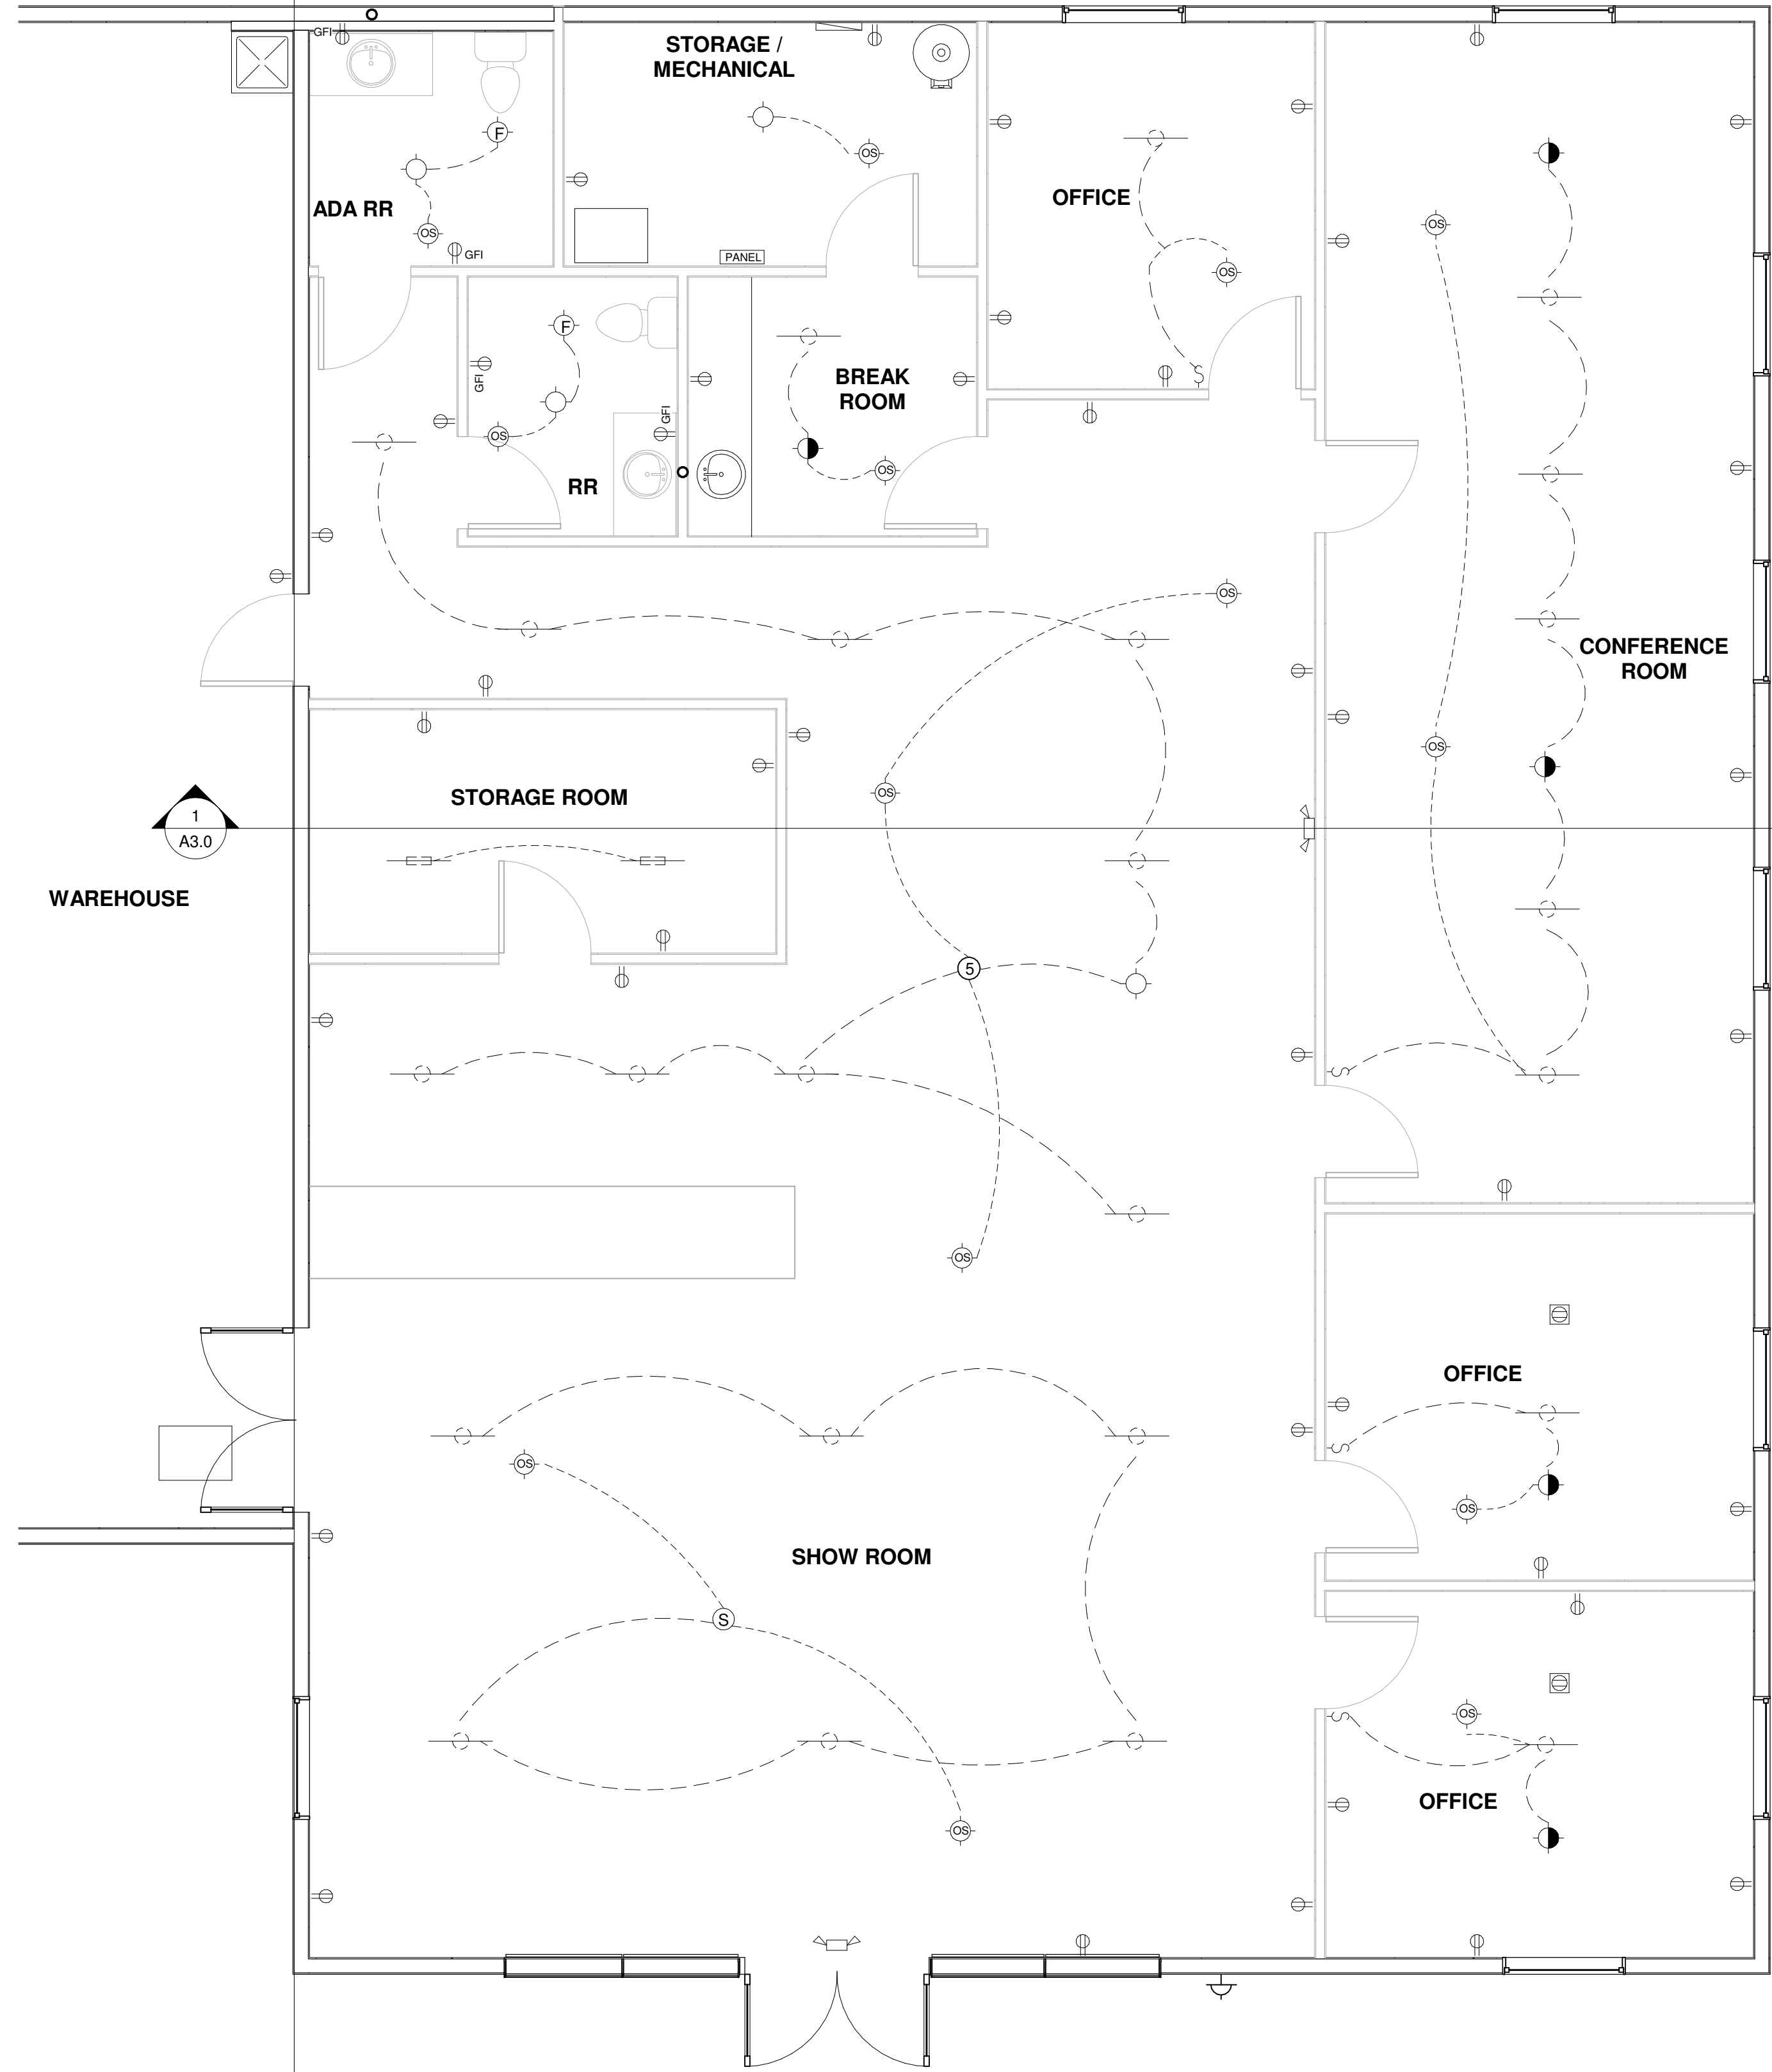

1  
A3.0  
WAREHOUSE

ELECTRICAL - SHOWROOM  
1/4" = 1'-0"

FRIESEN NUTRITION NEW BUILDING  
FRIESEN NUTRITION  
GREATFALLS, MONTANA








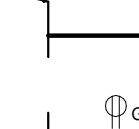
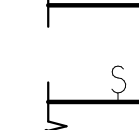
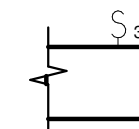
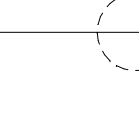



THIS DRAWING IS PROPERTY OF TETON DRAFTING SERVICES. IT IS TO BE USED ONLY FOR THE PROJECT AND SITE SPECIFICALLY INDICATED WITHIN THE EXPLICIT WRITTEN CONSENT OF TETON DRAFTING SERVICES. NO LIABILITY IS ASSUMED BEYOND THE PRODUCTION OF THESE PRINTS. ALL RIGHTS ARE RESERVED AND WILL BE ENFORCED AS PROVIDED BY THE CUSTOMER AND HAVE BEEN ACCEPTED AS IS.


CHECKED BY: MDG	DATE:
DRAWN BY: EVB	10/19/16
DATE	REVISIONS
	BY

TETON  
DRAFTING SERVICES  
136 SOUTH STATE STREET SHELLEY, IDAHO 83274  
PHONE (208)-357-2420 FAX (208)-357-2419

PROJECT NO.  
216059  
SHEET NO.  
**A4.0**  
OF SIXTEEN

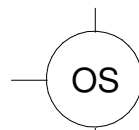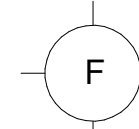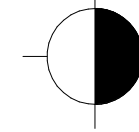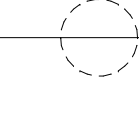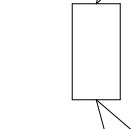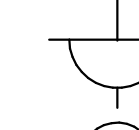ELECTRICAL LEGEND

-  OCCUPANCY SENSOR
-  EXHAUST FAN FQ-80
-  EMERGENCY BACK UP LIGHT
-  CAN LIGHT
-  EMERGENCY LIGHT
-  EXTERIOR LIGHT
-  JUNCTION BOX
-  FLOOR OUTLET
-  DUPLEX OUTLET
-  GFI OUTLET
-  SINGLE SWITCH
-  THREE WAY SWITCH
-  T-8 LIGHT
-  T-5 LIGHT

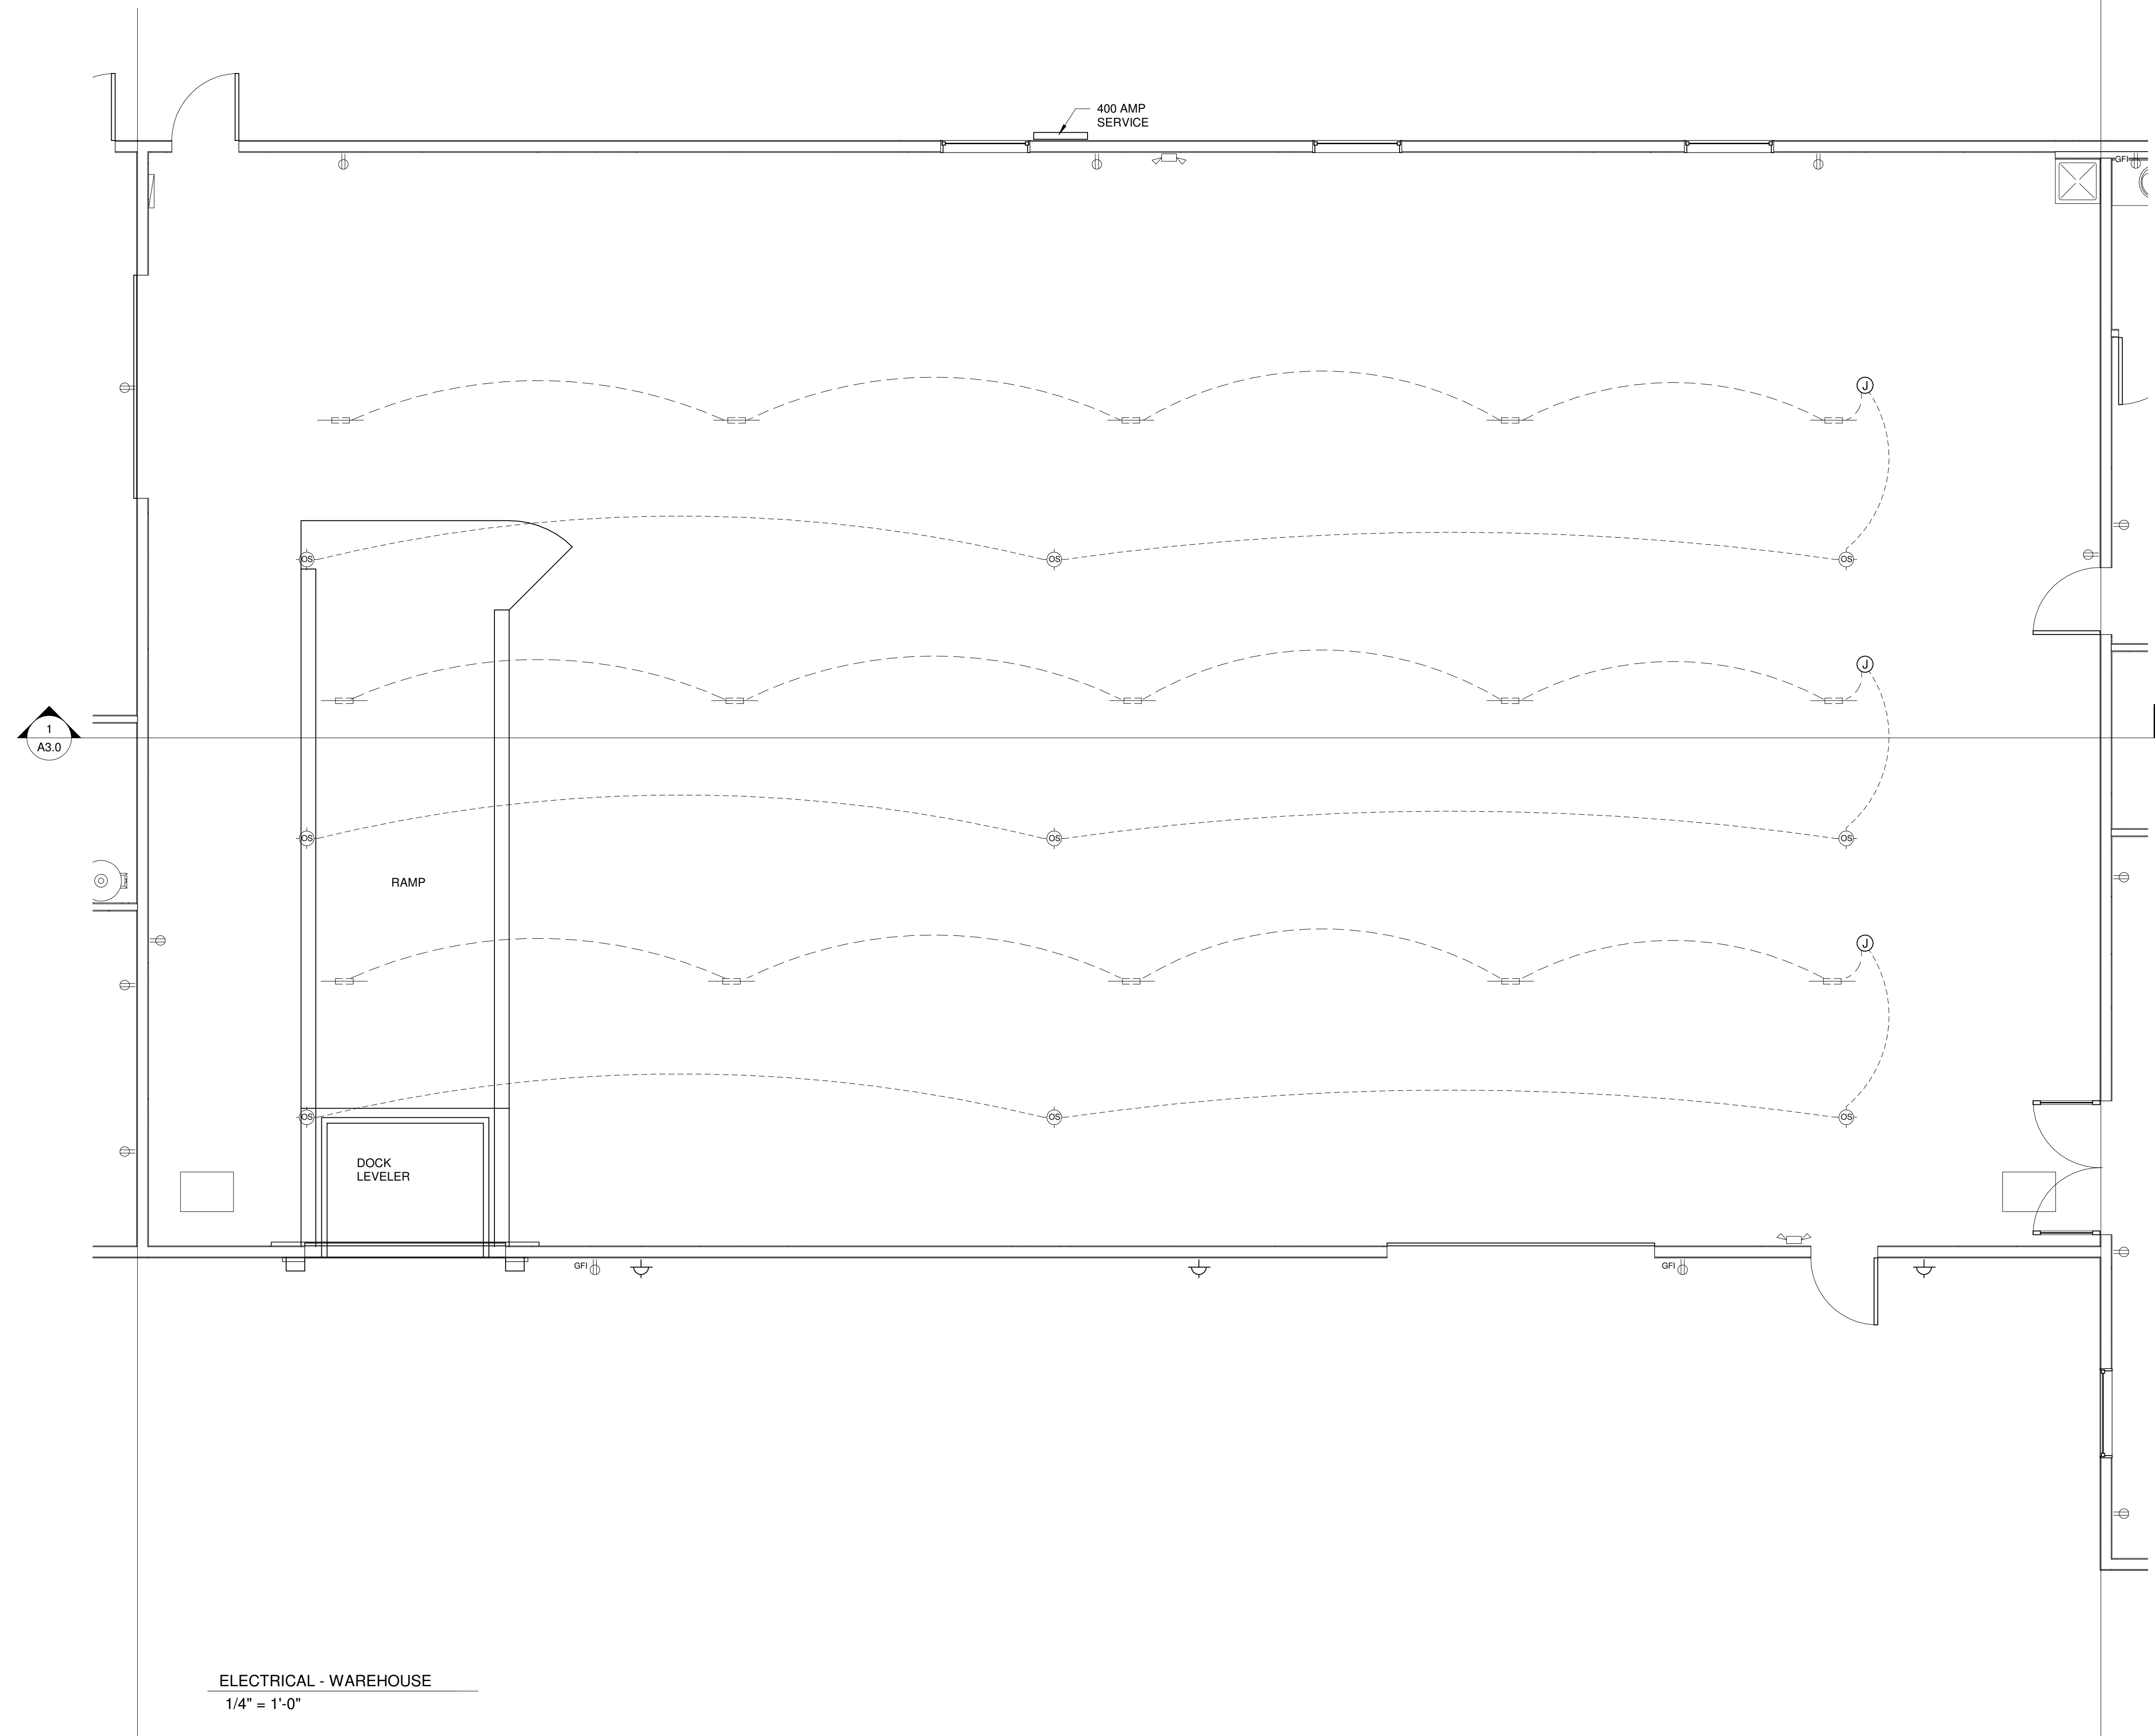

ELECTRICAL - WAREHOUSE  
1/4" = 1'-0"

FRIESEN NUTRITION NEW BUILDING  
FRIESEN NUTRITION  
GREATFALLS, MONTANA

THIS DRAWING IS PROPERTY OF TETON DRAFTING SERVICES. IT IS TO BE USED ONLY FOR THE PROJECT AND SITE INDICATED WITHOUT THE EXPRESS WRITTEN CONSENT OF TETON DRAFTING SERVICES. NO LIABILITY IS ASSUMED FOR ANY REVISIONS OR ASSEMBLY PROVIDED BY THE CUSTOMER AND HAVE BEEN ACCEPTED AS IS.















CHECKED BY: MDG	DATE:
DRAWN BY: EVB	10/19/16
DATE	REVISIONS
	BY


TETON  
DRAFTING SERVICES  
136 SOUTH STATE STREET SHELLEY, IDAHO 83274  
PHONE (208)-357-2420 FAX (208)-357-2419

PROJECT NO.  
216059  
SHEET NO.  
**A4.1**  
OF SIXTEEN

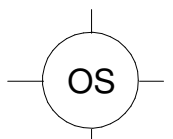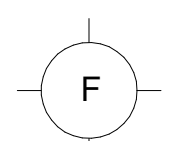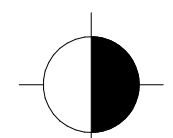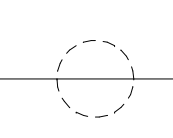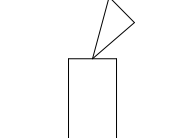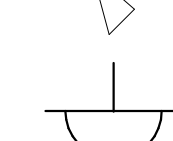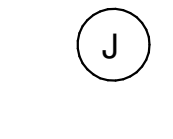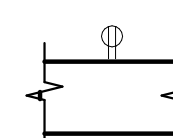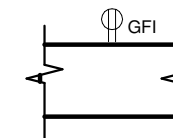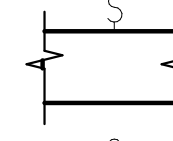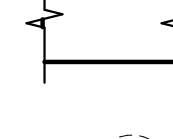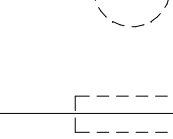

ELECTRICAL LEGEND

-  OCCUPANCY SENSOR
-  EXHAUST FAN FQ-80
-  EMERGENCY BACK UP LIGHT
-  CAN LIGHT
-  EMERGENCY LIGHT
-  EXTERIOR LIGHT
-  JUNCTION BOX
-  FLOOR OUTLET
-  DUPLEX OUTLET
-  GFI OUTLET
-  SINGLE SWITCH
-  THREE WAY SWITCH
-  T-8 LIGHT
-  T-5 LIGHT

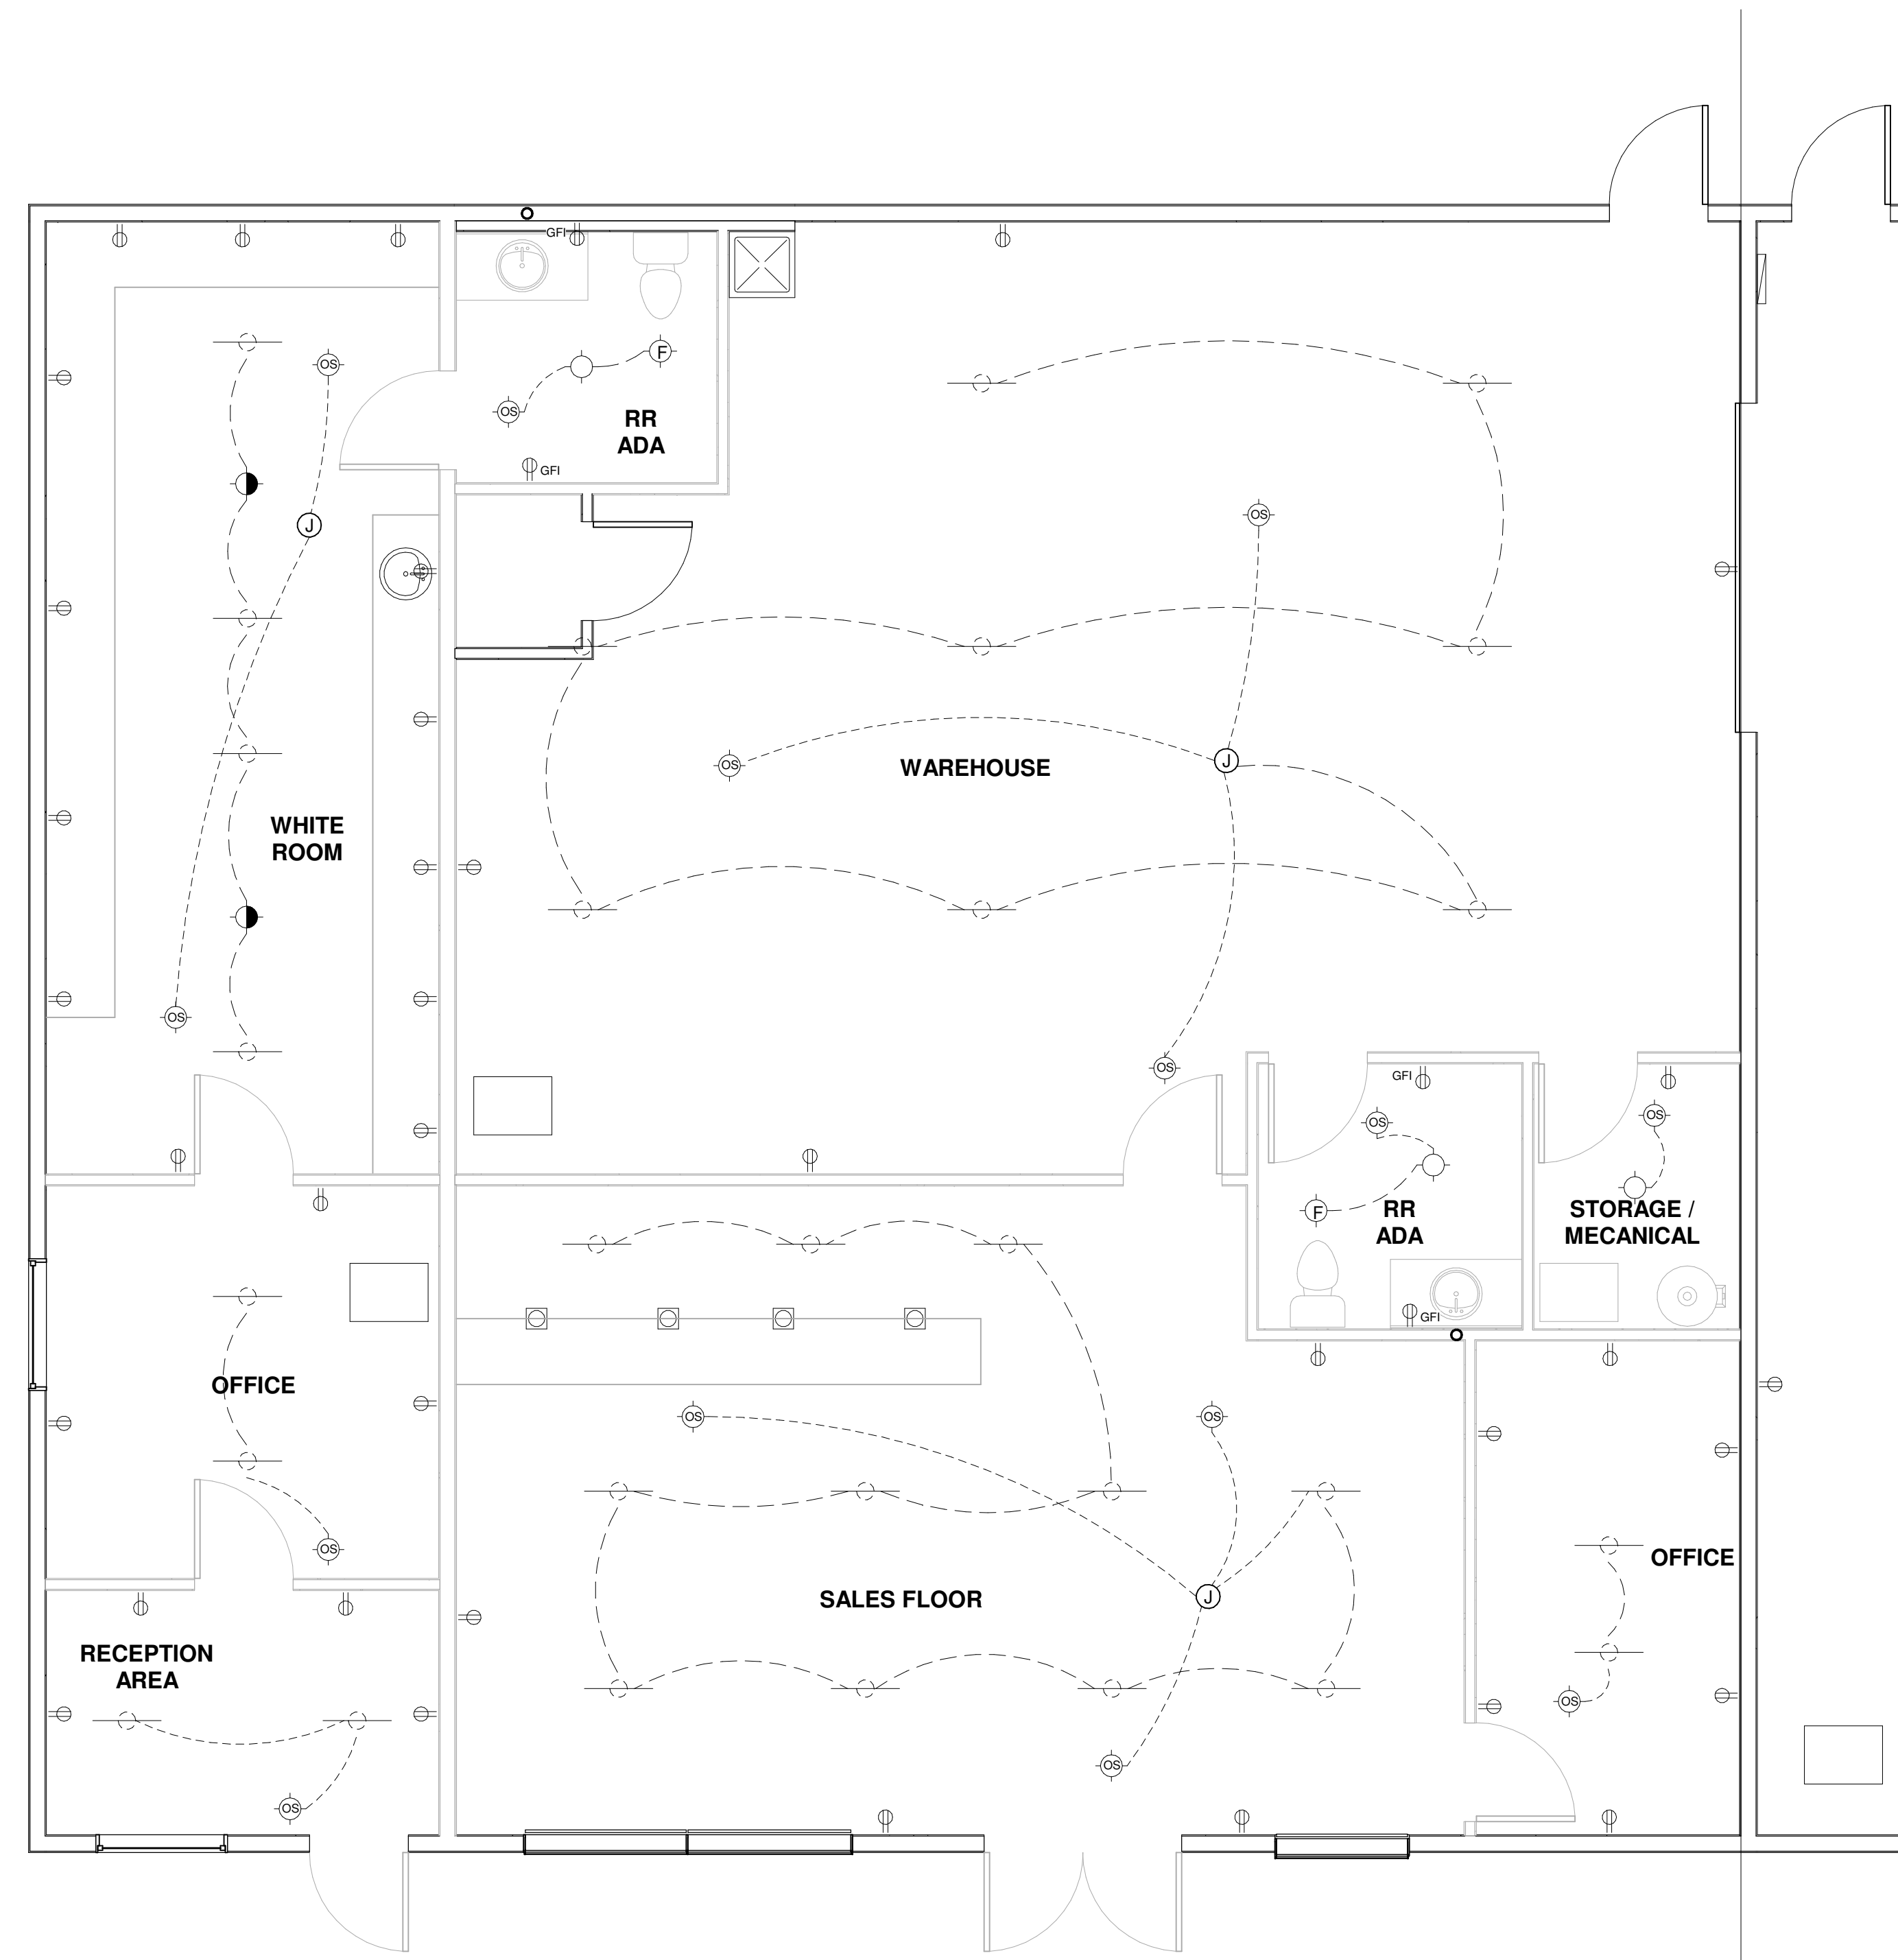

ELECTRICAL - SALES FLOOR  
1/4" = 1'-0"

**FRIESEN NUTRITION NEW BUILDING**  
FRIESEN NUTRITION  
GREATFALLS, MONTANA


THIS DRAWING IS PROPERTY OF TETON DRAFTING SERVICES. IT IS TO BE USED ONLY FOR THE PROJECT AND SITE SPECIFICALLY INDICATED WITHIN THIS DRAWING. NO PART OF THIS DRAWING IS TO BE REPRODUCED OR TRANSMITTED IN ANY FORM OR BY ANY MEANS, ELECTRONIC OR MECHANICAL, INCLUDING PHOTOCOPYING, RECORDING, OR BY ANY INFORMATION STORAGE AND RETRIEVAL SYSTEM, WITHOUT THE EXPRESS WRITTEN CONSENT OF TETON DRAFTING SERVICES. TETON DRAFTING SERVICES ASSUMES NO LIABILITY FOR ANY ERRORS OR OMISSIONS IN THIS DRAWING. THE USER ASSUMES ALL LIABILITY FOR ANY DAMAGE, INCLUDING PERSONAL INJURY OR DEATH, ARISING FROM THE USE OF THIS DRAWING. THIS DRAWING HAS BEEN REVIEWED AND ACCEPTED AS IS.

CHECKED BY: MDG	DATE:
	10/19/16
DRAWN BY: EVB	REVISIONS

**TETON**  
DRAFTING SERVICES

136 SOUTH STATE STREET SHELLEY, IDAHO 83274  
PHONE (208) 357-2420 FAX (208) 357-2419

PROJECT NO.  
216059  
SHEET NO.  
**A4.2**  
OF SIXTEEN

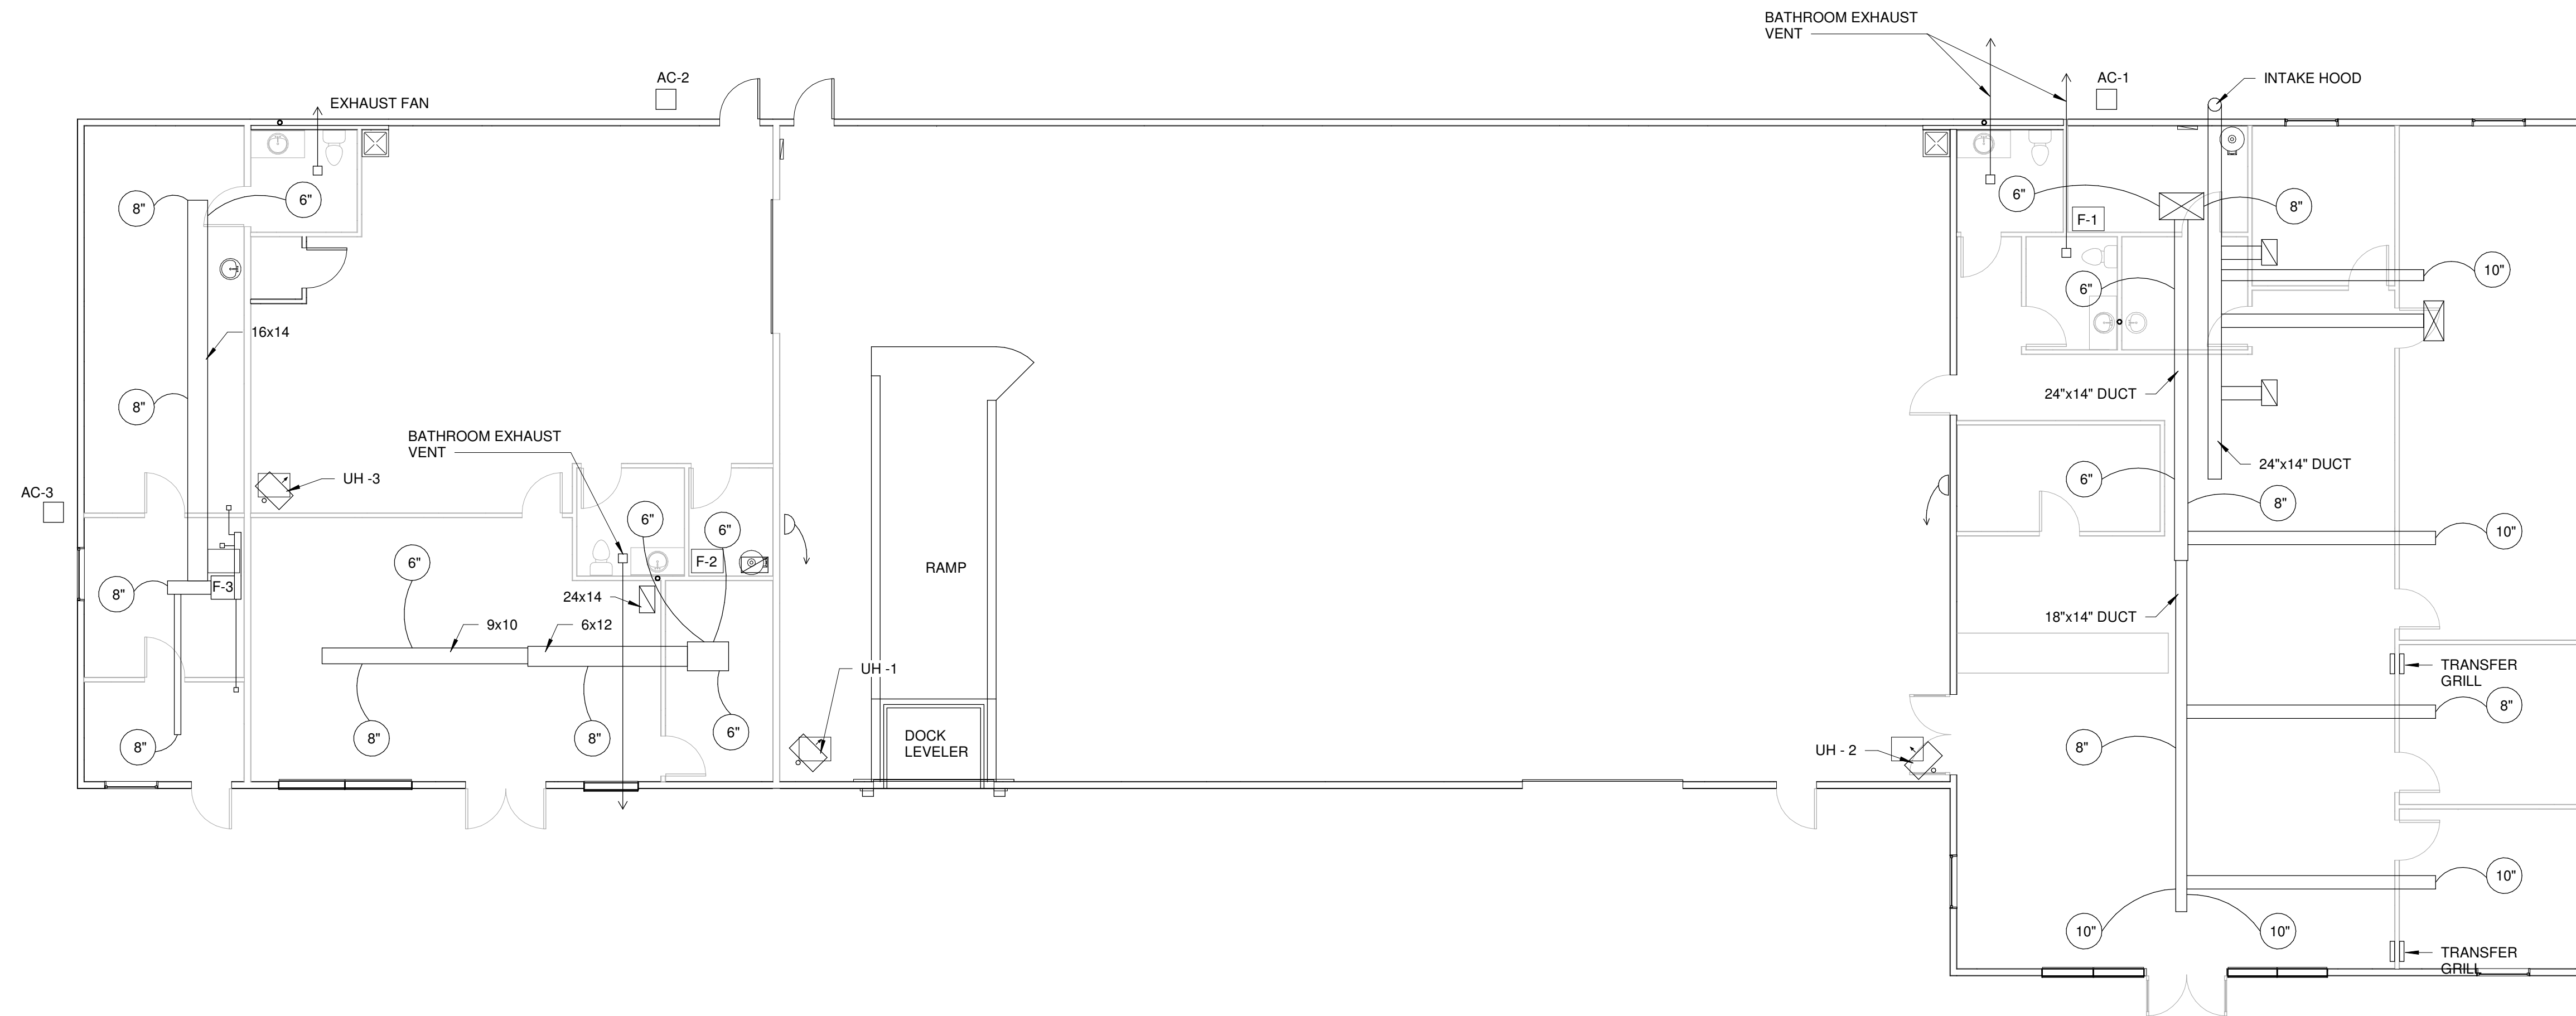


MECHANICAL PLAN  
1/8" = 1'-0"

**HVAC SCHEDULE**

F-1	GMH8120AN	AFUE 80%	INPUT 120,000 BTU
F-2	GMH80403AN	AFUE 80%	INPUT 40,000 BTU
F-3	GMH80403AN	AFUE 80%	INPUT 40,000 BTU
AC-1	GOODMAN VSX130601	13 SEER	60,000 BTU's COOLING
AC-2	GOODMAN VSX130241	13 SEER	24,000 BTU's COOLING
AC-3	GOODMAN VSX130241	13 SEER	24,000 BTU's COOLING
REGISTERS			
HIC	16W DIFFUSERS & DAMPERS		
RETURN GRILLS			
UNIT HEATER			
UH1&2	MODINE	ADP150AED13080% AFUE	150,000 BTU INPUT
UH3	MODINE	HD75 80% AFUE	75,000 BTU INPUT
BATH EXHAUST FAN			
EXHAUST FAN 1-4	BROAN	80 CFU	WALLOOPS

**HVAC LEGEND**

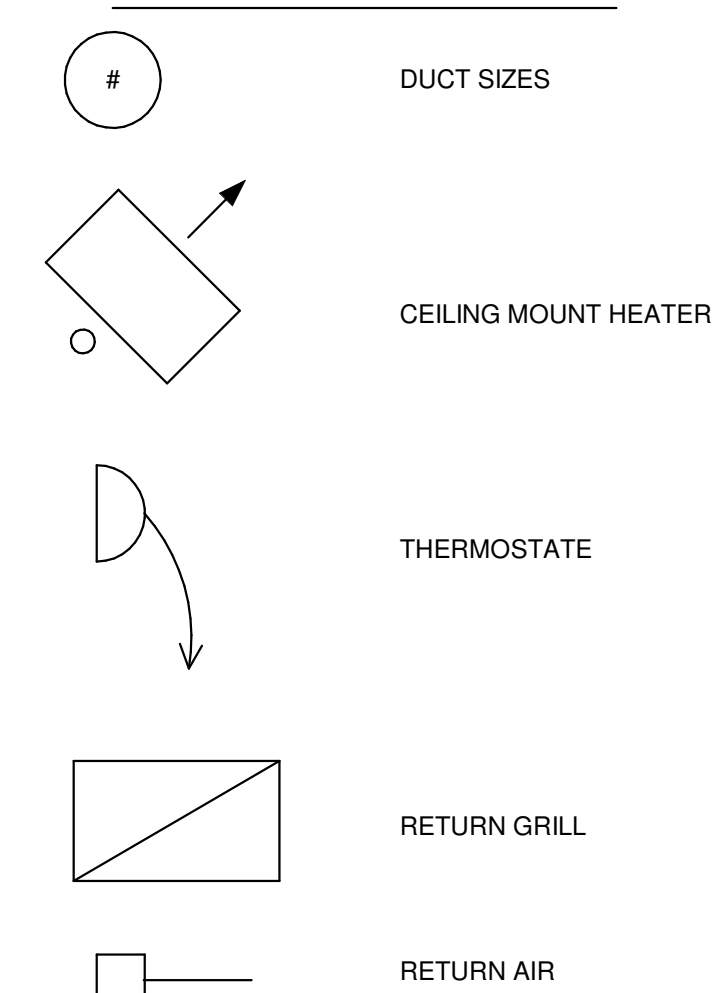


FRIESEN NUTRITION NEW BUILDING  
FRIESEN NUTRITION  
GREATFALLS, MONTANA

THIS DRAWING IS PROPERTY OF TETON DRAFTING SERVICES. IT IS TO BE USED ONLY FOR THE PROJECT AND SITE INDICATED WITHIN THE EXPLICIT WRITTEN CONSENT OF TETON DRAFTING SERVICES. NO LIABILITY IS ASSUMED FOR THE PRODUCTION OF THESE PRINTS. ALL INFORMATION IS PROVIDED AS IS. THE CUSTOMER HAS ACCEPTED AS IS.

CHECKED BY: MDG	DATE:
DRAWN BY: EVB	10/19/16
REVISIONS	BY
DATE	

TETON DRAFTING SERVICES  
136 SOUTH STATE STREET SHELLEY, IDAHO 83274  
PHONE (208) 357-2420 FAX (208) 357-2419





PROJECT NO. 216059  
SHEET NO. **A5.0**  
OF SIXTEEN

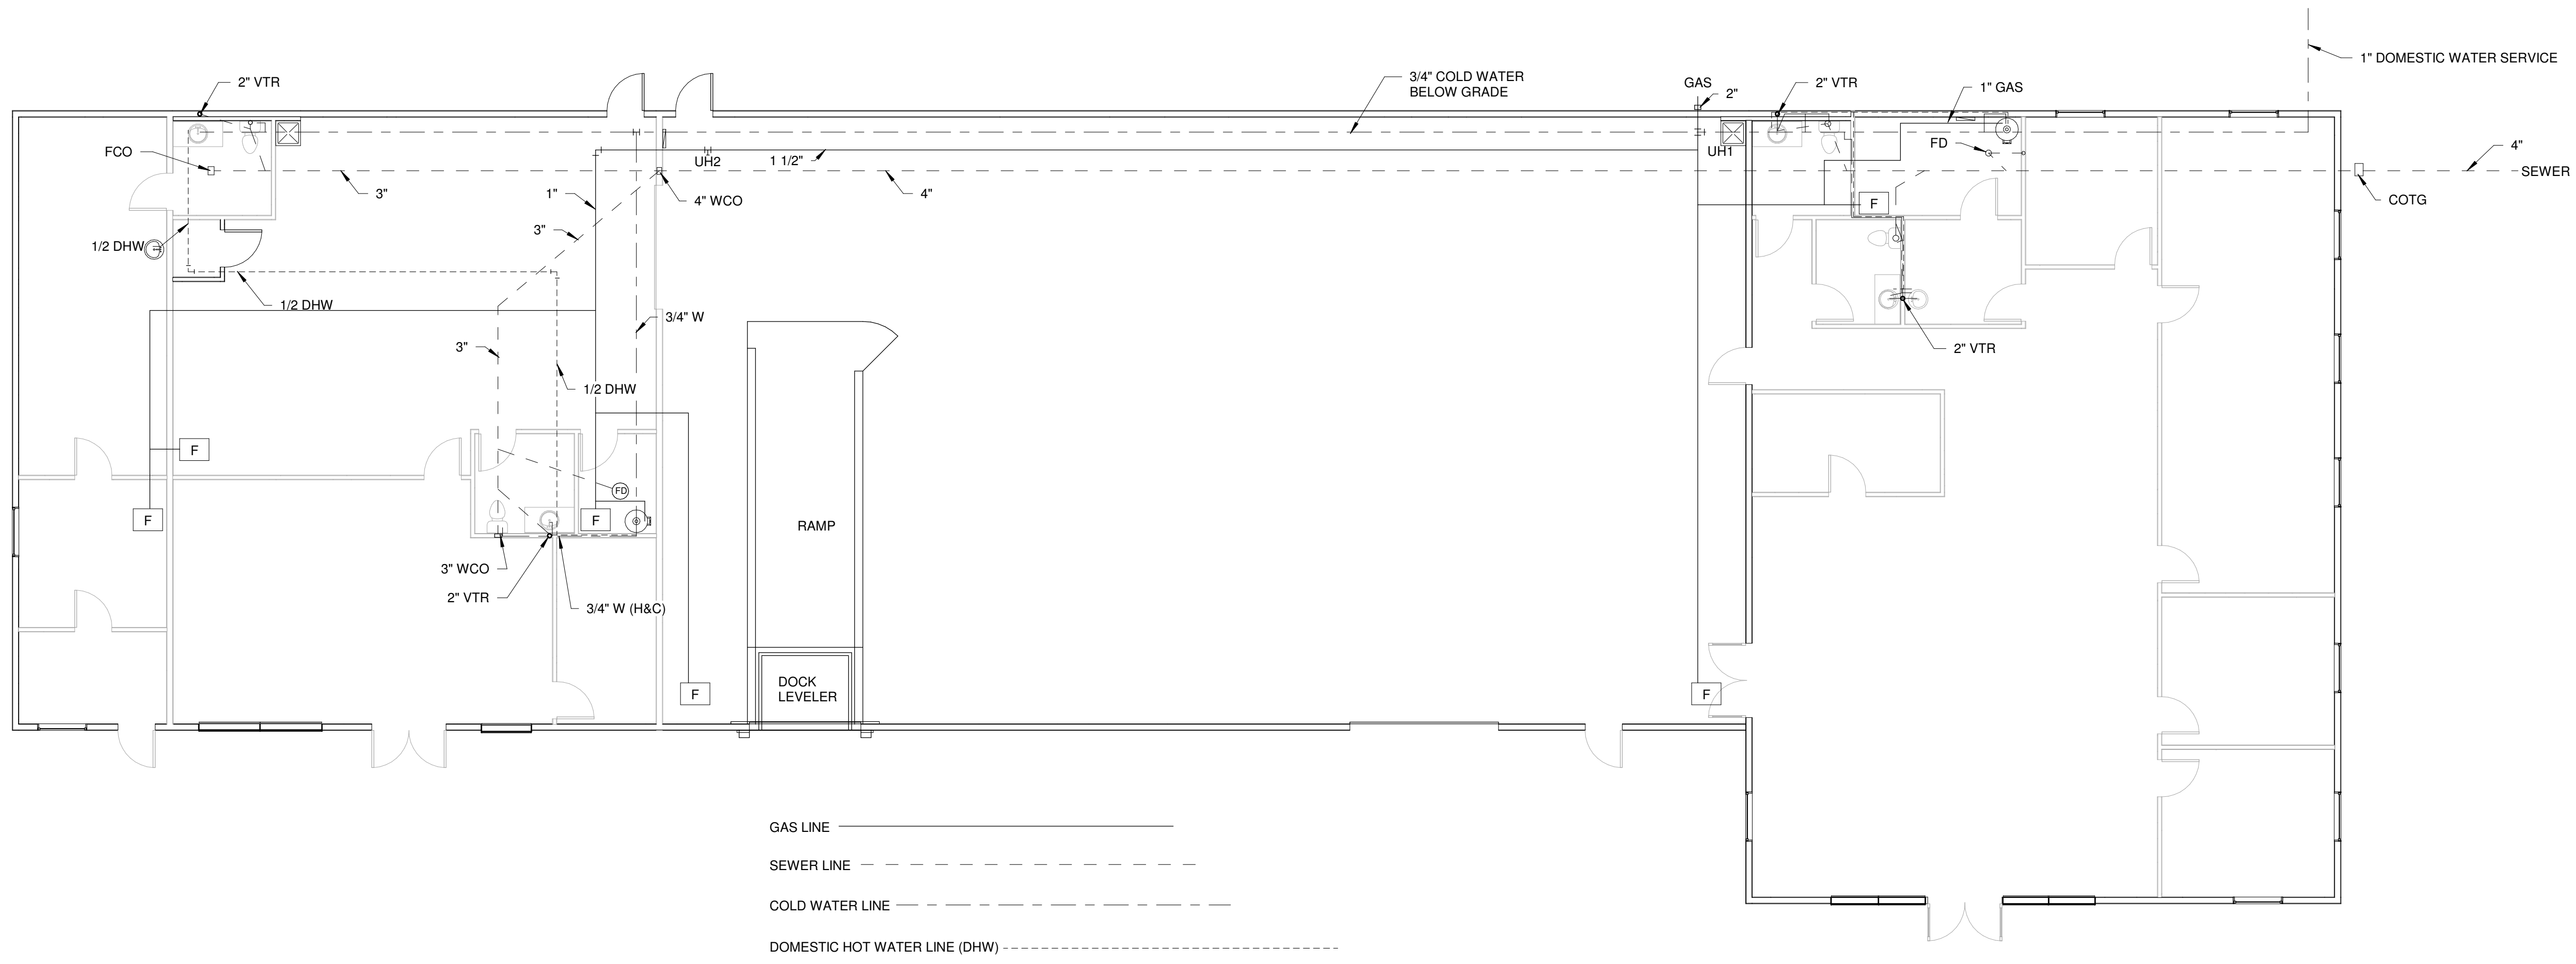

PLUMBING PLAN  
1/8" = 1'-0"

- GAS LINE —————
- SEWER LINE - - - - -
- COLD WATER LINE - - - - -
- DOMESTIC HOT WATER LINE (DHW) - - - - -

**PLUMBING EQUIPMENT SCHEDULE**

    	WATER HEATER
	TOILET
	URINAL
	FURNACE

**FRIESEN NUTRITION NEW BUILDING**  
FRIESEN NUTRITION  
GREATFALLS, MONTANA

THIS DRAWING IS PROPERTY OF TETON DRAFTING SERVICES. IT IS TO BE USED ONLY FOR THE PROJECT AND SITE SPECIFICALLY INDICATED WITHIN THIS DRAWING. NO PART OF THIS DRAWING IS TO BE REPRODUCED OR TRANSMITTED IN ANY FORM OR BY ANY MEANS, ELECTRONIC OR MECHANICAL, INCLUDING PHOTOCOPYING, RECORDING, OR BY ANY INFORMATION STORAGE AND RETRIEVAL SYSTEM, WITHOUT THE EXPRESS WRITTEN CONSENT OF TETON DRAFTING SERVICES. TETON DRAFTING SERVICES ASSUMES NO LIABILITY BEYOND THE PRODUCTION OF THESE PRINTS. ALL RIGHTS ARE RESERVED AND WILL BE ENFORCEABLE. ANY USE NOT PROVIDED BY THE CUSTOMER AND HAVE BEEN ACCEPTED AS IS.

CHECKED BY: MDG	DATE:	10/19/16
DRAWN BY: EVB	REVISIONS	
	DATE	
	BY	

 
**TETON DRAFTING SERVICES**  
136 SOUTH STATE STREET SHELLEY, IDAHO 83274  
PHONE (208)-357-2420 FAX (208)-357-2419

PROJECT NO.  
216059  
SHEET NO.  
**A6.0**  
OF SIXTEEN



NAPA Auto Parts - 4 New Beginnings

SITE PLAN  
1" = 40'-0"



ELEVATION ARE BASED ON A LOCAL DATUM.

FRIESEN NUTRITION NEW BUILDING  
FRIESEN NUTRITION  
GREATFALLS, MONTANA

THIS DRAWING IS PROPERTY OF TETON DRAFTING SERVICES. IT IS TO BE USED ONLY FOR THE PROJECT AND SITE SPECIFICALLY INDICATED WITHOUT THE EXPRESS WRITTEN CONSENT OF TETON DRAFTING SERVICES. NO LIABILITY IS ASSUMED FOR ANY ERRORS OR OMISSIONS THAT MAY BE PRESENT IN THIS DRAWING. THE USER HAS ACCEPTED AS IS.

CHECKED BY: MDG	DATE:
DRAWN BY: EVB	10/19/16
DATE	REVISIONS
	BY

TETON  
DRAFTING SERVICES  
136 SOUTH STATE STREET SHELLEY, IDAHO 83274  
PHONE (208)-357-2420 FAX (208)-357-2419

PROJECT NO.  
216059  
SHEET NO.  
**C1.0**  
OF SIXTEEN