



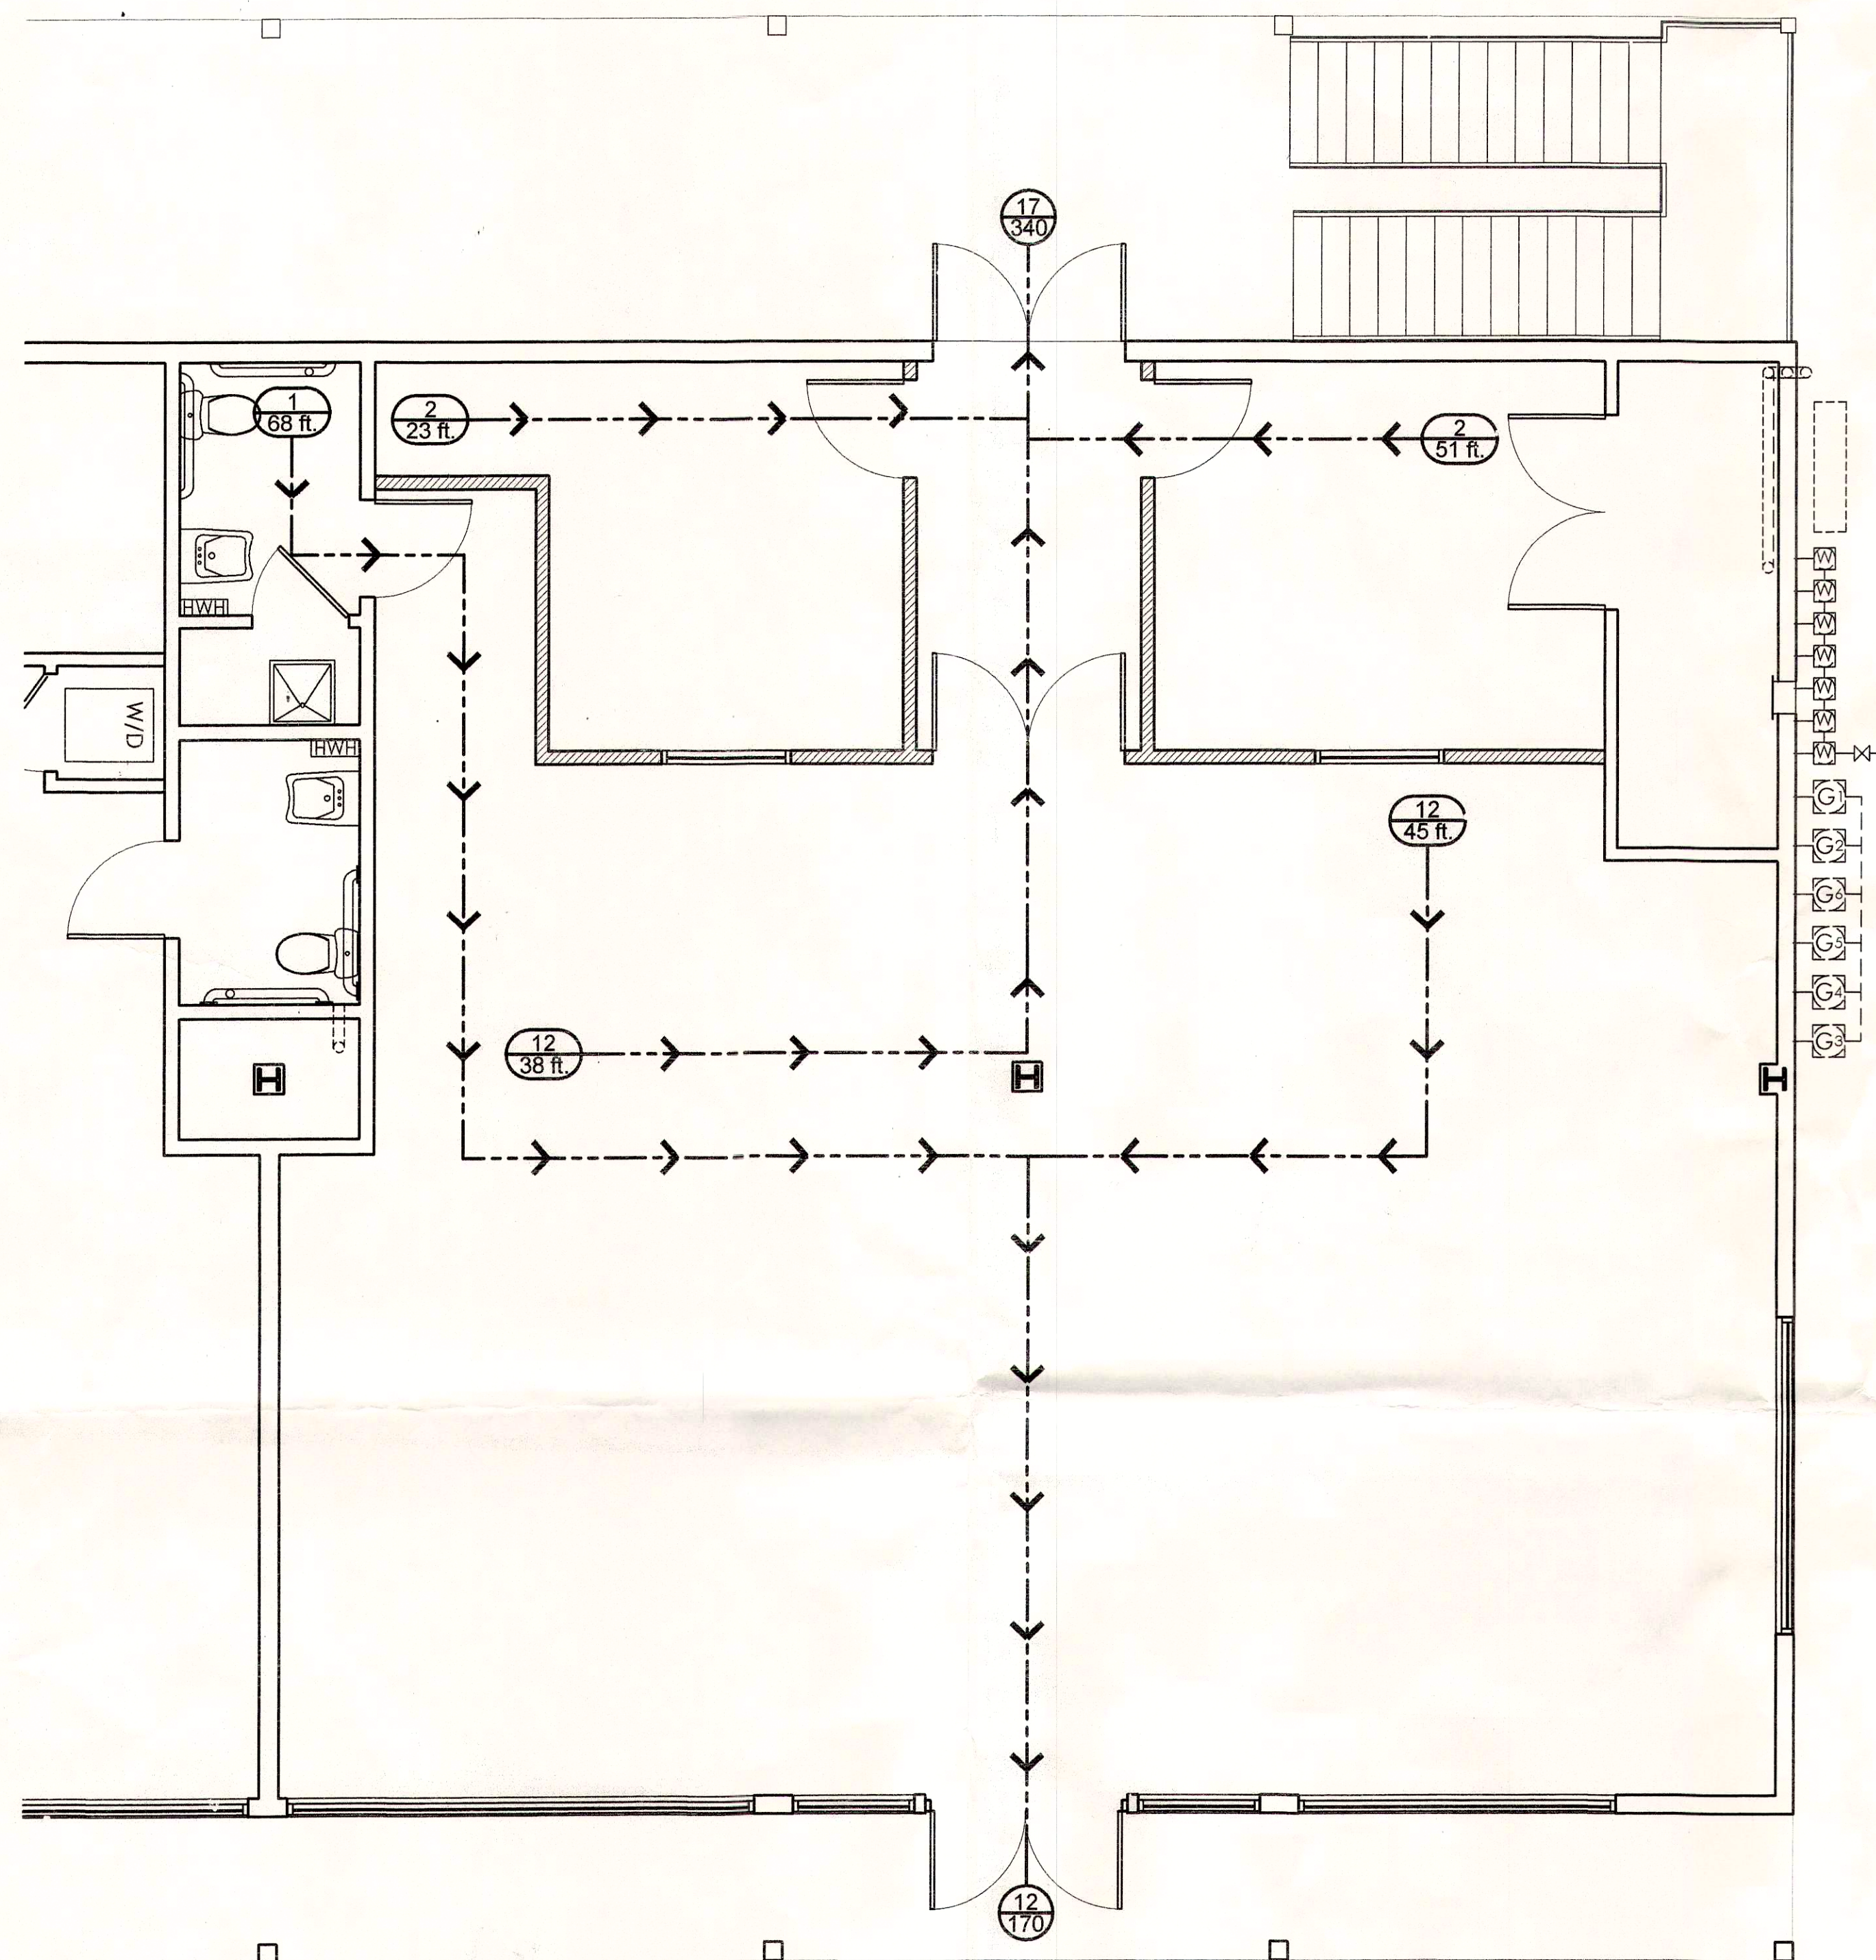

1 UNIT 2 EGRESS PLAN
SCALE: 1/4" = 1'-0"

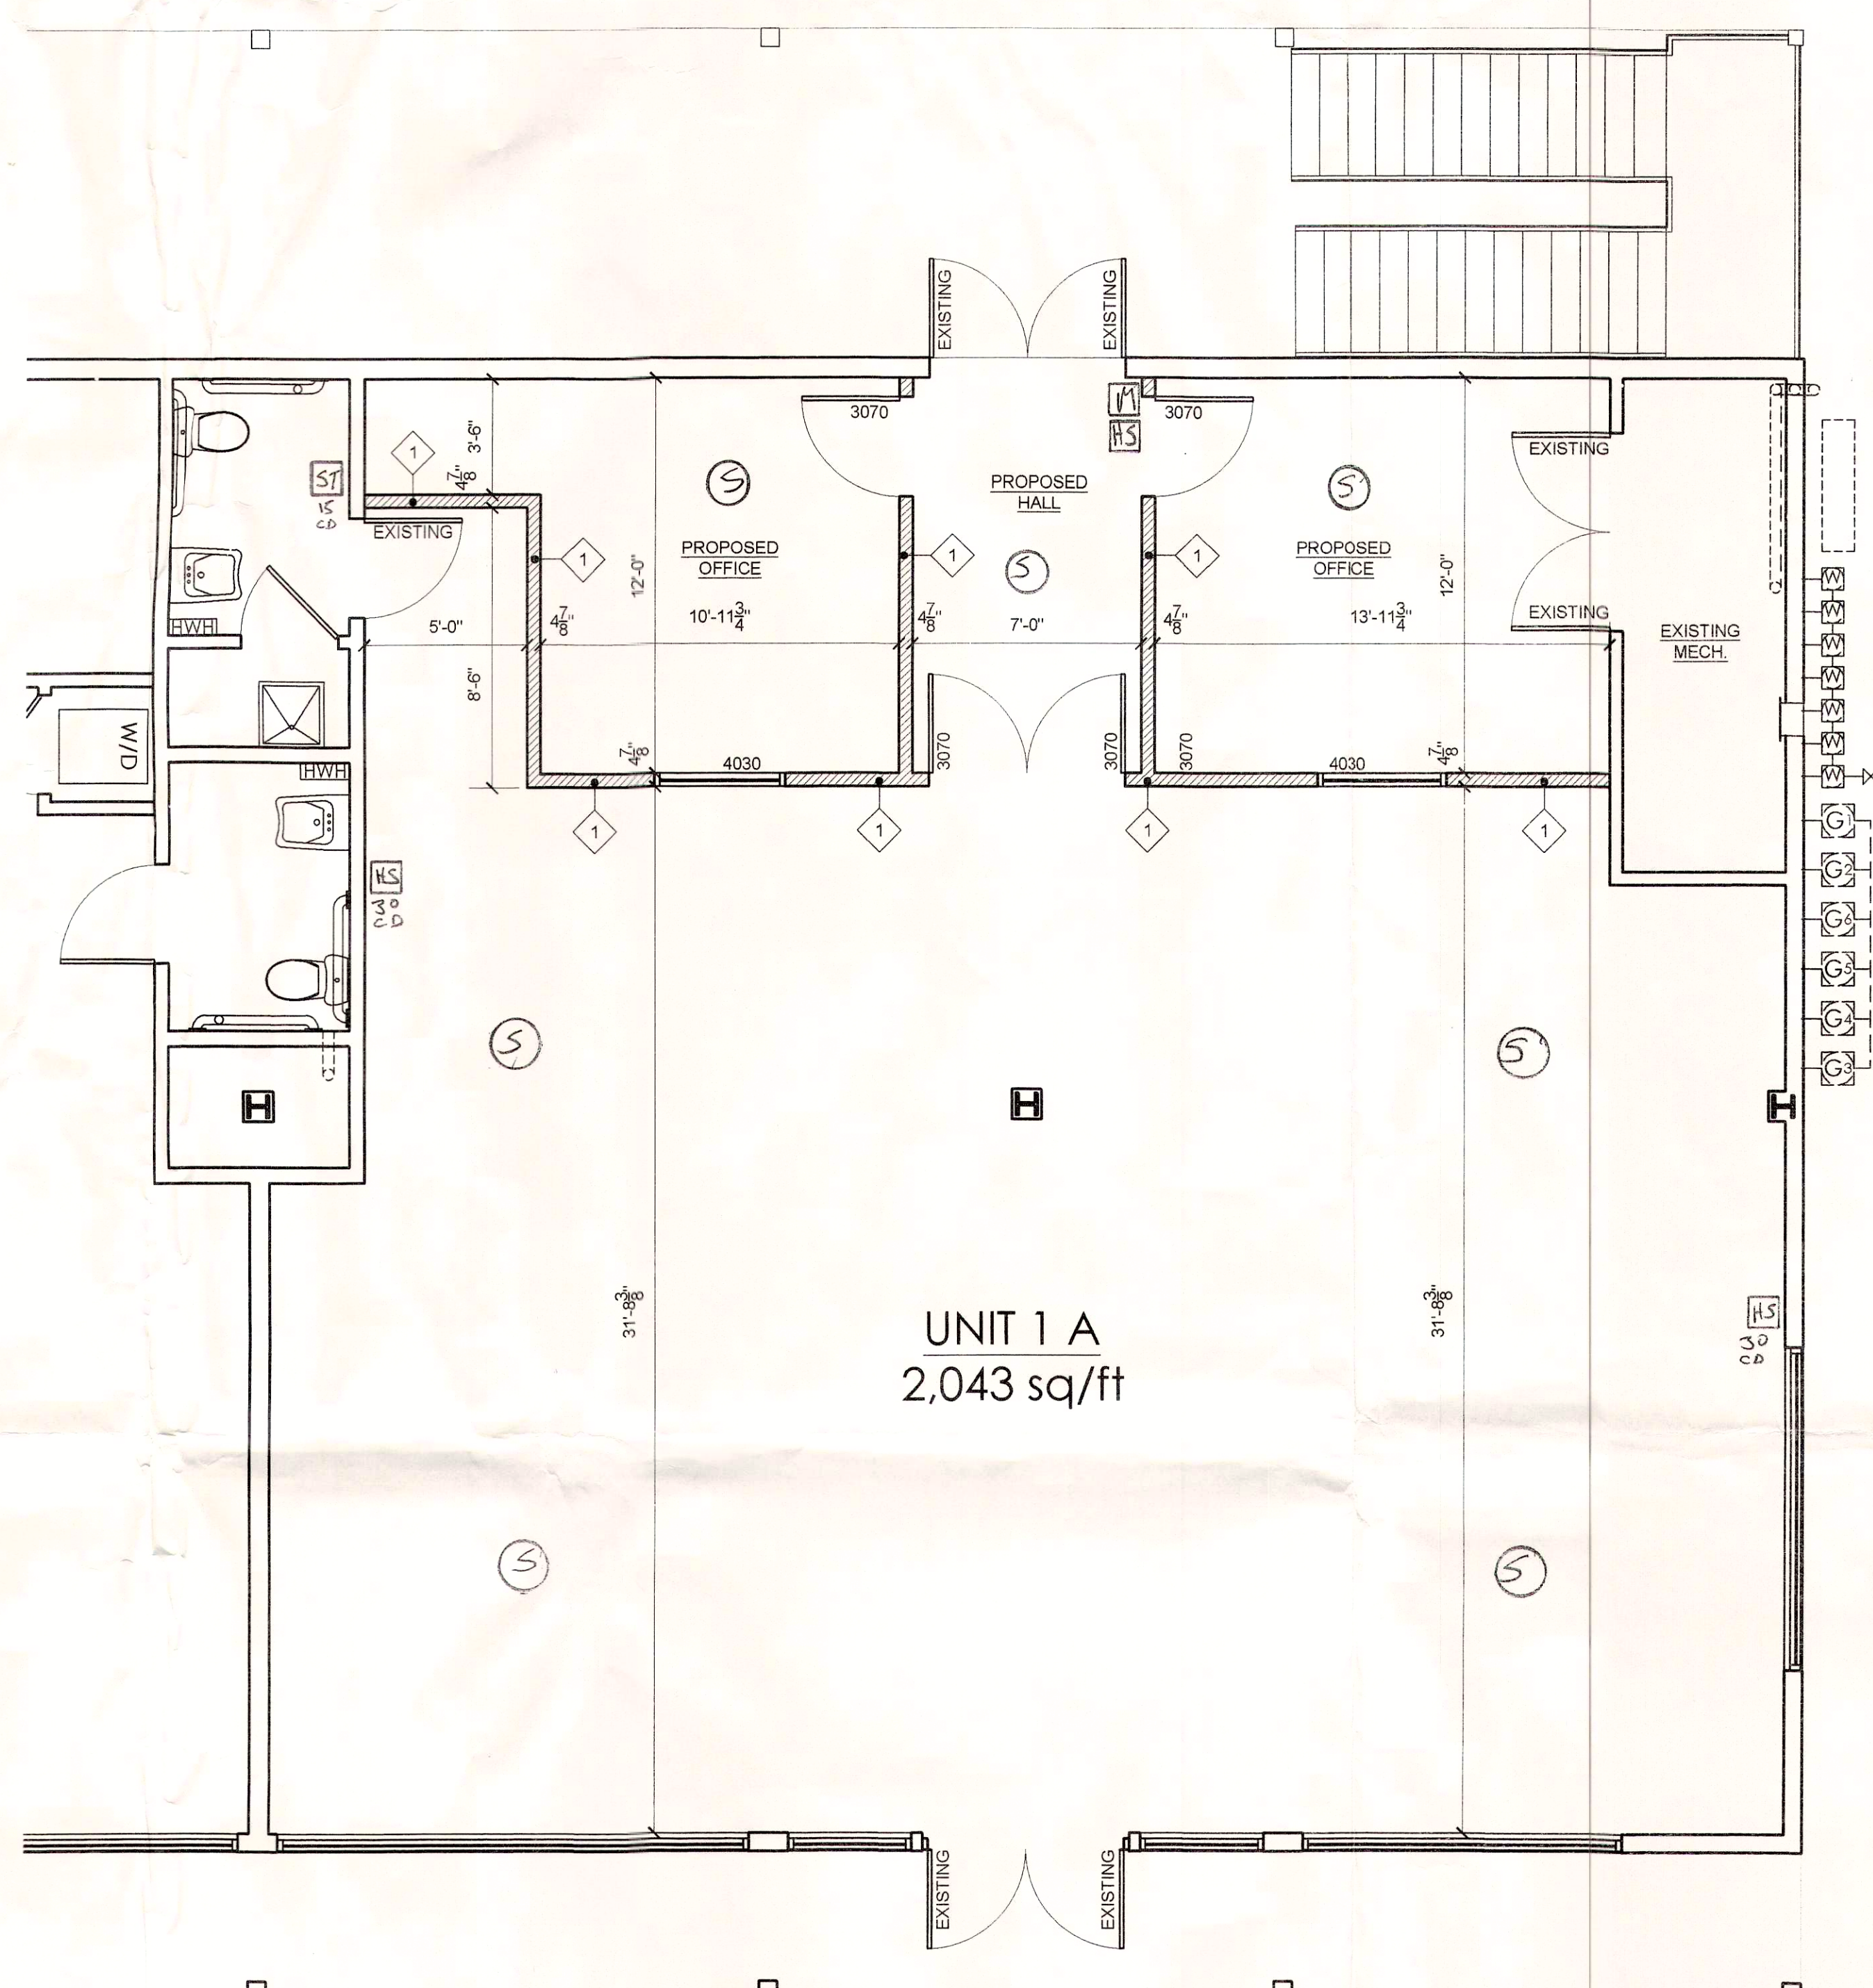

2 PROPOSED UNIT 1A FLOOR PLAN
SCALE: 1/4" = 1'-0"

FIRE ALARM LEGEND:

- Ⓢ SMOKE DETECTOR
- Ⓢ HORN STROBE
- Ⓢ STROBE
- Ⓢ MANUAL PULL STATION

UNIT 2

ATLANTIC SECURITY & FIRE
44 Oceanport Ave
West Long Branch, NJ 07764
(732) 531-0000

James Watt, Architect AI 13791
WATT ARCHITECTS
610 Bangs Avenue
Suite 510
Asbury Park, NJ 07712

PROJECT:
PROPOSED
UNOCCUPIED TENANT SPACE:
The Getty Building
1183 Main Street
UNIT 1A
Asbury Park, N.J. 07712

TITLE:
PROPOSED
PLANS & DETAILS

PROJECT NUMBER: 2019-11

SCALE: AS NOTED

DATE: 10-22-19

DRAWN BY: DJD

SHT. #

A-101

