


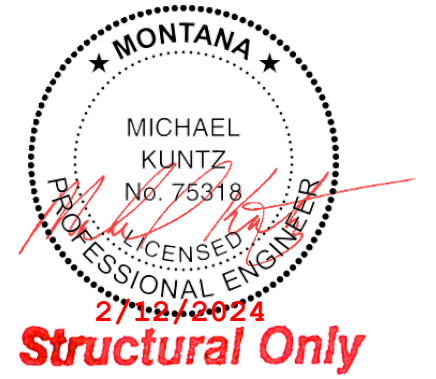

RLC ENTERPRISE

MISSOULA, MONTANA

9405 FUTURITY DRIVE



PROJECT NUMBER 23-038

DATE 2 / 12 / 2024

EV	DATE	DESCRIPTION
----	------	-------------

OVERALL FIRST FLOOR PLAN

A2.0

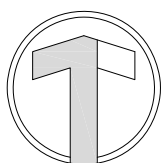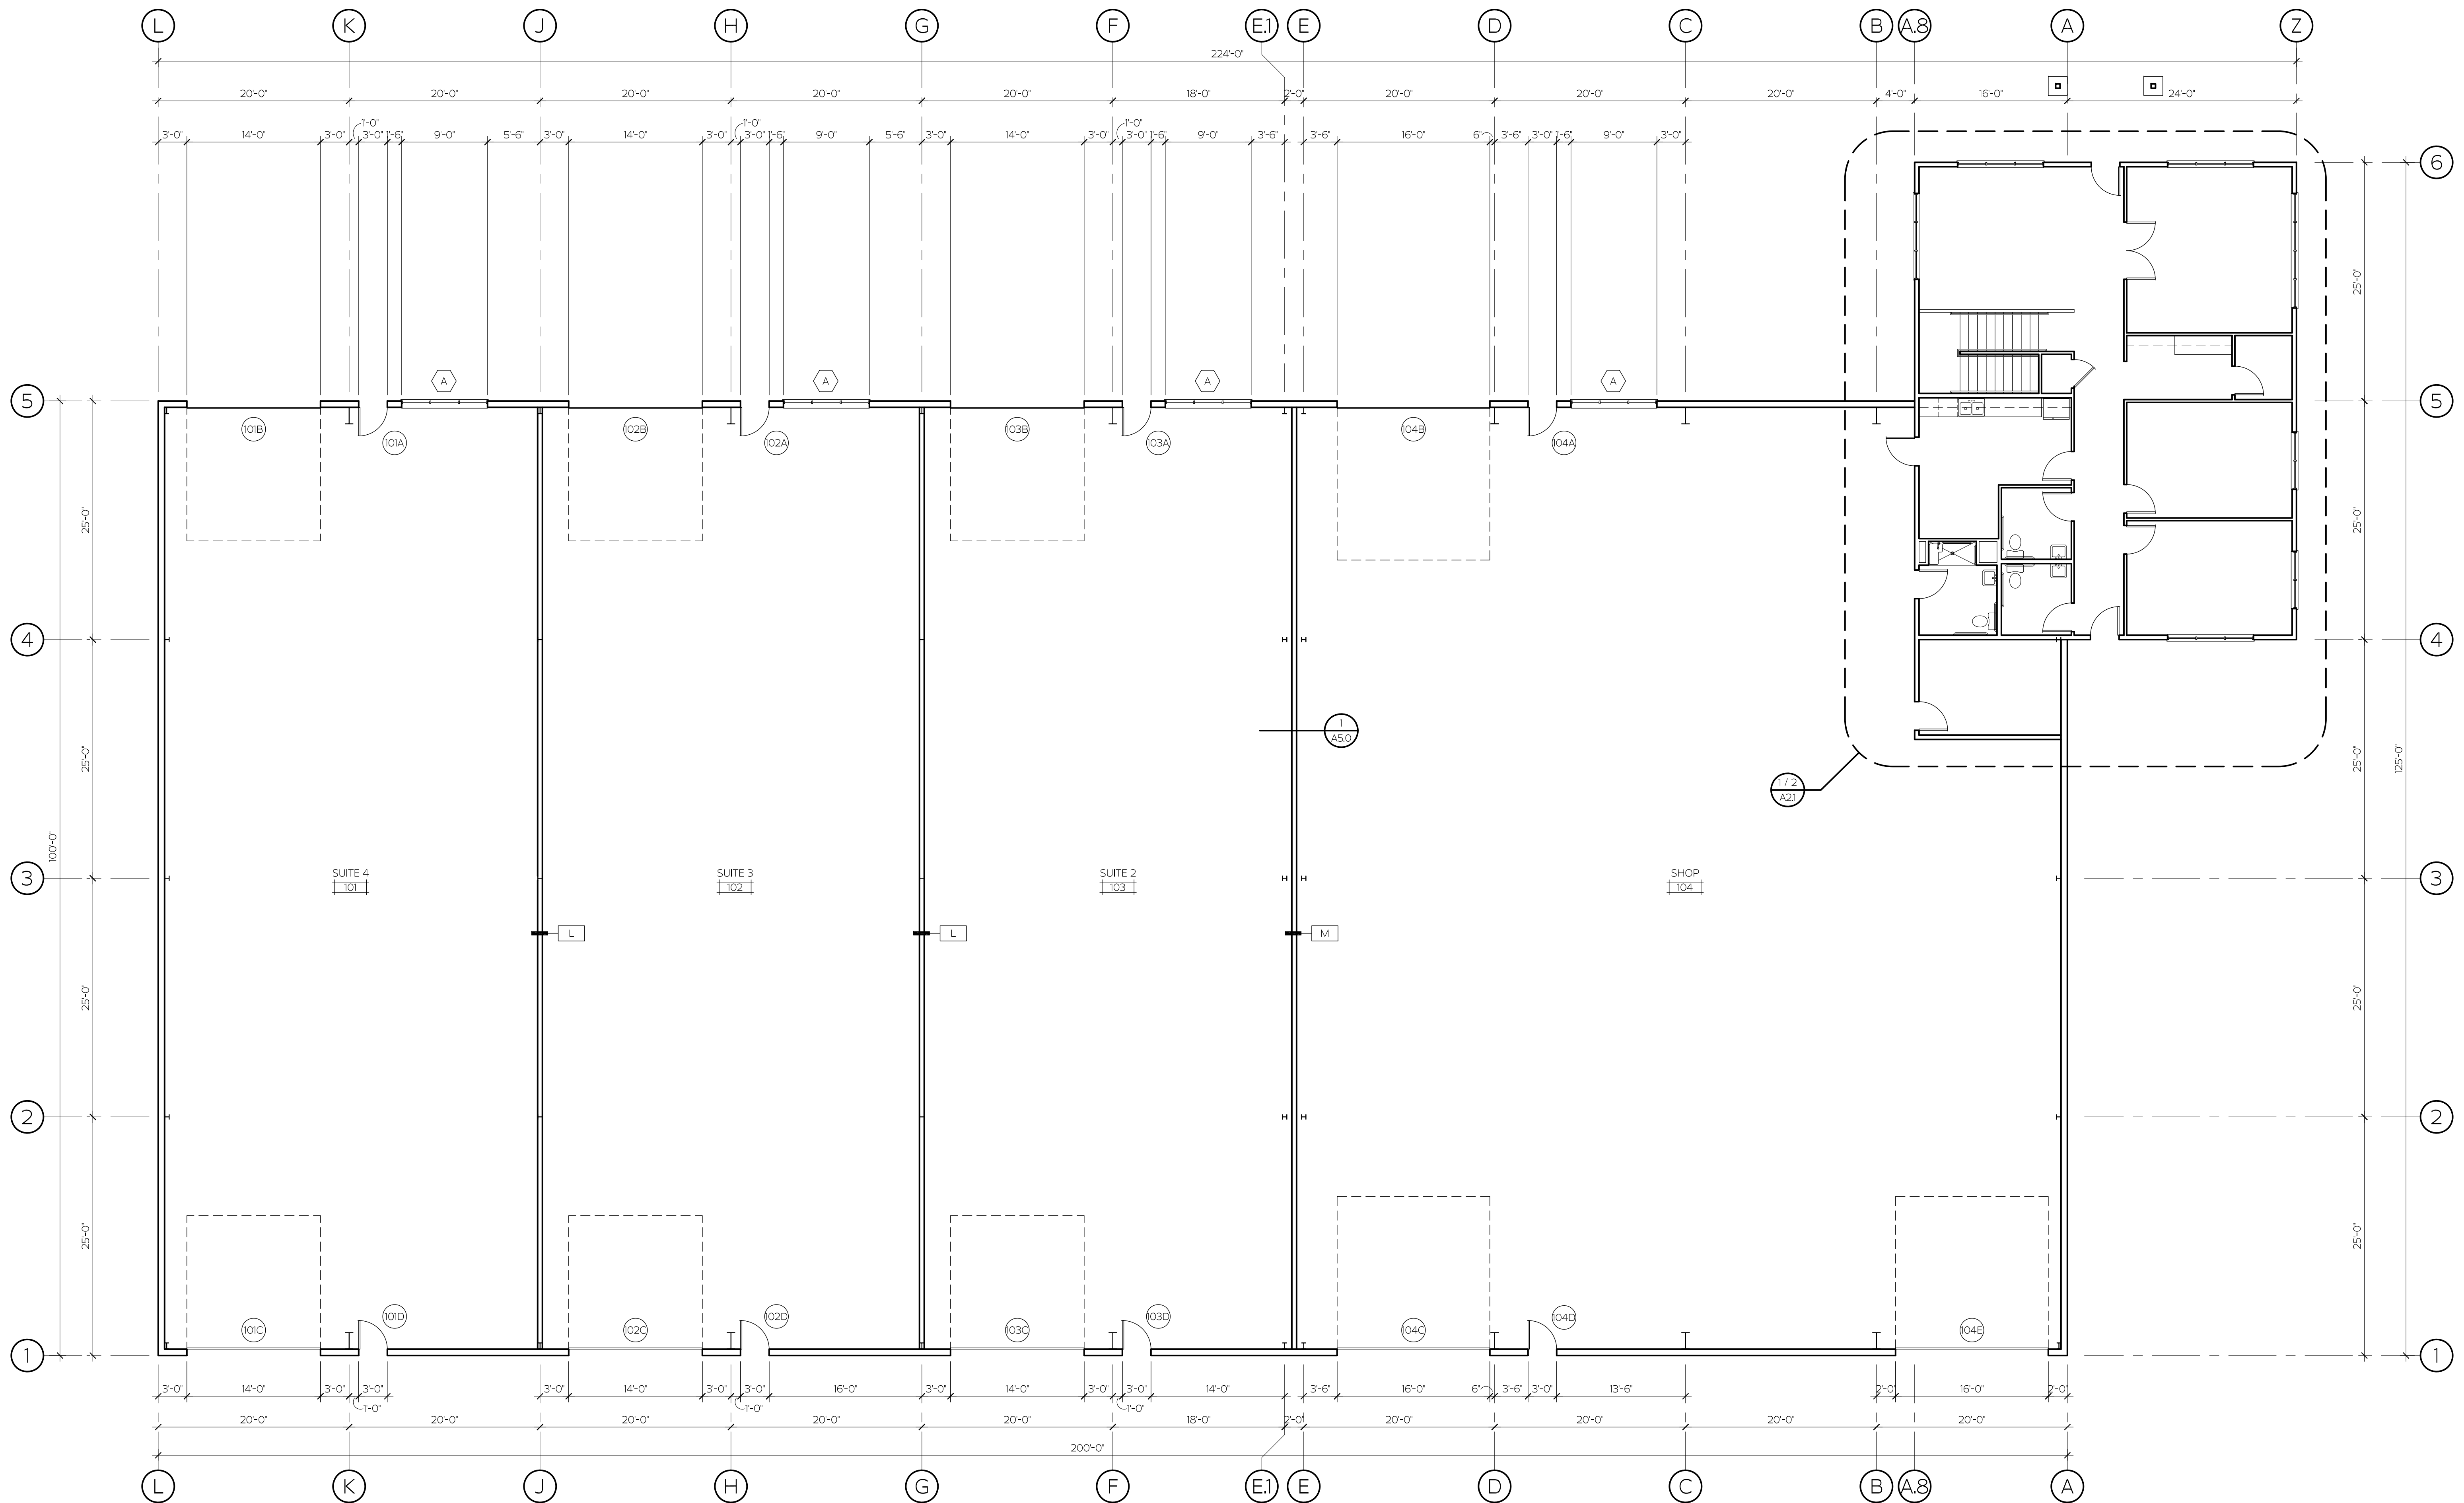

OVERALL FIRST FLOOR PLAN

SCALE: 1/8" = 1'-0"