




SITE EVALUATORS LLC
6136 FRISCO SQUARE BLVD.
SUITE 400
FRISCO, TX 75034
214-705-8555

LEV COR

WACO CENTRE
240 N NEW ROAD,
WACO, TX 76710


THIS IS NOT A WORKING
DRAWING.
DO NOT USE FOR
CONSTRUCTION.
ALL DIMENSIONS ARE
SUGGESTED AND ARE TO BE
VERIFIED BY THE
CONTRACTOR.
DRAWN BY: I.S.
NOT TO SCALE
DATE: 07-24-25

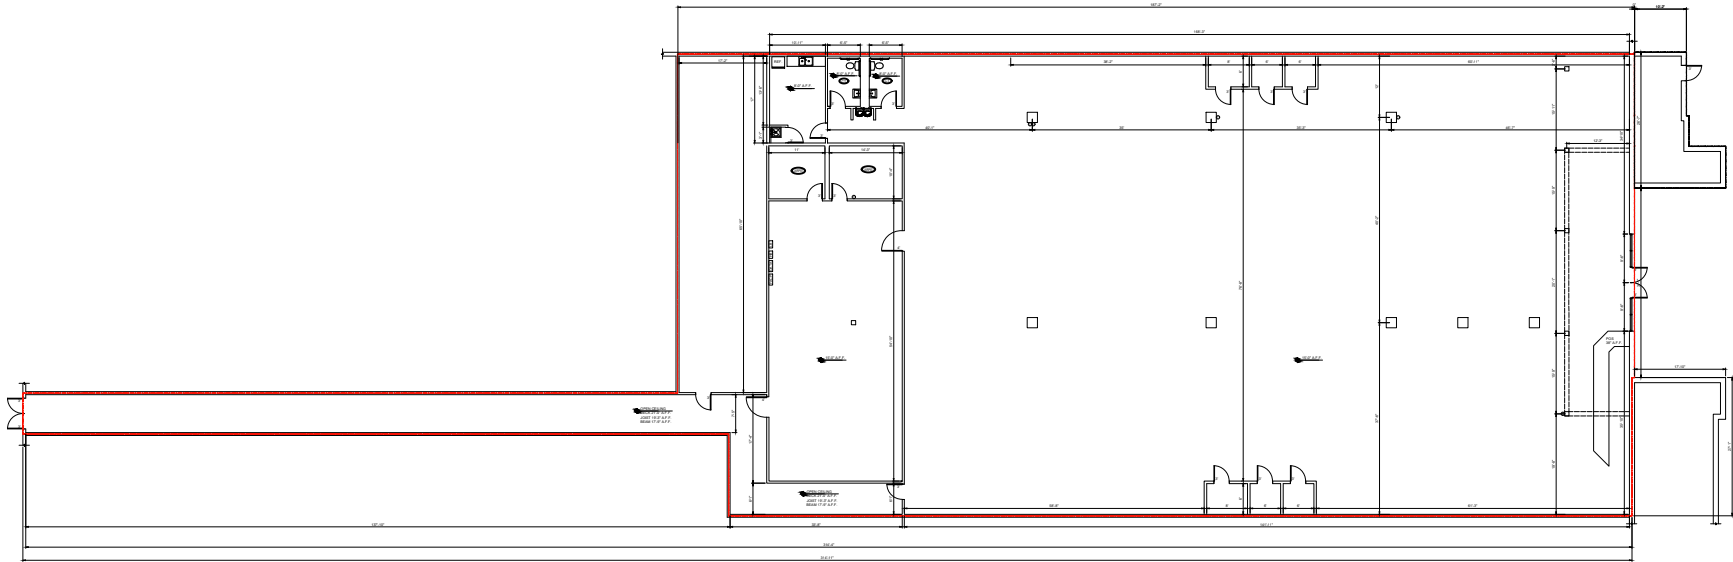

FLOOR PLAN

LEGEND	
[HB]	= 400 AMP, 480Y/277V
[LB]	= 150 AMP, 208Y/120V
(H)	= 6 GAL. ELECTRIC HOT WATER HEATER
(T)	= THERMOSTAT
[X]	AIR SUPPLY DIFFUSOR
[X]	AIR RETURN DIFFUSOR
[L]	2'x4' LAY-IN LIGHT FIXTURE
(S)	SPEAKER
(F)	FIRE ALARM STROBE

LEASEABLE S.F. = 17,768 SF
NAP AREA = 336 SF

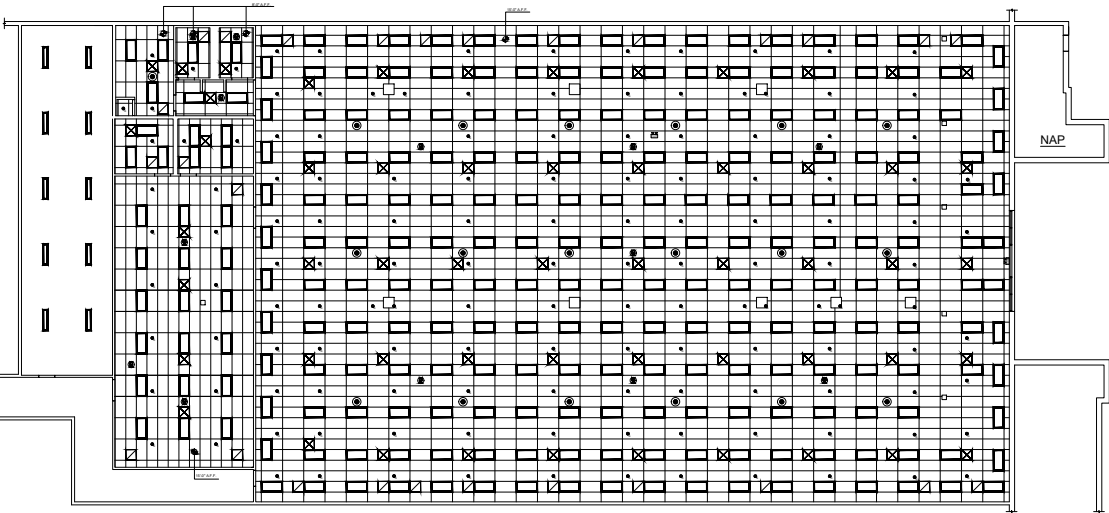

REFLECTED CEILING PLAN