

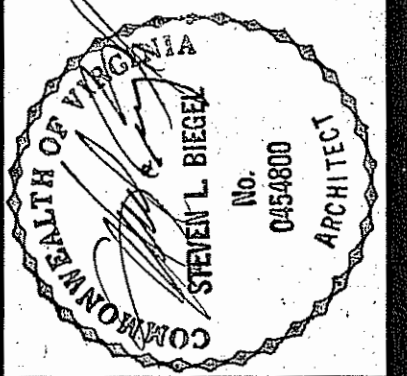
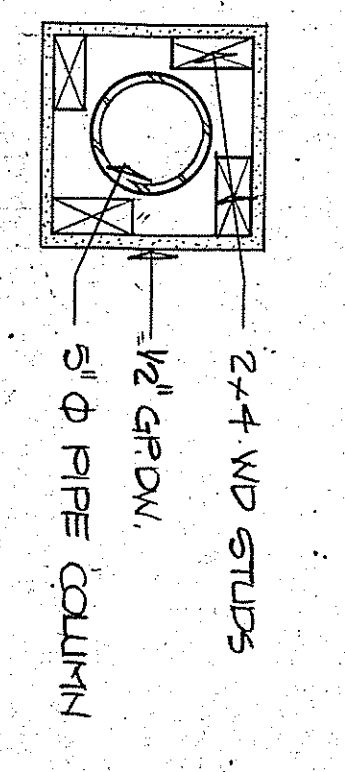
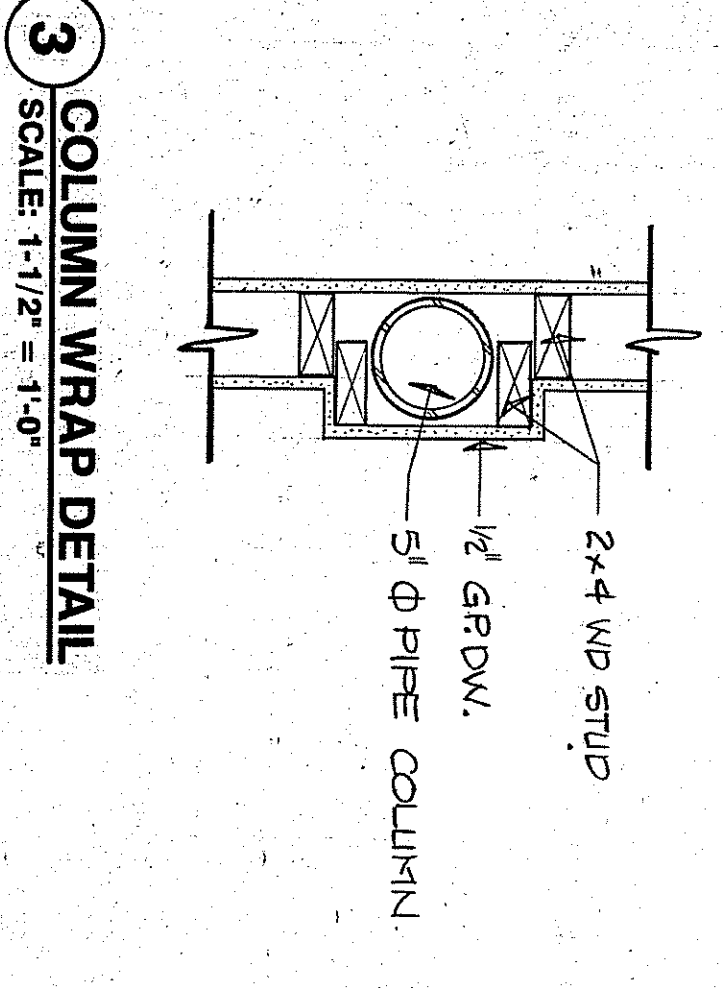


FLOOR PLAN
SCALE: 1/4"=1'-0"


NOTE: ALL DIMENSIONS ARE APPROXIMATE. CONTRACTOR TO FIELD VERIFY ALL DIMENSIONS.

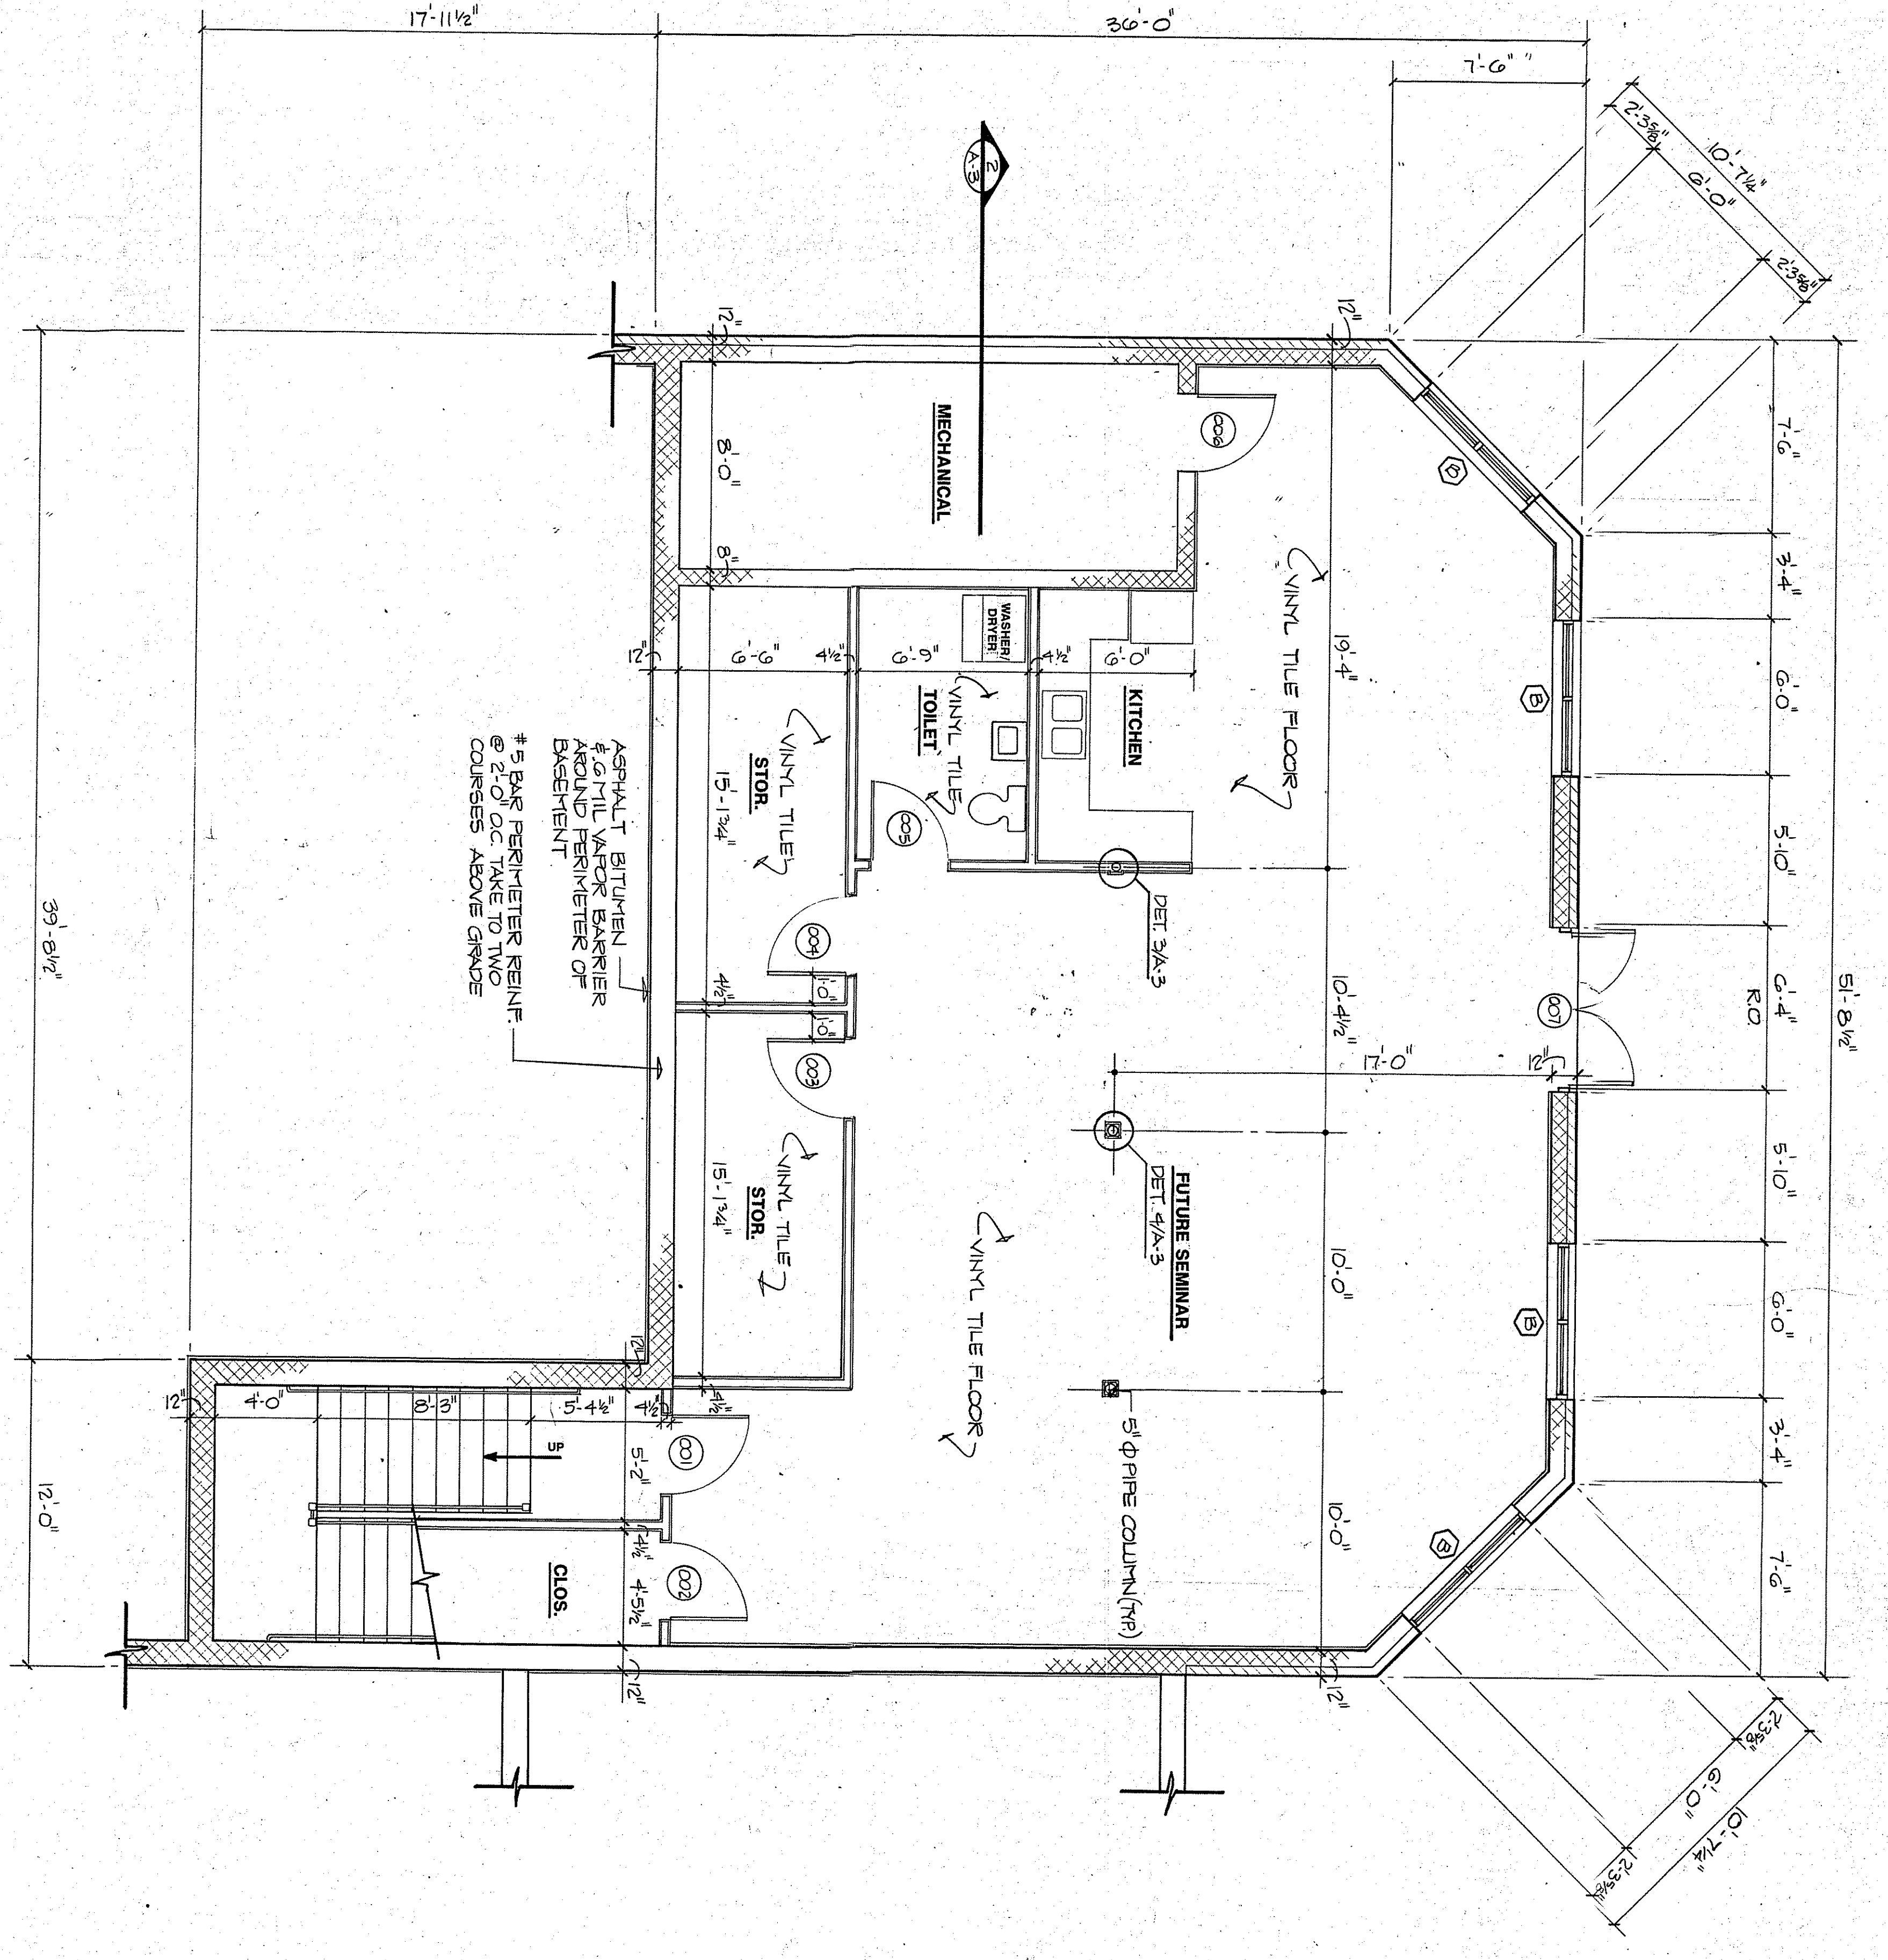

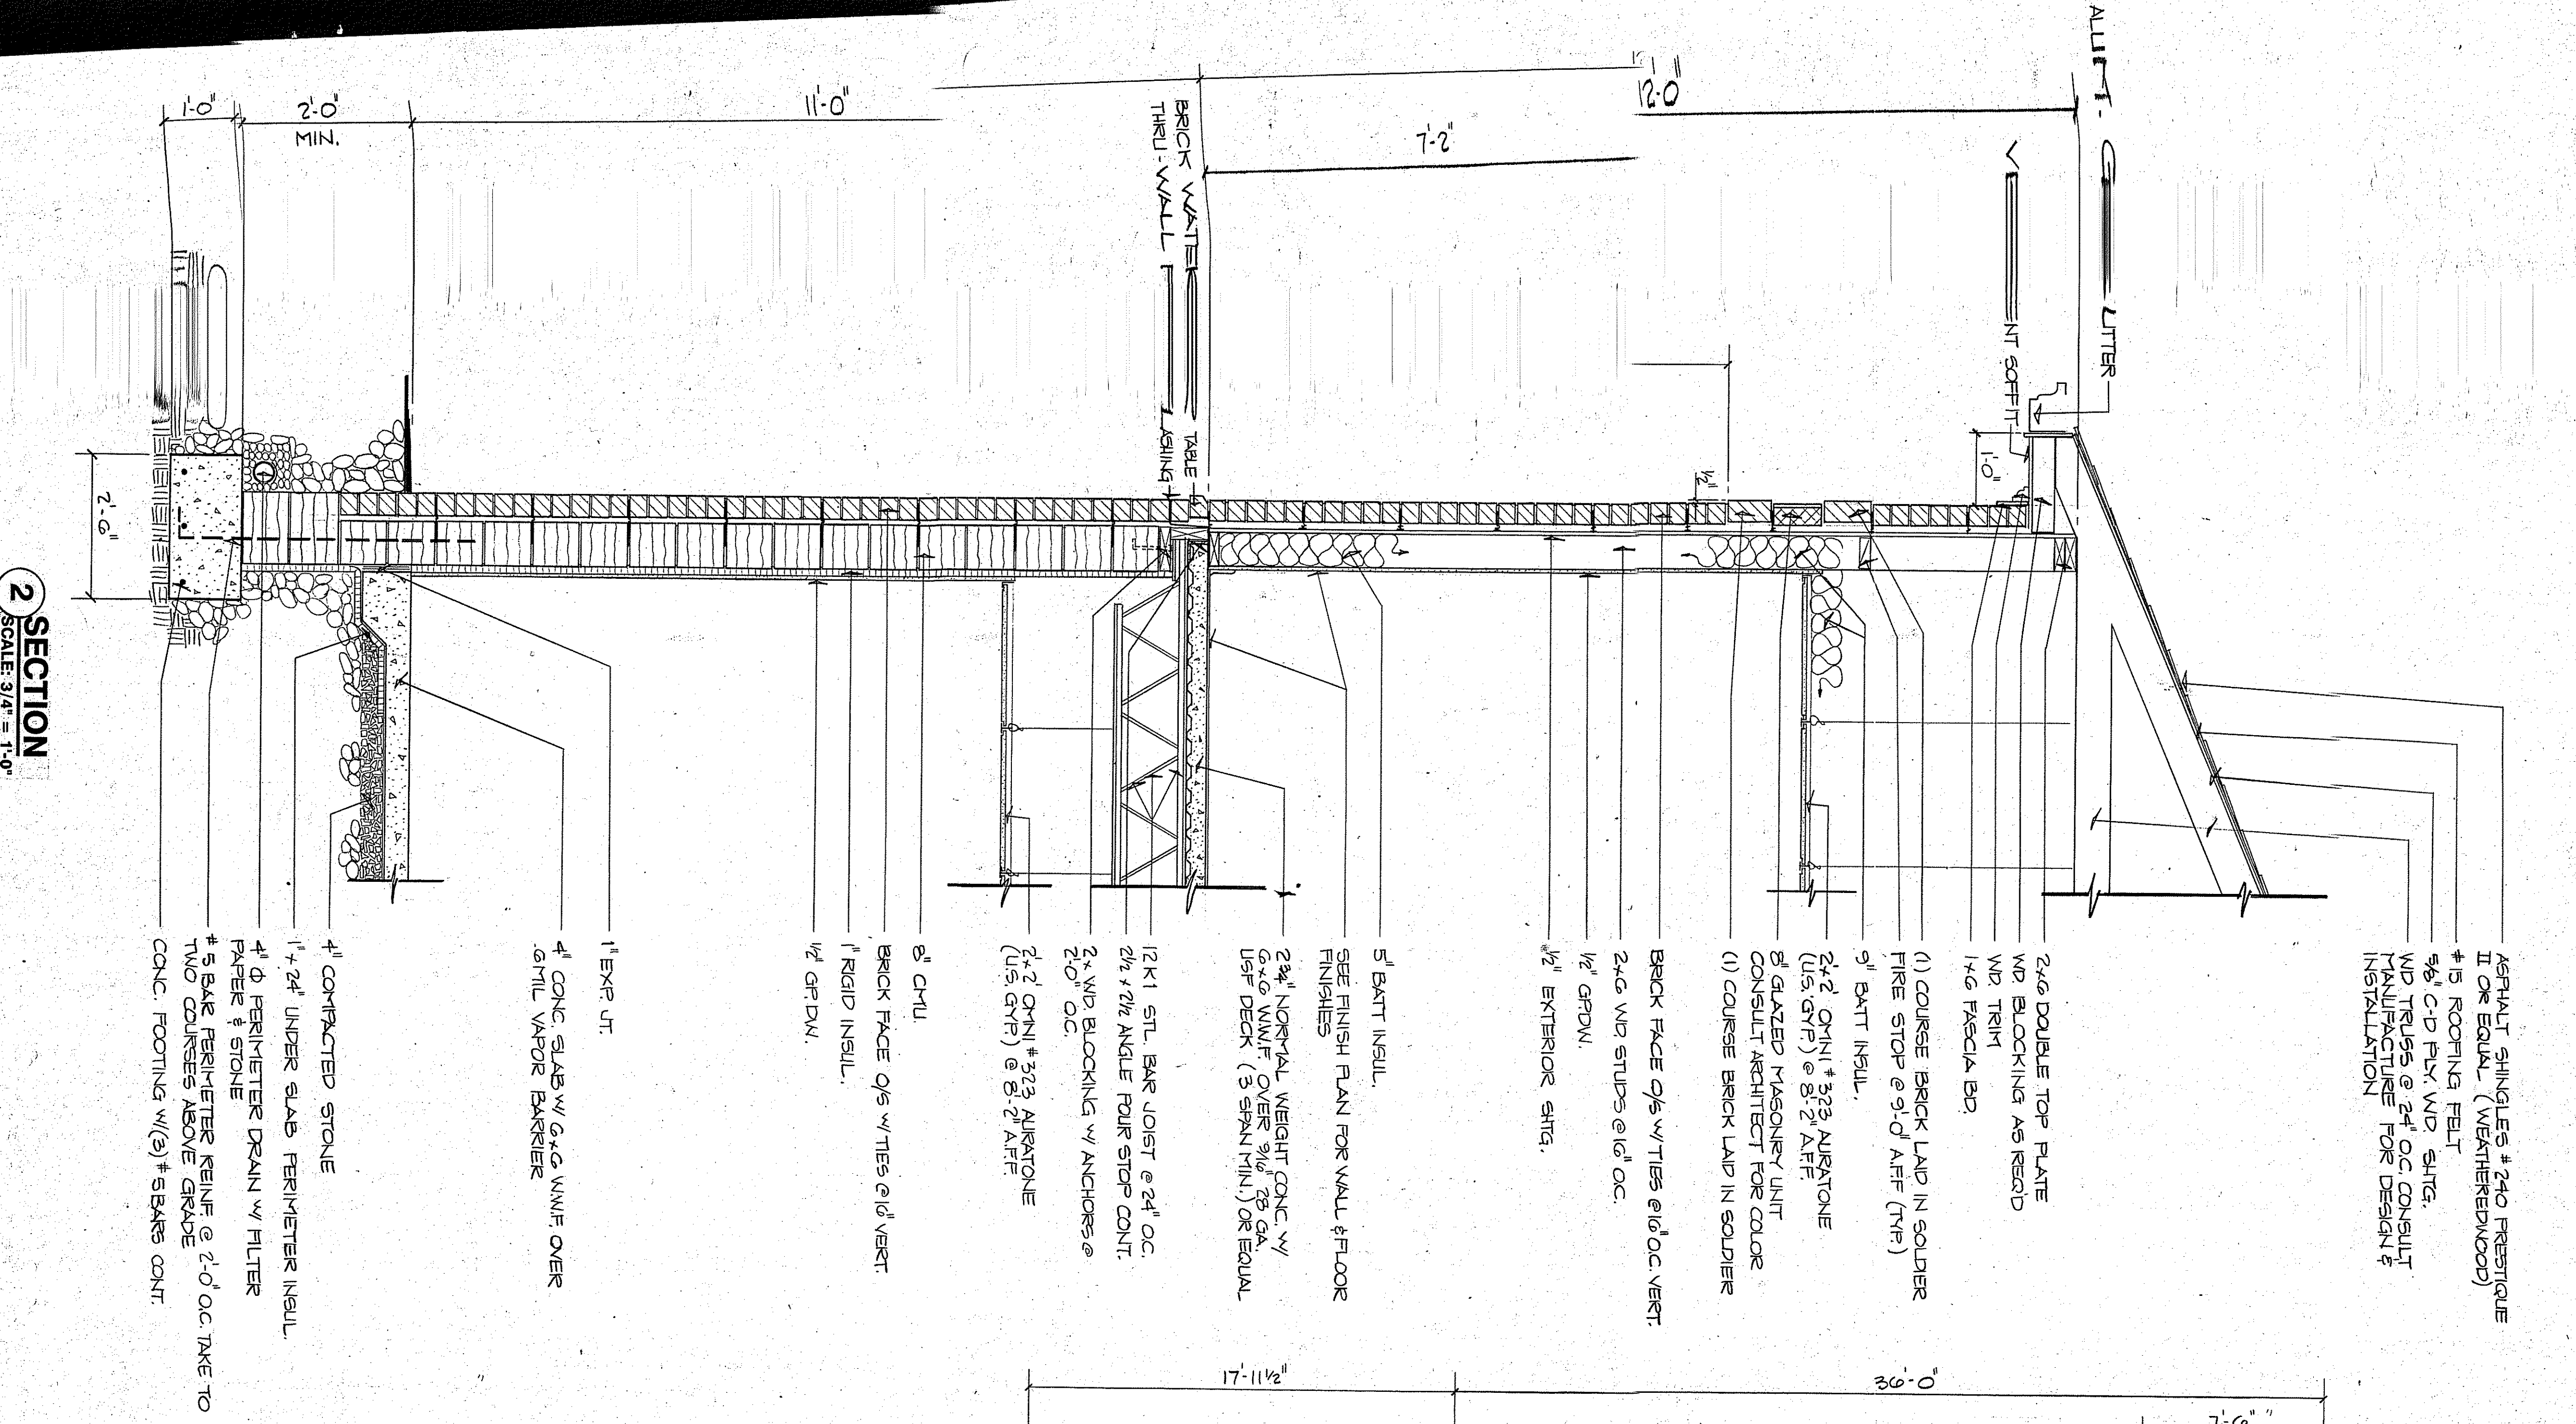

NOTE: ALL DIMENSIONS ARE APPROXIMATE. CONTRACTORS TO FIELD VERIFY ALL DIMENSIONS.

LAWRENCE & LAWRENCE, P.C.
ARCHITECTURE, PLANNING, INTERIOR DESIGN
98 ALEXANDRIA PIKE, SUITE 500
WARRENTON, VIRGINIA 22186
(703) 349-8480 (703) 349-8400

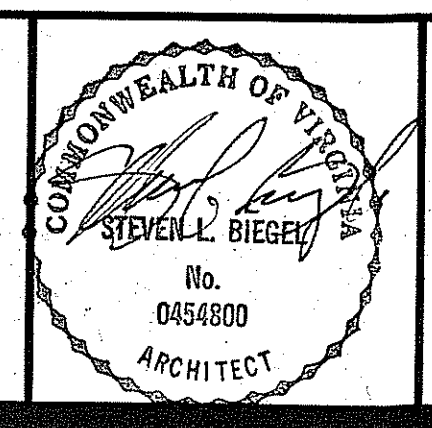

DR. N. L. MAURONER
MEDICAL OFFICE BUILDING
HOSPITAL HILL SITE
WARRENTON, VIRGINIA

BASEMENT PLAN
SCALE: 1/4" = 1'-0"
FEBRUAR 1, 1990