

**BUNKER DESIGN HOUSE**  
 Maggie McBride, R.A.  
 e: maggie@bunker.design  
 p: 404.402.1316  
 Kandace Walker-Runda  
 e: kandace@bunker.design  
 p: 646.401.2077



Market District  
**Crabapple**  
 Building 3 - Suite 101  
 3000 Heritage Walk, #101  
 Milton, Georgia 30004

revision: description date fire marshal comments  
 1 07/08/22


job number: 200804  
 date of issue: 06/23/22  
 drawing name:

**PROPOSED FLOOR & FIXTURE PLAN & SCHEDULES**

drawing no:

**A 2.0**

RELEASED FOR CONSTRUCTION

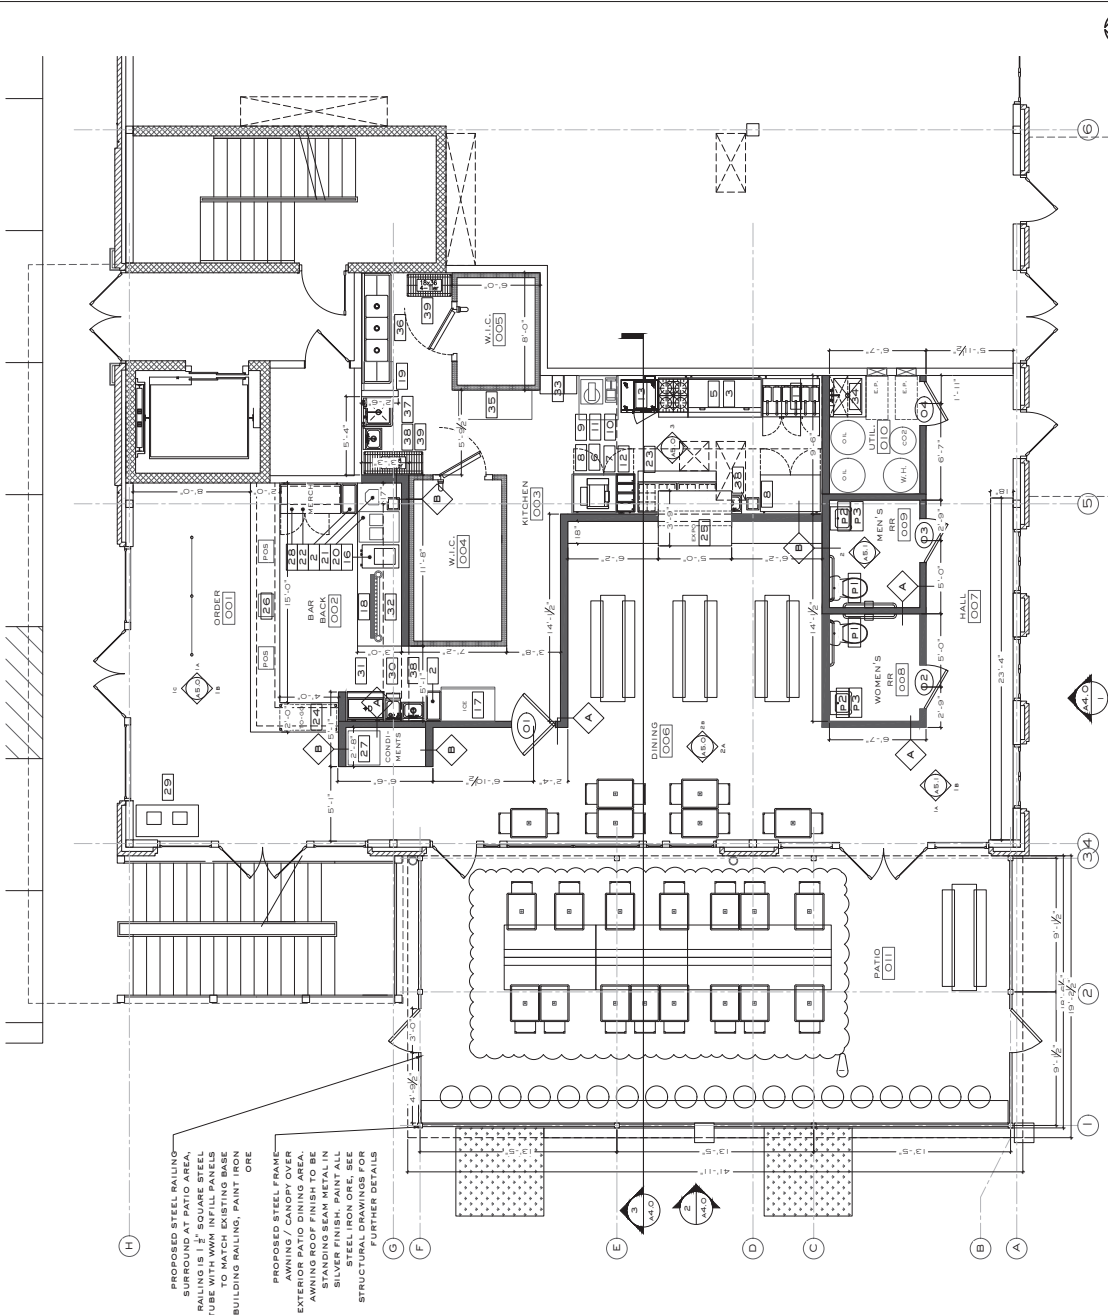

PROPOSED STEEL RAILING  
 SURROUNDING PATIO DINING AREA.  
 RAILING TO BE 42" HIGH WITH 4" DIA.  
 TUBE WITH W/M INFILL PANELS  
 TO MATCH EXISTING BASE  
 BUILDING RAILING, PAINT IRON  
 ONE

PROPOSED STEEL FRAME  
 AWNING / CANOPY OVER  
 EXTERIOR PATIO DINING AREA.  
 AWNING TO BE 10' HIGH WITH  
 STANDING SEAM METAL IN  
 SILVER FINISH. PAINT ALL  
 STEEL IRON ORE. SEE  
 STRUCTURAL DRAWING FOR  
 FURTHER DETAILS

- LEGEND:**  
 SCALE: 1/4" = 1'-0"
- (90) x ELEVATION TAG
  - DOOR TAG. SEE SCHEDULES
  - WINDOW TAG. SEE SCHEDULES
  - EQUIPMENT TAG. SEE MEP SHEETS
  - WALL TYPE TAG. SEE SCHEDULES
  - FLOOR FINISH TRANSITION. PROVIDE THRESHOLD AS REQUIRED
- SHEET NOTES:**  
 SCALE: NTS
- A. REF. SHEET E2.0 FOR REFLECTED CEILING PLAN AND LIGHT FIXTURE SCHEDULE. EXISTING UNDERSIDE OF METAL DECKING TO REMAIN EXPOSED IN FRONT OF HOUSE AREAS AND NEW DROPPED CEILING AT 10' AFF IN PREP KITCHEN. ALL LIGHTING SHOWN ON E2.0.
  - B. REF. SHEET E2.0 FOR ALL DOOR, PARTITION AND FINISH SCHEDULES.
  - C. REFERENCE ELECTRICAL, MECHANICAL AND PLUMBING ENGINEER SHEETS FOR ALL PLUMBING, ELECTRICAL, MECHANICAL AND KITCHEN EQUIPMENT SCHEDULES AND SPECS.
  - D. PROVIDE BLOCKING IN CEILING AND/OR WALLS AS REQUIRED FOR CEILING / WALL MOUNTED MILLWORK, EQUIPMENT.
  - E. REF. SHEET E2.0 & A3.0 FOR CEILING AND LIGHTING INFORMATION.
  - F. REFERENCE ELEVATIONS ON A.40 & A50 SHEETS FOR MORE INFORMATION.
  - G. PROVIDE THRESHOLD TRANSITIONS AS REQUIRED. THRESHOLDS TO NOT CHANGE IN HEIGHT MORE THAN 3/8" PER ADA.
  - H. FLOOR FINISHES TO EXTEND UNDERNEATH MILLWORK AND FURNITURE, TYP.

PKT	Plumbing & Restroom Accessory Fixtures Schedule	Rev
E99	Fixtures INF.	Notes/IFB: Mobiles
E100	Receptacles	
E101	Receptacles	
E102	Receptacles	
E200	Receptacles	

ITEM#	QTY	DESCRIPTION / MODEL
1	1	REFRIGERATOR - DEEP FAT, GAS WITH FILTER
2	1	SLIM JIN TRASH
3	1	GRIDDLE - HEAVY DUTY, GAS
4	1	TOASTER
5	1	72" WIDE CHEF'S BASE
6	1	36" WIDE CHEF'S BASE
7	1	U.C. REFRIGERATOR
8	1	U.C. FREEZER
9	1	20 QUART MIXER
10	1	COUNTERTOP HOT WELLS
11	1	SLANTED METRO SHELVING
12	1	U.C. BANDBACK FRIDGE
13	1	ICE MAKER
14	1	ICE TAP BEER TOWER - REMOTE KEYS
15	1	SHAKE MIXER
16	1	64" MEGA TOP SANDWICH UNIT
17	1	TO-GO OVERHEAD SHELVING
18	1	POS STATION
19	1	DISPENSER BODA
20	1	TRASH, RECYCLING & CONDIMENT STATION
21	1	BAR DUMP SINK
22	1	SHELVING OVER BAR BACK
23	1	EMPLOYEE LOCKERS
24	1	SS WORK TABLE
25	1	3 COMPARTMENT SINK
26	1	HAND SINK
27	1	METRO SHELVING
28	1	
29	1	
30	1	
31	1	
32	1	
33	1	
34	1	
35	1	
36	1	
37	1	
38	1	
39	1	