

Michael Morel
architect

14080 Mahogany Avenue
Jacksonville, Florida
32258
(561) 758 8454
memorel@outlook.com

Michael Morel
Massachusetts Architect
31840

2C Partners, LLC
145 Taylor Street
Littleton, Massachusetts

Revisions:

Content:
Floor Plan


Dwg:

Date: **11/30/23**

Proj. No. **2310**

Sheet No.

A2.1

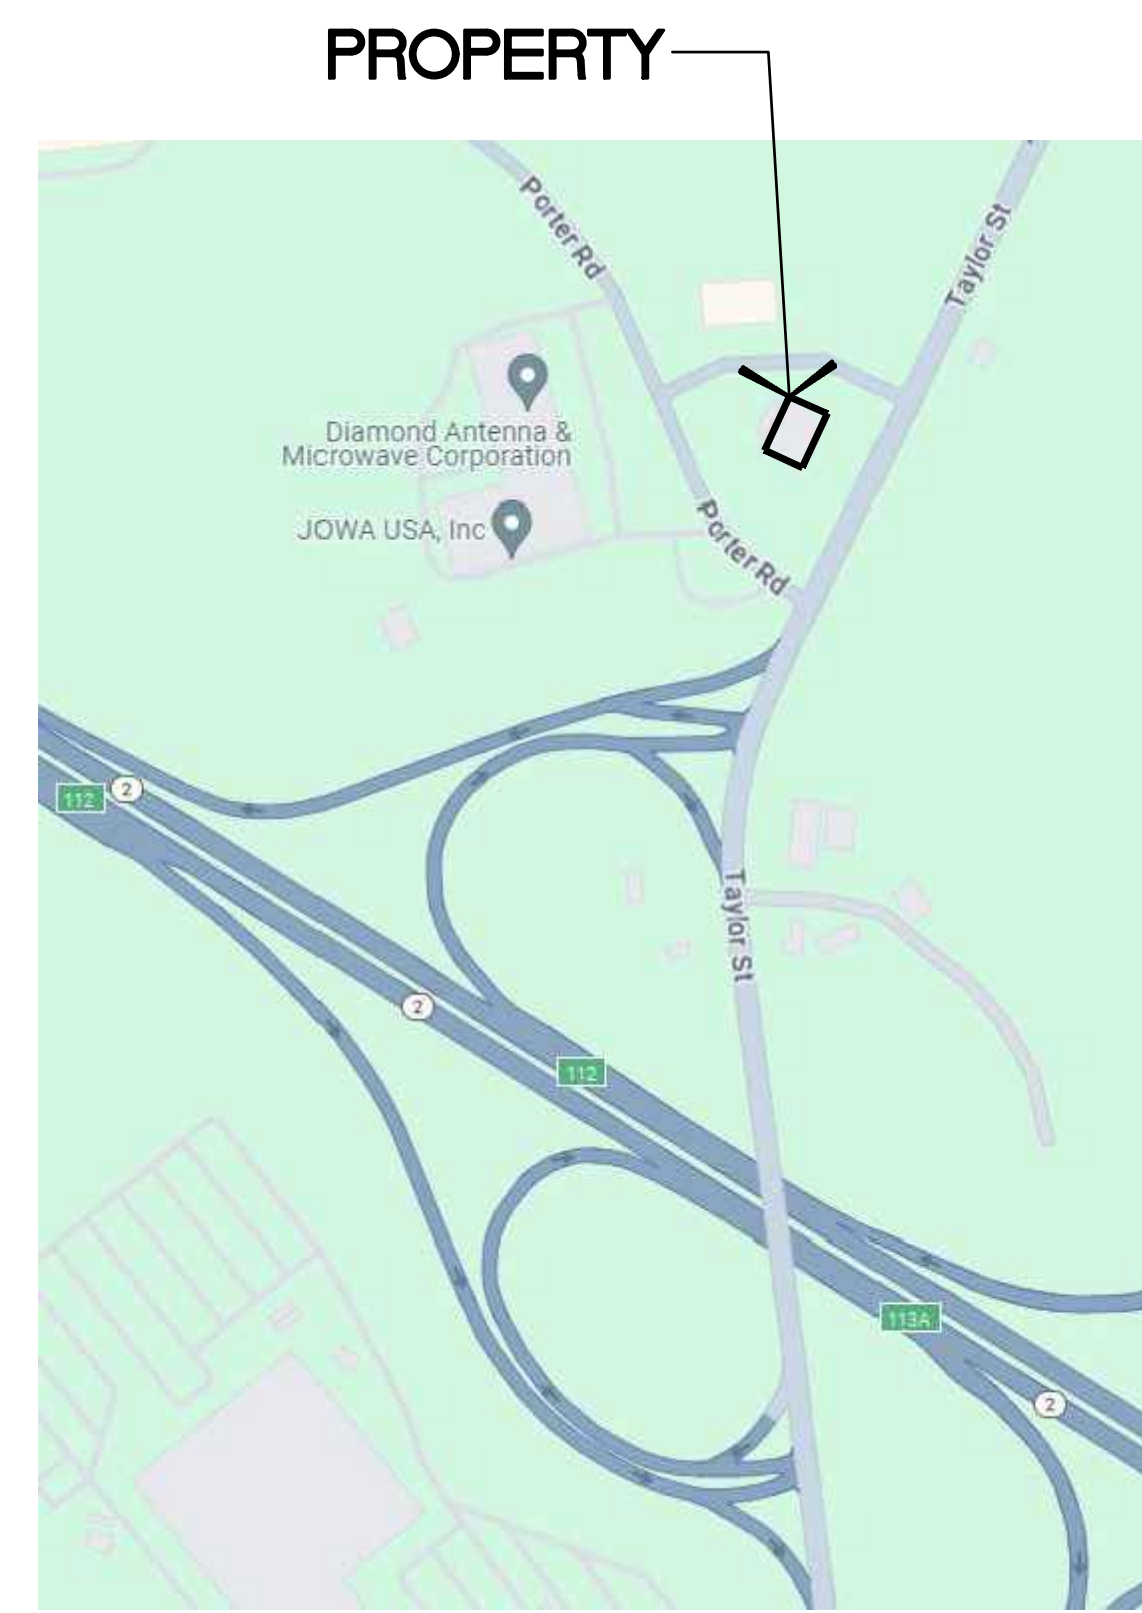

PROPERTY


PROPERTY LOCATION
NTS

GENERAL PROPERTY INFORMATION

LOCATION: 145 TAYLOR STREET, LITTLETON, MA
ACRES: 138
ZONING: IA

GENERAL BUILDING INFORMATION

GROSS BUILDING AREA: 6,000 SF
FINISHED BUILDING AREA: 6,000 SF
NON-SPRINKLERED
FIRE ALARM SYSTEM

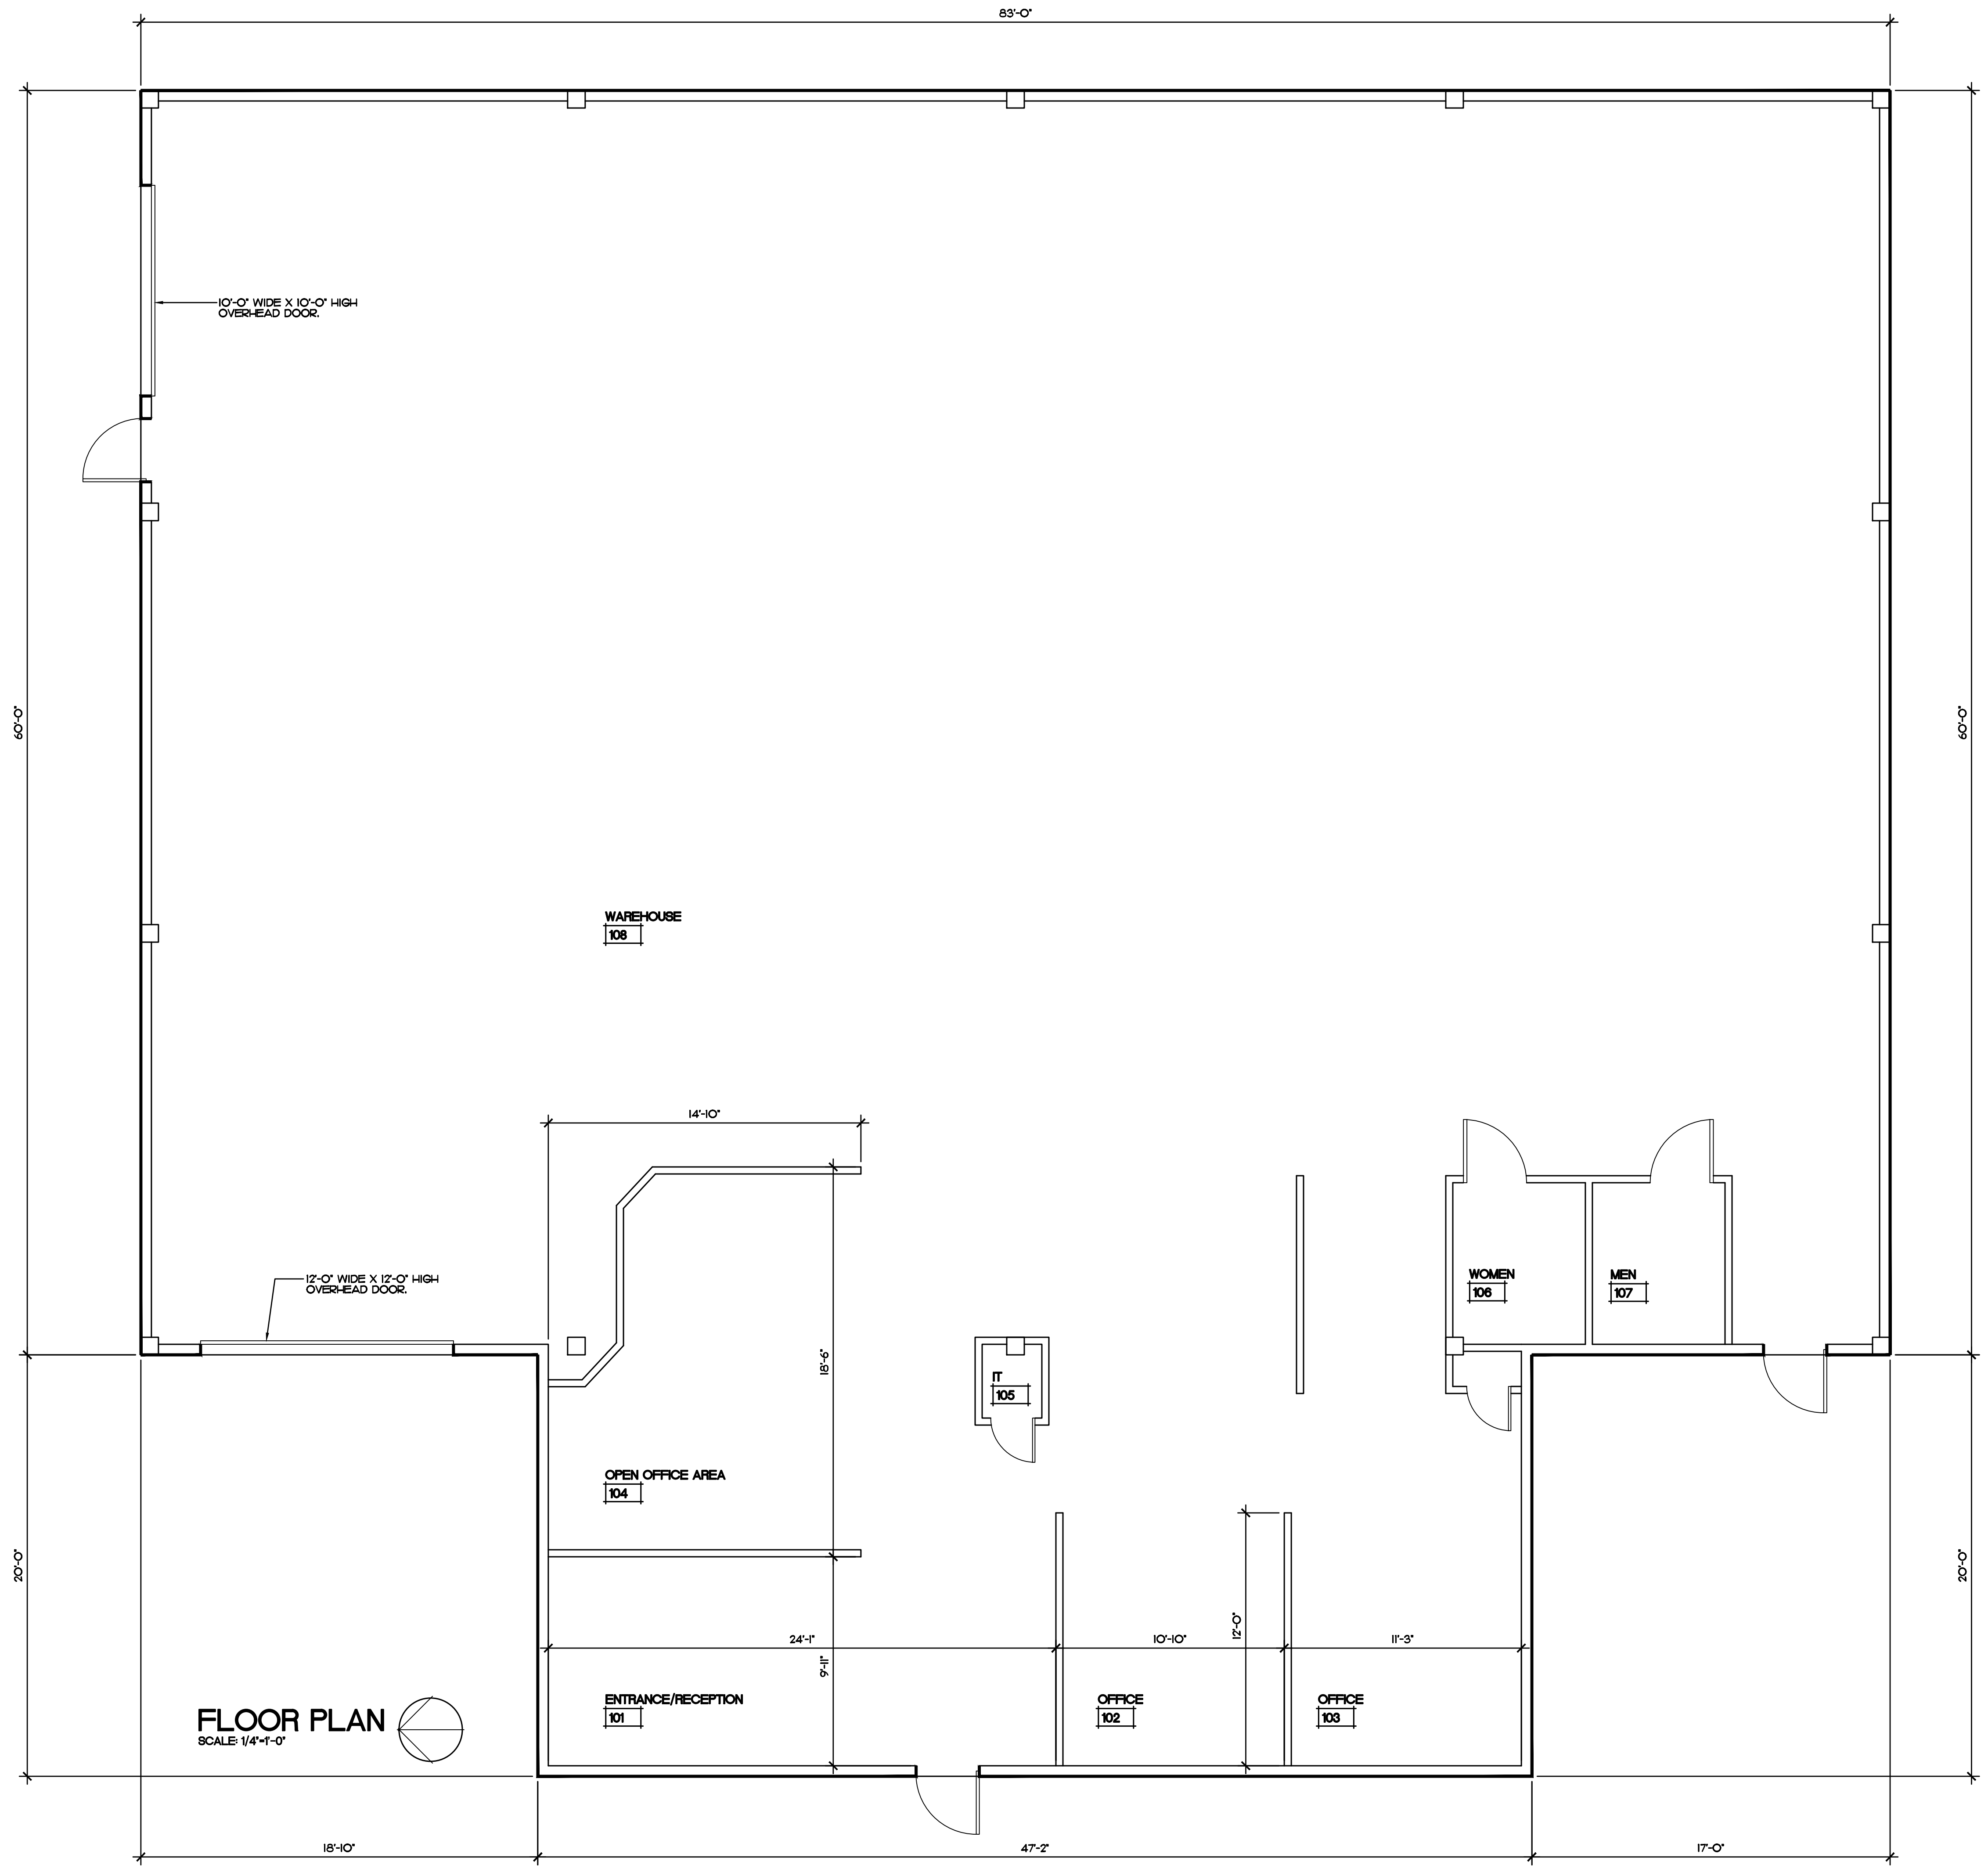

FLOOR PLAN
SCALE: 1/4"=1'-0"

