

FG - Full Glass
F - Flush
L - Louver
HM - Hollow Metal
ALUM - Aluminum

MIRROR OR MEDICINE CABINET

WALL MOUNTED LAVATORY

REQUIRED CLEARANCES

FINISHED FLOOR BELOW


3'-4"

1'-6" MAX.


9"

1'-0" to 1'-11"


2 H/C Accessible Lavatory
A3 Scale: 1/2"=1'-0"

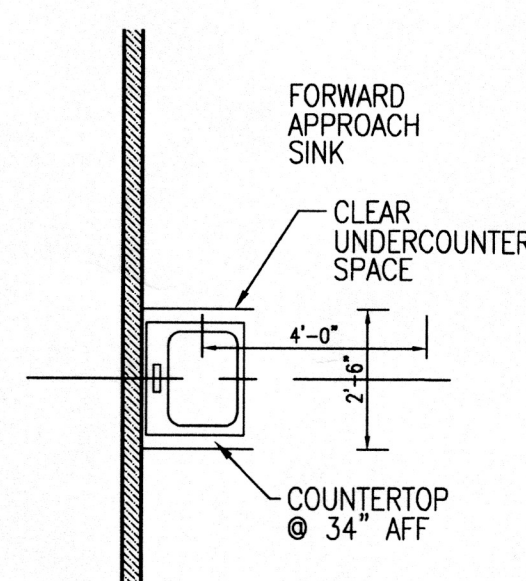


5 Typical Pantry Sink Detail

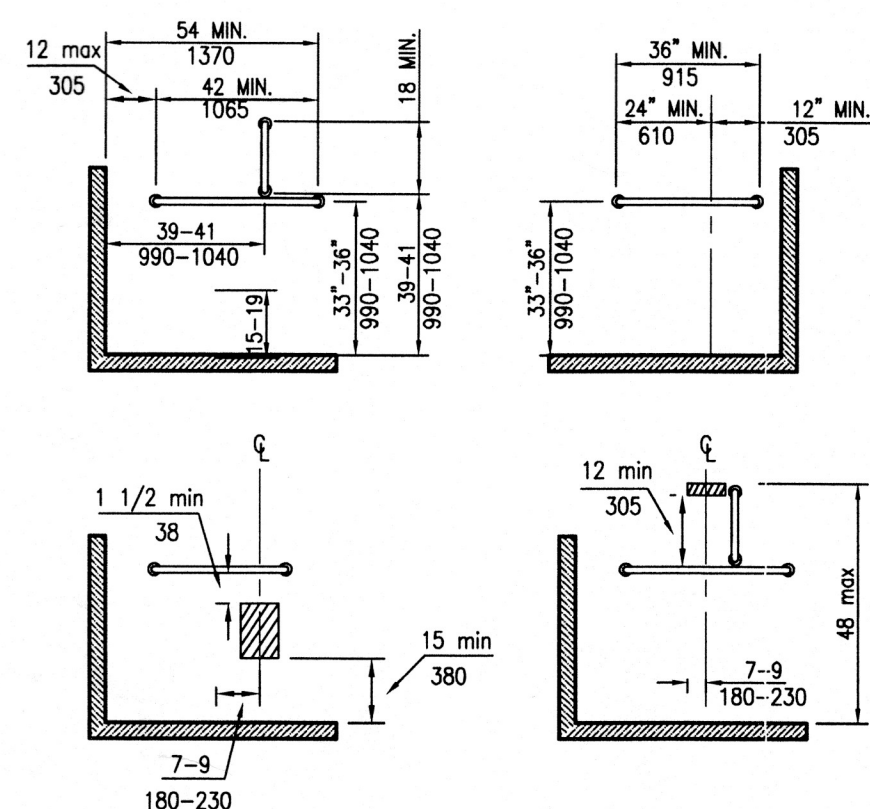

3 H/C Accessible Toilet
A3 Scale: NTS

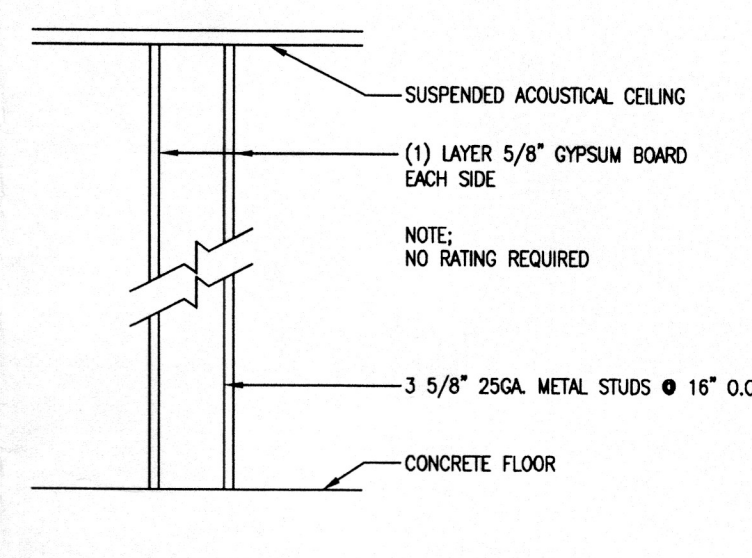


6 Typical Interior Wall
A3 Scale: Not to Scale

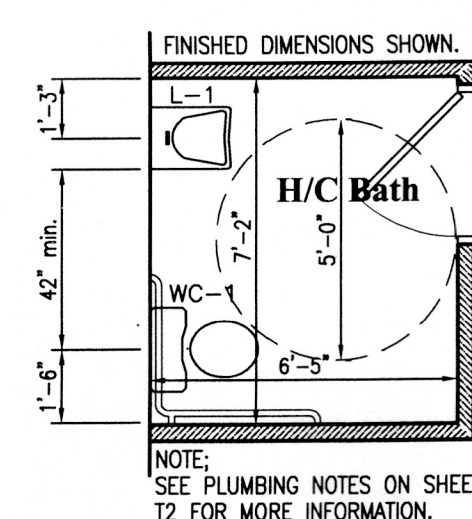

4 Typical H/C Bath
A3 Scale: 1/4"=1'-0"

HARDWARE SCHEDULE

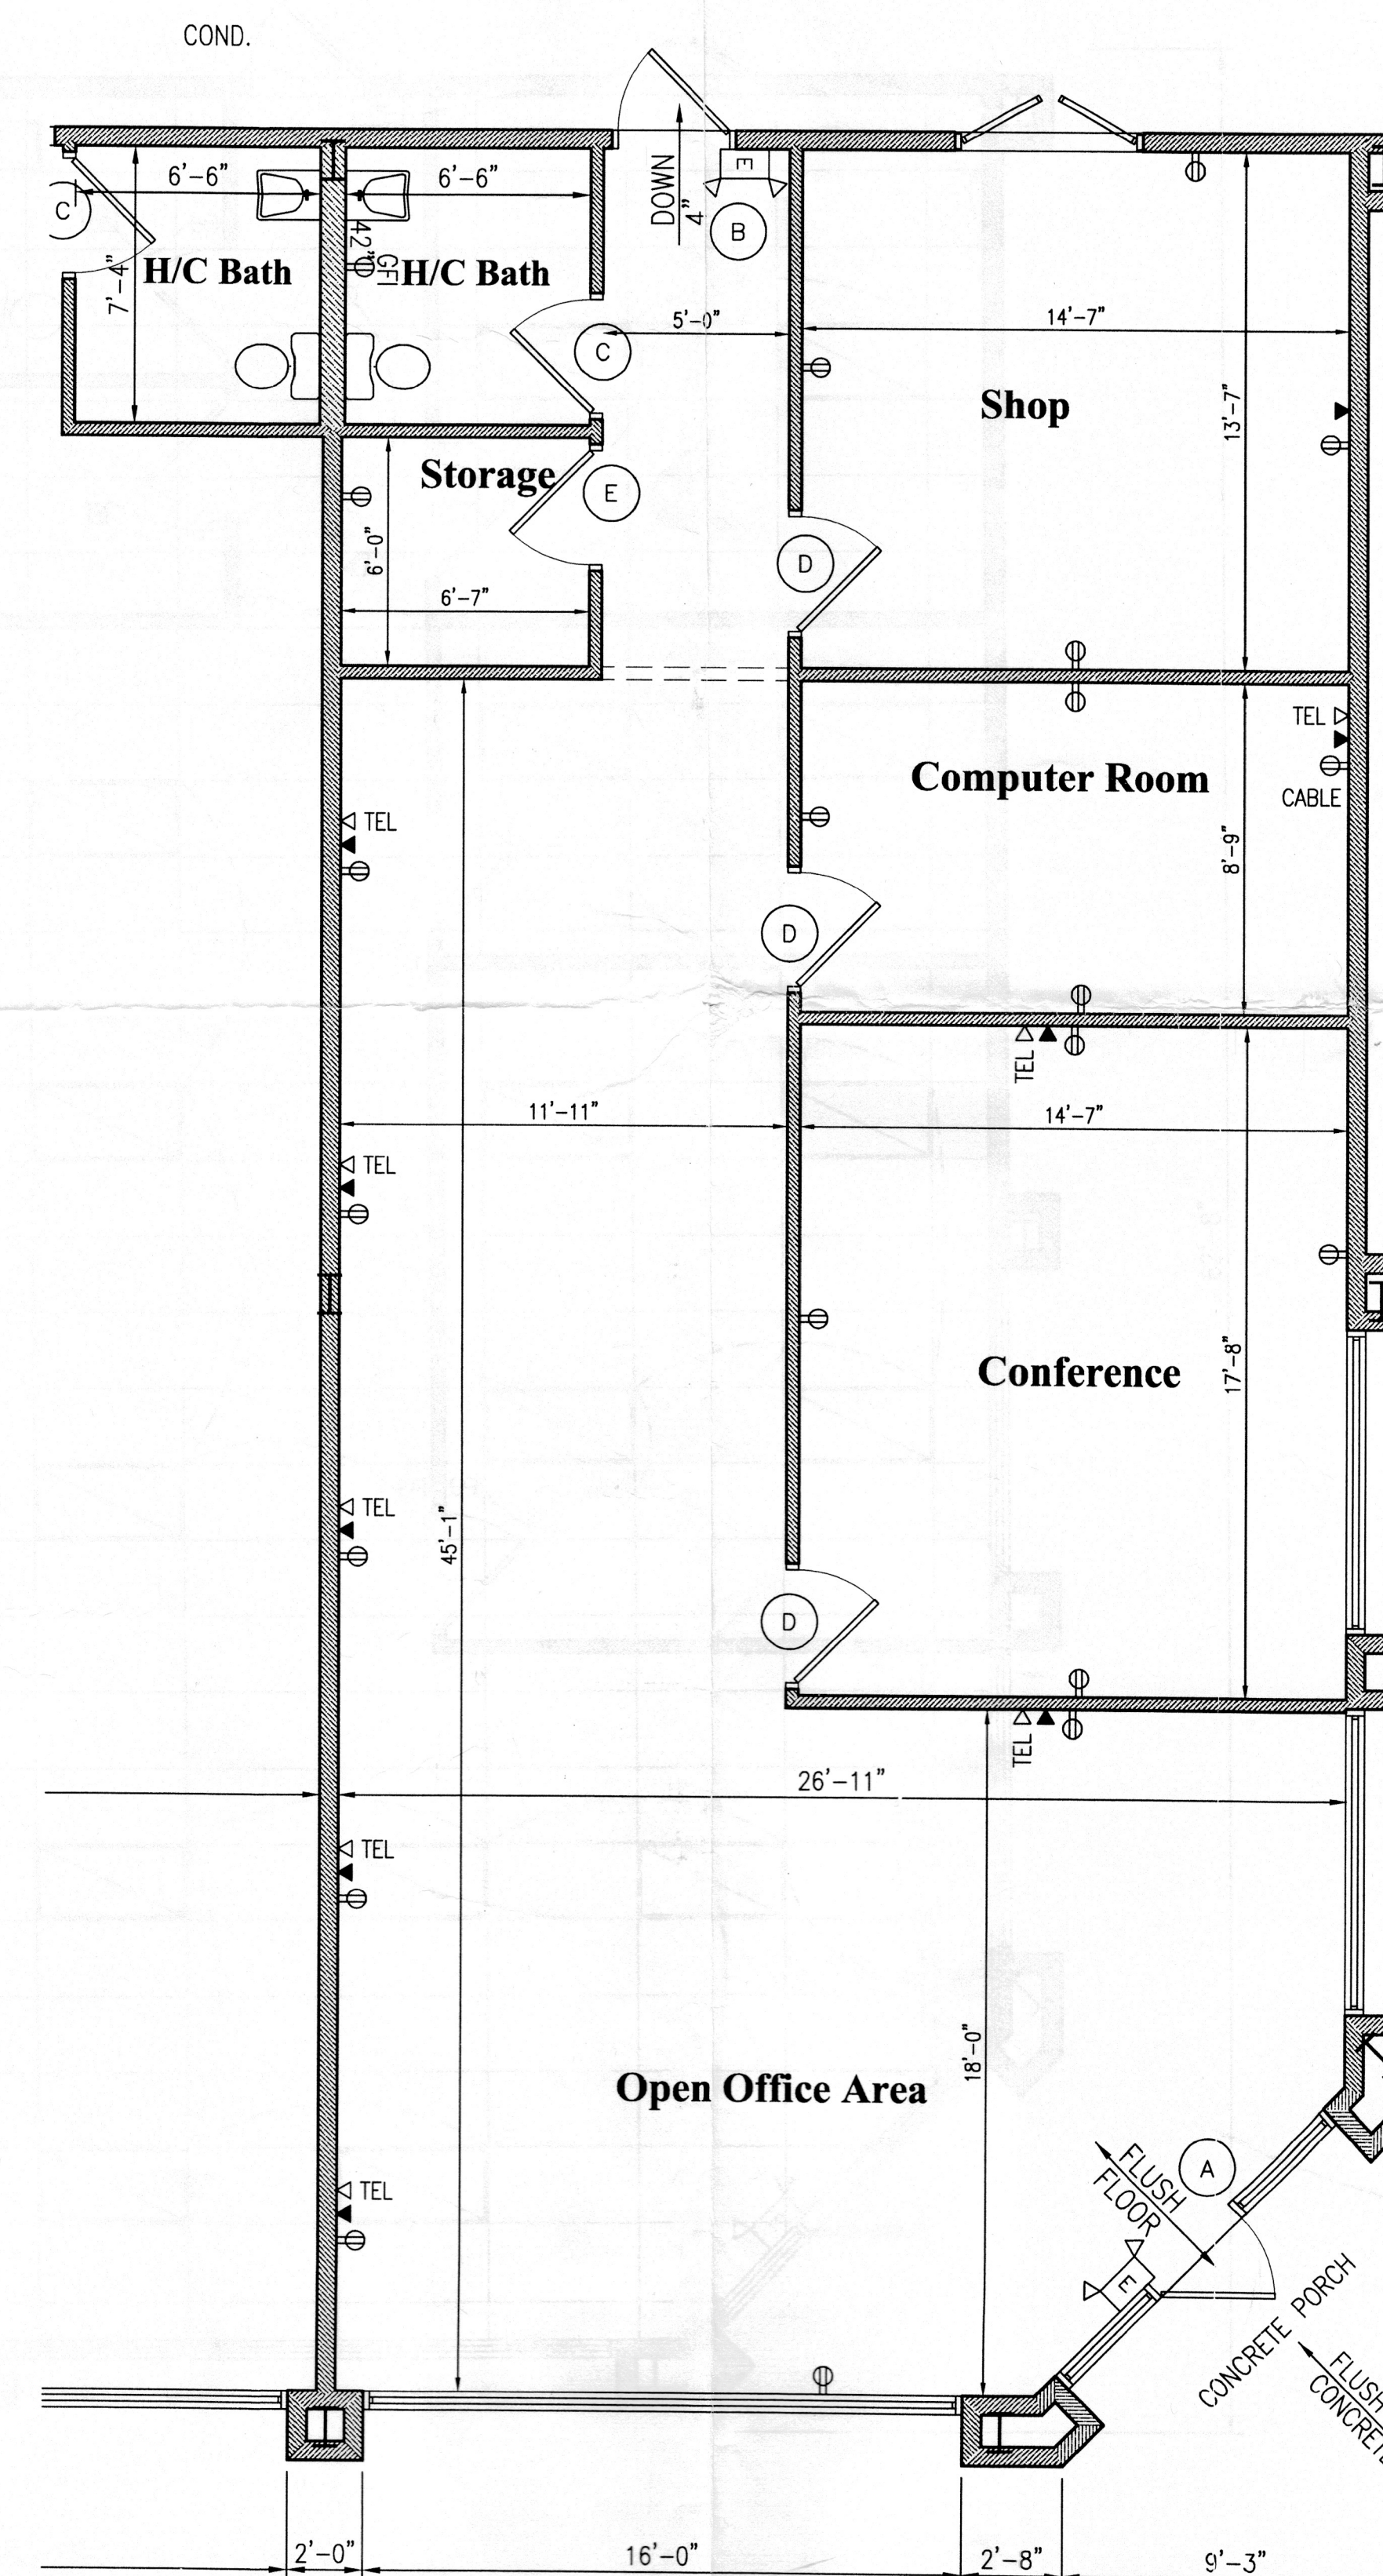[illegible]

5 Partial First Floor Fit-Up Plan
A3 Scale: 1/4"=1'-0"

ELECTRICAL LEGEND

-  - SINGLE POLE LIGHT SWITCH
-  - 3 WAY LIGHT SWITCH
-  - DUPLEX RECEPTACLE
-  - RJ11 telephone jack with wiring. Terminates in the Computer Room
-  - Cat 6 RJ45 jacks with wiring. All Cat 6 wiring terminates in the Computer Room
-  - 75 WATT INCANDESCENT LIGHT FIXTURE,
-  - INCANDESCENT LIGHT FIXTURE WITH CEILING MOUNTED FAN
-  - EXIT SIGN/EMERGENCY LIGHT
-  - TRANSLUCENT PLASTIC W/ RED LETTERS, WHITE BACKGROUND BATTERY - NICKEL CADMIUM
-  - EMERGENCY POWER SUPPLY
-  - UL TESTED
-  - 24x48 RECESSED FLOURESCENT LIGHT
-  - 24x24 RECESSED FLOURESCENT LIGHT

NOTES;
ALL EXTERIOR LIGHTING TO BE PHOTOCELL CONTROLLED
COMMON INTERIOR LIGHTING TO BE SWITCHED AT ENTRY
24 HOUR LIGHTING FIXTURES TO BE DETERMINED BY OWNER

COPPOLA ASSOCIATES

°Design, Architecture & Planning°

**3 Washington Center
Second Floor
Newburgh, NY 12550
TEL: 845-561-3559
FAX: 845-561-2051
ajcoppola@coppola-associates.com**



**NEW OFFICE BUILDING FOR
POUGHKEEPSIE PROPERTIES, LLC**

117 Executive Drive

**TOWN OF NEW
WINDSOR, NEW YORK**

Partial 1st Floor Fit-up Plan

REVISIONS

DATE _____

8/18/09

PROJECT NUMBER _____

08-23

SHEET NUMBER

A3