


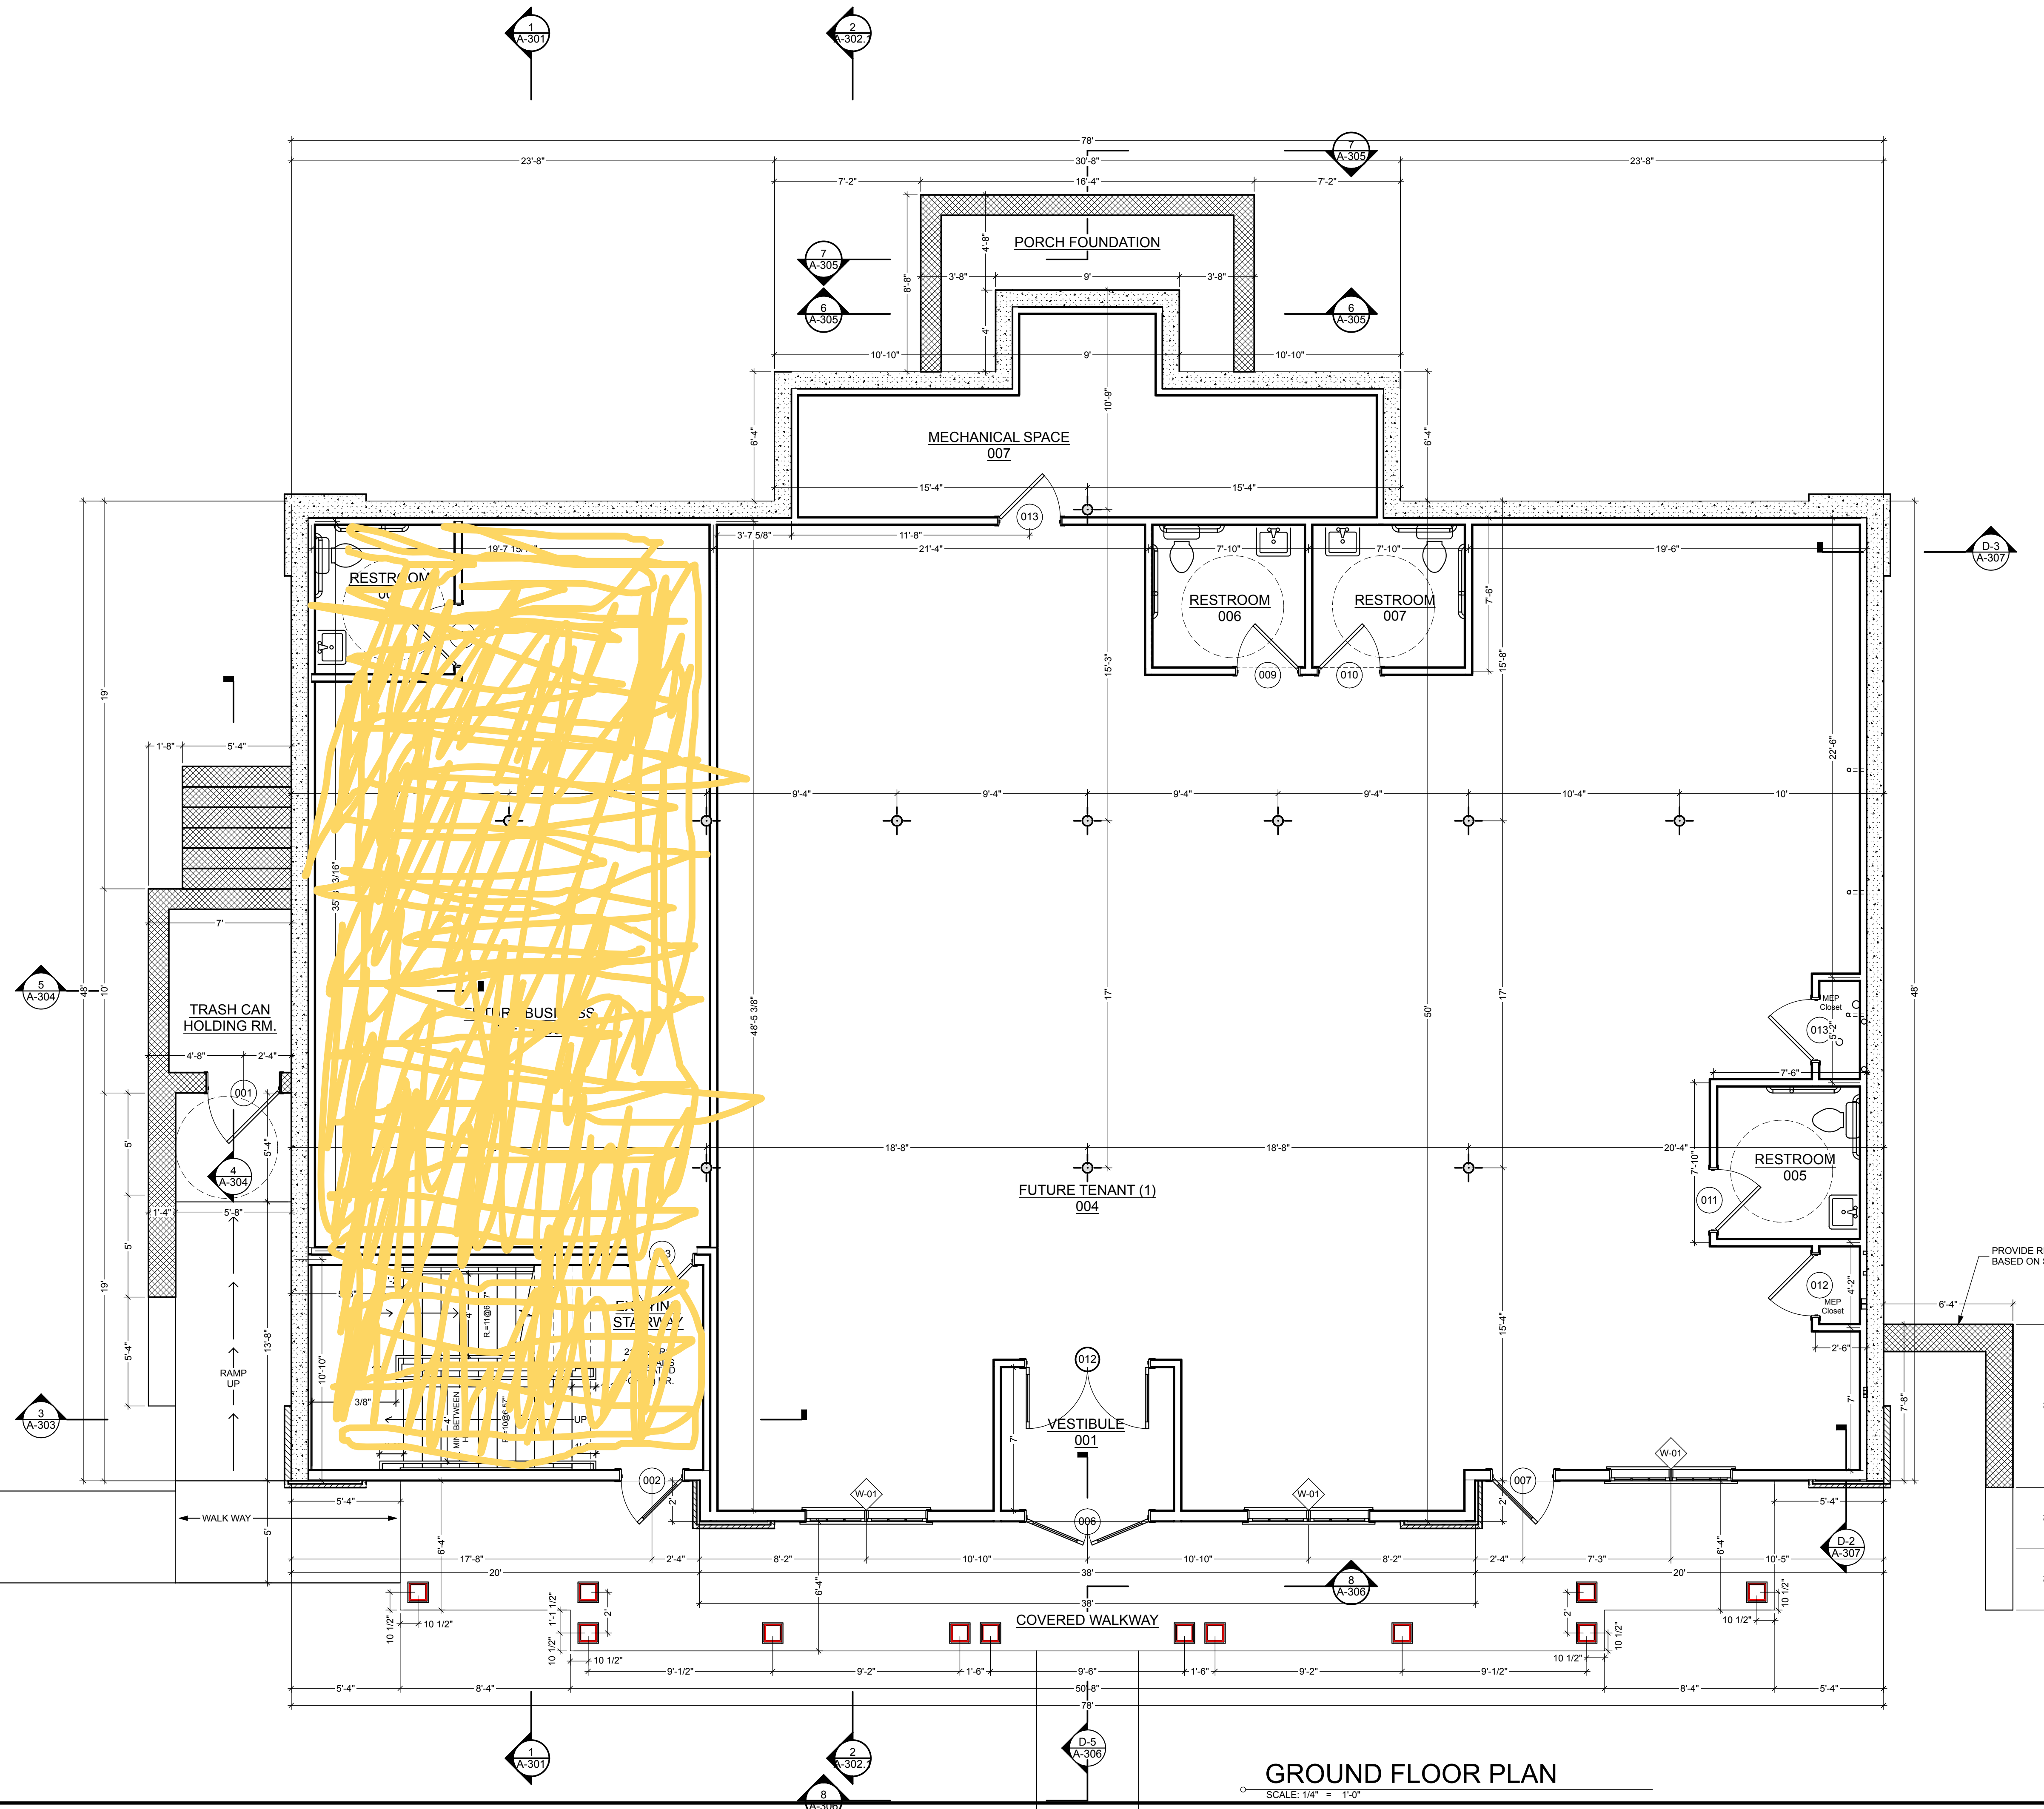

GROUND FLOOR PLAN

DRAWINGS ARE DESIGN-DEVELOPMENT
AND NOT FOR CONSTRUCTION.

Design VISION INC.
4593 Stuarts Draft Hwy.
Waynesboro, VA 22980
PHONE (540) 949-7766
FAX (540) 949-7850

Vision Tech Optometry Center
Osage Ln
Waynesboro, Virginia

SCALE: 1/4" = 1'-0"
DATE: 05-05-2017
REV. (1): 10-05-2017
DRAWING TITLE:
DRAWN: SPH
CHECKED: THV
CAD FILE:
VisionTechOptContr-240404-Rev2.pln

PROJECT NUMBER:
SHEET NUMBER:
A-100
PAGE
11 OF 40