


Sample 1Ø Panel Schedule													
PANEL NO. C		SECTION: OF		Bus: 120/208		Main C.B.		AMP					
Location: 14468A		Serving: 1Ø 3 Wire		AMP		Main Lugs Only							
A.I.C. Rating 14468A		Feed Thru Lugs		SubFeed Lugs		Iso. Gnd. Bus		Flush Mount		Top Feed		Bottom Feed	
Fully Rated		Series Rated		SubFeed Lugs		Iso. Gnd. Bus		Surface Mount		Top Feed		Bottom Feed	
Load Type	Circuit Description	CONN KVA	AMP	Pole	CKT	PH	CKT	Pole	AMP	CONN KVA	Circuit Description	Load Type	
Lighting	Dining Room	1080	20	1	1	A	2	1	20	840	Lighting	Kitchen	
Exterior	Lighting	840	20	1	3	B	4	1	20	1440	Ex. Dining Receptacles		
Counter	POS/Cooler	1560	20	1	5	A	6	1	20	1920	Soft Serve Machine		
Hot Water	Dispenser	2040	20	1	7	B	8	1	20	1320	Soda Machine/Carb.		
Pizza Prep/Adv	Freeze	1800	20	1	9	A	10	1	20	360	Lemonade Machine		
Metro Proofer		1440	20	1	11	B	12	2	60	5880	Combination Oven		
Metro Proofer		1440	20	1	13	A	14	1		5880			
D.T. POS/Lemonade		960	20	1	15	B	16	2	30	2760	Convection Oven		
D. T. Soda Machine		1200	20	1	17	A	18			2760			
Holding Cabinet		2064	20	1	19	B	20	1	20	1320	Hot Steam Well		
Holding Cabinet		2064	20	1	21	A	22	1	20	1320	Hot Steam Well		
Warming Shelf		168	20	2	23	B	24	1	20	1344	Air Fry Station		
		168			25	A	26	1	20	1320	Exhaust Fan		
Advantco Fridge		312	20	1	27	B	28	1	20	1080	Gas Fryer		
Menu Boards		1920	20	1	29	A	30	1	20	612	Building Signs		
Multi Product Holding		1800	20	1	31	B	32	1	20		Hood		
Space					33	A	34	1	20		Ex. Gen. Purpose Plug		
Space					35	B	36						
Space					37	A	38						
Space					39	B	40						
Space					41	A	42						

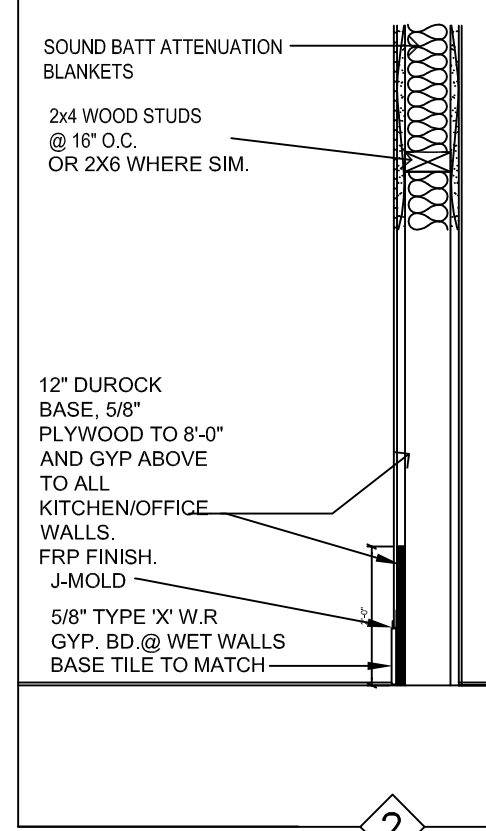

2 TYPICAL THROUGH OUT ENTIRE KITCHEN AREA


GENERAL NOTES

- CONTRACTORS SHALL NOT SCALE THESE DRAWINGS FOR CONSTRUCTION PURPOSES. IN THE EVENT OF OMISSION OF NECESSARY DIMENSIONS THE CONTRACTORS SHALL NOTIFY THE ARCHITECT AND/OR ENGINEER(S).
- VERIFY ALL DIMENSIONS, CONDITIONS, AND GRADES AT JOB SITE PRIOR TO COMMENCING WORK.
- VERIFY SIZE, LOCATION, AND CHARACTERISTICS OF ALL WORK AND EQUIPMENT TO BE FURNISHED BY OWNER OR OTHERS, WITH THE MANUFACTURER OR SUPPLIER BEFORE ANY CONSTRUCTION PERTAINING TO SAME IS BEGUN.
- VERIFY SIZE AND LOCATION OF ALL OPENINGS FOR MECHANICAL EQUIPMENT AND WORK WITH CONTRACTORS INVOLVED.
- ERRORS AND/OR OMISSIONS IN ROOM, DOOR, AND WINDOW SCHEDULES DO NOT RELIEVE THE CONTRACTOR FROM EXECUTING WORK SHOWN ON DRAWINGS OR DESCRIBED IN SPECIFICATIONS.
- ALL EXPOSED CONDUIT/PIPE/ETC. INSIDE OR OUTSIDE OF STORE TO BE PAINTED.
- LED LIGHTS PROVIDED AND INSTALLED BY STARLITE SIGNS.
- THE MENU BOARD SUPPLIED AND INSTALLED BY STARLITE SIGNS. CONTRACTOR TO PROVIDE FOOTINGS.
- ALL EQUIPMENT IN THE EQUIPMENT SCHEDULE IS SUPPLIED AND INSTALLED BY KITCHEN EQUIPMENT SUPPLIER EXCEPT WHERE NOTED OTHERWISE. (HVAC CONTRACTOR TO INSTALL CURBS, MAKE UP AIR, AIR EXHAUST AND HOOD AS WELL AS EXHAUST AND MAKE UP DUCTWORK ABOVE CEILING AND TO THE HOOD. FINAL ELECTRICAL AND PLUMBING CONNECTIONS BY MAIN CONTRACTOR. KES TO PROVIDE PRESSURE TREATED SUPPORTS FOR ROOF TOP EQUIPMENT. SUPPORTS TO RUN IN DIRECTION OF WATER FLOW.



MISC. WALL TYPE NOTES:

- ALL DIMENSIONS ON PLANS UNLESS OTHERWISE NOTED ARE TO FACE OF GYPSUM BOARD TO FACE OF GYPSUM BOARD AND FROM FACE OF INTERIOR FINISH SURFACE TO FACE OF EXTERIOR FINISH SURFACE.
- FRAMER SHALL ALLOW FOR DRYWALL, CORNER BEADS, AND FRP PANELS FOR PROPER FINISHED DIMENSIONS REQUIRED AT CRITICAL DIMENSIONS TO INSTALL EQUIPMENT.

ALL HVAC IS EXISTING
WALK-INS ARE EXISTING

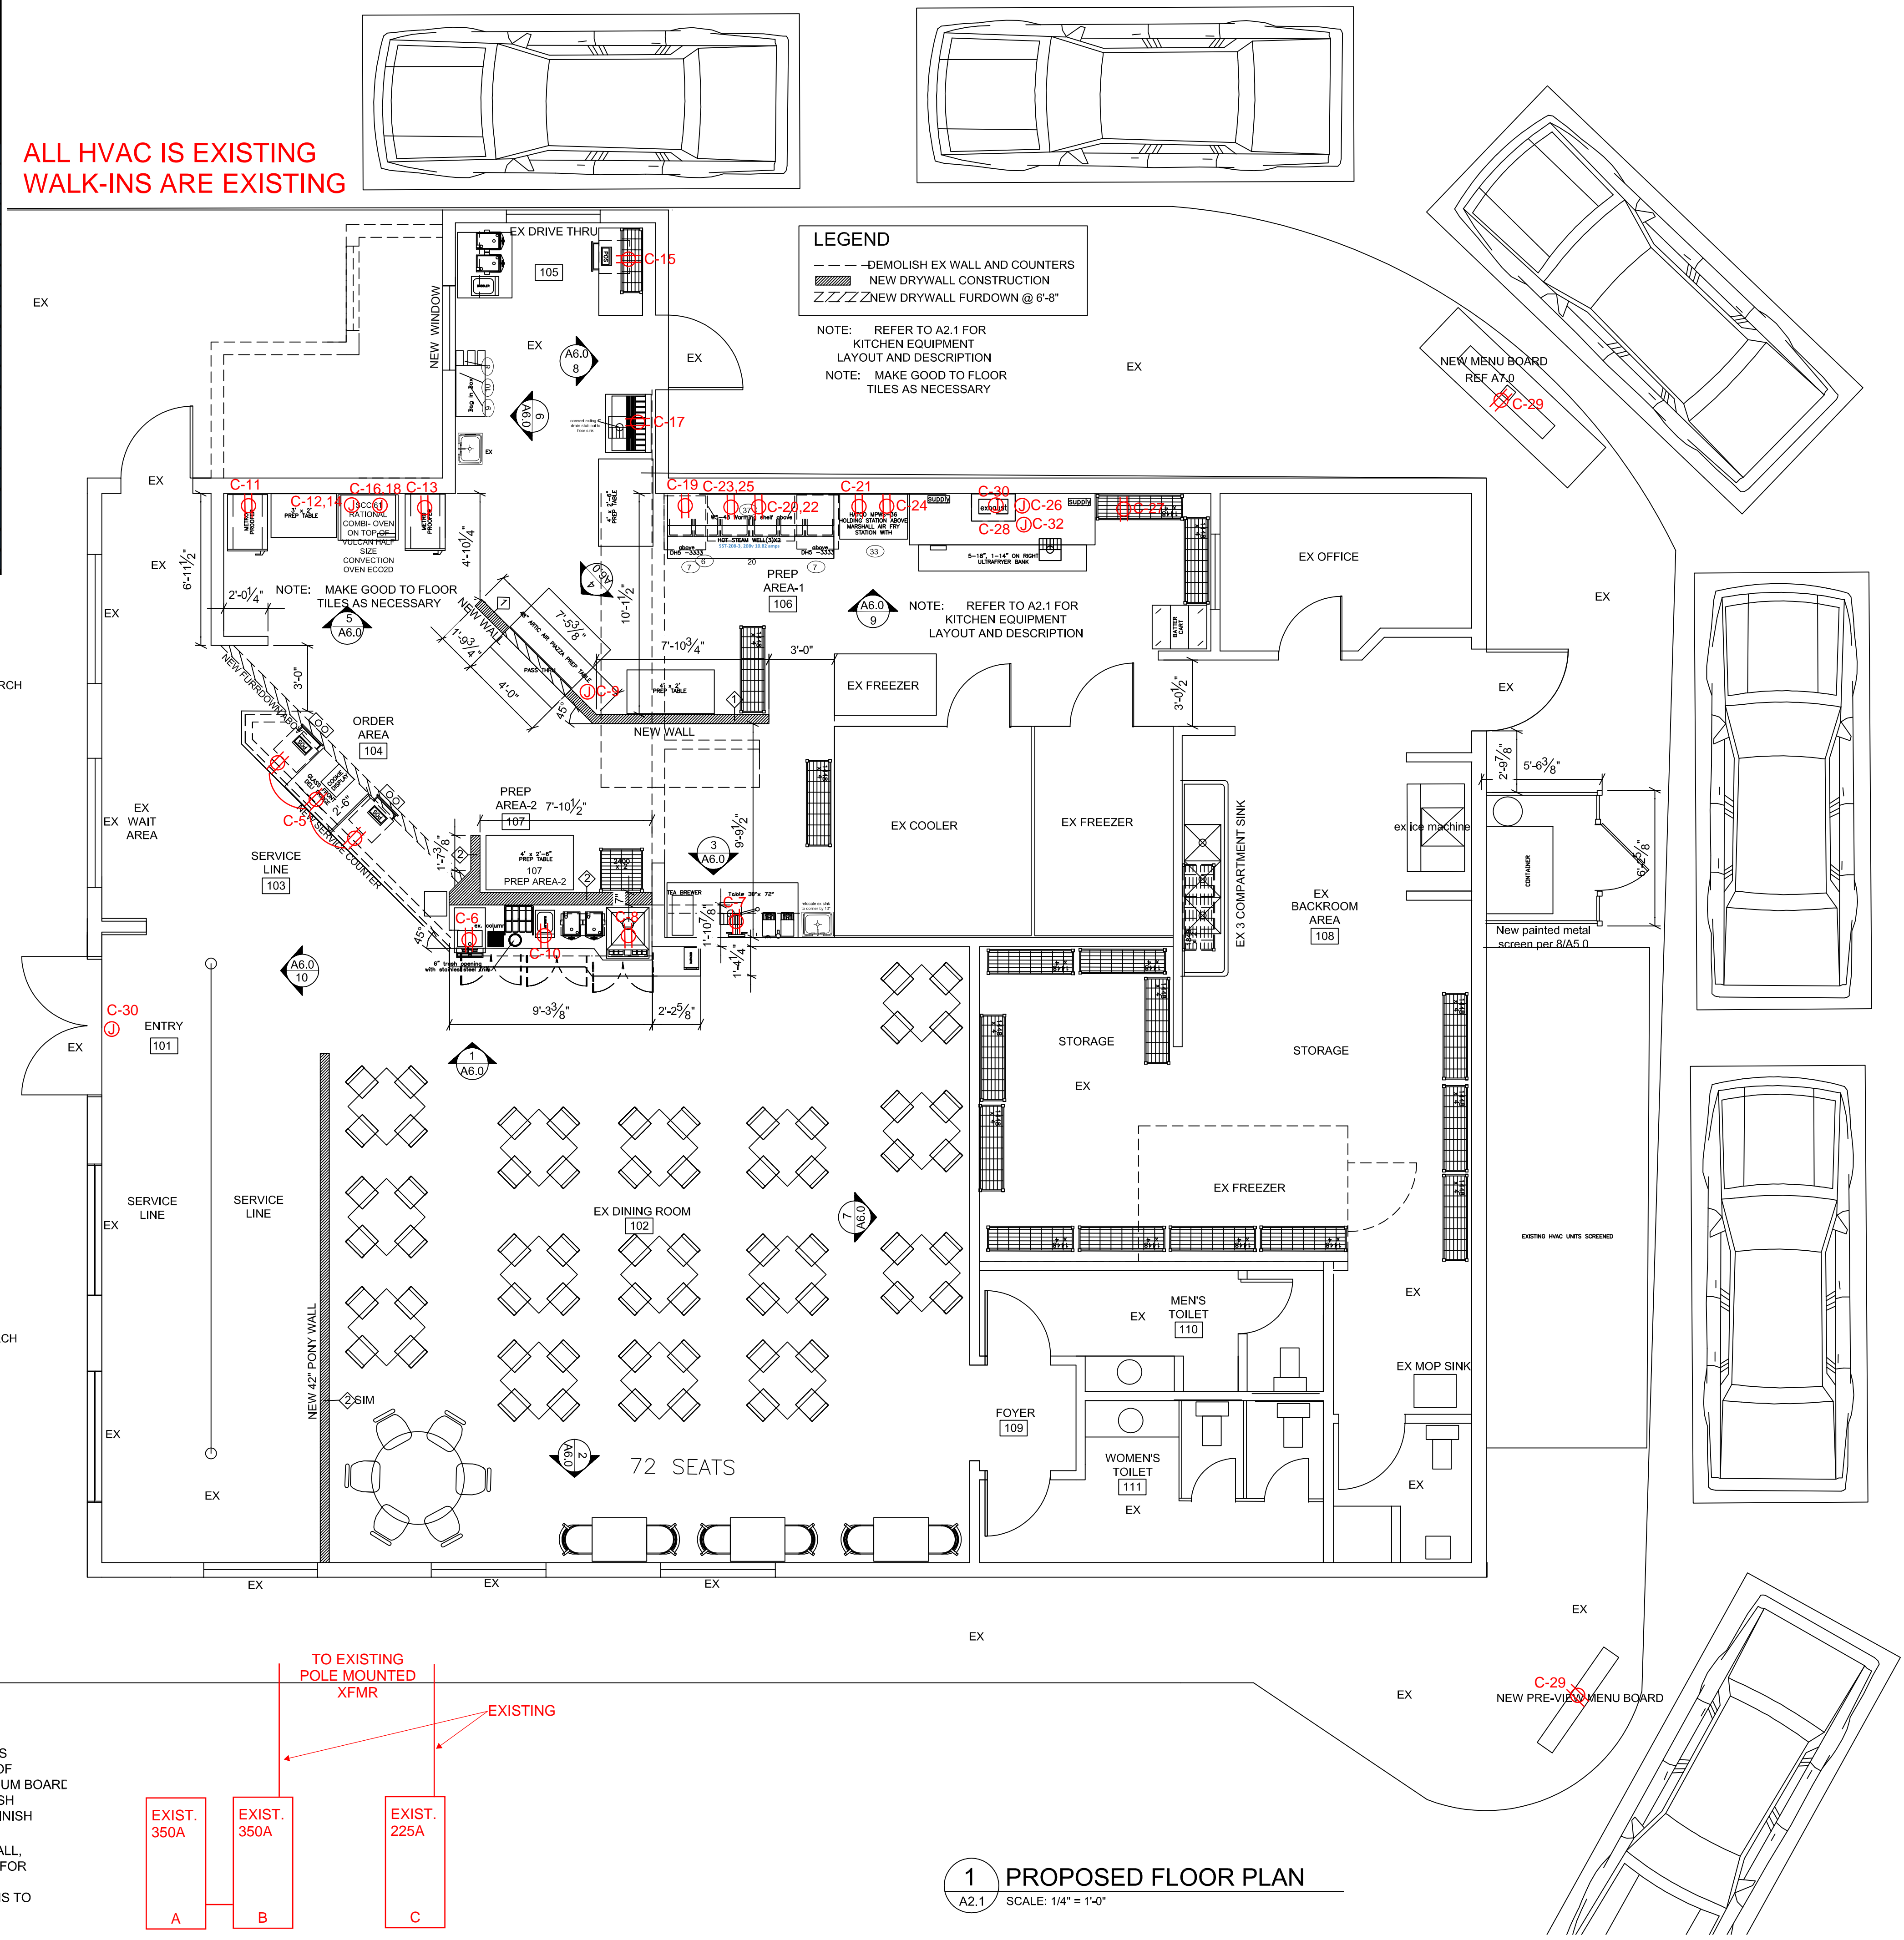

1 PROPOSED FLOOR PLAN
A2.1 SCALE: 1/4" = 1'-0"

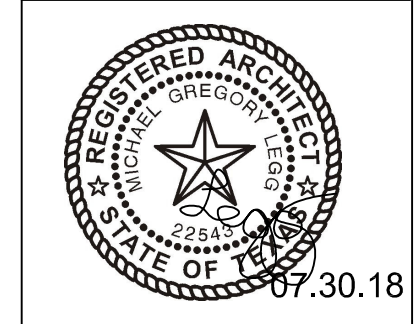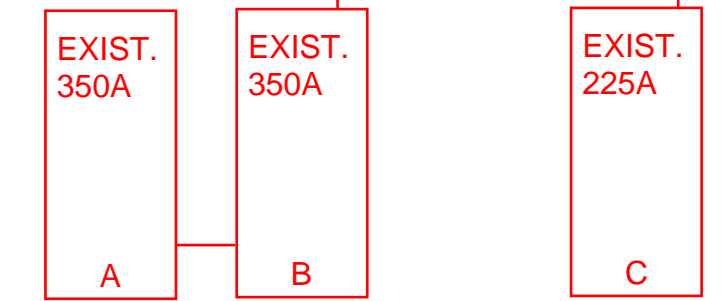

DRAWING COORDINATION
Architectural, Landscape, Civil, Structural, Mechanical and Electrical drawings are interrelated. General Contractor and all Sub Contractors shall review and coordinate the entire set of drawings and specifications.

FLOOR PLAN
GOLDEN CHICK RESTAURANT REMODEL
AT 18TH STREET AND HWY I-35
WACO, TX

DATE	DESCRIPTION	BY
Rev 01		

SCALE:
AS NOTED
PROJECT NO.
01-12-17
SHEET NO.
A2.0