


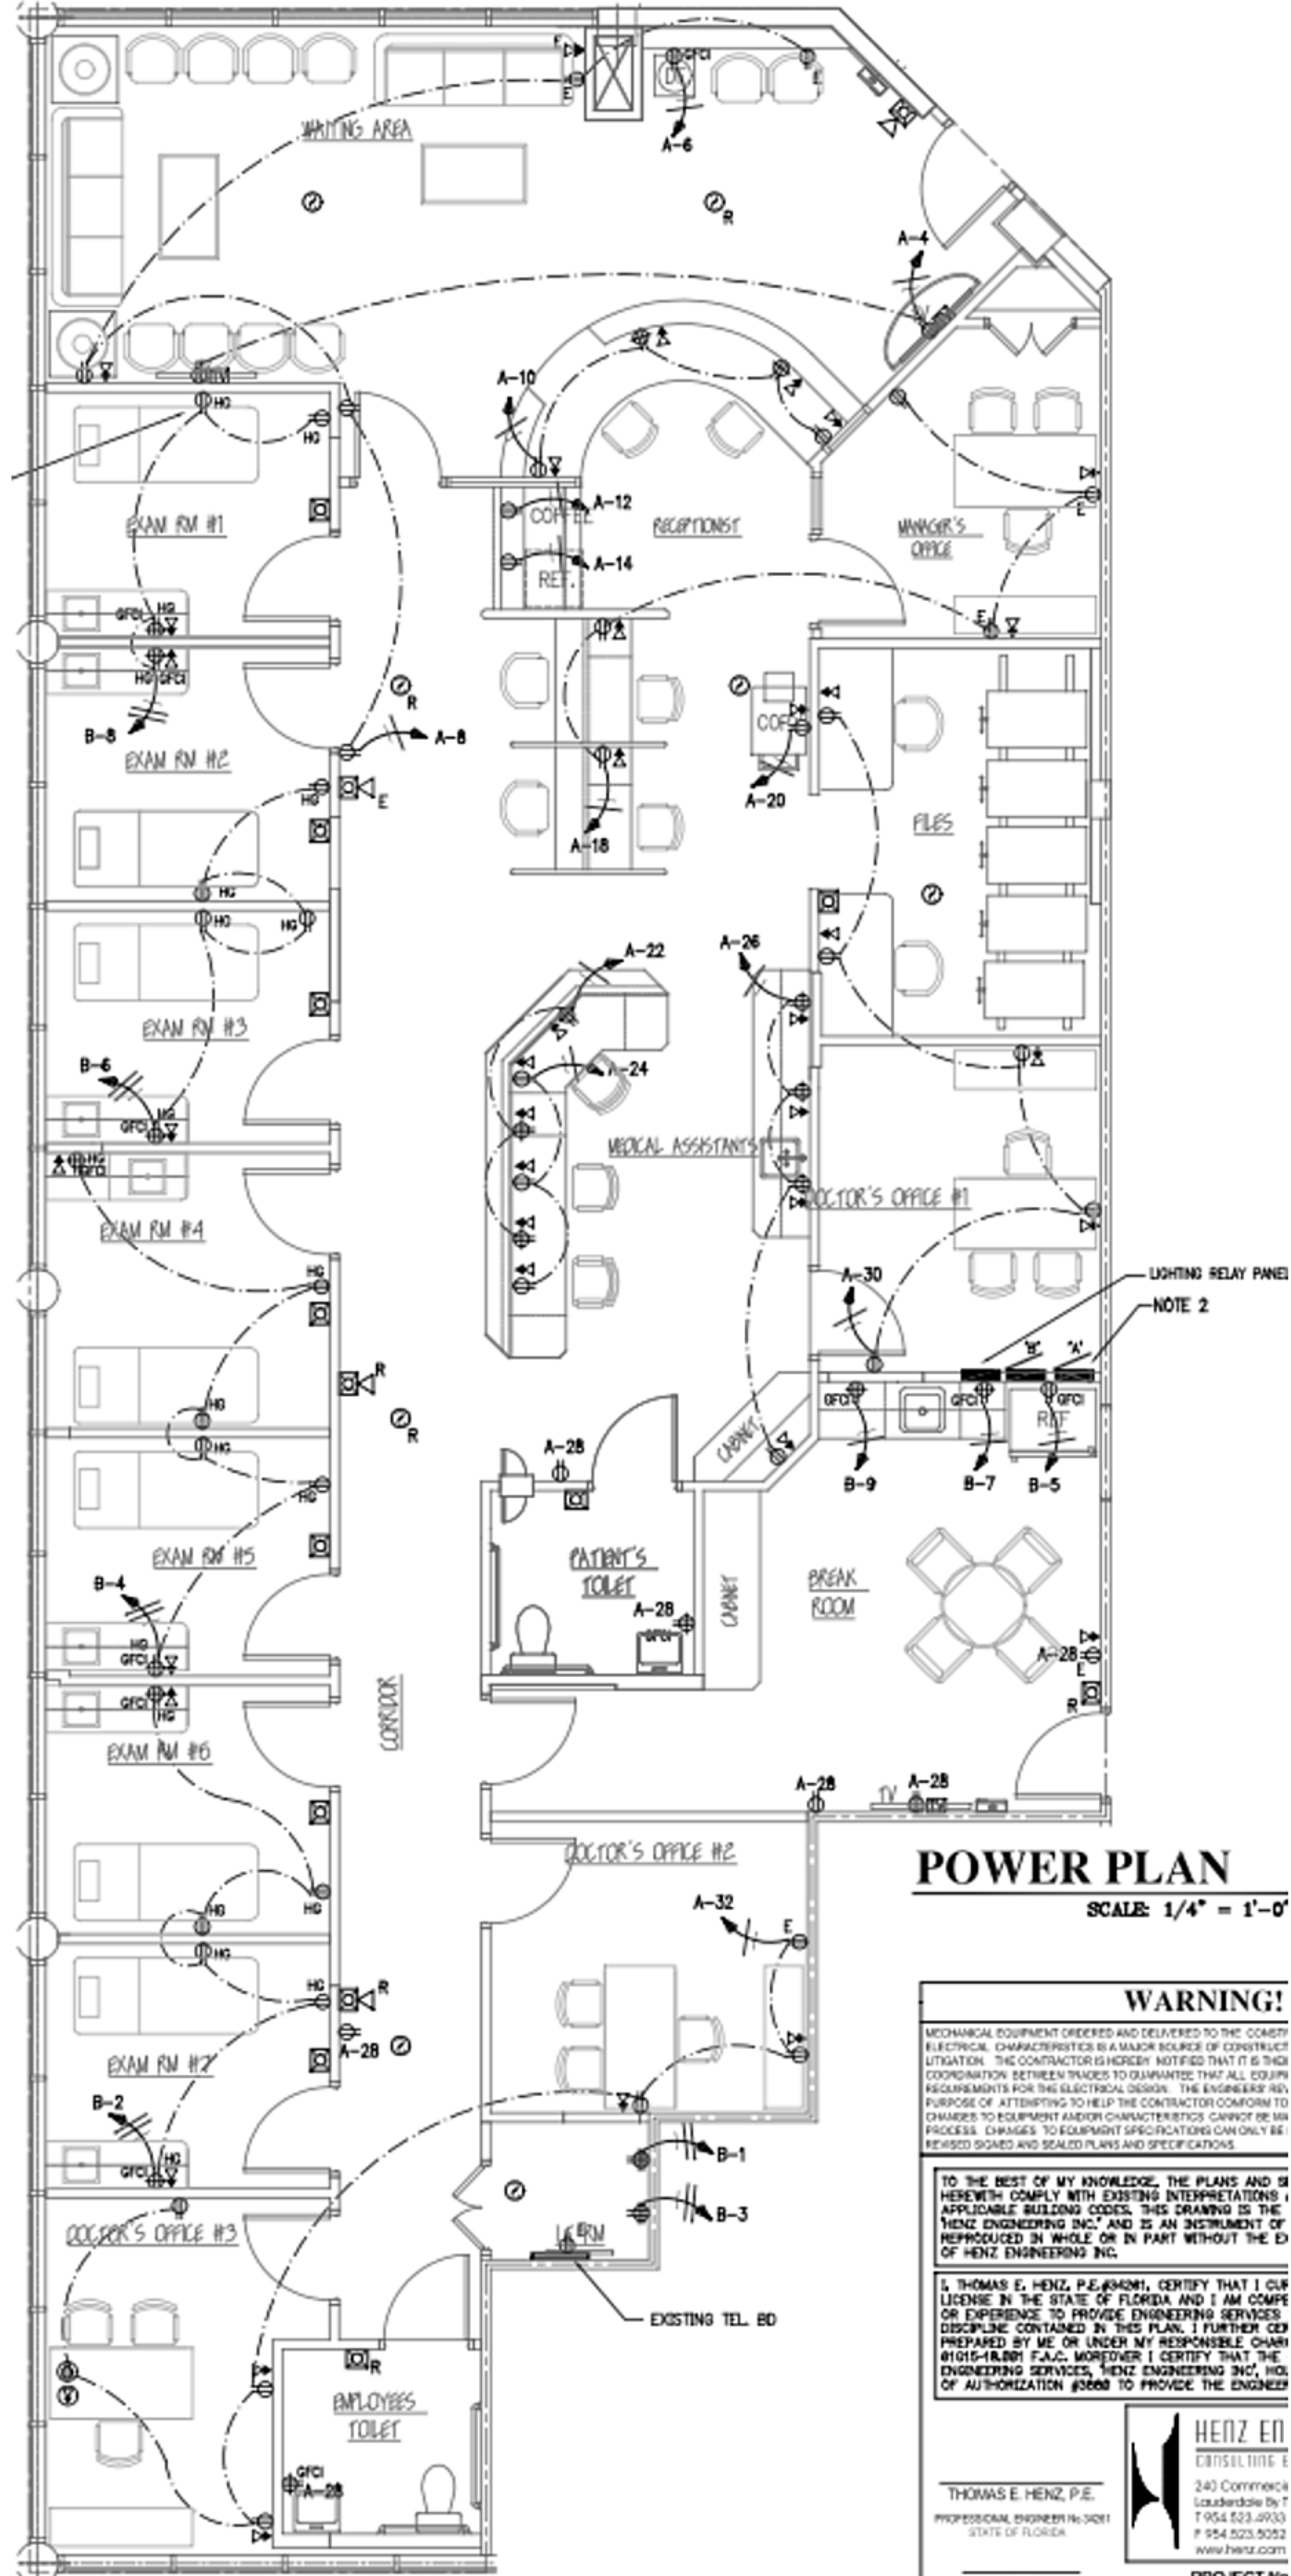

POWER PLAN

SCALE: 1/4" = 1'-0"

WARNING!

MECHANICAL EQUIPMENT ORDERED AND DELIVERED TO THE CONSTRUCTION SITE IS THE RESPONSIBILITY OF THE CONTRACTOR. THE CONTRACTOR IS HEREBY NOTIFIED THAT IT IS THE CONTRACTOR'S RESPONSIBILITY TO OBTAIN ALL NECESSARY PERMITS AND APPROVALS FOR THE CONSTRUCTION OF THE PROJECT. THE ENGINEER'S RESPONSIBILITY IS LIMITED TO THE DESIGN OF THE ELECTRICAL SYSTEM AND DOES NOT INCLUDE THE DESIGN OF THE MECHANICAL SYSTEMS. THE CONTRACTOR SHALL BE RESPONSIBLE FOR THE PROTECTION OF ALL EXISTING UTILITIES AND STRUCTURES. ANY CHANGES TO THE DESIGN SHALL BE MADE IN WRITING AND SIGNED BY THE ENGINEER.

TO THE BEST OF MY KNOWLEDGE, THE PLANS AND SPECIFICATIONS HEREIN COMPLY WITH THE BUILDING CODES AND REGULATIONS OF THE STATE OF FLORIDA. THIS DRAWING IS THE PROPERTY OF HENZ ENGINEERING INC. AND IS NOT TO BE REPRODUCED OR COPIED IN ANY MANNER WITHOUT THE WRITTEN PERMISSION OF HENZ ENGINEERING INC.

I, THOMAS E. HENZ, P.E., #10421, CERTIFY THAT I AM A LICENSED PROFESSIONAL ENGINEER IN THE STATE OF FLORIDA AND I AM COMPETENT TO PROVIDE ENGINEERING SERVICES. I FURTHER CERTIFY THAT THE PLANS AND SPECIFICATIONS WERE PREPARED BY ME OR UNDER MY CLOSE PERSONAL SUPERVISION AND I AM AWARE OF THE CONTENTS AND I AM NOT PROVIDING ENGINEERING SERVICES TO ANY OTHER PROJECTS AT THE SAME TIME. I AM NOT PROVIDING ENGINEERING SERVICES TO ANY OTHER PROJECTS AT THE SAME TIME.

THOMAS E. HENZ, P.E.
PROFESSIONAL ENGINEER No. 10421
STATE OF FLORIDA

HENZ ENGINEERING
CONSULTING ENGINEERS
240 Commercial
Lauderdale Blvd. N.
T 954.523.5933
F 954.523.5932
www.henz.com

DATE:

PROJECT No: