


2 NEW REFLECTED CEILING PLAN
1/4" = 1'-0"

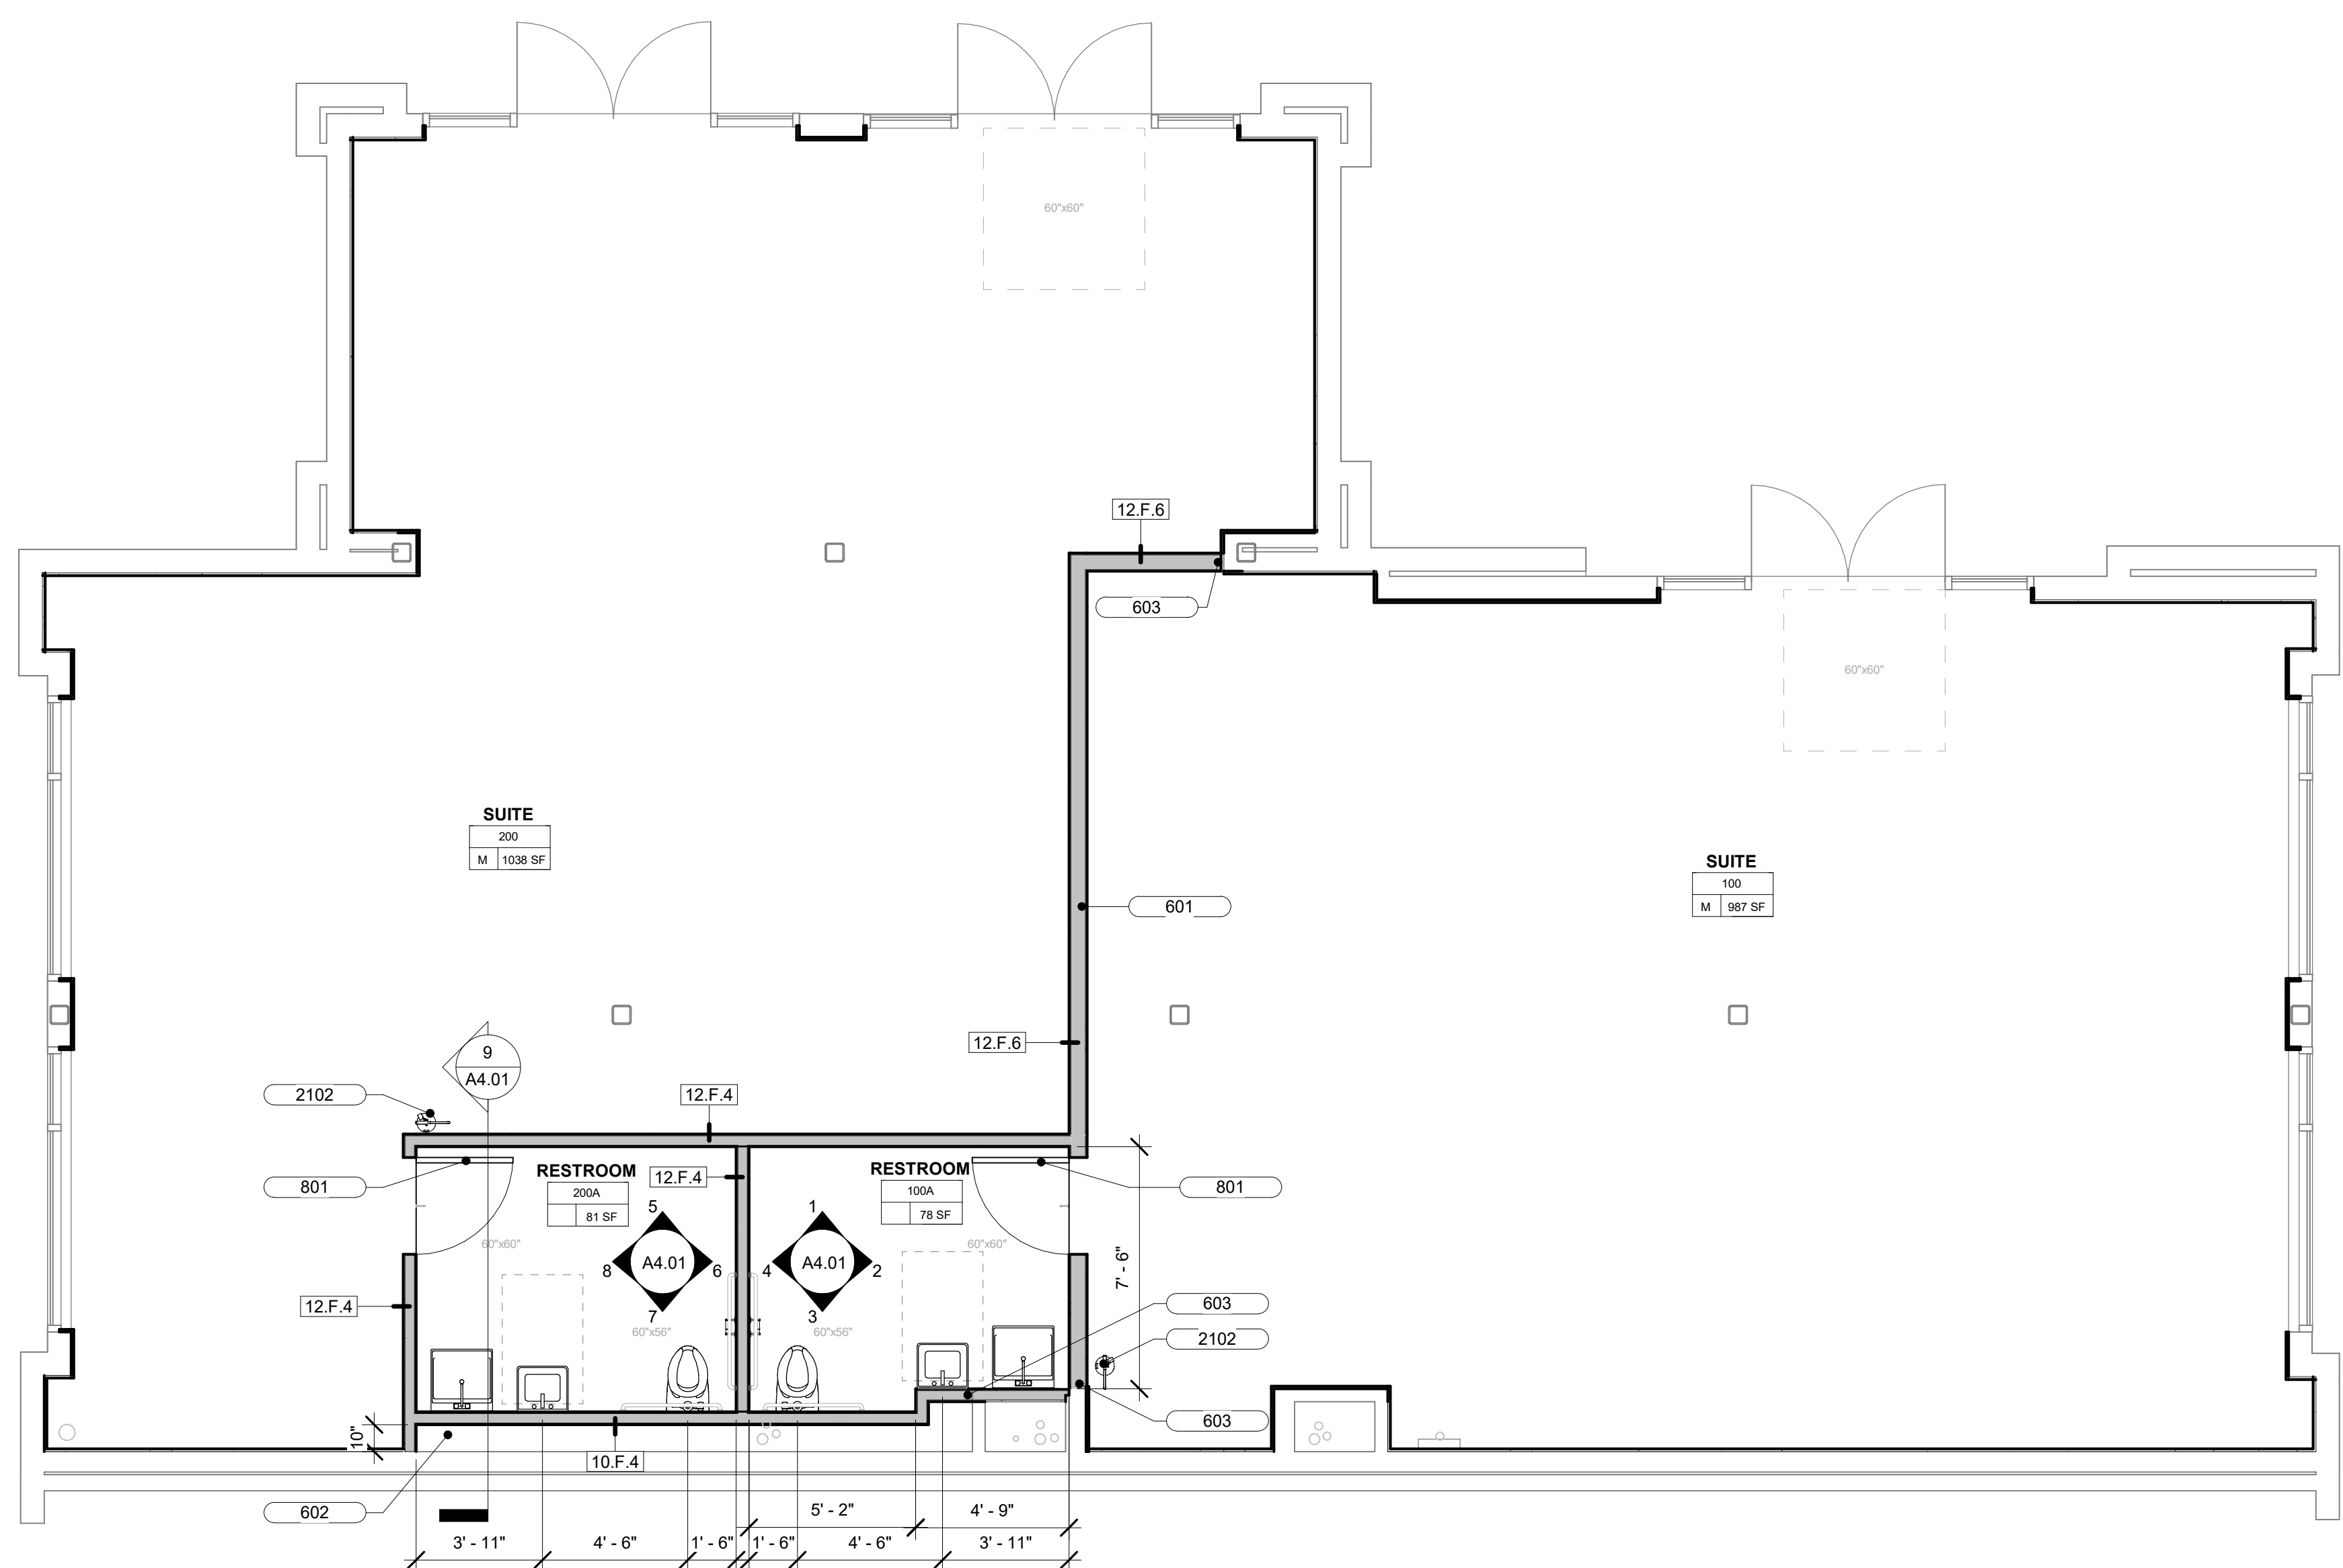

1 NEW FLOOR PLAN
1/4" = 1'-0"

FLOOR PLAN LEGEND

(N) WALL

REFLECTED CEILING PLAN LEGEND

SUSPENDED ACOUSTICAL CEILING - TYPE A
 PAINTED GWB CEILING - TYPE B
 CEILING (ASSEMBLY) TAG
 TYPE
 1'-0" HEIGHT ABOVE SLAB

SHEET NOTES - NEW PLANS

1. SEE MEP AND FIRE PROTECTION PLANS FOR WORK UNDER THOSE DISCIPLINES NOT SHOWN HERE.

KEYNOTE LEGEND

KEY VALUE	DESCRIPTION
601	NEW ACOUSTICAL PARTITION
602	NEW PLUMBING CHASE
603	ALIGN NEW AND EXISTING PARTITIONS
801	30/30 PRESHING SOLID CORE DOOR, FLAT, PAINT GRADE, ACCESSIBLE BATHROOM/BEDROOM LOCKSET, LEVER HANDEL, KICK PLANT ON PUSH SIDE, BRUSHED NICK HARDWARE FINISH.
901	CONTINUE SUSPENDED CEILING OVER RESTROOMS
2102	WALL MOUNTED FIRE EXTINGUISHER

Approvals

Client

Architect

Engineer

Firm Name and Address and Logo

251 Rhode Island St., Suite 202
 San Francisco, CA 94103
 1212 Broadway, Suite 1700
 Oakland, CA 94612
 tel 415.487.6900

Consultant

Project Name and Address

**AMG MACARTHUR
 STUDIO RETAIL
 TENANT
 IMPROVEMENT**

4311 - 4317 MACARTHUR BLVD.
 OAKLAND, CA 94619

Date	No.	Revisions

DRAWING TITLE

**NEW FLOOR AND REVLECTED
 CEILING PLANS**

PERMITTING

SHEET NO.	JOB NO.		
A2.01	2320		
DATE	DRAFTER	CHECKED BY	SITE NO.
APRIL 2024	Author	Checker	
SCALE	CLIENT PROJECT NO.		
As indicated			