


175 MCJELLIAN HIGHWAY, BOSTON, MA
FLOOR PLAN: FIRST; SCALE: 1/16"=1'-0"; DATE: 01-26-18

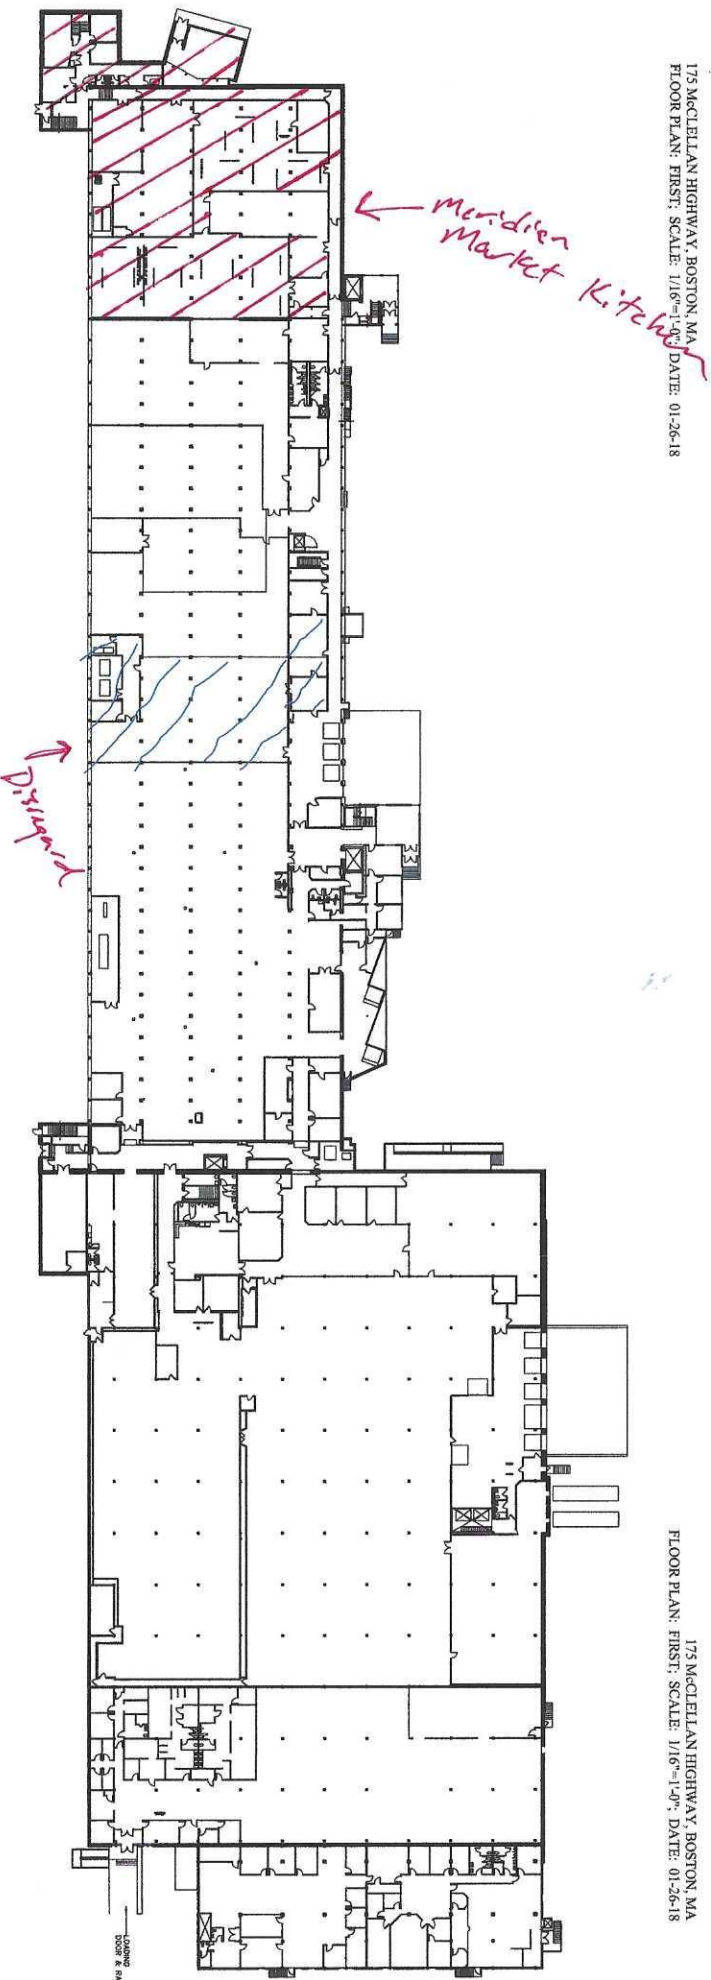

Electrical Service 1 of 3
2,000 Amps 120/208

Electrical Service 2 of 3
2,000 Amps 120/208

Electrical Service 3 of 3
3,000 Amps 480

175 MCJELLIAN HIGHWAY, BOSTON, MA
FLOOR PLAN: FIRST; SCALE: 1/16"=1'-0"; DATE: 01-26-18

MECHANICAL ROOM & PLUMB