



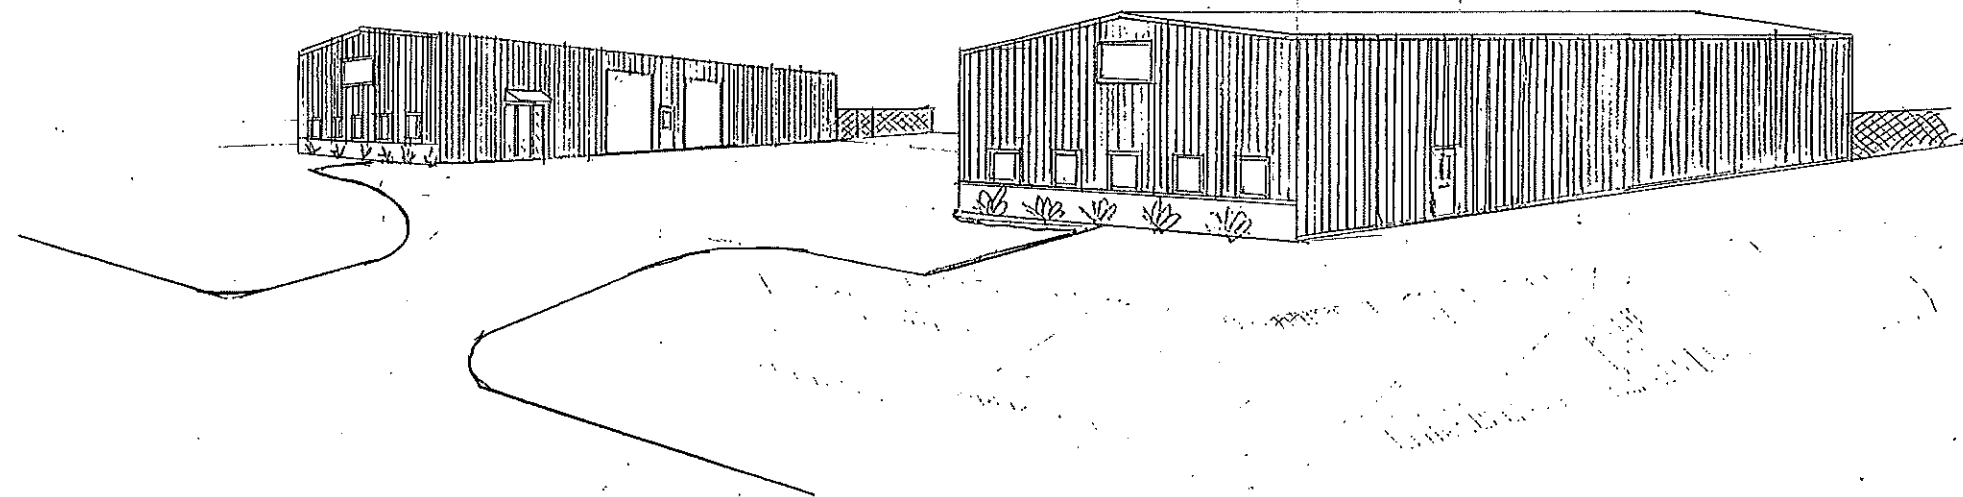


Blaise Thomas Enterprises LLC	
Date: 2-7-25	1017 Areasmith Dr. Bldg A & B
Scale: Not to scale	Richland MS, 39218
Drawn by J E Corube	
601-594-0169	
1 05 17	

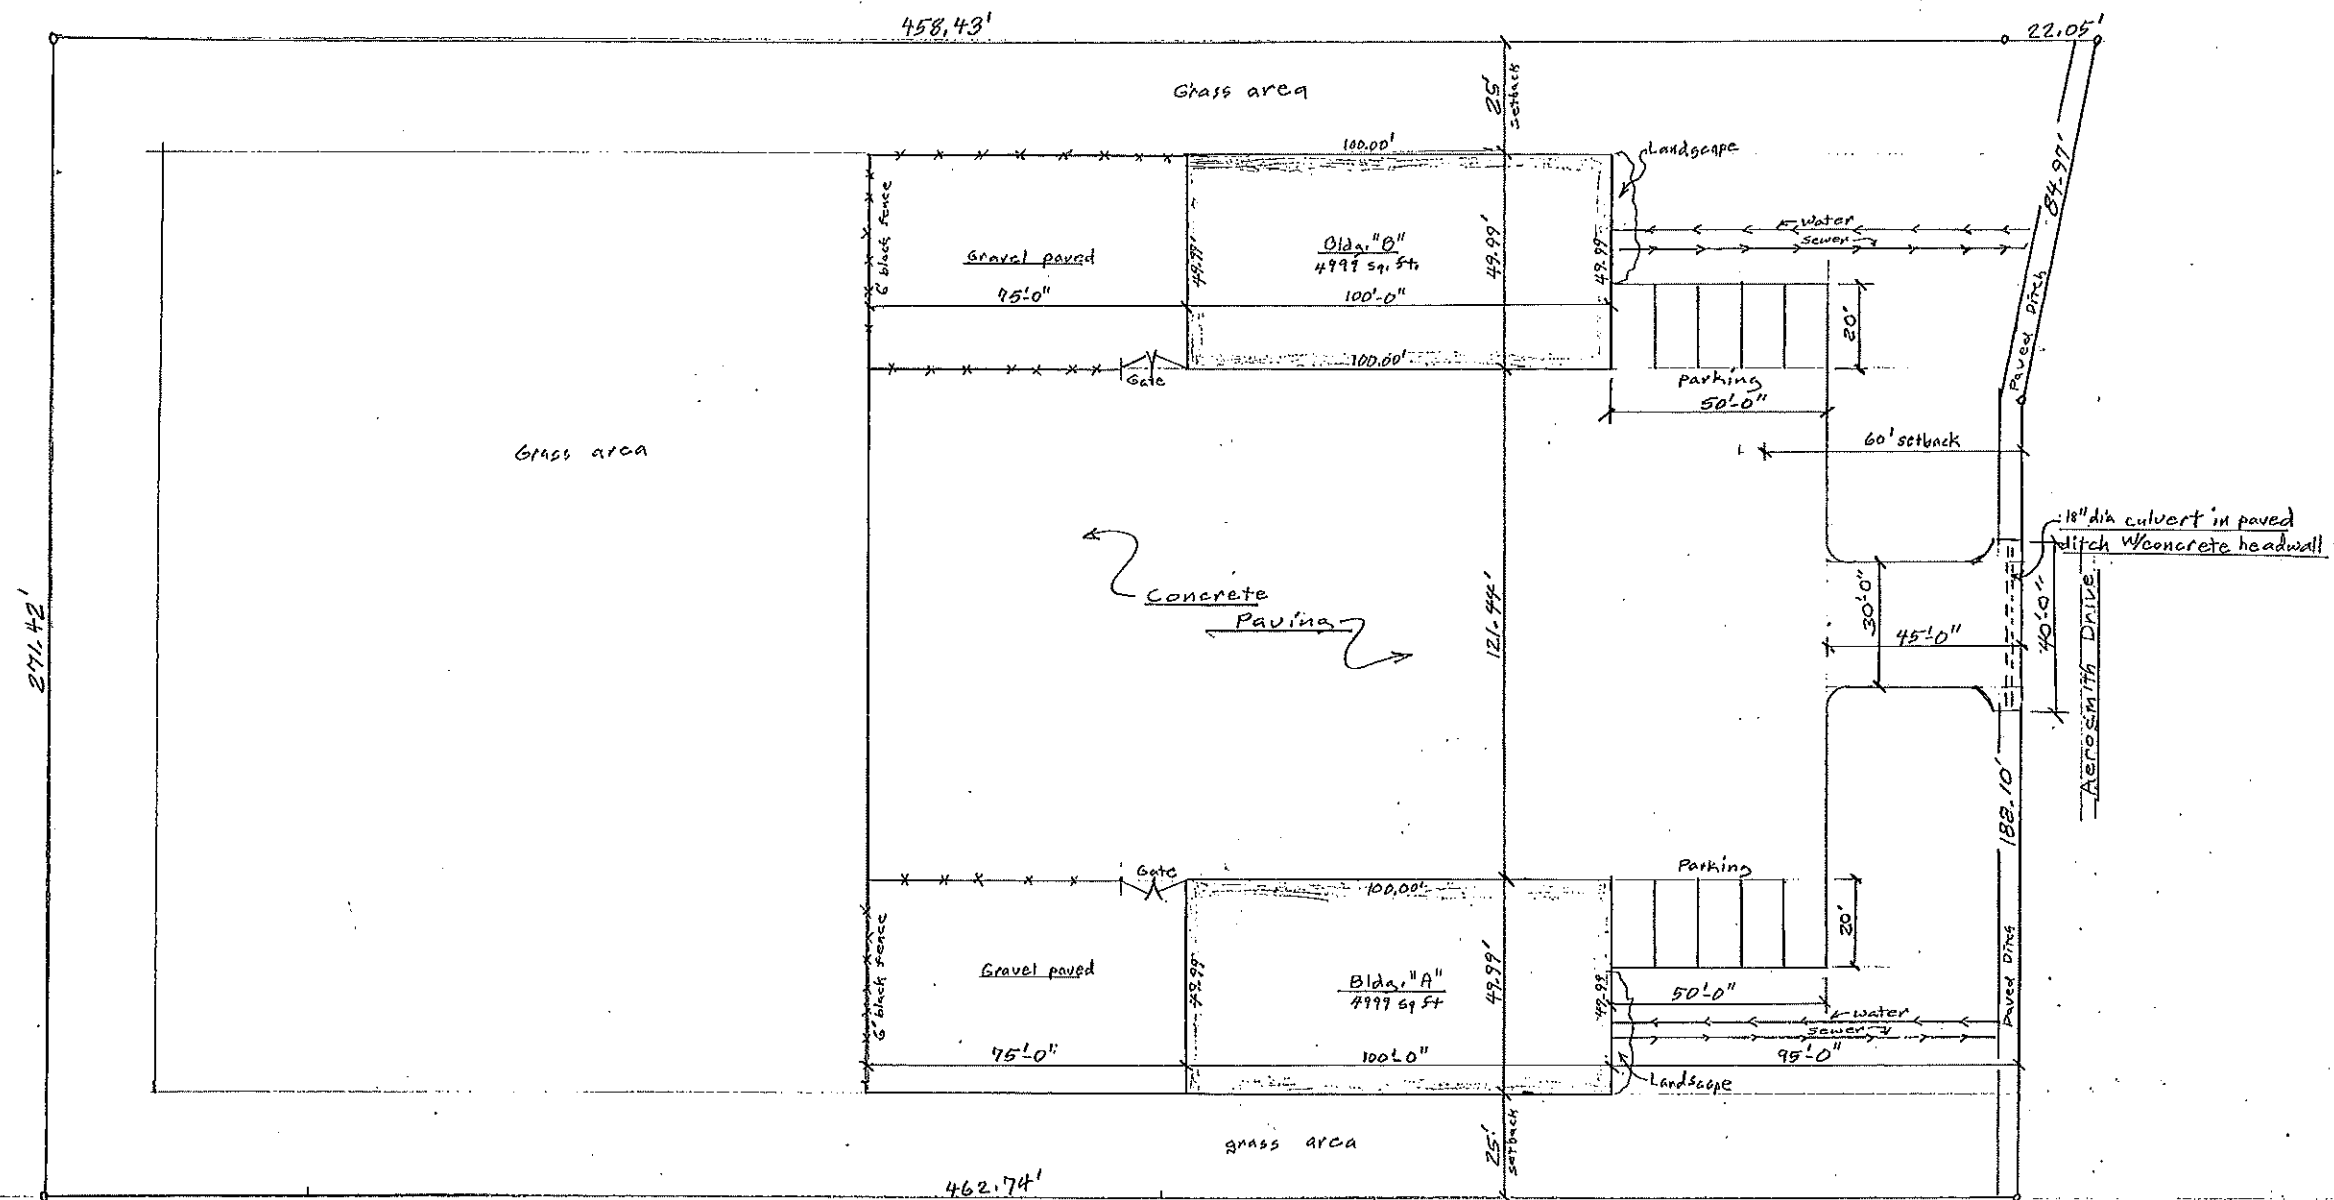


Site Plan
Scale: 1"=20'


Blaise Thomas Enterprises LLC	
Date: 2-4-25	107 Aerosmith Dr. Bldg. A & B
Scale: 1"=20'	Richland Mo. 39218
Drawn by JE Cornbl	
601-594-0169	
2 of 7	

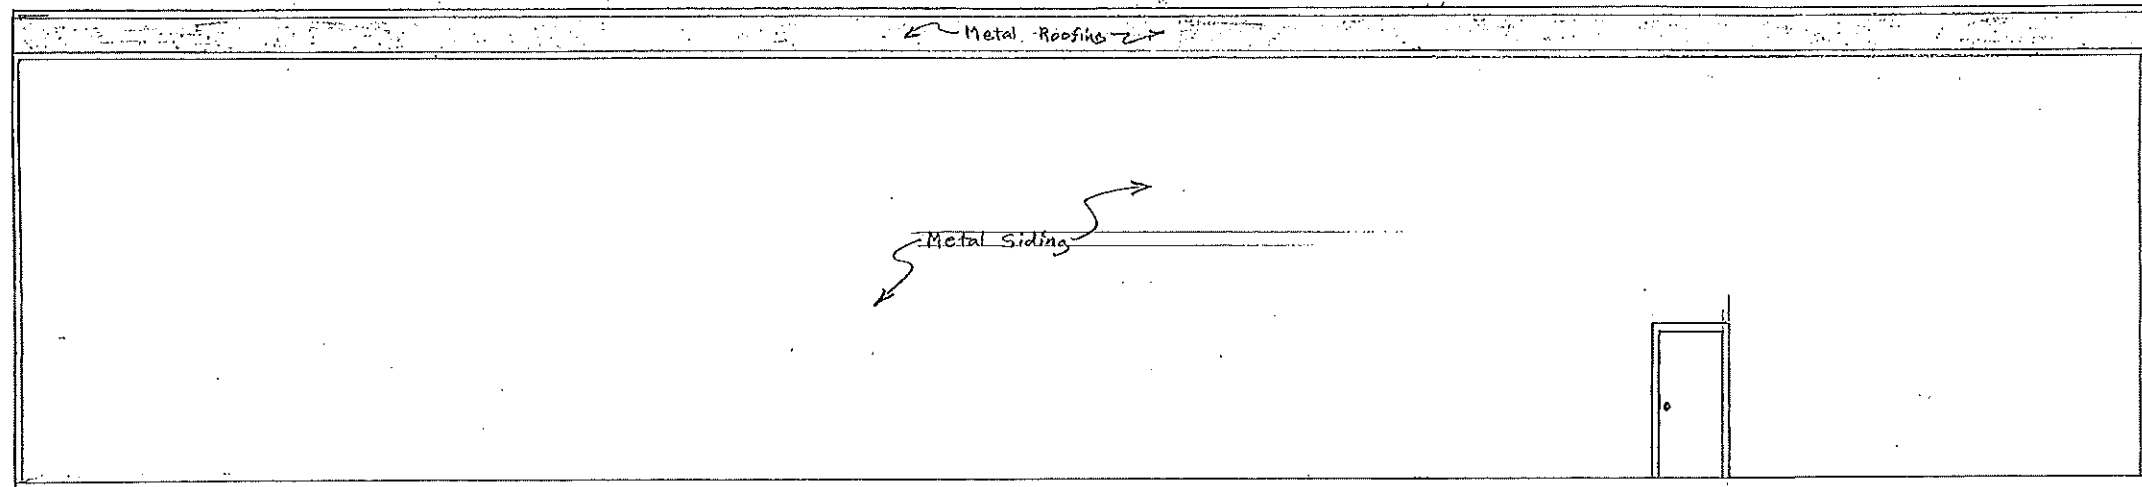


Left-Side
Scale: 1/4"=1'-0"

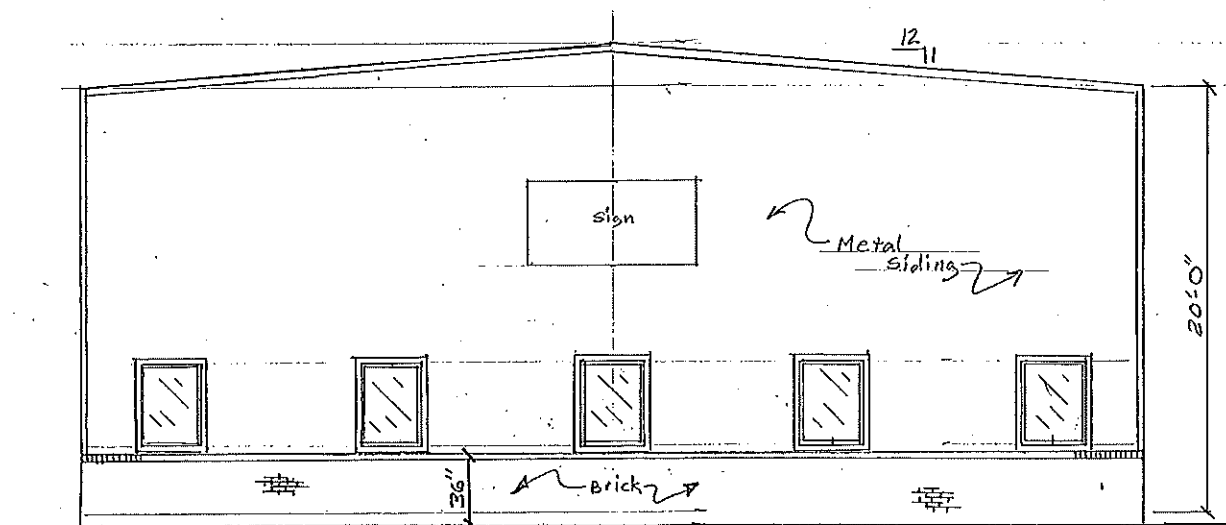

Front View
Scale: 1/4"=1'-0"

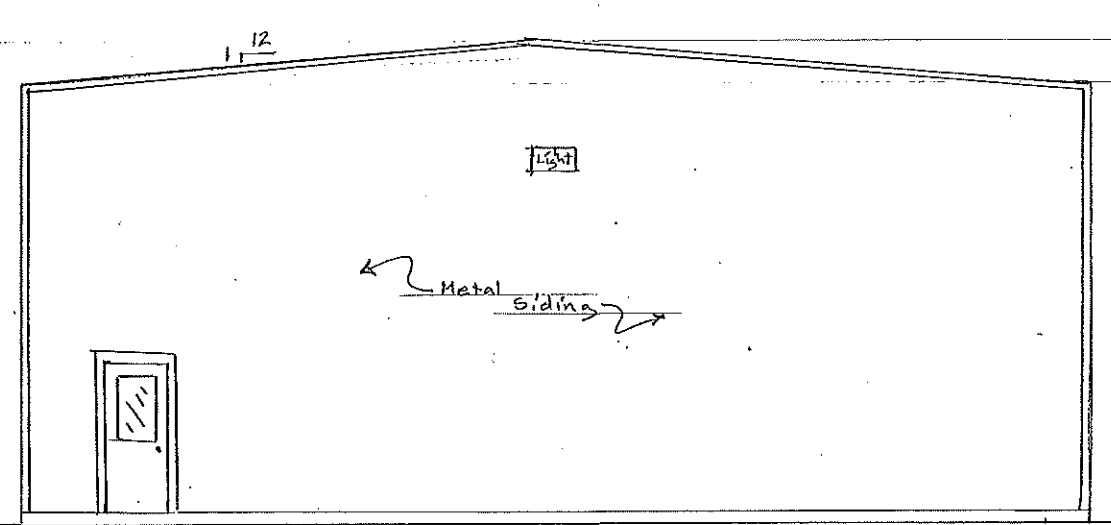


Rear View
Scale: 1/4"=1'-0"

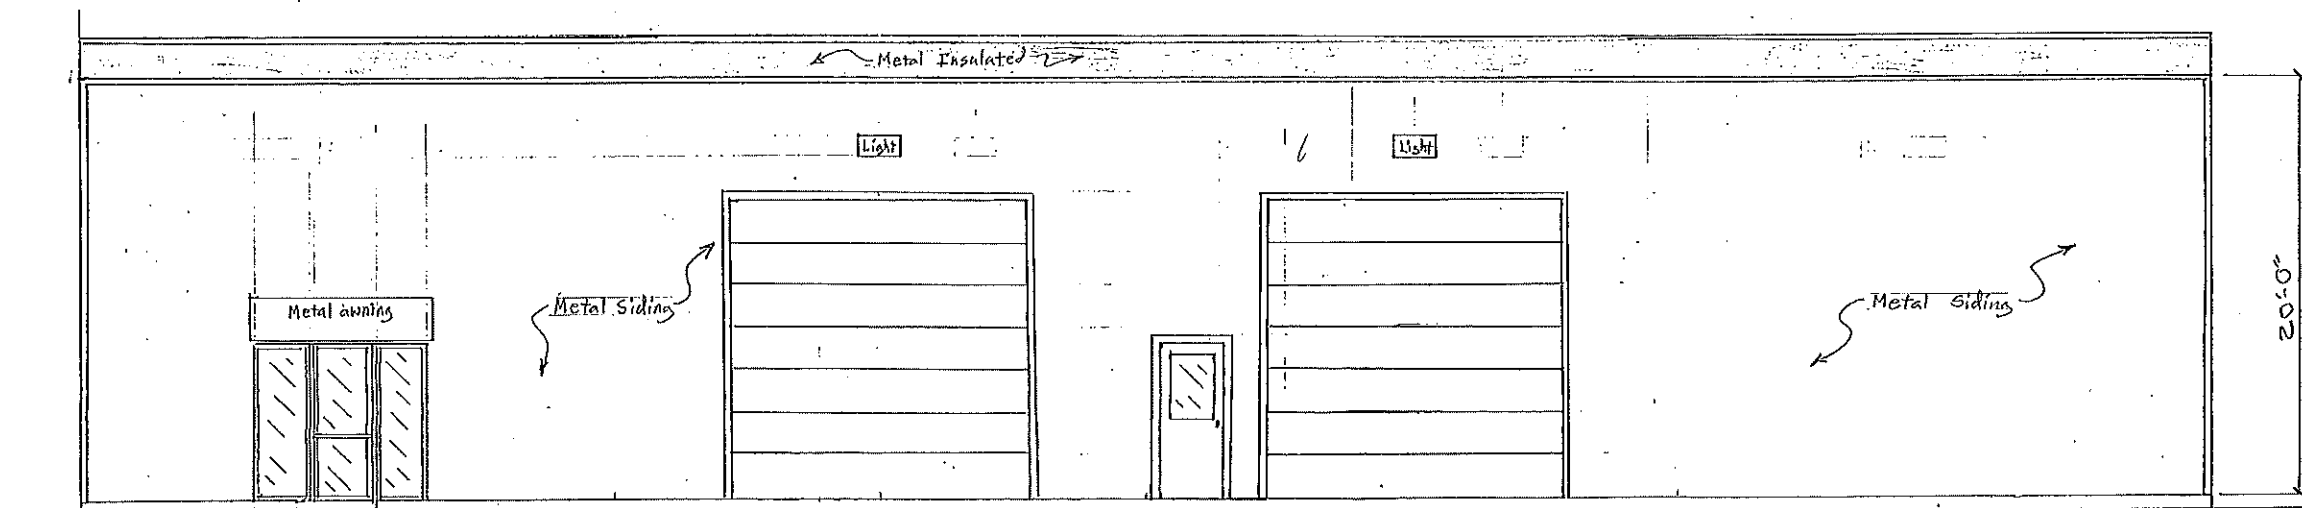

Right-Side
Scale: 1/4"=1'-0"

Note:
Building opposite this Bldg
will be in reverse of these
elevation drawings


Blaise Thomas Enterprises LLC	
Date: 2-4-25	107 Aerospace Dr, Bldg A28
Scale: 1/4"=1'-0"	Richland, Ms 39218
Drawn by J.E. Grube	
601-594-0169	
3 of 17	


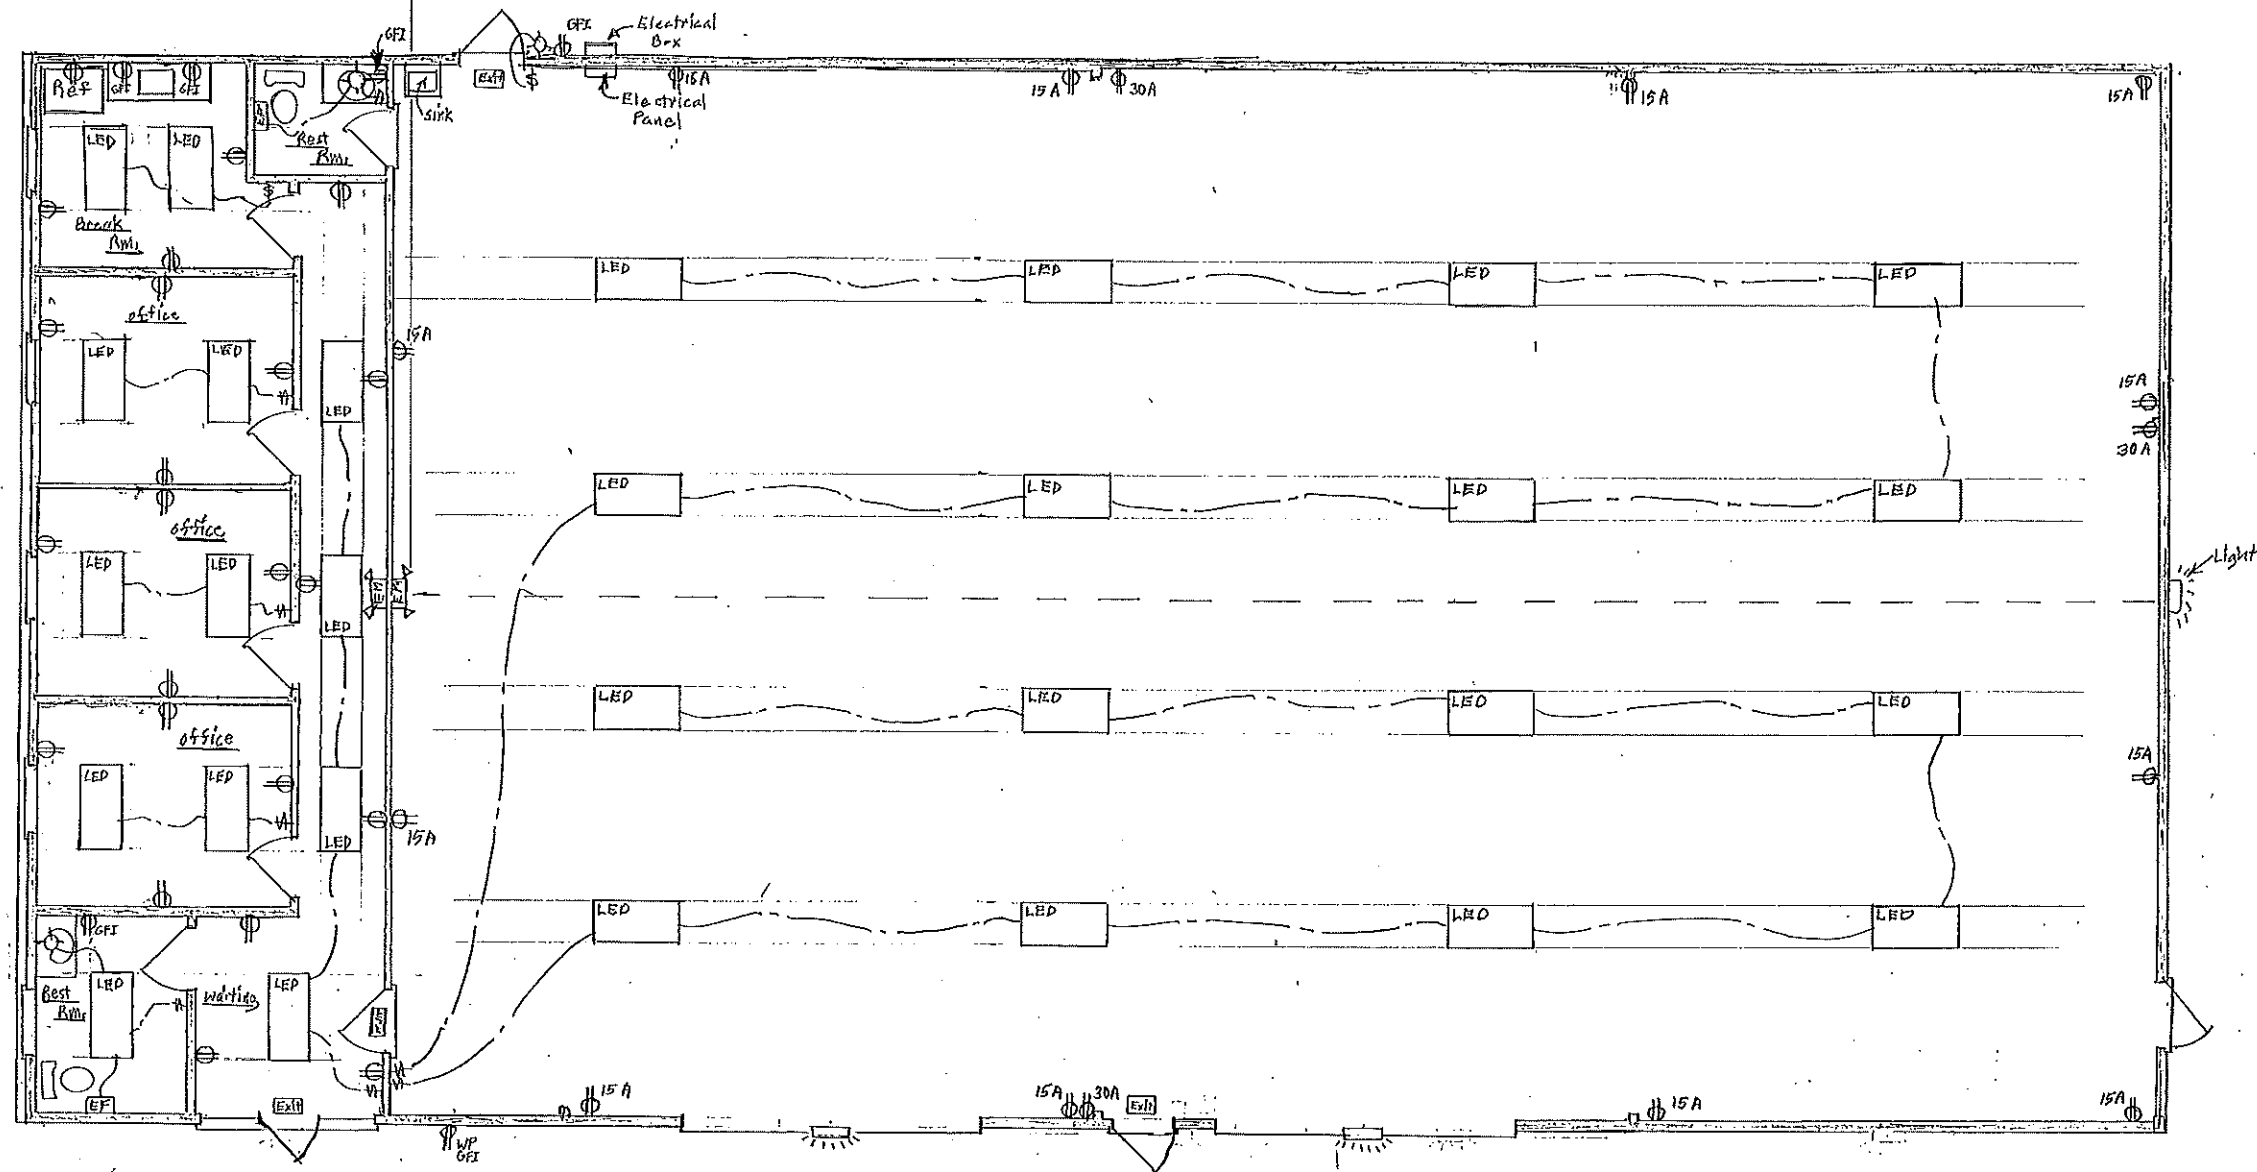


Electrical Schedule	
Mark	Description
LED	24"x48" LED Fixture
EF	Exhaust Fan
W	Wall Fixture
WMSL	Wall Mount security Light
EM	Emergency Light
EXIT	Exit Light
S	Single pole switch
O	120 VAC Outlet
GFI	120 VAC Ground fault Interrupter outlet

Electrical Plan
Scale: 1/4"=1'-0"

Blaise Thomas Enterprises LLC	
Date: 2-4-25	107 N. 2nd St. Bldg. A & B
Scale: 1/4"=1'-0"	Richmond, M.S. 39218
Drawn by JE Grube	
601-594-0169	
5 of 7	

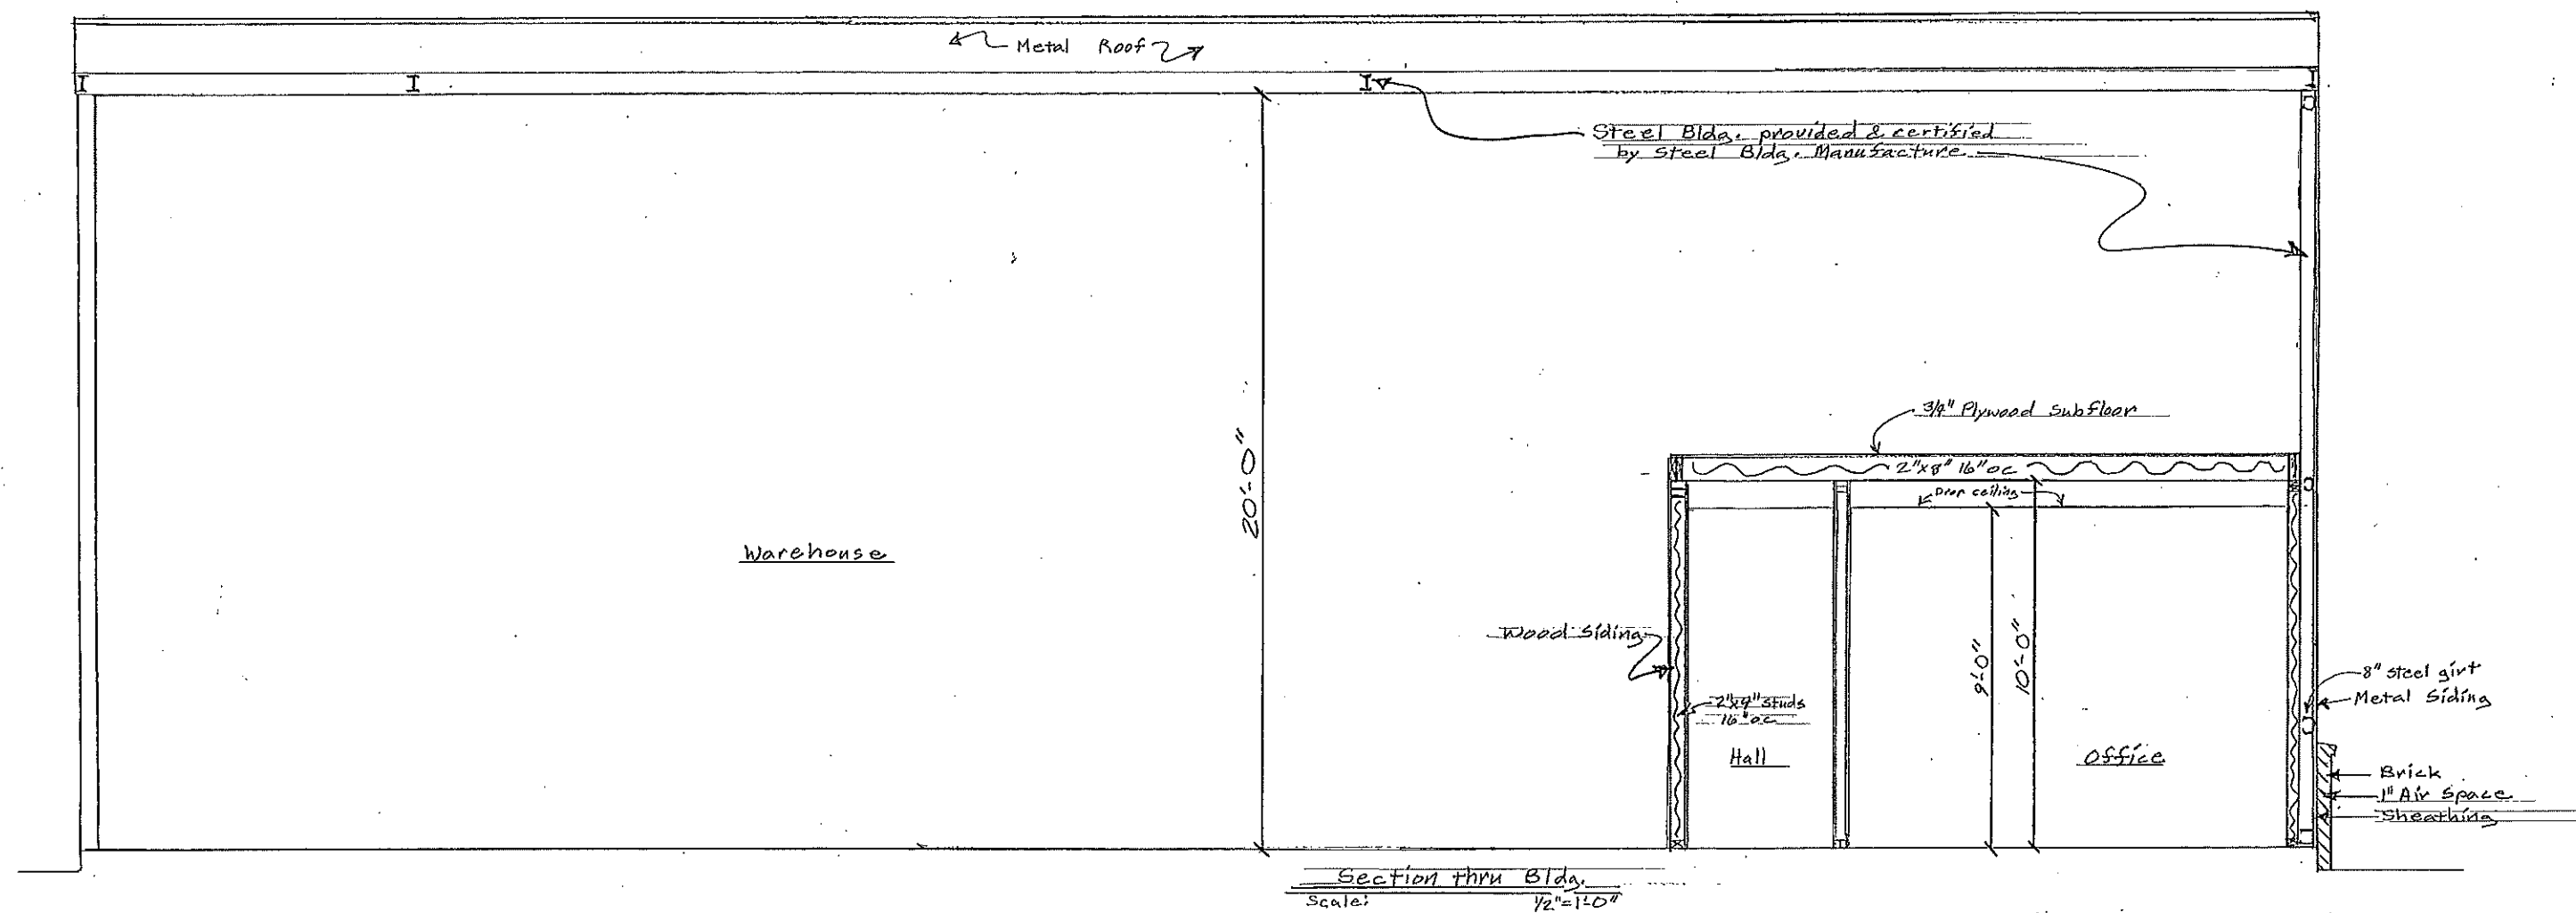

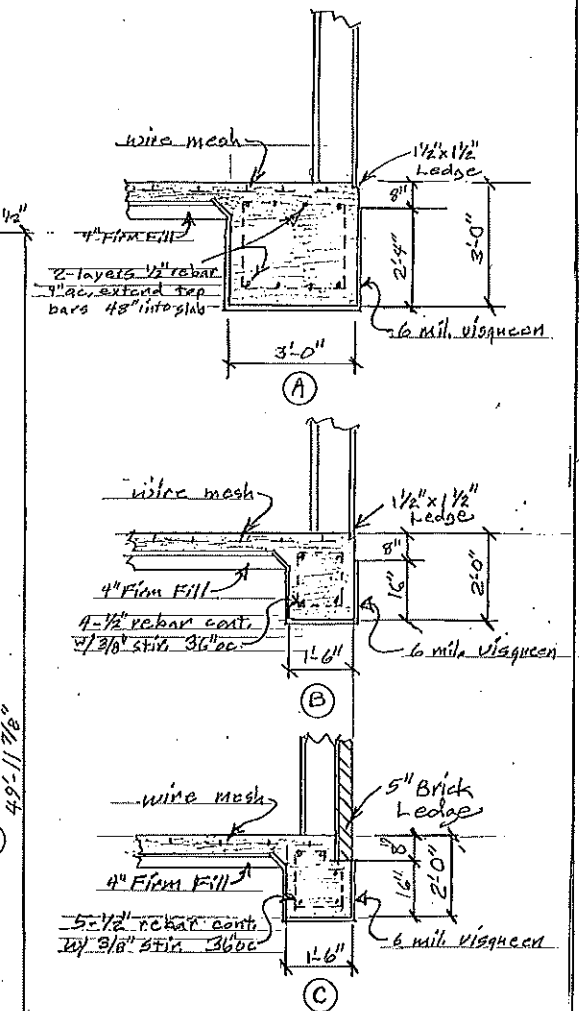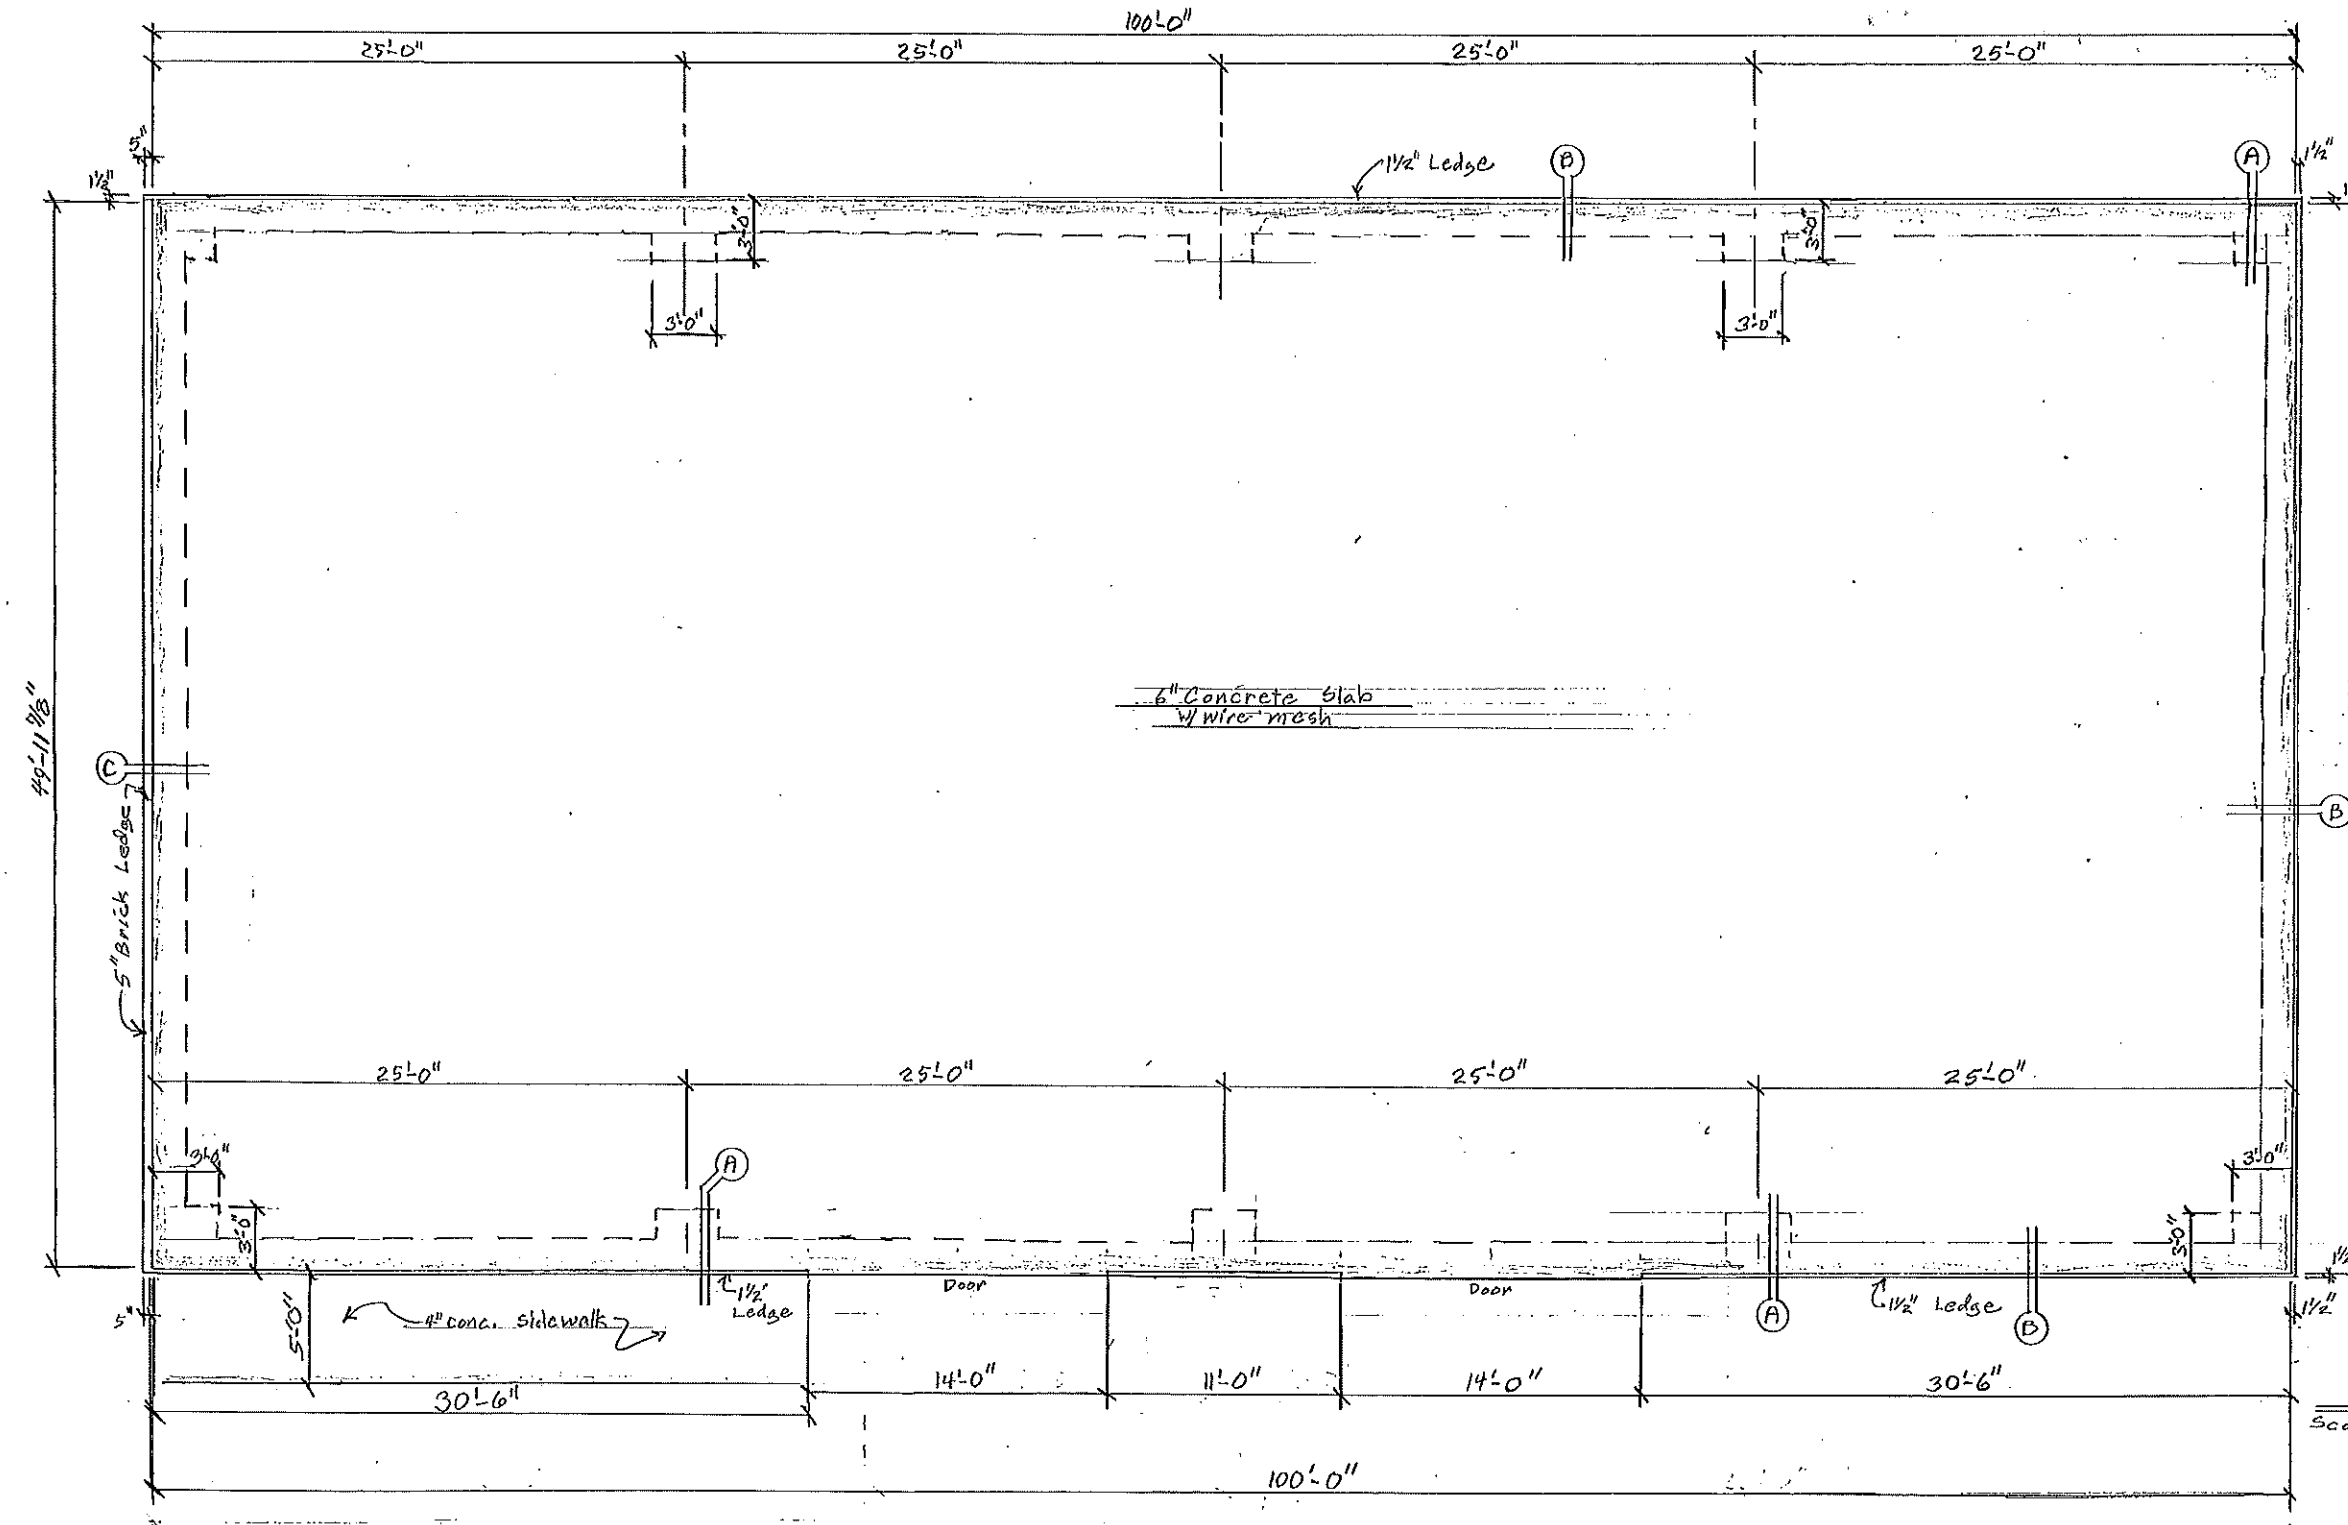

Foundation Plan
Scale: 1/4" = 1'-0"

Blais e Thomas Enterprises LLC	
Date: 2-4-25	107 Aergsmith Dr Bldg #2B
Scale: 1/4" = 1'-0"	Richland Ms, 39218
Drawn by JE Grube	
601-594-0169	
17.05.17	