


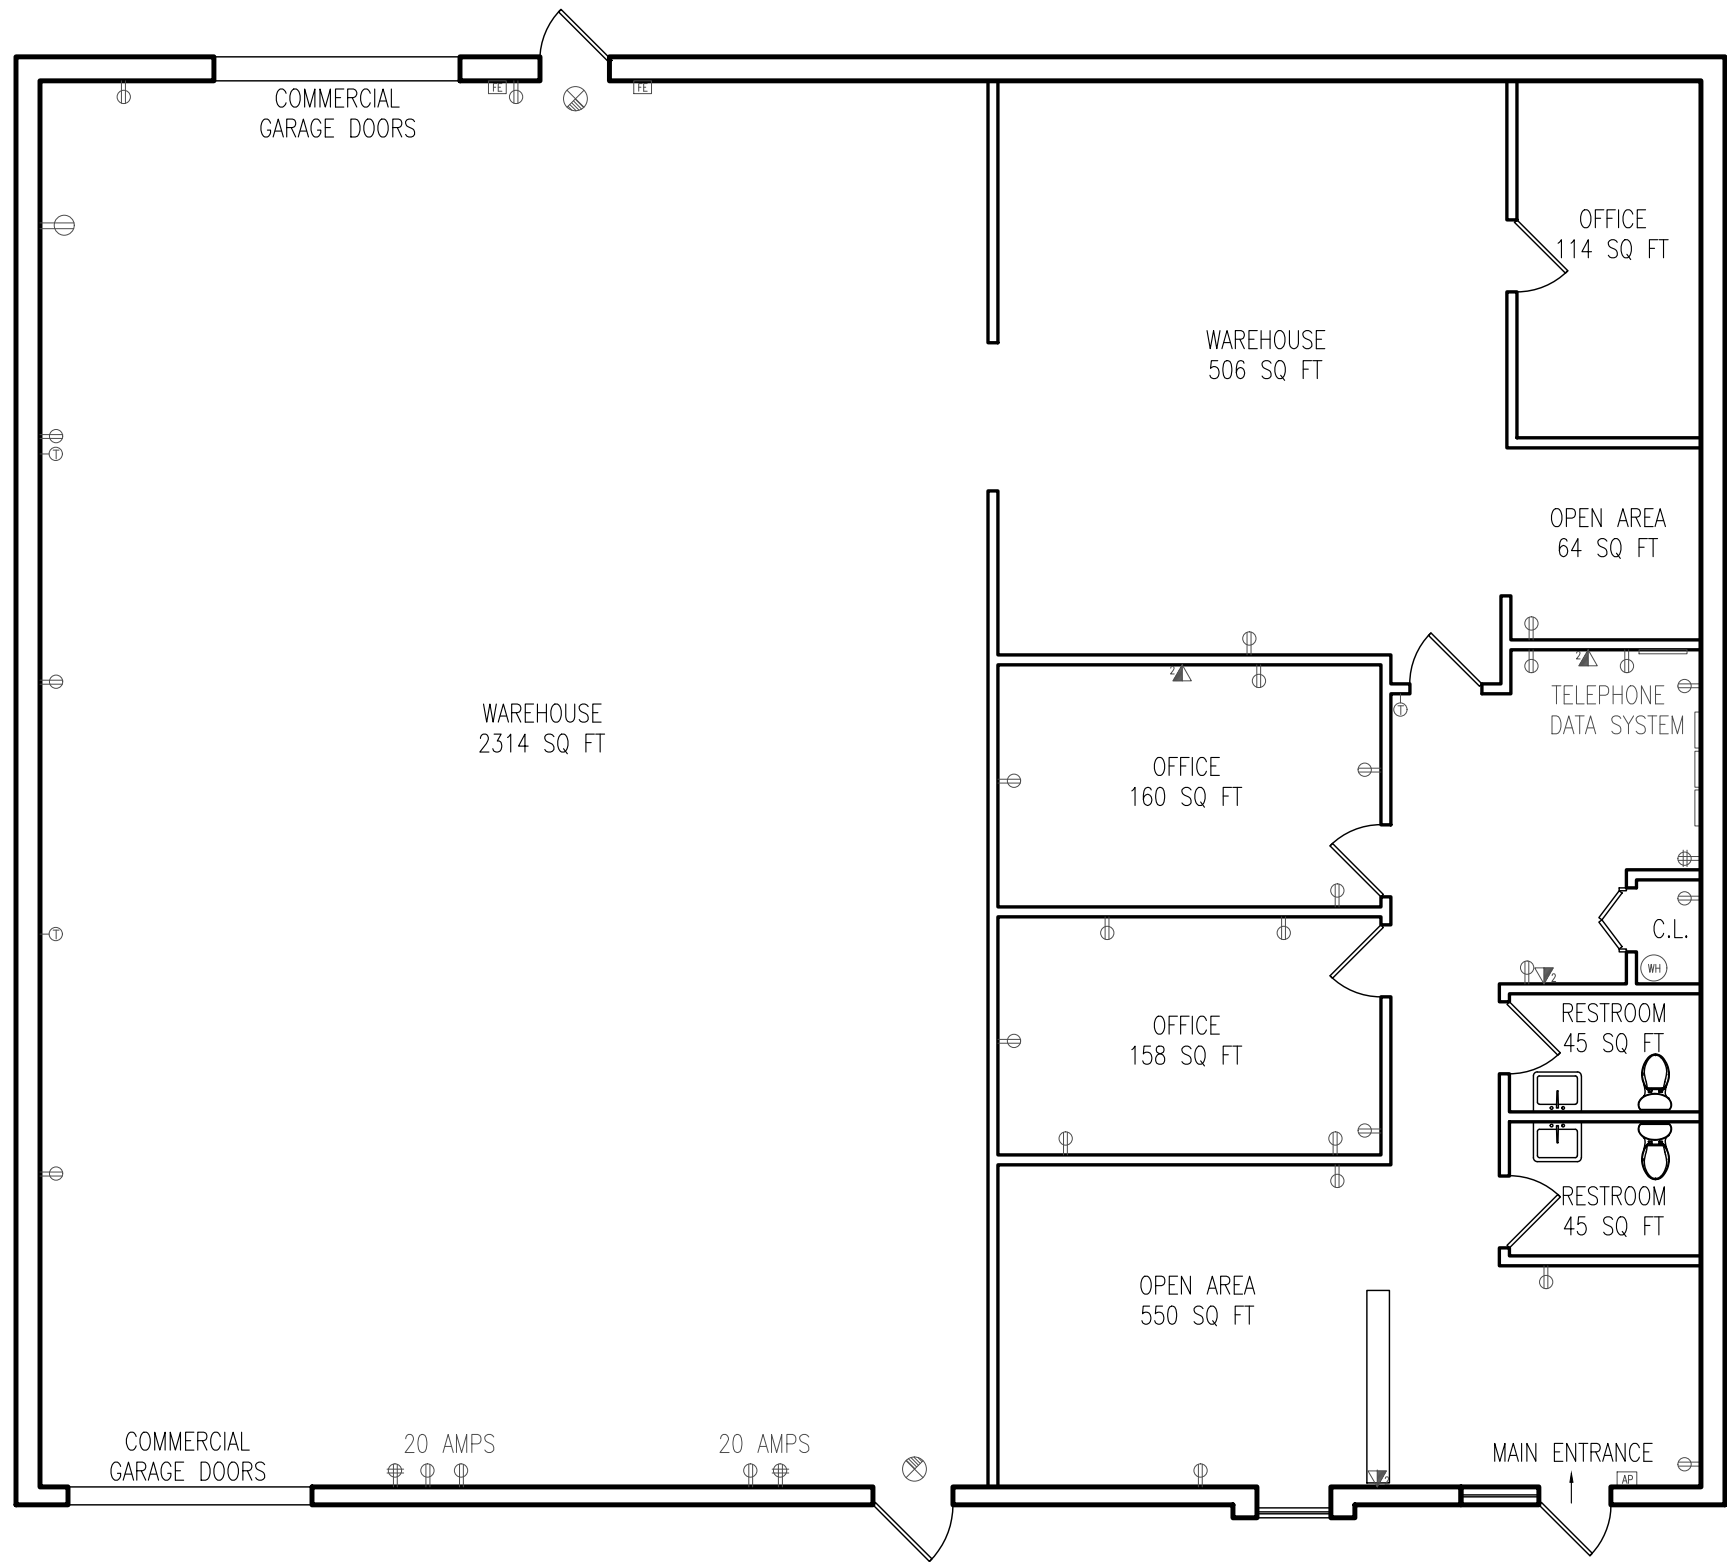

1 AS-BUILT FLOOR PLAN - FLEX SPACE 1106
AB-1 SCALE: 1/8" = 1'-0"



3322 US-22 W
BLDG 10 SUITE 1005
BRANCHBURG, NJ 08876

OFFICE: 908-393-9984

CAROLINE E. SHELLY
CID#21ID00046100

- UTILITY REQUIREMENTS LEGEND
- TELE/DATA PORT
 - DUPLEX OUTLET
 - QUAD OUTLET
 - THERMOSTAT
 - WATER HEATER
- LIFE SAFETY LEGEND
- EXIT SIGN
 - FIRE EXTINGUISHER
 - EMERGENCY LIGHT

JOB: **AS-BUILT FLOOR PLAN,
FLEX SPACE 1106**



1106 INDUSTRIAL PARKWAY,
BRICK, NJ 08724

NO.	DATE	DESCRIPTION	BY
0	09 13 22	INITIAL RELEASE	EDLC

FLOOR PLAN

SCALE: AS NOTED
DATE: 09/13/2022
JOB NO: HFP-0955
DWN BY: EDLC/CKD BY: CES

AB-1

3322 US-22 W
BLDG 10 SUITE 1005
BRANCBURG, NJ 08876

OFFICE: 908-393-9984

CAROLINE E. SHELLY
CID#21ID00046100

REFLECTED CEILING PLAN LEGEND

-  RECESSED DOWN LIGHT
-  18" SURFACE MOUNTED LIGHT
-  24" X 48" SUSPENDED LIGHT
FIXTURE
-  HVAC SUPPLY REGISTER
-  HVAC RETURN GRILLE
-  8" X 8" HVAC SUPPLY REGISTER
-  SPRINKLER
-  LIGHT SWITCH

LIFE SAFETY LEGEND

-  EXIT SIGN
-  FIRE EXTINGUISHER
-  EMERGENCY LIGHT

JOB:
**AS-BUILT REFLECTED
CEILING PLAN,
FLEX SPACE 1106**

FOR:

1106 INDUSTRIAL PARKWAY,
BRICK, NJ 08724

NO.	DATE	DESCRIPTION	BY
0	09 13 22	INITIAL RELEASE	EDLC

CEILING PLAN

SCALE: AS NOTED
DATE: 09/13/2022
JOB NO: HFP-0955
DWN BY: EDLC/KD BY: CES

AB-2



1 AS-BUILT REFLECTED CEILING PLAN - FLEX SPACE 1106
AB-2 SCALE: 1/8" = 1'-0"