

REFER TO BASE BUILDING CONSTRUCTION DOCUMENTS, SPECIFICATIONS, AND DETAILS FOR FURTHER INFORMATION

NO.	DATE	REVISIONS / SUBMISSIONS	Rev.
22			
21			
20			
19			
18			
17			
16	03.15.2022	ISSUED FOR PAA	8
15	06.01.2021	ISSUED FOR PAA	7
14	05.14.2021	SKP-219	6
13	02.28.2020	ADDENDUM 6	5
12	02.12.2020	ADDENDUM 5	4
11	10.11.2019	ADDENDUM 4	3
10	08.30.2019	DOB FILING SUBMISSION	
9	07.26.2019	DOB FILING SUBMISSION	
8	07.17.2019	ADDENDUM 1	2
7	06.28.2019	ISSUE FOR CONSTRUCTION	
6	05.31.2019	90% CONSTRUCTION DOCUMENTS (PROGRESS SUBMISSION)	
5	05.31.2019	DOB FILING SUBMISSION 05.31.19	1
4	03.22.2019	PROGRESS PRINT (60% CONSTRUCTION DOCUMENTS)	
3	01.18.2019	DESIGN DEVELOPMENT	
2	06.29.2018	DOB Initial Filing Submission	
1	06.22.2018	Schematic Design	

fxcollaborative

FXCollaborative Architects LLP | 22 West 19th Street | New York, NY 10011 | 212 627 1700 | fxcollaborative.com
SEVERUD
 469 Seventh Avenue, Suite 902, New York, NY 10018 212-668-3700
MG ENGINEERING D.P.C.
 116 West 32nd Street, New York, NY 10001 212-643-9005
LANGAN
 21 Park Place, 300 West 31st Street, 8th Floor, New York, NY 10001 212-478-5400
GILSANZ MURRAY STEFICEK LLP
 129 West 27th Street, Floor 5, New York, NY 10001 212-254-0030
INC Architecture & Design
 150 Varot Street, Floor 5 South, New York, NY 10013 212-673-1666
ONELUX Studio
 158 West 29th Street, 10th Floor, New York, NY 10001 212-201-9790
RKLA Studio
 333 Hudson Street, Suite 1001, New York, NY 10013 212-229-2534

185 Broadway
 New York, NY 10038

DRAWING TITLE:
3RD FLOOR PLUMBING PLAN

Seal: _____ Drawn: _____ Project No.: 8126 00
 Author: _____



Drawing No.: **P-103.02**

03/26/18
 Scale: 1/4" = 1'-0"
 7 of 37

NEW YORK CITY BUILDING DEPARTMENT APPROVAL NOTE
 THIS PLAN IS APPROVED ONLY FOR WORK INDICATED ON THE APPLICATION SPECIFICATION SHEET. ALL OTHER MATTERS SHOWN ARE NOT TO BE RELIED UPON, OR TO BE CONSIDERED AS EITHER BEING APPROVED OR IN ACCORDANCE WITH APPLICABLE CODES.

NEW YORK CITY ENERGY CONSERVATION CODE
 TO THE BEST OF MY KNOWLEDGE, BELIEF AND PROFESSIONAL JUDGMENT, THESE PLANS AND SPECIFICATIONS ARE IN COMPLIANCE WITH THE 2016 NEW YORK CITY ENERGY CONSERVATION CODE.



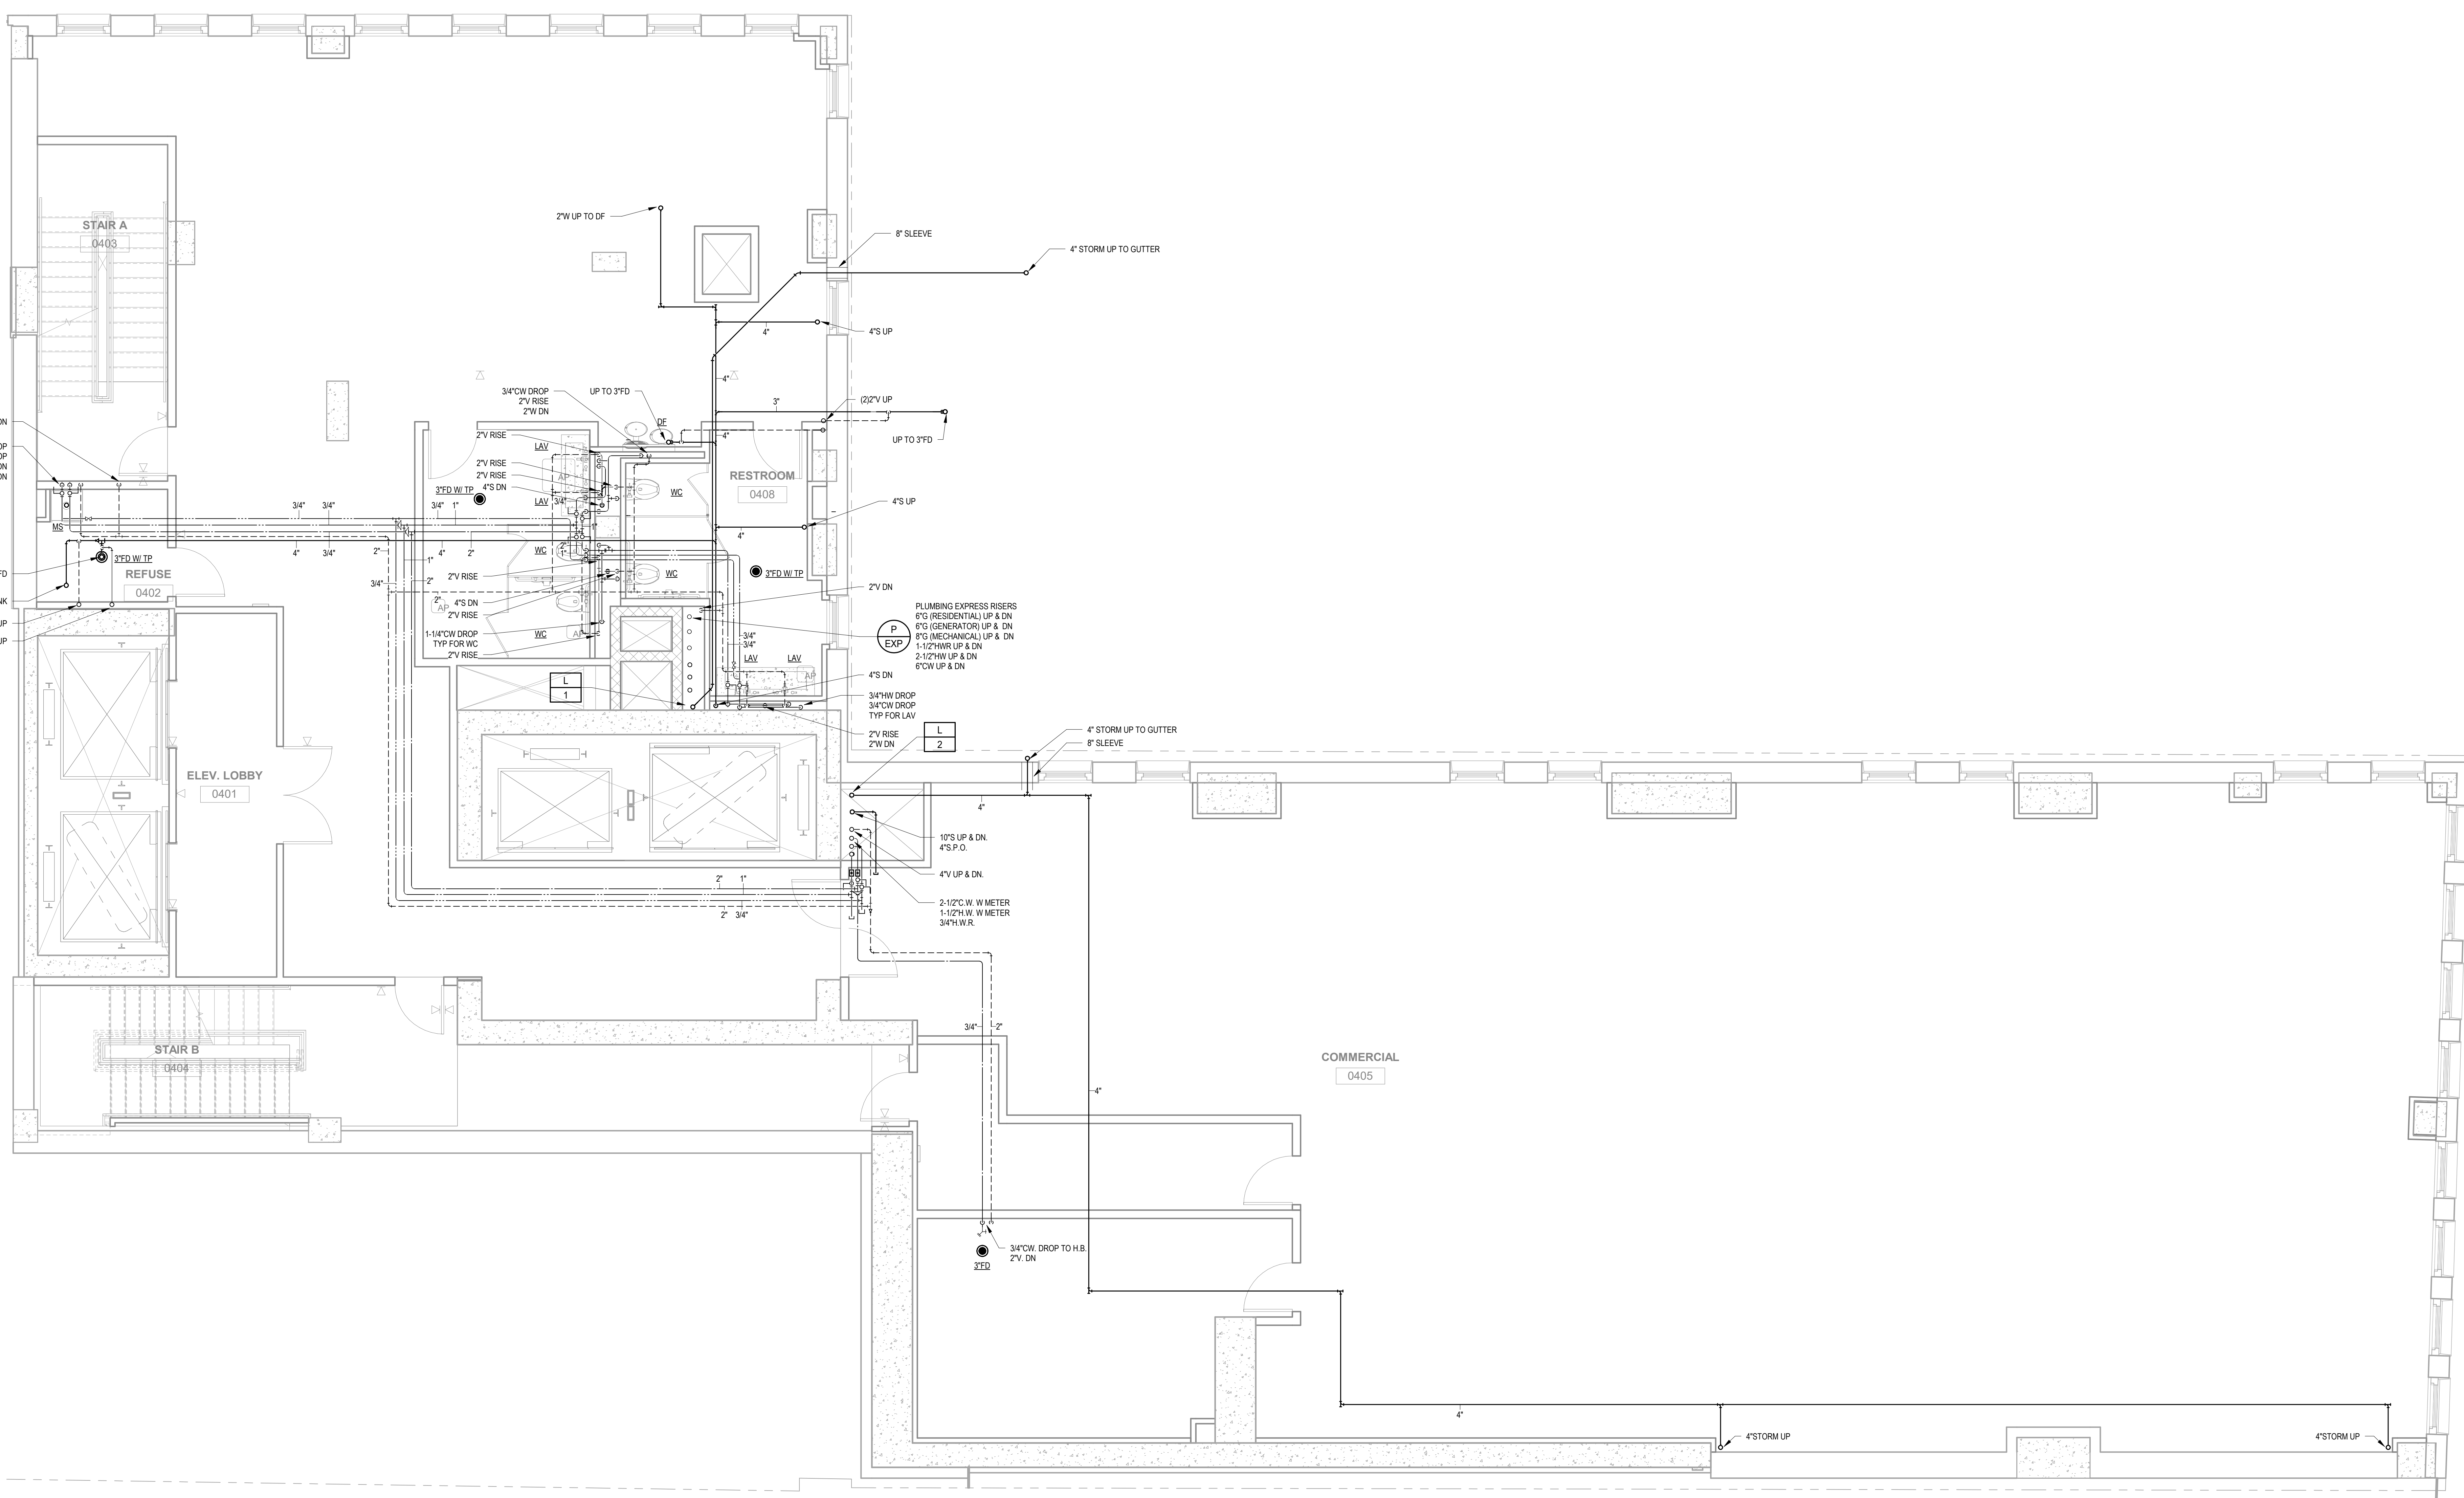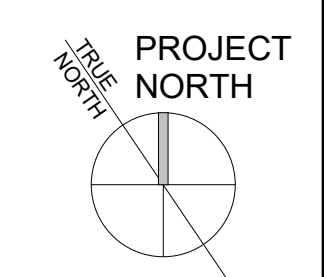

REFER TO BASE BUILDING CONSTRUCTION DOCUMENTS, SPECIFICATIONS, AND DETAILS FOR FURTHER INFORMATION

NO.	DATE	REVISIONS / SUBMISSIONS	Rev.
22			
21			
20			
19			
18			
17			
16	03.15.2022	ISSUED FOR PAA	8
15	12.23.2020	ISSUED FOR PAA	7
14	05.15.2020	ADDENDUM 7	6
13	02.28.2020	ADDENDUM 6	5
12	02.12.2020	ADDENDUM 5	4
11	10.11.2019	ADDENDUM 4	3
10	08.30.2019	DOB FILING SUBMISSION	
9	07.26.2019	DOB FILING SUBMISSION	
8	07.17.2019	ADDENDUM 1	2
7	06.28.2019	ISSUE FOR CONSTRUCTION	
6	05.31.2019	90% CONSTRUCTION DOCUMENTS (PROGRESS SUBMISSION)	
5	05.31.2019	DOB FILING SUBMISSION 05.31.19	1
4	03.22.2019	PROGRESS PRINT (50% CONSTRUCTION DOCUMENTS)	
3	01.18.2019	DESIGN DEVELOPMENT	
2	06.29.2018	DOB Initial Filing Submission	
1	06.22.2018	Schematic Design	

fxcollaborative

FXCollaborative Architects LLP | 22 West 19th Street | New York, NY 10011 | 212.627.1700 | fxcollaborative.com
SEVERUD
 469 Seventh Avenue, Suite 900, New York, NY 10018 212-666-3700
MG ENGINEERING D.P.C.
 116 West 32nd Street, New York, NY 10001 212-643-9005
LANGAN
 21 Park Plaza, 300 West 31st Street, 8th Floor, New York, NY 10001 212-479-5400
GILSANZ MURRAY STEFICEK LLP
 129 West 27th Street, Floor 5, New York, NY 10001 212-254-0030
INC Architecture & Design
 150 Varot Street, Floor 5 South, New York, NY 10013 212-673-1695
ONELUX Studio
 158 West 29th Street, 10th Floor, New York, NY 10001 212-201-9790
RKLA Studio
 333 Hudson Street, Suite 1001, New York, NY 10013 212-229-2534

185 Broadway
 New York, NY 10038

DRAWING TITLE:
4TH FLOOR PLUMBING PLAN

Seal: _____ Drawn: _____ Project No.: 8126.00
 Author: _____



Drawing No.: **P-104.02**

05/22/18
 Scale: 1/4" = 1'-0"
 8 of 37

NEW YORK CITY BUILDING DEPARTMENT APPROVAL NOTE
 THIS PLAN IS APPROVED ONLY FOR WORK INDICATED ON THE APPLICATION SPECIFICATION SHEET. ALL OTHER MATTERS SHOWN ARE NOT TO BE RELIED UPON, OR TO BE CONSIDERED AS EITHER BEING APPROVED OR IN ACCORDANCE WITH APPLICABLE CODES.

NEW YORK CITY ENERGY CONSERVATION CODE
 TO THE BEST OF MY KNOWLEDGE, BELIEF AND PROFESSIONAL JUDGMENT, THESE PLANS AND SPECIFICATIONS ARE IN COMPLIANCE WITH THE 2016 NEW YORK CITY ENERGY CONSERVATION CODE.



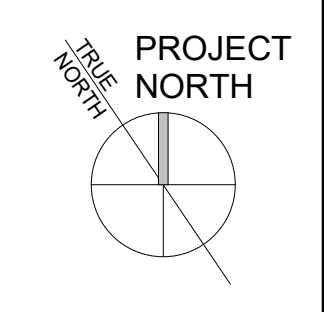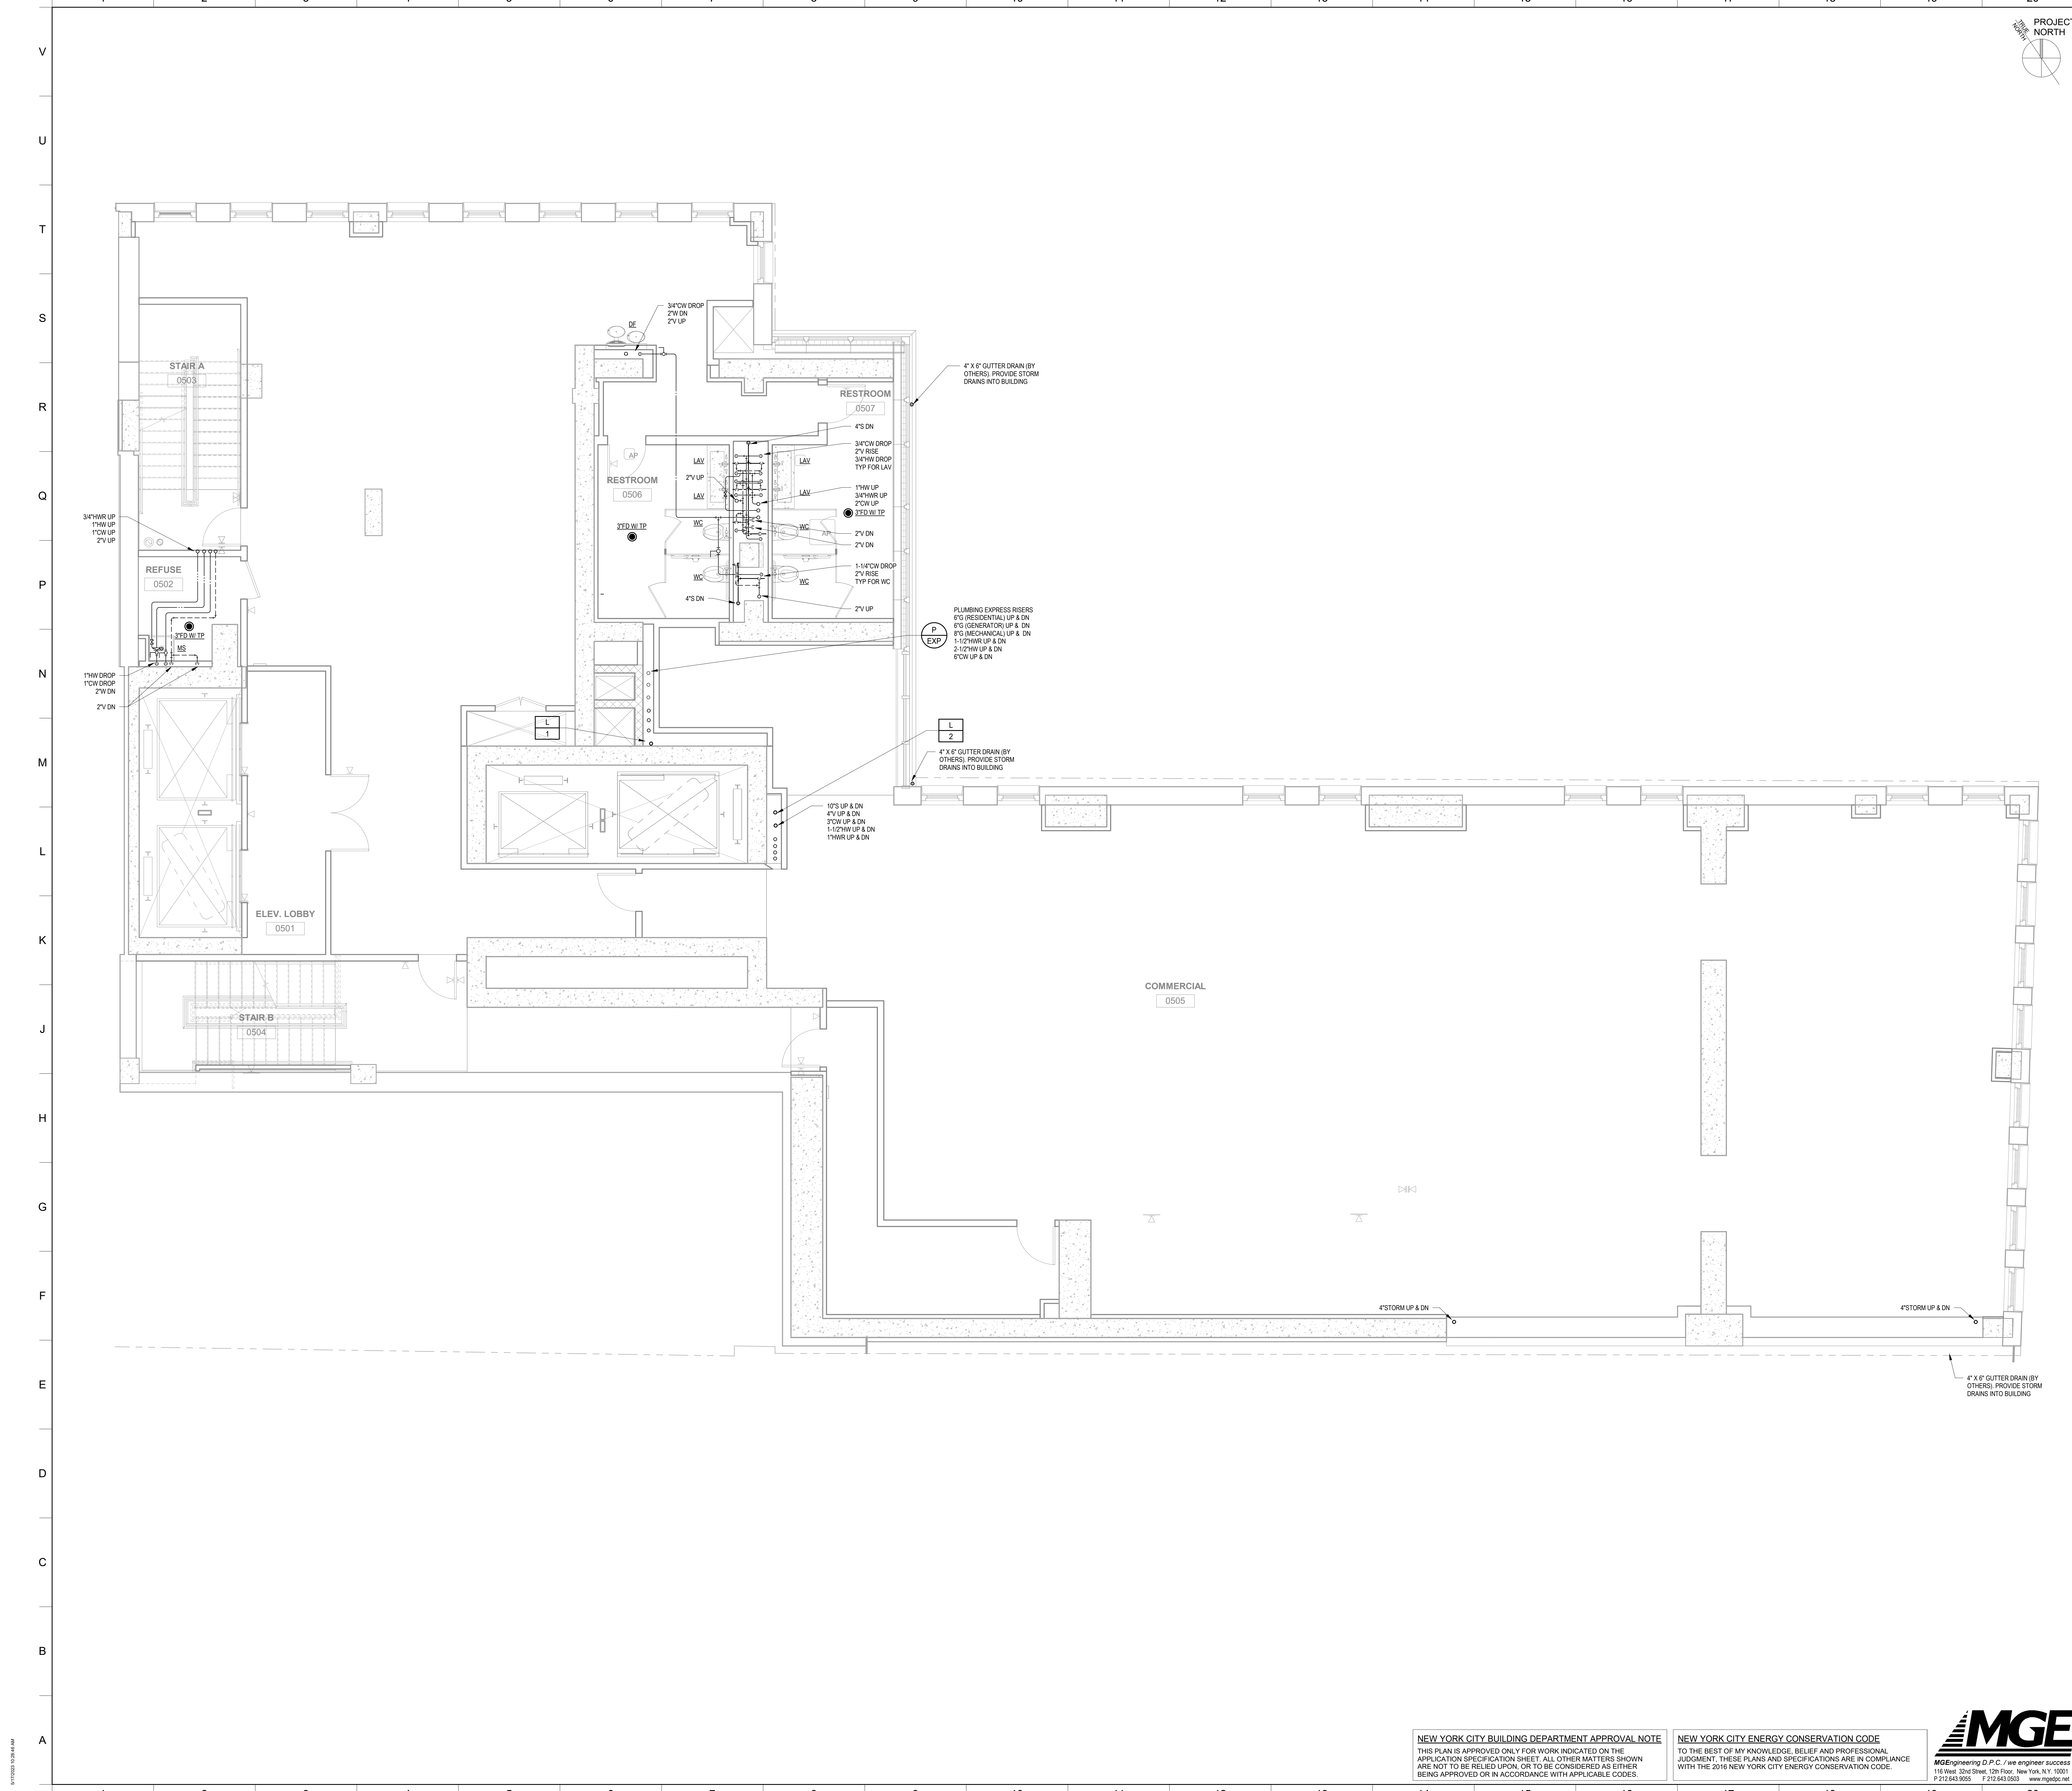

PROJECT NORTH

NO.	DATE	REVISIONS / SUBMISSIONS	Rev. Δ
22			
21			
20			
19			
18			
17			
16			
15	12.23.2020	ISSUED FOR PAA	7
14	08.24.2020	ADDENDUM 9	6
13	05.15.2020	ADDENDUM 7	5
12	02.28.2020	ADDENDUM 6	4
11	02.12.2020	ADDENDUM 5	3
10	10.11.2019	ADDENDUM 4	2
9	08.30.2019	DOB FILING SUBMISSION	
8	07.26.2019	DOB FILING SUBMISSION	
7	06.28.2019	ISSUE FOR CONSTRUCTION	
6	05.31.2019	90% CONSTRUCTION DOCUMENTS (PROGRESS SUBMISSION)	
5	05.31.2019	DOB FILING SUBMISSION 05.31.19	1
4	03.22.2019	PROGRESS PRINT (60% CONSTRUCTION DOCUMENTS)	
3	01.18.2019	DESIGN DEVELOPMENT	
2	06.29.2018	DOB Initial Filing Submission	
1	06.22.2018	Schematic Design	

fxcollaborative

FXCollaborative Architects LLP | 22 West 19th Street | New York, NY 10011 | 212 627 1700 | fxcollaborative.com
SEVERUD
 469 Seventh Avenue, Suite 900, New York, NY 10018 212-686-3700
MG ENGINEERING D.P.C.
 116 West 32nd Street, New York, NY 10001 212-643-9005
LANGAN
 21 Park Place, 300 West 31st Street, 8th Floor, New York, NY 10001 212-479-5400
GILSANZ MURRAY STEFICEK LLP
 129 West 27th Street, Floor 5, New York, NY 10001 212-254-0030
INC Architecture & Design
 150 Varot Street, Floor 5 South, New York, NY 10013 212-673-1695
ONELUX Studio
 158 West 29th Street, 10th Floor, New York, NY 10001 212-201-9790
RKLA Studio
 333 Hudson Street, Suite 1001, New York, NY 10013 212-229-2534

185 Broadway
 New York, NY 10038

DRAWING TITLE:
5TH FLOOR PLUMBING PLAN

Seal: Drawn: Project No.:
 Author: 8126 00



Drawing No.:
P-105.01
 05/22/18
 Scale: 1/4" = 1'-0"
 9 of 37

NEW YORK CITY BUILDING DEPARTMENT APPROVAL NOTE
 THIS PLAN IS APPROVED ONLY FOR WORK INDICATED ON THE APPLICATION SPECIFICATION SHEET. ALL OTHER MATTERS SHOWN ARE NOT TO BE RELIED UPON, OR TO BE CONSIDERED AS EITHER BEING APPROVED OR IN ACCORDANCE WITH APPLICABLE CODES.

NEW YORK CITY ENERGY CONSERVATION CODE
 TO THE BEST OF MY KNOWLEDGE, BELIEF AND PROFESSIONAL JUDGMENT, THESE PLANS AND SPECIFICATIONS ARE IN COMPLIANCE WITH THE 2016 NEW YORK CITY ENERGY CONSERVATION CODE.



MGE Engineering D.P.C. | we engineer success
 116 West 32nd Street, 12th Floor, New York, NY 10001
 P 212.643.9005 F 212.643.9003 www.mgepc.net

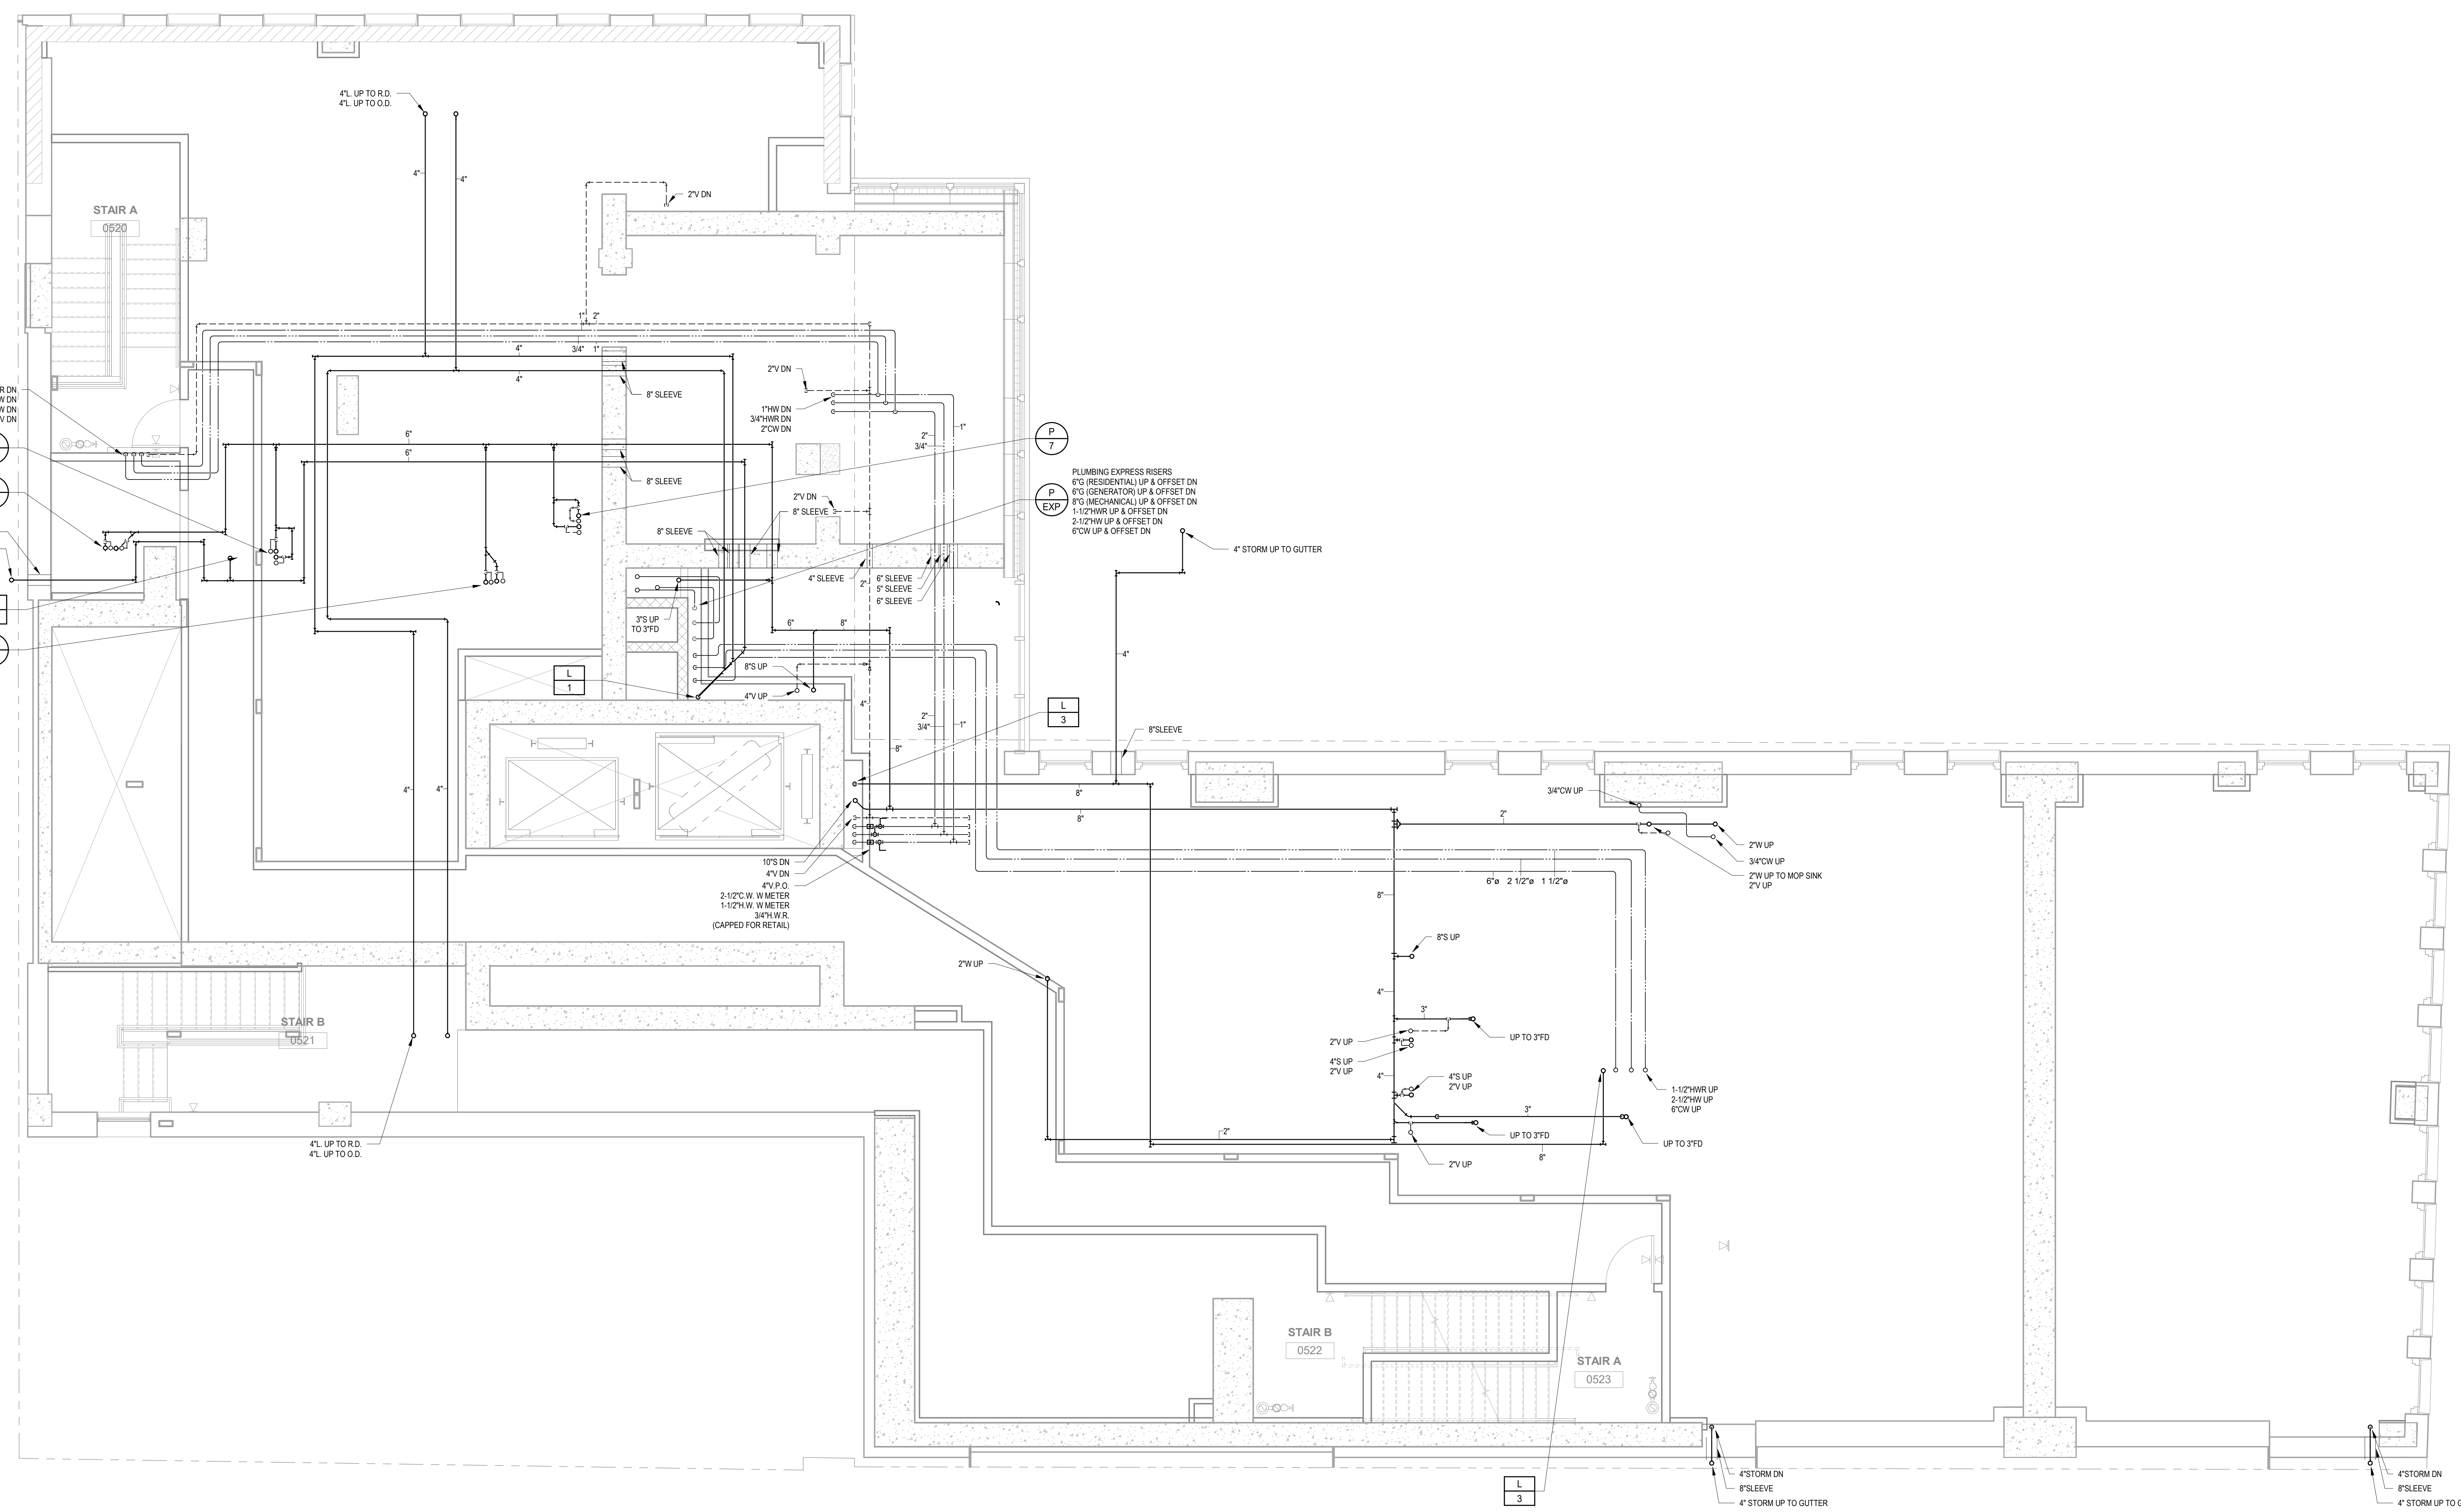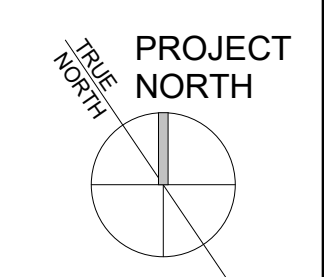

NO.	DATE	REVISIONS / SUBMISSIONS	Rev. Δ
22			
21			
20			
19			
18	06.01.2021	ISSUED FOR PAA	10
17	04.23.2021	ADDENDUM 12	9
16	01.29.2021	ADDENDUM 11	8
15	12.23.2020	ISSUED FOR PAA	7
14	08.24.2020	ADDENDUM 9	6
13	05.15.2020	ADDENDUM 7	5
12	02.28.2020	ADDENDUM 6	4
11	02.12.2020	ADDENDUM 5	3
10	08.30.2019	DOB FILING SUBMISSION	
9	07.26.2019	DOB FILING SUBMISSION	
8	07.17.2019	ADDENDUM 1	2
7	06.28.2019	ISSUE FOR CONSTRUCTION	
6	05.31.2019	90% CONSTRUCTION DOCUMENTS (PROGRESS SUBMISSION)	
5	05.31.2019	DOB FILING SUBMISSION 05.31.19	1
4	03.22.2019	PROGRESS PRINT (50% CONSTRUCTION DOCUMENTS)	
3	01.18.2019	DESIGN DEVELOPMENT	
2	06.29.2018	DOB Initial Filing Submission	
1	06.22.2018	Schematic Design	

fxcollaborative

FXCollaborative Architects LLP | 22 West 19th Street | New York, NY 10011 | 212 627 1700 | fxcollaborative.com
SEVERUD
 469 5th Avenue, Suite 900, New York, NY 10018 212-686-3700
MG ENGINEERING D.P.C.
 116 West 32nd Street, New York, NY 10001 212-643-9005
LANGAN
 21 Park Place, 300 West 31st Street, 8th Floor, New York, NY 10001 212-479-5400
GILSANZ MURRAY STEFICEK LLP
 129 West 27th Street, Floor 5, New York, NY 10001 212-254-0030
INC Architecture & Design
 150 Varot Street, Floor 5 South, New York, NY 10013 212-673-1695
ONELUX Studio
 158 West 29th Street, 10th Floor, New York, NY 10001 212-201-9790
RKLA Studio
 333 Hudson Street, Suite 1001, New York, NY 10013 212-229-2534

185 Broadway
 New York, NY 10038

DRAWING TITLE:
5TH FLOOR MEZZANINE PLUMBING PLAN

Seal: _____ Drawn: _____ Project No.: 8126 00
 Author: _____

Drawing No.: **P-106.02**
 05/23/18
 Scale: 1/4" = 1'-0"
 10 of 37

NEW YORK CITY BUILDING DEPARTMENT APPROVAL NOTE
 THIS PLAN IS APPROVED ONLY FOR WORK INDICATED ON THE APPLICATION SPECIFICATION SHEET. ALL OTHER MATTERS SHOWN ARE NOT TO BE RELIED UPON, OR TO BE CONSIDERED AS EITHER BEING APPROVED OR IN ACCORDANCE WITH APPLICABLE CODES.

NEW YORK CITY ENERGY CONSERVATION CODE
 TO THE BEST OF MY KNOWLEDGE, BELIEF AND PROFESSIONAL JUDGMENT, THESE PLANS AND SPECIFICATIONS ARE IN COMPLIANCE WITH THE 2016 NEW YORK CITY ENERGY CONSERVATION CODE.

