


NO.	REVISIONS

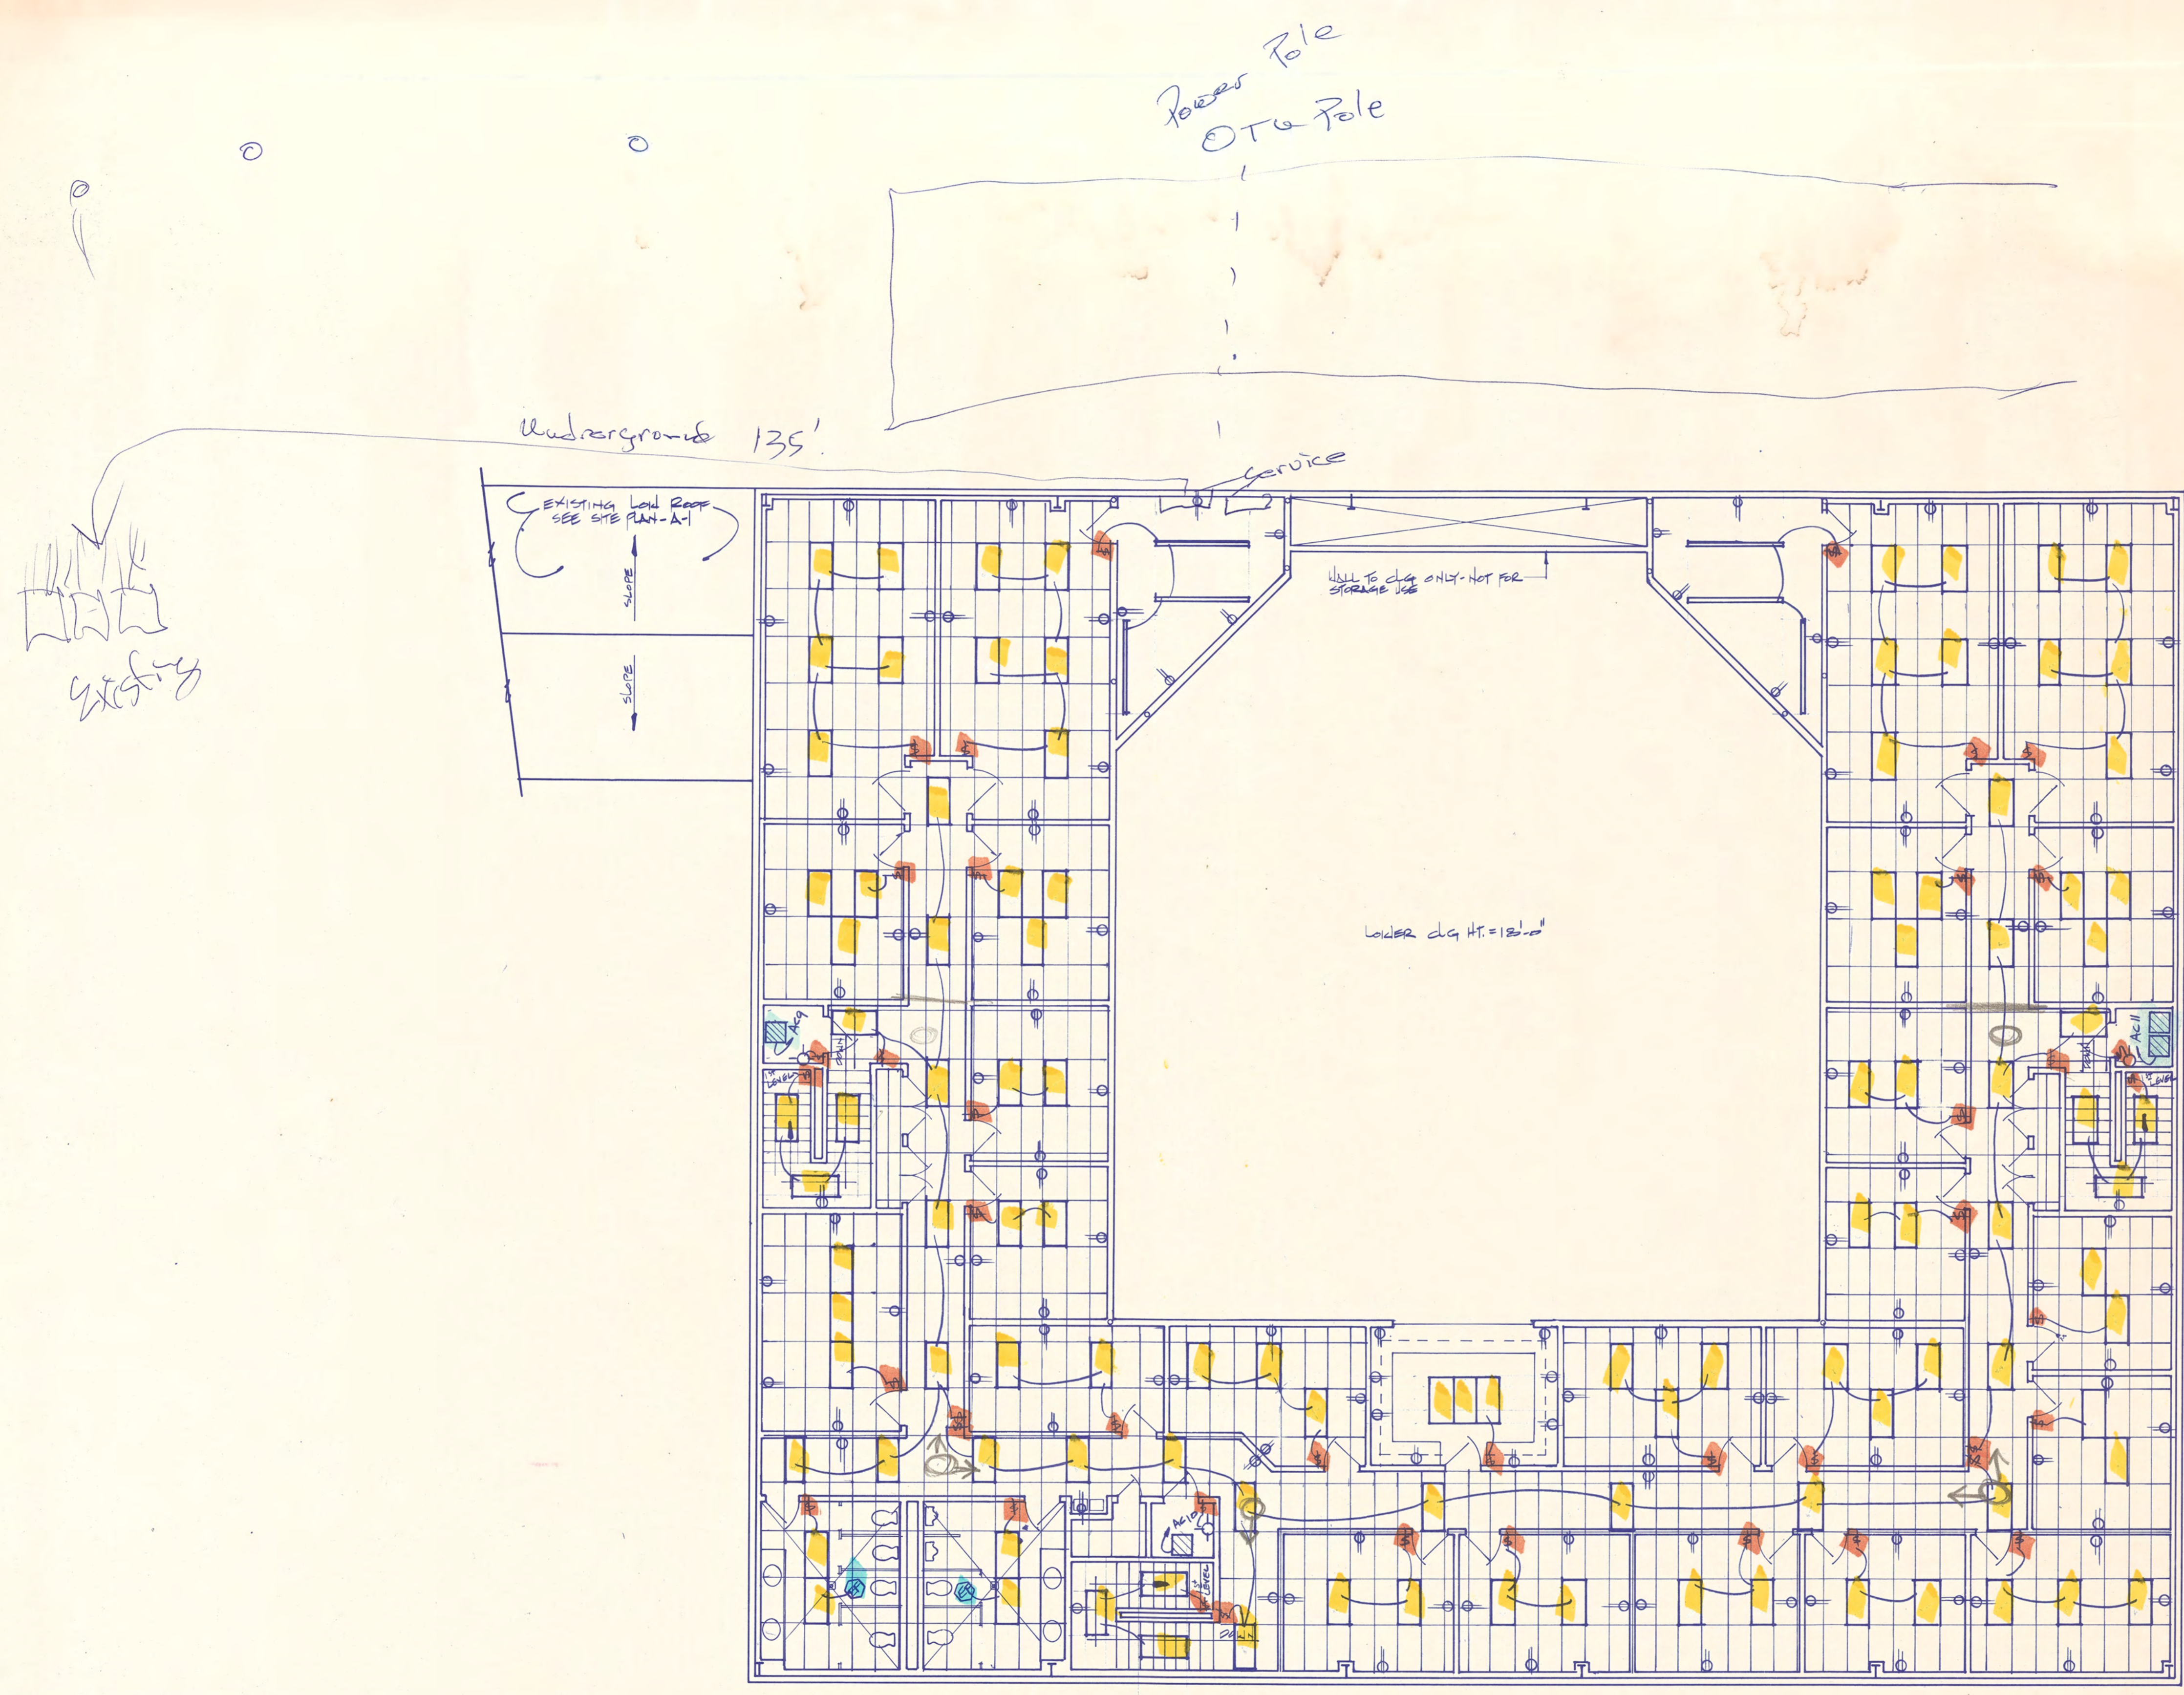

2nd Floor Plan - Electrical

**SUBJ. TO ELD. INSPTR'S APPROV.**  
 CITY OF DALLAS  
 DIVISION OF BUILDING INSPECTION

**DESIGNS UNLIMITED**  
 BUILDING DESIGNS - CONSULTANTS  
 PO BOX 931  
 FORNEY, TEXAS  
 75126  
 214-226-6025



DRAWN *RW*  
 DATE 8/18/06  
 SCALE 1/8" = 1'-0"  
 JOB GRACE ASST. OF GOD CHURCH  
 SHEET

Grace Assembly of God