



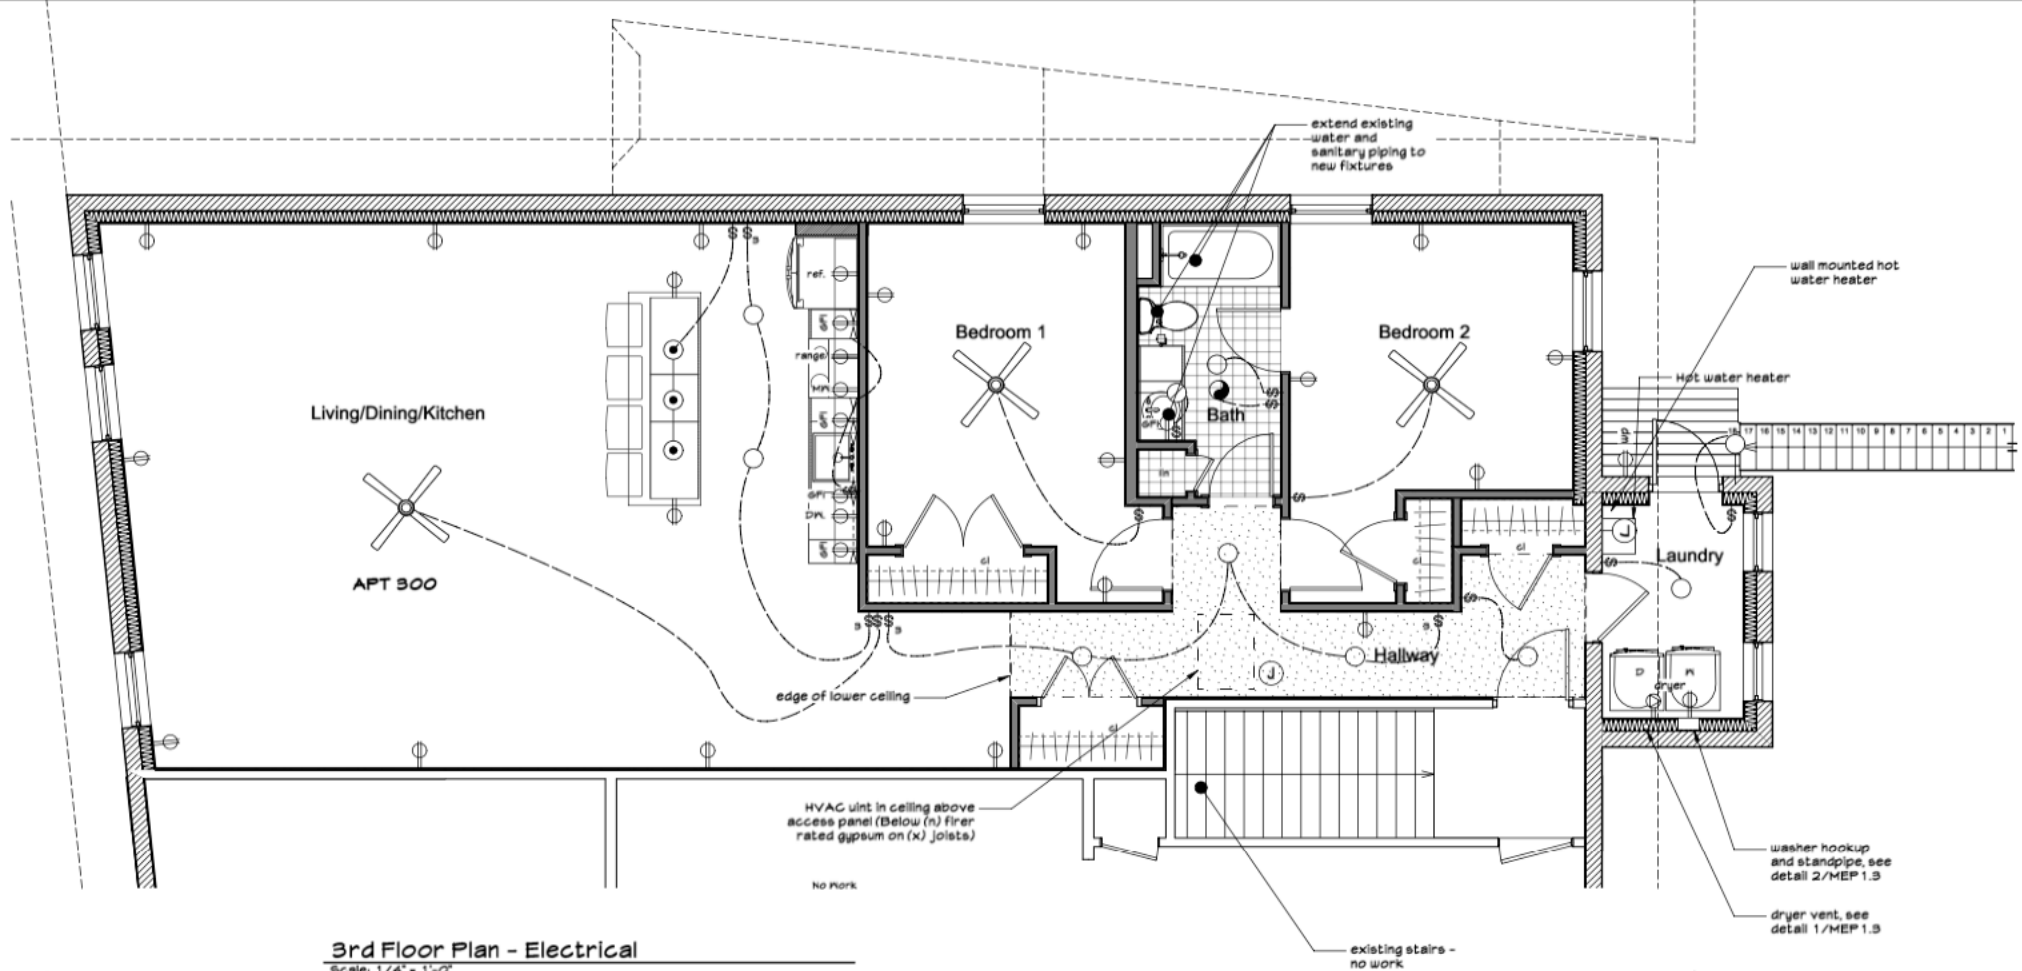

3rd Floor Plan - Electrical

Scale: 1/4" = 1'-0"

Note: (x) outlets not noted

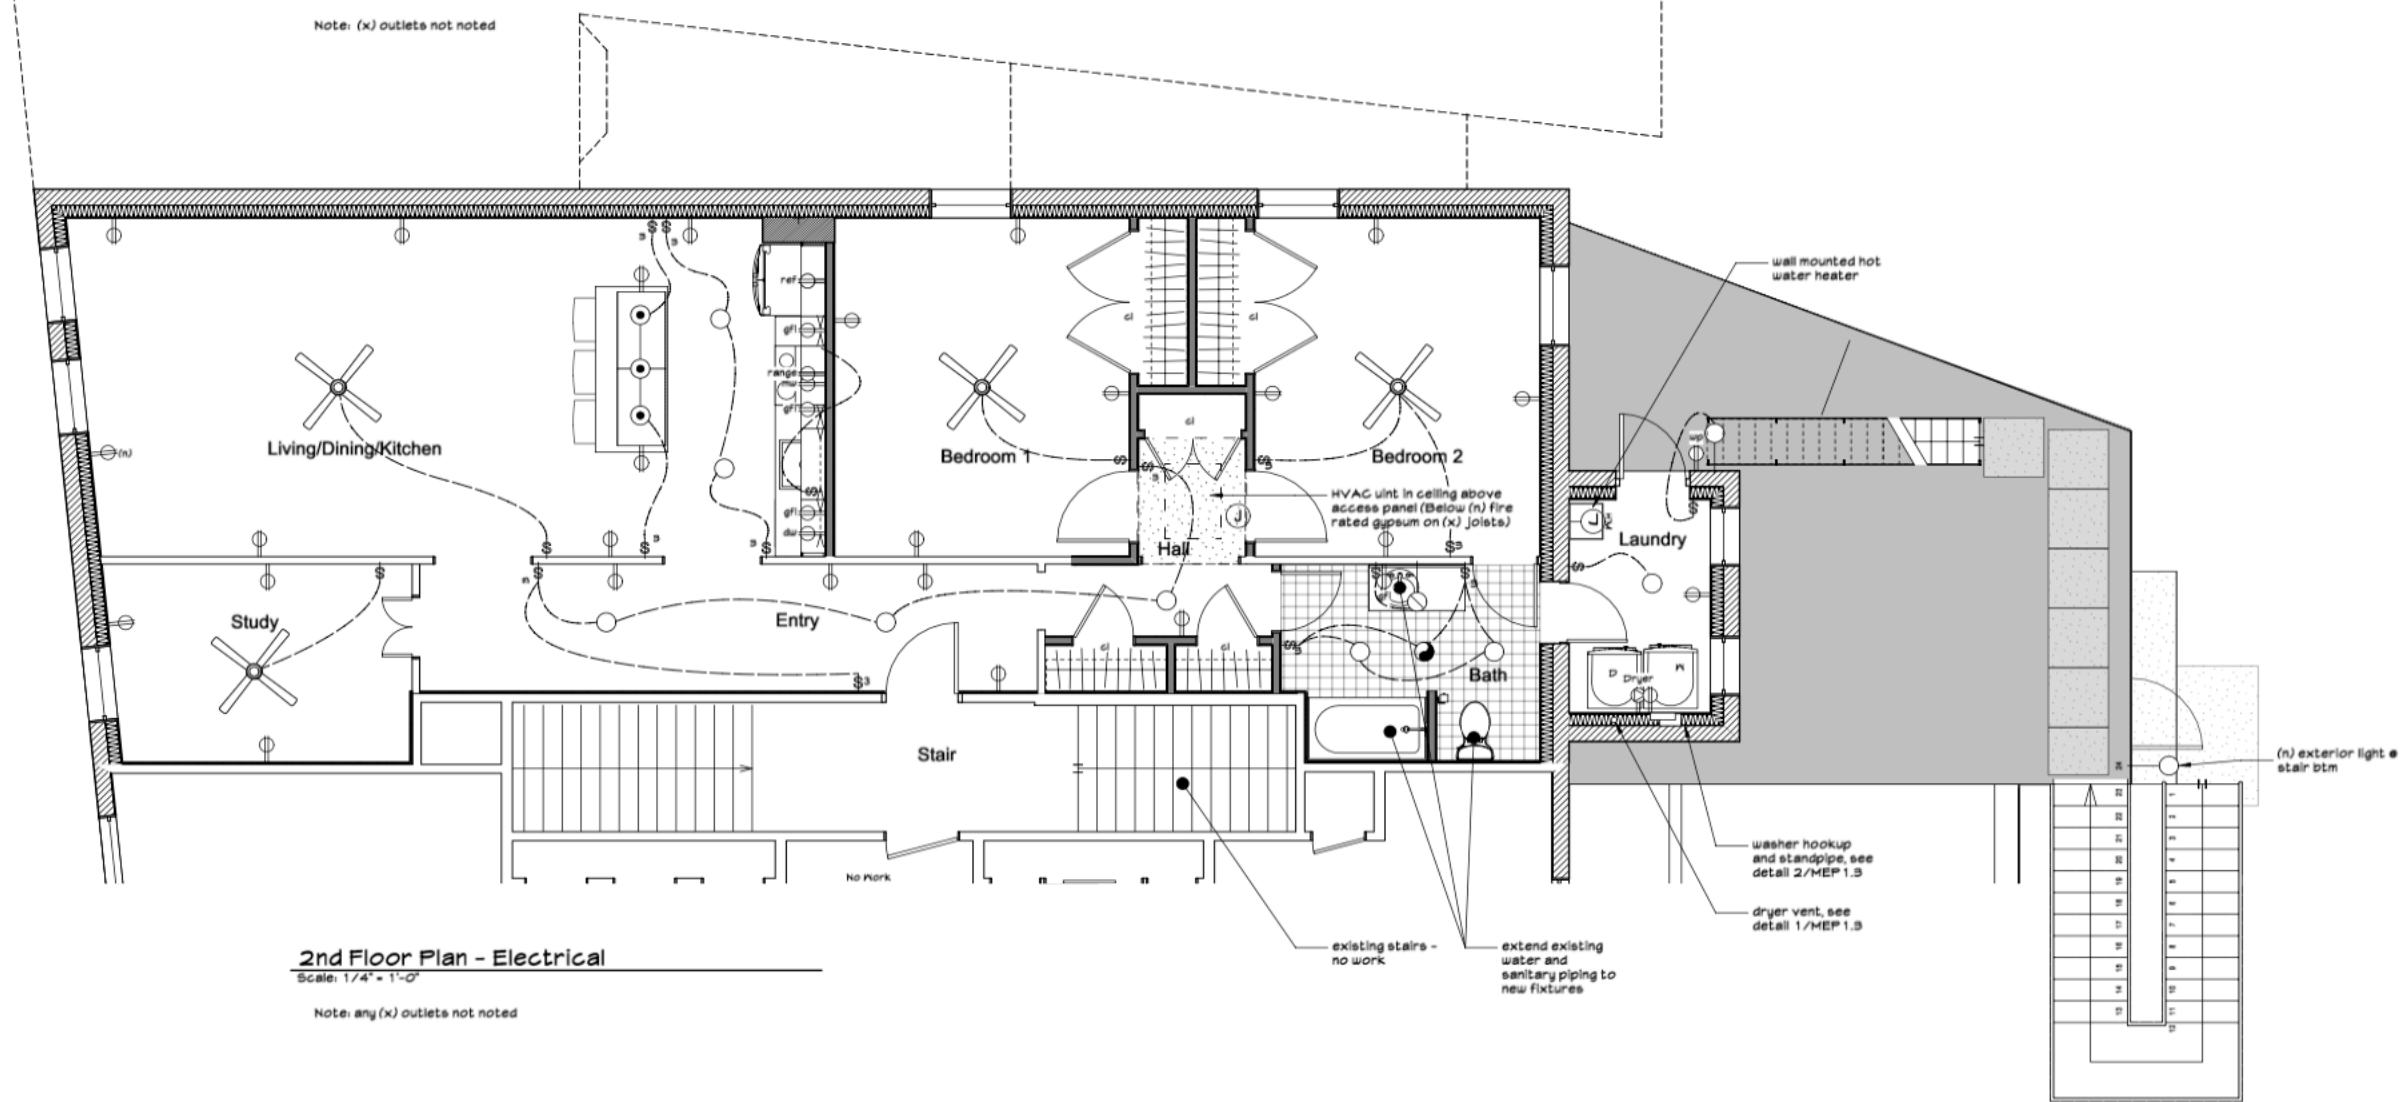

2nd Floor Plan - Electrical

Scale: 1/4" = 1'-0"

Note: any (x) outlets not noted

ELECTRICAL SYMBOLS	
	LIGHT SWITCH (D-DIMMER) (44' A.F.F. MAX.)
	3 WAY SWITCH
	DUPLEX OUTLET
	WATERPROOF OUTLET
	GROUND FAULT INTERRUPT RECEPTACLE
	220 CIRCUIT
	ELECTRICAL WIRE
	ELECTRICAL PANEL
	CEILING MOUNTED INCANDESCENT
	WALL MOUNTED INCANDESCENT
	PENDANT CEILING LIGHT FIXTURE
	EXHAUST FAN/LIGHT COMBO
	UNDER CABINET LIGHT
	CEILING FAN/ LIGHT
	FLOOD LIGHTS (SINGLE OR PAIR)
	HEAT DETECTOR- HARDWIRED
	SMOKE DETECTOR- HARDWIRED

© 2021 Copyright Notice: This material is owned by and is the sole and exclusive property of Steven Glickman Architect and is supplied to the client on a confidential basis solely for use in connection with the project herein. Federal law prohibits the reproduction, display, sale or other disposition of this document without the express written consent of Steven Glickman Architect.

No.	Date	Issue Notes



Design Firm: **Steven Glickman Architect**
 400 Northampton Street, Suite 500
 Easton, PA 18042, 610.253.6536
 610.253.6536, steven@stevenlickmanarchitect.com

Consultant:

Project Title: **Broadway Apartment Renovation**
 1-5 Broadway
 Bangor, PA 18013

Sheet Title: **Electrical Plans**

Project Manager	SLG	Project ID	2126
Drawn By	ARO/SLG	Scale	
Reviewed By	SLG	Sheet No.	MEP 1.2
Date	12.28.21	of	12
CAD File Name	Broadway.vwx		