

1006 JC PARKWAY
BLOOMINGTON, IL



SHEET NO.	DESCRIPTION
1	COVER SHEET
2	FLOOR PLAN
3	ELEVATION VIEWS


[illegible]

ISSUED

DATE	ISSUE DATE
DESIGNED	
DRAWN	BELL
CHECKED	
APPROVED	

GREENE & BRADFORD, INC.
OF SPRINGFIELD

CONSULTING ENGINEERS
3501 CONSTITUTION DRIVE
SPRINGFIELD, ILLINOIS 62711
PROFESSIONAL DESIGN FIRM NO. 184-001179
PROFESSIONAL ENGINEERING CORPORATION
(217) 793-8844, 793-6227

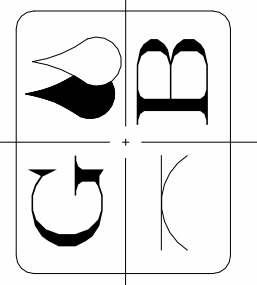

COVER SHEET

FLOOR PLAN AND ELEVATIONS
FOR LDC PROPERTIES
1006 JC PARKWAY
BLOOMINGTON, IL

PROJ. NO. 25303

LOT SCALE





ET NO.
1

NOTE:
ALL DIMENSIONS AND RELATED INFORMATION, INCLUDING ELECTRICAL BOX LOCATIONS,
WERE OBTAINED VIA FIELD INSPECTION AND MEASUREMENTS, AND MAY NOT INCLUDE
COMPLETE INFORMATION. INFORMATION SHOWN ON DRAWINGS SHOULD BE VERIFIED
PRIOR TO CONSTRUCTION.

SCALE IS FOR PAPER SIZE: 24" X 36"

PRINTED ON: 3/28/2025 9:07:59 AM

- 1 3' - 3/4" X 2' - 3/4" WINDOW
- 2 3' - 3/4" X 5' - 0" WINDOW
- 3 4' - 1/2" X 2' - 3/4" WINDOW
- 4 4' - 1/2" X 5' - 0" WINDOW

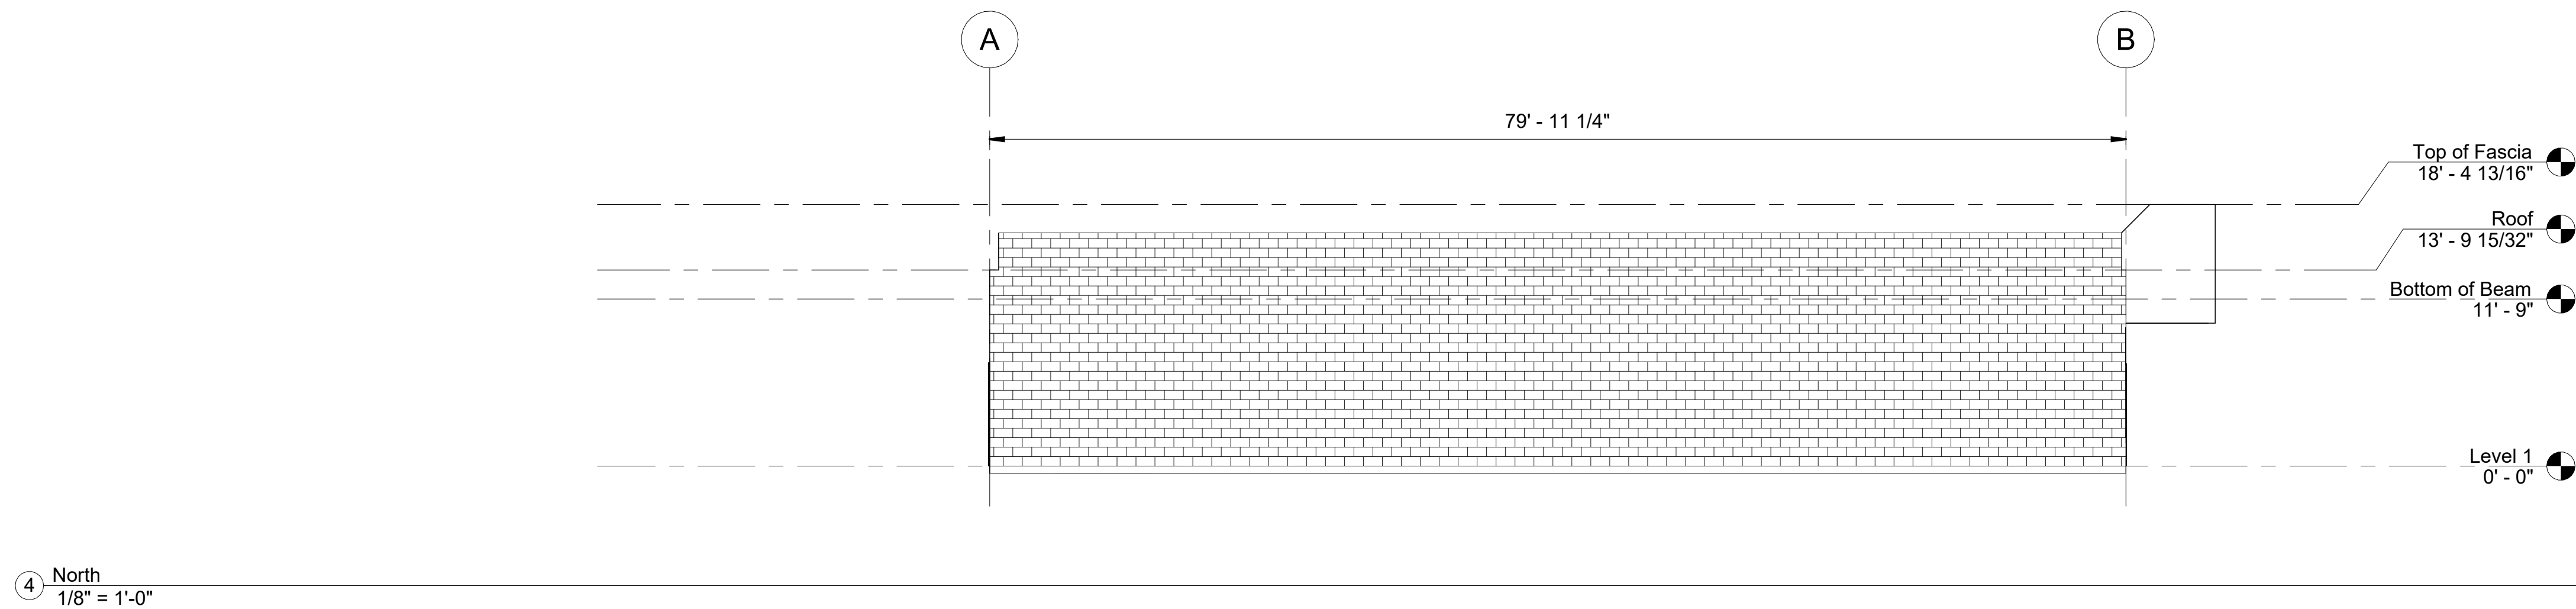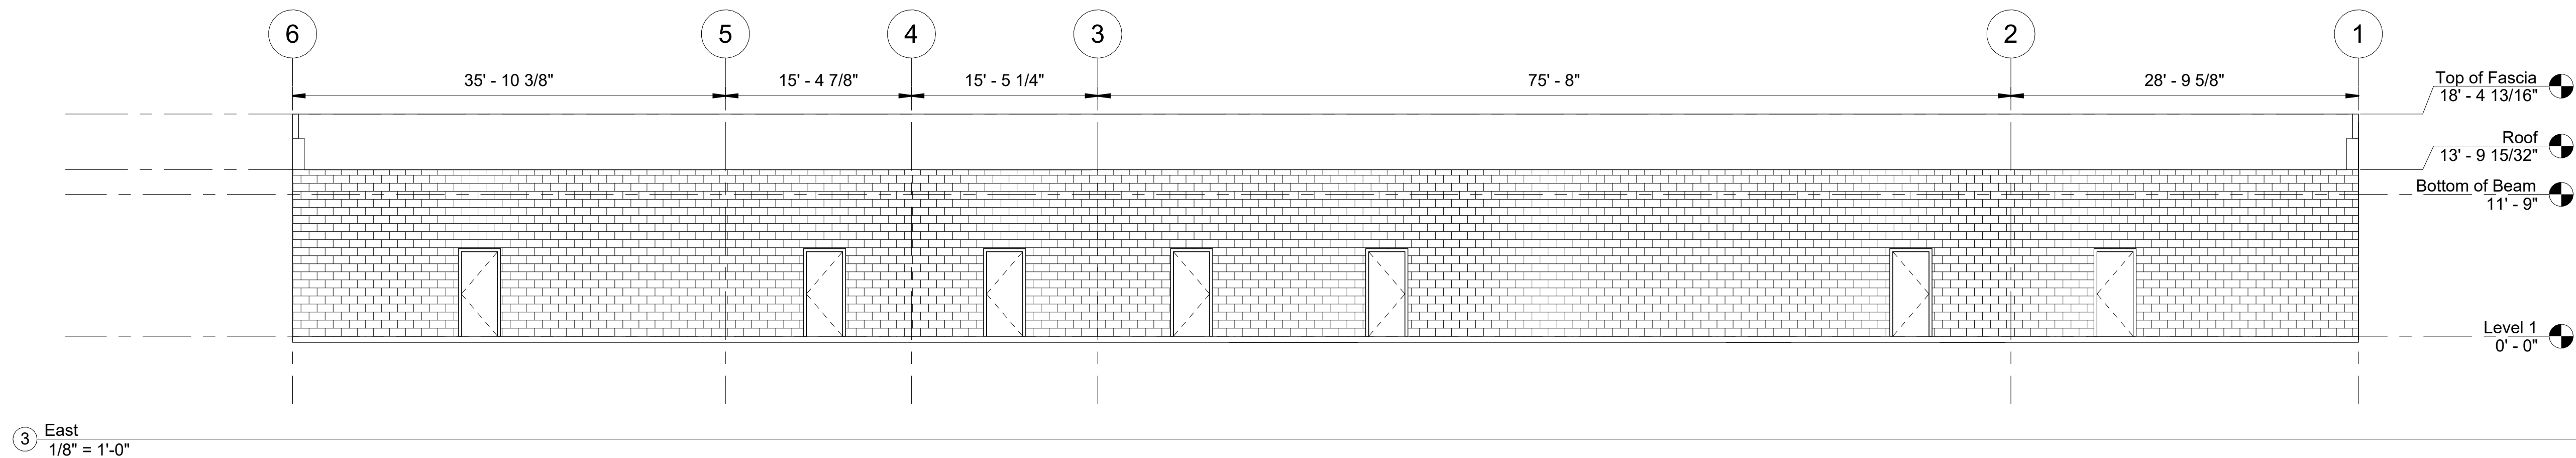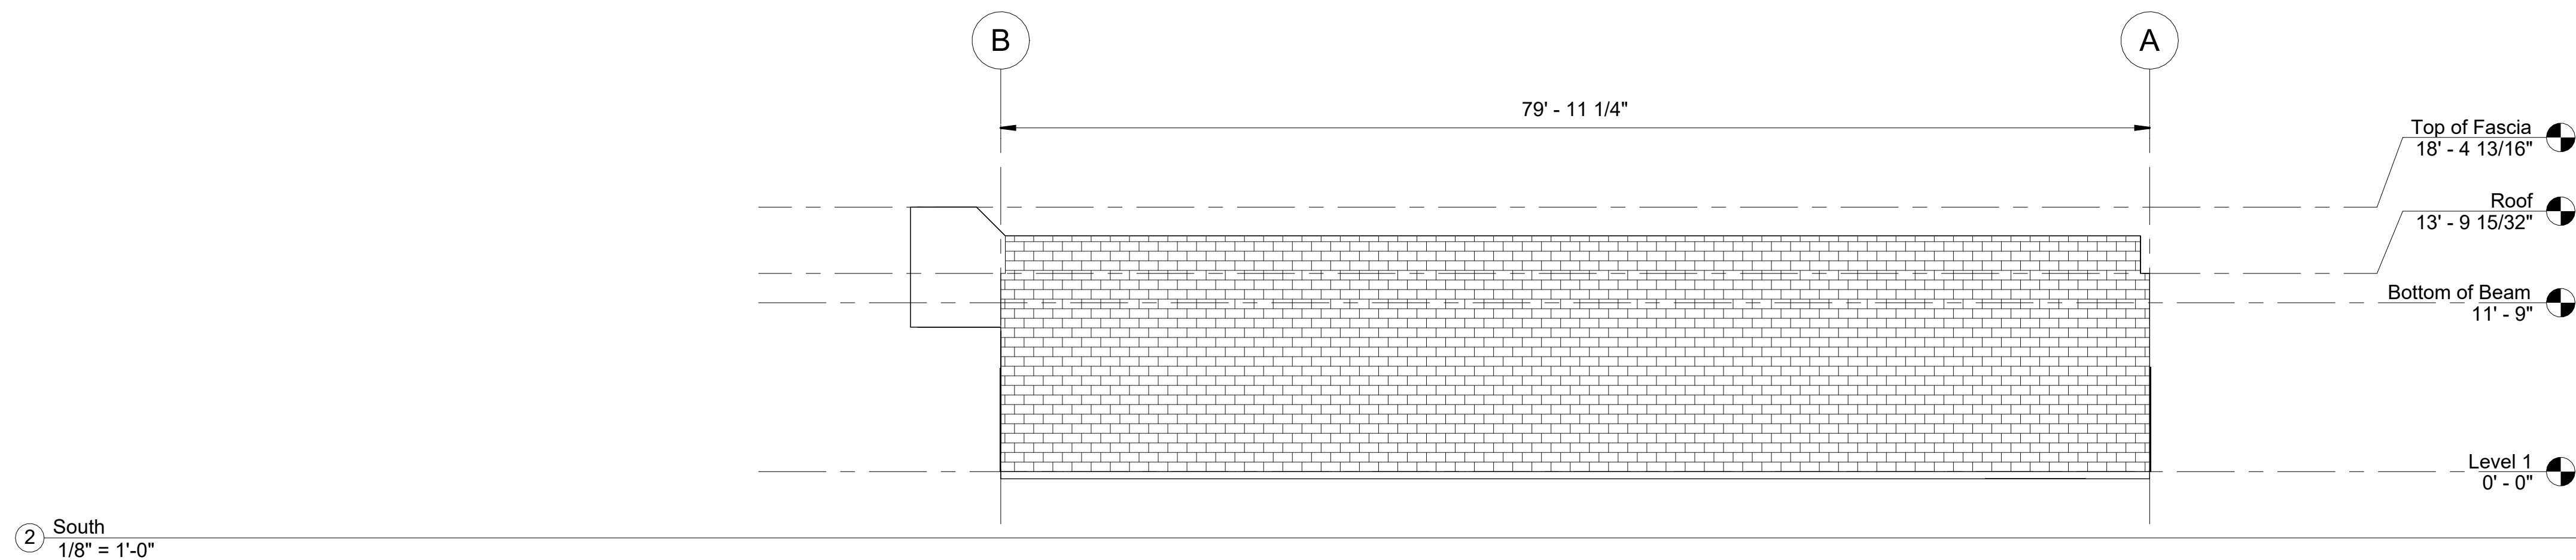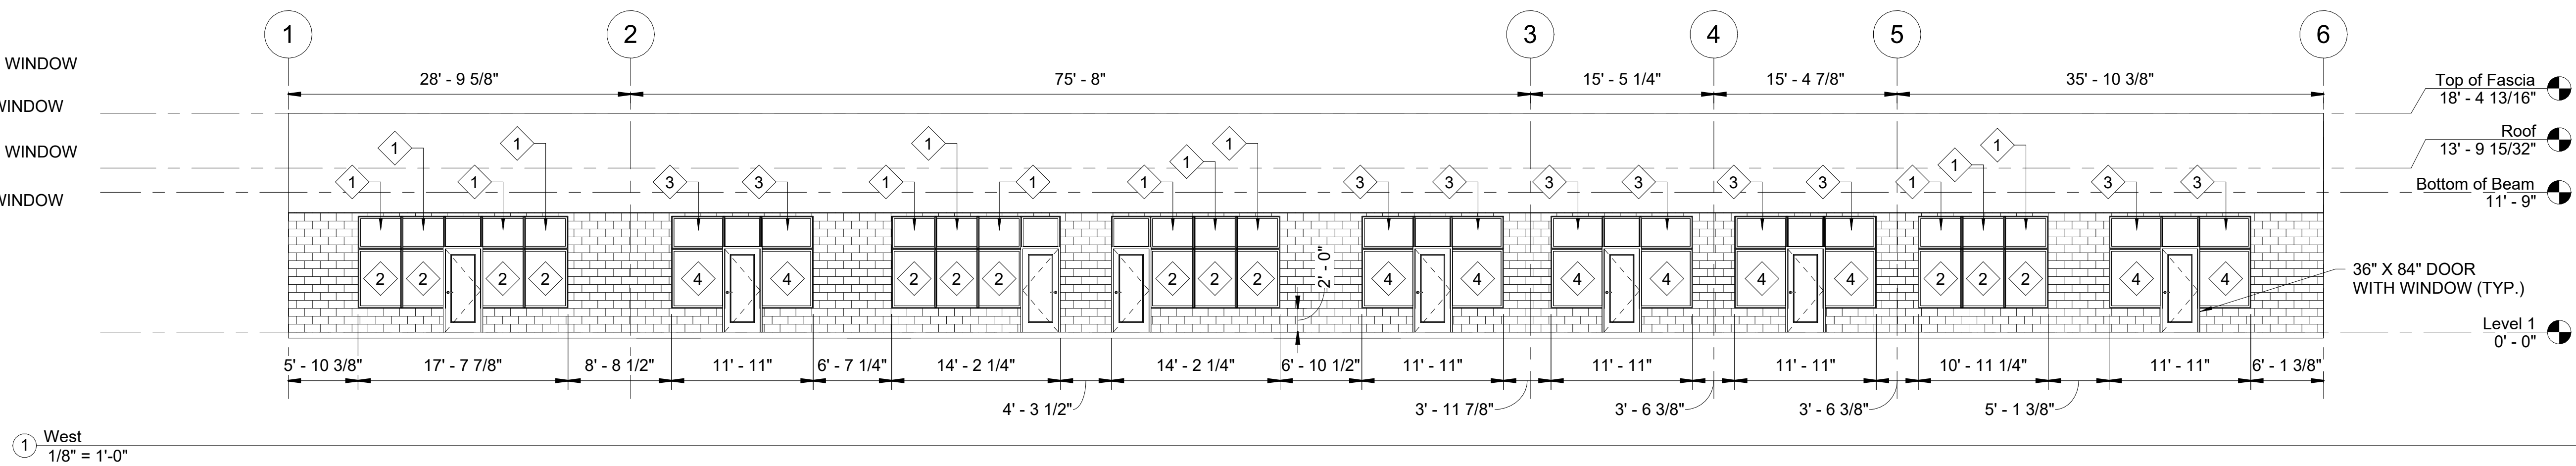

ELEVATION VIEWS	FLOOR PLAN AND ELEVATIONS FOR LDC PROPERTIES 1006 JC PARKWAY BLOOMINGTON, IL		GREENE & BRADFORD, INC. OF SPRINGFIELD	ISSUED	BY	DATE
				ISSUED		
				ISSUED		
				ISSUED		
				ISSUED		
				ISSUED		
PROJ. NO. 25303		CONSULTING ENGINEERS 3601 N. UNIVERSITY AVE. SPRINGFIELD, ILLINOIS 62711 PROFESSIONAL DESIGN FIRM NO. 184-001179 PROFESSIONAL ENGINEERING CORPORATION (217) 793-8844, 793-6227				
PLOT SCALE 1/8" = 1'-0"		DATE DESIGNED DRAWN CHECKED APPROVED				
SHEET NO. 3						