
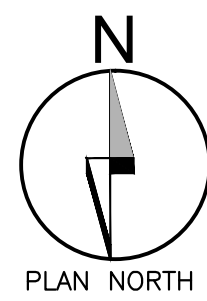


01 FLOOR PLAN
SCALE: 1/4"=1'-0"

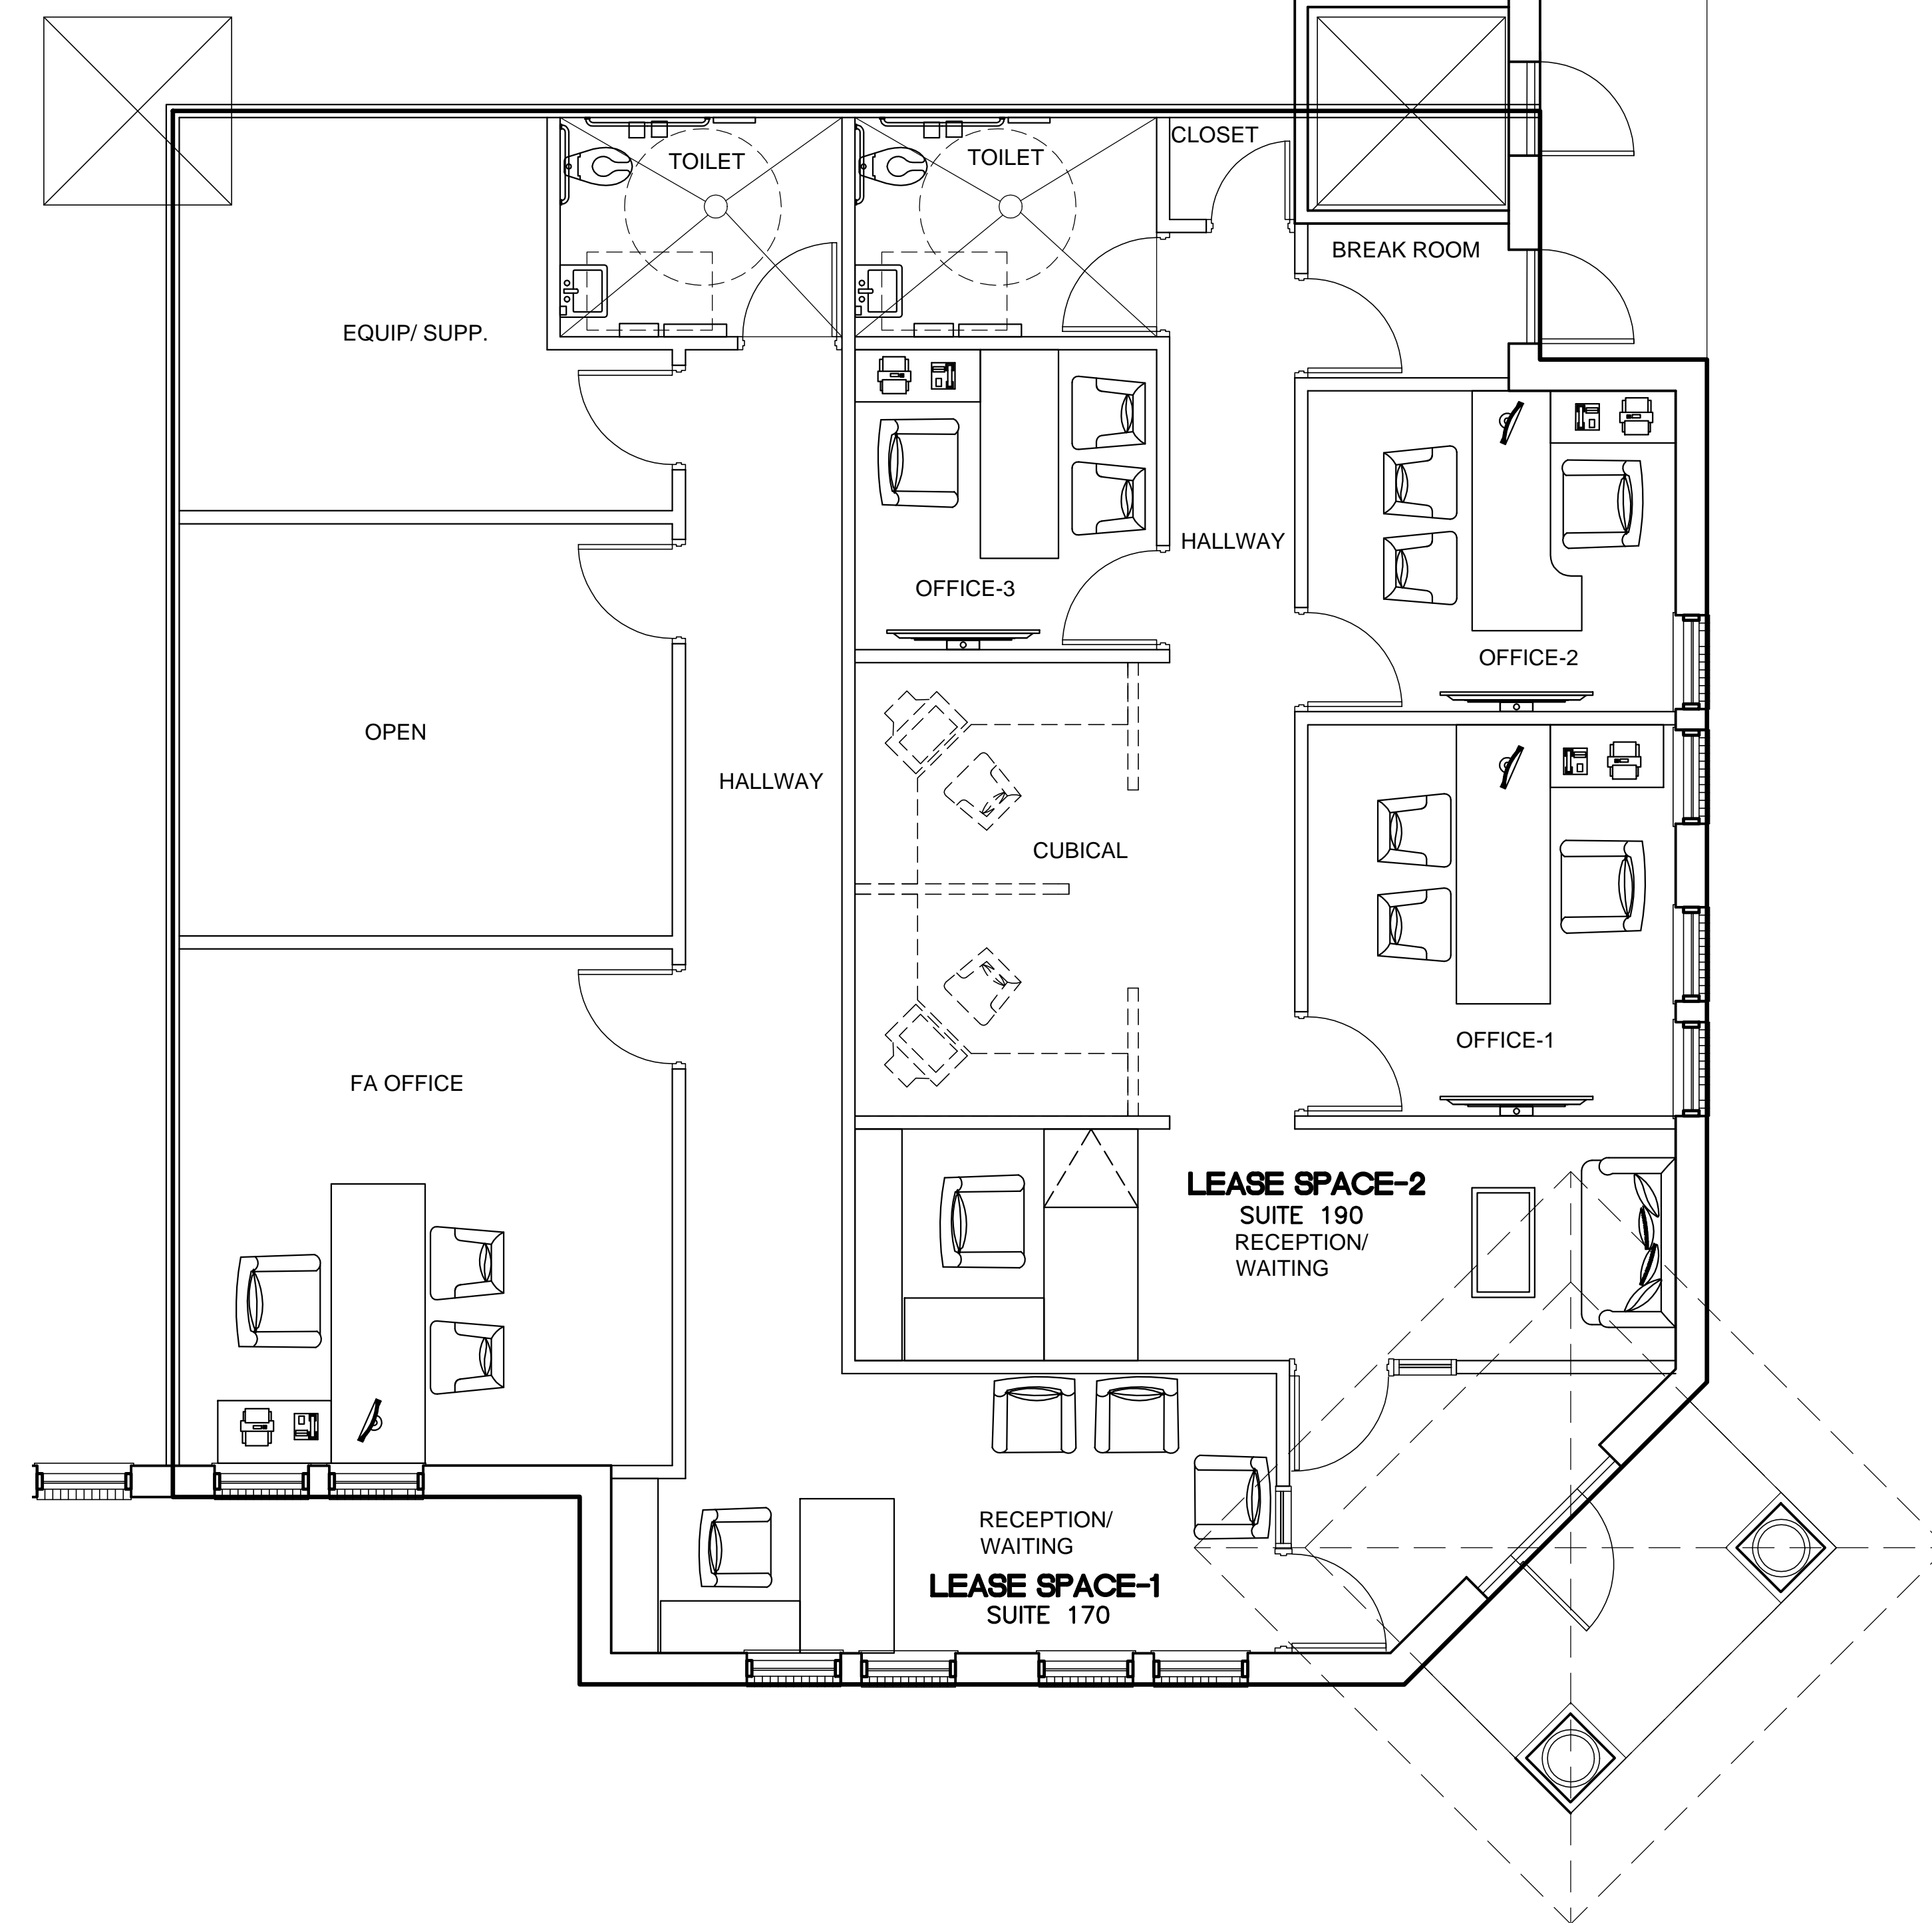

02 FURNISHING PLAN
SCALE: 1/4"=1'-0"

WALL LEGEND - INTERIOR

WALL TYPE	SYMBOL	DESCRIPTION
A	=====	1 HR RATED STUD WALL, FULL HEIGHT TO DECK WITH 5/8" GYP. BD. (TYPE FIRECODE "C" OR "X") ON BOTH SIDES. (REF. DETAILS 07/A3011 FOR U.L. DETAILS)
B C	=====	STUD WALL WITH 5/8" GYP. BD. HEIGHT, WIDTH AND INSULATION VARIES. REFER TO SHEET A801 FOR ACTUAL CONDITIONS.
	-----	ITEM NIC-UNO
D	=====	MODULAR WALL SYSTEM-NIC
E	=====	FULLY HEIGHT GLASS PARTITION

GENERAL NOTES:

- ALL MECHANICAL AND ELECTRICAL OPERATING DEVICES (SUCH AS ELECTRICAL SWITCH, RECEPTACLE, THERMOSTATS, OUTLETS ETC. ARE TO BE MOUNTED AT 48" A.F.F. MAX FOR FRONT APPROACH AND 54" A.F.F. FOR SIDE APPROACH.
- CONTRACTOR TO VERIFY THE LOCATIONS, SIZES AND DIMENSIONS OF ALL FIXTURES WITH TENANT PRIOR TO INSTALLATION OR PLACING ORDER

ADA COMPLIANCE NOTE FOR TENANT:

LEASE HOLDER TO COMPLY WITH THE FOLLOWINGS TO MEET ADA REQUIRED FOR COUNTERS:

COUNTERS WITH CASH REGISTERS AND COUNTERS WITHOUT CASE REGISTERS SHALL HAVE AN ACCESSIBLE SECTION AT EACH TYPE OF COUNTER HAVING A 36 INCHES MINIMUM WIDTH AND A 36 INCHES MAXIMUM HEIGHT ABOVE THE FINISH FLOOR.

NOTE:

FOR INSULATION REQUIREMENTS OF PARTITION TYPES REFER TO REFERENCED DETAILS AS SHOWN IN LEGEND

FOR TYPICAL PLUMBING FIXTURE LOCATIONS. REFER TO SHEET A202.

FOR RESTROOM FINISHES REF. SHEET A601 SANDED, SMOOTH, FINISH. REFER TO FINISH SCHEDULE FOR PAINTING

ALL DIMENSIONS ARE TO FACE OF STUD AND DOOR OPENING

ALL WET WALLS AND WALLS IMMEDIATELY ADJACENT TO WET WALLS ARE TO RECEIVE WATER RESISTANT GYP. BD. WITH A THICKNESS AS SPECIFIED BY PARTITION TYPE.

Original Date:
FEBRUARY 18, 2018

Issue Log

ISSUED FOR REVIEW	02/08/2018
ISSUED FOR REVIEW	03/09/2018
ISSUED FOR REVIEW	03/09/2018
ISSUED FOR PERMIT	03/25/2018
ISSUED FOR CONSTRUCTION	03/25/2018

DRAWN BY: CHECKED BY:

© COPYRIGHT

OFFICE SPACE
INTERIOR FINISH OUT
AT 935 W EXCHANGE PARKWAY, SUITE 170
ALLEN, TEXAS

This document, whether in hard copy or electronic readable format, is copyrighted by the individual or firm named in the project for which it was prepared. This document is not to be used or reproduced for reuse by any party on any project or any other project without the express written permission of the individual or firm named in the project. Any reuse, including copying, scanning, or otherwise reproducing, without the express written permission of the individual or firm named in the project, is prohibited. The use of this material may result in civil and/or criminal penalties.

Sheet Number:
A202
Project Number:
18-013