



If this sheet is less than 22"x34" in size, it has been reduced.  
Graphic scales must be adjusted accordingly.

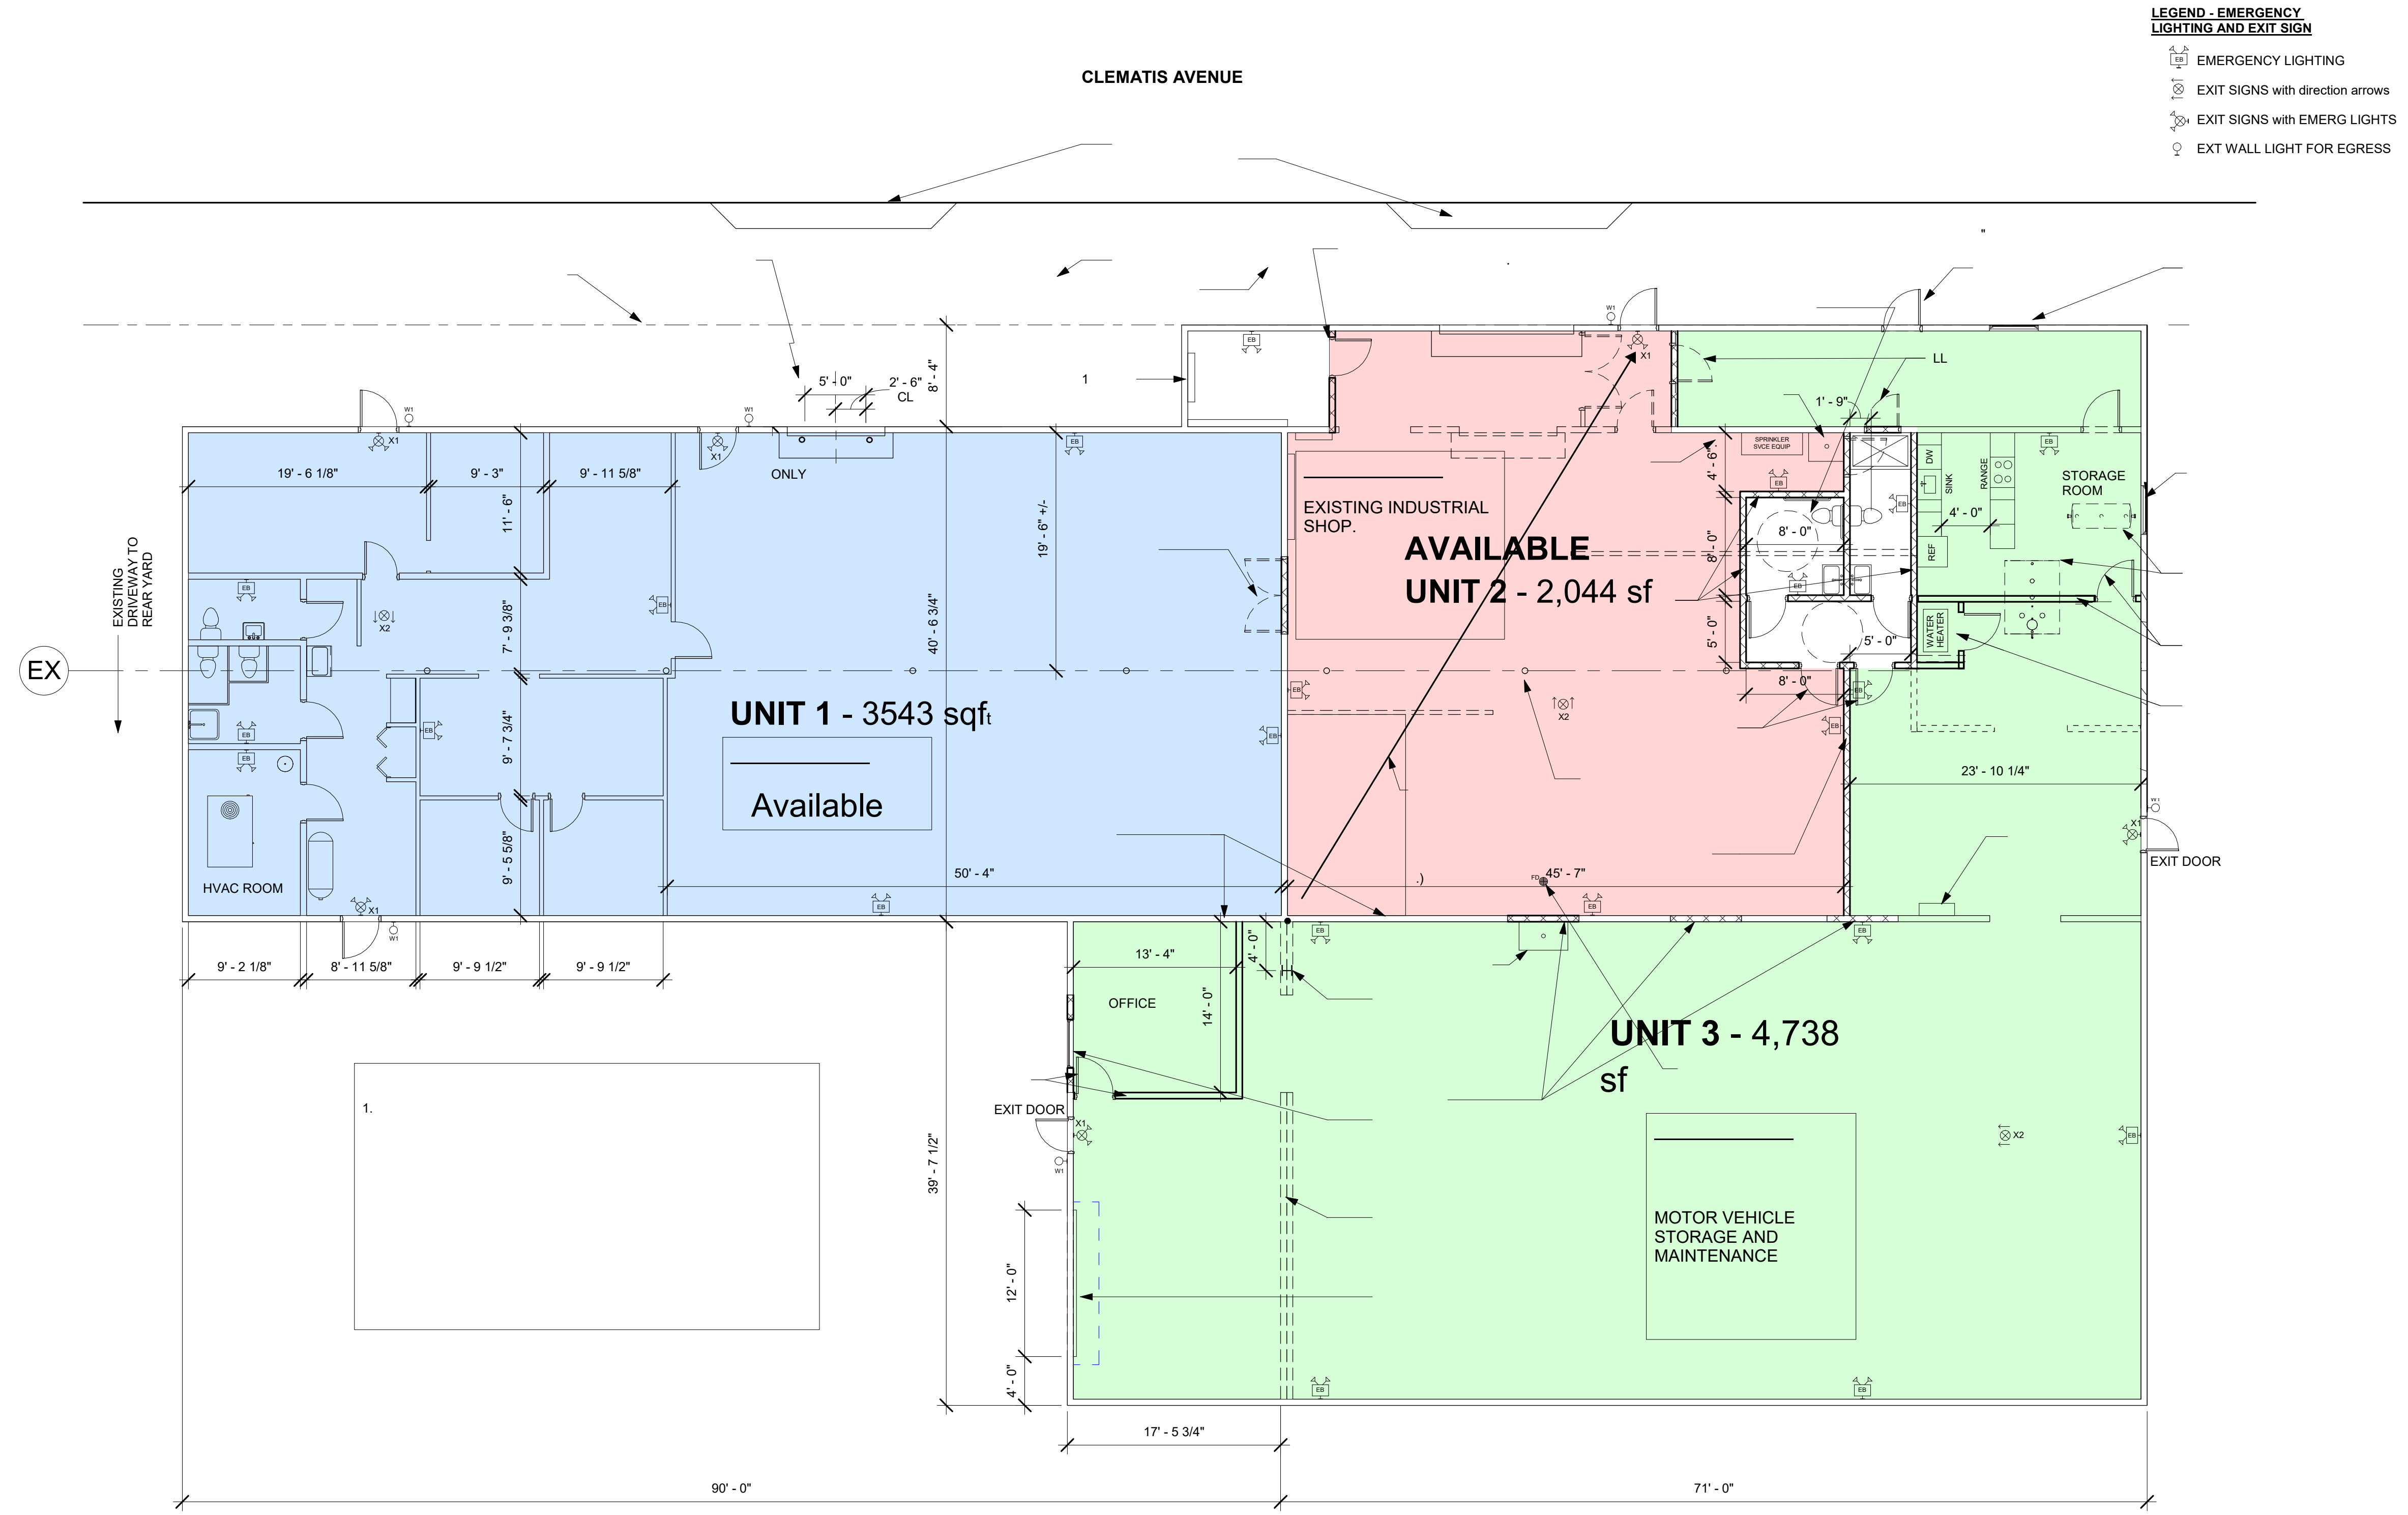

- LEGEND - EMERGENCY LIGHTING AND EXIT SIGN**
- EMERGENCY LIGHTING
  - EXIT SIGNS with direction arrows
  - EXIT SIGNS with EMERG LIGHTS
  - EXT WALL LIGHT FOR EGRESS

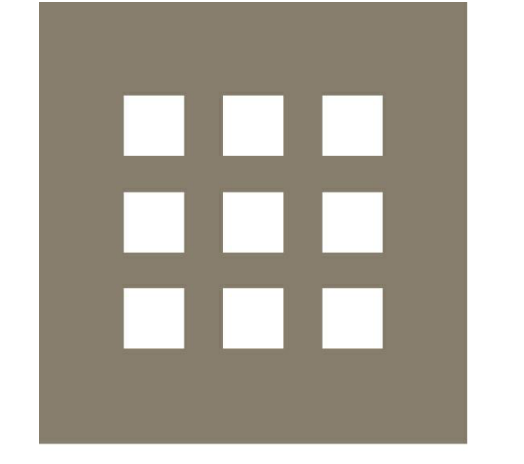

**DHK**  
ARCHITECTS

54 Canal Street  
2nd Floor  
Boston, MA 02114  
617-267-6408  
Fax 617-267-1990

70 CLEMATIS AVE  
WALTHAM, MA

| No. | Date | Revision |
|-----|------|----------|
| 1   |      | 0        |

CONFORMED  
ARCHITECTURAL FLOOR  
PLAN

Scale  
1/8" = 1'-0"



File Name  
SK-1  
Drawn By  
JB  
Checked By  
BS  
Job No.  
5037  
Date  
2023-08-18

Drawing No.  
**SK-1**

1 Floor Plan - Unit Demising Plan  
1/8" = 1'-0"

