


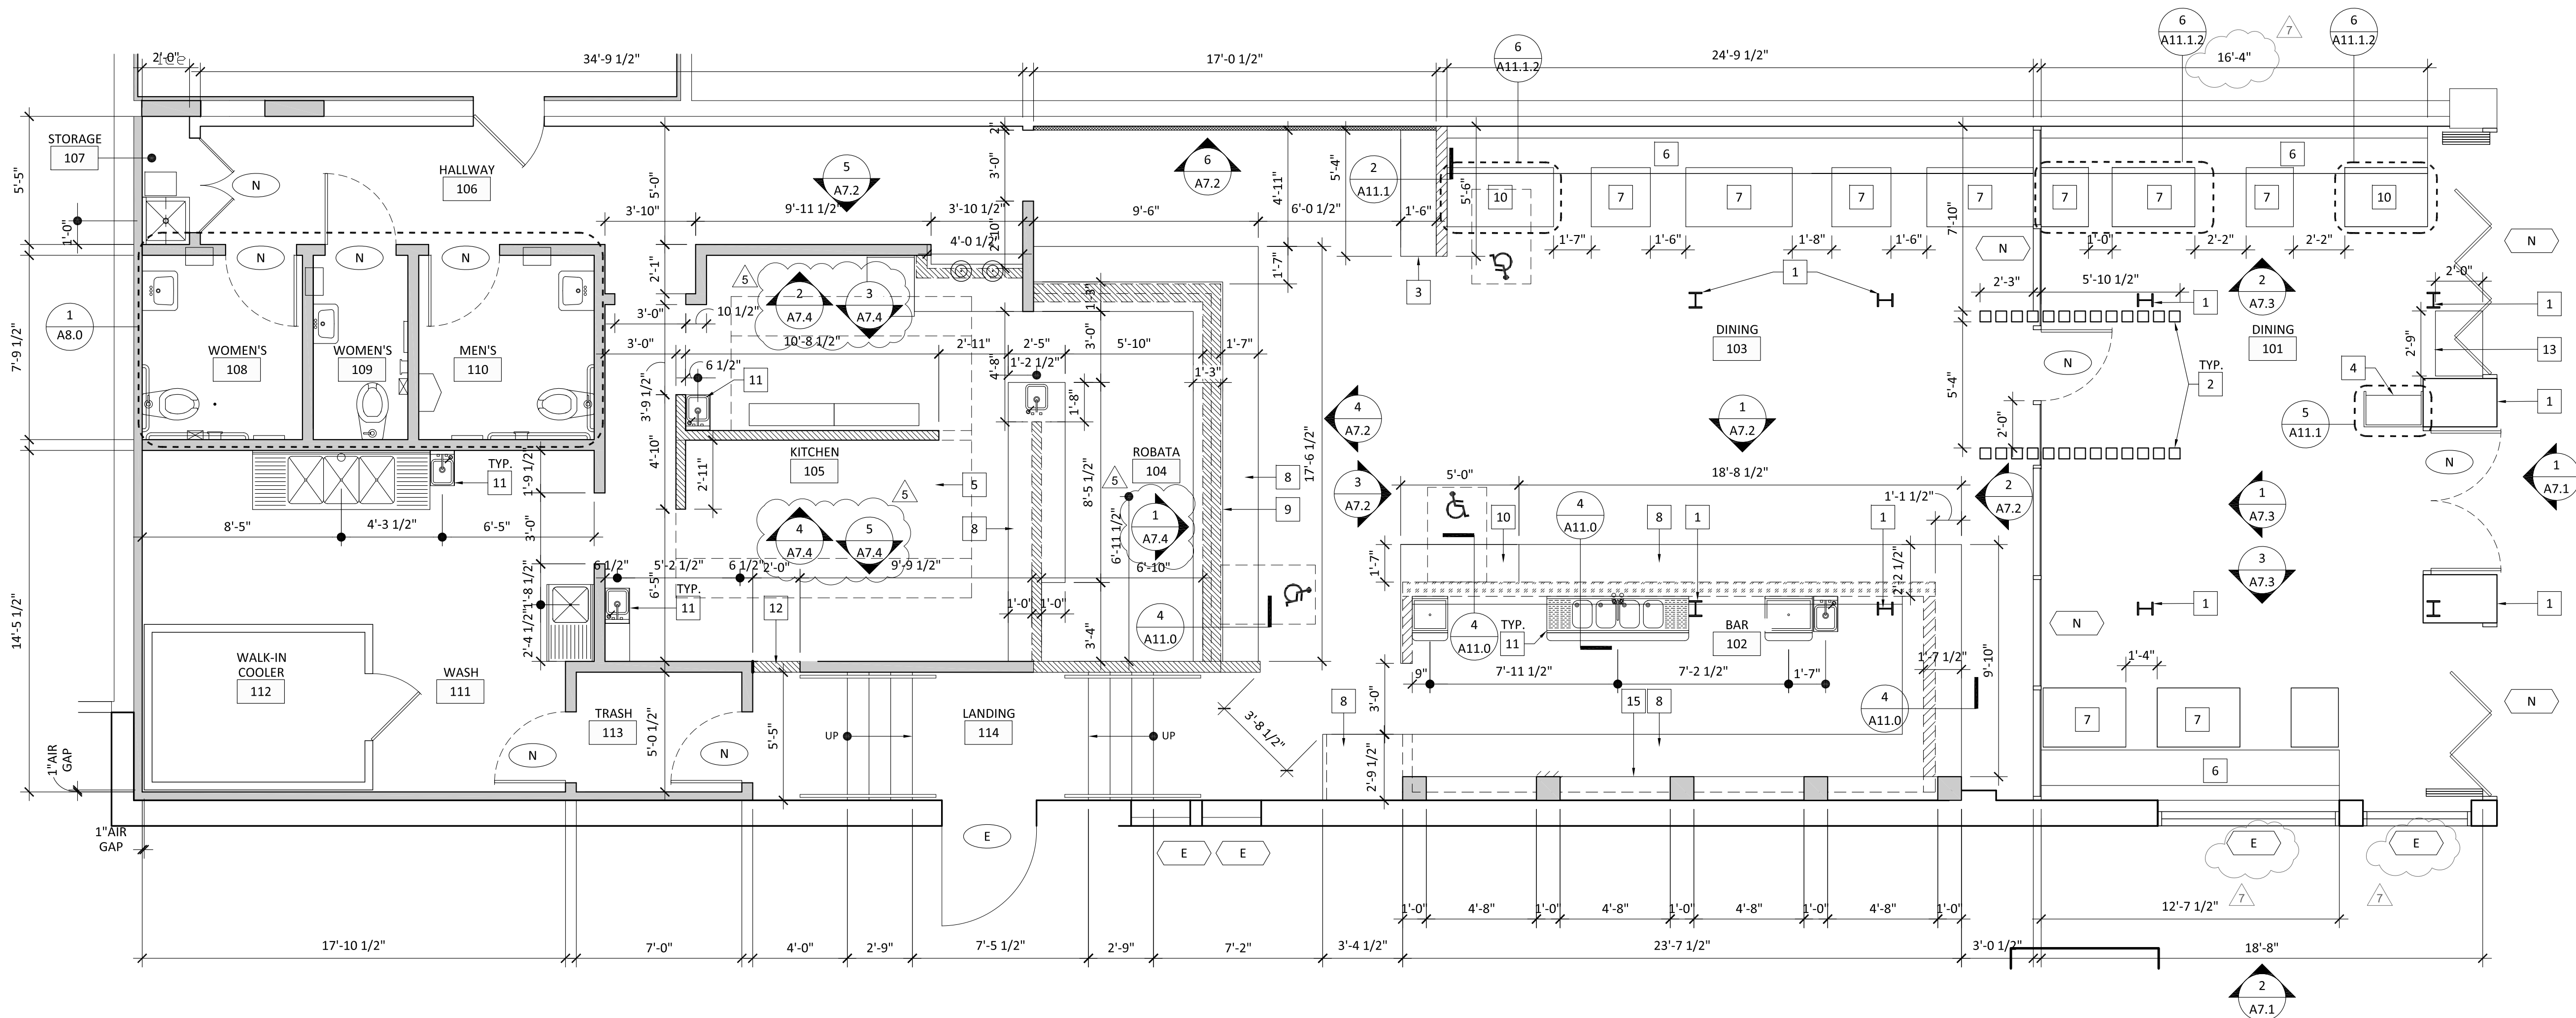

1 PARTITION PLAN

PARTITION KEYNOTES

- EXISTING COLUMN TO REMAIN AS IS.
- ENTRANCE WOOD SLATS PER DETAIL.
- CUSTOM BUILT-IN STORAGE CABINET PER DETAIL.
- MOVABLE CUSTOM HOSTESS STAND PER DETAIL.
- LINE OF HOOD ABOVE (ISLAND TYPE)
- CUSTOM BUILT-IN BOOTH PER CORRESPONDING DETAIL
- FIXED TABLE PER PLANS. BOLT TO THE FLOOR/ BASE TO BE PROVIDED BY G.C./ TOP TO BE PROVIDED BY SEPARATE VENDOR. SEE FURNITURE PLAN FOR DETAILS.
- COUNTER TOP PER PLANS.
- RAISED COUNTER TOP PER PLANS.
- ADA ACCESSIBLE COUNTER PER PLANS.
- EQUIPMENT PER PLAN AND SCHED.
- PASS-THRU WINDOW PER PLAN.
- MOVABLE SERVER STATION PER PLAN.
- NOT USED
- CUSTOM BACK BAR SHELVING PER PLAN.

LEGEND/ WALL TYPES

- EXISTING PARTITION TO REMAIN
- 3 5/8" METAL STUD METAL STUD WALL (FULL HEIGHT) WITH 5/8" GYP. BD. EACH SIDE
- 3 5/8" METAL STUD METAL STUD WALL (LOW WALL) WITH 5/8" GYP. BD. EACH SIDE
- 6" METAL STUD METAL STUD WALL (LOW WALL) WITH 5/8" GYP. BD. EACH SIDE
- EXISTING DOOR TO REMAIN
- NEW DOOR PER OTHER
- EXISTING STOREFRONT/ WINDOW TO REMAIN AS IS. ALL EXISTING WINDOWS ARE NON-OPERABLE AND TO REMAIN AS THEY ARE.
- NEW WINDOW PER OTHER.

PROJECT NOTES

- NOTIFY IKEDO DESIGN OF ANY DISCREPANCIES WITH PLANS. CALL TO OBTAIN CLARIFICATION PRIOR TO CONSTRUCTION/ INSTALLATION/ ORDERING.
 - CALL IKEDO DESIGN IF DESIGN INTENT IS NOT CLEAR. AT NO TIME IS THE CONTRACTOR TO ASSUME OR GUESS IKEDO DESIGN'S DESIGN INTENT.
 - GENERAL CONTRACTOR IS TO INFORM IKEDO DESIGN IMMEDIATELY IF THERE ARE ANY DIMENSIONAL DISCREPANCIES BETWEEN THE PLANS AND FIELD CONDITIONS.
 - ALL SIGNAGE SHOP DRAWINGS MUST BE SUBMITTED TO IKEDO DESIGN OR JINYA CORPORATE FOR REVIEW. APPROVAL.
 - PAINT ALL DIFFUSERS/ GRILL, SECURITY CAMERAS, SPEAKERS BLACK. OWNER SHALL CONTACT JINYA CORPORATE BEFORE INSTALLATION.
- NEW PATIO BENCH PER CORRESPONDING DETAIL.



990 Highland Drive
Suite 110A
Solana Beach, CA 92075
p: 858.436.7967

ROBATA JINYA
RESTAURANT
6529 W. HOLLYWOOD BLVD.
LOS ANGELES, CA 90028


REVISION: OWNER 8.13.21
REVISION:
REVISION: JINYA 11.08.21
REVISION: HEALTH 12.29.21
REVISION: OWNER 1.26.23
REVISION: OWNER 11.30.23
REVISION:
BID SET:
HEALTH SUBMITTAL:
CITY SUBMITTAL:
TENANT APPROVAL:
SCALE: 1/4" = 1'-0"
PROJECT NO: RJ0420
DRAWN: MK & SI
DATE: 01/14/22

PARTITION PLAN

THIS PERMIT APPLICATION SET OF DRAWINGS ARE INTENDED FOR BUILDING DEPARTMENT REVIEW ONLY. REVISIONS DUE TO PLAN CHECK AND IKEDO DESIGN REVIEW/COORDINATION MAY BE REQUIRED.

SHEET NO:

A3.0

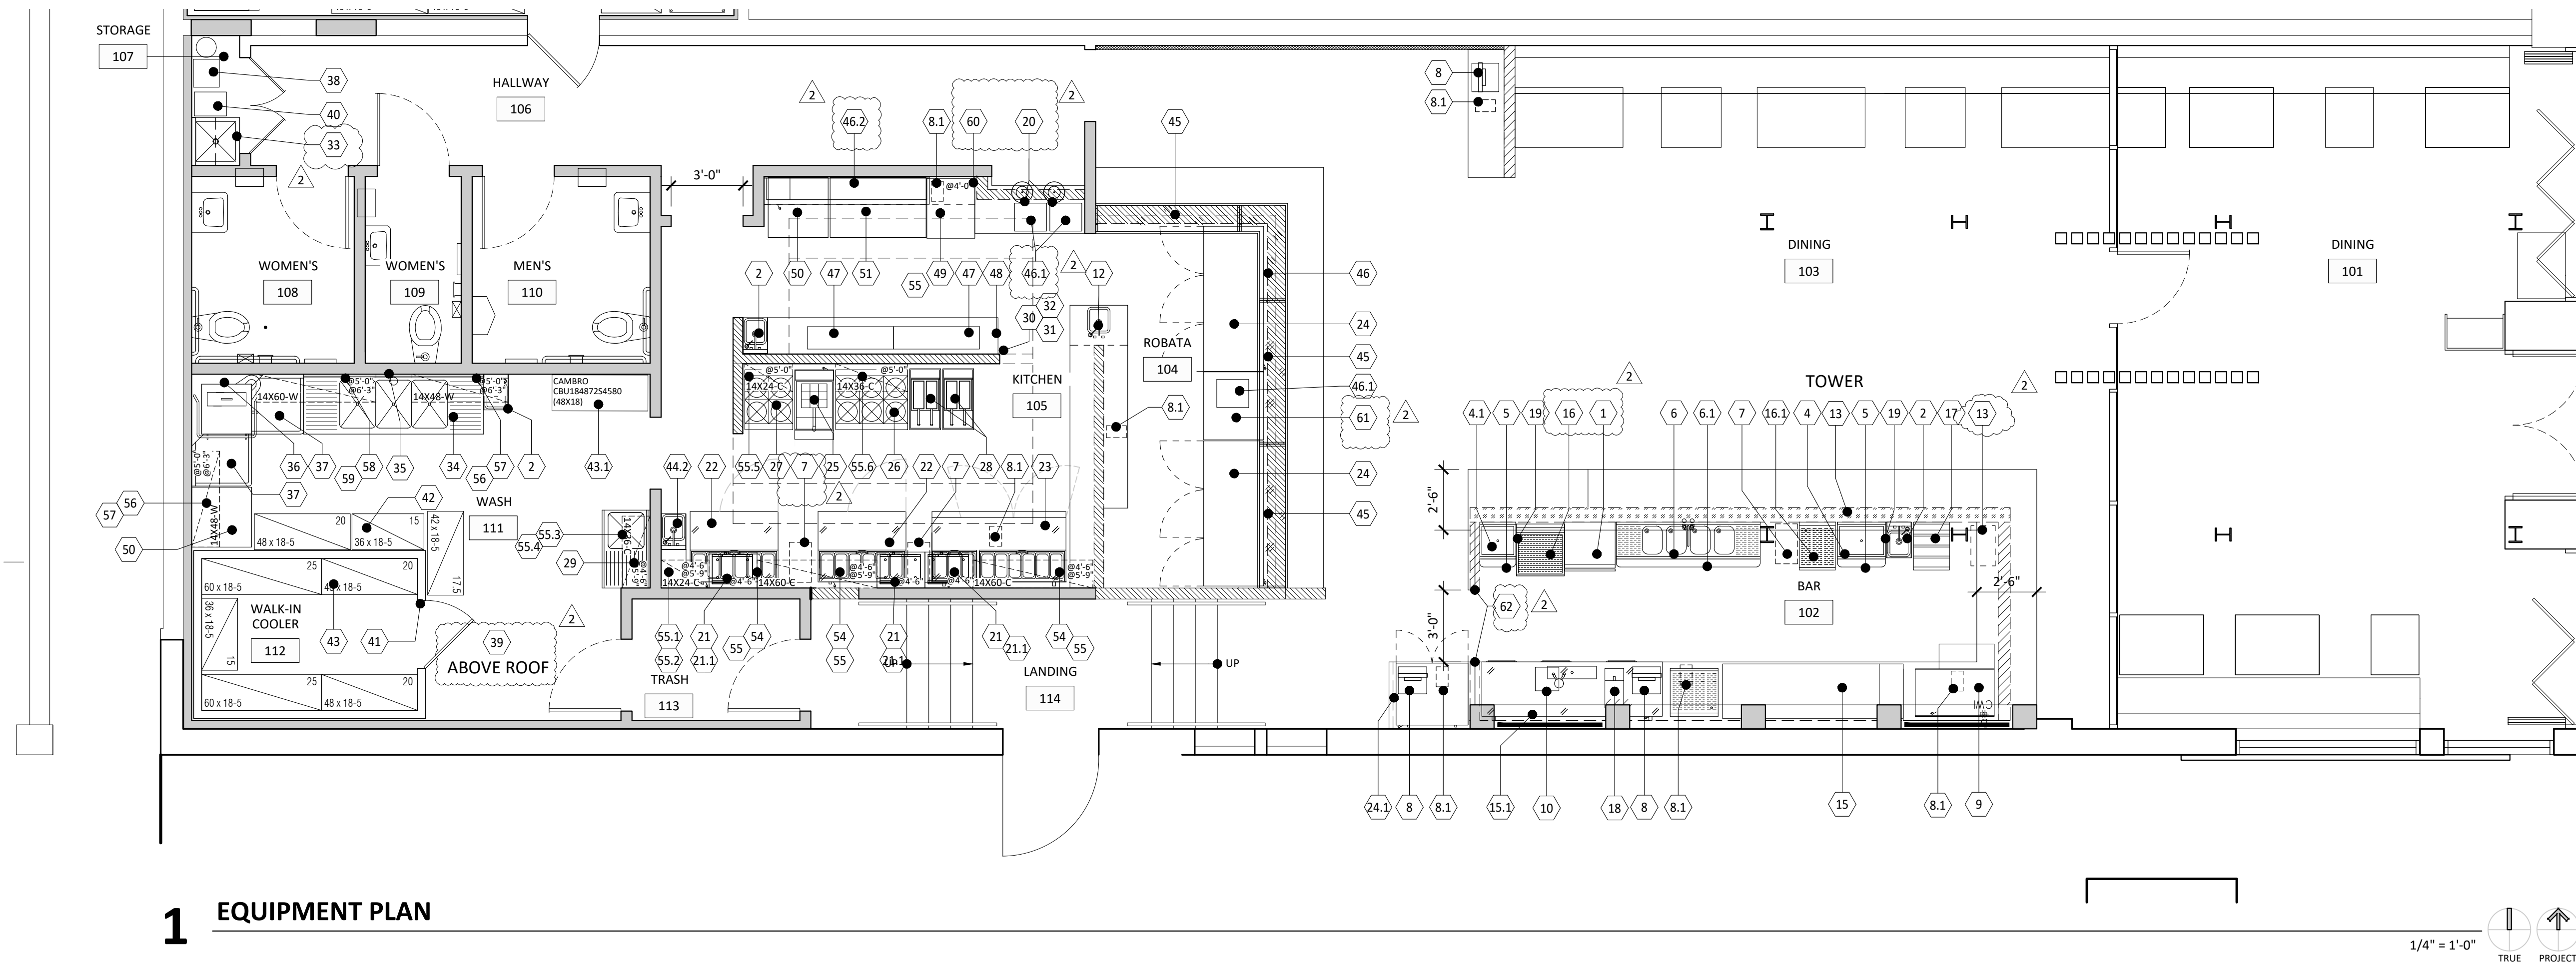

1 EQUIPMENT PLAN

FOOD EQUIPMENT SCHEDULE

ITEM NO.	QTY.	DESCRIPTION	MANUFACTURER	MODEL NO.
1	1	UNDERCOUNTER DISHWASHER LOW TEMP.	AMERICAN DISH SERVICE	ET-PD-H
2	3	SPACE SAVER HANDSINK + SOAP & TOWEL DISPENSER (W/ SPLASHGUARDS)	GSW	HS-1217SSG
3		NOT USED	-	-
4	1	ICE BIN W/ 18" X 24" X 12" BOWL	KROWNE METAL	18-24
4.1	1	ICE BIN W/ 18" X 18 1/2" X 12" BOWL	KROWNE METAL	18-18
5	1	24" S.S. SINGLE SPEEDRAIL	KROWNE METAL	S-24
5.1	1	18" S.S. SINGLE SPEEDRAIL	KROWNE METAL	S-18
6	1	4 COMP. SINK W/ DRAINBOARDS (BOWL SIZE: 10" X 14" X 10")	KROWNE METAL	KR18-64C
6.1	1	72" S.S. DOUBLE SPEEDRAIL	KROWNE METAL	RD-72
7	V.I.F.	TRASH BIN	PER OWNER	-
8	2	POS SYSTEM. COORDINATE FINAL LOCATIONS WITH JINYA CORP.	PROVIDED BY JINYA APPROVED VENDOR	
8.1	5	PRINTER (COORDINATE WITH POS SYSTEM PROVIDER)	PROVIDED BY JINYA APPROVED VENDOR	
9	1	ICE MACHINE	HOSHIZAKI	IM-200BAC
10	1	SAKE WARMER (9.8"W X 20.28"H X 14.76"D (32"H W/ SAKE CUBE))	JC-UNITEC	TSK-150CS
11		NOT USED	-	-
12	1	COUNTER MOUNTED HANDSINK + SOAP & TOWEL DISPENSER (W/ SPLASHGUARDS)	GSW	HS-1317IHG
13	1	HIGHBALL DISPENSER	HOSHIZAKI	DSU-25SLD-BNA
14		NOT USED	-	-
15	1	GLASS DOOR BACK BAR COOLER W/ 2" CASTERS (90-3/4" x 27-1/4" x 37-1/8")	TURBO AIR	TBB-45G-N
15.1	1	BEER DISPENSERS W/ 2" CASTERS (90-3/4" x 27-1/4" x 37-1/8") 2 TAPS	TURBO AIR	TBD-45BD-N
16	1	24" GLASS STORAGE CABINET W/ DRAINBOARD	KROWNE METAL	KR21-GS81
16.1	1	18" GLASS STORAGE W/ TOP	KROWNE METAL	KR-G18 AND BB-125
17	1	18" LIQUOR DISPLAY CABINET	KROWNE METAL	KR18-18RD
18	1	HOT WATER DISPENSER	CECILWARE	HWD2
19	1	SODA GUN. VERIFY SODA REQUIREMENTS W/ VENDOR	PROVIDED BY JINYA APPROVED VENDOR	
20	2	HEAT LAMP (CEILING MOUNTED, RETRACTABLE, GLOSSY GRAY)	HATCO	DL-775-RL
21	3	MICROWAVE (20-1/8" x 16-1/2" x 12")	PANASONIC	NE-1054-F
21.1	3	S.S. MICROWAVE WALL SHELF 24"W X 18"D @ 5'-0" A.F.F.	GSW	MS-2418
22	2	SANDWICH/ SALAD UNIT (44" X 31-1/4" X 36")	TURBO AIR	TPR-44SD-N
23	1	SANDWICH/ SALAD UNIT (67" X 32-1/4" X 36")	TURBO AIR	TPR-67SD-N
24	2	UNDERCOUNTER REF (72-5/8" X 30" X 30-5/8")	TURBO AIR	MUR-72-N
24.1	1	UNDERCOUNTER FREEZER	BEVERAGE AIR	UCF36AHC
25	1	GAS PASTA COOKER W/ BUILT-IN WATER FAUCET (PROVIDE FLOOR SINK)	ANETS	GPC-18
26	1	36" RESTAURANT RANGE	AMERICAN RANGE	AR-6
27	1	24" HEAVY DUTY HOT PLATE W/ STAND & CASTERS	AMERICAN RANGE	ARHP-24-4 & ESS-24
28	2	HEAVY DUTY FRYER	IMPERIAL	IFS-40
29	1	PREP SINK (18G 1-COMP S.S. 18"X18"X12") + S.S. SPLASHGUARDS (11-1/2" H/ SMOOTH, ROUND EDGE)	GSW OR EQUAL	SE1818R

30	1	ISLAND EXHAUST HOOD - TYPE I - 11'-7" X 6'-10" BY CAPTIVE AIRE	CONTACT: MIKE WASILUK, REGIONAL MANAGER AT CAPTIVE AIRE. C: 619.993.0799.
31	1	FIRE SUPPRESSION SYSTEM- WET CHEMICAL (PROVIDE ELECTRICAL & GAS SHUT-OFFS PER MANUFACTURE REQ.)	CONTACT: MIKE WASILUK, REGIONAL MANAGER AT CAPTIVE AIRE. C: 619.993.0799.
32	1	EXHAUST FAN & MAKEUP AIR SYSTEM W/ INTERLOCKING SYSTEM (PROVIDE FAN INFO FOR MECHANICAL DRAWINGS)	CONTACT: MIKE WASILUK, REGIONAL MANAGER AT CAPTIVE AIRE. C: 619.993.0799.
33	1	24" X 24" MOP SINK WITH MOP SINK FAUCET EQUIPPED WITH BACK FLOW DEVICE + CLEANING SUPPLY SHELVES/CABINETS/BROOM HANGER : (1) @ 5'-4" A.F.F. & (1) @ 6'-7" A.F.F.	-
34	1	3 COMPARTMENT SINK	GSW OR EQUAL SH24183D
35	1	PRE-RINSE SPRAYER W/ ADD-ON FAUCET - 14" SPOUT	FISHER 52922
36	1	LOW-TEMP SINGLE RACK DISHWASHER	AMERICAN DISH SERVICE AF/AF-C-ES
37	1 EA.	24" LONG S.S. DISH TABLES FOR #52	GSW DT24C-L & DT24C-R
38	1	WATER SOFTENER	FUJI WATER -
39	1	WATER HEATER	PER PLUMBING
40	1	EMPLOYEE LOCKERS	- -
41	1	WALK-IN REFRIGERATOR (6'-4" X 9'-0" INSIDE DIMS., LIGHT & COIL)	PER GENERAL CONTRACTOR
42	6	DRY STORAGE SHELVING - 5 TIERS	- -
43	-	COLD STORAGE SHELVING - 5 TIERS	WINCO VEX-86P
43.1	1	48" SOLID STATIONARY SHELF - 4 TIER SHELVING (48" X 18" X 72"H)	CAMBRO CBU18487254580
44	1	20" X 16" X 12" 16-GAUGE STAINLESS STEEL ONE COMPARTMENT DROP-IN SINK W/ 8" FAUCET	REGENCY 600D12012
44.1	1	17" X 15" X 12" 16-GAUGE STAINLESS STEEL ONE COMPARTMENT SINK W/ 8" FAUCET W/ COUNTER TOP	CUSTOM
44.2	1	14" X 12" X 6" 16-GAUGE STAINLESS STEEL HAND SINK DROP-IN SINK W/ FAUCET	CUSTOM
45	3	CUSTOM SUSHI CASE - 72" X 12" X 10" (W X D X H) REMOTE COMPRESSOR	YOSHIMASA GARASU - 6M
46	1	CUSTOM SUSHI CASE - 23" X 48" W X 12" D X 10" H (W X D X H) REMOTE COMPRESSOR	YOSHIMASA GARASU - C X CM
46.1	3	REMOTE COMPRESSOR FOR #45 AND #46	PER MANUFACTURE PER MANUFACTURE
46.2	1	SUSHI CASE - 82.7"W X 13.6"D X 11"H (W X D X H) SELF CONTAINED	HOSHIZAKI HNC-2108A-L-SLH
47	2	YAKITORI GRILL (WATER AND DRAIN REQUIRED)	- -
48	1	S.S. WORK TABLE W/ TWO UNDERSHELVES (18" X 115")	- -
49	1	S.S. EQUIPMENT STAND (24" X 30")	- -
50	2	S.S. WORK TABLE W/ TWO UNDERSHELVES (30" X 30")	- -
51	1	S.S. WORK TABLE W/ TWO UNDERSHELVES (48" X 30")	- -
52	1	S.S. CONTINUOUS WALL SHELVING 48"W X 14"D @ 4'-9" A.F.F.	GSW WS-W1448
53	1	S.S. CONTINUOUS WALL SHELVING 48"W X 14"D @ 5'-9" A.F.F.	GSW WS-W1448
54	2	S.S. CONTINUOUS WALL SHELVING 60"W X 14"D @ 4'-9" A.F.F.	GSW WS-W1460
55	3	S.S. CONTINUOUS WALL SHELVING 60"W X 14"D @ 5'-9" A.F.F.	GSW WS-W1460
55.1	1	S.S. CONTINUOUS WALL SHELVING 24"W X 14"D @ 4'-9" A.F.F.	GSW WS-W1424
55.2	1	S.S. CONTINUOUS WALL SHELVING 24"W X 14"D @ 5'-9" A.F.F.	GSW WS-W1424
55.3	1	S.S. CONTINUOUS WALL SHELVING 36"W X 14"D @ 4'-9" A.F.F.	GSW WS-W1436
55.4	1	S.S. CONTINUOUS WALL SHELVING 36"W X 14"D @ 5'-9" A.F.F.	GSW WS-W1436
55.5	1	S.S. CONTINUOUS WALL SHELVING 24"W X 14"D @ 5'-0" A.F.F.	GSW WS-W1424
55.6	1	S.S. CONTINUOUS WALL SHELVING 36"W X 14"D @ 5'-0" A.F.F.	GSW WS-W1436
56	2	S.S. WIRED WALL SHELVING 48"W X 14"D @ 5'-0" A.F.F.	THUNDER CMSV1448
57	2	S.S. WIRED WALL SHELVING 48"W X 14"D @ 6'-3" A.F.F.	THUNDER CMSV1448

58	1	S.S. WIRED WALL SHELVING 60"W X 14"D @ 5'-0" A.F.F.	THUNDER	CMSV1460
59	1	S.S. WIRED WALL SHELVING 60"W X 14"D @ 6'-3" A.F.F.	THUNDER	CMSV1460
60	1	S.S. CONTINUOUS WALL SHELVING 105"W X 16"D @ 4'-0" A.F.F.		
61	1	S.S. WORK TABLE (28" X 30")		
62	2	SNEEZE GUARD		

PROJECT NOTES

- NOTIFY IKEDO DESIGN OF ANY DISCREPANCIES WITH PLANS. CALL TO OBTAIN CLARIFICATION PRIOR TO CONSTRUCTION/ INSTALLATION/ ORDERING.
- CALL IKEDO DESIGN IF DESIGN INTENT IS NOT CLEAR. AT NO TIME IS THE CONTRACTOR TO ASSUME OR GUESS IKEDO DESIGN'S DESIGN INTENT.
- GENERAL CONTRACTOR IS TO INFORM IKEDO DESIGN IMMEDIATELY IF THERE ARE ANY DIMENSIONAL DISCREPANCIES BETWEEN THE PLANS AND FIELD CONDITIONS.
- ALL SIGNAGE SHOP DRAWINGS MUST BE SUBMITTED TO IKEDO DESIGN OR JINYA CORPORATE FOR REVIEW. APPROVAL.
- PAINT ALL DIFFUSERS/ GRILL, SECURITY CAMERAS, SPEAKERS BLACK. OWNER SHALL CONTACT JINYA CORPORATE BEFORE INSTALLATION.


REVISION:	OWNER	8.13.21
REVISION:		
REVISION:	JINYA	11.08.21
REVISION:	HEALTH	12.29.21
REVISION:	OWNER	1.26.23
REVISION:	OWNER	11.30.23
BID SET:		
HEALTH SUBMITTAL:		
CITY SUBMITTAL:		
TENANT APPROVAL:		
SCALE:	1/4" = 1'-0"	
PROJECT NO:	RJ0420	
DRAWN:	MK & SI	
DATE:	01/14/22	

EQUIPMENT PLAN & SCHEDULE

THIS PERMIT APPLICATION SET OF DRAWINGS ARE INTENDED FOR BUILDING DEPARTMENT REVIEW ONLY. REVISIONS DUE TO PLAN CHECK AND IKEDO DESIGN REVIEW/COORDINATION MAY BE REQUIRED.

SHEET NO:

A3.1

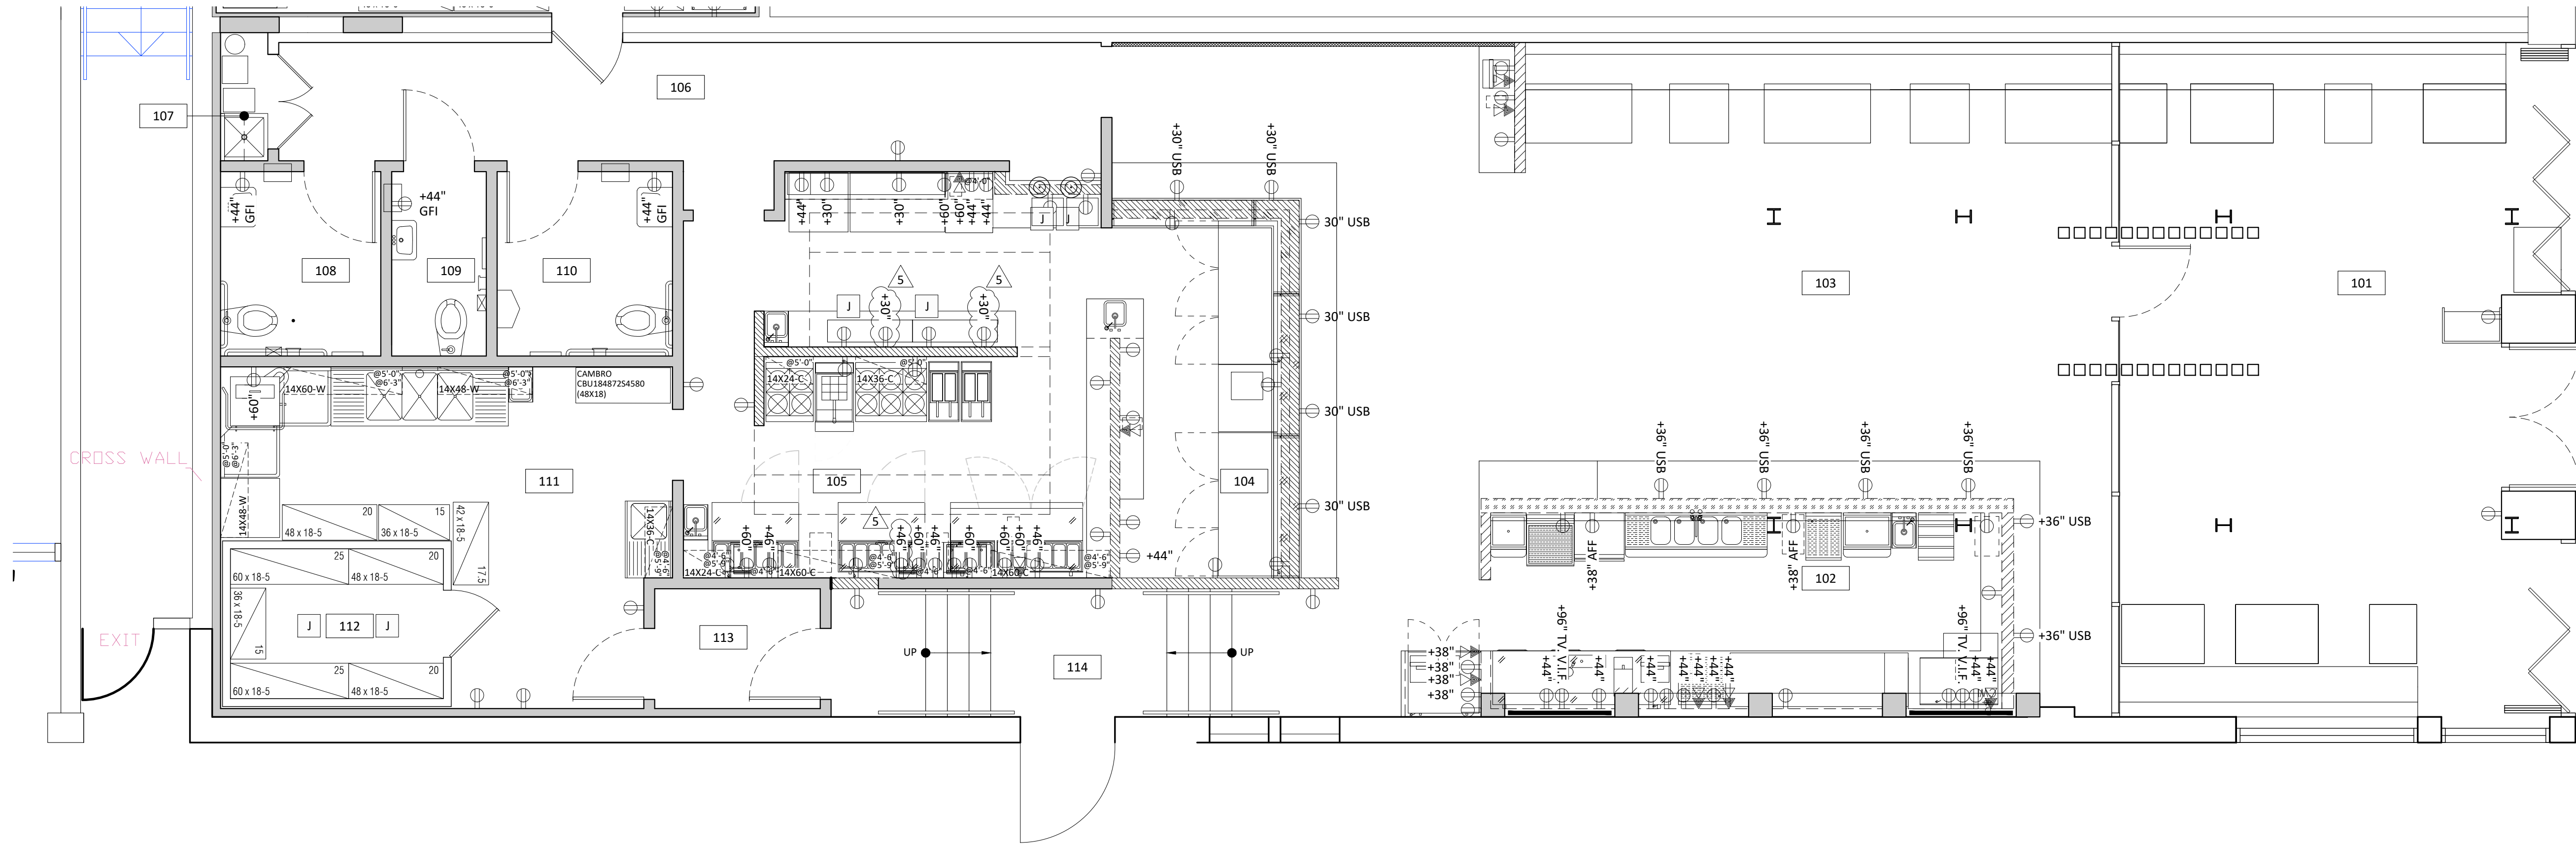

1 POWER, DATA & TELEPHONE PLAN

1/4" = 1'-0"
TRUE PROJECT

ELECTRICAL LEGEND

- BUILDING STANDARD DUPLEX OUTLET MOUNTED @ +15" ON CENTER A.F.F. U.O.N.
- NUMBER INDICATES MOUNTING HEIGHT
- BUILDING STANDARD DUPLEX OUTLET WITH USB MOUNTED @ +15" ON CENTER A.F.F. U.O.N.
- BUILDING STANDARD TELEPHONE OUTLET MOUNTED @ +15" ON CENTER A.F.F. U.O.N.
- BUILDING STANDARD DATA OUTLET MOUNTED @ +15" ON CENTER A.F.F. U.O.N.

PROJECT NOTES

- NOTIFY IKEDO DESIGN OF ANY DISCREPANCIES WITH PLANS. CALL TO OBTAIN CLARIFICATION PRIOR TO CONSTRUCTION/ INSTALLATION/ ORDERING.
- CALL IKEDO DESIGN IF DESIGN INTENT IS NOT CLEAR. AT NO TIME IS THE CONTRACTOR TO ASSUME OR GUESS IKEDO DESIGN'S DESIGN INTENT.
- GENERAL CONTRACTOR IS TO INFORM IKEDO DESIGN IMMEDIATELY IF THERE ARE ANY DIMENSIONAL DISCREPANCIES BETWEEN THE PLANS AND FIELD CONDITIONS.
- ALL SIGNAGE SHOP DRAWINGS MUST BE SUBMITTED TO IKEDO DESIGN OR JINYA CORPORATE FOR REVIEW APPROVAL.
- PAIN ALL DIFFUSERS/ GRILL, SECURITY CAMERAS, SPEAKERS BLACK. OWNER SHALL CONTACT JINYA CORPORATE BEFORE INSTALLATION.

REVISION:	OWNER	8.13.21	1
REVISION:	JINYA	11.08.21	4
REVISION:	HEALTH	12.23.21	5
REVISION:	OWNER	1.26.23	6
REVISION:	OWNER	11.30.23	7
REVISION:			
BID SET:			
HEALTH SUBMITTAL:			
CITY SUBMITTAL:			
TENANT APPROVAL:			
SCALE:	1/4" = 1'-0"		
PROJECT NO:	RJ0420		
DRAWN:	MK & SI		
DATE:	01/14/22		

 
POWER, DATA & TELEPHONE PLAN

THIS PERMIT APPLICATION SET OF DRAWINGS ARE INTENDED FOR BUILDING DEPARTMENT REVIEW ONLY. REVISIONS DUE TO PLAN CHECK AND IKEDO DESIGN REVIEW/COORDINATION MAY BE REQUIRED.

SHEET NO:

A4.0

NOT FOR CONSTRUCTION UNTIL PERMITTED



DRY WALL CEILING

KEYNOTES

- ## PROJECT NOTES

- KEDO**
DESIGN
Space Planning & Interior Design

990 Highland Drive
Suite 110A
Solana Beach, CA 92075
p: 858.436.7967

ROBATA JINYA
RESTAURANT
6529 W. HOLLYWOOD BLVD.
LOS ANGELES, CA 90028

REVISION: OWNER 8.13.21 

REVISION:

REVISION: JINYA 11.08.21 

REVISION: HEALTH 12.29.21 

REVISION: OWNER 1.26.23 

REVISION: OWNER 11.30.23 

REVISION:

BID SET:

HEALTH SUBMITTAL:

CITY SUBMITTAL:

TENANT APPROVAL:

SCALE: 1/4" = 1'-0"

PROJECT NO: RI0420

DRAWN: MK & S

DATE: 01/14/22

REFLECTED
CEILING PLAN


THIS PERMIT APPLICATION SET OF DRAWINGS ARE
INTENDED FOR BUILDING DEPARTMENT REVIEW ONLY.
REVISIONS DUE TO PLAN CHECK AND IKEDO DESIGN
REVIEW/COORDINATION MAY BE REQUIRED.

SHEET NO:

A5.0

NOT FOR CONSTRUCTION UNTIL PERMITTED

All ideas, design arrangements, and plans indicated or represented by this drawing are owned by, and the property of Ikedo Design. and were created, evolved, and developed for use on and in connection with this project. None of such ideas, arrangements, or plans shall be used by or disclosed to any person, firm, or corporation for any purpose whatsoever without the written permission of Ikedo Design. Filing of these drawings or specifications with any public agency is not a publication of same. No reproduction is therefore permissible without the written consent of Ikedo Design.

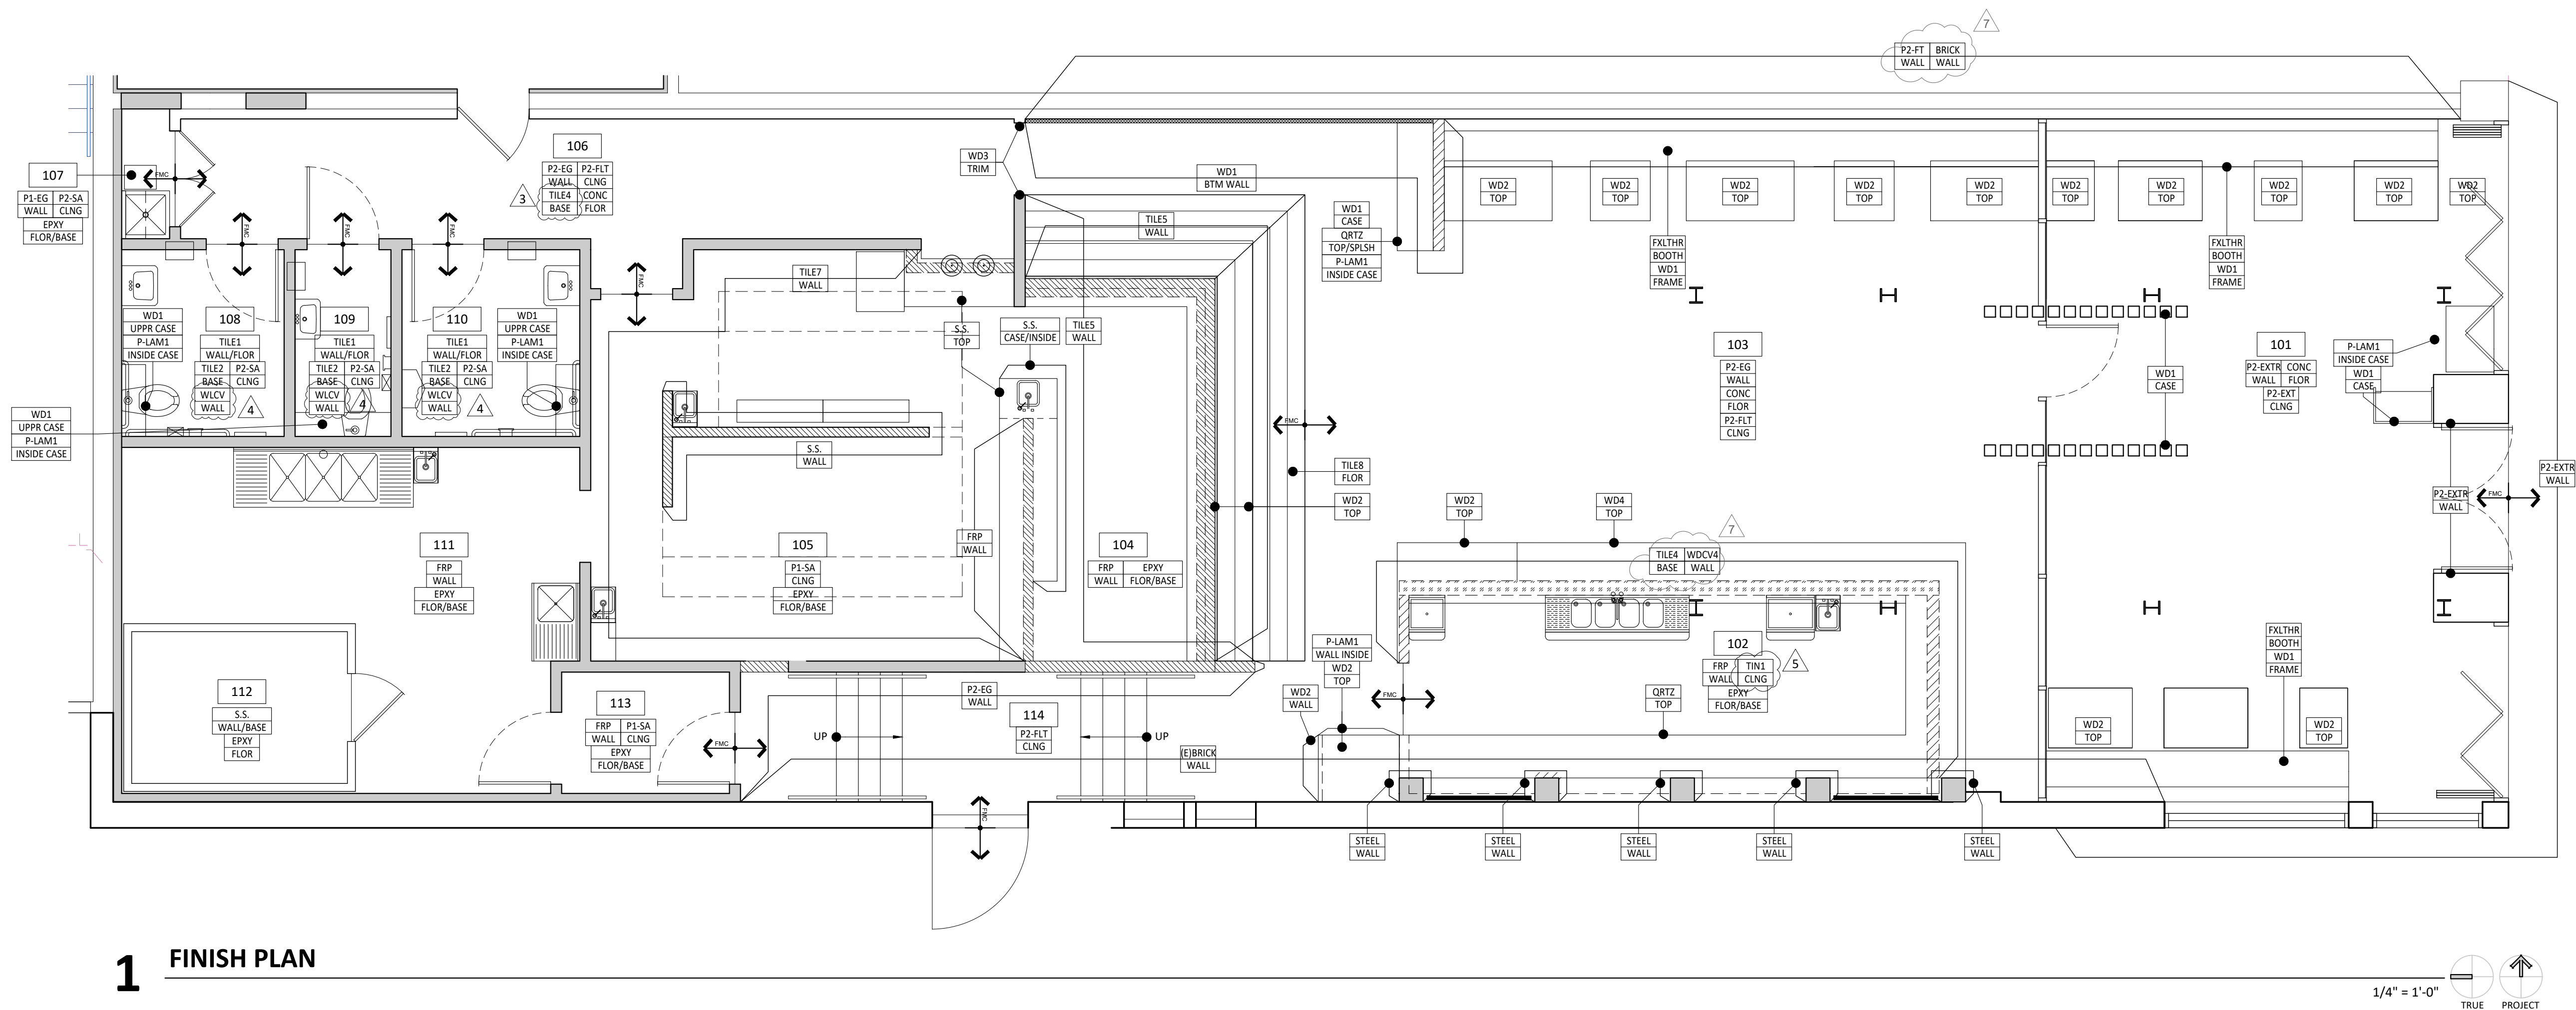

1 FINISH PLAN

FINISH LEGEND

FINISHES ARE ONLY FOR PRICING. DO NOT ORDER UNTIL FINAL APPROVAL FROM TENANT. SEE ELEVATION SHEET(S) AND DETAIL SHEET(S) FOR FINISH APPLICATION / LAYOUT.

S.T.F.	SPEC TO FOLLOW
	FINISH MATERIAL CHANGE
	MATERIAL LOCATION
	BRICK VENEER: (PAINTABLE BRICK VENEER) MANUFACTURER: OLD MILL THIN BRICK SYSTEMS STYLE: CASTLE GATE, COLONIAL COLLECTION SIZE: 2 1/4" X 7 5/8" X 9/16", CASES OF 50 (7.3 S.F.) GROUT: 3/8", CUSTOM BUILDING PRODUCTS #19 PEWTER INSTALL: PER CONTRACTOR
	CONCRETE: MANUFACTURER: WEST COAT STYLE: GRIND, STAIN SEAL (SC-36 AND EC-11) COLOR: BLACK INSTALL: PER CONTRACTOR CONTACT: MARC DIZINNO Marc.Dizinn@westcoat.com 760.802.6374
	EPOXY FLOOR: MANUFACTURER: WEST COAT STYLE: DUBRO SYSTEM - 3/8" R, 6" HIGH, SELF COVE COLOR: PEWTER GRAY 12 PER CONTRACTOR CONTACT: MARC DIZINNO Marc.Dizinn@westcoat.com 760.802.6374
	CERAMIC TILE (RESTROOM): MANUFACTURER: BEDROSANS PRODUCT NO.: STPSIMBL1224 SIZE: 12" X 24" COLOR: BLACK GROUT: 1/16", CUSTOM BUILDING PRODUCTS #60 CHARCOAL INSTALL: PER CONTRACTOR LAYOUT: VERTICAL RUNNING BOND/ STAGGERED; SEE ELEVATIONS CONTACT: IKEDO DESIGN
	BASE TILE (RESTROOM): MANUFACTURER: BEDROSANS PRODUCT NO.: STPSIMBL612COVE SIZE: 6" X 12" X 3/8" COLOR: BLACK RADIUS: 3/8" RADIUS GROUT: 1/16", CUSTOM BUILDING PRODUCTS #60 CHARCOAL INSTALL: PER CONTRACTOR LAYOUT: ALIGN VERTICAL GROUT LINES W/ TILE1 ON WALLS; SEE ELEVATIONS AS.1 CONTACT: IKEDO DESIGN
	TILE (ACCENT TILE): PORCELAIN FIELD TILE MANUFACTURER: BEDROSANS PRODUCT NO.: STPSIMBL1224 SIZE: 12" X 24" COLOR: BLACK GROUT: 1/16", CUSTOM BUILDING PRODUCTS #60 CHARCOAL INSTALL: PER CONTRACTOR LAYOUT: VERTICAL RUNNING BOND/ STAGGERED; SEE ELEVATIONS AS.1 CONTACT: IKEDO DESIGN

	TILE (BASE TILE): PORCELAIN FIELD TILE MANUFACTURER: BEDROSANS PRODUCT NO.: GRNABSBLK012H SERIES NAME: ABSOLUTE BLACK COLOR: ABSOLUTE BLACK SIZE: 3" X 12" GROUT: 3/16", CUSTOM BUILDING PRODUCTS #60 CHARCOAL INSTALL: PER CONTRACTOR; SEE ELEVATIONS LAYOUT: LINEAR CONTACT: IKEDO DESIGN
	SLAB (ROBATA WALL): MANUFACTURER: BEDROSANS PRODUCT NO.: 100000475 SERIES NAME: MAGNIFICA ENCORE CEMENT- HONED COLOR: 60" X 127" (12MM THICKNESS) GROUT: 1/16", CUSTOM BUILDING PRODUCTS -S.T.F. INSTALL: PER CONTRACTOR; SEE ELEVATIONS CONTACT: IKEDO DESIGN

	TILE (RESTROOM ACCENT TILE): MANUFACTURER: BEDROSANS PRODUCT NO.: CRDANTWALS48-N SERIES NAME: ANTIQUE COLOR: ANTIQUE SIZE: 12" X 24" GROUT: 1/16", CUSTOM BUILDING PRODUCTS #541 WALNUT INSTALL: PER CONTRACTOR; SEE ELEVATIONS AS.1 LAYOUT: RANDOM STAGGERED END JOINTS CONTACT: IKEDO DESIGN
--	---

	CERAMIC TILE (KITCHEN WALL): MANUFACTURER: BEDROSANS PRODUCT NO.: CERWINBL824 SERIES NAME: WINTER COLOR: BLANCO SIZE: 8" X 24" GROUT: 1/16", CUSTOM BUILDING PRODUCTS INSTALL: PER CONTRACTOR; SEE ELEVATIONS LAYOUT: RANDOM STAGGERED END JOINTS CONTACT: IKEDO DESIGN
--	--

	PORCELAIN TILE (ROBATA FLOOR): MANUFACTURER: PORCELANOSA PRODUCT NO.: 100214599 SERIES NAME: DELAWARE COLOR: NOGAL SIZE: 8" X 72" GROUT: 1/16", CUSTOM BUILDING PRODUCTS - S.T.F. INSTALL: PER CONTRACTOR; SEE PLANS AND ELEVATIONS LAYOUT: RANDOM STAGGERED END JOINTS CONTACT: IKEDO DESIGN
--	--

	PORCELAIN TILE (ROBATA SOFFIT FACE): MANUFACTURER: PORCELANOSA PRODUCT NO.: 100214616 SERIES NAME: DELAWARE COLOR: NOGAL SIZE: 12" X 72" GROUT: 1/16", CUSTOM BUILDING PRODUCTS - S.T.F. INSTALL: PER CONTRACTOR; SEE PLANS AND ELEVATIONS LAYOUT: LINEAR CONTACT: IKEDO DESIGN
--	--

	PLASTIC LAMINATE (CABINET INSIDE): MANUFACTURER: FORMICA COLOR & FINISH: BLACK - MATTE PRODUCT #: 909-58 INSTALL: PER CONTRACTOR, SEE FINISH PLAN
	QUARTZ STONE SLAB: MANUFACTURER: CAESARSTONE COLOR: 5100 VANILLA NOIR - 2CM (THICKNESS) FINISH/EDGE: POLISHED - MITERED EDGE GROUT: BLACK INSTALL: PER CONTRACTOR, SEE FINISH PLAN CONTACT: MARIA MORRISON C. (949) 324-3896 maria.morrison@caesarstone.com

	WOOD STAIN: MANUFACTURER: OLD MASTERS PRODUCTS WOOD SPECIES: VERTICAL GRAIN DOUGLAS FIR COLOR: DARK WALNUT 12001 TYPE: WIPING STAIN FINISH: MASTER'S ARMOR - FLAT/ WATER-BASED TOP COAT - 72001 SIZE: 1X6, UNLESS DETAILS SAY OTHERWISE PER CONTRACTOR, SEE FINISH PLAN & ELEVATIONS
	WOOD STAIN GLUAM (COUNTER TOPS, TABLE TOPS, STOOL SEATS): MANUFACTURER: TIMEWORN WOOD, LLC COLOR: WALNUT TYPE: ORIGINAL TEXTURE: SMOOTH FINISH: 2K ACRYLIC POLYURETHANE SEALER & TOP COATS W/ WOOD PUTTY. EASED CORNERS & EDGES. PER CONTRACTOR, SEE FINISH PLANS & ELEVATIONS

	WOOD STAIN (BEAM): MANUFACTURER: PER CONTRACTOR TYPE: WIPING STAIN MATCH TO 'TILE 8' FINISH: MASTER'S ARMOR - FLAT/ WATER-BASED TOP COAT - 72001 INSTALL: PER CONTRACTOR, SEE FINISH PLANS & ELEVATIONS
--	--

	LIVE WOOD SLAB (BAR COUNTERTOP): MANUFACTURER: WOODSLABS.COM (https://www.woodslabs.com) SPECIES: WALNUT WOOD LIVE WOOD SLAB FINISH: CLEAR COAT TYPE: PER CONTRACTOR, SEE FINISH PLANS & ELEVATIONS CONTACT: CONTACT TO THE OWNER FOR COORDINATION BEFORE PURCHASING
--	---

	ENGINEERED WOOD (ROBATA FLOOR): MANUFACTURER: WOODSLABS.COM (https://www.woodslabs.com) SPECIES: WALNUT WOOD LIVE WOOD SLAB FINISH: CLEAR COAT TYPE: PER CONTRACTOR, SEE FINISH PLANS & ELEVATIONS CONTACT: CONTACT TO THE OWNER FOR COORDINATION BEFORE PURCHASING
--	--

	TILE (ACCENT TILE): PORCELAIN FIELD TILE MANUFACTURER: BEDROSANS PRODUCT NO.: STPSIMBL1224 SIZE: 12" X 24" COLOR: BLACK GROUT: 1/16", CUSTOM BUILDING PRODUCTS #60 CHARCOAL INSTALL: PER CONTRACTOR LAYOUT: VERTICAL RUNNING BOND/ STAGGERED; SEE ELEVATIONS AS.1 CONTACT: IKEDO DESIGN
--	---

	ALUMINUM WALL TRANSITION (BAR): MANUFACTURER: SCHULTER SYSTEMS STYLE: QUADCEC SIZE: SUITABLE PER CORRESPONDING TILE THICKNESS COLOR: TSDA (DARK ANTHRACITE) APPLY: PER CONTRACTOR, SEE FINISH PLAN & ELEVATIONS
--	--

	BOXWOOD MAT (PATIO): MANUFACTURER: COMMERCIAL SILK STYLE: SPEC TO FOLLOW; BOXWOOD MAT; EXTERIOR SIZE: PER CONTRACTOR, SEE FINISH PLAN & ELEVATIONS INSTALL: PER CONTRACTOR, SEE FINISH PLAN & ELEVATIONS CONTACT: CASEY EMANS, CASEY@PLANSCAPEINC.COM, CELL: 952.200.7007
--	--

	MIRROR (RESTROOM): MANUFACTURER: CONTRACTOR'S WARDROBE COLOR: CLEAR INSTALL: PER CONTRACTOR; SEE ELEVATIONS AND DETAILS
--	--

	FIBERGLASS REINFORCED PLASTIC (WALL): MANUFACTURER: MARLITE OR SIM. STYLE: SPEC TO FOLLOW COLOR: WHITE INSTALL: PER CONTRACTOR; WET AREA: 8'-0" A.F.F.
--	--

	PLASTER PAINT (BAR COUNTER LOW WALL): MANUFACTURER: PORTOLA COLOR: ROMAN CLAY - SASHA TYPE: SPEC TO FOLLOW APPLY: BY CONTRACTOR, SEE FINISH PLAN & ELEVATIONS
--	---

	PAINT (KITCHEN AREAS): MANUFACTURER: BENJAMIN MOORE COLOR: WHITE ICE OC-58 TYPE: SEE PLAN APPLY: * SG (SEMIGLOSS); SA (SATIN); EG (EGGSHELL); FLT (FLAT) BY CONTRACTOR, SEE FINISH PLAN & ELEVATIONS
--	---

	PAINT (CEILING & OTHER): MANUFACTURER: BENJAMIN MOORE COLOR: BLACK 2132-10 TYPE: SEE PLAN APPLY: * SG (SEMIGLOSS); SA (SATIN); EG (EGGSHELL); FLT (FLAT) BY CONTRACTOR, SEE FINISH PLAN & ELEVATIONS
--	---

	PAINT (EXTERIOR): MANUFACTURER: BENJAMIN MOORE COLOR: WHITE ICE OC-58 TYPE: SEE PLAN APPLY: * SG (SEMIGLOSS); SA (SATIN); EG (EGGSHELL); FLT (FLAT) BY CONTRACTOR, SEE FINISH PLAN & ELEVATIONS
--	--

	TIN PANELS (BAR CEILING): MANUFACTURER: AMERICAN TIN CEILINGS COLOR: ARTISAN SILVER W/ BRUSHED BRONZE SIZE: 24" X 24" TYPE: WALLUP PATTERN #2 INSTALL: PER CONTRACTOR; SEE ELEVATIONS AND DETAILS
--	--

	FAUX LEATHER (POLYURETHANE): MANUFACTURER: KSPEC TO FOLLOW STYLE: SPEC TO FOLLOW COLOR: SPEC TO FOLLOW APPLY: PER CONTRACTOR, SEE DETAIL CONTACT: CHERYL ANNOTTI P: (805) 207-6613 cheryl.annotti@kravet.com
--	---

	METAL PLATE: MANUFACTURER: PER CONTRACTOR STYLE: 18 GA. (APPROX. 1/20") HOT ROLLED STEEL BLACKENED PATINA (SLATE BLACK PATINA BY SCULPT NOUVEAU OR SIM.) FINISH: BLACKENED, EASE ALL EXPOSED EDGES INSTALL: PER CONTRACTOR, SEE FINISH PLAN
--	--


	STAINLESS STEEL: MANUFACTURER: PER CONTRACTOR FINISH: BRUSHED TYPE: COMMERCIAL GRADE, SUBMIT RECOMMENDATION FOR APPROVAL INSTALL: PER CONTRACTOR, HEIGHT PER ELEVATIONS
--	---

	WALL PAPER (RESTROOM WALL): MANUFACTURER: WILLIAM E (G.C.) PRODUCT NO.: SERIES NAME: COLOR: SIZE: GROUT: INSTALL: CONTACT: PER CONTRACTOR; SEE ELEVATIONS
--	---

	WOOD COVERING: MANUFACTURER: LANCKO (SUPPLIED BY DUCHATEAU) COLLECTION: KRESCENT WOOD SPECIES: AMERICAN WALNUT: 'WALNUT' STAIN/ COVER/BOX: 20.64 S.F./BOX (16 TILES PER BOX) INSTALL: PER CONTRACTOR, SEE ELEVATIONS FOR CHANGING DIRECTIONS. CONSTRUCTION GLUE & FINE NEEDLE NAILS CONTACT: IKEDO DESIGN
--	---

PROJECT NOTES

- NOTIFY IKEDO DESIGN OF ANY DISCREPANCIES WITH PLANS. CALL TO OBTAIN CLARIFICATION PRIOR TO CONSTRUCTION/ INSTALLATION/ ORDERING.
- CALL IKEDO DESIGN IF DESIGN INTENT IS NOT CLEAR. AT NO TIME IS THE CONTRACTOR TO ASSUME OR GUESS IKEDO DESIGN'S DESIGN INTENT.
- GENERAL CONTRACTOR IS TO INFORM IKEDO DESIGN IMMEDIATELY IF THERE ARE ANY DIMENSIONAL DISCREPANCIES BETWEEN THE PLANS AND FIELD CONDITIONS.
- ALL SIGNAGE SHOP DRAWINGS MUST BE SUBMITTED TO IKEDO DESIGN OR JINYA CORPORATE FOR REVIEW. APPROVAL.
- PAINT ALL DIFFUSERS/ GRILL, SECURITY CAMERAS, SPEAKERS BLACK. OWNER SHALL CONTACT JINYA CORPORATE BEFORE INSTALLATION.

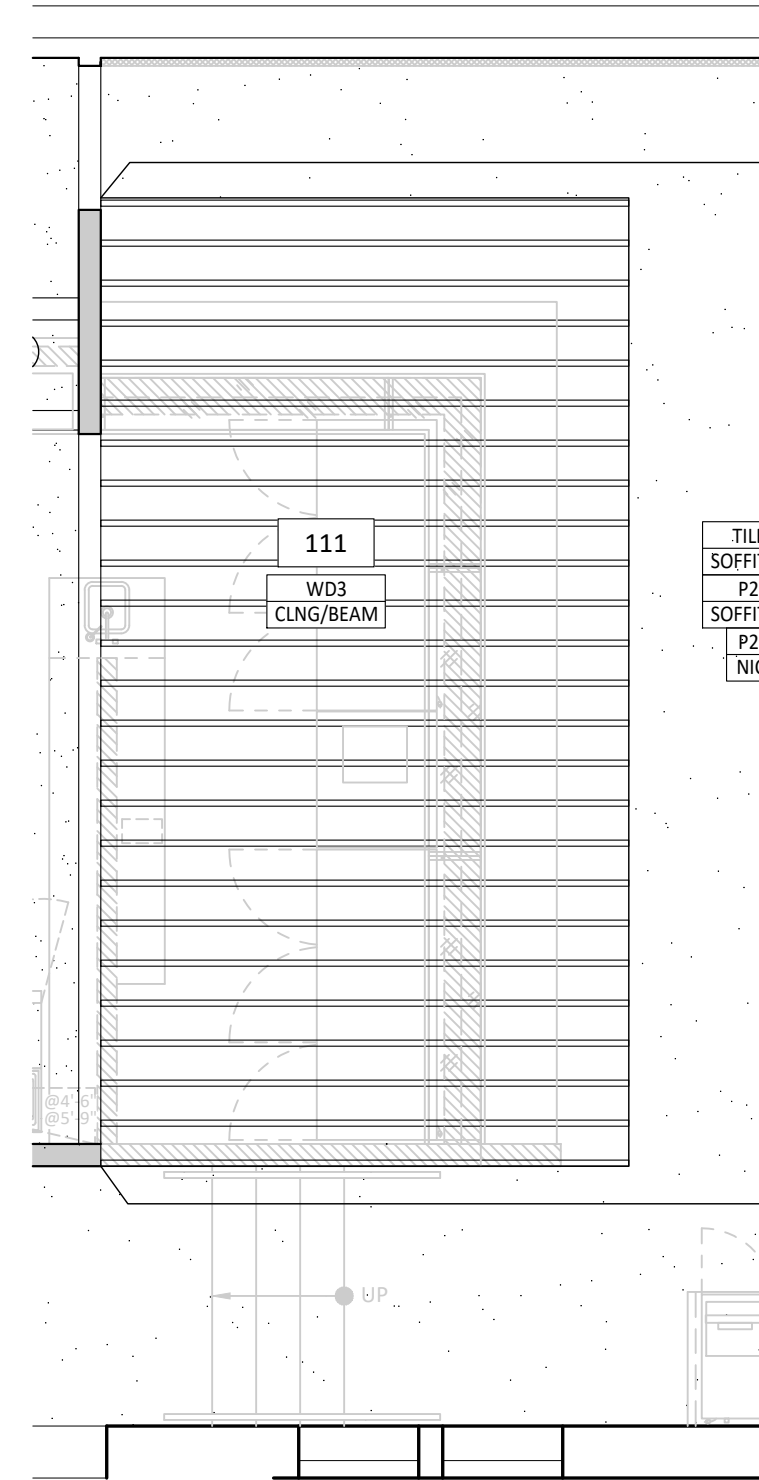

2 FINISH RCP PLAN @ ROBATA

1/4" = 1'-0"
TRUE PROJECT

NOT FOR CONSTRUCTION UNTIL PERMITTED


REVISION:	OWNER	8.13.21
REVISION:	JINYA	11.08.21
REVISION:	HEALTH	12.29.21
REVISION:	OWNER	1.26.23
REVISION:	OWNER	11.30.23
BID SET:		
HEALTH SUBMITTAL:		
CITY SUBMITTAL:		
TENANT APPROVAL:		
SCALE:	1/4" = 1'-0"	
PROJECT NO:	RJ0420	
DRAWN:	MK & SI	
DATE:	01/14/22	

FINISH FLOOR PLAN

THIS PERMIT APPLICATION SET OF DRAWINGS ARE INTENDED FOR BUILDING DEPARTMENT REVIEW ONLY. REVISIONS DUE TO PLAN CHECK AND IKEDO DESIGN REVIEW/COORDINATION MAY BE REQUIRED.

SHEET NO:


A6.0

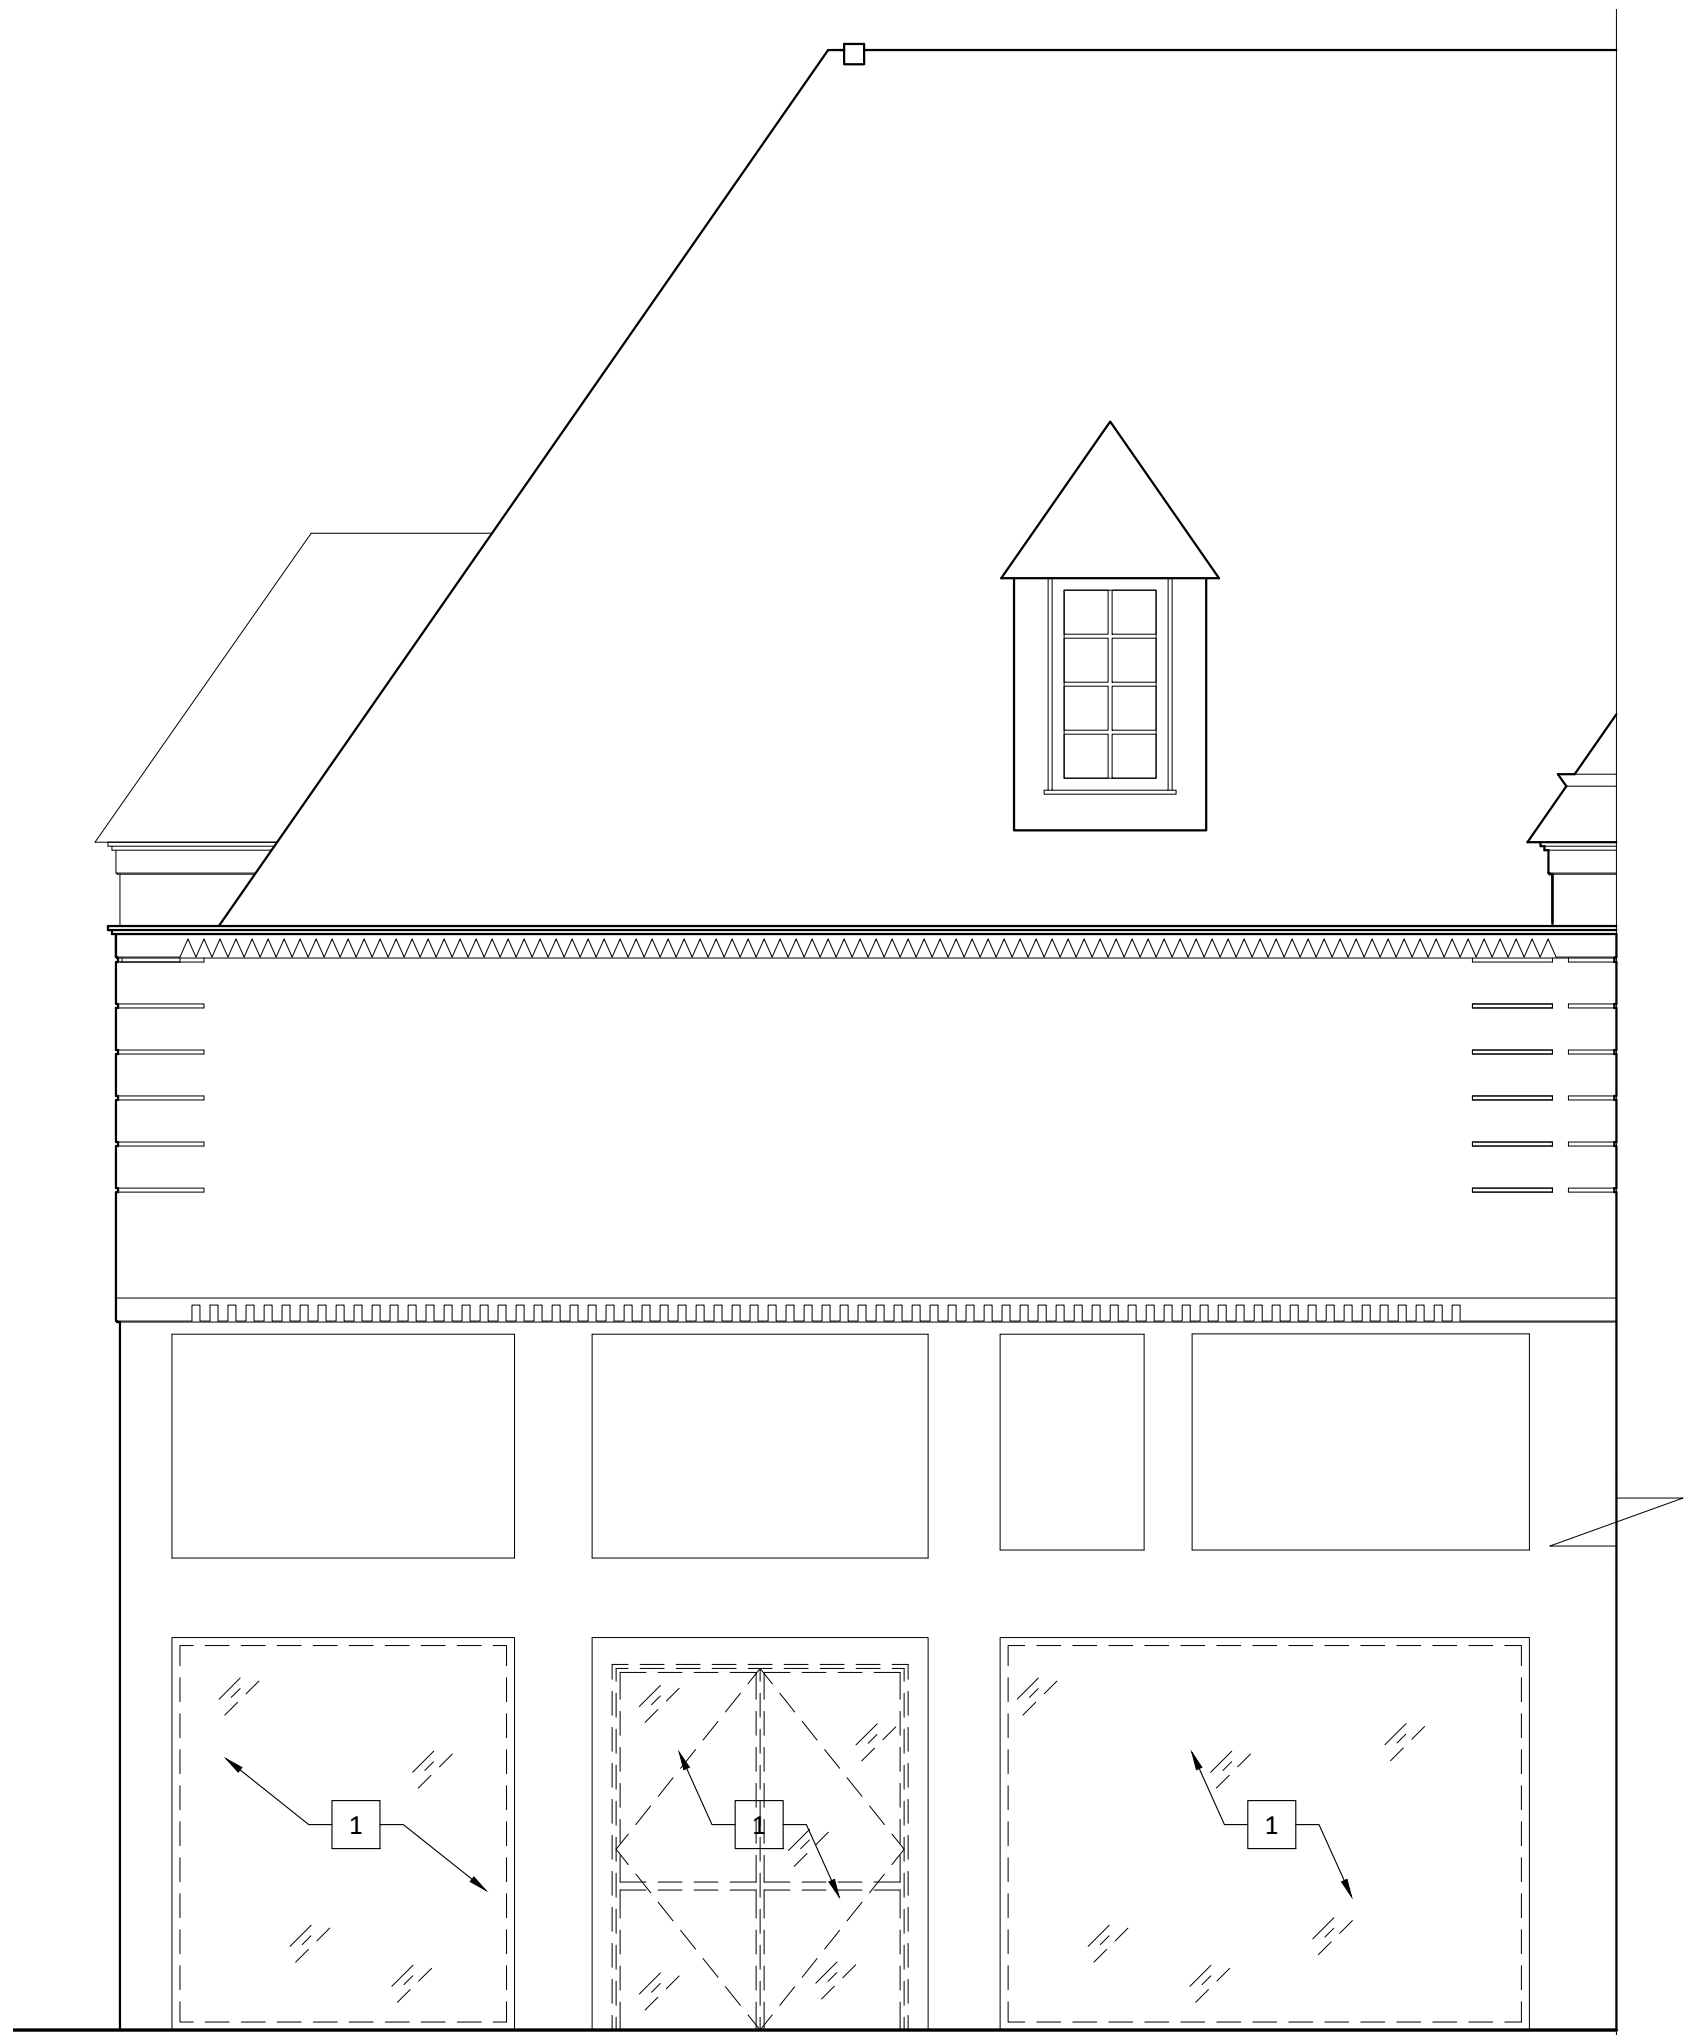

1 DEMOLITION SOUTH ELEVATION

1/4" = 1'-0"


1

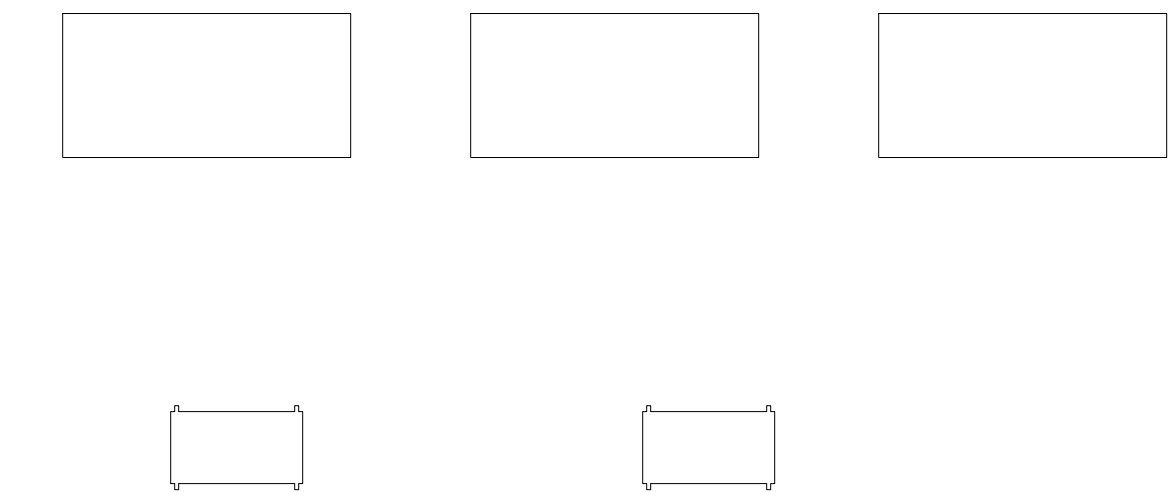

2 DEMOLITION WEST ELEVATION

1/4" = 1'-0"

2

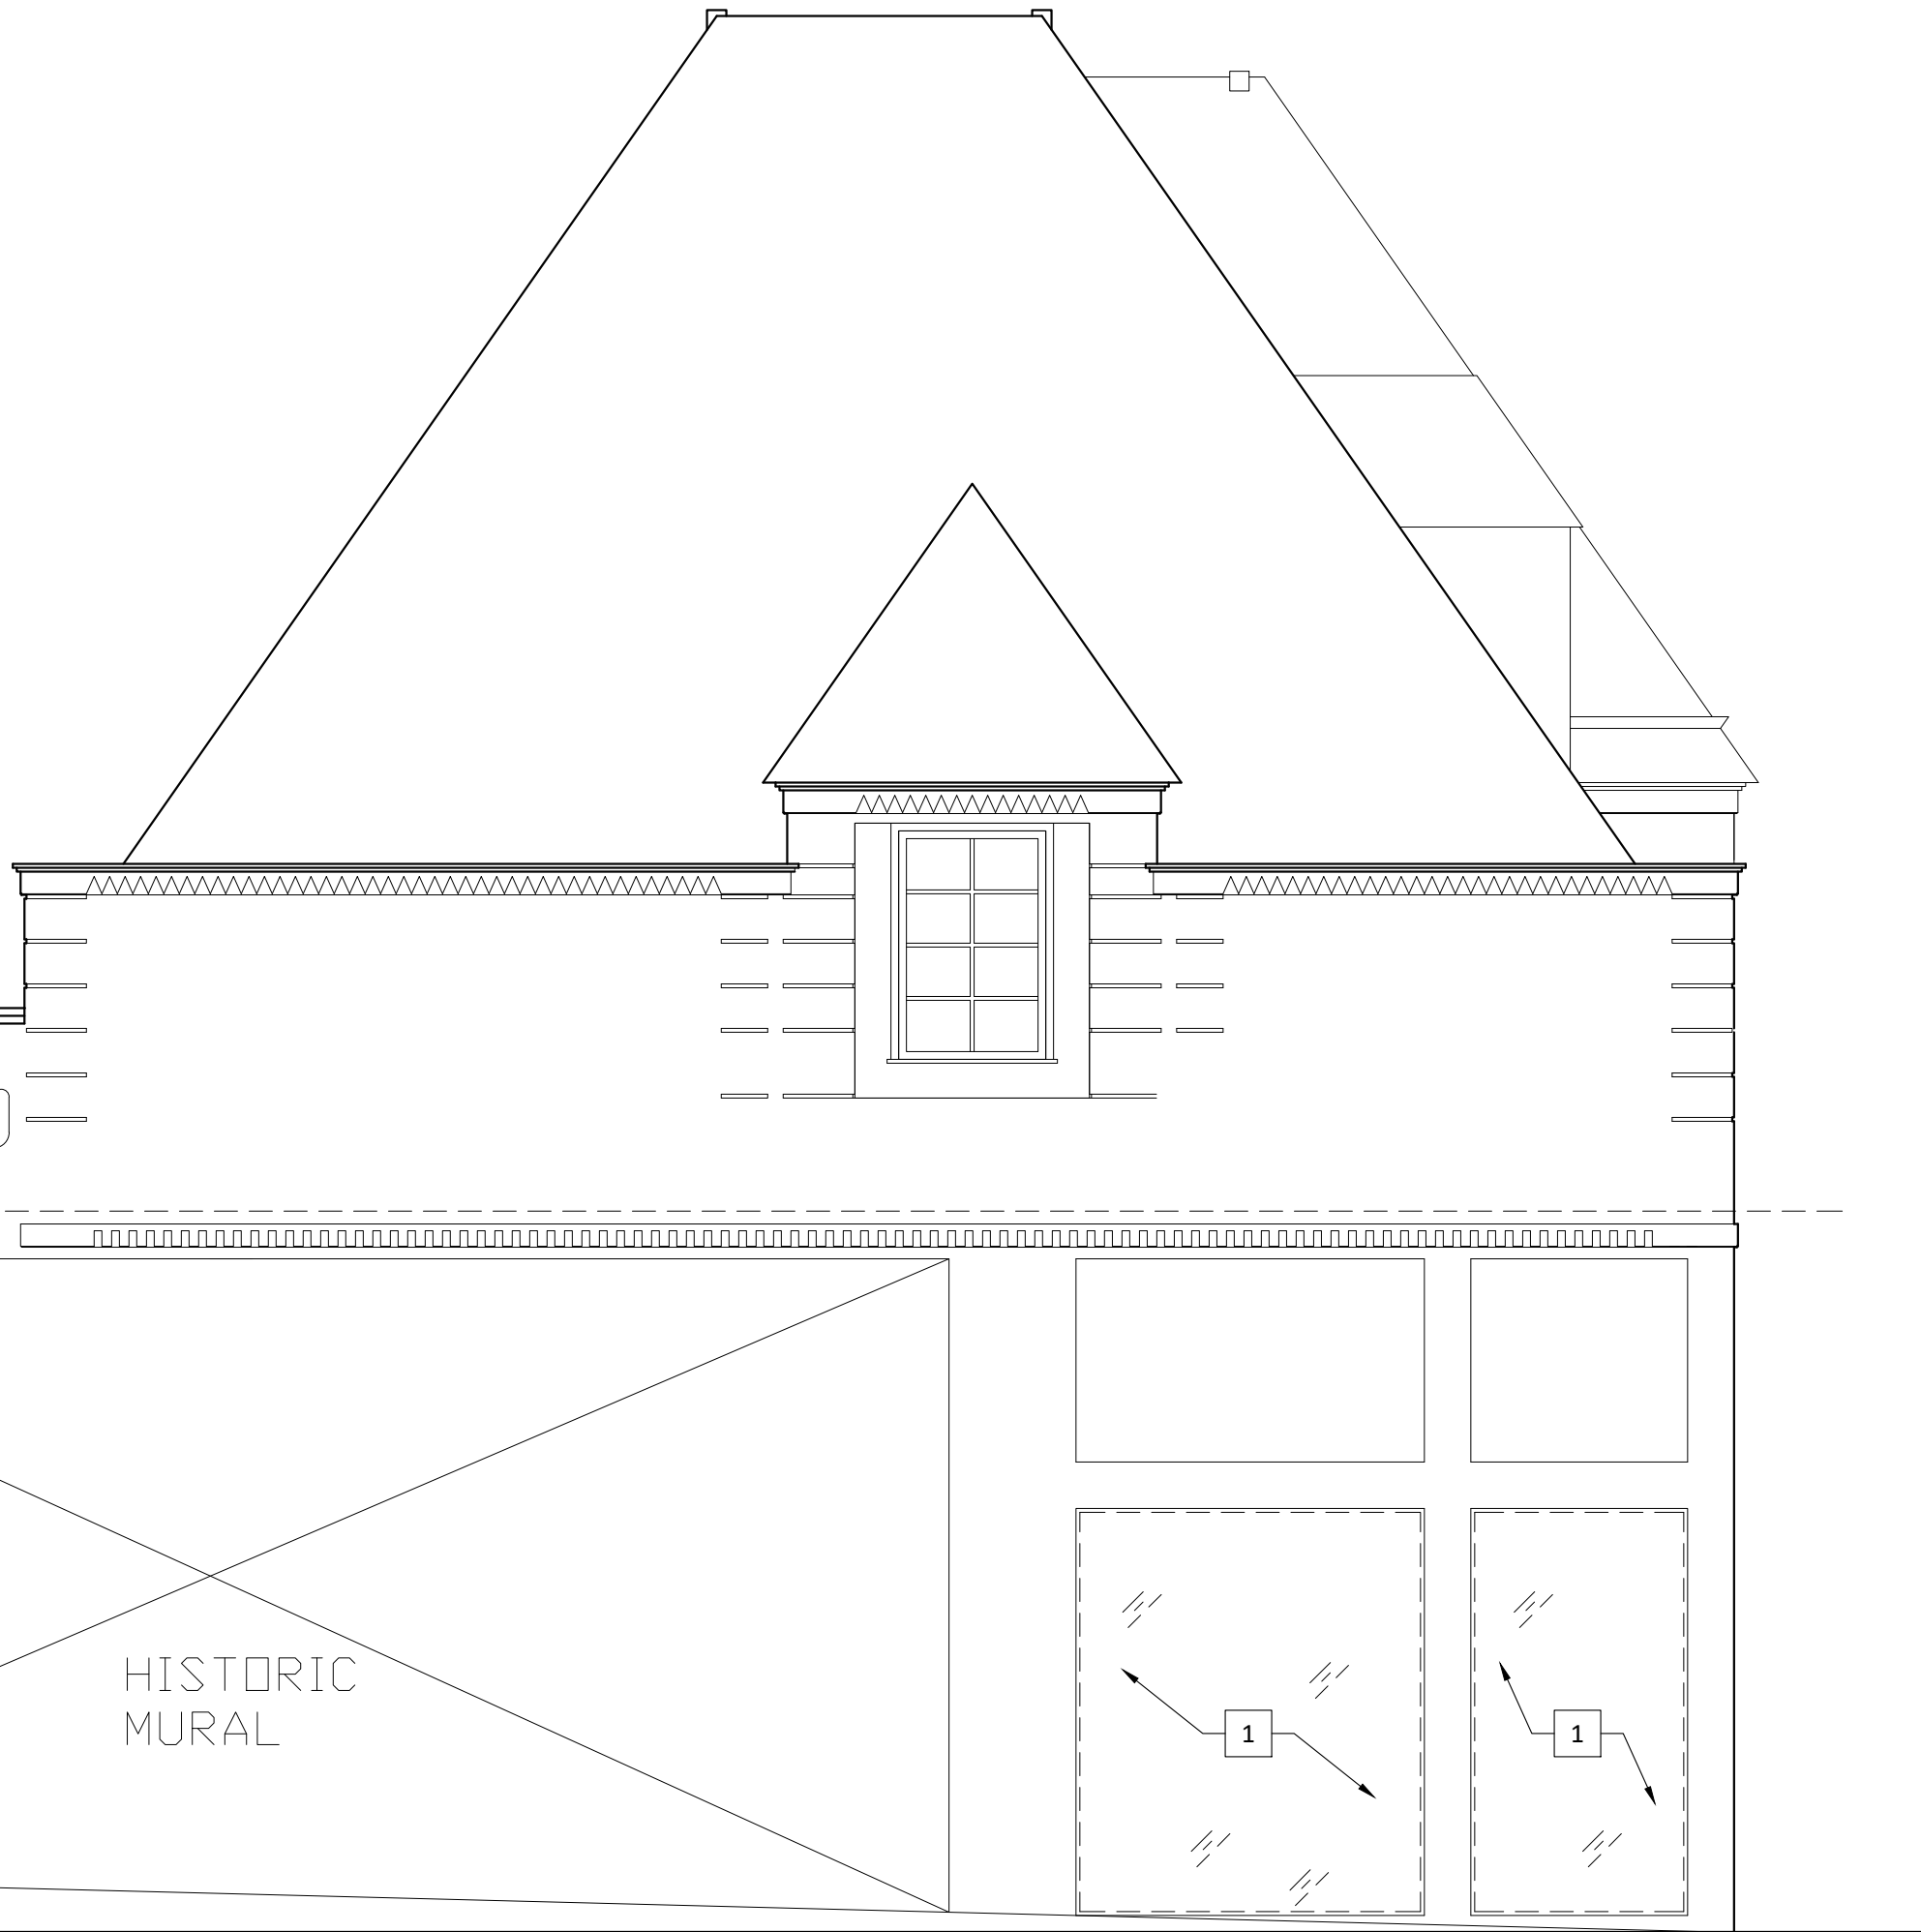

HISTORIC
MURAL

DEMO KEYNOTES

- 1 REMOVE STORE FRONT WINDOW SYSTEM,

PROJECT NOTES

1. NOTIFY IKEDO DESIGN OF ANY DISCREPANCIES WITH PLANS. CALL TO OBTAIN CLARIFICATION PRIOR TO CONSTRUCTION/ INSTALLATION/ ORDERING.
2. CALL IKEDO DESIGN IF DESIGN INTENT IS NOT CLEAR. AT NO TIME IS THE CONTRACTOR TO ASSUME OR GUESS IKEDO DESIGN'S DESIGN INTENT.
3. GENERAL CONTRACTOR IS TO INFORM IKEDO DESIGN IMMEDIATELY IF THERE ARE ANY DIMENSIONAL DISCREPANCIES BETWEEN THE PLANS AND FIELD CONDITIONS.
4. ALL SIGNAGE SHOP DRAWINGS MUST BE SUBMITTED TO IKEDO DESIGN OR JINYA CORPORATE FOR REVIEW APPROVAL.
5. PAINT ALL DIFFUSERS/ GRILL, SECURITY CAMERAS, SPEAKERS BLACK. OWNER SHALL CONTACT JINYA CORPORATE BEFORE INSTALLATION.



990 Highland Drive
Suite 110A
Solana Beach, CA 92075
p: 858.436.7967

ROBATA JINYA
RESTAURANT
6529 W. HOLLYWOOD BLVD.
LOS ANGELES, CA 90028

REVISION:	OWNER	8.13.21	1
REVISION:			
REVISION:	JINYA	11.08.21	4
REVISION:	HEALTH	12.29.21	5
REVISION:	OWNER	1.26.23	6
REVISION:	OWNER	11.30.23	7

BID SET:
HEALTH SUBMITTAL:
CITY SUBMITTAL:
TENANT APPROVAL:
SCALE: 1/4" = 1'-0"
PROJECT NO: RJ0420
DRAWN: MK & SJ
DATE: 01/14/22

EXTERIOR
DEMOLITION
ELEVATIONS

THIS PERMIT APPLICATION SET OF DRAWINGS ARE
INTENDED FOR BUILDING DEPARTMENT REVIEW ONLY.
REVISING DUE TO PLAN CHECK AND IKEDO DESIGN
REVIEW/COORDINATION MAY BE REQUIRED.

SHEET NO:


A7.0

NOT FOR CONSTRUCTION UNTIL PERMITTED



1 PROPOSED SOUTH ELEVATION

1/4" = 1'-0"

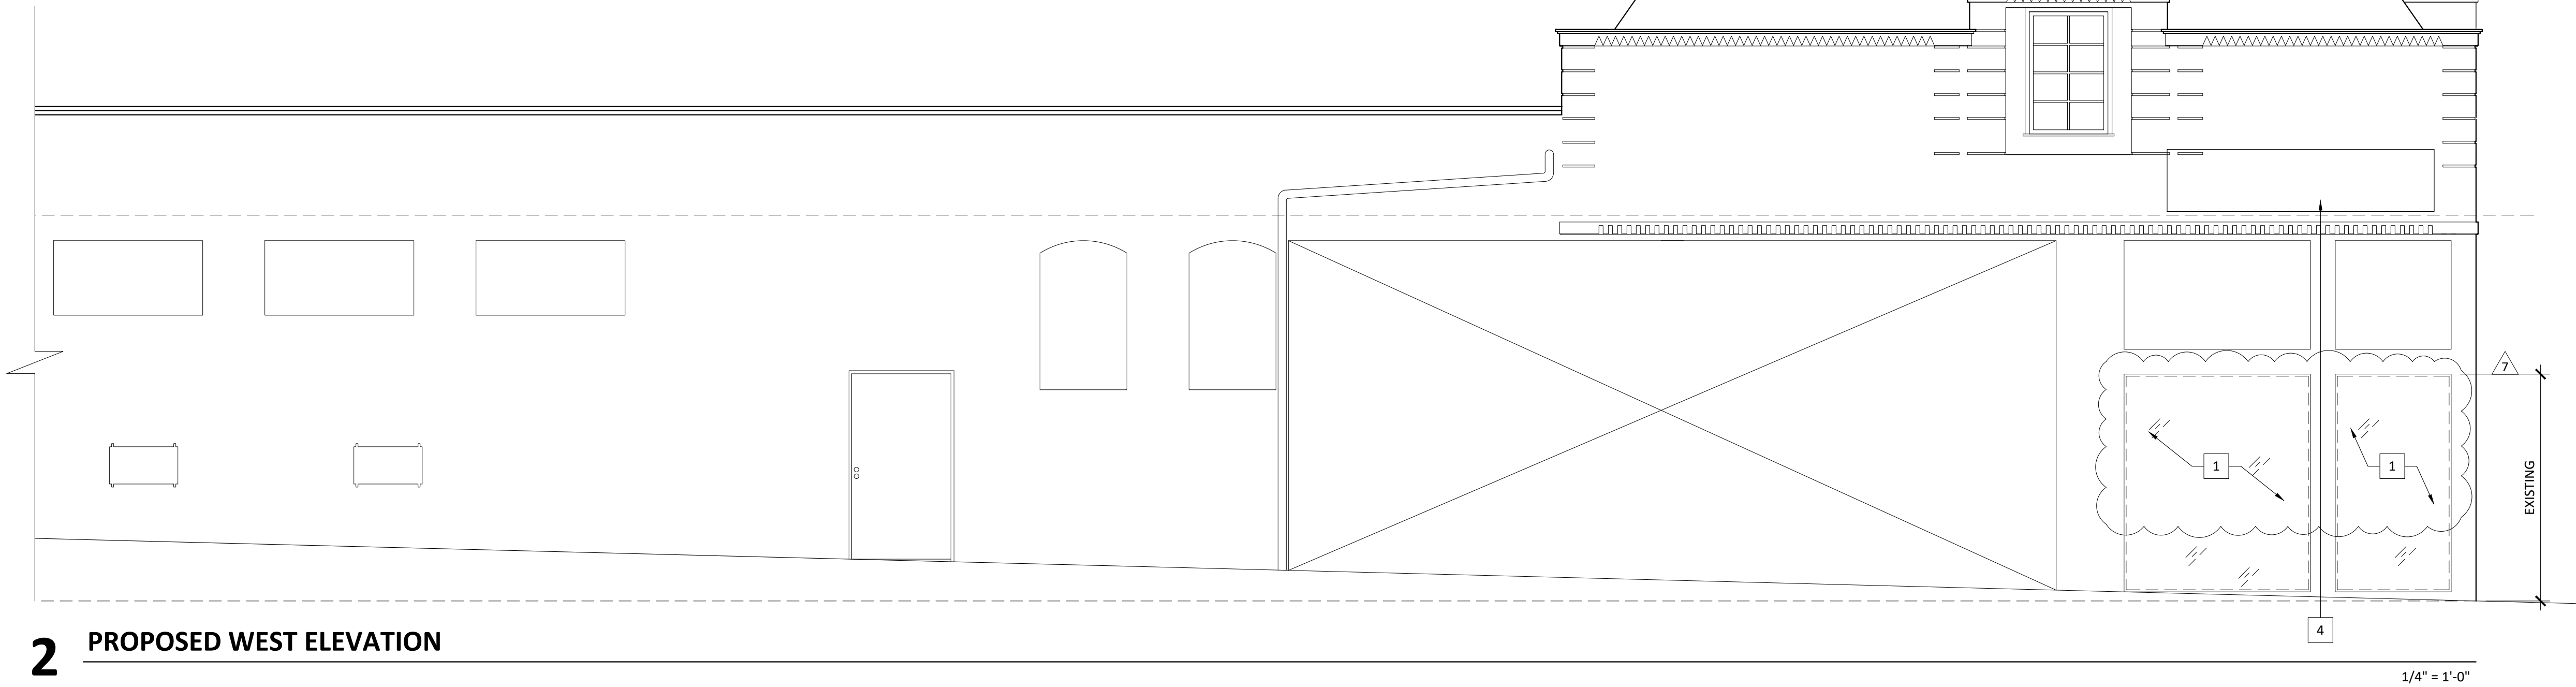

2 PROPOSED WEST ELEVATION

1/4" = 1'-0"

KEYNOTES

- 1 NEW WINDOW PER PLAN.
- 2 NOT USED 7
- 3 NEW DOOR PER PLAN.
- 4 NEW SIGNAGE PER SIGN COMPANY.

PROJECT NOTES

1. NOTIFY IKEDO DESIGN OF ANY DISCREPANCIES WITH PLANS. CALL TO OBTAIN CLARIFICATION PRIOR TO CONSTRUCTION/ INSTALLATION/ ORDERING.
2. CALL IKEDO DESIGN IF DESIGN INTENT IS NOT CLEAR. AT NO TIME IS THE CONTRACTOR TO ASSUME OR GUESS IKEDO DESIGN'S DESIGN INTENT.
3. GENERAL CONTRACTOR IS TO INFORM IKEDO DESIGN IMMEDIATELY IF THERE ARE ANY DIMENSIONAL DISCREPANCIES BETWEEN THE PLANS AND FIELD CONDITIONS.
4. ALL SIGNAGE SHOP DRAWINGS MUST BE SUBMITTED TO IKEDO DESIGN OR JINYA CORPORATE FOR REVIEW APPROVAL.
5. PAINT ALL DIFFUSERS/ GRILL, SECURITY CAMERAS, SPEAKERS BLACK. OWNER SHALL CONTACT JINYA CORPORATE BEFORE INSTALLATION.



990 Highland Drive
Suite 110A
Solana Beach, CA 92075
p: 858.436.7967

**ROBATA JINYA
RESTRAUNT**
6529 W. HOLLYWOOD BLVD.
LOS ANGELES, CA 90028

REVISION:	OWNER	8.13.21	1
REVISION:			
REVISION:	JINYA	11.08.21	4
REVISION:	HEALTH	12.29.21	5
REVISION:	OWNER	1.26.23	6
REVISION:	OWNER	11.30.23	7
REVISION:			
BID SET:			
HEALTH SUBMITTAL:			
CITY SUBMITTAL:			
TENANT APPROVAL:			
SCALE:	1/4" = 1'-0"		
PROJECT NO:	RJ0420		
DRAWN:	MK & SJ		
DATE:	01/14/22		






**PROPOSED
EXTERIOR
ELEVATIONS**

THIS PERMIT APPLICATION SET OF DRAWINGS ARE
INTENDED FOR BUILDING DEPARTMENT REVIEW ONLY.
REVISIONS DUE TO PLAN CHECK AND IKEDO DESIGN
REVIEW/COORDINATION MAY BE REQUIRED.

SHEET NO:

A7.1

NOT FOR CONSTRUCTION UNTIL PERMITTED

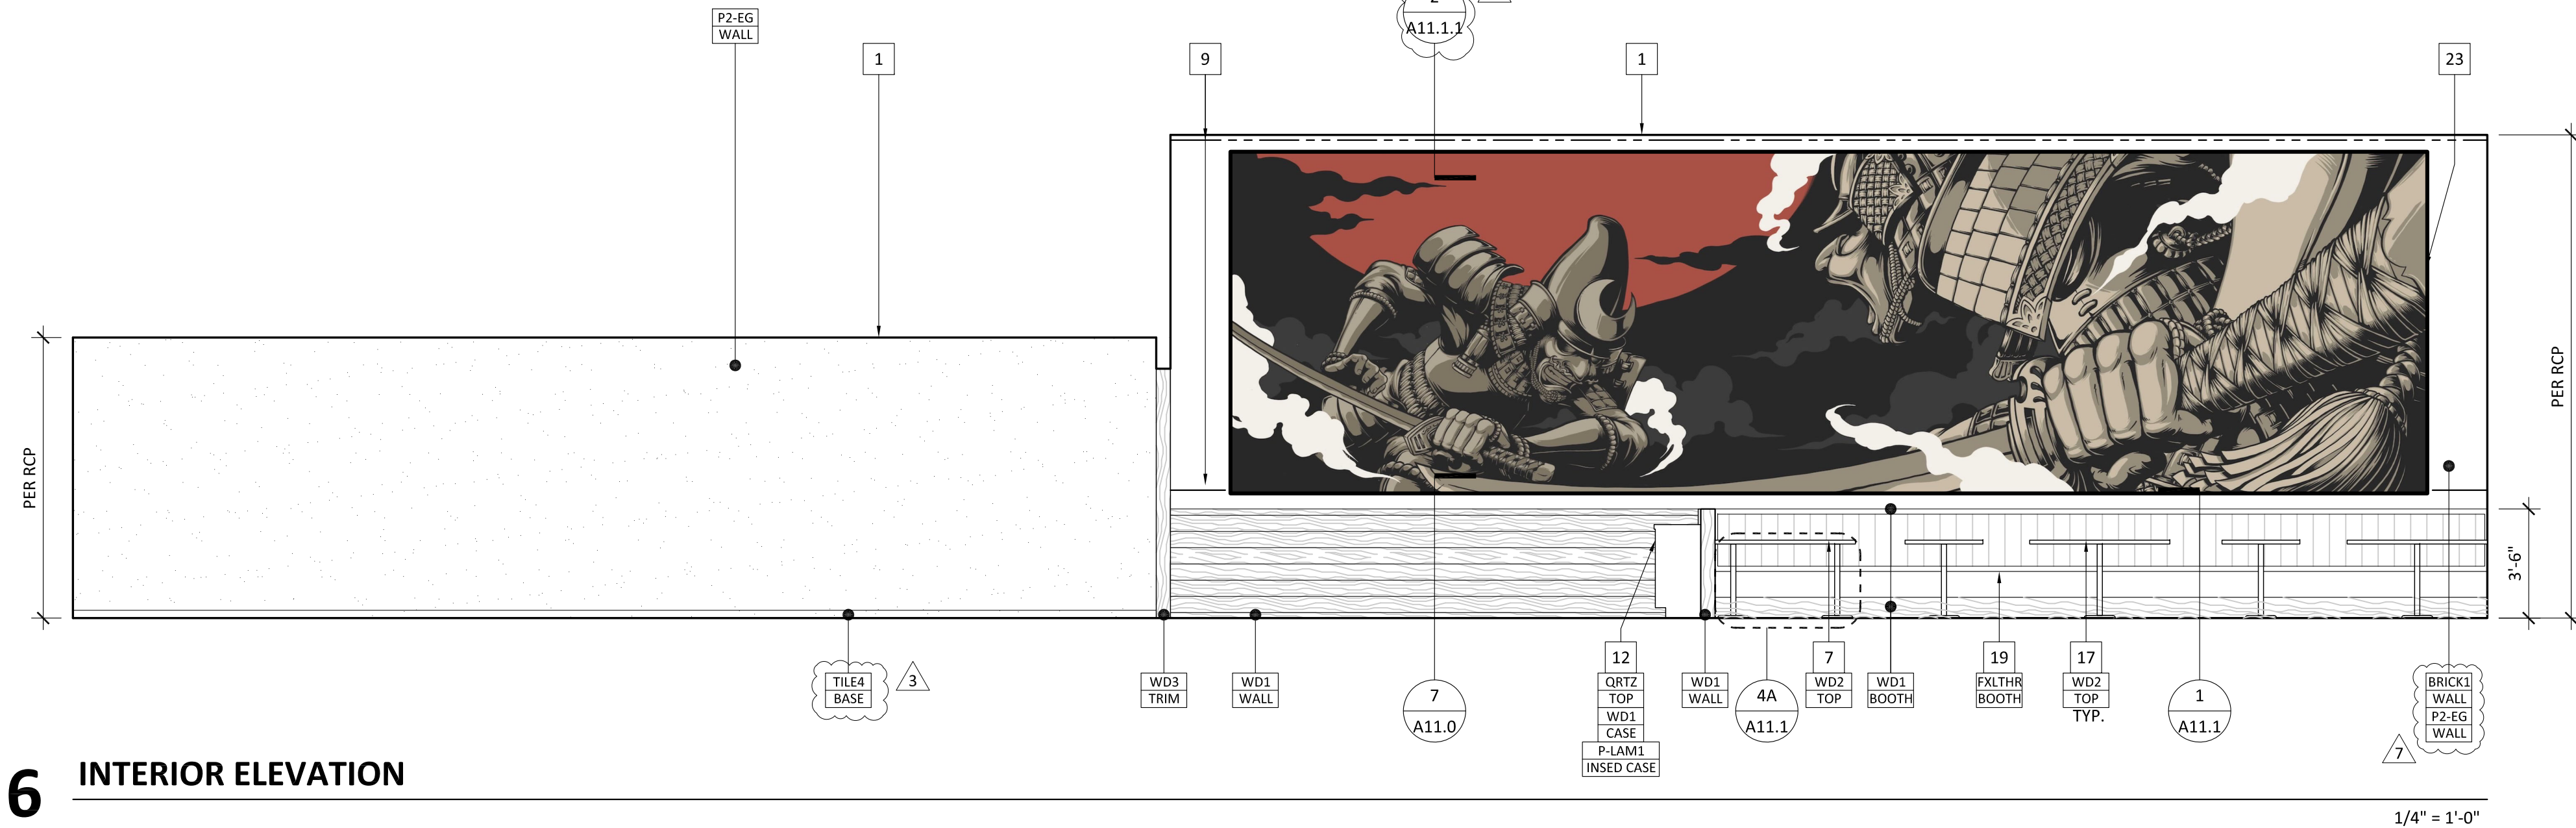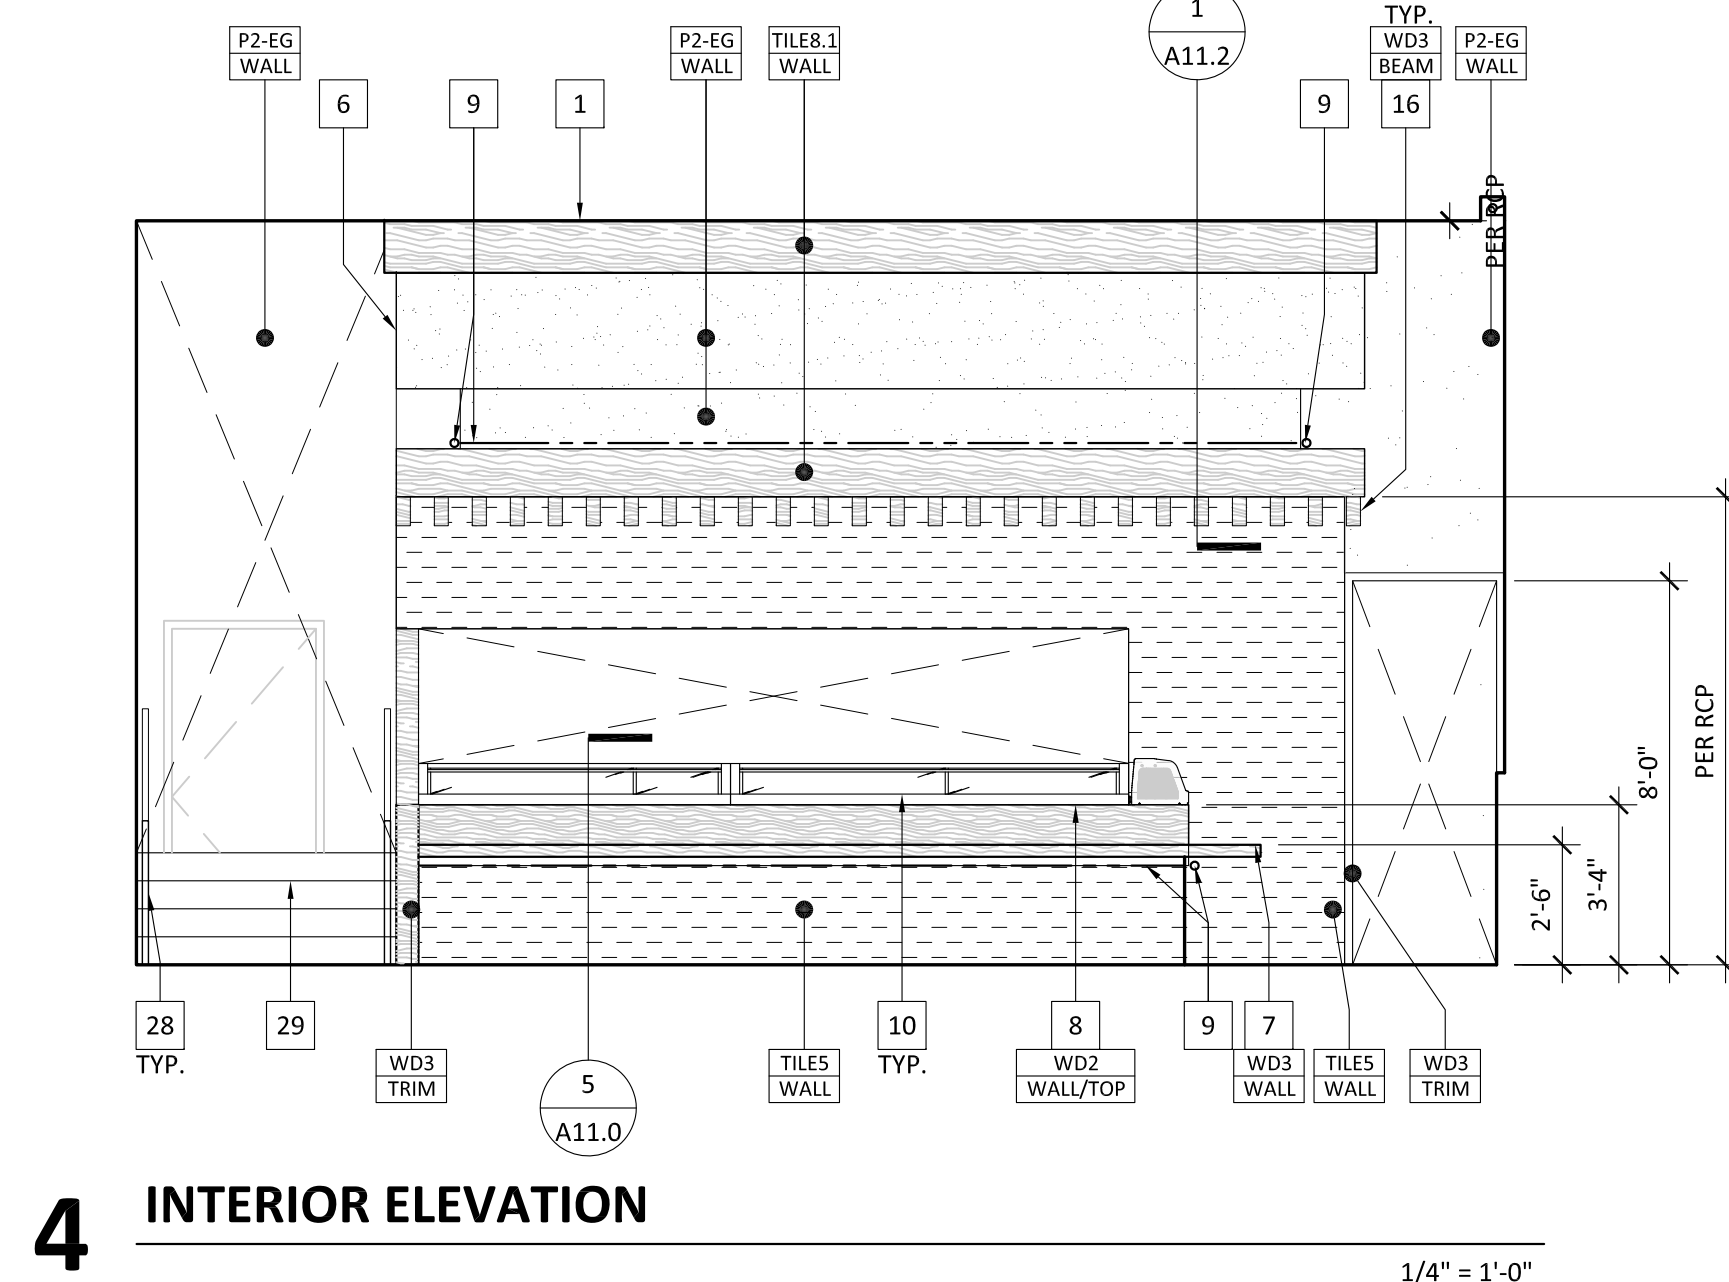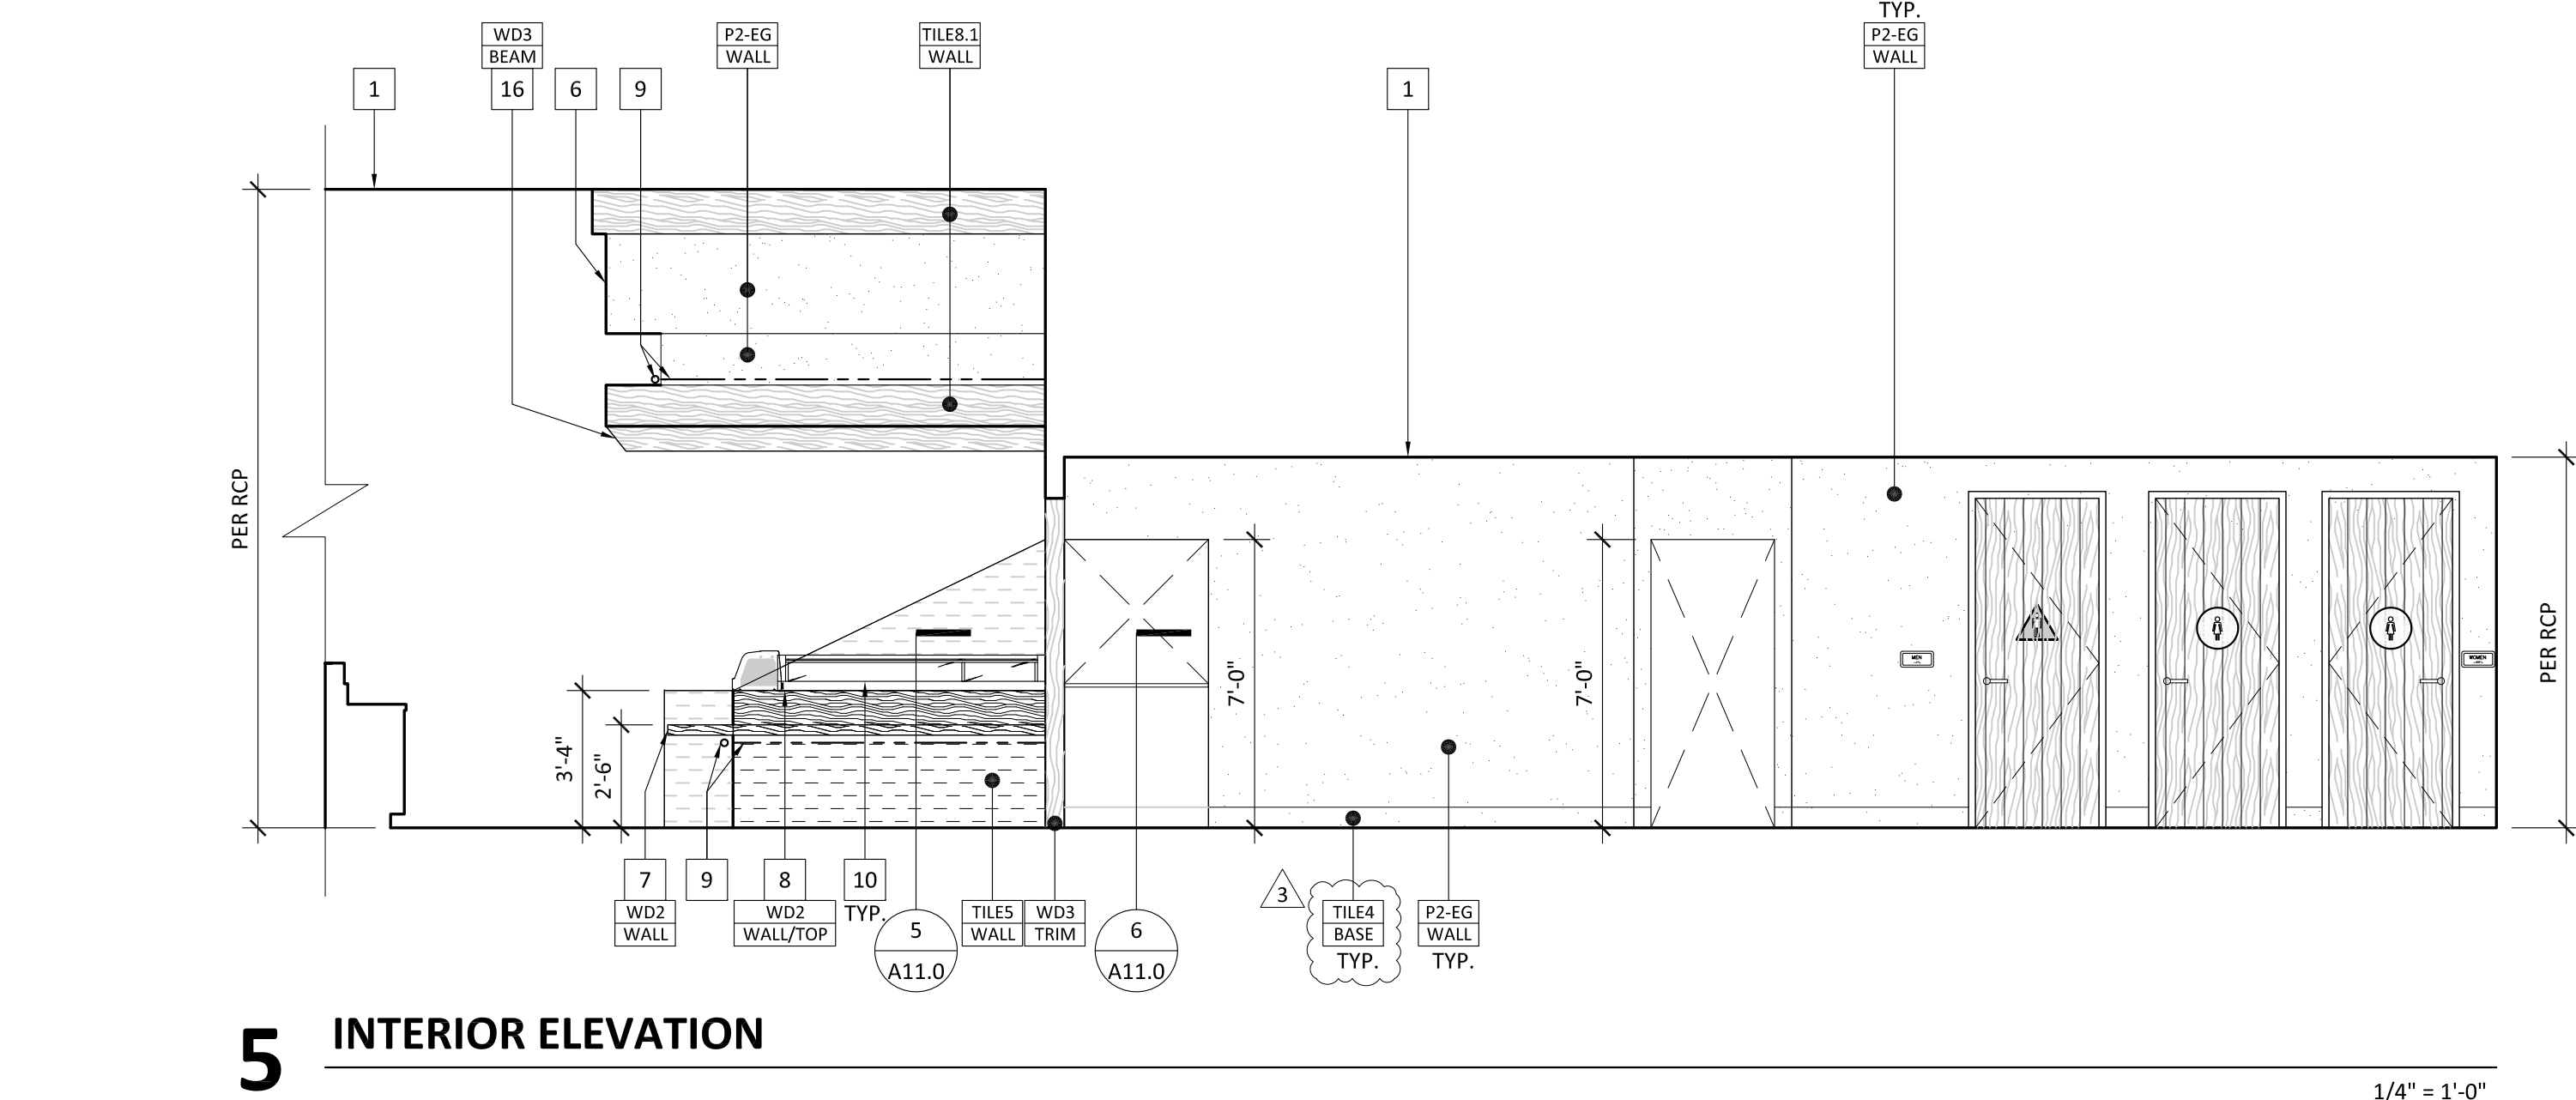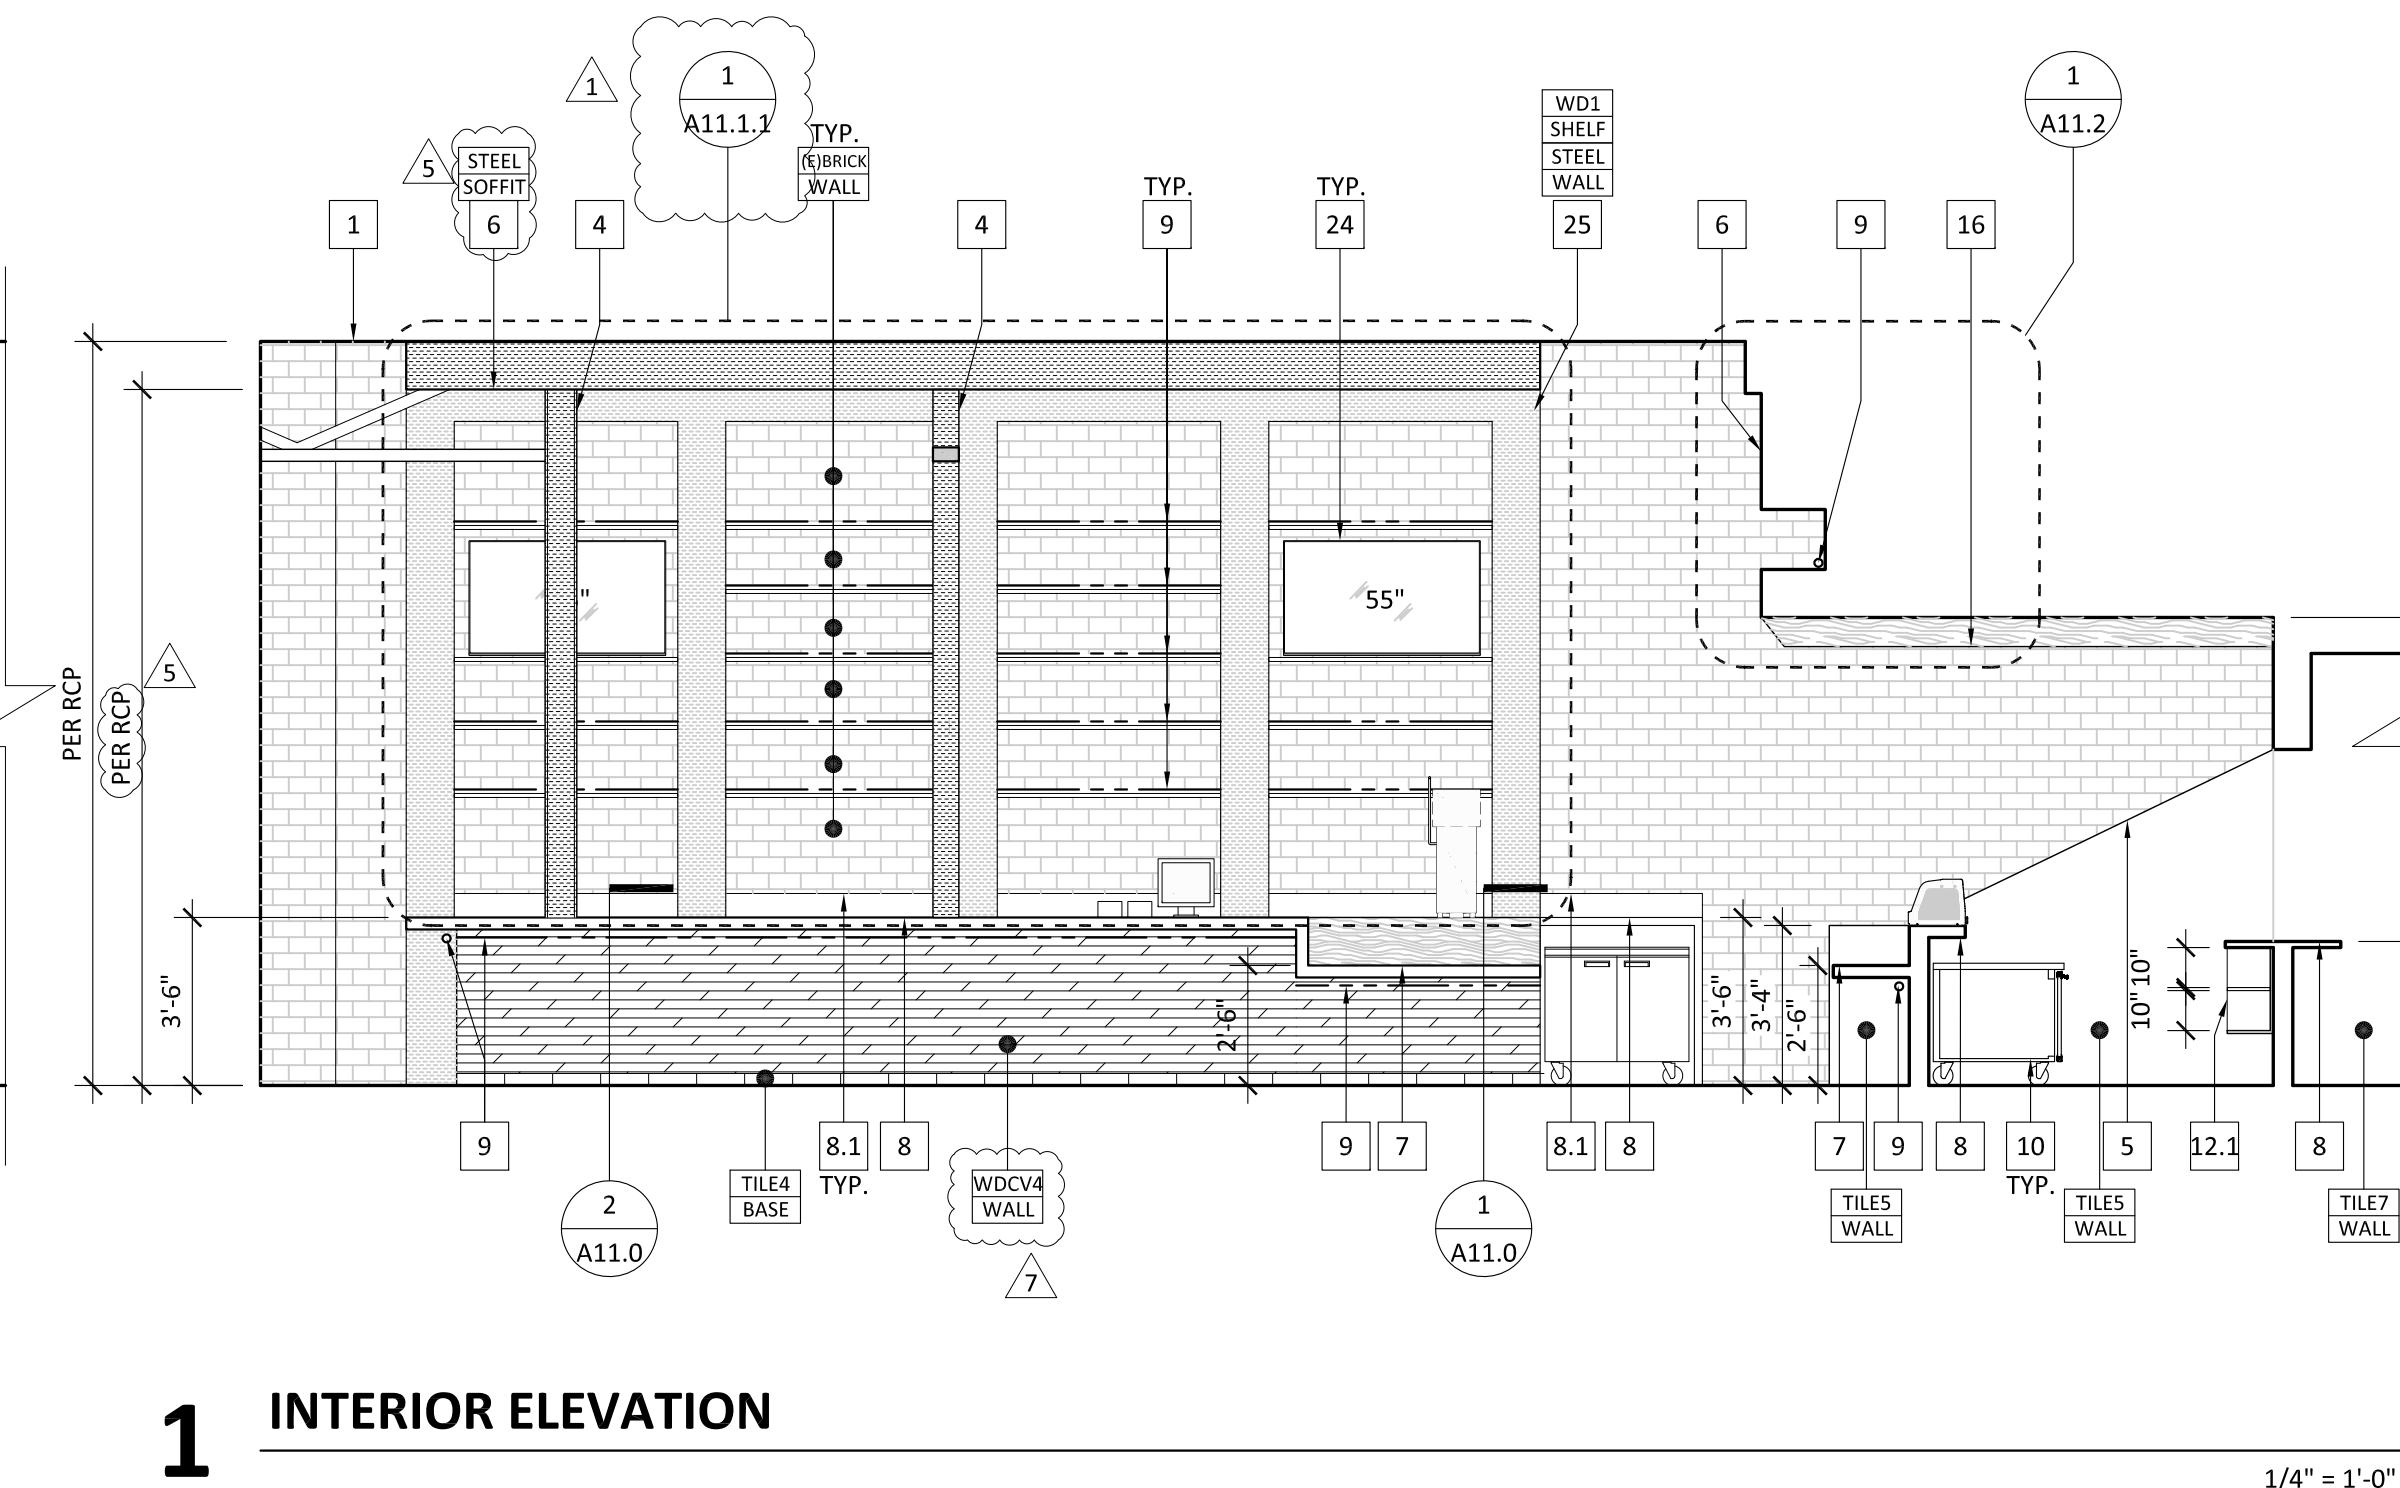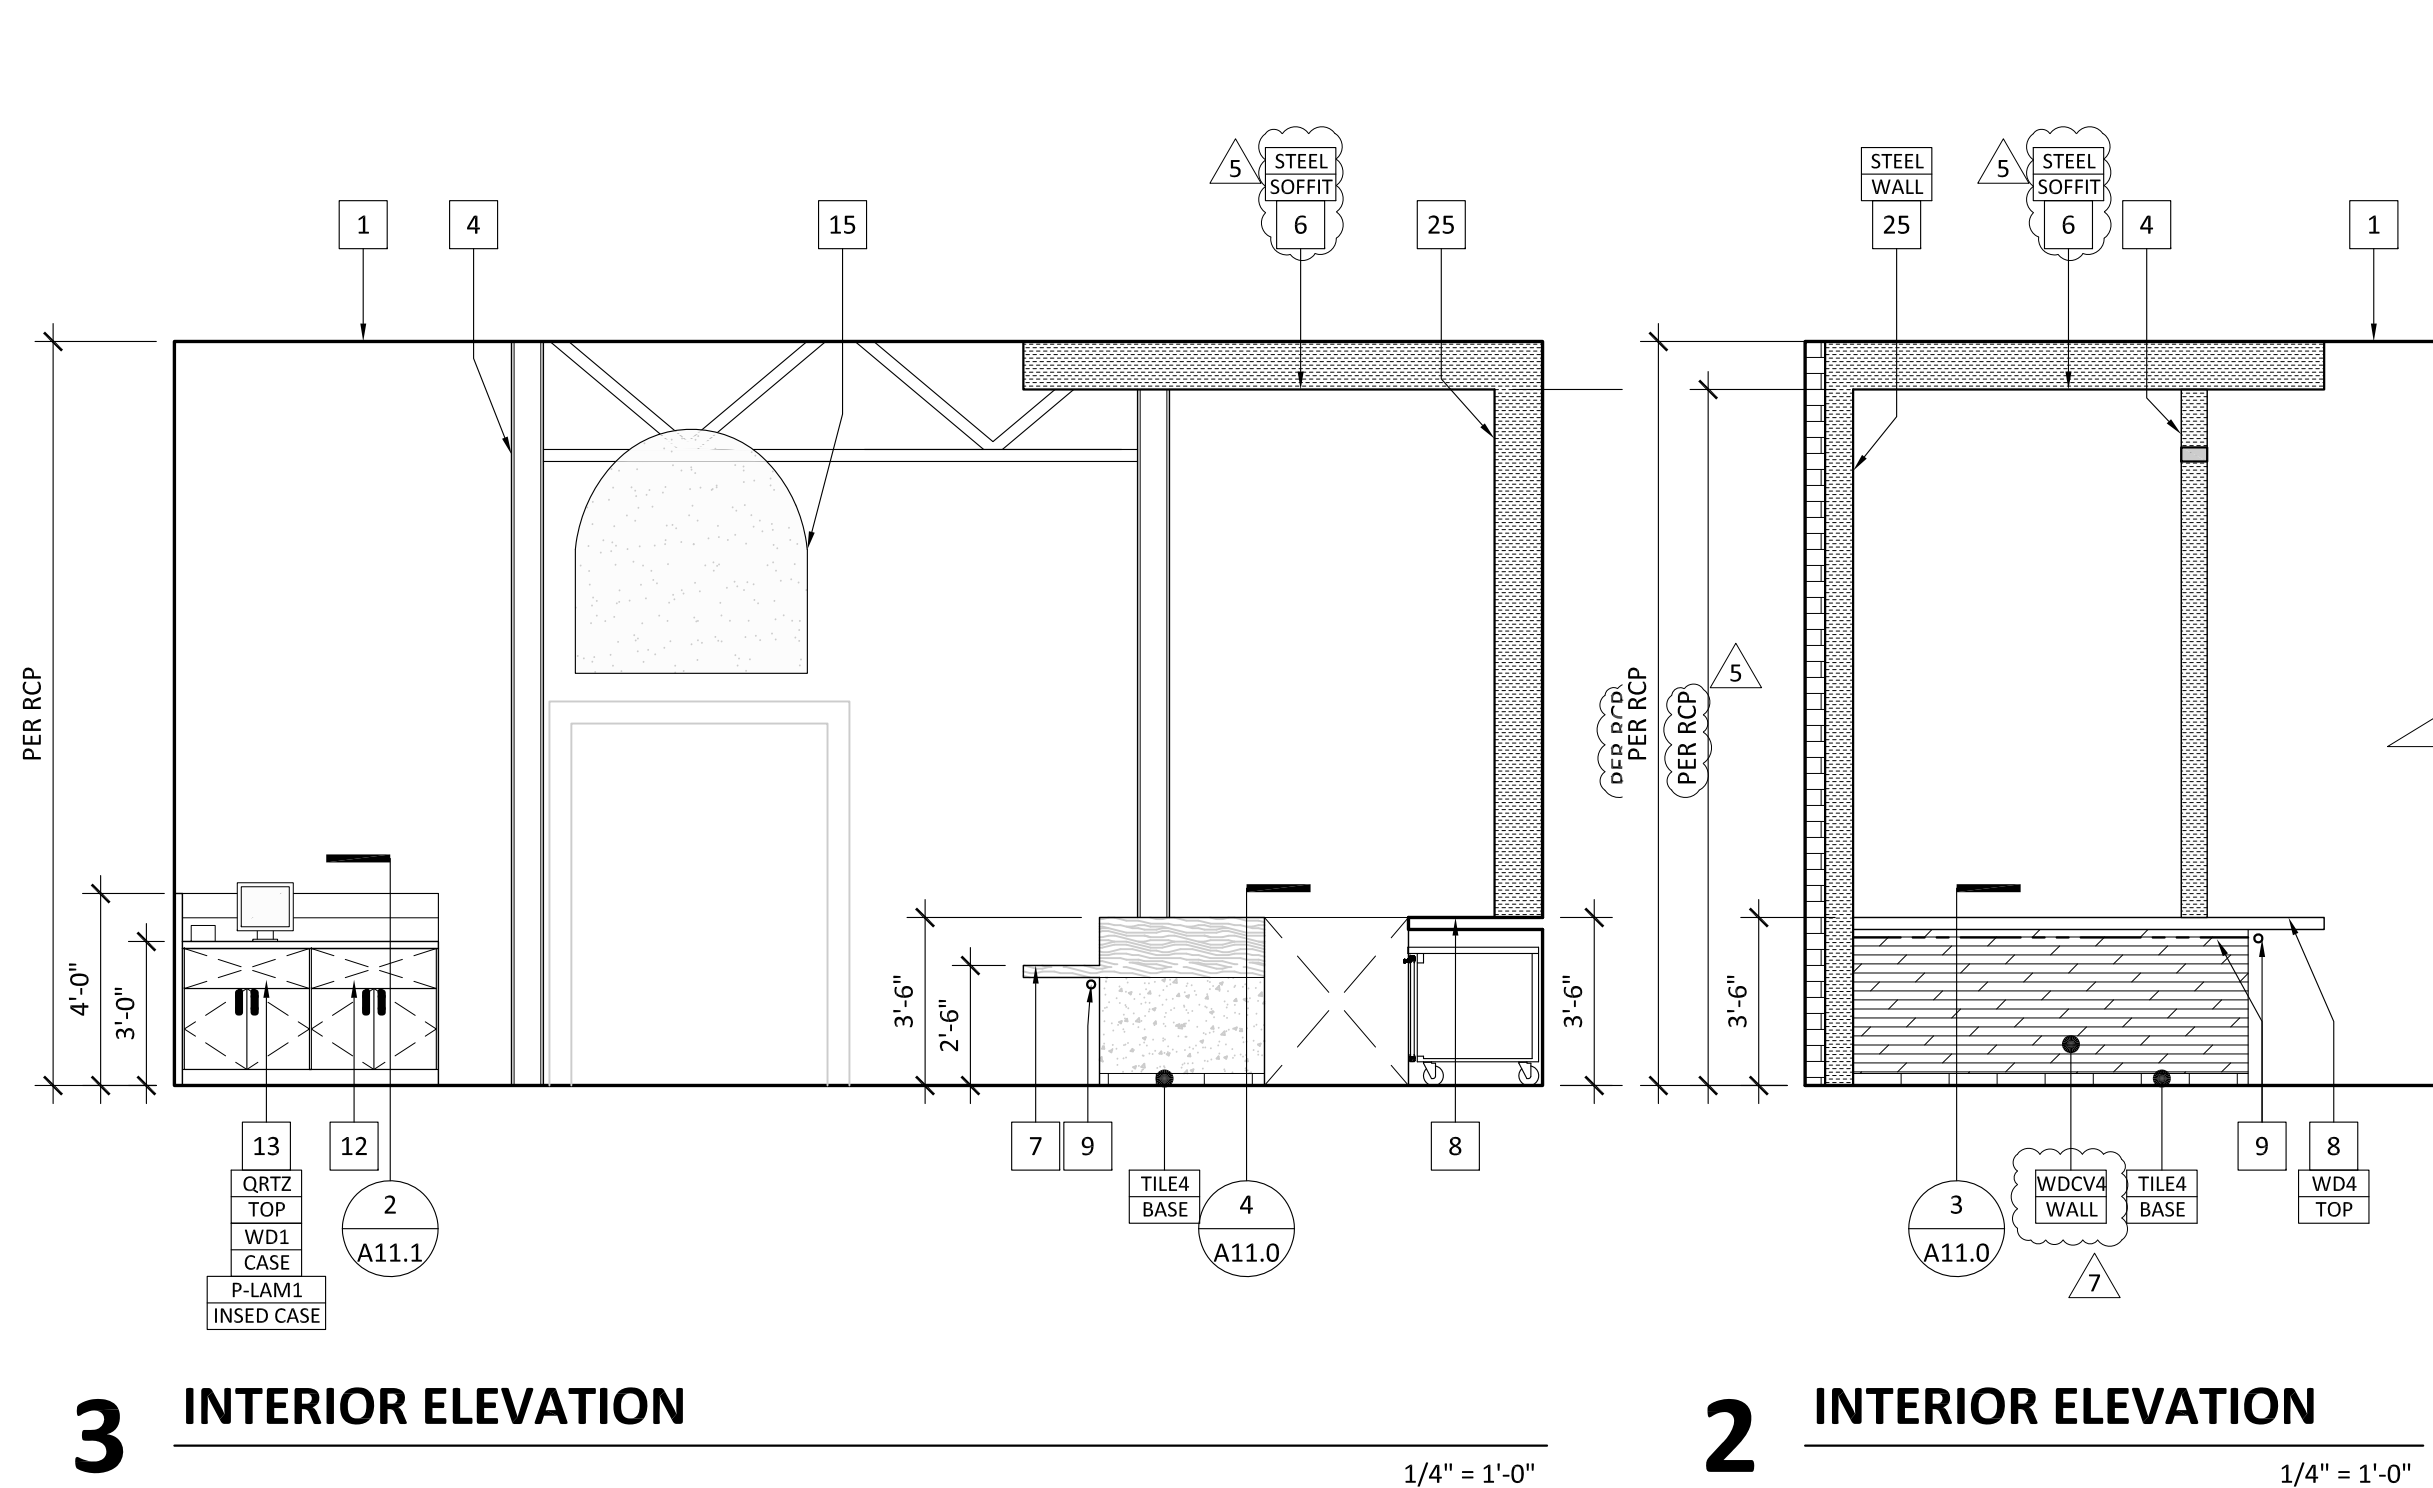

- ### KEYNOTES
- 1 CEILING LINE.
 - 2 DOOR PER DOOR SCHEDULE.
 - 3 WINDOW PER WINDOW SCHEDULE.
 - 4 EXISTING COLUMN.
 - 5 WALL PARTITION PER PLANS.
 - 6 DROPPED SOFFIT PER PLAN.
 - 7 ADA ACCESSIBLE COUNTER PER PLANS.
 - 8 COUNTER TOP/ CAP PER PLANS.
 - 8.1 COUNTERTOP BACK SPLASH PER CORRESPONDING DETAIL.
 - 9 LIGHT FIXTURE SEE RCP PLAN.
 - 10 EQUIPMENT PER PLAN AND SCHED.
 - 11 NOT USED.
 - 12 CUSTOM BUILT-IN STORAGE CABINET W/ ADJUSTABLE SHELVES.
 - 12.1 CUSTOM BUILT-IN OPEN SHELVING W/ ADJUSTABLE SHELVES.
 - 13 CASH DRAWER OPENING BUILT-IN STORAGE CABINET.
 - 14 CUSTOM TRASH STORAGE BUILT-IN PER CORRESPONDING DETAIL.
 - 15 DECORATIVE HANGING BELL PER OTHER.
 - 16 DECORATIVE WOOD BEAM PER PLAN.
 - 17 FIXED TABLE PER PLANS. BOLT TO THE FLOOR/ BASE TO BE PROVIDED BY G.C./ TOP TO BE PROVIDED BY SEPARATE VENDOR. SEE FURNITURE PLAN FOR DETAILS.
 - 18 DECORATIVE GREEN ARTWORK PER OTHER.
 - 19 CUSTOM BUILT-IN UPHOLSTERED BOOTH PER PLANS.
 - 20 WOOD SLATS PER PLAN.
 - 21 NOT USED.
 - 22 PLANTER PER OWNER. SEE FURNITURE PLAN FOR DETAILS.
 - 23 ARTWORK PER OWNER. PRIOR TO STARTING ARTWORK, OWNER/GC NEED TO CONTACT JINYA CORPORATE OFFICE & IKEDO DESIGN.
 - 24 TV PER OWNER. PROVIDE STRUCTURAL SUPPORT & ELECTRICAL AS NEEDED. MOUNTING HEIGHTS PER PLANS.
 - 25 BACK BAR SHELVING PER PLANS. PROVIDE STRUCTURAL SUPPORT AND ELECTRICAL FOR LED TAP LIGHTING AS NEEDED.
 - 26 NOT USED.
 - 27 NOT USED.
 - 28 HANDRAIL PER PLAN.
 - 29 STAIRS PER PLAN.
 - 30 NOT USED



- ### PROJECT NOTES
1. NOTIFY IKEDO DESIGN OF ANY DISCREPANCIES WITH PLANS. CALL TO OBTAIN CLARIFICATION PRIOR TO CONSTRUCTION/ INSTALLATION/ ORDERING.
 2. CALL IKEDO DESIGN IF DESIGN INTENT IS NOT CLEAR. AT NO TIME IS THE CONTRACTOR TO ASSUME OR GUESS IKEDO DESIGN'S DESIGN INTENT.
 3. GENERAL CONTRACTOR IS TO INFORM IKEDO DESIGN IMMEDIATELY IF THERE ARE ANY DIMENSIONAL DISCREPANCIES BETWEEN THE PLANS AND FIELD CONDITIONS.
 4. ALL SIGNAGE SHOP DRAWINGS MUST BE SUBMITTED TO IKEDO DESIGN OR JINYA CORPORATE FOR REVIEW. APPROVAL.
 5. PAINT ALL DIFFUSERS/ GRILL, SECURITY CAMERAS, SPEAKERS BLACK. OWNER SHALL CONTACT JINYA CORPORATE BEFORE INSTALLATION.

REVISION:	OWNER	8.13.21	1
REVISION:			
REVISION:			
REVISION:	JINYA	11.08.21	4
REVISION:	HEALTH	12.29.21	5
REVISION:	OWNER	1.26.23	6
REVISION:	OWNER	11.30.23	7
REVISION:			
BID SET:			
HEALTH SUBMITTAL:			
CITY SUBMITTAL:			
TENANT APPROVAL:			
SCALE:	1/4" = 1'-0"		
PROJECT NO:	RJ0420		
DRAWN:	MK & SI		
DATE:	01/14/22		

INTERIOR ELEVATIONS

THIS PERMIT APPLICATION SET OF DRAWINGS ARE INTENDED FOR BUILDING DEPARTMENT REVIEW ONLY. REVISIONS DUE TO PLAN CHECK AND IKEDO DESIGN REVIEW/COORDINATION MAY BE REQUIRED.

SHEET NO:

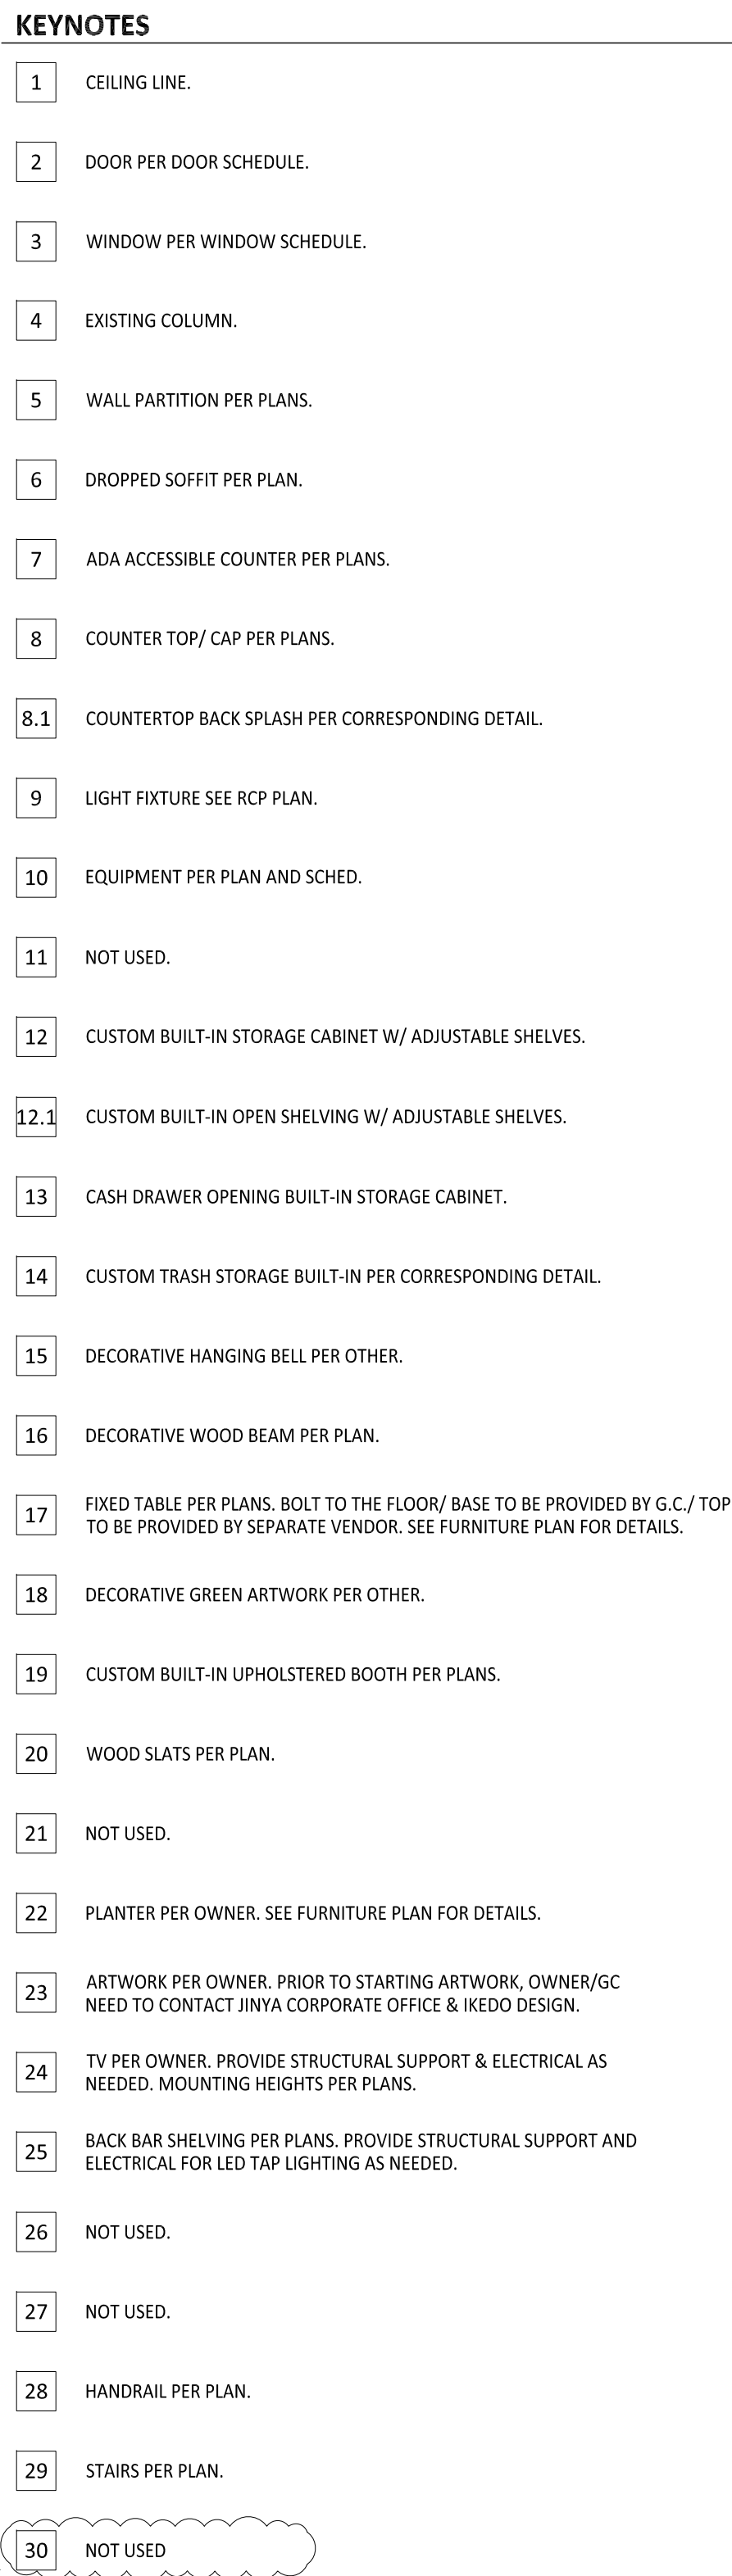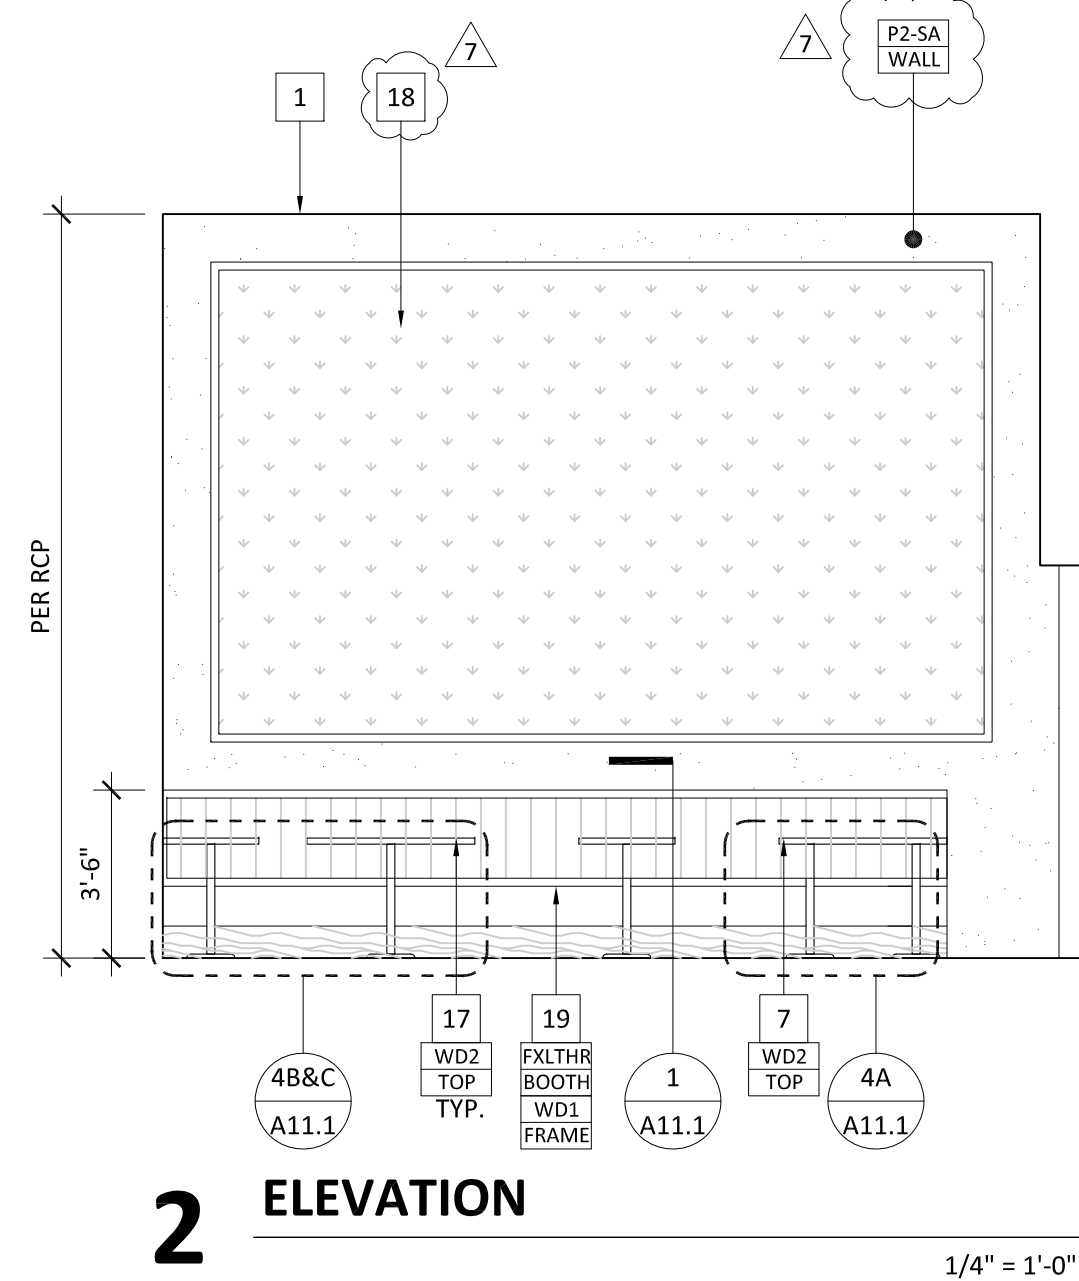

990 Highland Drive
Suite 110A
Solana Beach, CA 92075
p: 858.436.7967

ROBATA JINYA
RESTAURANT
6529 W. HOLLYWOOD BLVD.
LOS ANGELES, CA 90028

REVISION:	OWNER 8.13.21	1
REVISION:		
REVISION:		
REVISION:	JINYA 11.08.21	4
REVISION:	HEALTH 12.29.21	5
REVISION:	OWNER 1.26.23	6
REVISION:	OWNER 11.30.23	7
REVISION:		
BID SET:		
HEALTH SUBMITTAL:		
CITY SUBMITTAL:		
TENANT APPROVAL:		
SCALE:	1/4" = 1'-0"	
PROJECT NO:	RJ042	
DRAWN:	MK &	
DATE:	01/14/22	

INTERIOR ELEVATIONS

THIS PERMIT APPLICATION SET OF DRAWINGS ARE
INTENDED FOR BUILDING DEPARTMENT REVIEW ONLY.
REVISIONS DUE TO PLAN CHECK AND IKEDO DESIGN
REVIEW/COORDINATION MAY BE REQUIRED.


SHEET NO.

A7.3

NOT FOR CONSTRUCTION UNTIL PERMITTED


PROJECT NOTES

1. NOTIFY IKEDO DESIGN OF ANY DISCREPANCIES WITH PLANS. CALL TO OBTAIN CLARIFICATION PRIOR TO CONSTRUCTION/ INSTALLATION/ ORDERING.
2. CALL IKEDO DESIGN IF DESIGN INTENT IS NOT CLEAR. AT NO TIME IS THE CONTRACTOR TO ASSUME OR GUESS IKEDO DESIGN'S DESIGN INTENT.
3. GENERAL CONTRACTOR IS TO INFORM IKEDO DESIGN IMMEDIATELY IF THERE ARE ANY DIMENSIONAL DISCREPANCIES BETWEEN THE PLANS AND FIELD CONDITIONS.
4. ALL SIGNAGE SHOP DRAWINGS MUST BE SUBMITTED TO IKEDO DESIGN OR JINYA CORPORATE FOR REVIEW APPROVAL.
5. PAINT ALL DIFFUSERS/ GRILL, SECURITY CAMERAS, SPEAKERS BLACK. OWNER SHALL CONTACT JINYA CORPORATE BEFORE INSTALLATION.

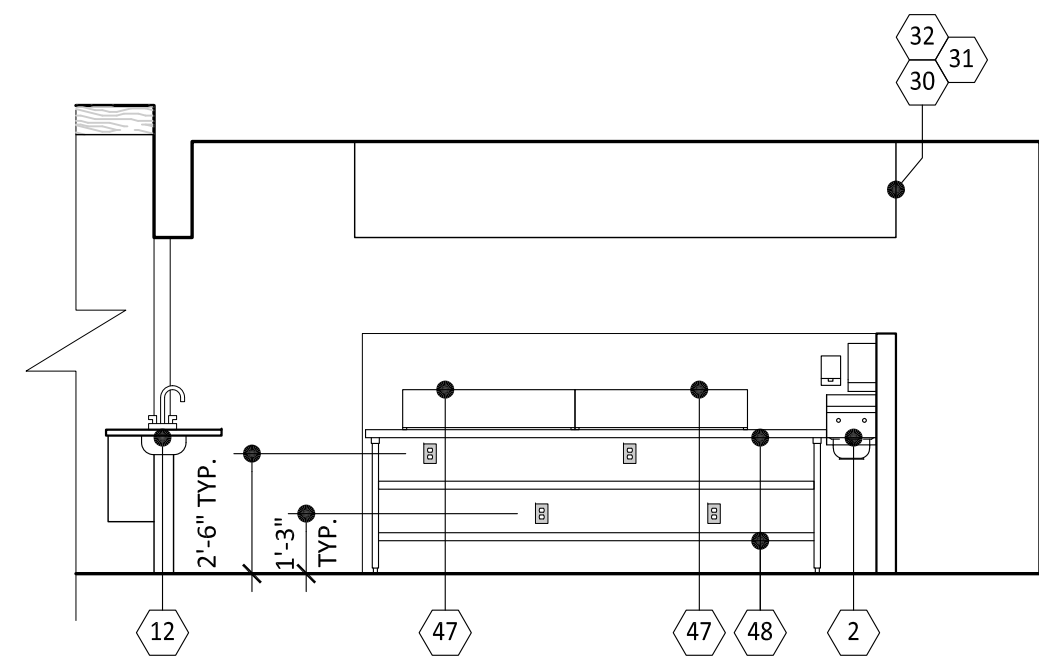


3 ELEVATION

1/4" = 1'-0"

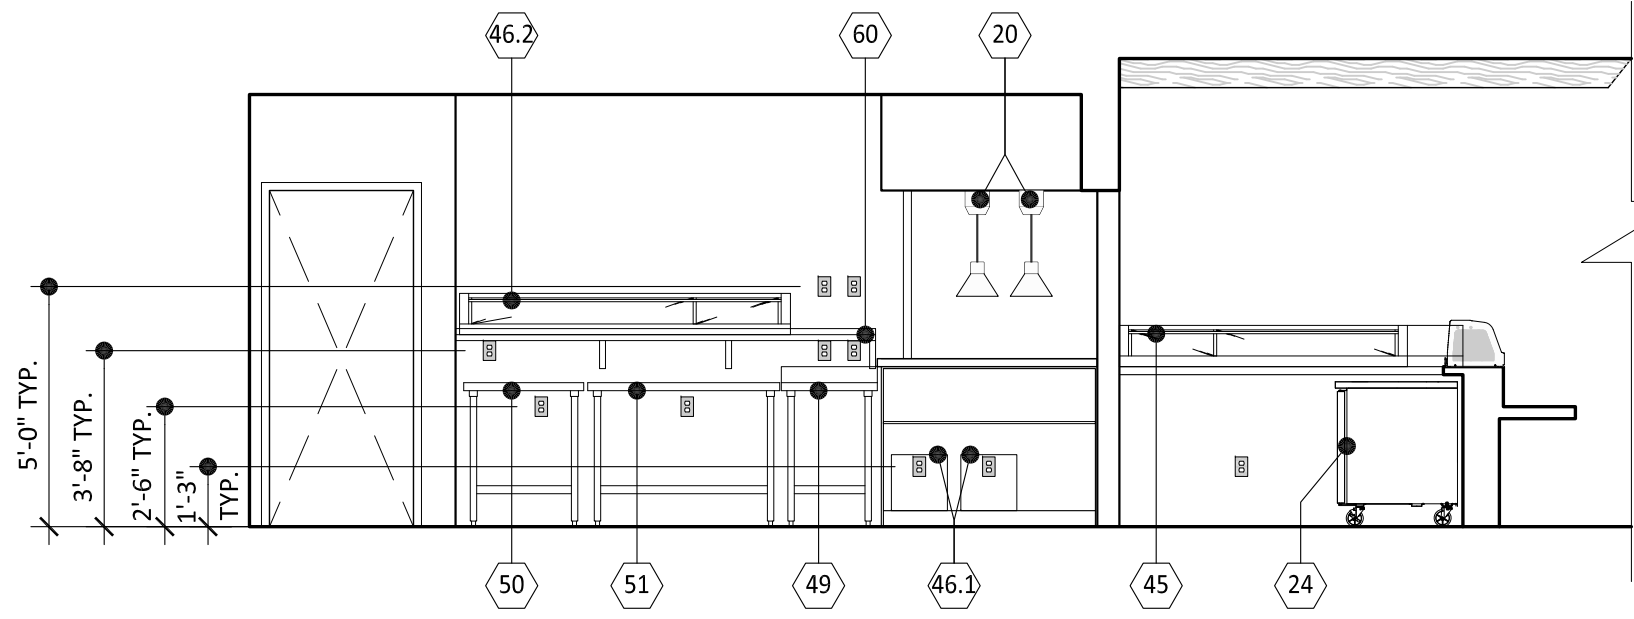


2 ELEVATION

1/4" = 1'-0"

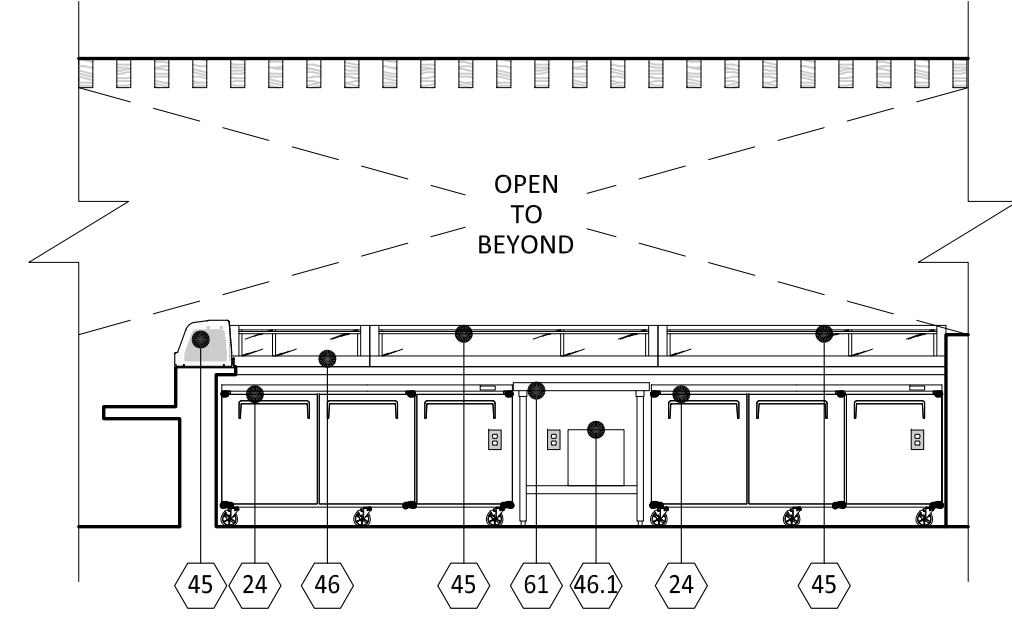


1 ELEVATION

1/4" = 1'-0"

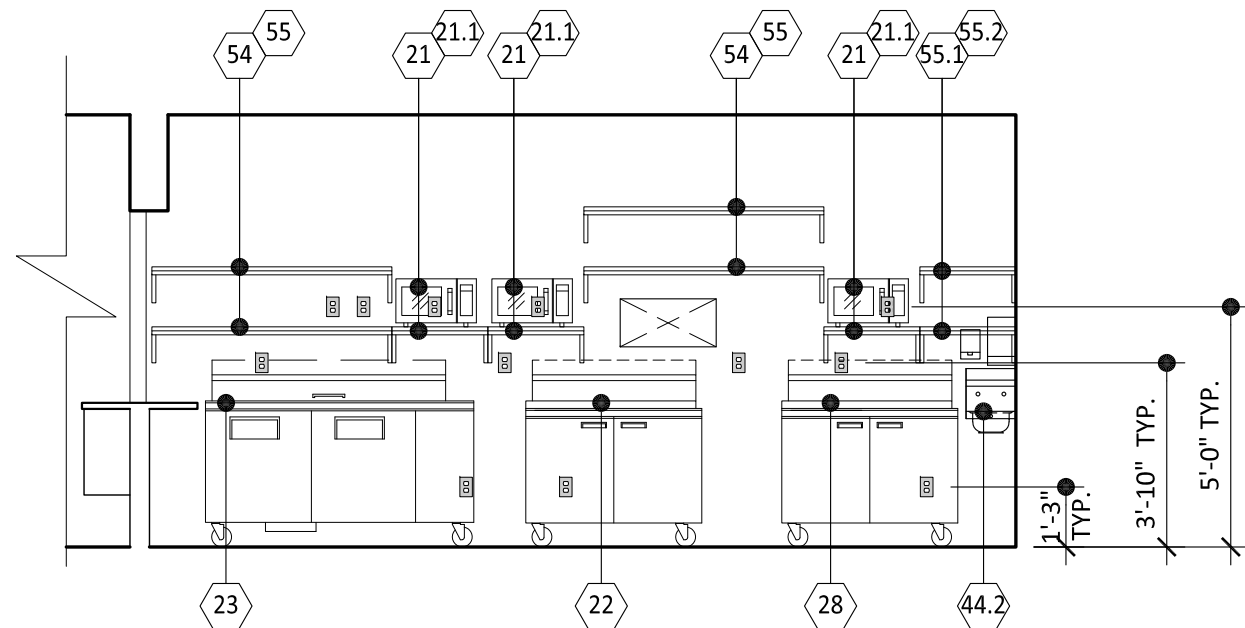

5 ELEVATION

1/4" = 1'-0"

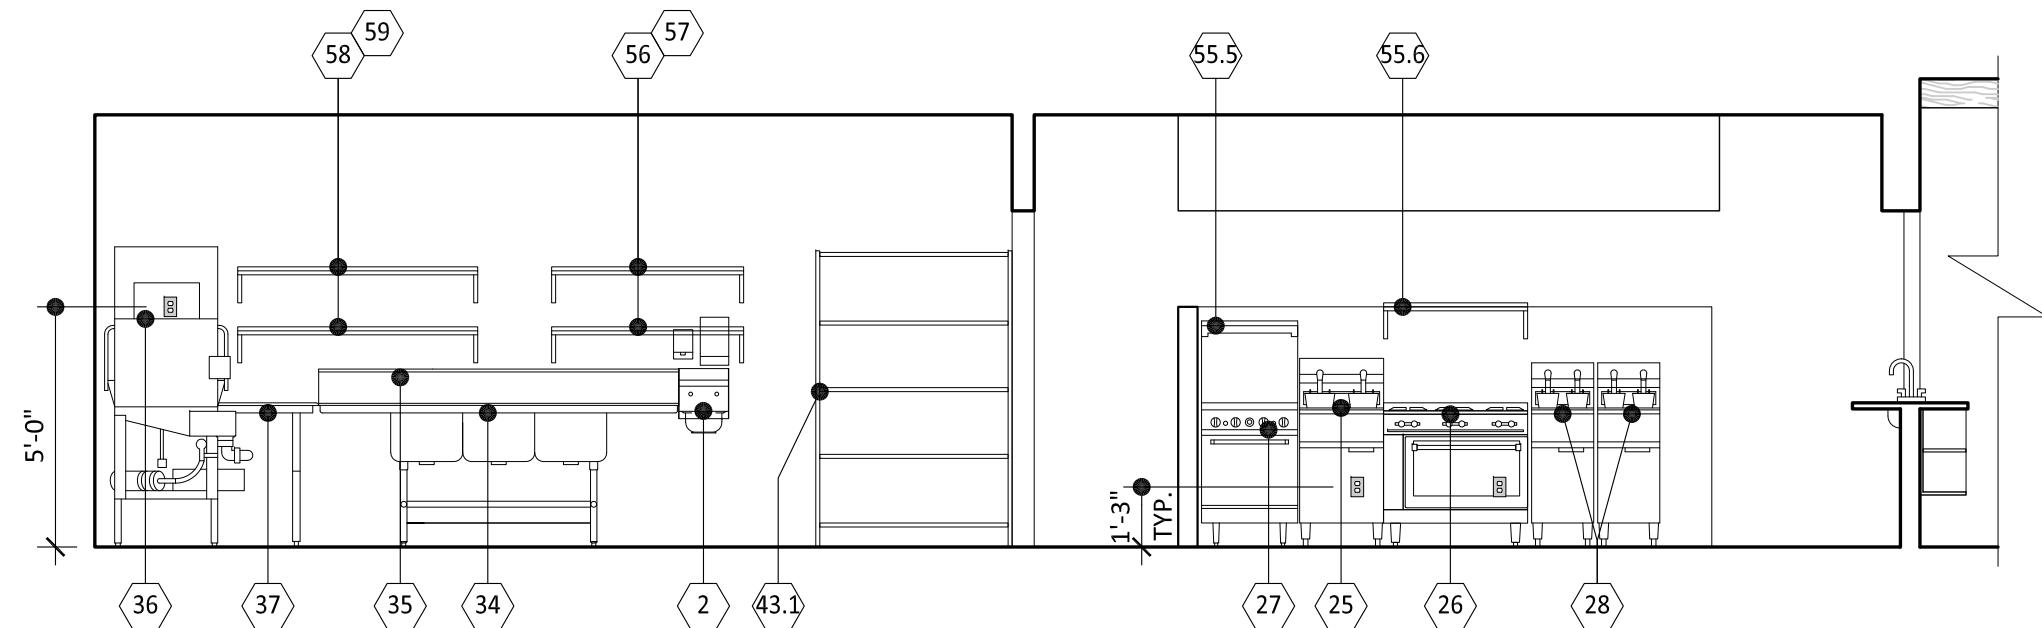

4 ELEVATION

1/4" = 1'-0"

KEYNOTES

- 1 CEILING LINE.
- 2 DOOR PER DOOR SCHEDULE.
- 3 WINDOW PER WINDOW SCHEDULE.
- 4 EXISTING COLUMN.
- 5 WALL PARTITION PER PLANS.
- 6 DROPPED SOFFIT PER PLAN.
- 7 ADA ACCESSIBLE COUNTER PER PLANS.
- 8 COUNTER TOP/ CAP PER PLANS.
- 8.1 COUNTERTOP BACK SPLASH PER CORRESPONDING DETAIL.
- 9 LIGHT FIXTURE SEE RCP PLAN.
- 10 EQUIPMENT PER PLAN AND SCHED.
- 11 NOT USED.
- 12 CUSTOM BUILT-IN STORAGE CABINET W/ ADJUSTABLE SHELVES.
- 12.1 CUSTOM BUILT-IN OPEN SHELVING W/ ADJUSTABLE SHELVES.
- 13 CASH DRAWER OPENING BUILT-IN STORAGE CABINET.
- 14 CUSTOM TRASH STORAGE BUILT-IN PER CORRESPONDING DETAIL.
- 15 DECORATIVE HANGING BELL PER OTHER.
- 16 DECORATIVE WOOD BEAM PER PLAN.
- 17 FIXED TABLE PER PLANS. BOLT TO THE FLOOR/ BASE TO BE PROVIDED BY G.C./ TOP TO BE PROVIDED BY SEPARATE VENDOR. SEE FURNITURE PLAN FOR DETAILS.
- 18 DECORATIVE GREEN ARTWORK PER OTHER.
- 19 CUSTOM BUILT-IN UPHOLSTERED BOOTH PER PLANS.
- 20 WOOD SLATS PER PLAN.
- 21 NOT USED.
- 22 PLANTER PER OWNER. SEE FURNITURE PLAN FOR DETAILS.
- 23 ARTWORK PER OWNER. PRIOR TO STARTING ARTWORK, OWNER/GC NEED TO CONTACT JINYA CORPORATE OFFICE & IKEDO DESIGN.
- 24 TV PER OWNER. PROVIDE STRUCTURAL SUPPORT & ELECTRICAL AS NEEDED. MOUNTING HEIGHTS PER PLANS.
- 25 BACK BAR SHELVING PER PLANS. PROVIDE STRUCTURAL SUPPORT AND ELECTRICAL FOR LED TAP LIGHTING AS NEEDED.
- 26 NOT USED.
- 27 NOT USED.
- 28 HANDRAIL PER PLAN.
- 29 STAIRS PER PLAN.
- 30 NOT USED

PROJECT NOTES

1. NOTIFY IKEDO DESIGN OF ANY DISCREPANCIES WITH PLANS. CALL TO OBTAIN CLARIFICATION PRIOR TO CONSTRUCTION/ INSTALLATION/ ORDERING.
2. CALL IKEDO DESIGN IF DESIGN INTENT IS NOT CLEAR. AT NO TIME IS THE CONTRACTOR TO ASSUME OR GUESS IKEDO DESIGN'S DESIGN INTENT.
3. GENERAL CONTRACTOR IS TO INFORM IKEDO DESIGN IMMEDIATELY IF THERE ARE ANY DIMENSIONAL DISCREPANCIES BETWEEN THE PLANS AND FIELD CONDITIONS.
4. ALL SIGNAGE SHOP DRAWINGS MUST BE SUBMITTED TO IKEDO DESIGN OR JINYA CORPORATE FOR REVIEW APPROVAL.
5. PAINT ALL DIFFUSERS/ GRILL, SECURITY CAMERAS, SPEAKERS BLACK. OWNER SHALL CONTACT JINYA CORPORATE BEFORE INSTALLATION.



990 Highland Drive
Suite 110A
Solana Beach, CA 92075
p: 858.436.7967

ROBATA JINYA
RESTAURANT
6529 W. HOLLYWOOD BLVD.
LOS ANGELES, CA 90028


REVISION:	OWNER	3
8.13.21		
REVISION:		
REVISION:		
REVISION:	JINYA	4
11.08.21		
REVISION:	HEALTH	5
12.29.21		
REVISION:	OWNER	6
1.26.23		
REVISION:	OWNER	7
11.30.23		

BID SET:
HEALTH SUBMITTAL:
CITY SUBMITTAL:
TENANT APPROVAL:
SCALE: 1/4" = 1'-0"
PROJECT NO: RJ0420
DRAWN: MK & SI
DATE: 01/14/22

KITCHEN ELEVATIONS


THIS PERMIT APPLICATION SET OF DRAWINGS ARE INTENDED FOR BUILDING DEPARTMENT REVIEW ONLY. REVISIONS DUE TO PLAN CHECK AND IKEDO DESIGN REVIEW/COORDINATION MAY BE REQUIRED.

SHEET NO: A7.4

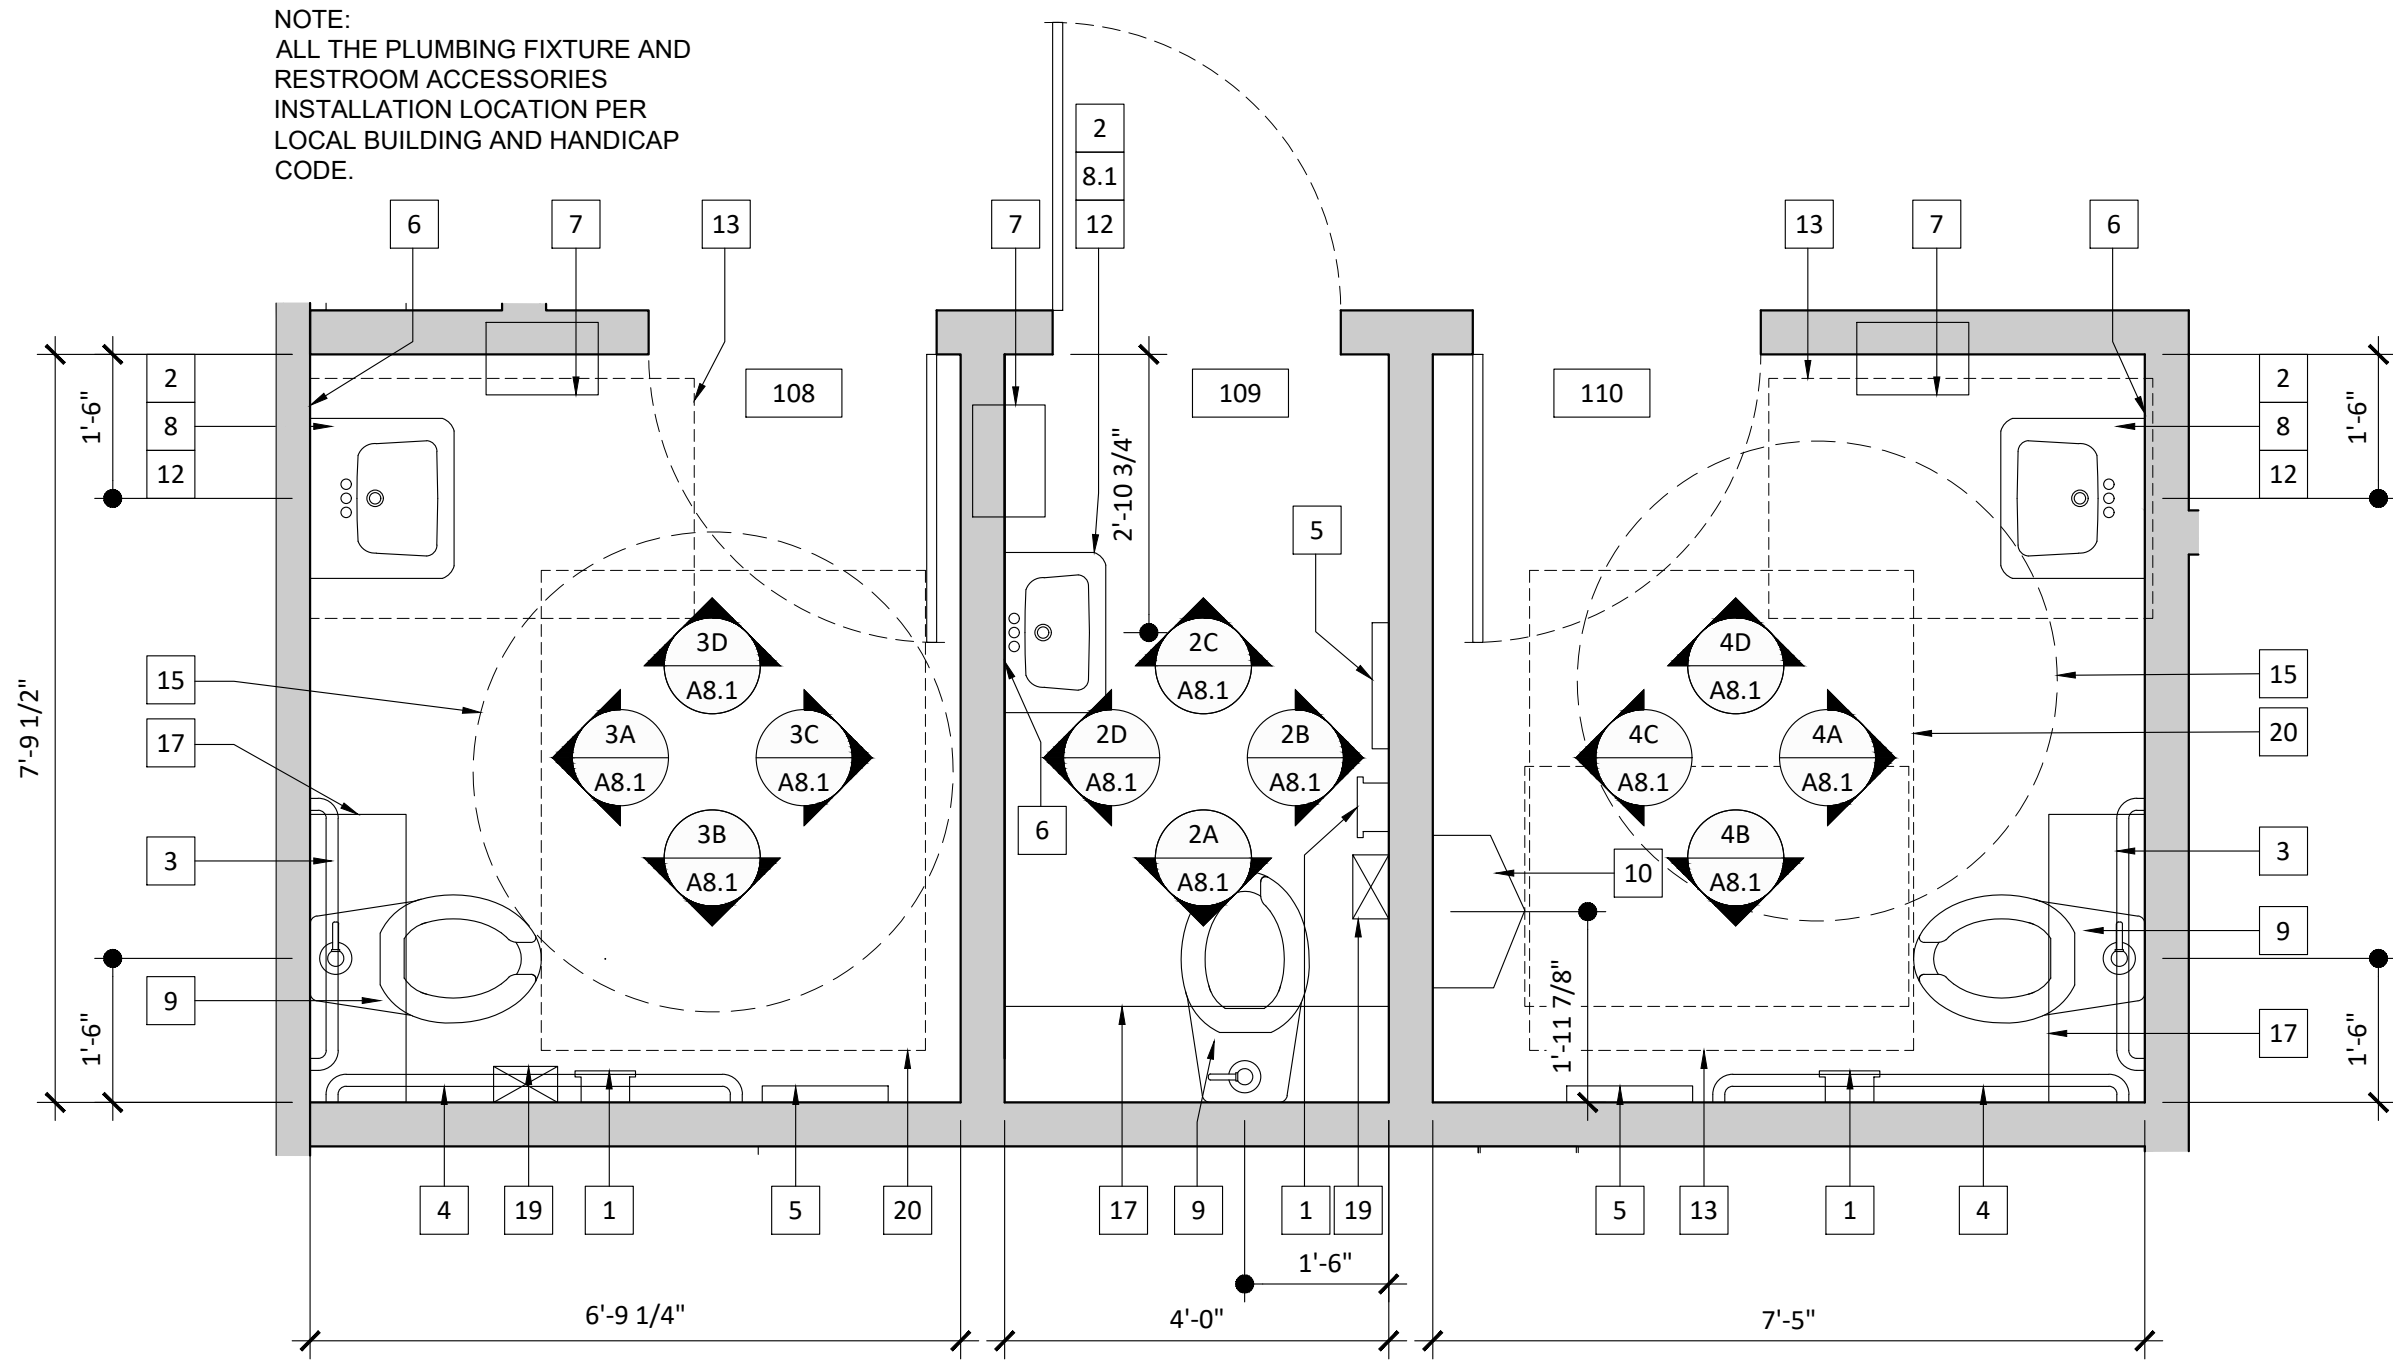

1 ENLARGED RESTROOM PLAN

SEE 2, 3, 4 / A8.0 FOR TYPICAL TOILET REQUIREMENTS

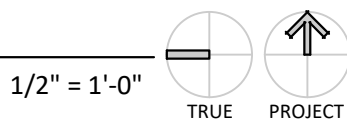

KEYNOTES

- TOILET TISSUE DISPENSER - SURFACE MOUNTED -
CONTURA SERIES, MODEL: B-4288, BY BOBRICK
- LIQUID SOAP DISPENSER - DECK MOUNTED -
FINISH: VIBRANT STAINLESS, MODEL: K-1995-VS, BY KOHLER.
- GRAB BAR - 1 1/2" DIAMETER MIN., 36" LONG MIN. -
FINISH: SATIN STAINLESS STEEL, MODEL: B-6806, BY BOBRICK
- GRAB BAR - (SAME AS #3) 42" LONG MIN.
- SEAT-COVER DISPENSER - SURFACE MOUNTED -
CONTURA SERIES, MODEL: B-4221, BY BOBRICK.
(ALL DISPENSERS 40" MAX TO HIGHEST OPERABLE PART).
- MIRROR - SURFACE MOUNTED - FULL WIDTH & HEIGHT AS INDICATED
PER PLANS, 38" A.F.F.
- RECESSED PAPER TOWEL DISPENSER AND WASTE RECEPTACLE - CONTURA
SERIES, MODEL: B-43944, SATIN-FINISH STAINLESS STEEL, BY BOBRICK.
- WALL-MOUNTED LAVATORY - SOHO SERIES, FINISH: WHITE, MODEL:
K-2084-NR, BY KOHLER
- WALL-MOUNTED LAVATORY - FINISH: WHITE, MODEL: SPEC TO FOLLOW, BY
KOHLER
- FLOOR MOUNTED WATER CLOSET PER PLUMBING PLANS.
- WALL MOUNTED URINAL PER PLUMBING PLANS.
- NOT USED.
- FAUCET - SENSOR ACTIVATED COUNTER-MOUNTED W/ FAUCET EXTENSION KIT -
FINISH: CHROME, LINO SERIES, MODEL: EAF-250-P & EAF-35-A (EXTENSION KIT),
BY SLOAN
- 30" X 48" CLEAR SPACE.
- NOT USED.
- 60" DIAMETER CLEAR SPACE.
- LIGHTING FIXTURE PER RCP.
- BUILT-IN UPPER STORAGE PER PLANS.
- NOT USED.
- SANITARY NAPKIN DISPOSAL - SURFACE MOUNTED - CONTURA SERIES. FINISH:
SATIN-STAINLESS STEEL, MODEL: B-35139 BY BOBRICK
- 48" x 60" CLEAR MANEUVERING SPACE



990 Highland Drive
Suite 110A
Solana Beach, CA 92075
p: 858.436.7967

ROBATA JINYA
RESTRAUNT
6529 W. HOLLYWOOD BLVD.
LOS ANGELES, CA 90028

REVISION:	OWNER	1
8.13.21		
REVISION:		
REVISION:	JINYA	4
11.08.21		
REVISION:	HEALTH	5
12.29.21		
REVISION:	OWNER	6
1.26.23		
REVISION:	OWNER	7
11.30.23		
REVISION:		
BID SET:		
HEALTH SUBMITTAL:		
CITY SUBMITTAL:		
TENANT APPROVAL:		
SCALE:	1/2" = 1'-0"	
PROJECT NO:	RJ0420	
DRAWN:	MK & SJ	
DATE:	01/14/22	

ENLARGED RESTROOM PLAN

THIS PERMIT APPLICATION SET OF DRAWINGS ARE
INTENDED FOR BUILDING DEPARTMENT REVIEW ONLY.
REVISING DUE TO PLAN CHECK AND IKEDO DESIGN
REVIEW/COORDINATION MAY BE REQUIRED.


SHEET NO:

A8.0


NOT FOR CONSTRUCTION UNTIL PERMITTED

PROJECT NOTES


- NOTIFY IKEDO DESIGN OF ANY DISCREPANCIES WITH PLANS. CALL TO OBTAIN
CLARIFICATION PRIOR TO CONSTRUCTION/ INSTALLATION/ ORDERING.
- CALL IKEDO DESIGN IF DESIGN INTENT IS NOT CLEAR. AT NO TIME IS THE CONTRACTOR
TO ASSUME OR GUESS IKEDO DESIGN'S DESIGN INTENT.
- GENERAL CONTRACTOR IS TO INFORM IKEDO DESIGN IMMEDIATELY IF THERE ARE ANY
DIMENSIONAL DISCREPANCIES BETWEEN THE PLANS AND FIELD CONDITIONS.
- ALL SIGNAGE SHOP DRAWINGS MUST BE SUBMITTED TO IKEDO DESIGN OR JINYA
CORPORATE FOR REVIEW APPROVAL.
- PAIN

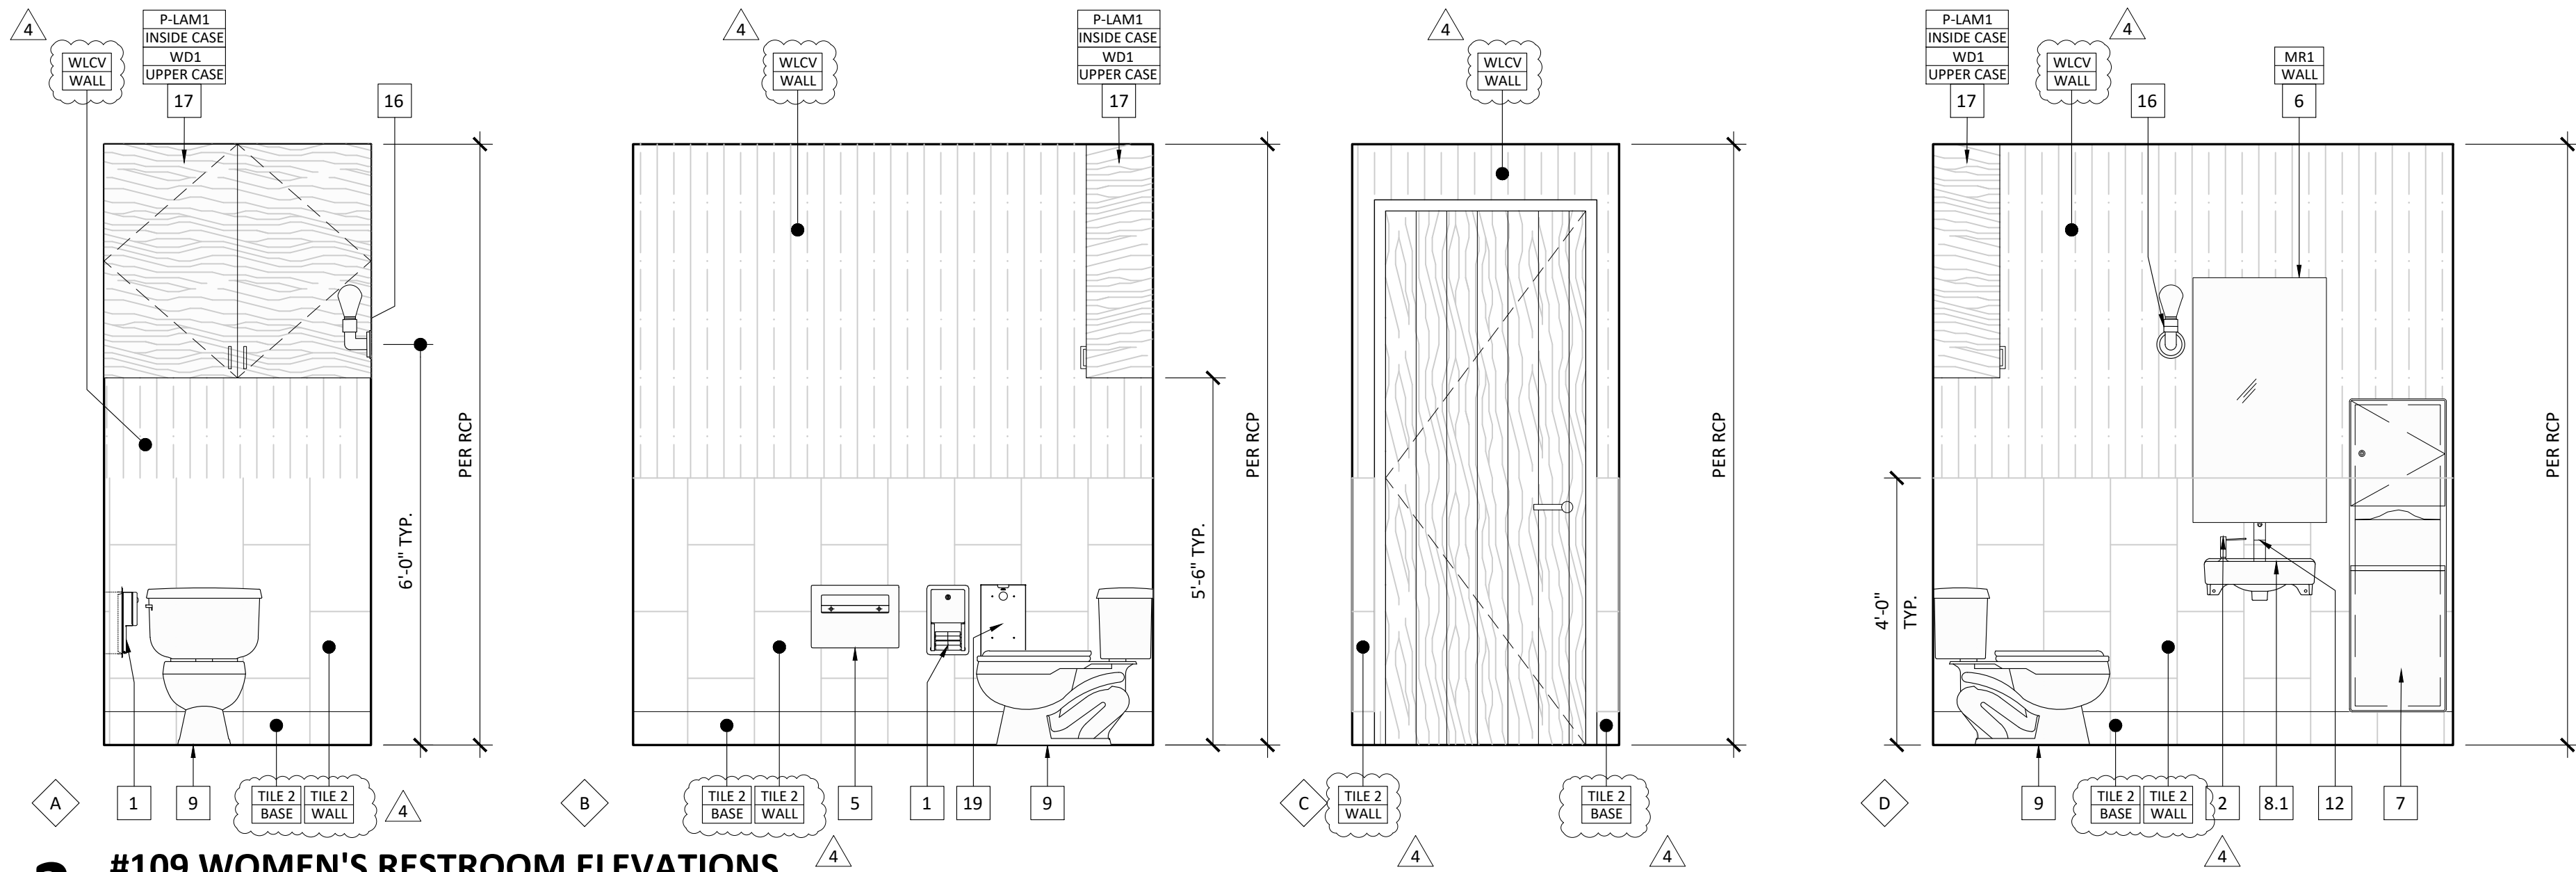

2 #109 WOMEN'S RESTROOM ELEVATIONS

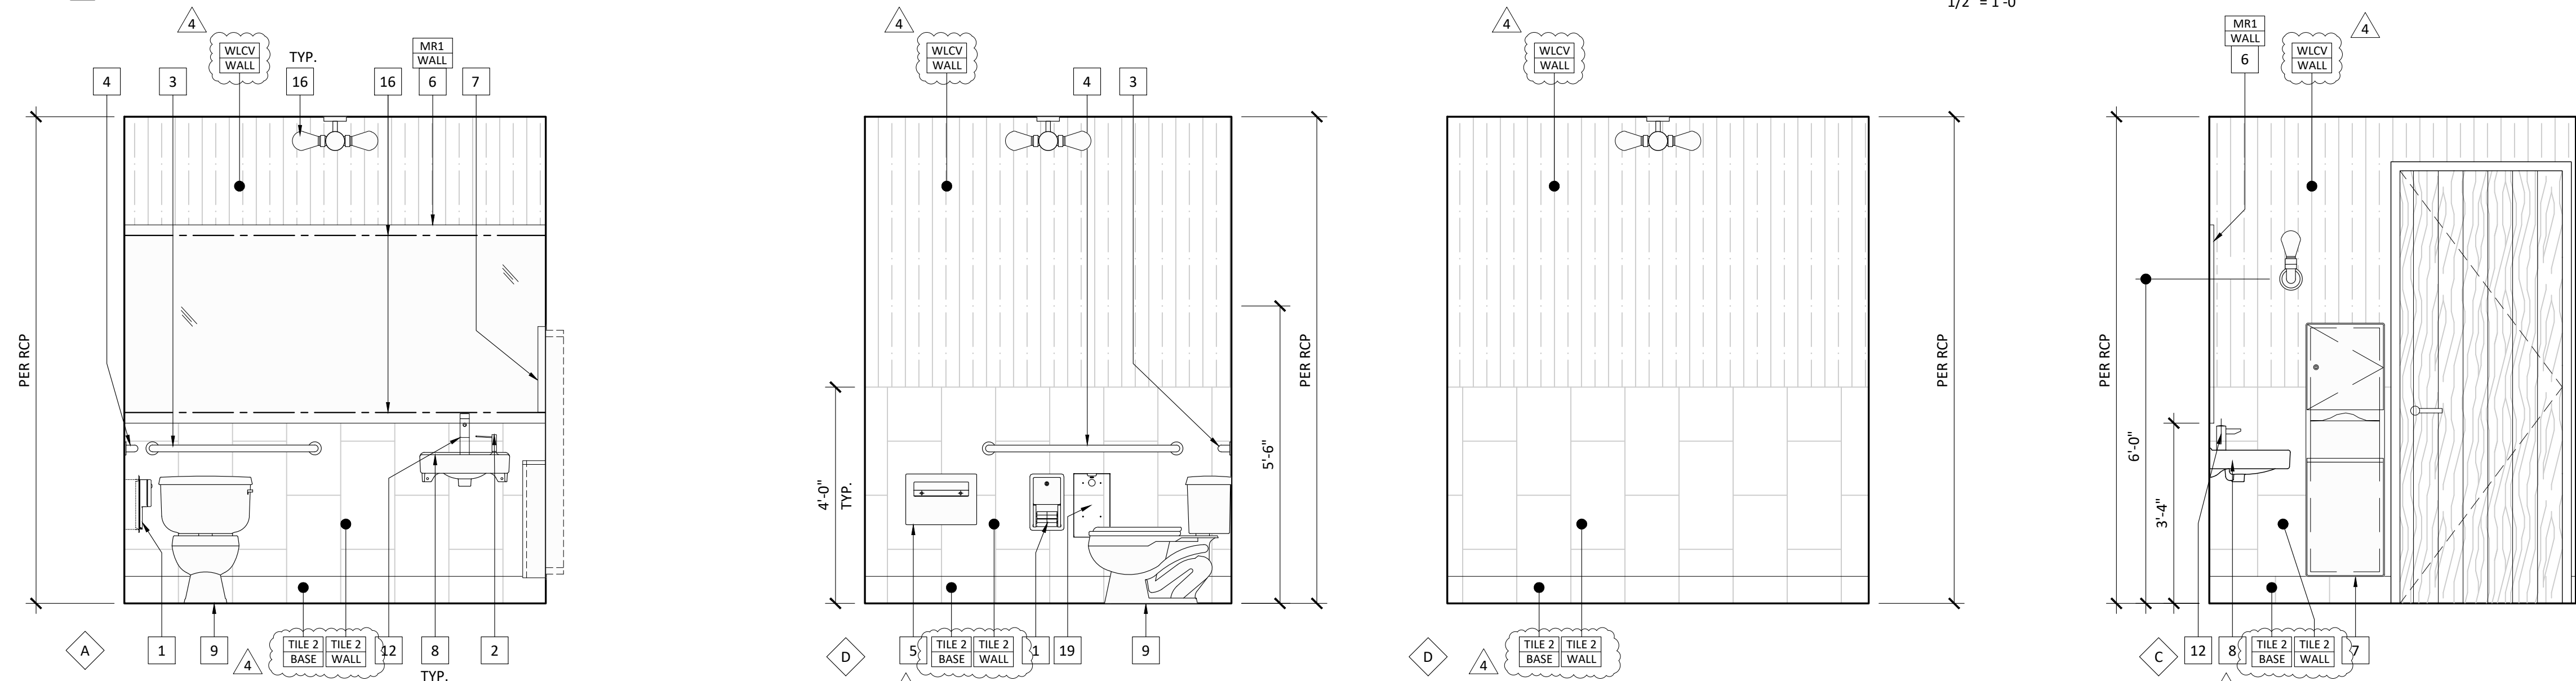

3 #108 WOMEN'S RESTROOM ELEVATIONS

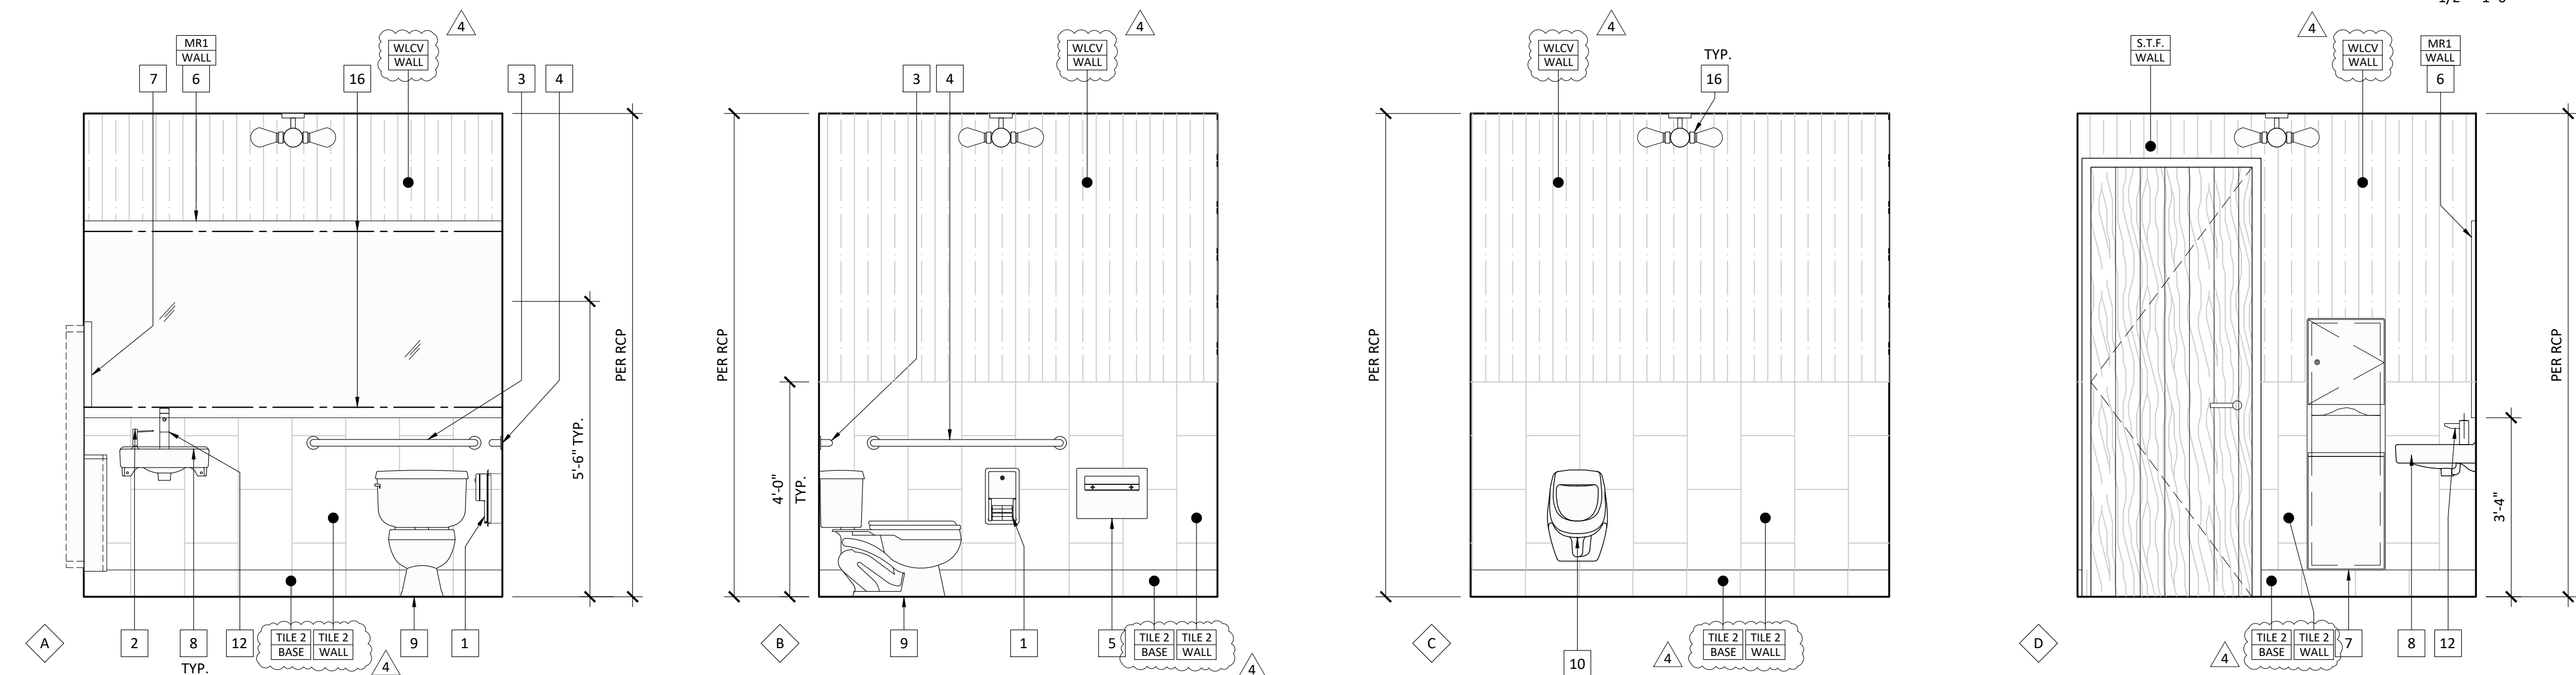

4 #110 MEN'S RESTROOM ELEVATIONS

KEYNOTES

- TOILET TISSUE DISPENSER - SURFACE MOUNTED - CONTURA SERIES, MODEL: B-4288, BY BOBRICK
- LIQUID SOAP DISPENSER - DECK MOUNTED - FINISH: VIBRANT STAINLESS, MODEL: K-1995-VS, BY KOHLER.
- GRAB BAR - 1 1/2" DIAMETER MIN., 36" LONG MIN. - FINISH: SATIN STAINLESS STEEL, MODEL: B-6806, BY BOBRICK
- GRAB BAR - (SAME AS #3) 42" LONG MIN.
- SEAT-COVER DISPENSER - SURFACE MOUNTED - CONTURA SERIES, MODEL: B-4221, BY BOBRICK. (ALL DISPENSERS 40" MAX TO HIGHEST OPERABLE PART).
- MIRROR - SURFACE MOUNTED - FULL WIDTH & HEIGHT AS INDICATED PER PLANS, 38" A.F.F.
- RECESSED PAPER TOWEL DISPENSER AND WASTE RECEPTACLE - CONTURA SERIES, MODEL: B-43944, SATIN-FINISH STAINLESS STEEL, BY BOBRICK.
- WALL-MOUNTED LAVATORY - SOHO SERIES, FINISH: WHITE, MODEL: K-2084-NR, BY KOHLER
- WALL-MOUNTED LAVATORY - FINISH: WHITE, MODEL: SPEC TO FOLLOW, BY KOHLER
- FLOOR MOUNTED WATER CLOSET PER PLUMBING PLANS.
- WALL MOUNTED URINAL PER PLUMBING PLANS.
- NOT USED.
- FAUCET - SENSOR ACTIVATED COUNTER-MOUNTED W/ FAUCET EXTENSION KIT - FINISH: CHROME, LINO SERIES, MODEL: EAF-250-P & EAF-35-A (EXTENSION KIT), BY SLOAN
- 30" X 48" CLEAR SPACE.
- 56" X 60" CLEAR SPACE
- 60" DIAMETER CLEAR SPACE.
- LIGHTING FIXTURE PER RCP.
- BUILT-IN UPPER STORAGE PER PLANS.
- NOT USED.
- SANITARY NAPKIN DISPOSAL - SURFACE MOUNTED- CONTURA SERIES. FINISH: SATIN-STAINLESS STEEL, MODEL: B-35139 BY BOBRICK
- 48" x 60" CLEAR MANEUVERING SPACE

REVISION:	OWNER	8.13.21	1
REVISION:			
REVISION:			
REVISION:	JINYA	11.08.21	4
REVISION:	HEALTH	12.29.21	5
REVISION:	OWNER	1.26.23	6
REVISION:	OWNER	11.30.23	7
REVISION:			
BID SET:			
HEALTH SUBMITTAL:			
CITY SUBMITTAL:			
TENANT APPROVAL:			
SCALE:	1/2" = 1'-0"		
PROJECT NO:	RJ0420		
DRAWN:	MK & SI		
DATE:	01/14/22		

**ENLARGED
RESTROOM
PLAN**

THIS PERMIT APPLICATION SET OF DRAWINGS ARE
INTENDED FOR BUILDING DEPARTMENT REVIEW ONLY.
REVISING DUE TO PLAN CHECK AND IKEDO DESIGN
REVIEW/COORDINATION MAY BE REQUIRED.

SHEET NO:


A8.0

NOT FOR CONSTRUCTION UNTIL PERMITTED

7

CHAIR RAIL SECTION DETAIL


SCALE: 1"= 1'-0"

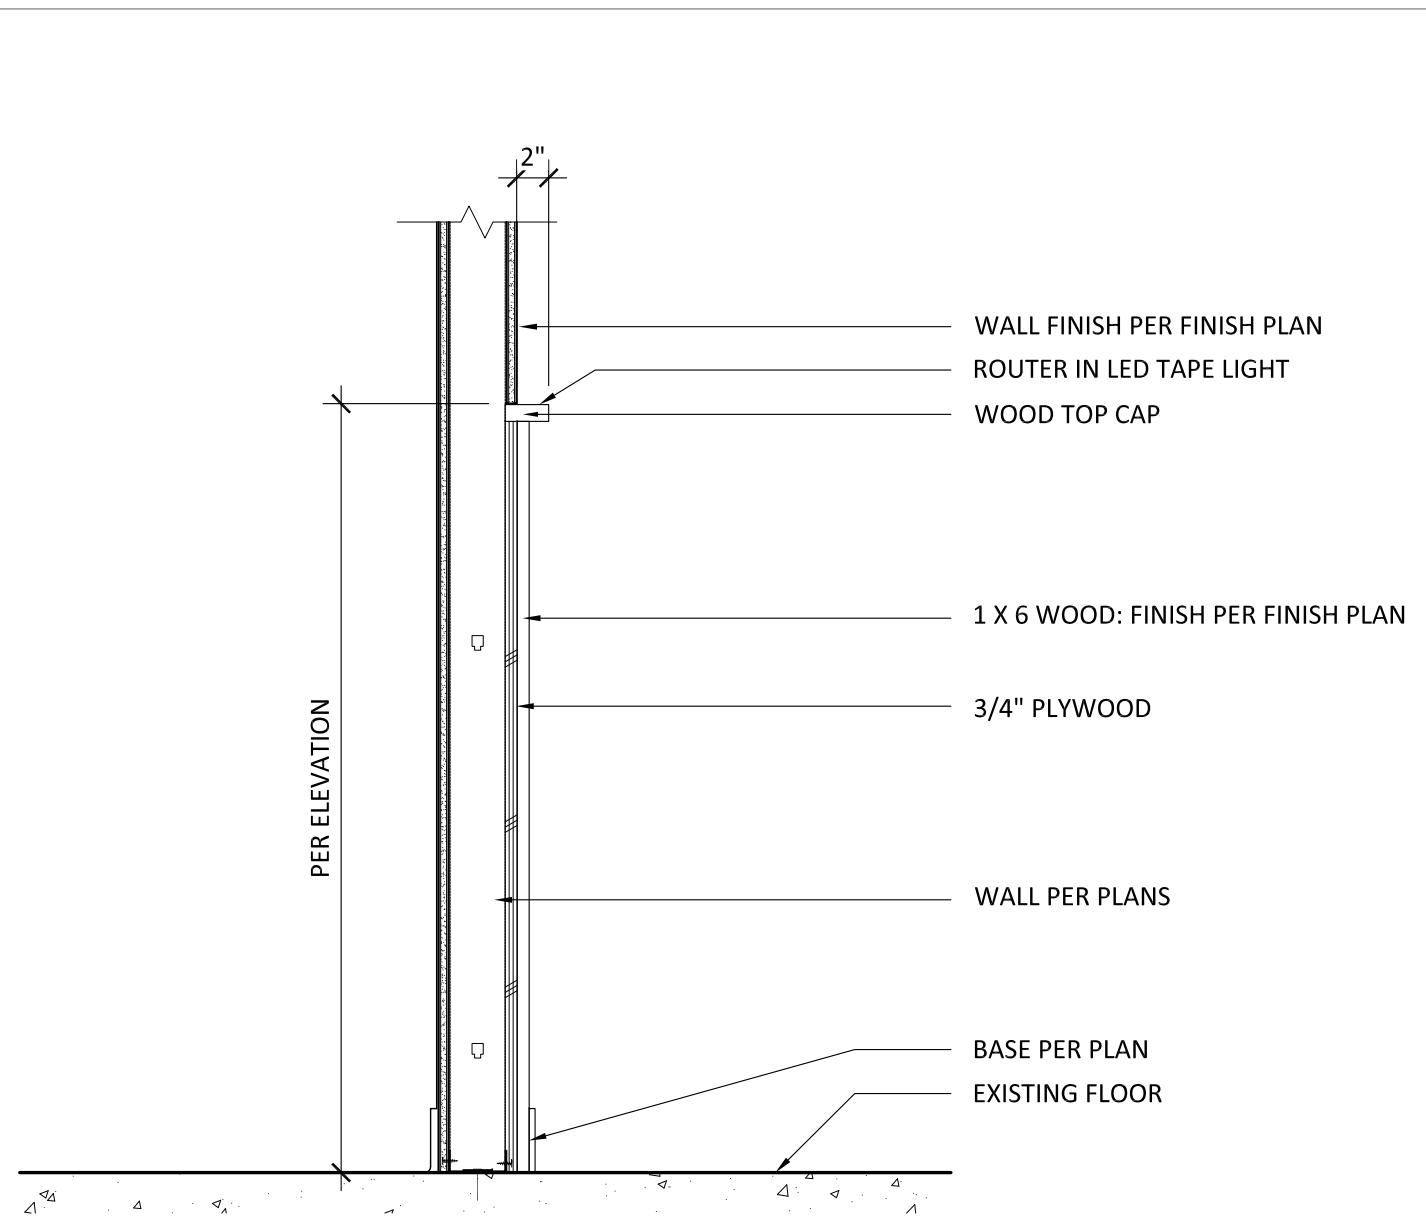

4

TYPICAL LOW WALL DETAIL


SCALE: 1-1/2\"/>

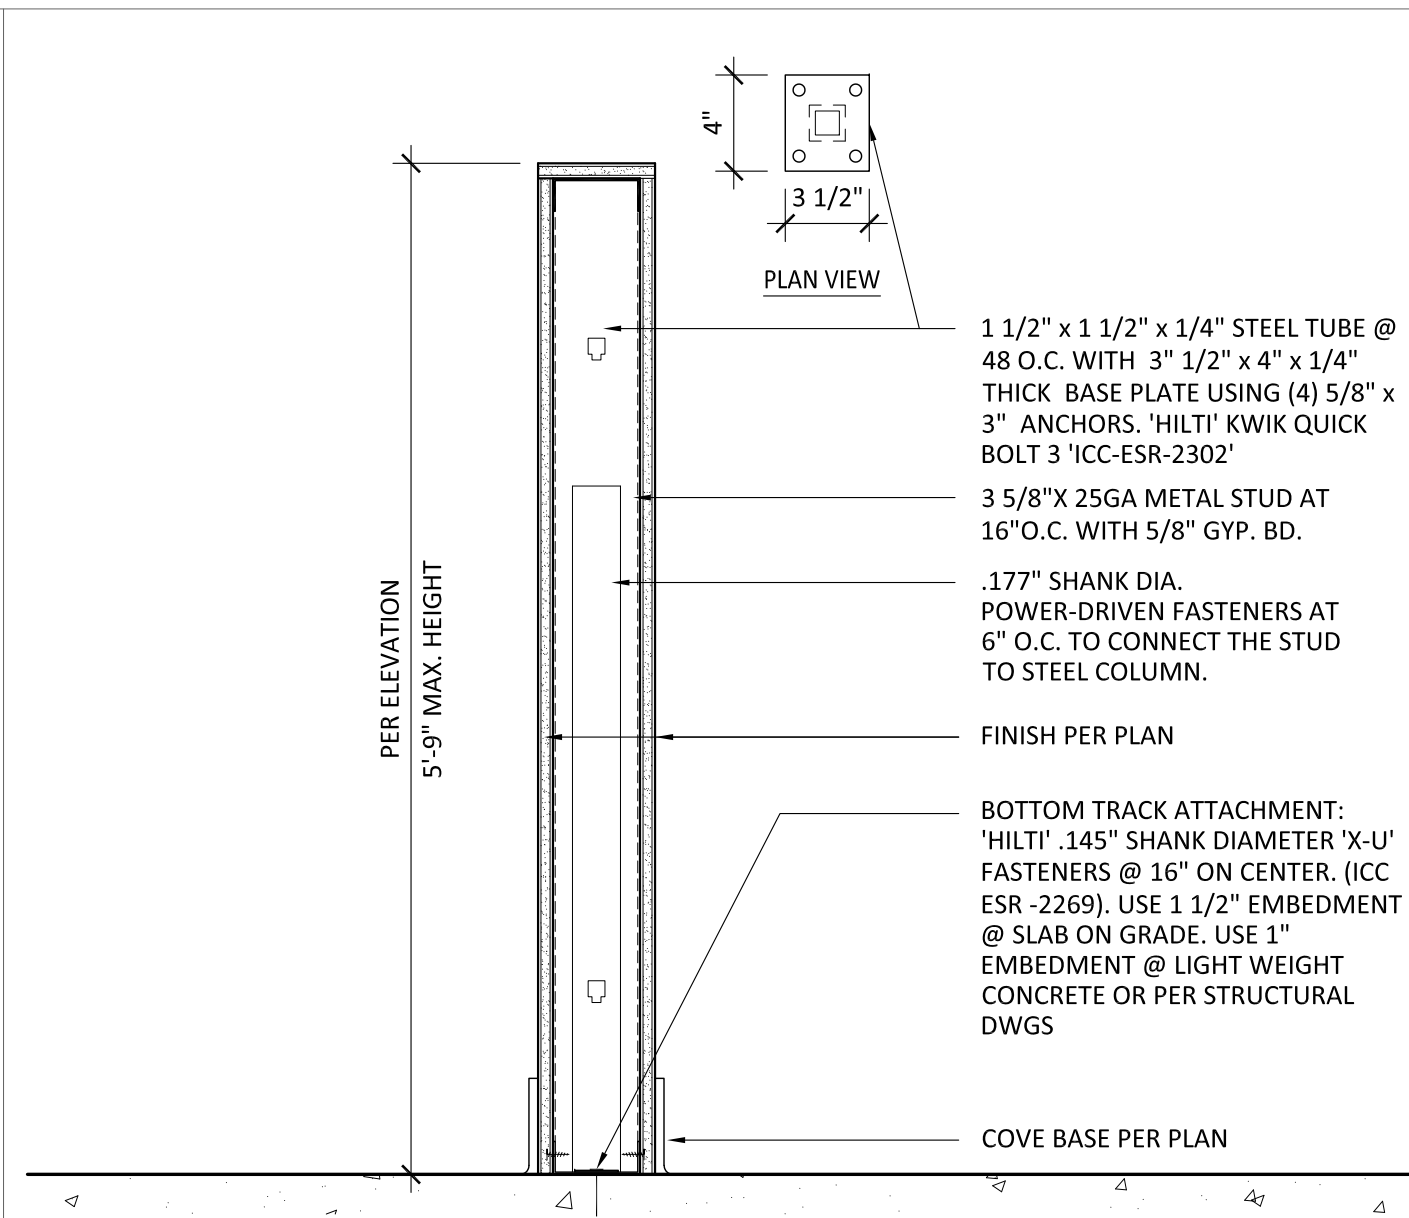

1

ADA BAR COUNTER W/ SCUPPER

SCALE: 1-1/2\"/>

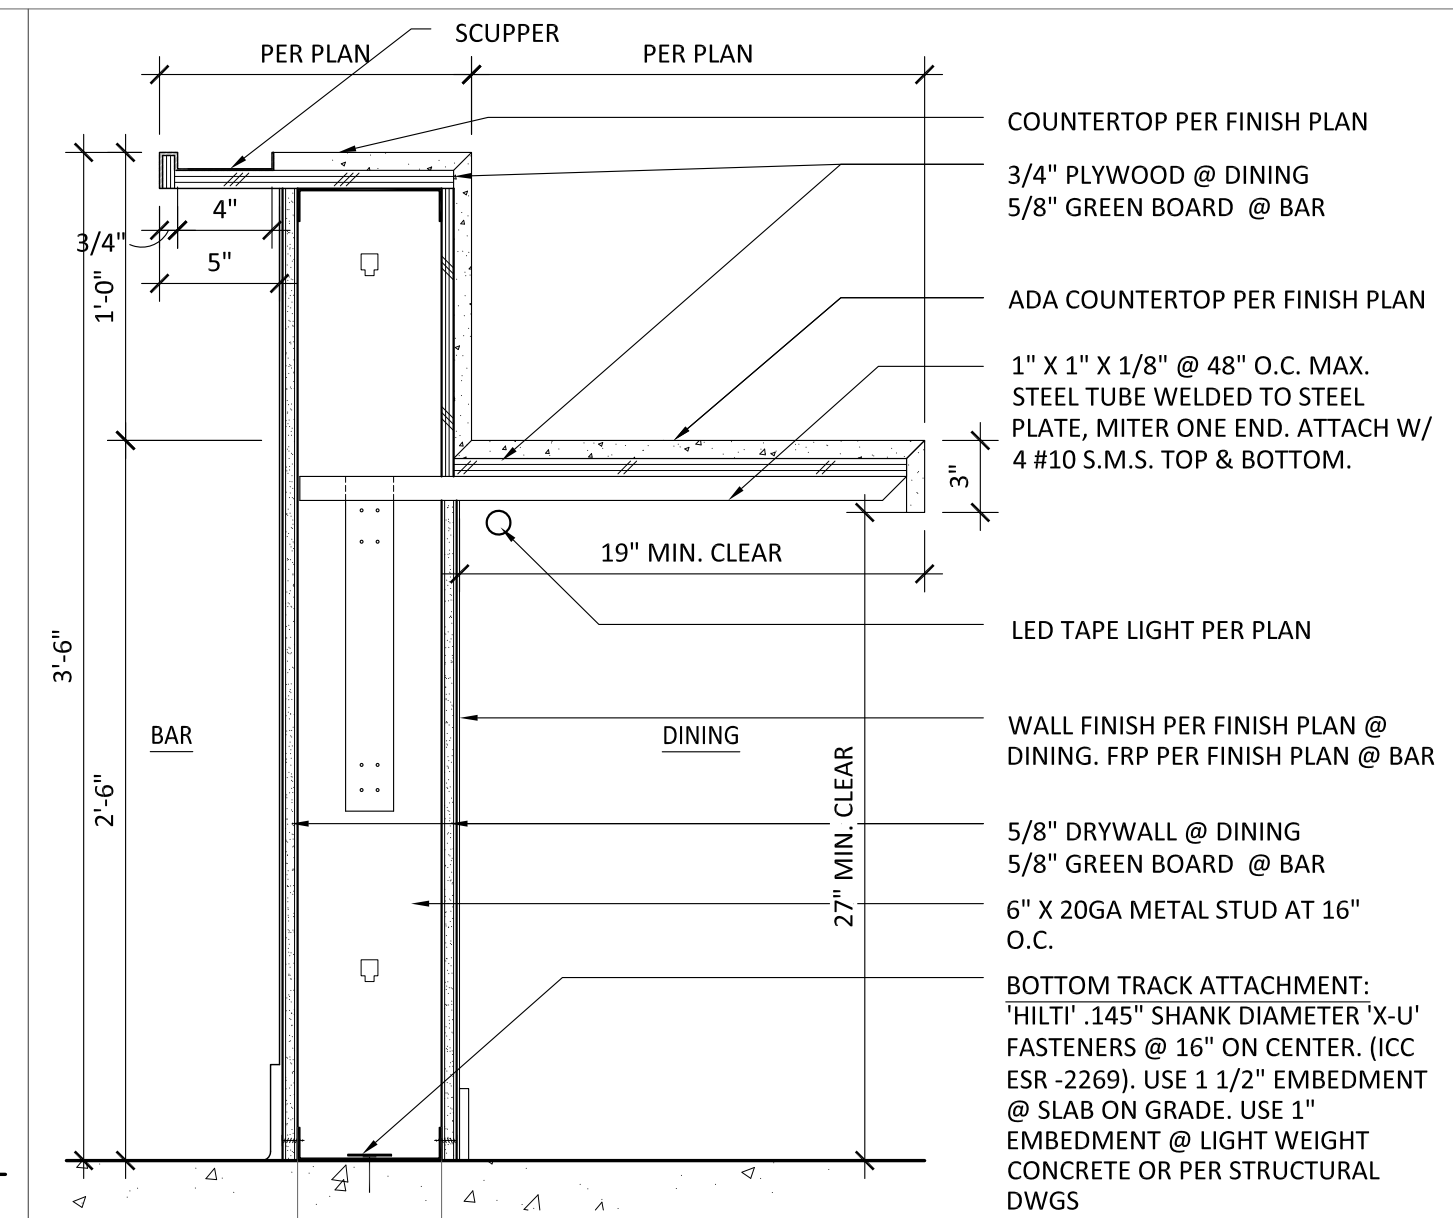


5

ROBATA BAR

1-1/2\"/>


SCALE:

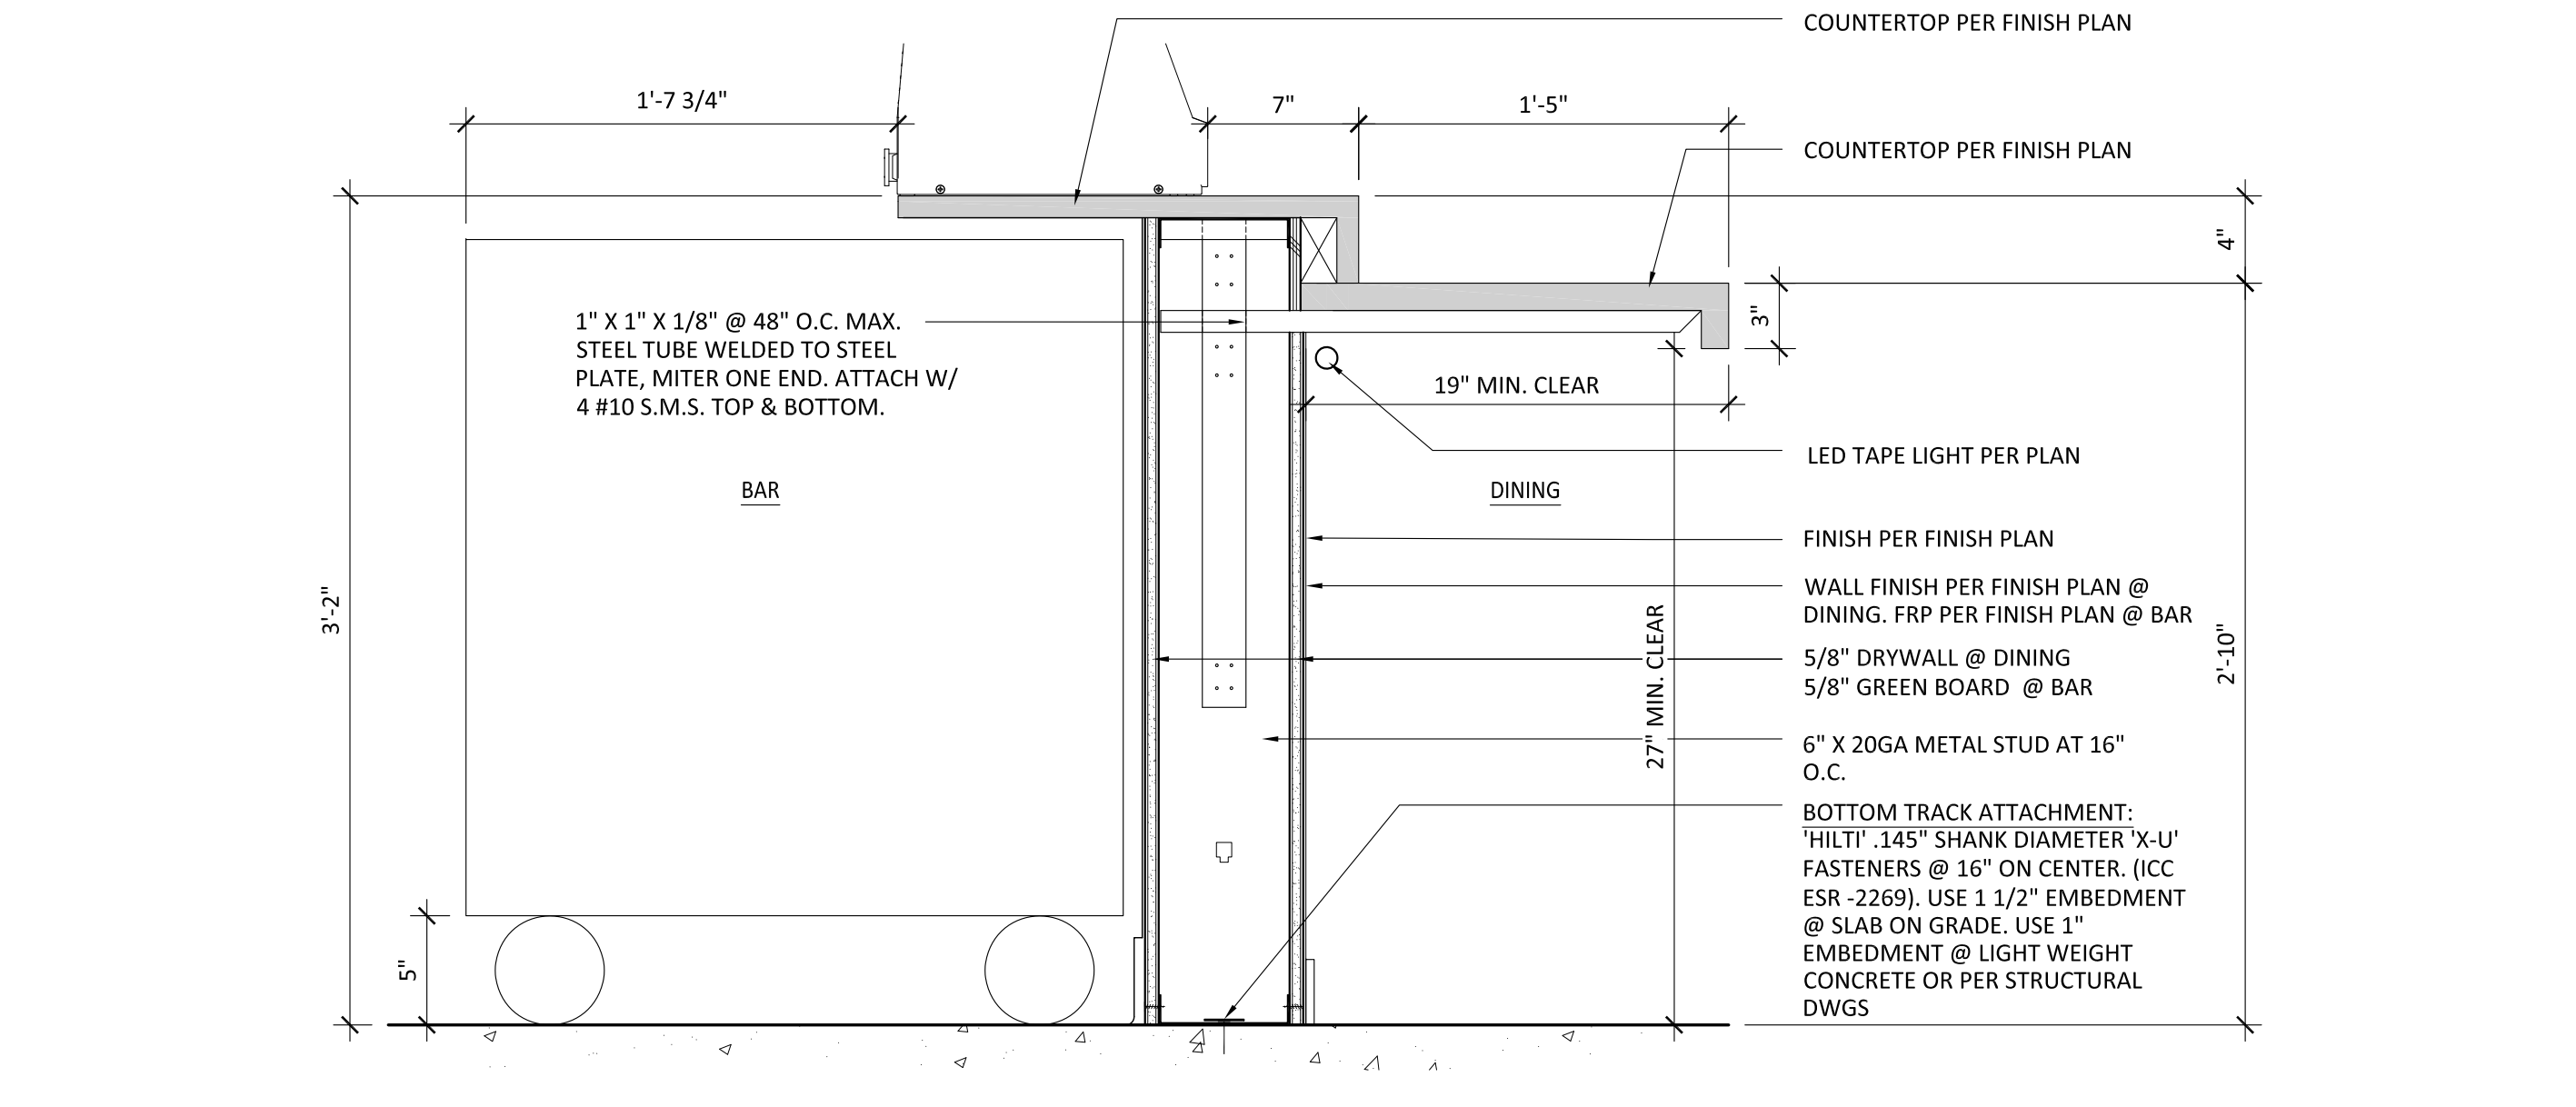

2

BAR COUNTER W/ SCUPPER


SCALE: 1-1/2\"/>

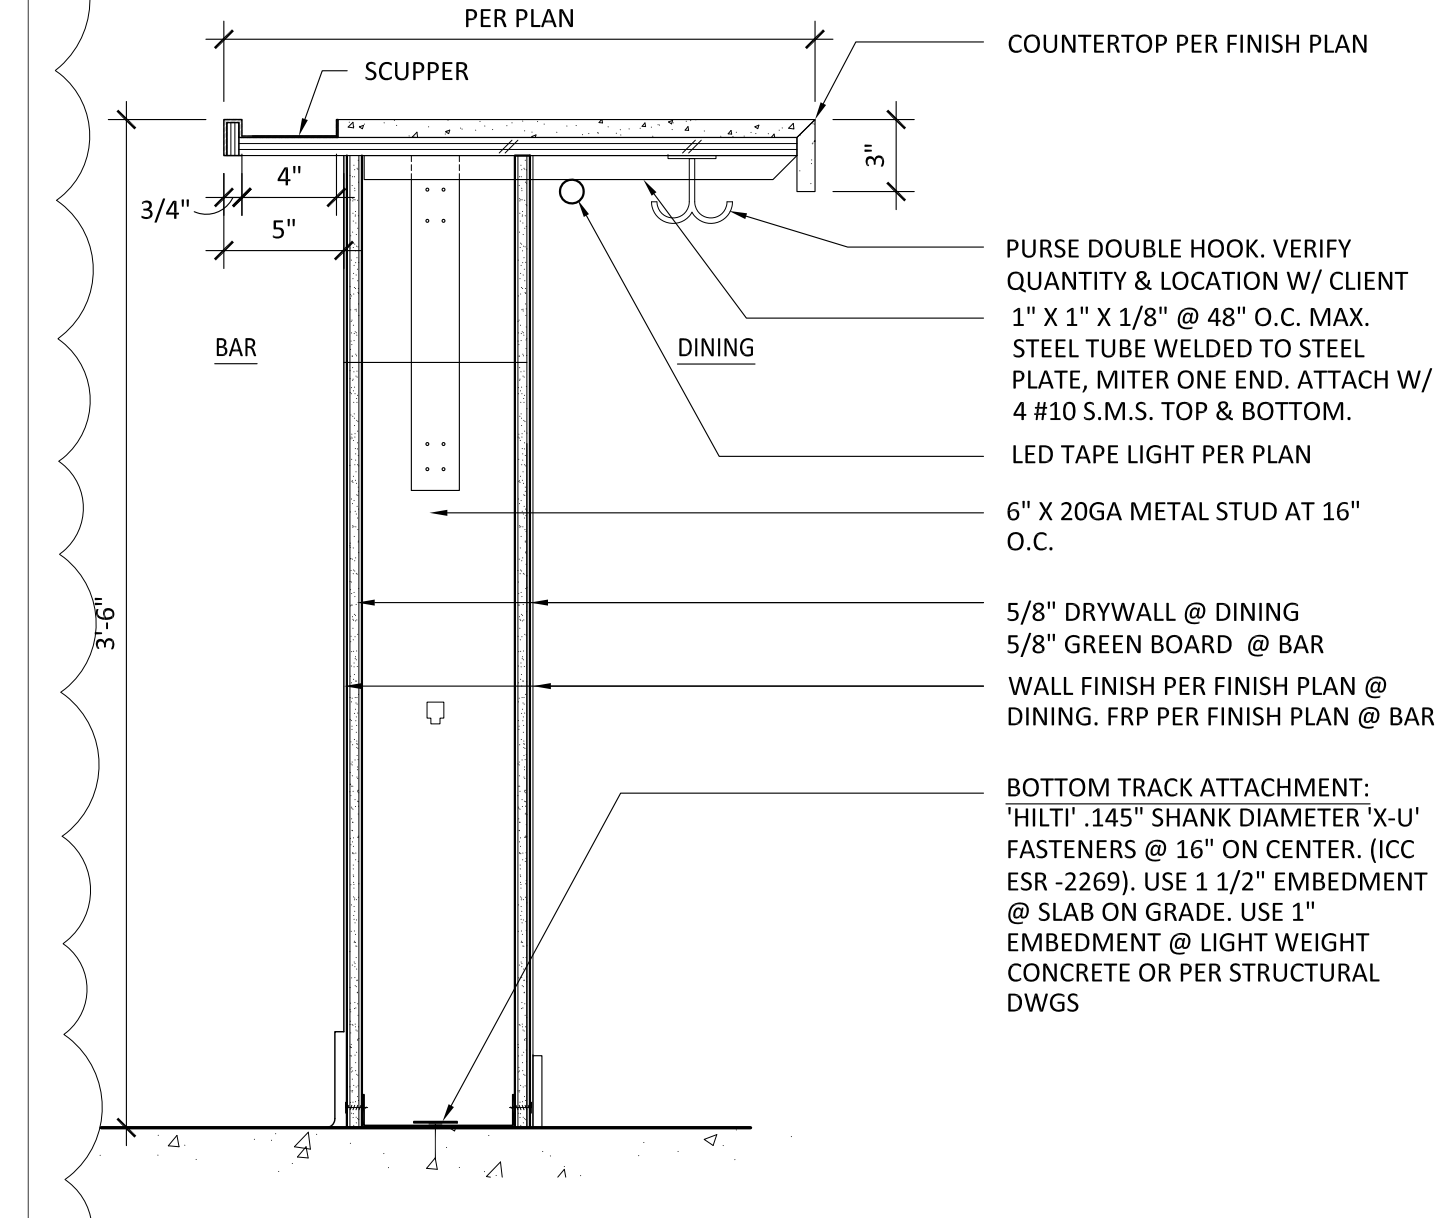

6

SERVER PICK UP COUNTER


SCALE: 1-1/2\"/>

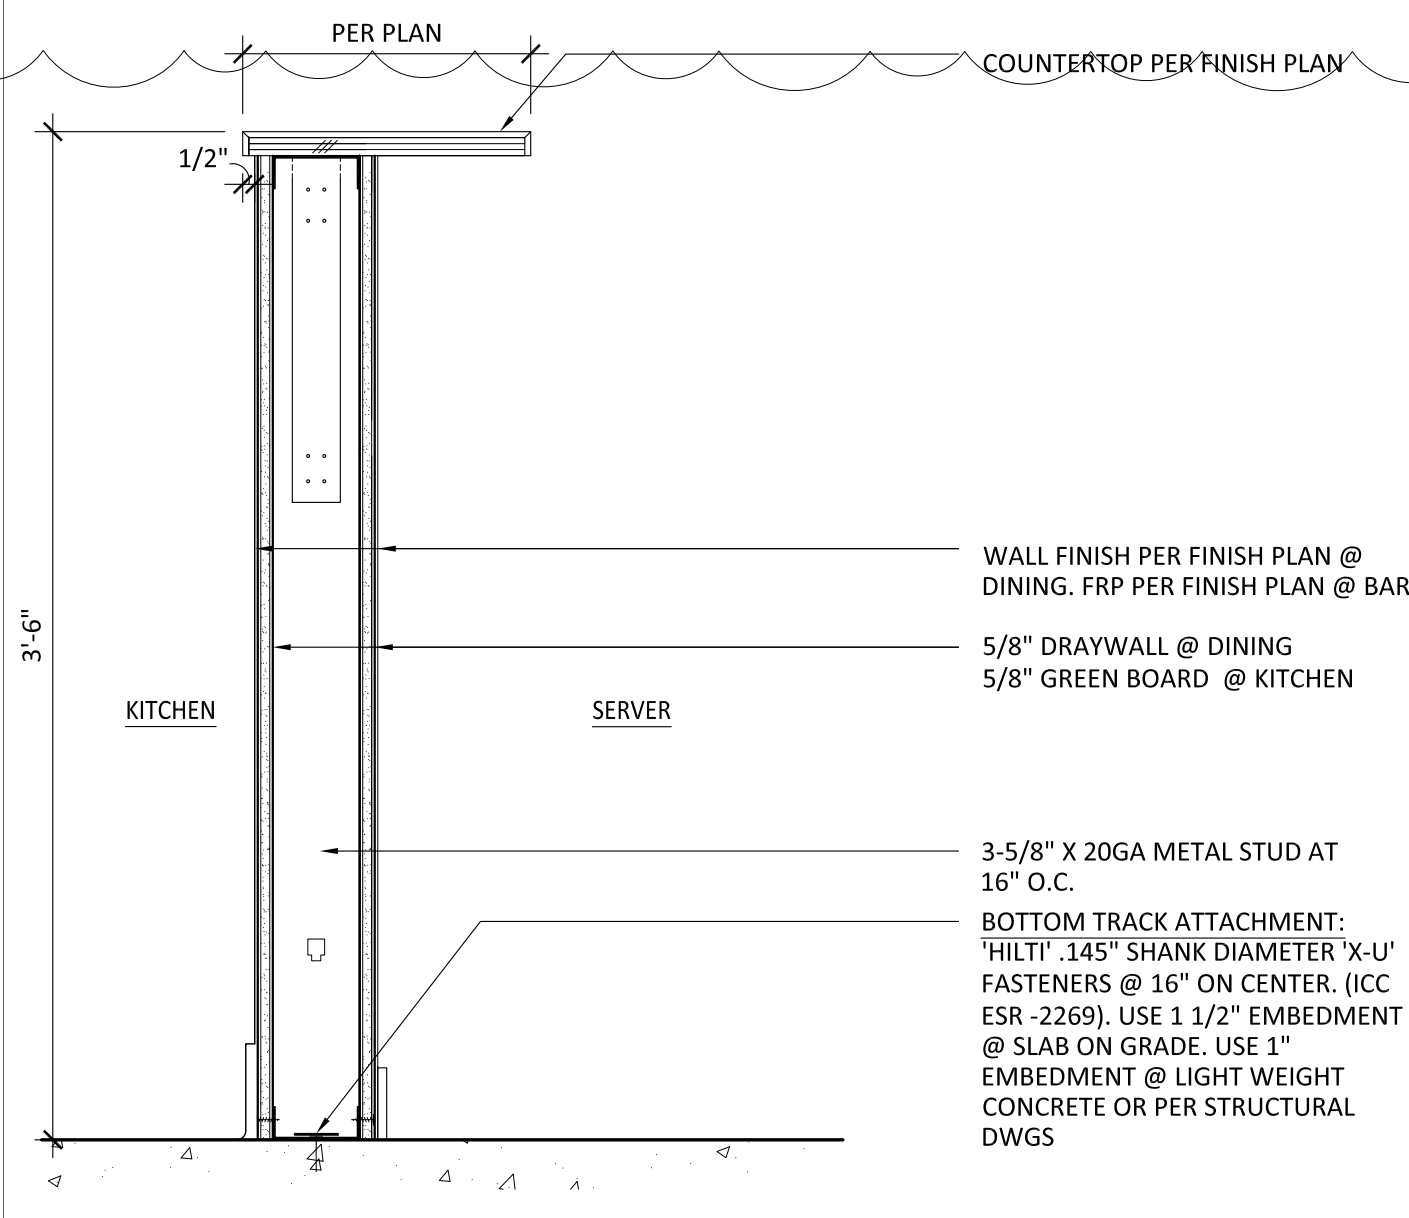

3

SERVER COUNTER @ BAR

SCALE: 1-1/2\"/>

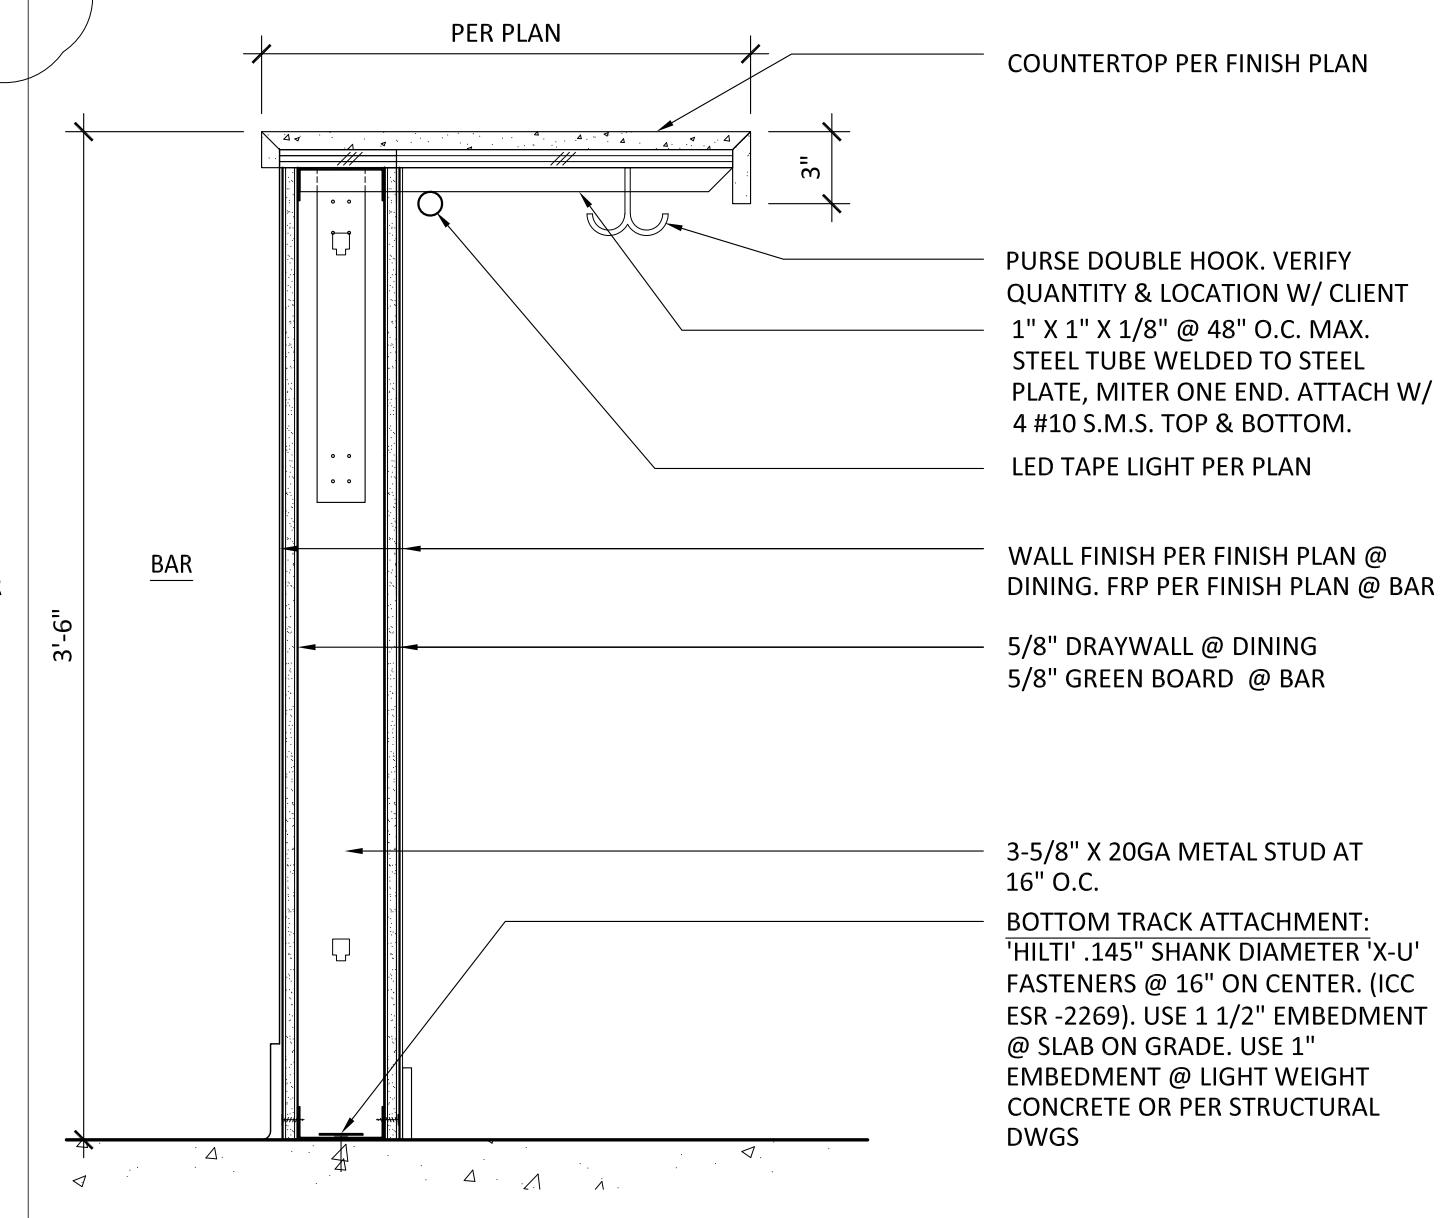

REVISION:	OWNER	8.13.21	1
REVISION:			
REVISION:	JINYA	11.08.21	4
REVISION:	HEALTH	12.29.21	5
REVISION:	OWNER	1.26.23	6
REVISION:	OWNER	11.30.23	7
REVISION:			
BID SET:			
HEALTH SUBMITTAL:			
CITY SUBMITTAL:			
TENANT APPROVAL:			
SCALE:			
PROJECT NO:	RJ0420		
DRAWN:	MK & SI		
DATE:	01/14/22		


**WALL
DETAILS**

THIS PERMIT APPLICATION SET OF DRAWINGS ARE
INTENDED FOR BUILDING DEPARTMENT REVIEW ONLY.
REVISIONS DUE TO PLAN CHECK AND KEDO DESIGN
REVIEW/COORDINATION MAY BE REQUIRED.


SHEET NO:

A11.0

NOT FOR CONSTRUCTION UNTIL PERMITTED

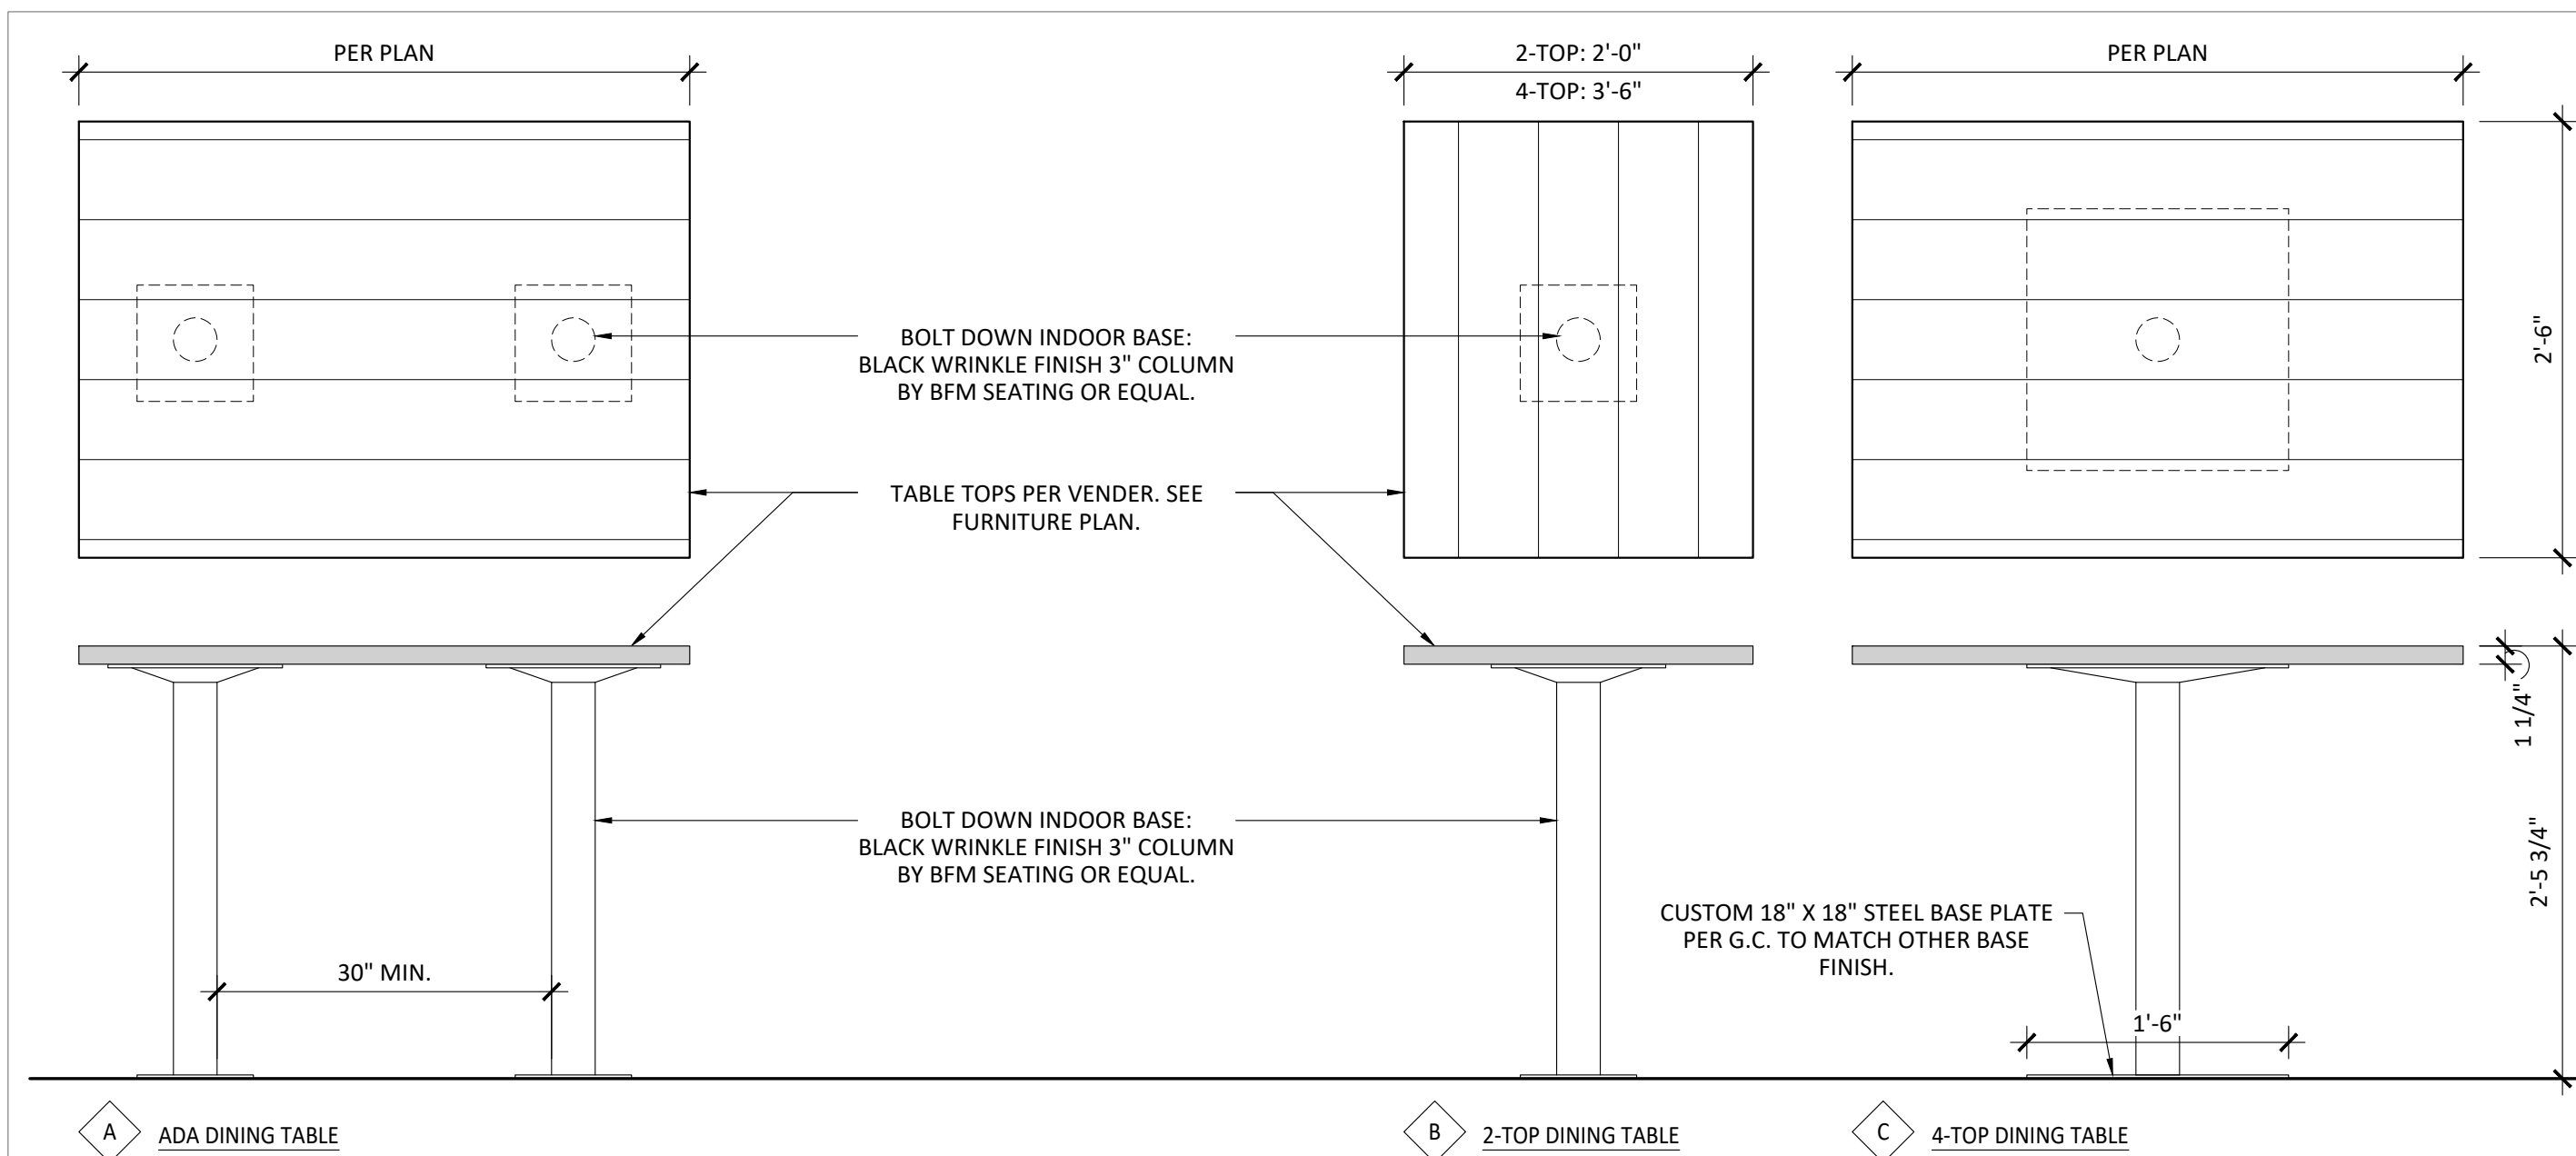


4 DINING TABLE DETAILS SCALE: 1" = 1'-0"

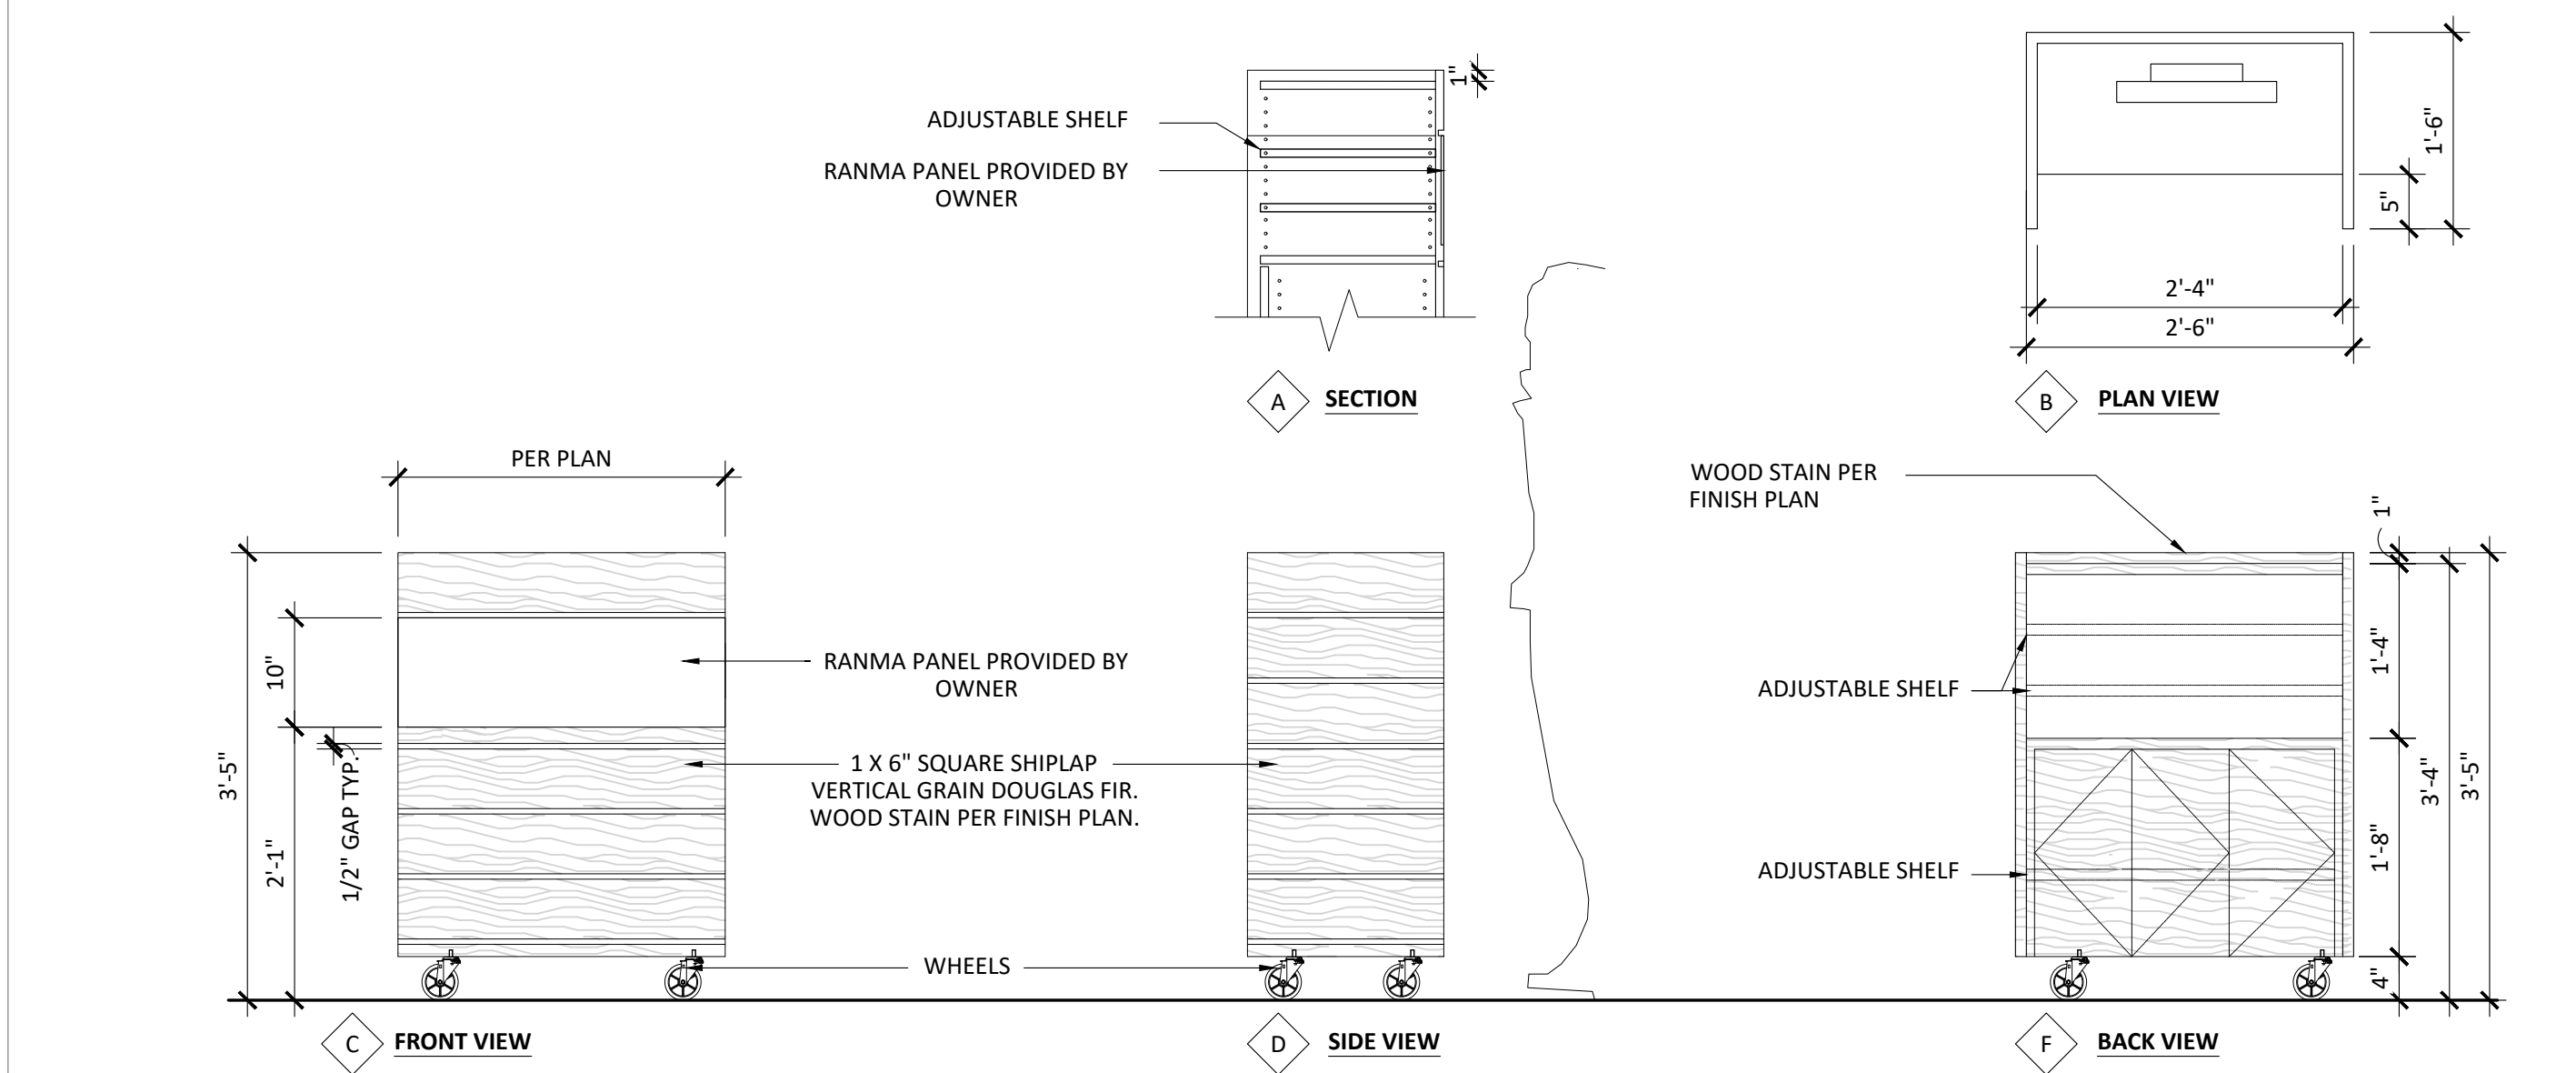


5 HOSTESS STAND DETAIL SCALE: 3/4" = 1'-0"


1

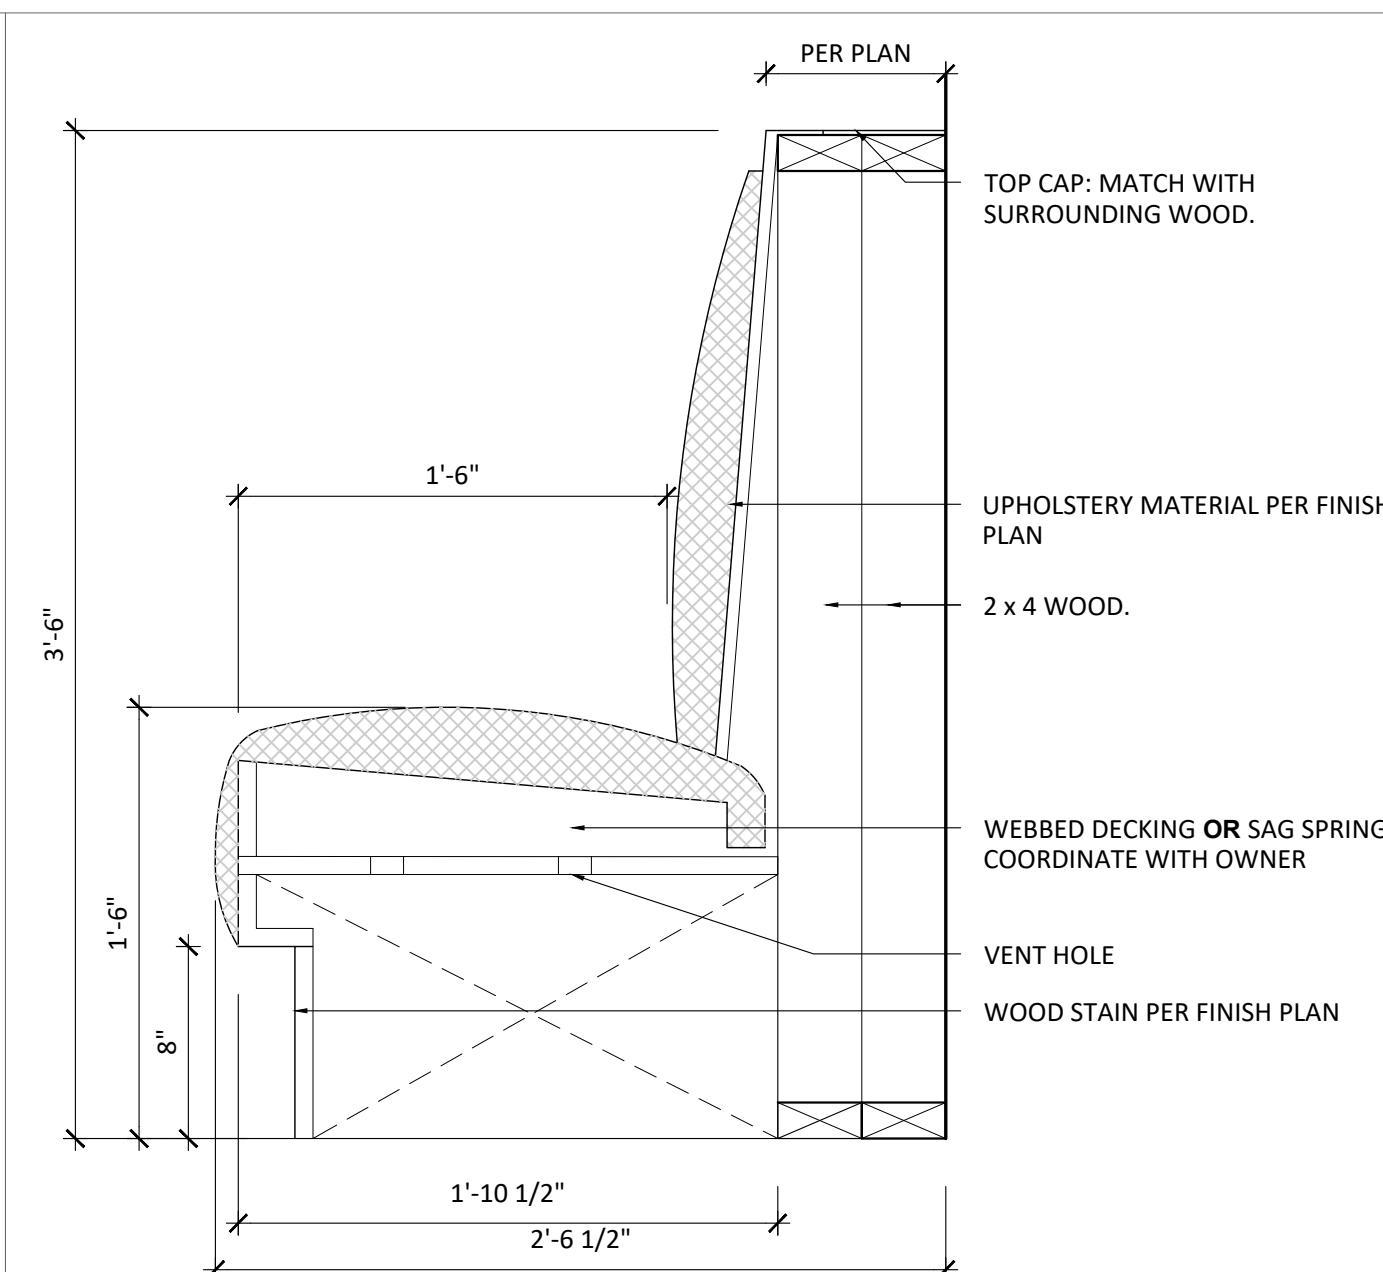

1 BOOTH SEATING SCALE: 1-1/2" = 1'-0"

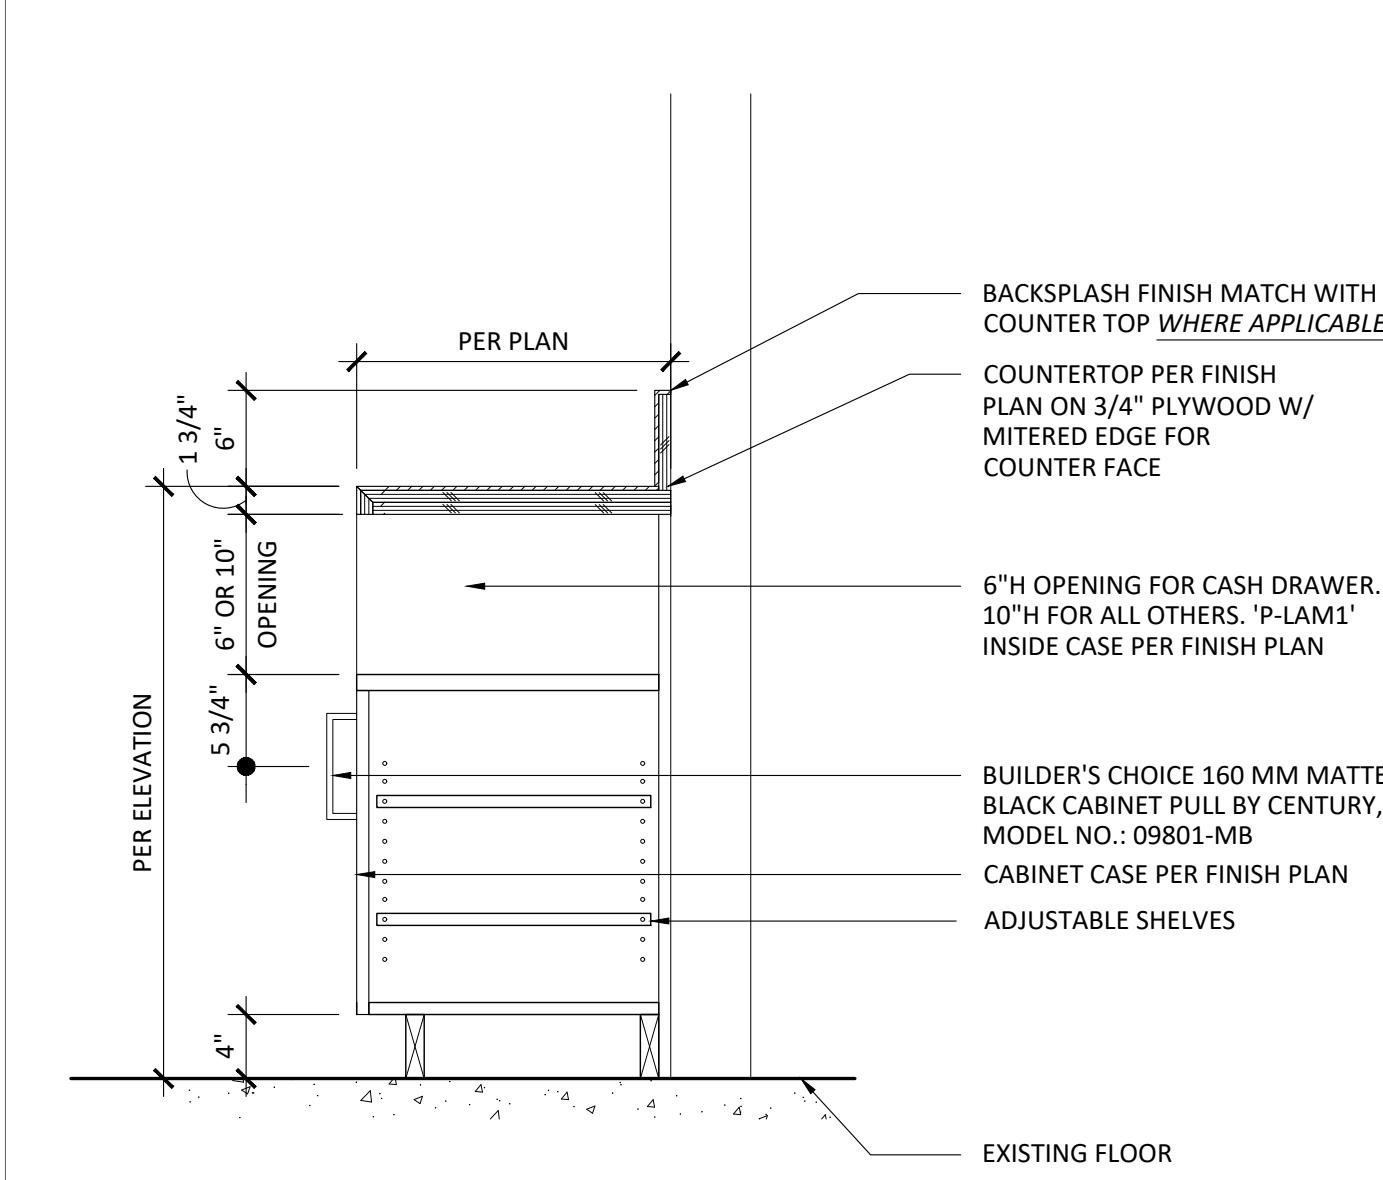

2 CABINET W/ BACKSPLASH SCALE: 1" = 1'-0"

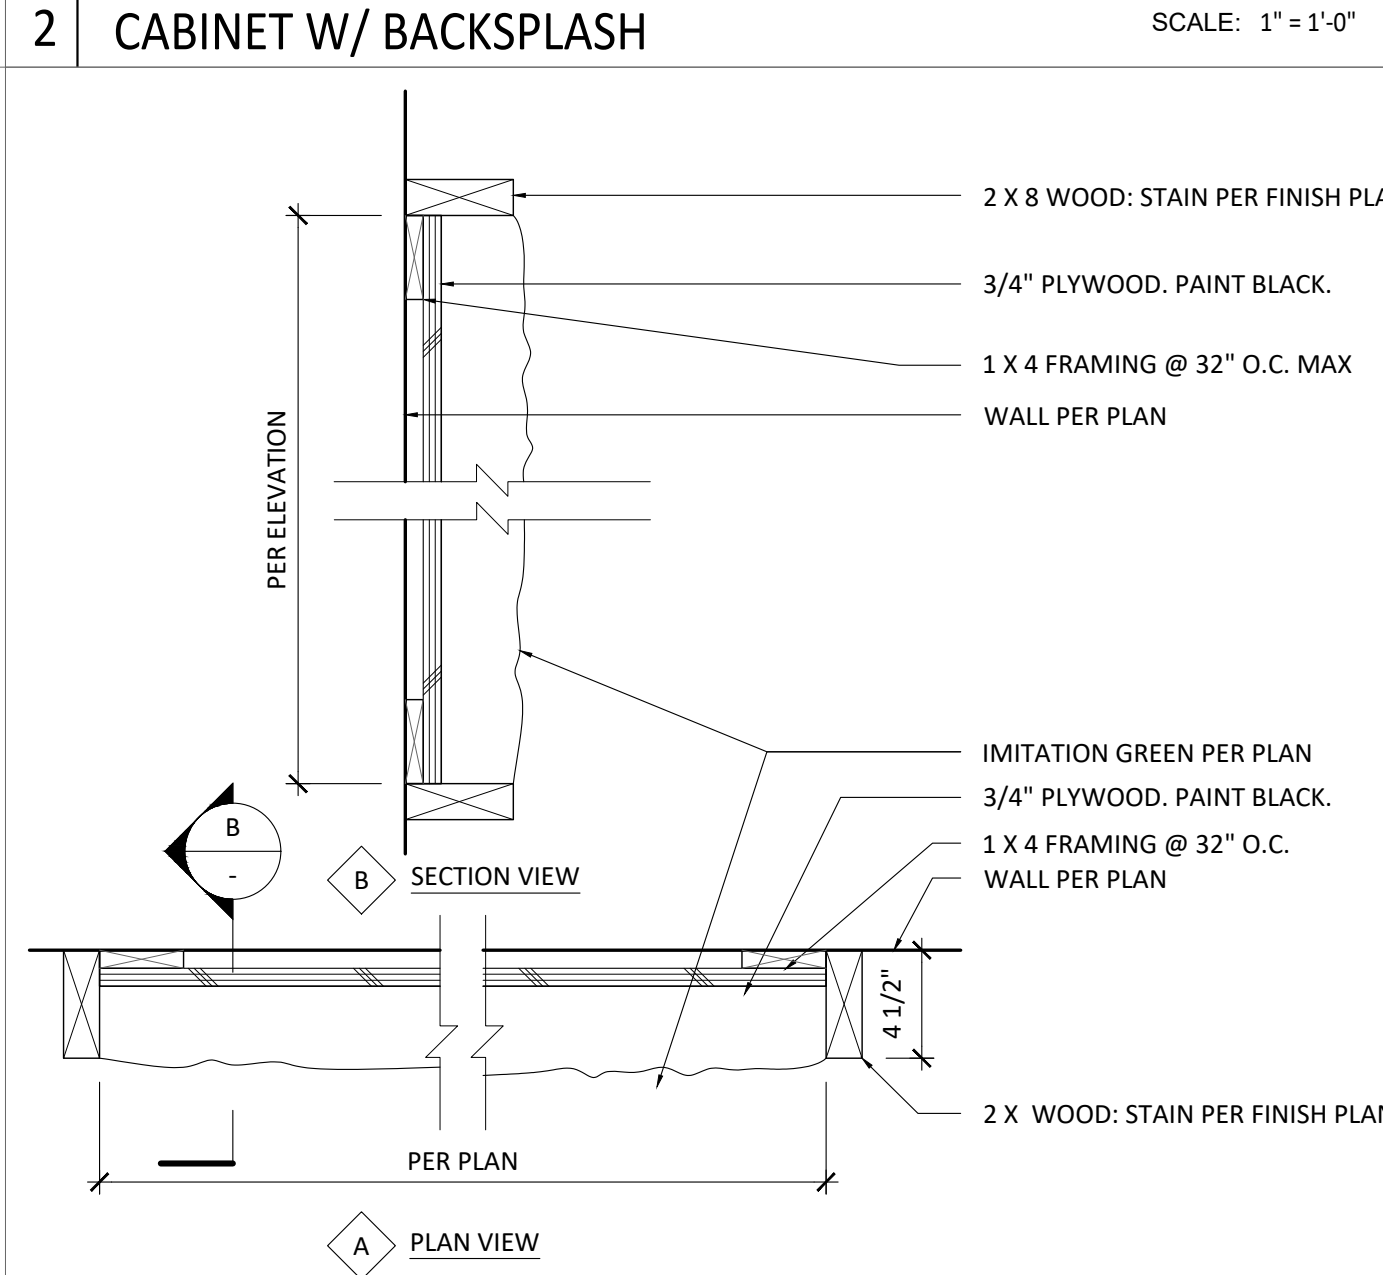

3 WALL PLANTER BOX DETAIL SCALE: 1-1/2" = 1'-0"

REVISION:	OWNER	8.13.21	1
REVISION:	JINYA	11.08.21	4
REVISION:	HEALTH	12.29.21	5
REVISION:	OWNER	1.26.23	6
REVISION:	OWNER	11.30.23	7
REVISION:			
BID SET:			
HEALTH SUBMITTAL:			
CITY SUBMITTAL:			
TENANT APPROVAL:			
SCALE:			
PROJECT NO:	RJ0420		
DRAWN:	MK & SJ		
DATE:	01/14/22		



**MILLWORK
DETAILS**

THIS PERMIT APPLICATION SET OF DRAWINGS ARE
INTENDED FOR BUILDING DEPARTMENT REVIEW ONLY.
REVISIONS DUE TO PLAN CHECK AND KEDO DESIGN
REVIEW/COORDINATION MAY BE REQUIRED.

SHEET NO:


A11.1.1

NOT FOR CONSTRUCTION UNTIL PERMITTED

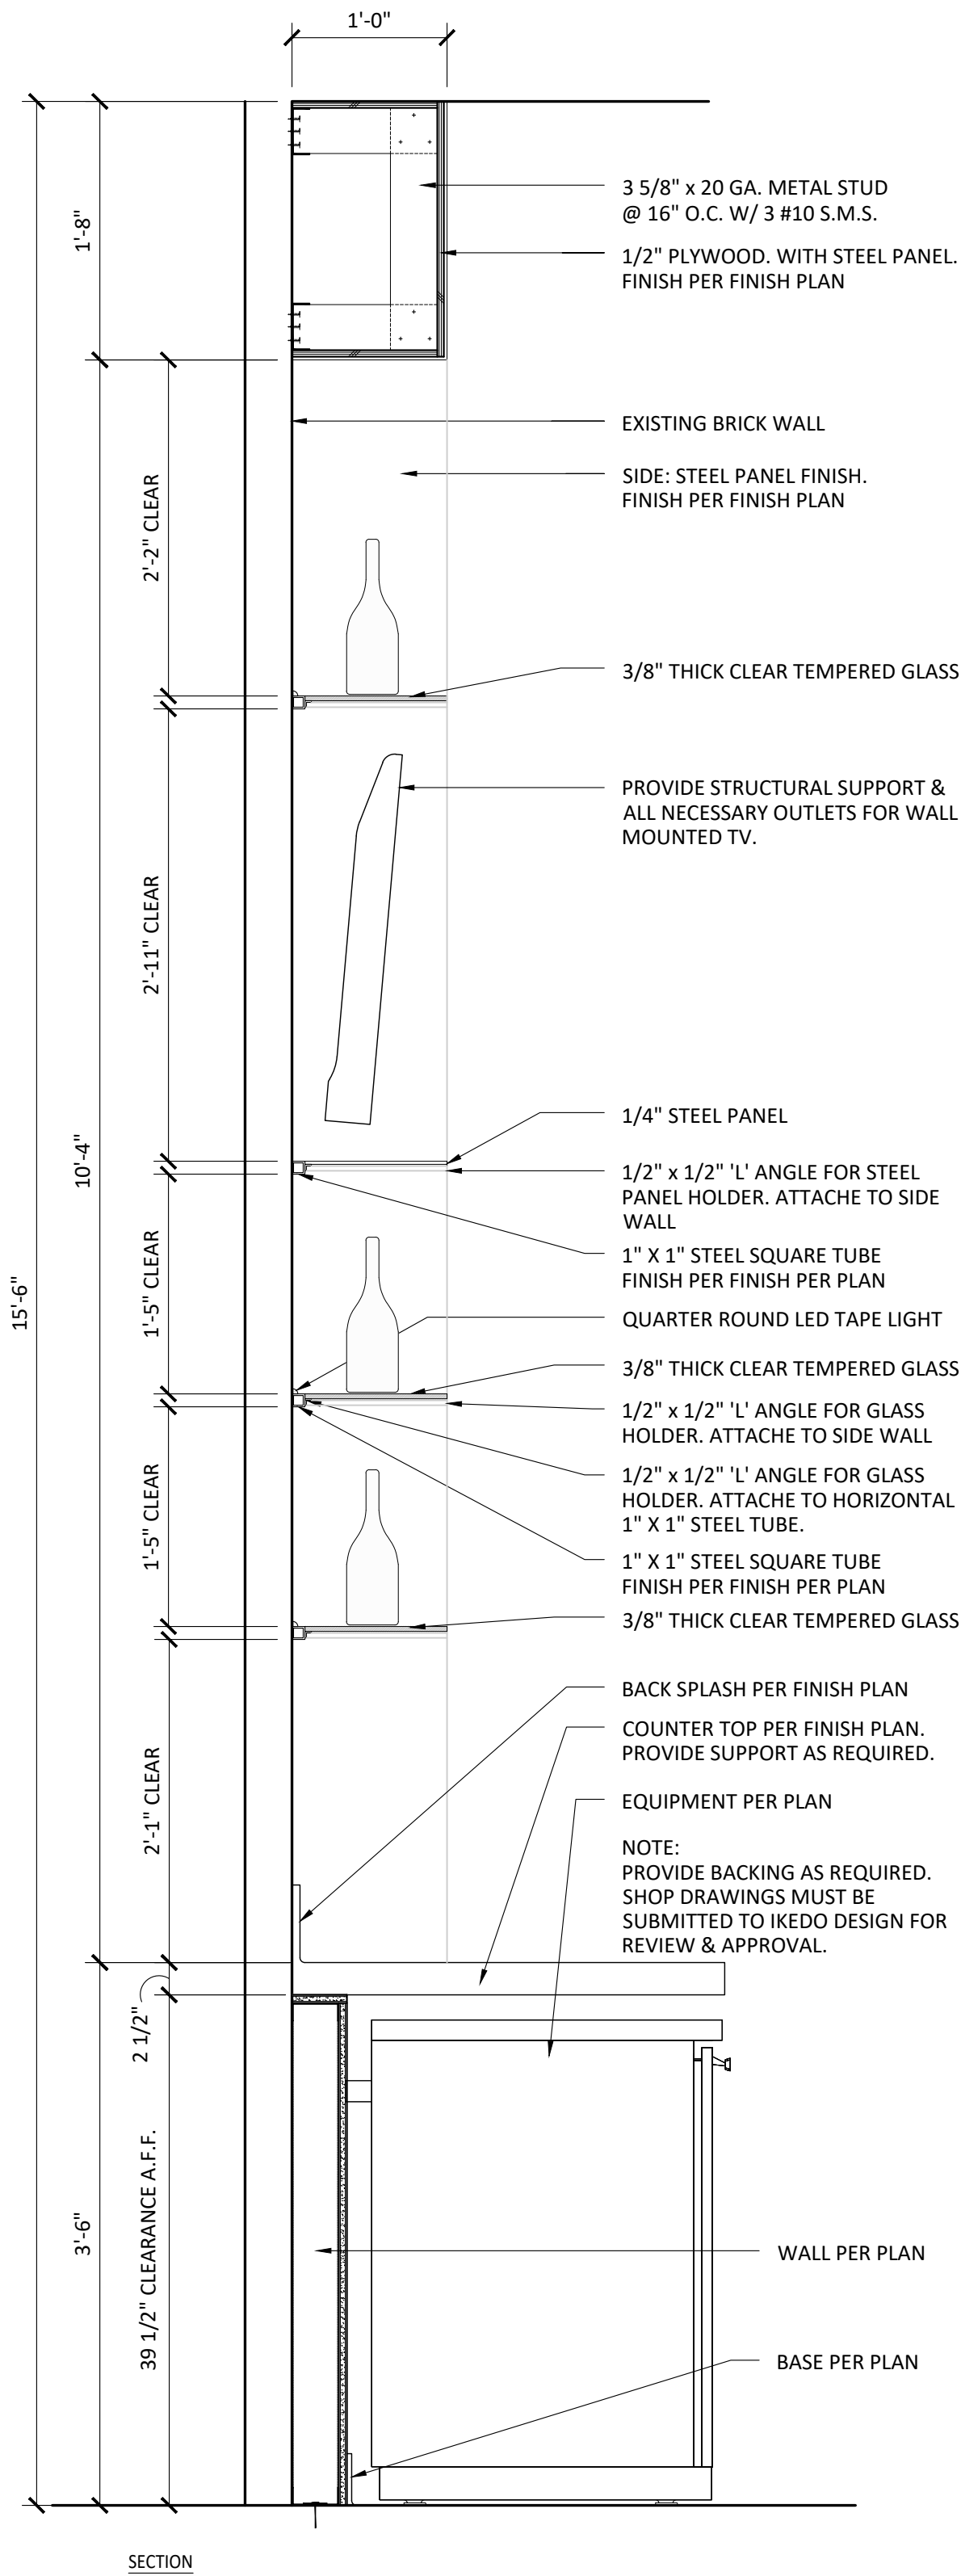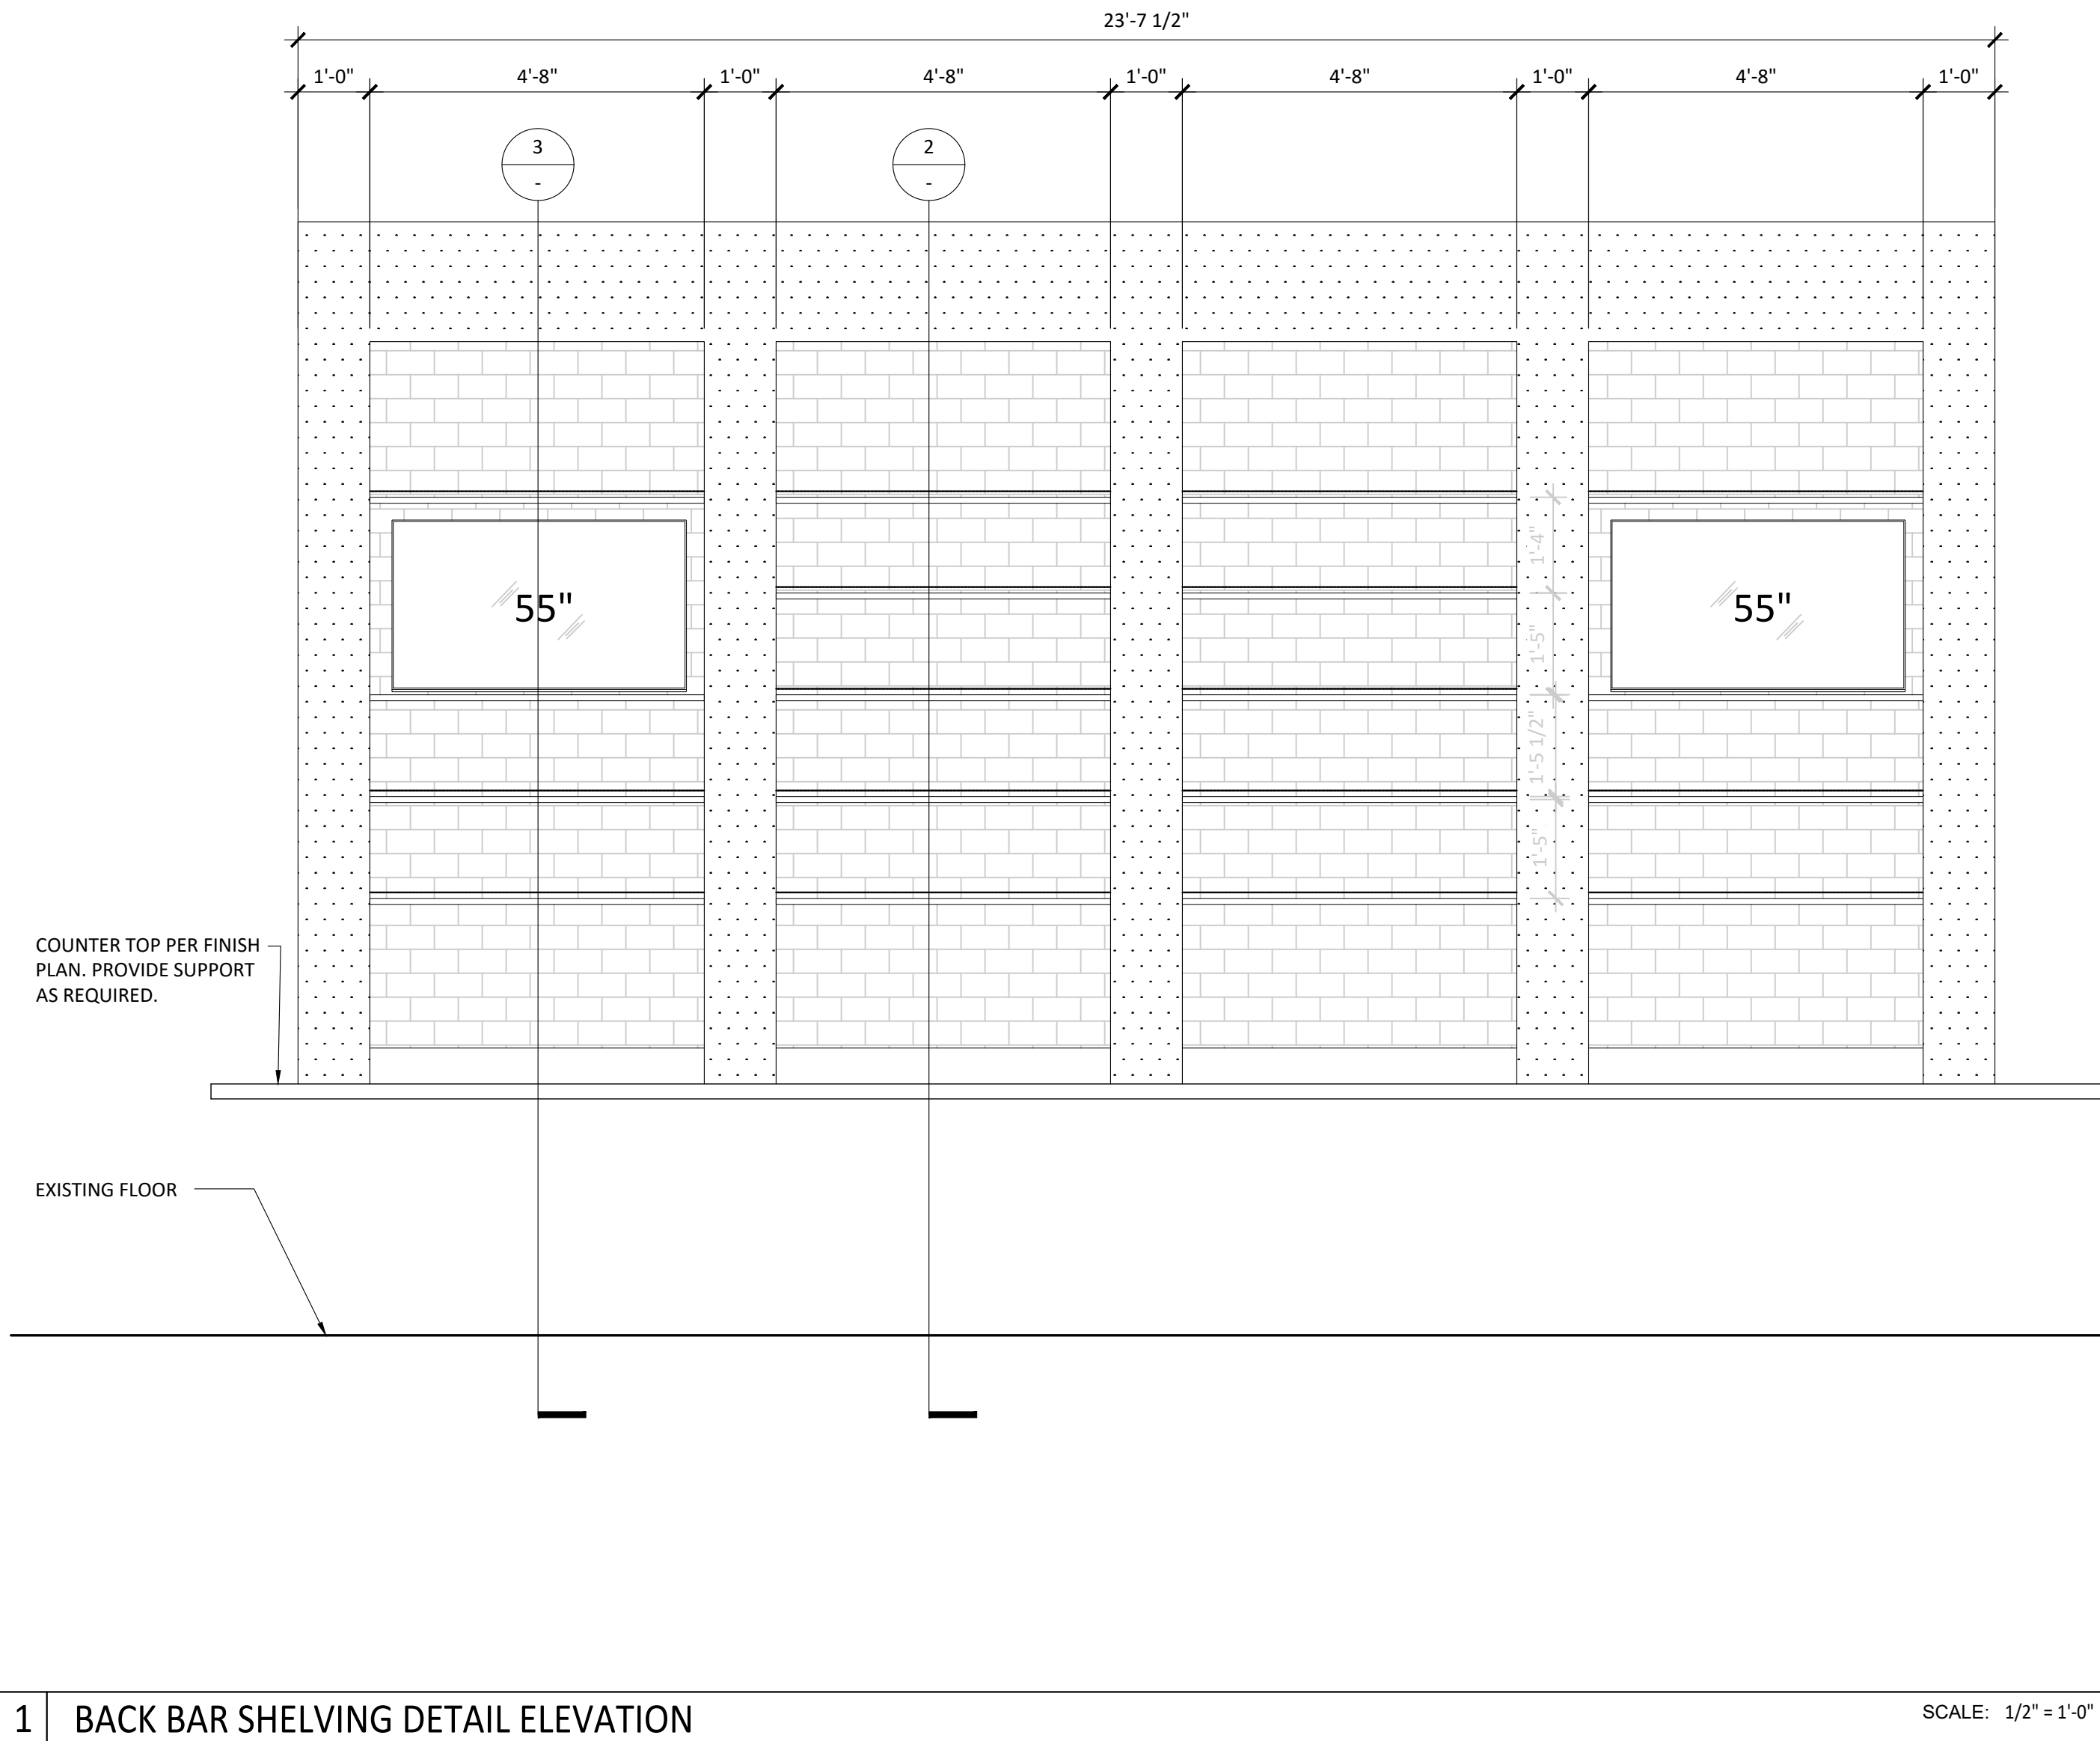

3 TYP. SHELVING AT BAR

SCALE: 1" = 1'-0"

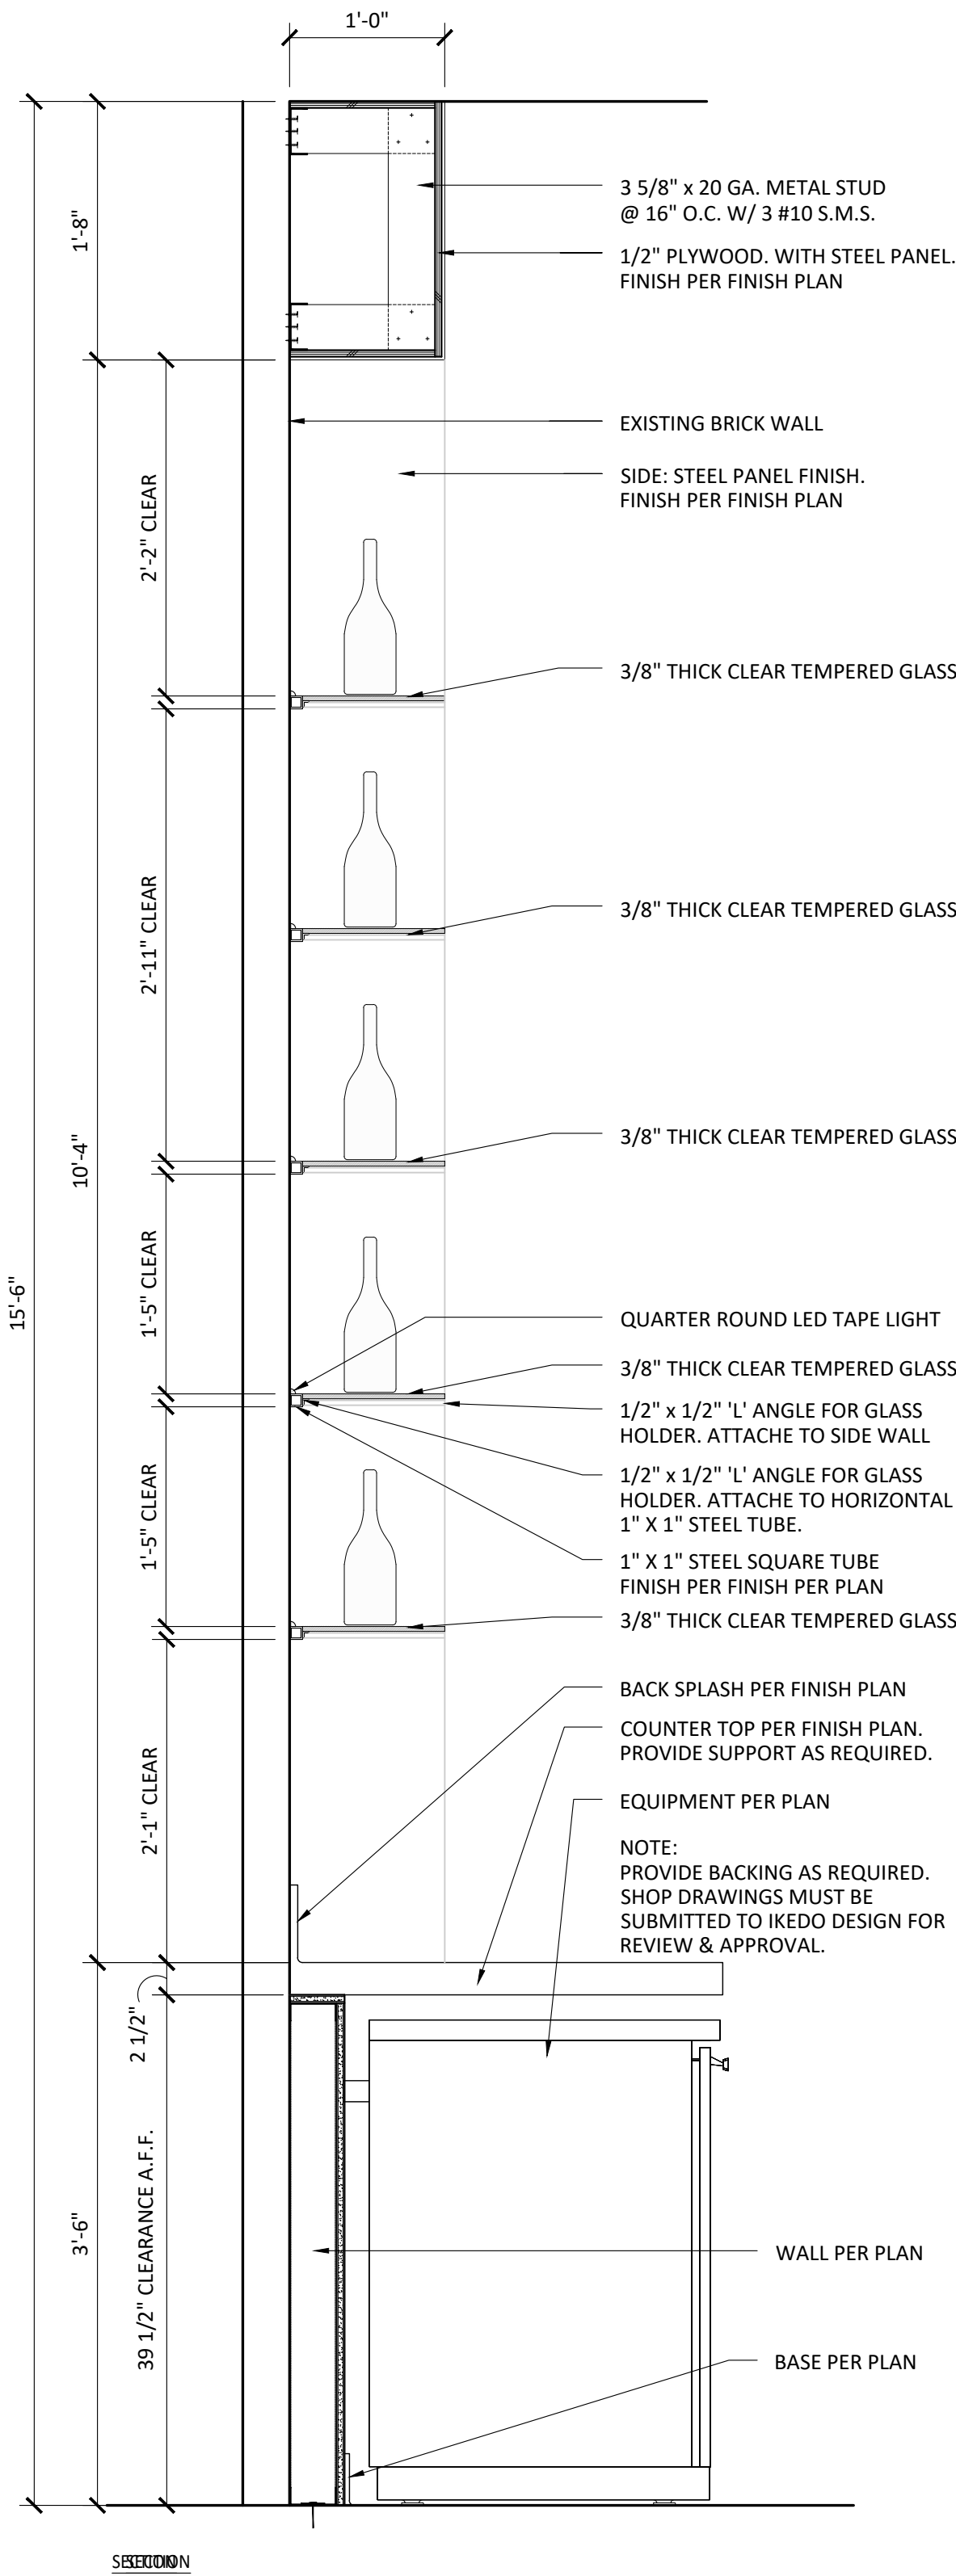

2 TYP. SHELVING AT BAR

SCALE: 1" = 1'-0"


REVISION:	OWNER	1
8.13.21		
REVISION:		
REVISION:	JINYA	4
11.08.21		
REVISION:	HEALTH	5
12.29.21		
REVISION:	OWNER	6
1.26.23		
REVISION:	OWNER	7
11.30.23		
REVISION:		
BID SET:		
HEALTH SUBMITTAL:		
CITY SUBMITTAL:		
TENANT APPROVAL:		
SCALE:		
PROJECT NO:	RJ0420	
DRAWN:	MK & SJ	
DATE:	01/14/22	

**CEILING
DETAILS**


THIS PERMIT APPLICATION SET OF DRAWINGS ARE
INTENDED FOR BUILDING DEPARTMENT REVIEW ONLY.
REVISIONS DUE TO PLAN CHECK AND KEDO DESIGN
REVIEW/COORDINATION MAY BE REQUIRED.

SHEET NO:


A11.2

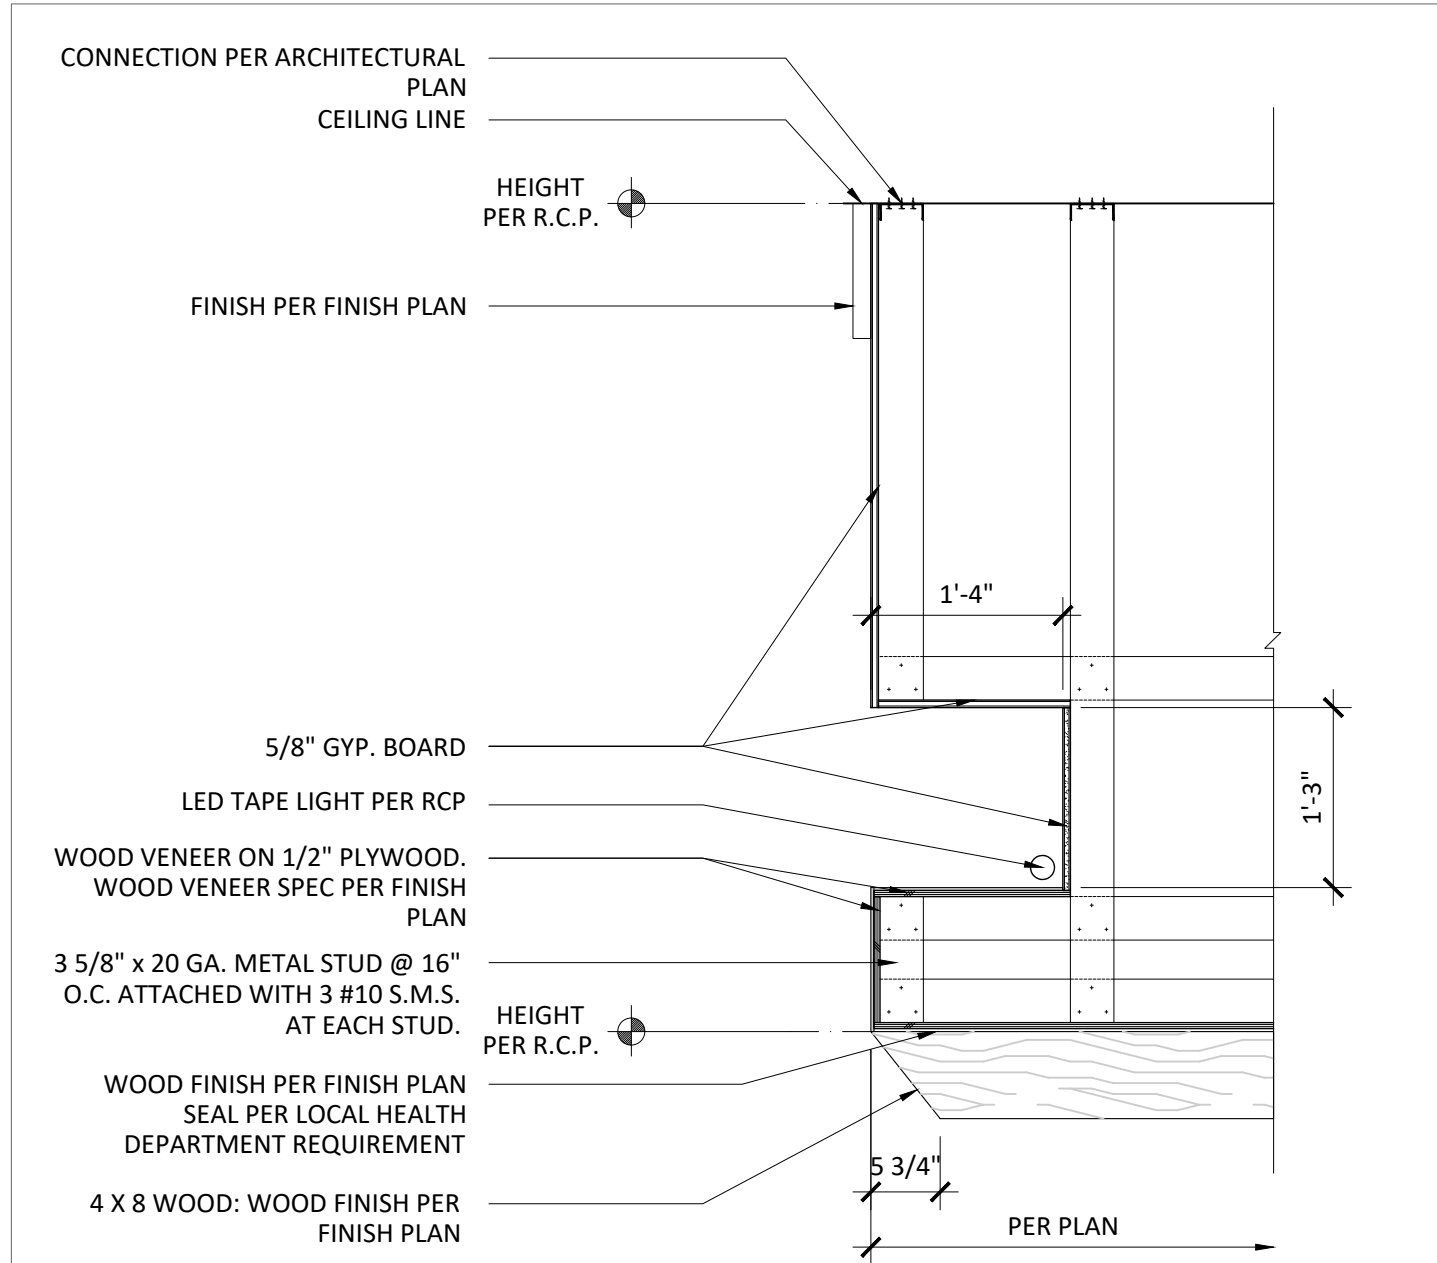

1 SOFFIT DETAIL @ ROBATA SCALE: 3/4" = 1'-0"

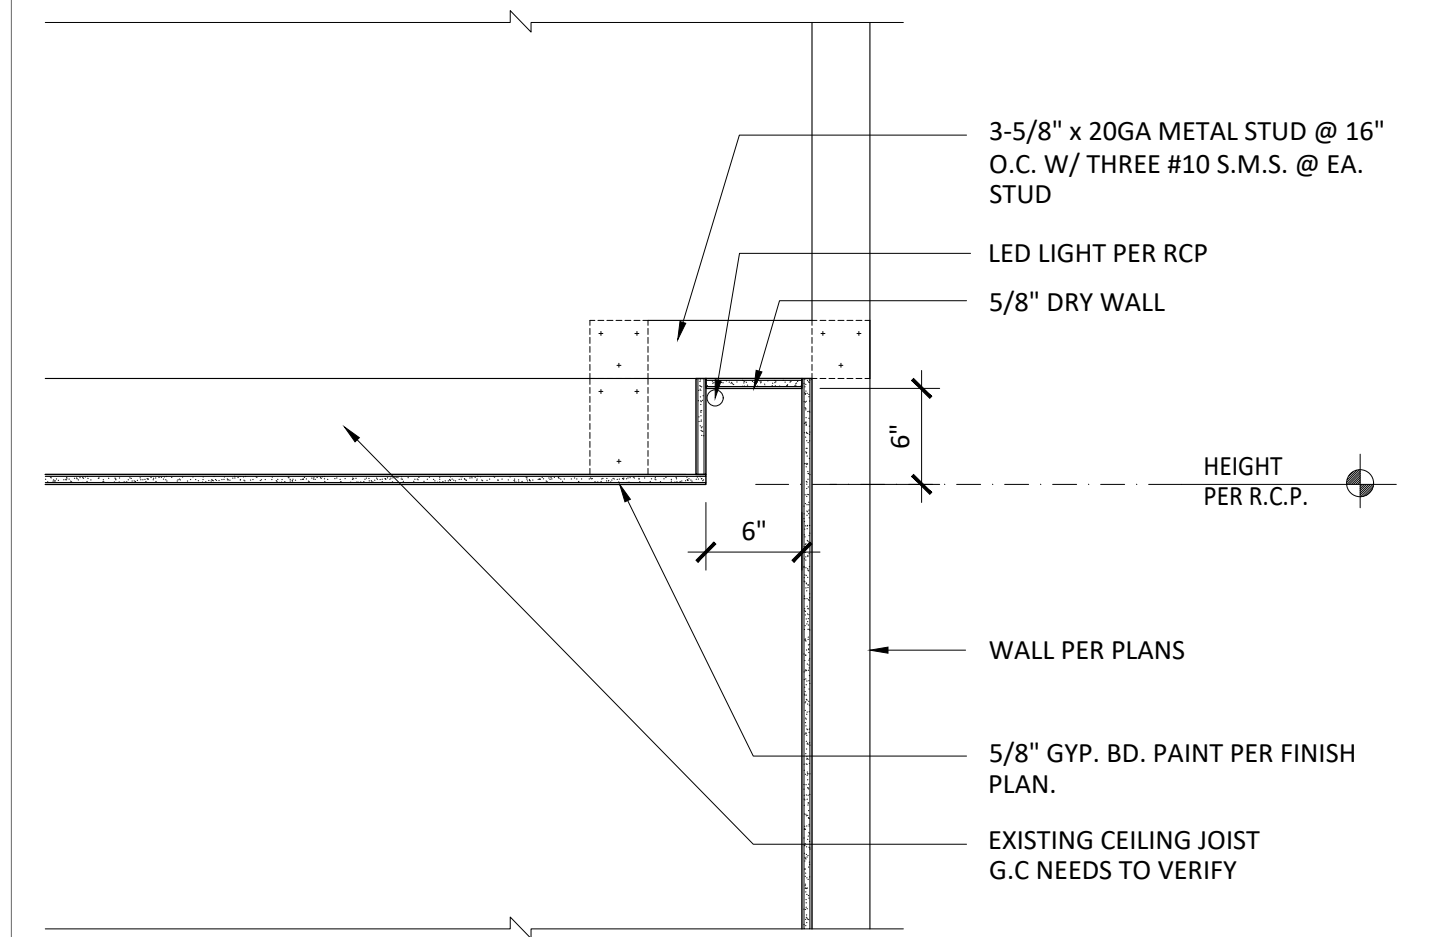

2 COVE DETAIL SCALE: 1" = 1'-0"

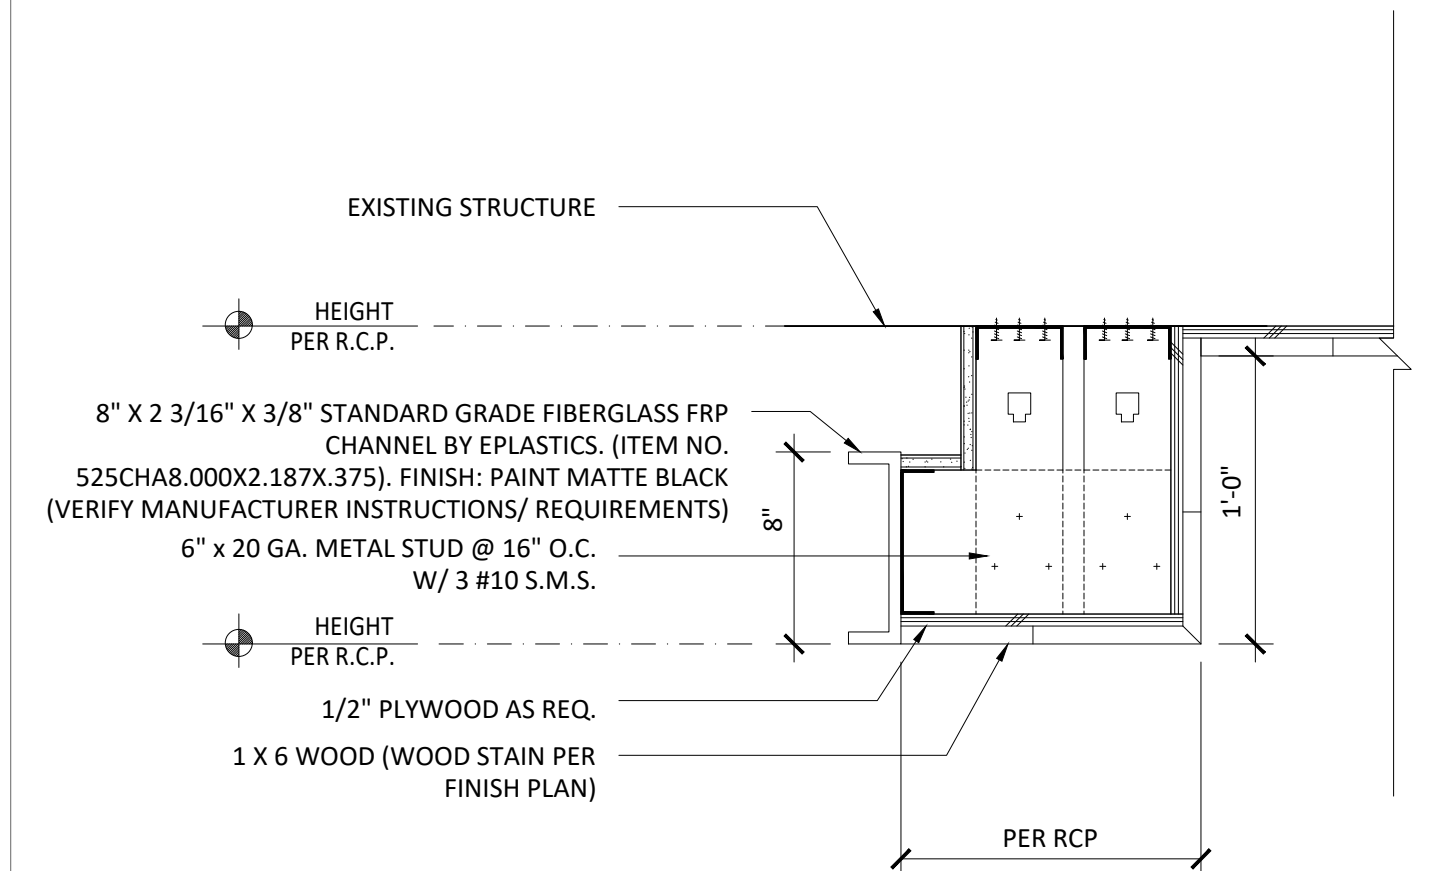

3 SOFFIT DETAIL @ BAR SCALE: 1-1/2" = 1'-0"

1 - 12

2 - 24



3 - 12



3.1 - 2
Dining
chair
heights



4 - 12



5 - 8

W-7518

