


Merit Health
113 JACKSON STREET
Olde Towne Building 2A
SUITE A

PLANS REVIEWED
CITY OF RIDGELAND
PROJECT NAME/13 Jackson St. 2A
REVIEWER *Clay Toney*
DATE *9-20-17*

FOUNDATION PLAN
SCALE: 3/16"=1'-0"

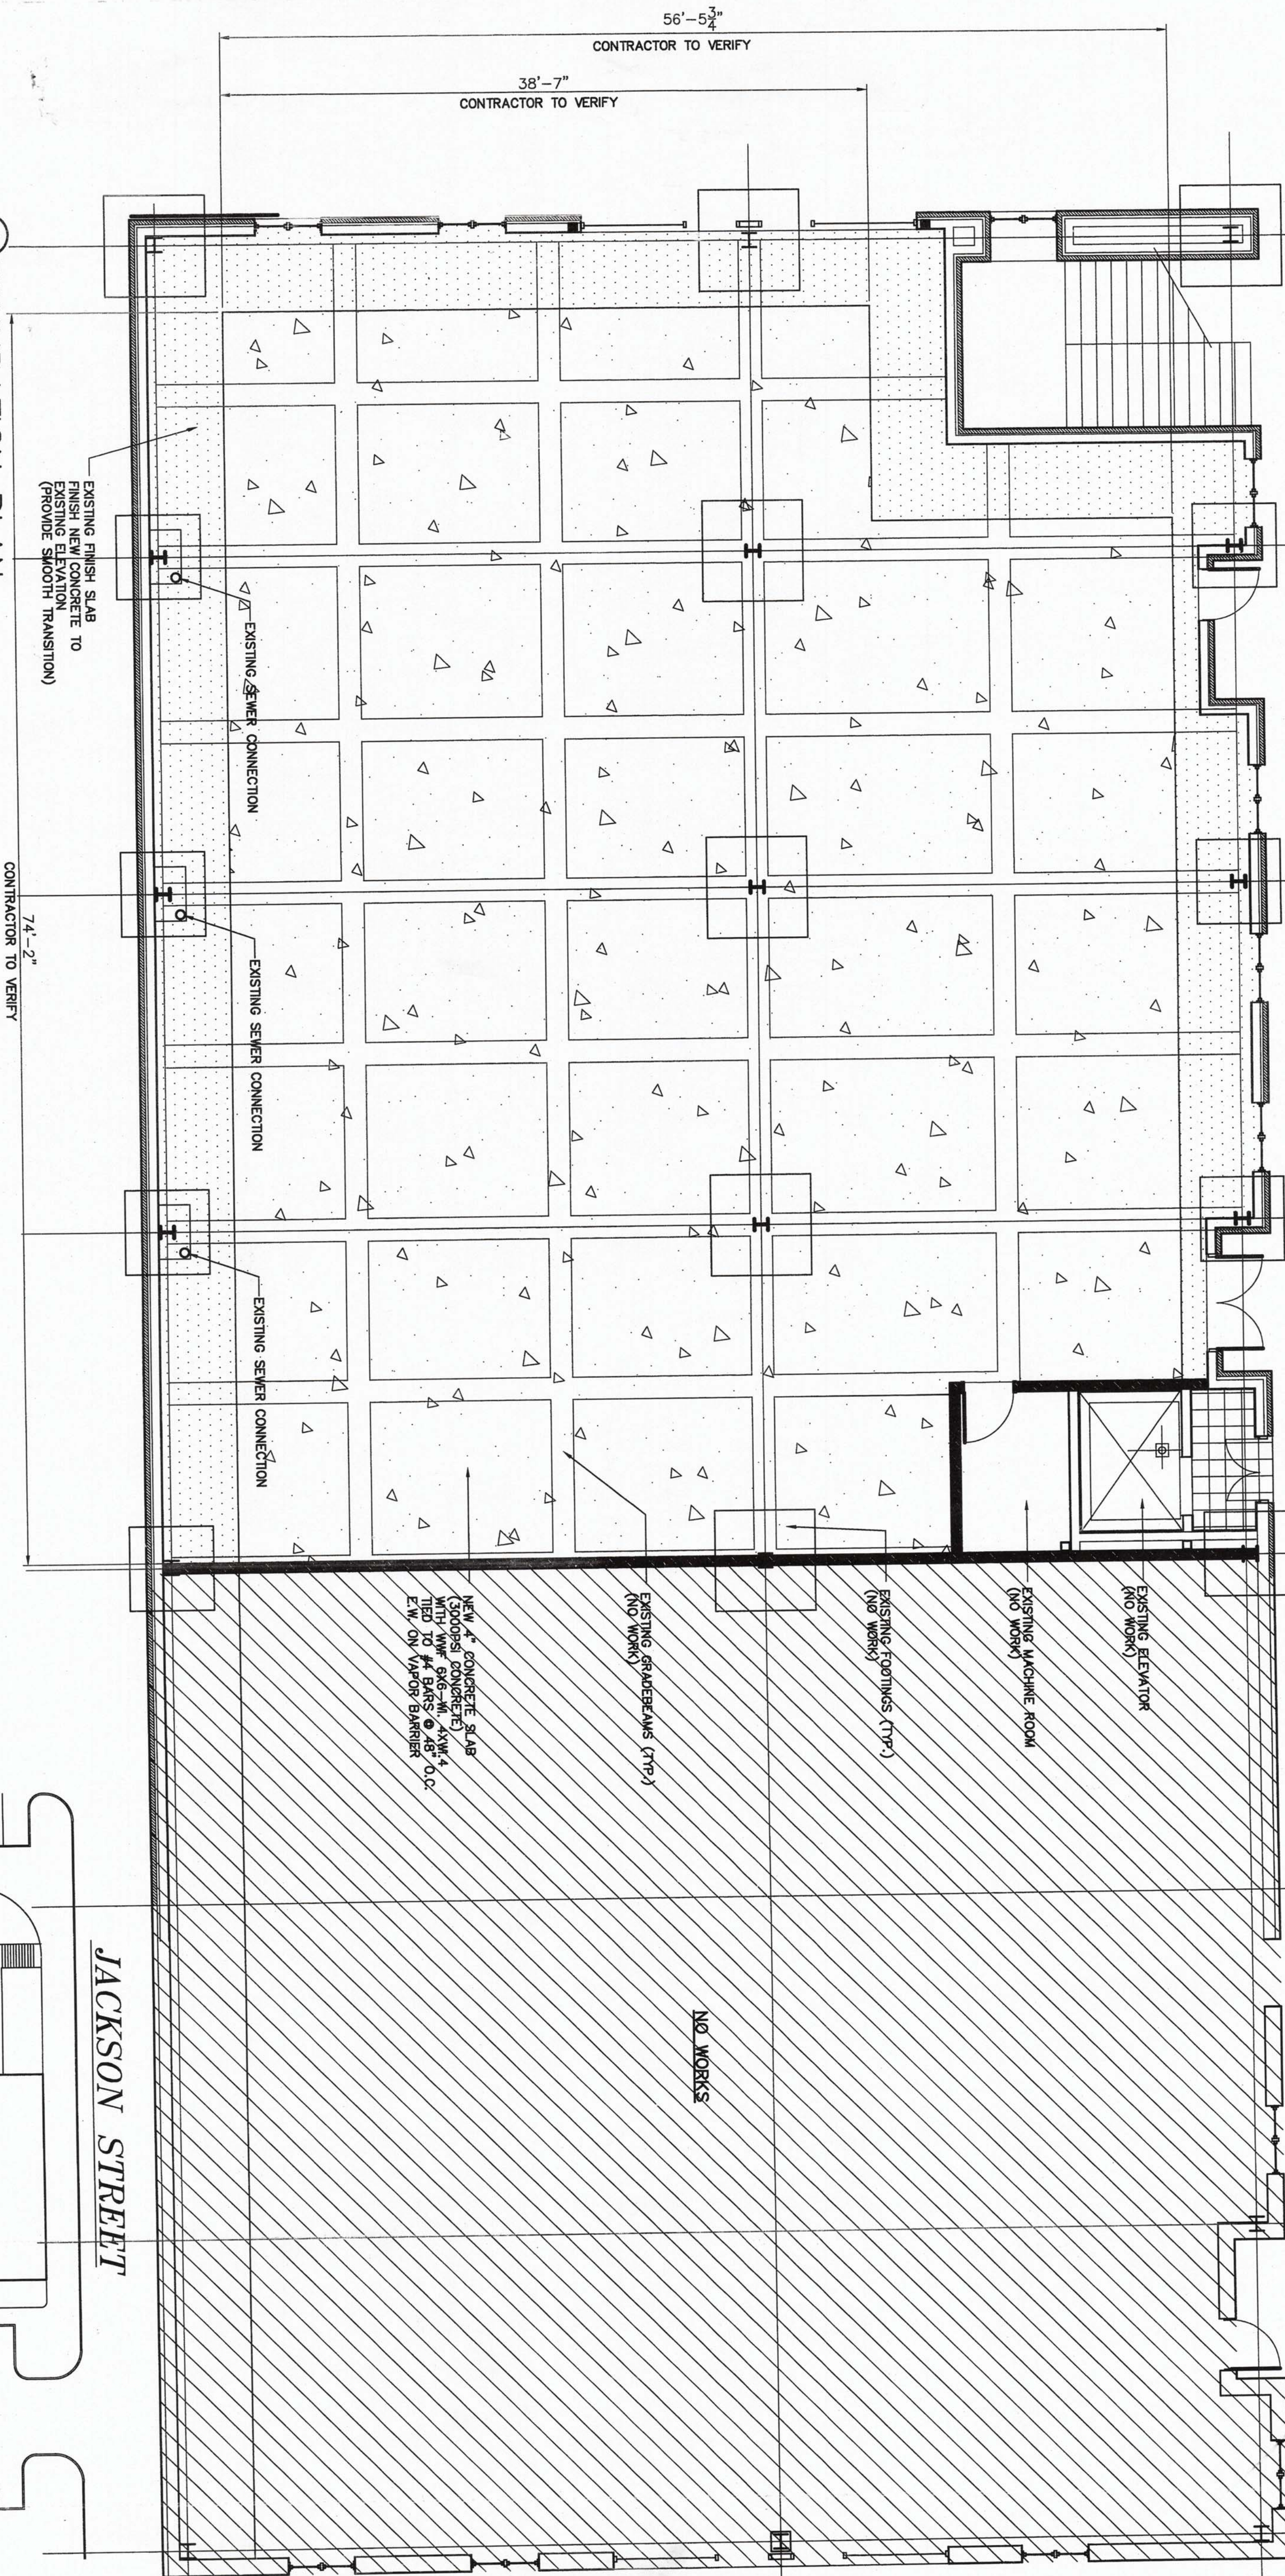


BIKE CROSSING

JACKSON STREET

COAT TAILS

LOCATION MAP
SCALE: NTS


Olde Towne Building 2A
Merit Health
Jackson Street, Ridgeland, Mississippi

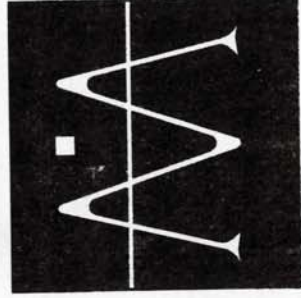

REVISIONS
BY

F1.0

DRAWN
CHECKED
DATE
SEPTEMBER 18, 2017
SCALE
JOB NO.
SHEET

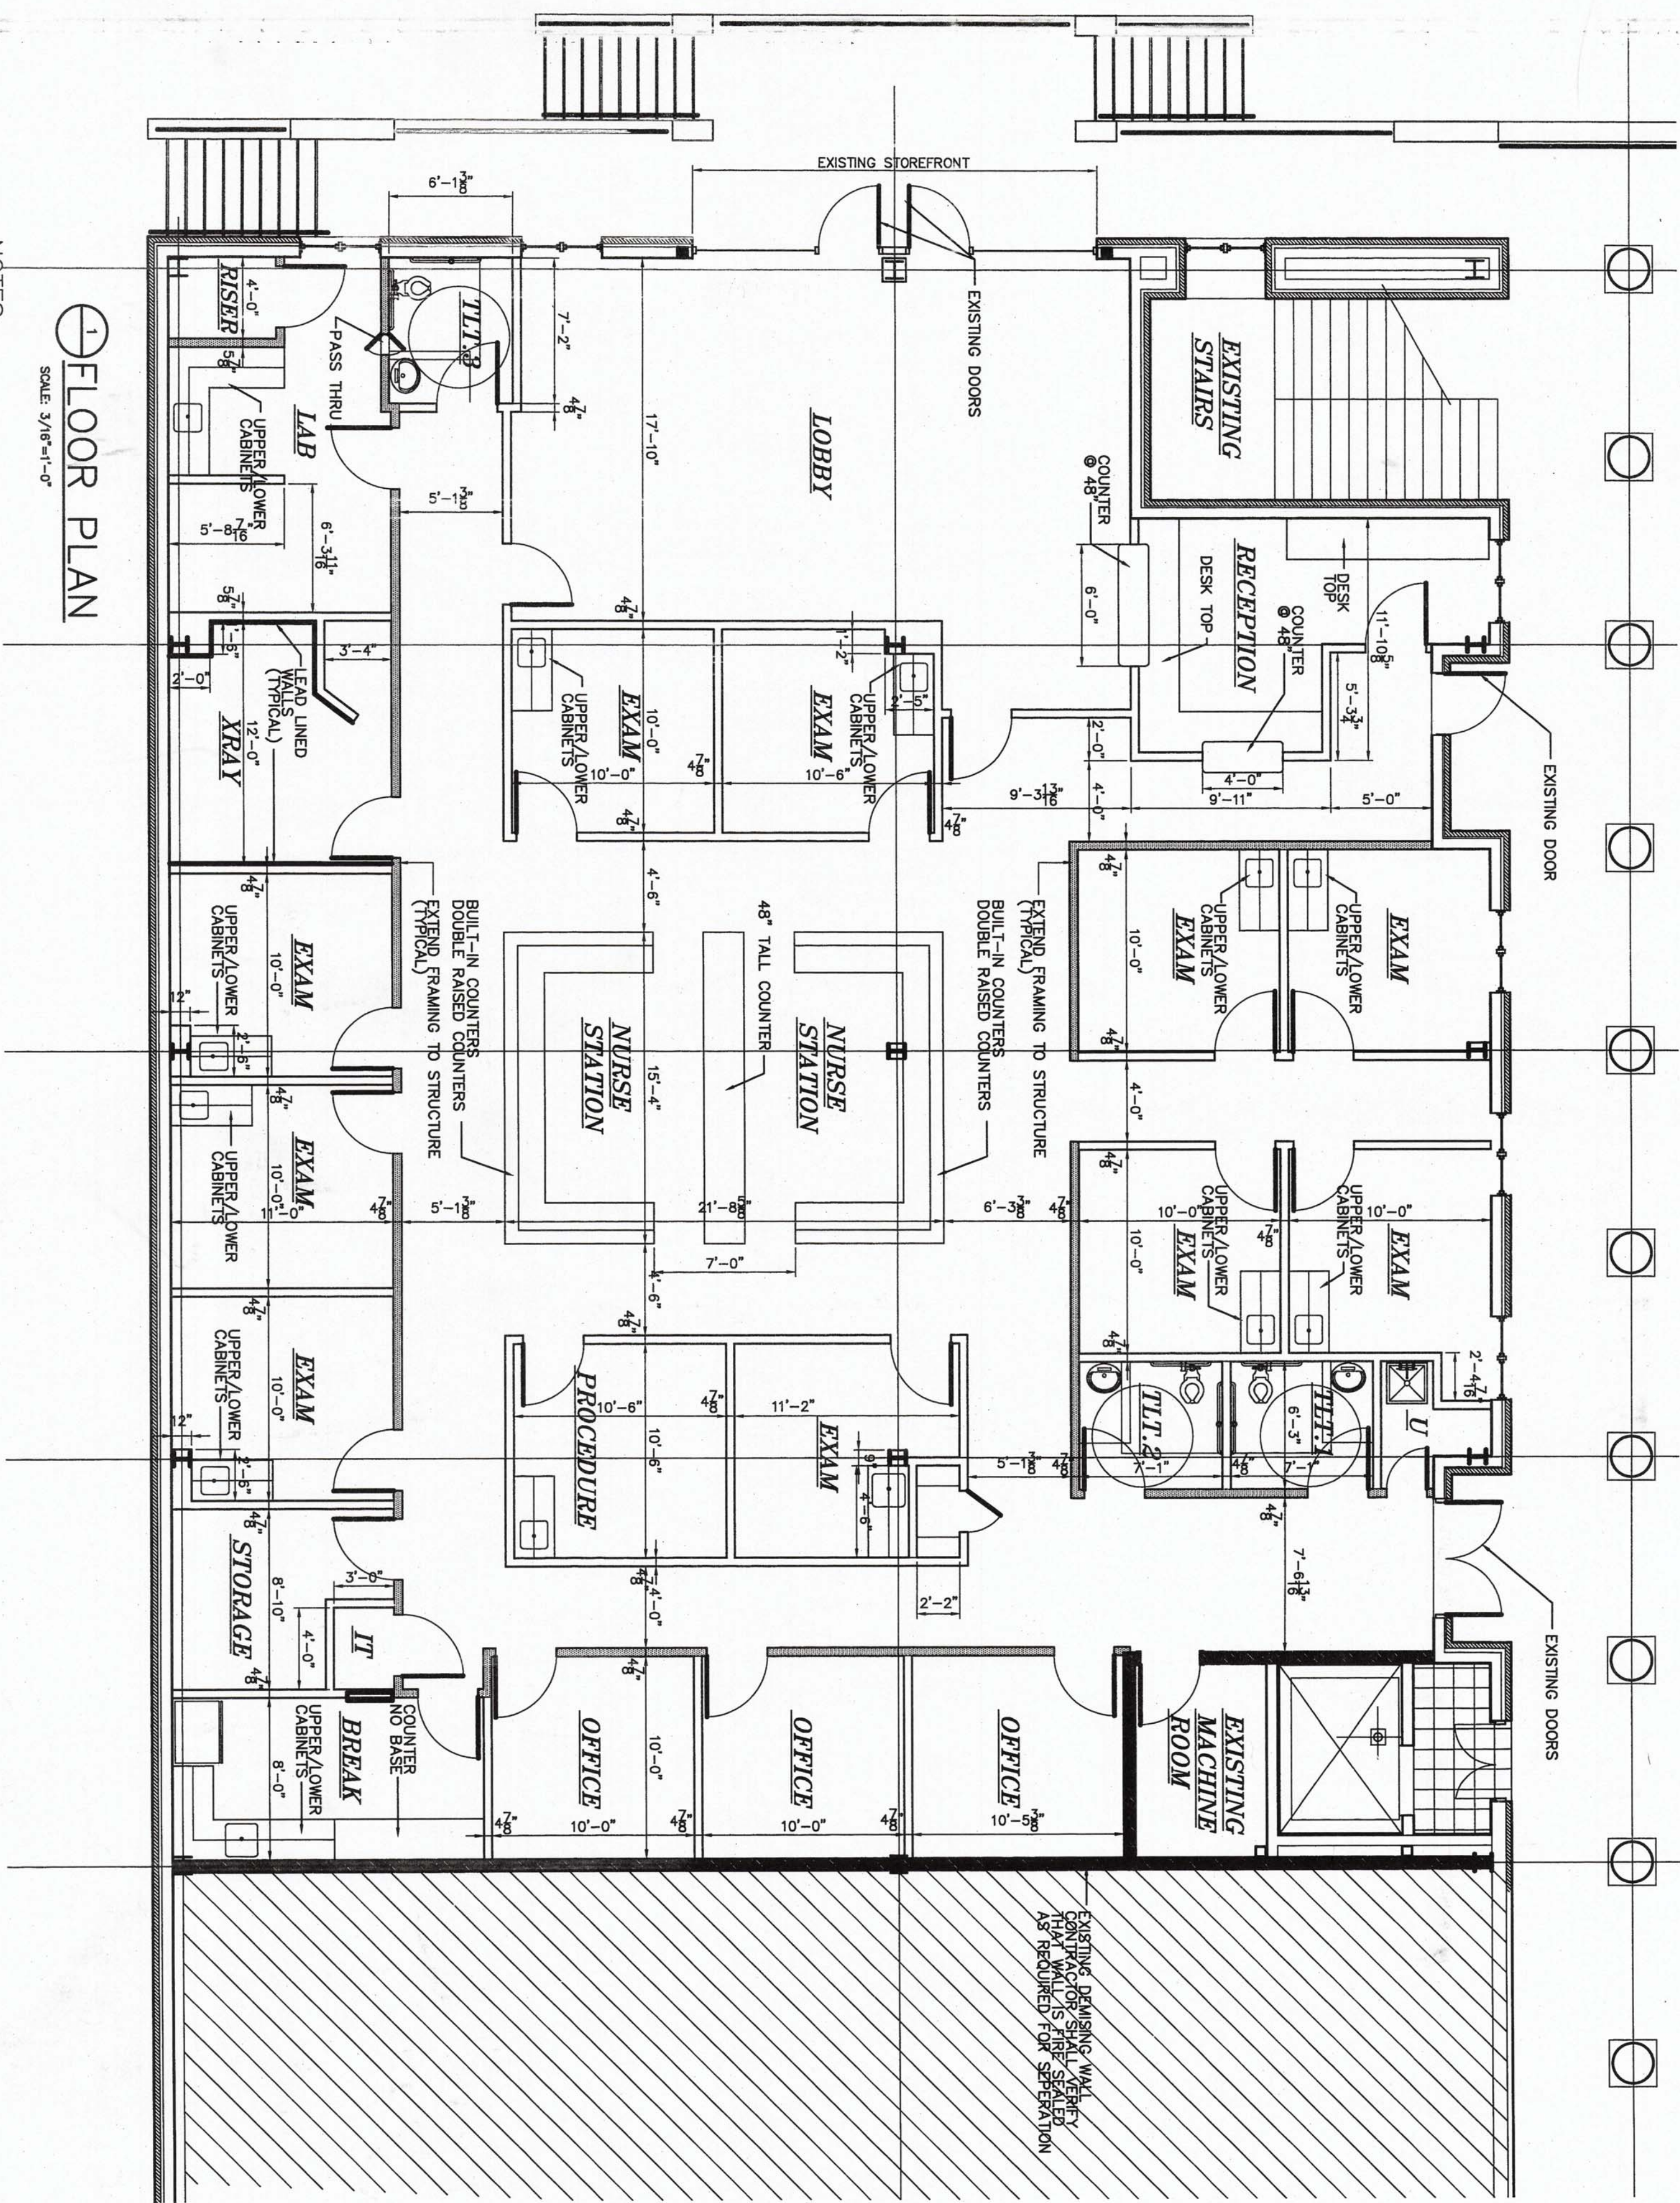


NOTES:

1. TOTAL SQUARE FEET 4,915SF
2. BUILDING USAGE: MEDICAL OFFICE
3. OCCUPANT LOAD = 49.15 (50P)
4. BUILDING FULLY SPRINKLED
5. CONSTRUCTION SHALL BE OF MTL. STUD FRAMING (NO WOOD)
6. INTERIOR WALLS SHALL BE CONSTRUCTED WITH 3" MTL. STUD FRAMING AT 16" O.C. WITH 5/8" GYP. ON EACH SIDE. (EXTEND WALL 12" ABOVE CEILING UNLESS NOTED OTHERWISE)
7. ALL FLOORS SHALL BE LVT WITH 4" RUBBER BASE.
8. ALL COLORS AND FINISHES SHALL BE APPROVED BY OWNER.

DOOR NOTES:



ALL NEW INTERIOR DOORS SHALL BE 36"x84"x1 3/4" SOLID CORE WOOD DOORS WITH PAINTED MTL. FRAMES (FINISHES TO BE APPROVED BY OWNER)

1. LATCH SIDE CLEARANCES AT ALL DOORWAYS SHALL BE IN ACCORDANCE WITH ADAAG.
2. ALL EXITS TO BE LABELED.
3. INTERIOR DOORS TO BE LABELED AS TO INTENDED USE.
4. ALL EXIT DOORS SHALL PROVIDED PANIC HARDWARE.
5. THE OPERATING DEVICE ON ALL DOORS SHALL BE CAPABLE OF OPERATION WITH ONE HAND AND SHALL NOT REQUIRE TIGHT GRASPING, TIGHT PINCHING OR TWISTING OF THE WRIST TO OPERATE.
6. THE INTERIOR HINGED DOOR SHALL BE 5.0 POUNDS (22.2 N) MAXIMUM PER ADAAG.
7. ALL DOORS TO BE LEVER TYPE WITH 1 1/2" THRESHOLD.
7. LANDING SHALL BE PROVIDED AT EVERY REQUIRED EXIT AND THEY SHALL BE A MINIMUM OF 36 INCHES IN WIDTH AND 44 INCHES LONG IN THE DIRECTION OF TRAVEL.

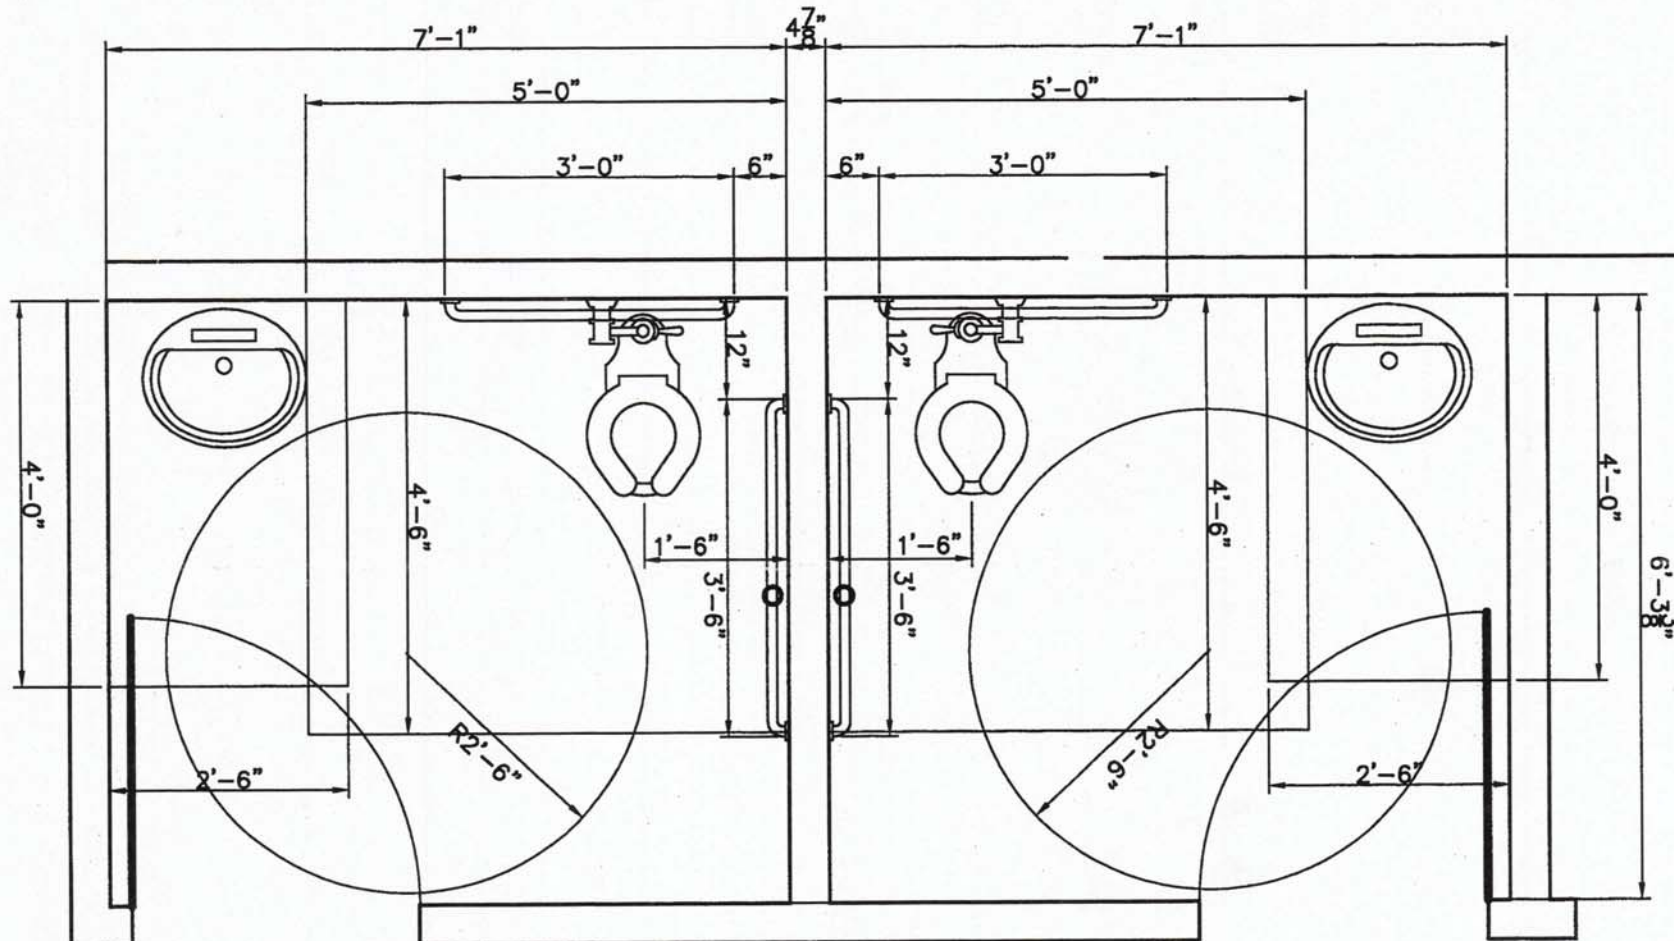

2 ENLARGED ADA T.L.T. PLAN

SCALE 1/2"=1'-0"

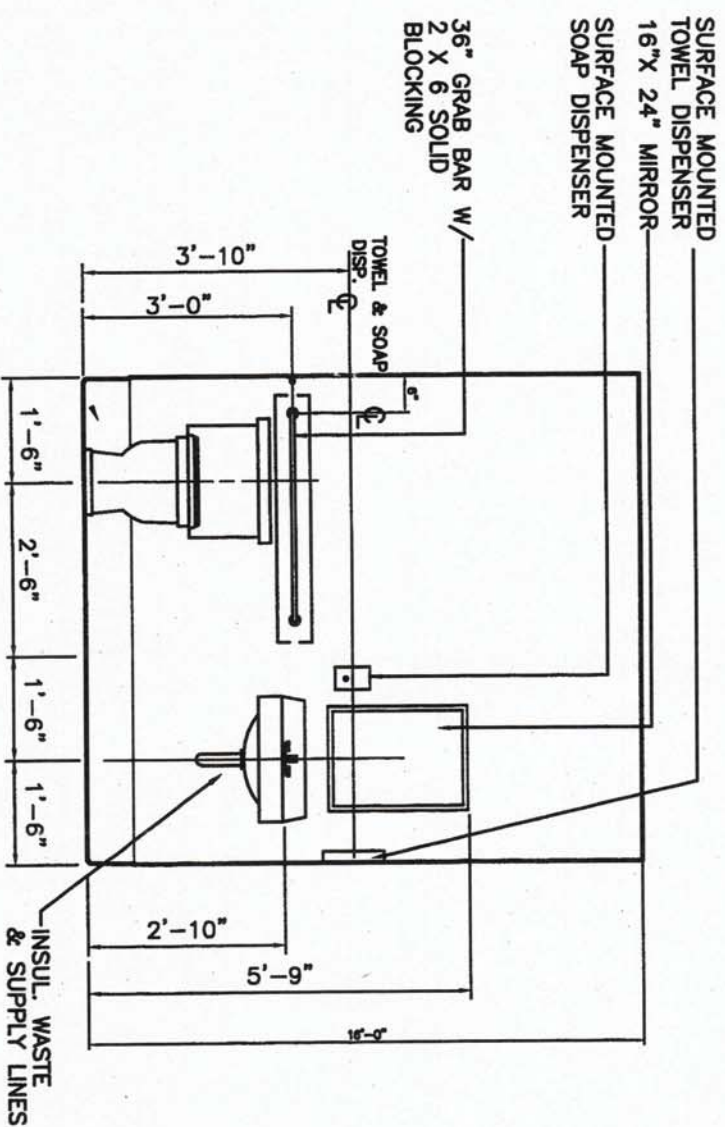
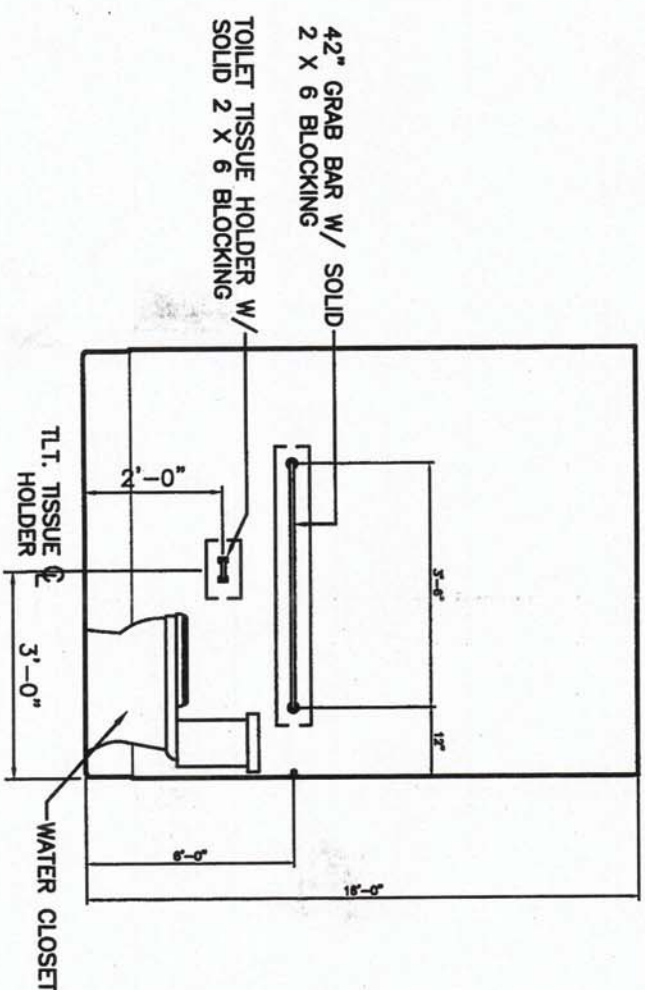


2 ADA MOUNTING HT


SCALE: NTS

PLUMBING PLAN

SCALE 3/8"=1'-0"

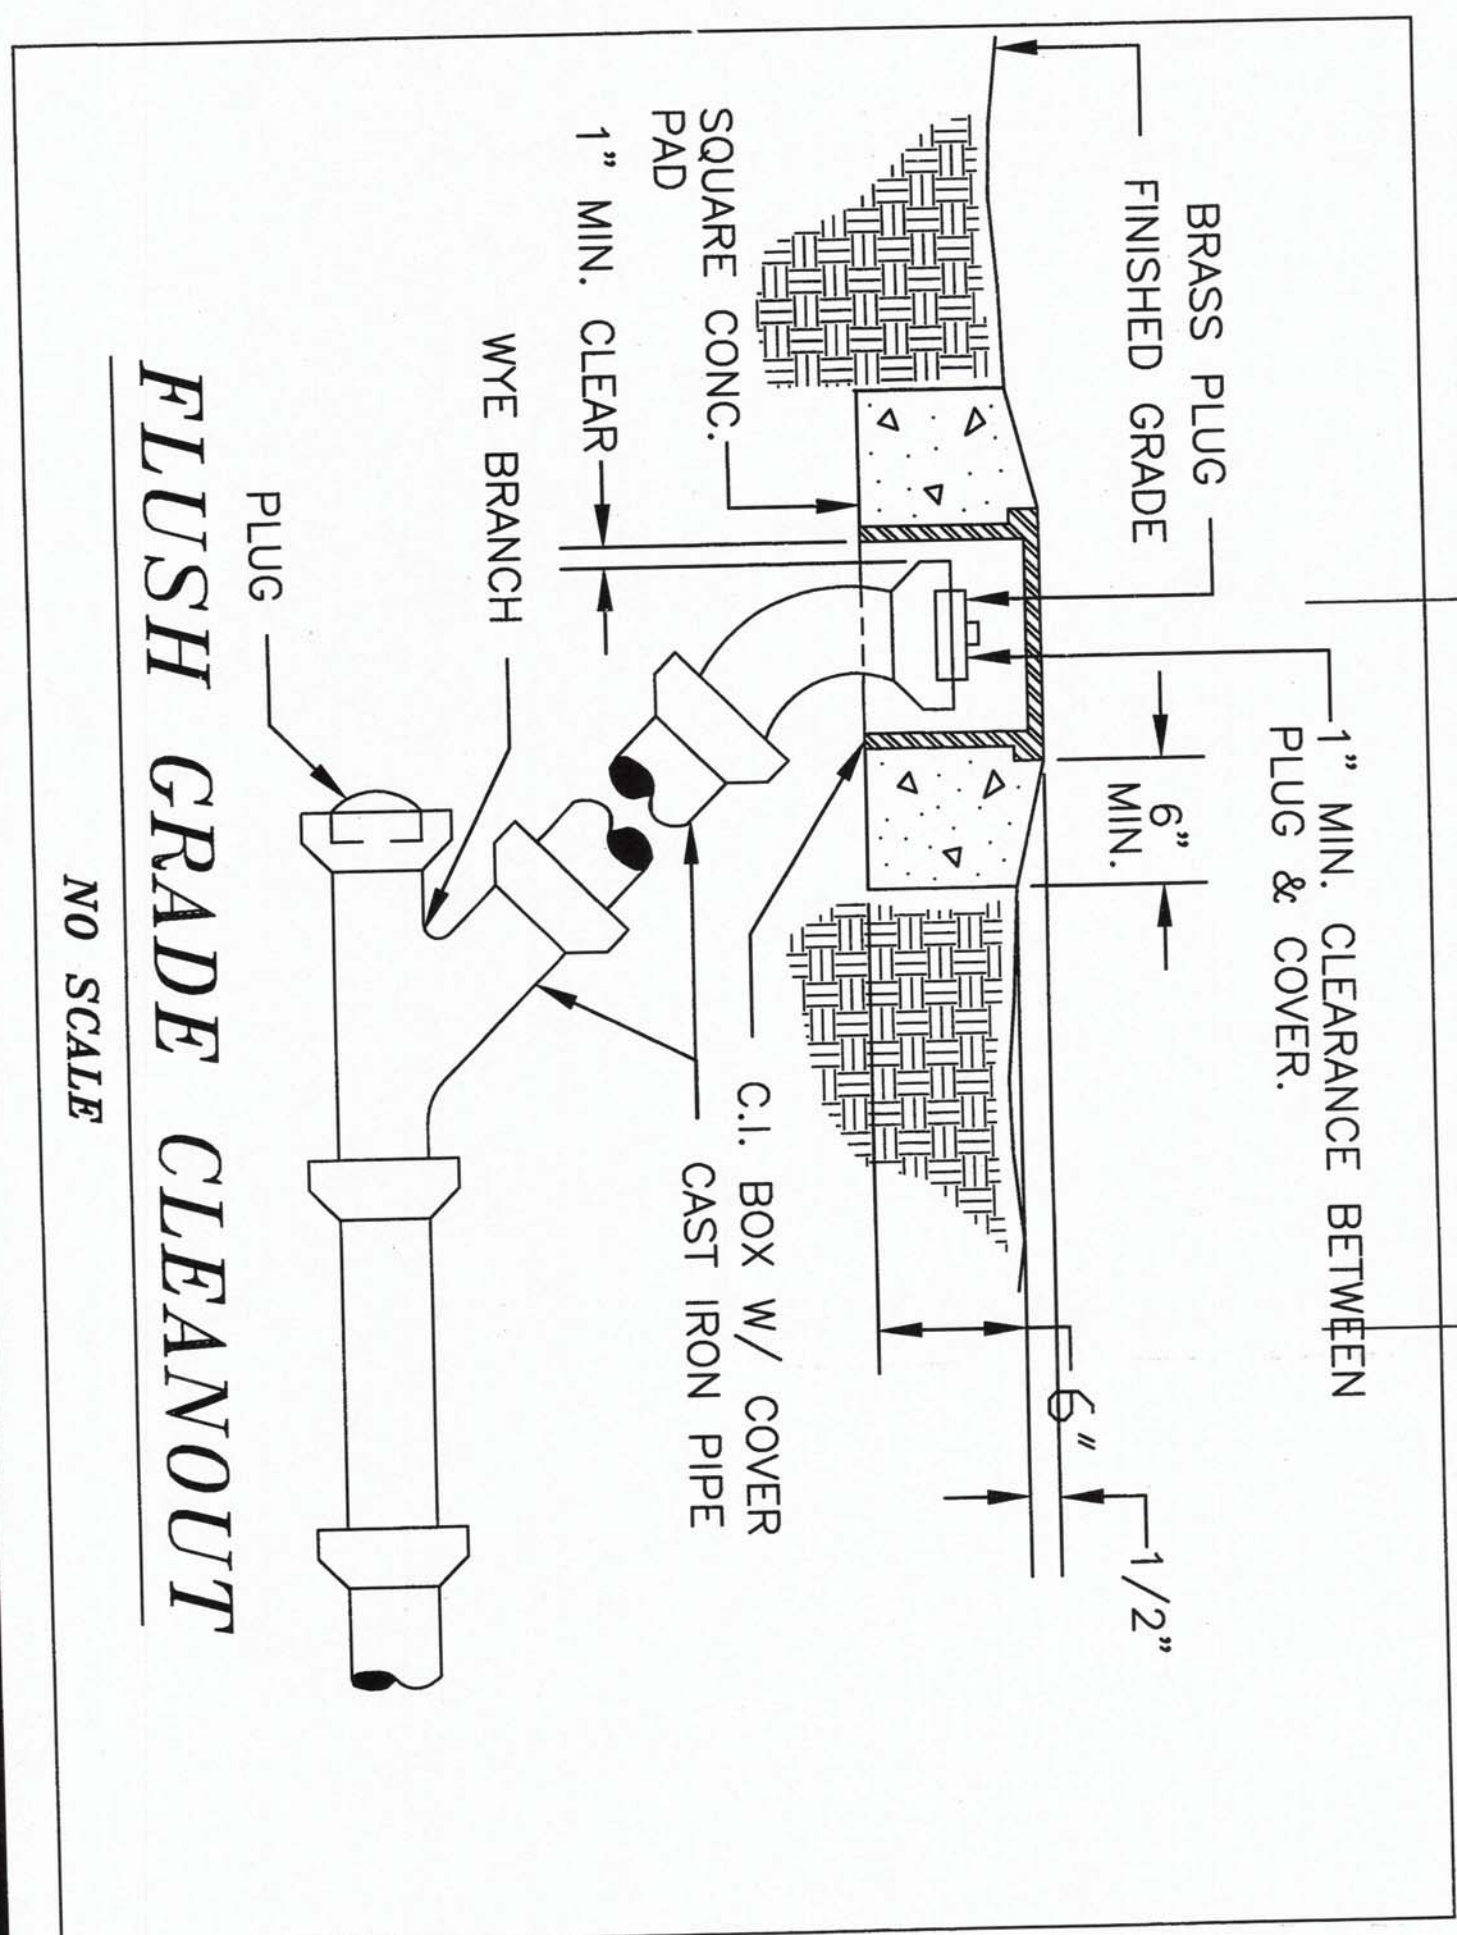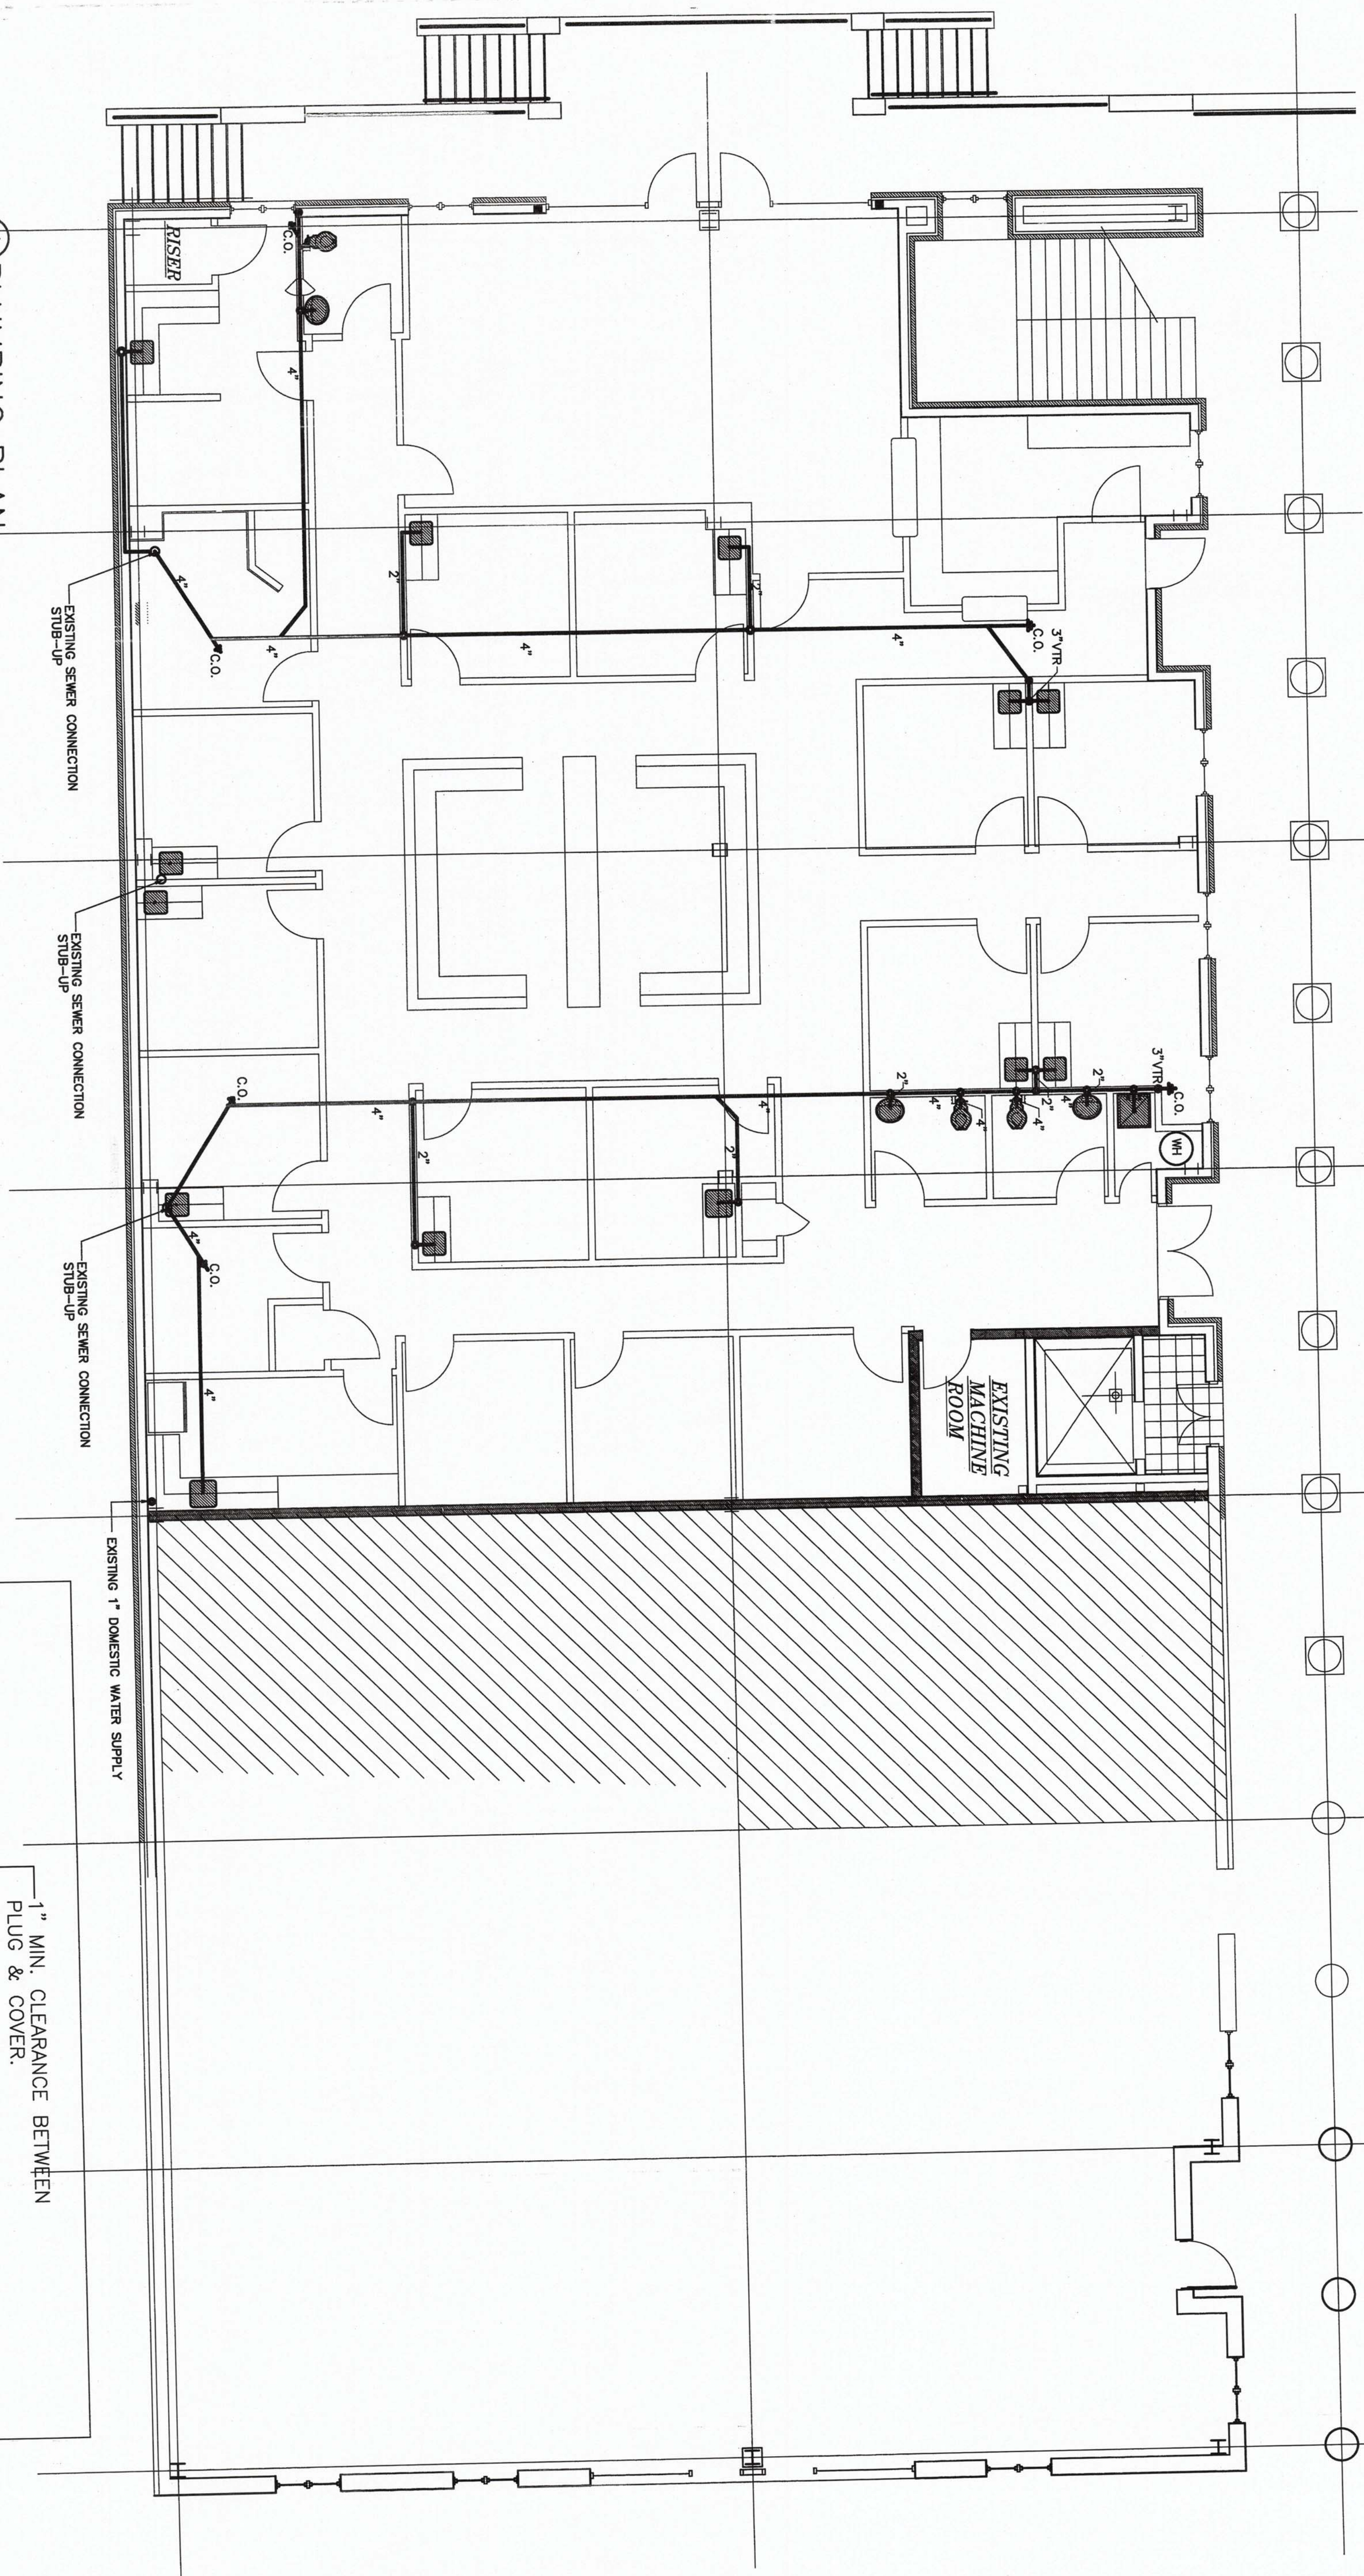


Olde Towne Building 2A
Merit Health
Jackson Street, Ridgeland, Mississippi

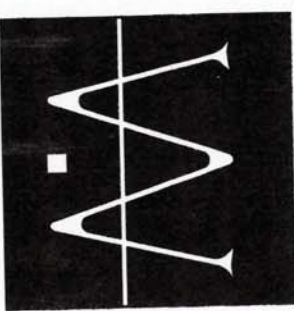

REVISIONS BY

1 POWER PLAN
SCALE: 3/16"=1'-0"

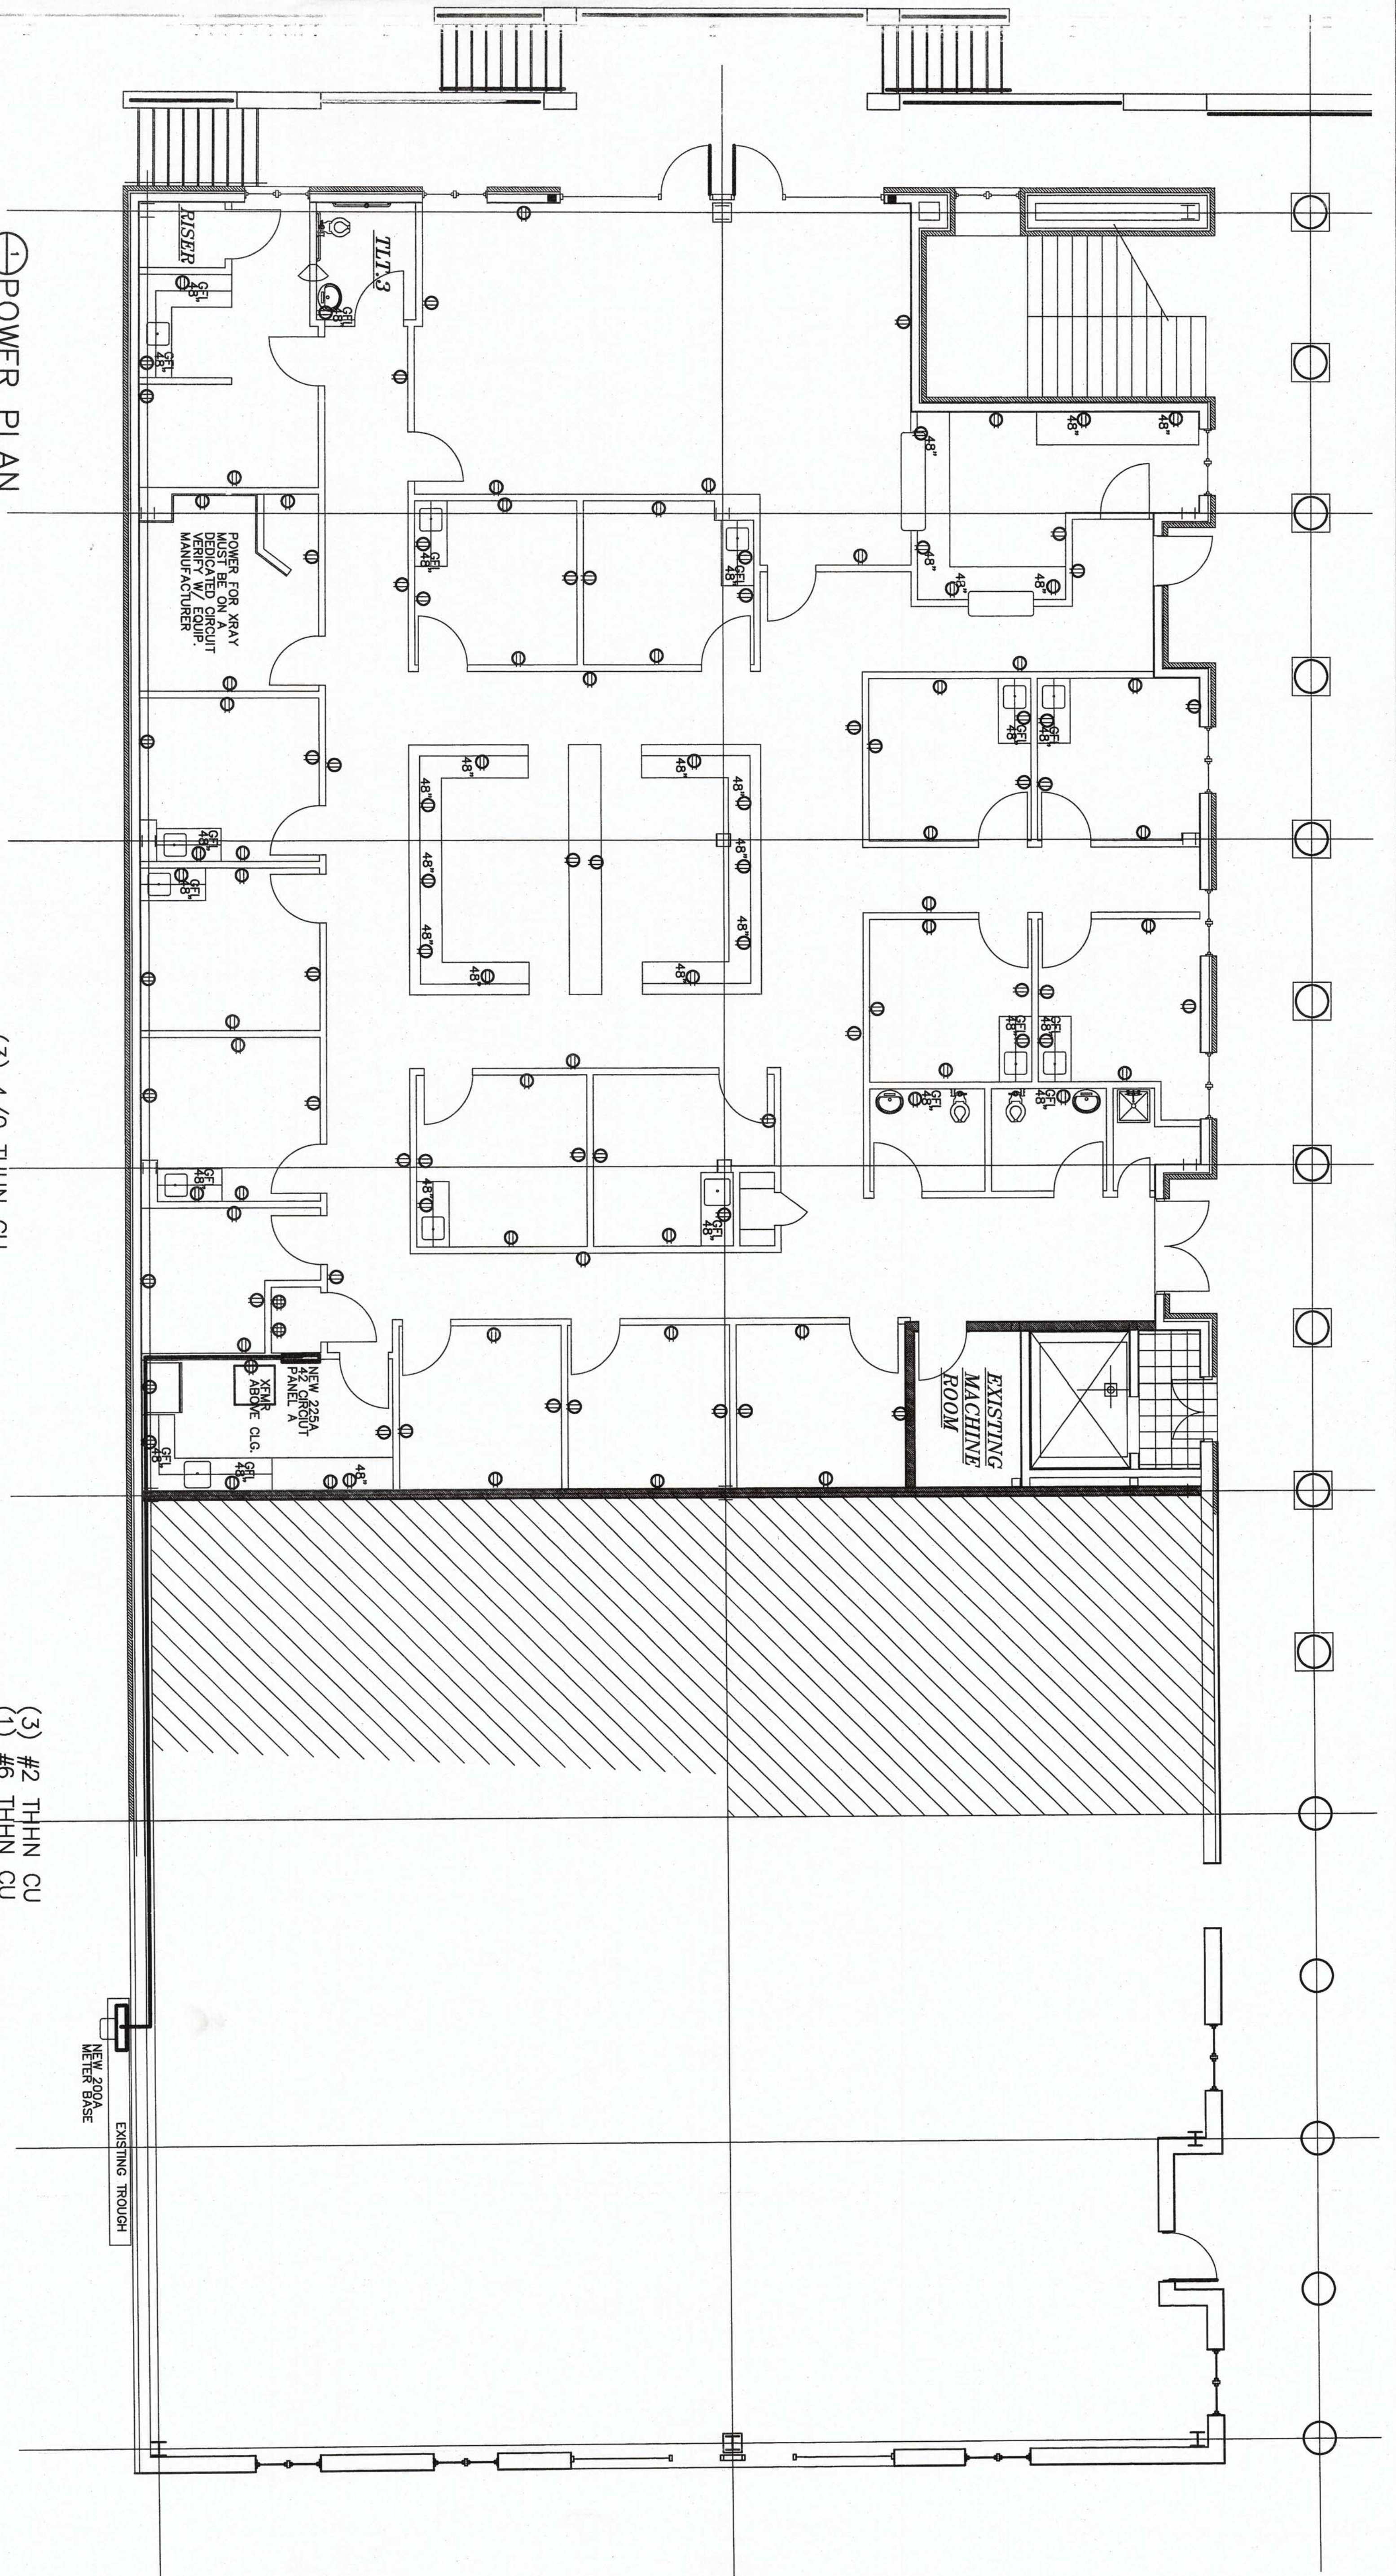

(3) 4/0 THHN CU
(1) 1/0 GRD
2" CONDUIT

(3) #2 THHN CU
(1) #6 THHN CU
1-1/2" CONDUIT

120/280V
225AMP
PANEL A

XFMR

(3) #2 THHN CU
(1) #6 THHN CU
1-1/2" CONDUIT

NEW 100A
12 ENCLOSED
CIRCUIT BREAKER

EXISTING POWER
SERVICE

EXISTING TROUGH


NEW 100A METER

NEW 100A 3PH
DISCONNECT

NEW 200A
METER BASE

EXISTING TROUGH


1 POWER RISER DIAGRAM
SCALE: NTS

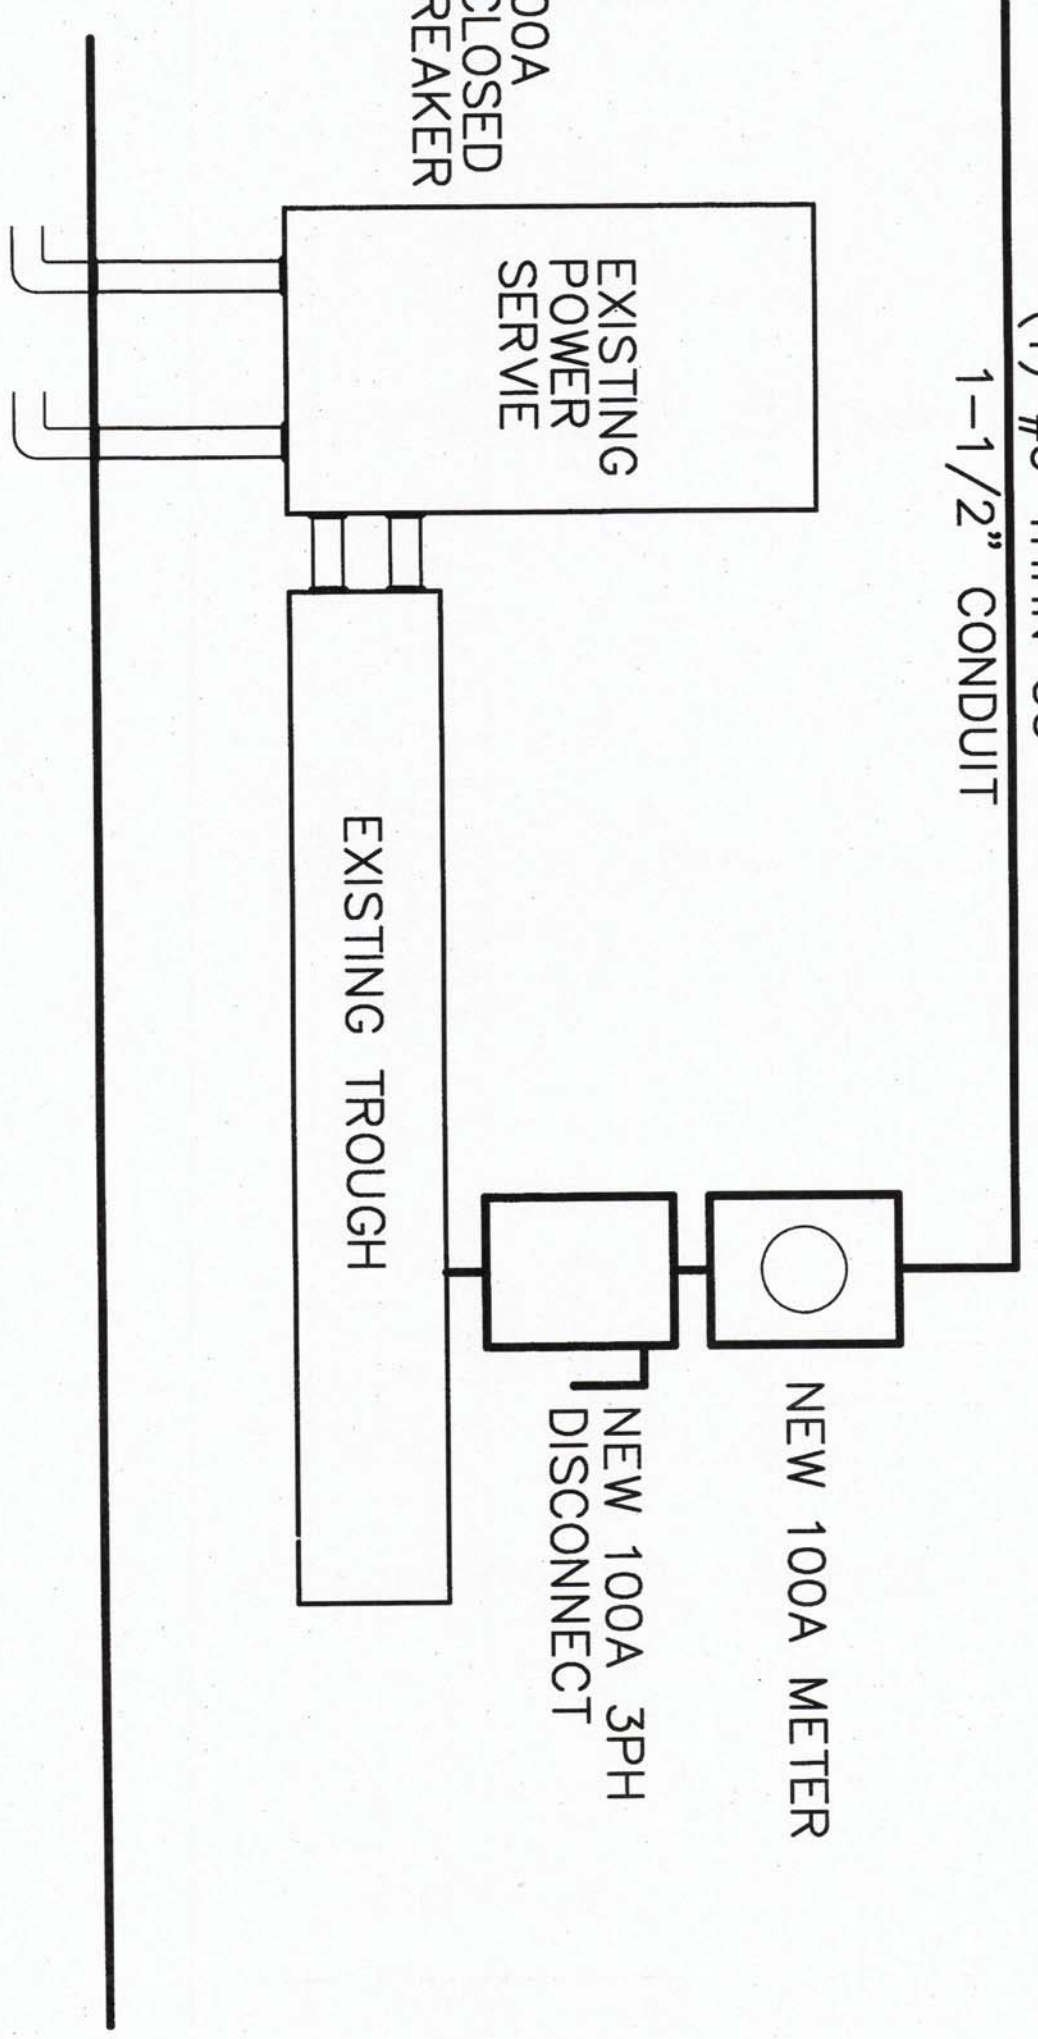

Olde Towne Building 2A
Merit Health
Jackson Street, Ridgeland, Mississippi

WOOLDRIDGE & ASSOCIATES
105 CENTRAL AVENUE
RIDGELAND, MS 39167
601-965-4811 / 601-965-4898 FAX
www.wooldridge.com

REGISTERED ARCHITECT
2685
Daniel B. Wooldridge
Jackson, MS

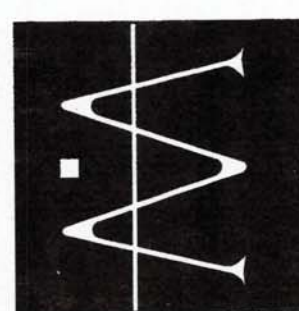

REVISIONS	BY


Drawn: _____
Checked: _____
DATE: SEPTEMBER 16, 2017
SCALE: _____
JOB NO.: _____
SHEET: _____

E1.0

OF SHEETS


1 LIGHTING PLAN
SCALE: 3/8"=1'-0"

- EXIT & EMERGENCY FIXTURE WITH BATTERY BACKUP
- EMERGENCY FIXTURE WITH BATTERY BACKUP
- 18" TROFFER 48" FOUR BULB FLUORESCENT FIXTURE
- RECESSED CAN FIXTURE FLUORESCENT

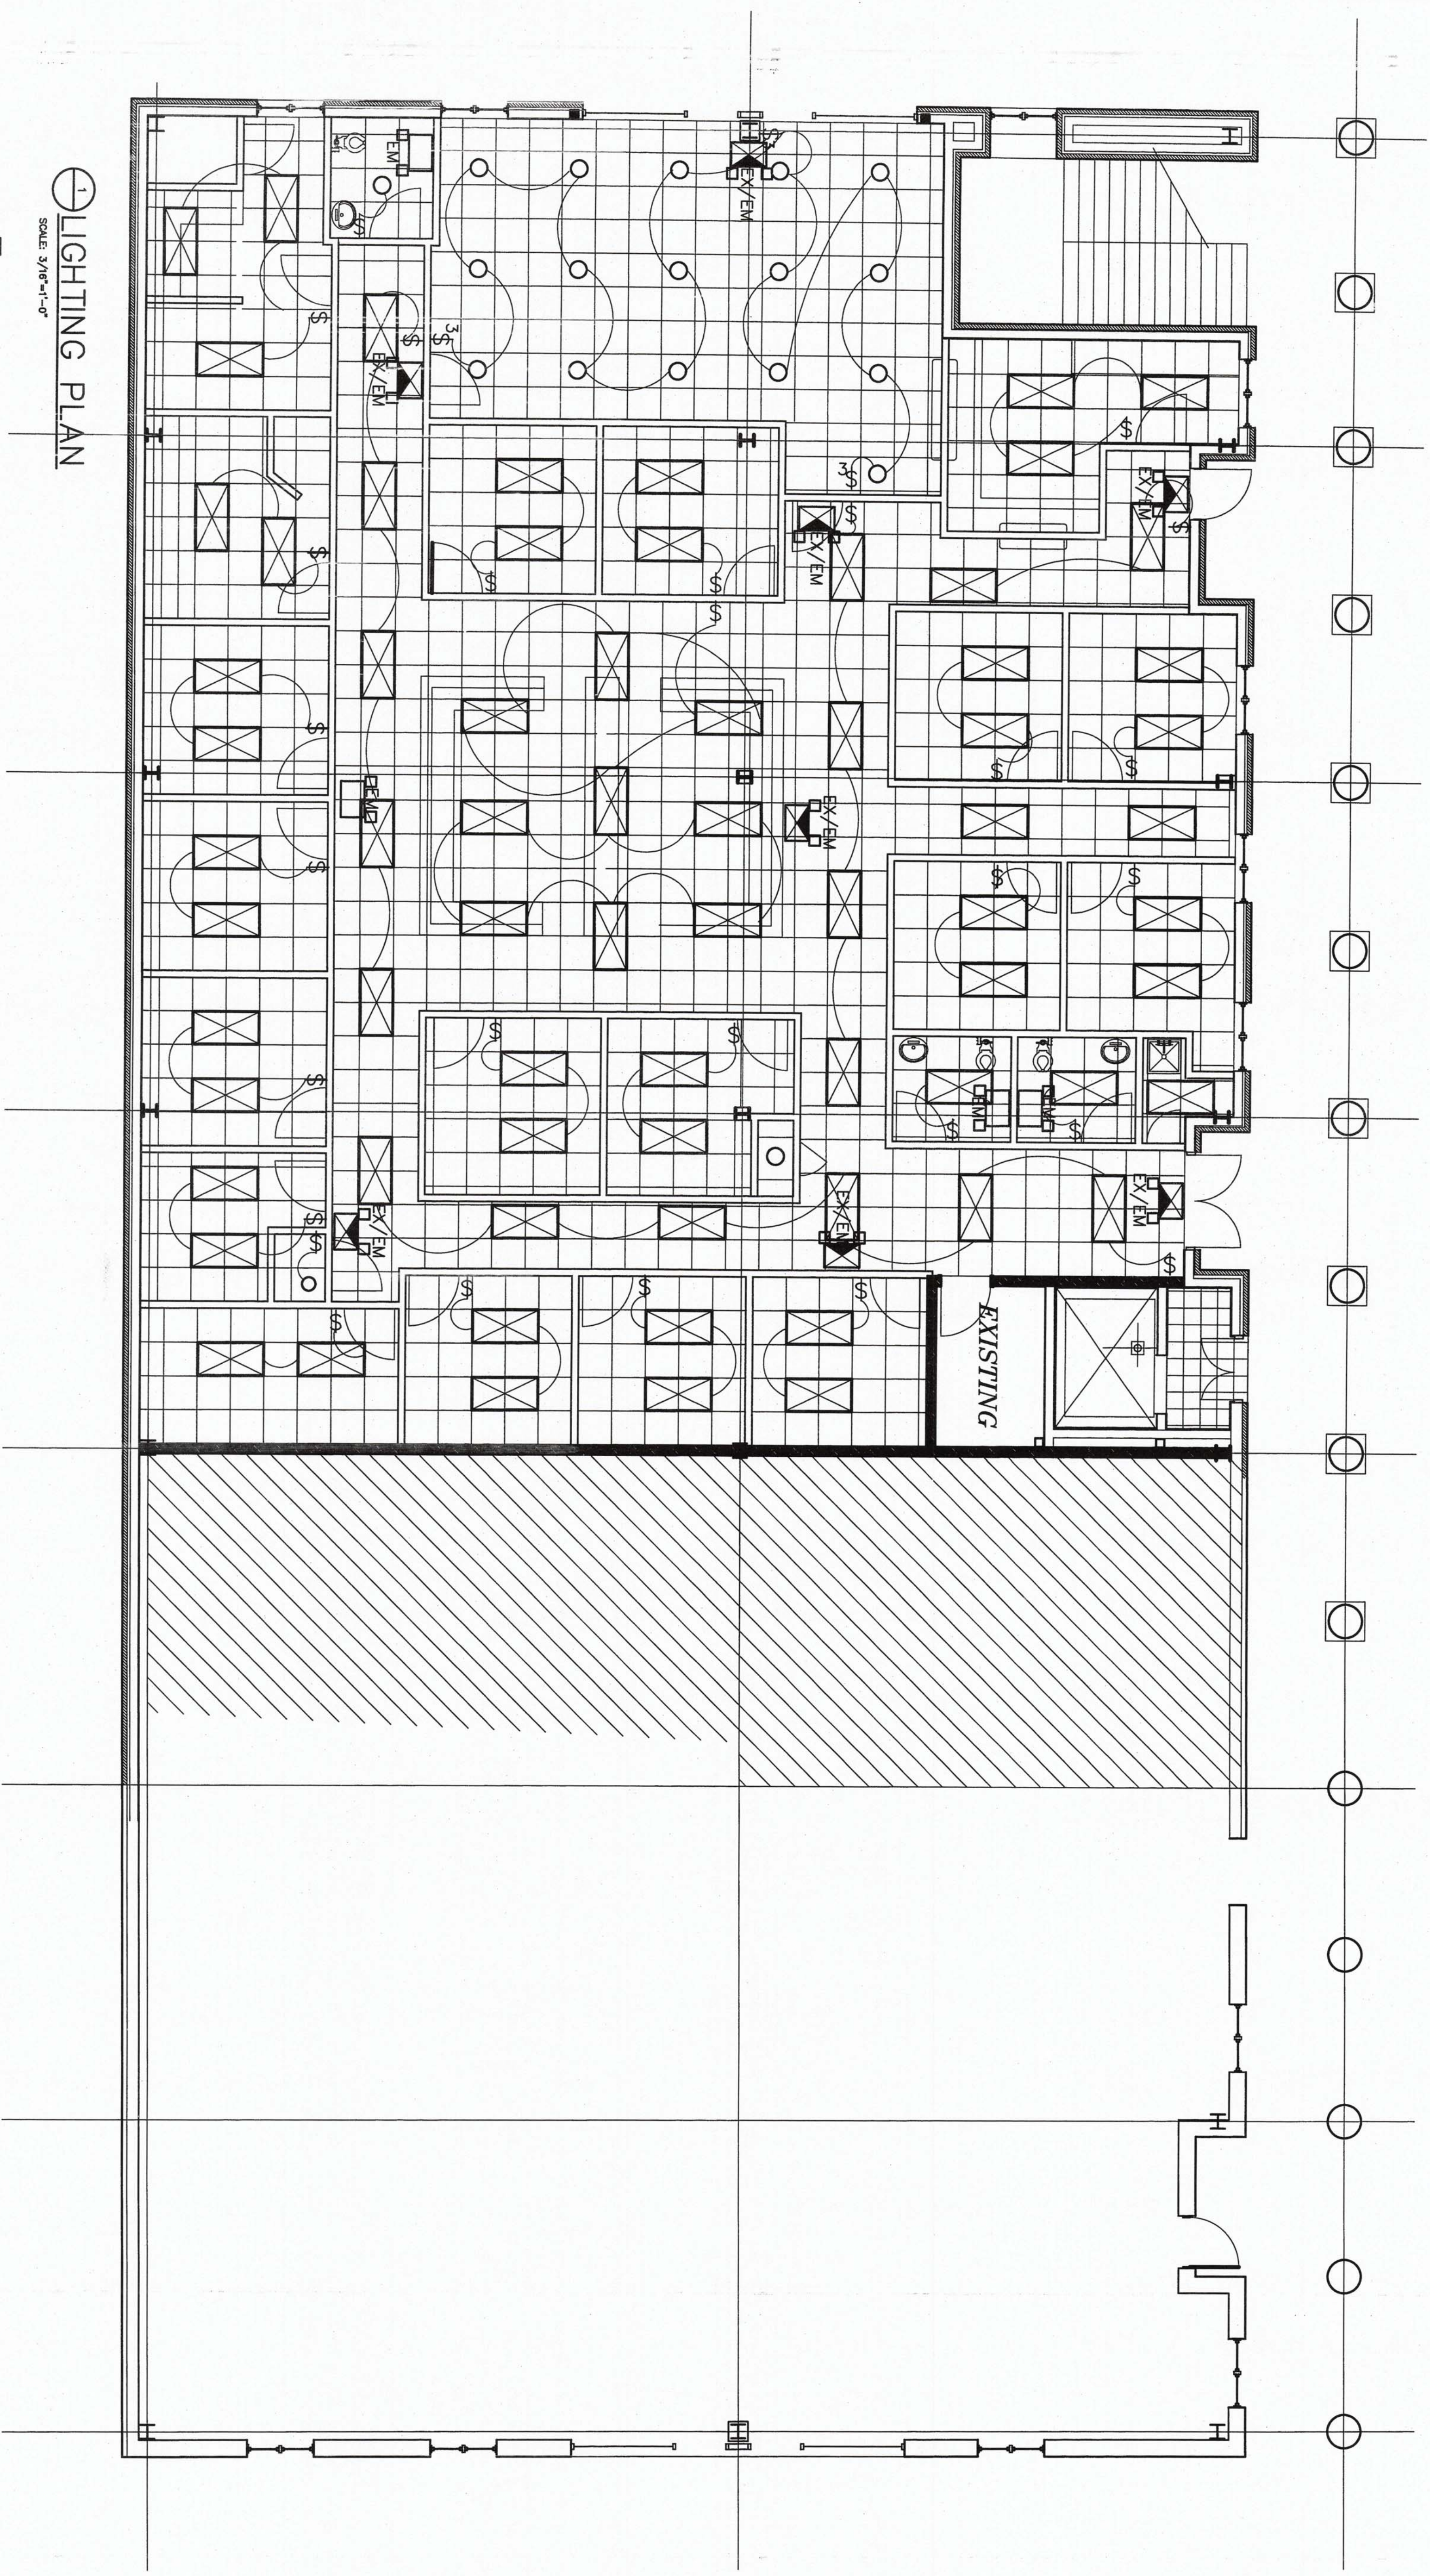

Olde Towne Building 2A
Merit Health
Jackson Street, Ridgeland, Mississippi

WOOLDRIDGE & ASSOCIATES
105 CENTRAL AVENUE
RIDGELAND, MS 39157
REG. ARCH. 2355
Daniel B. Wooldridge
JUL 17 2007
MISSISSIPPI

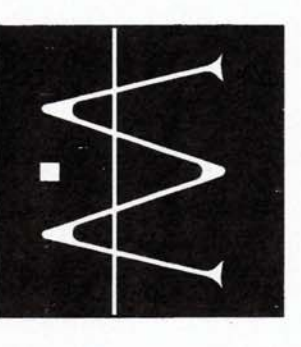

REVISIONS BY

DRAWN	CHECKED
DATE	DATE
SCALE	SCALE
SHEET	SHEET
JOB NO.	JOB NO.
E1.1	