


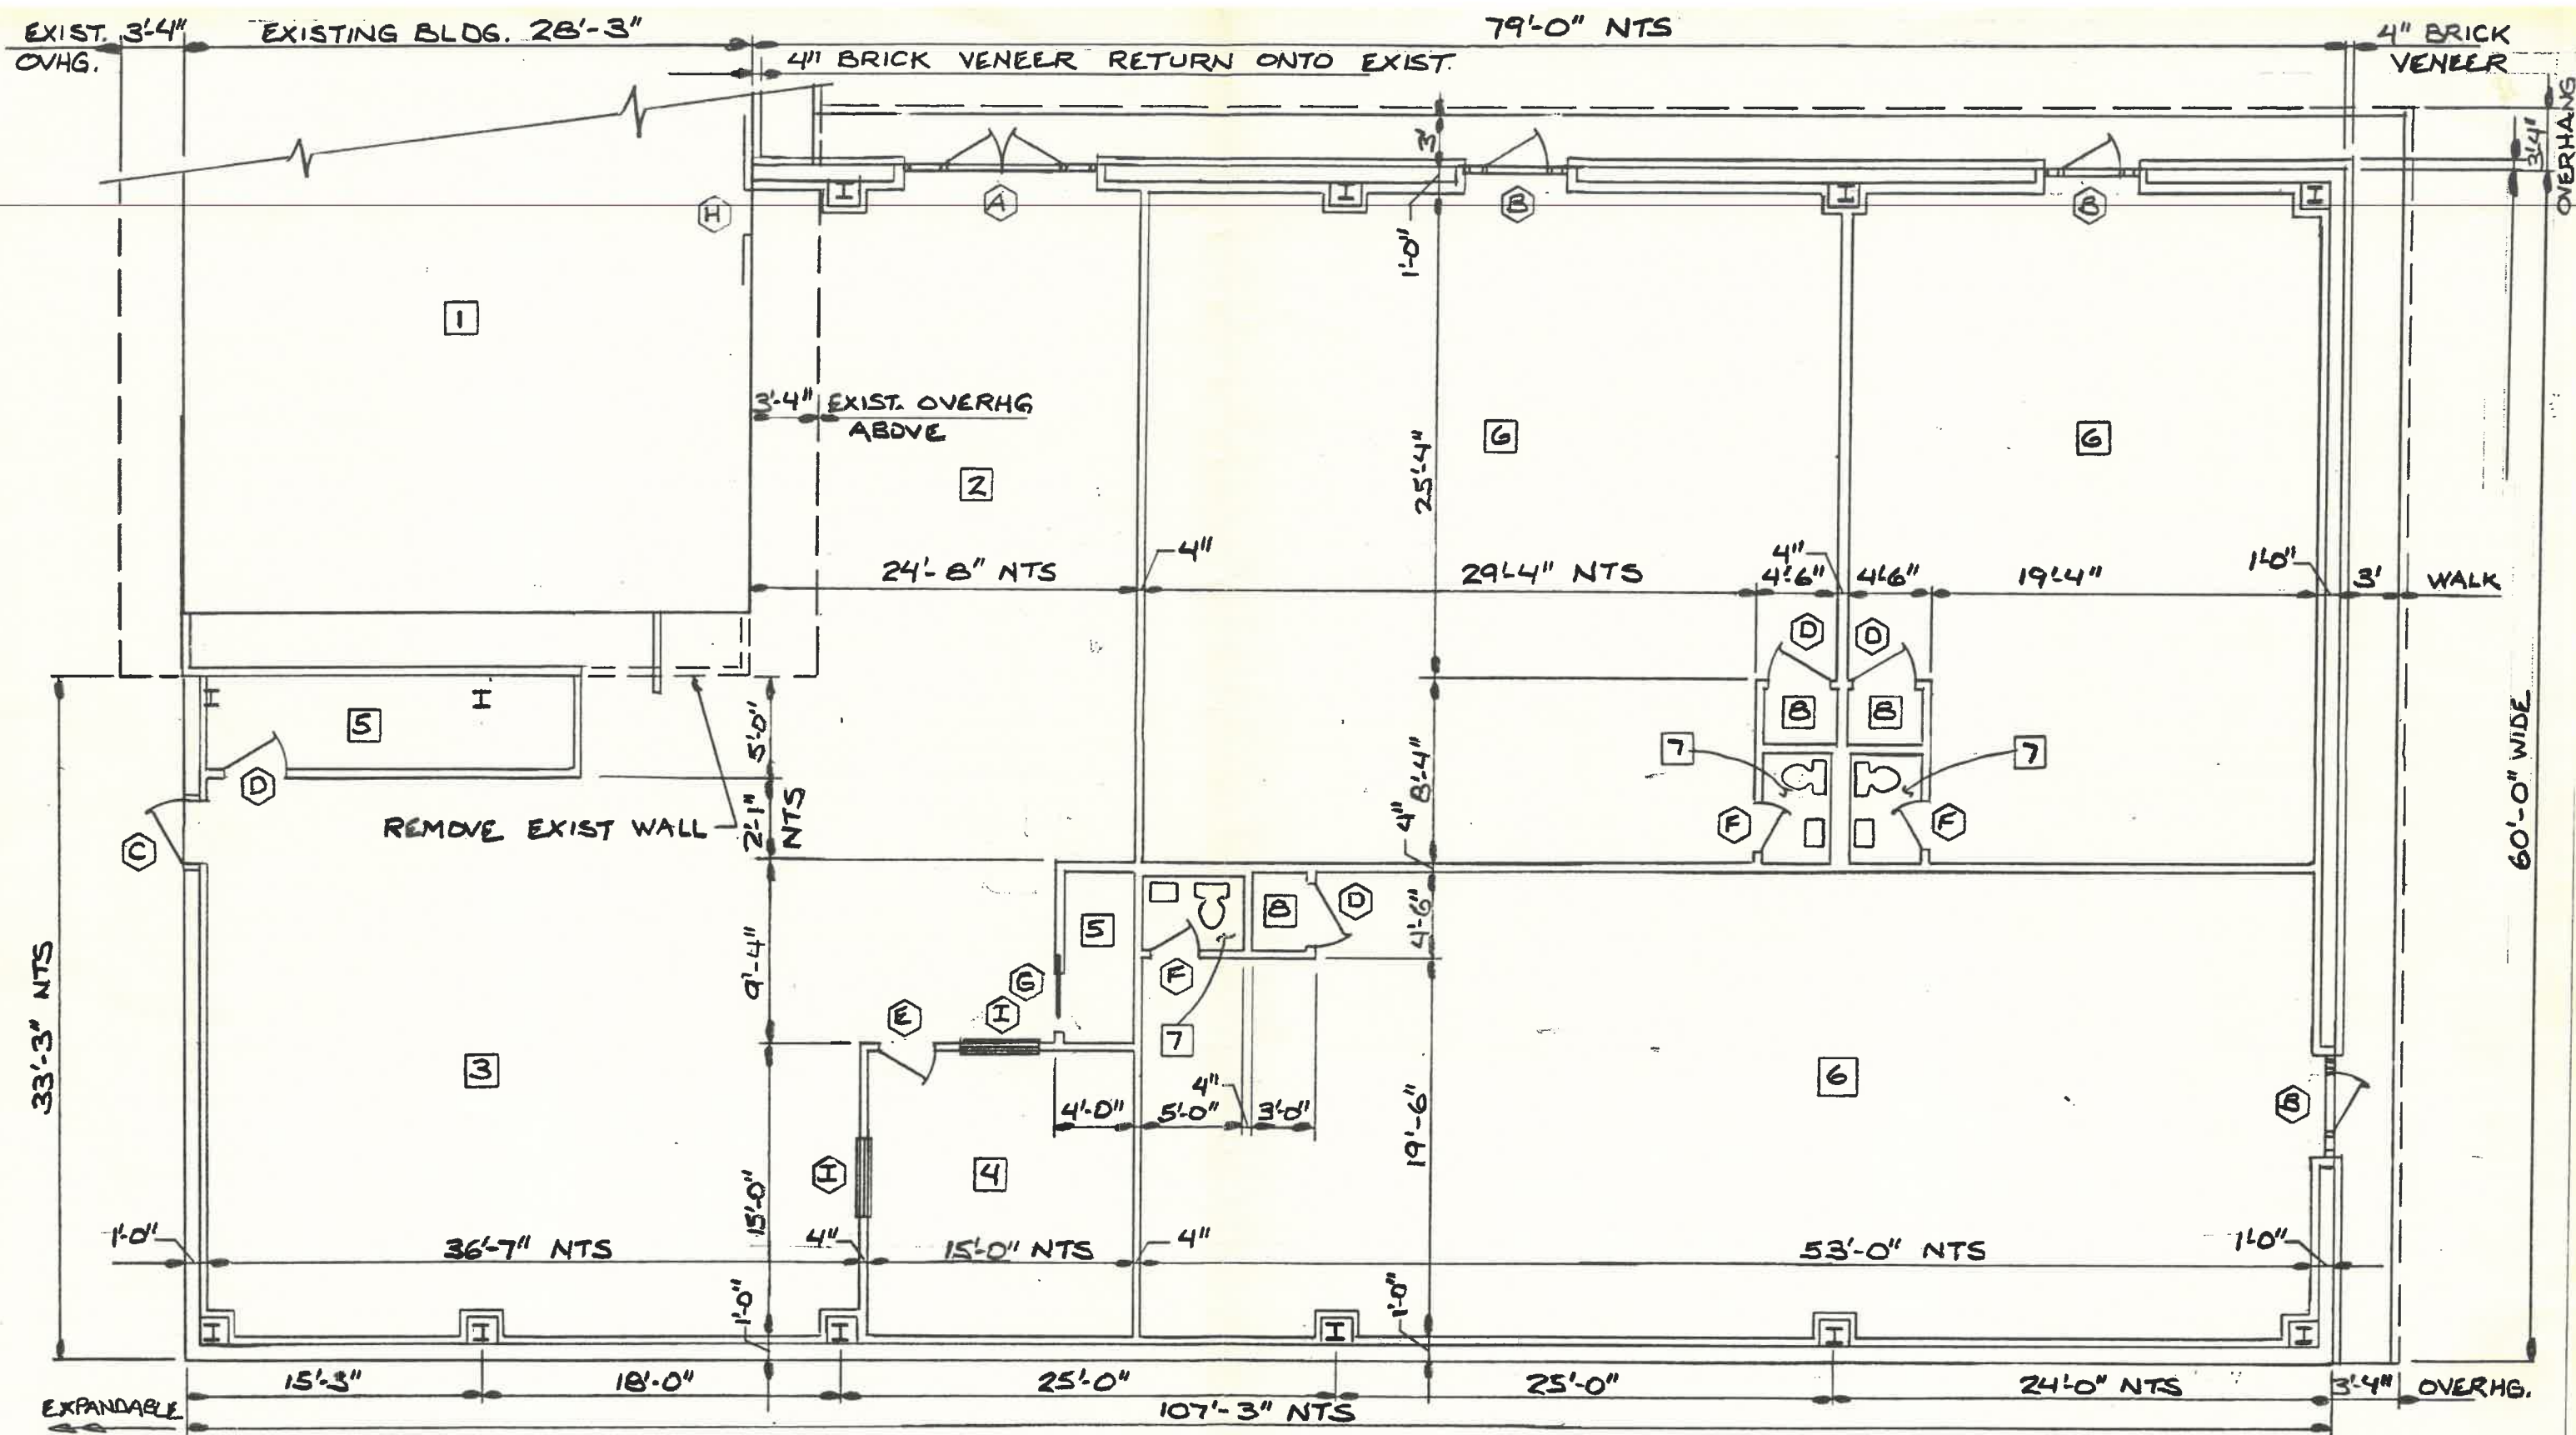

PLAN

1/8" = 1'-0"

REV. 1-19-88
REV. 1-16-88
REV. 1-7-88

ED DUPONT & ASSOCIATES, INC.
Consulting Engineers
8220 Hidden Lake Drive South
Jacksonville, Florida 32216
904-737-4174

Edwin R. DuPont, PE #14590

PEEPLER CONST. CO., INC.
8846 Washington Avenue
P. O. Box 9066
Jacksonville, FL 32208
904-765-2666

New Facility for
Peters' Business Center
Jacksonville, Florida

FLOOR PLAN

Date: 1-4-88

Scale: 1/8"=1'-0"

Drwg: 3 of 9