



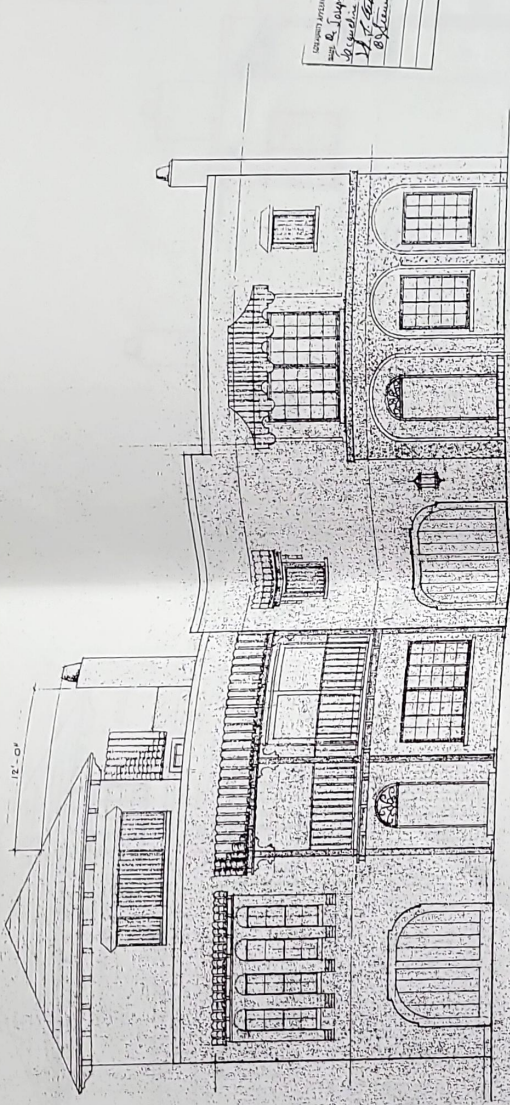

FRONT ELEVATION
SCALE: 1/4" = 1'-0"

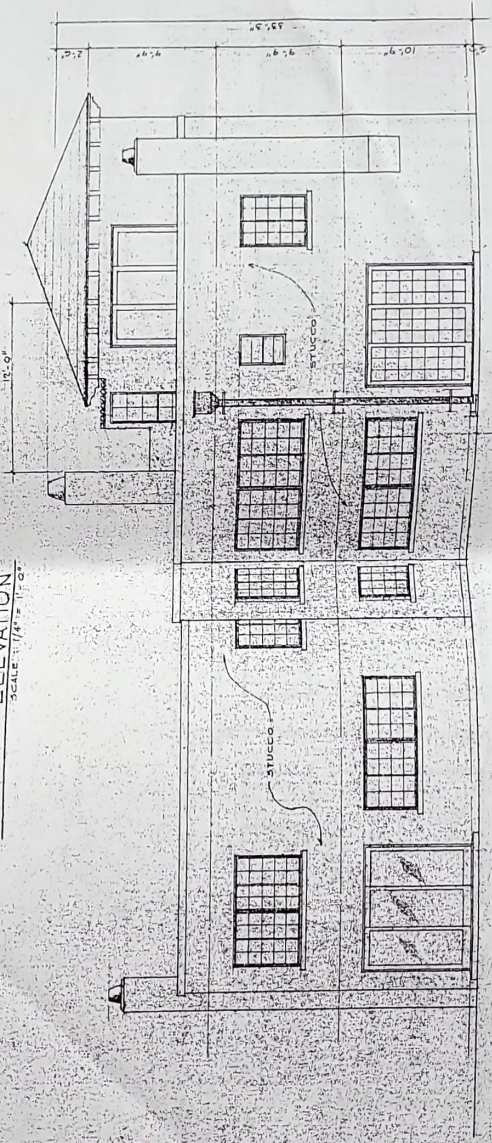

REAR ELEVATION
SCALE: 1/4" = 1'-0"

CONSTRUCTION OF THIS ELEVATION
BY
J. GRANGER McDANIEL
ARCHITECT
DATE
1/1/1911




I. GRANGER McDANIEL
150 EAST PALMETTO PARK ROAD, SUITE 425
MOBILE, ALABAMA 36688


A FOURPLEX
For Mr. & Mrs. E. D. JOSEPH
Belt Air Drive
HIGHLAND BEACH, FLORIDA

MATT SUMNER
 CONSULTING
 ARCHITECT
 DATE
 DRAWN
 CHD
 APPD
 ISSUED

Amended plan / amendment
 11/15/78
 12/2/78
 Joseph A. Baker
 President

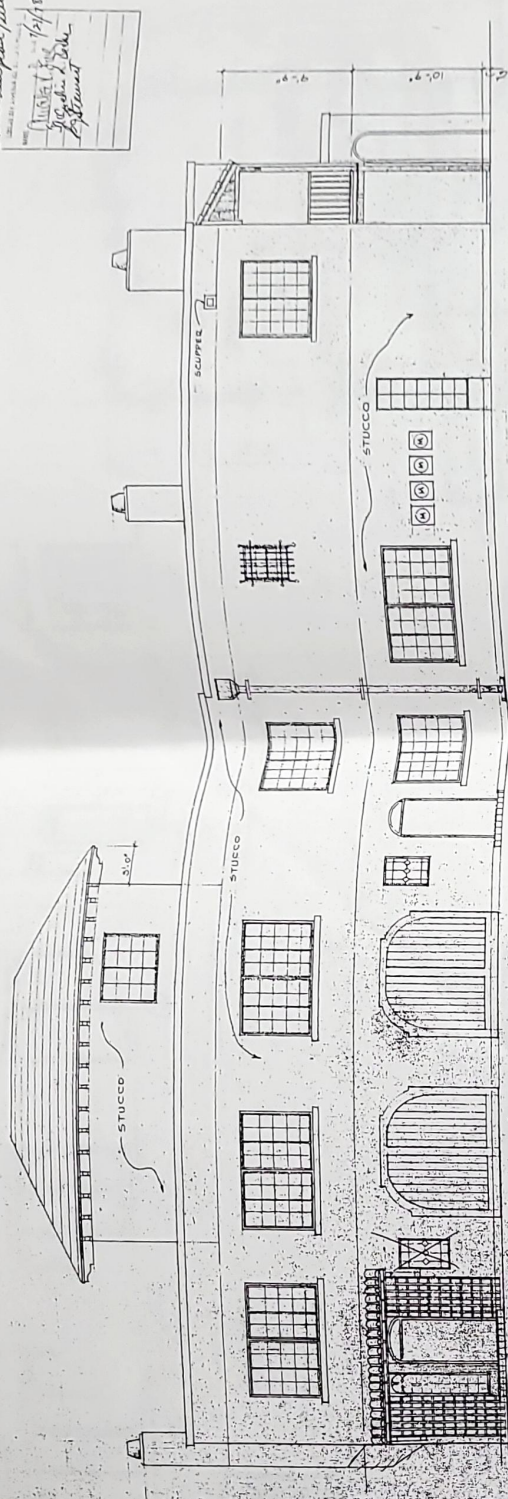

WEST ELEVATION

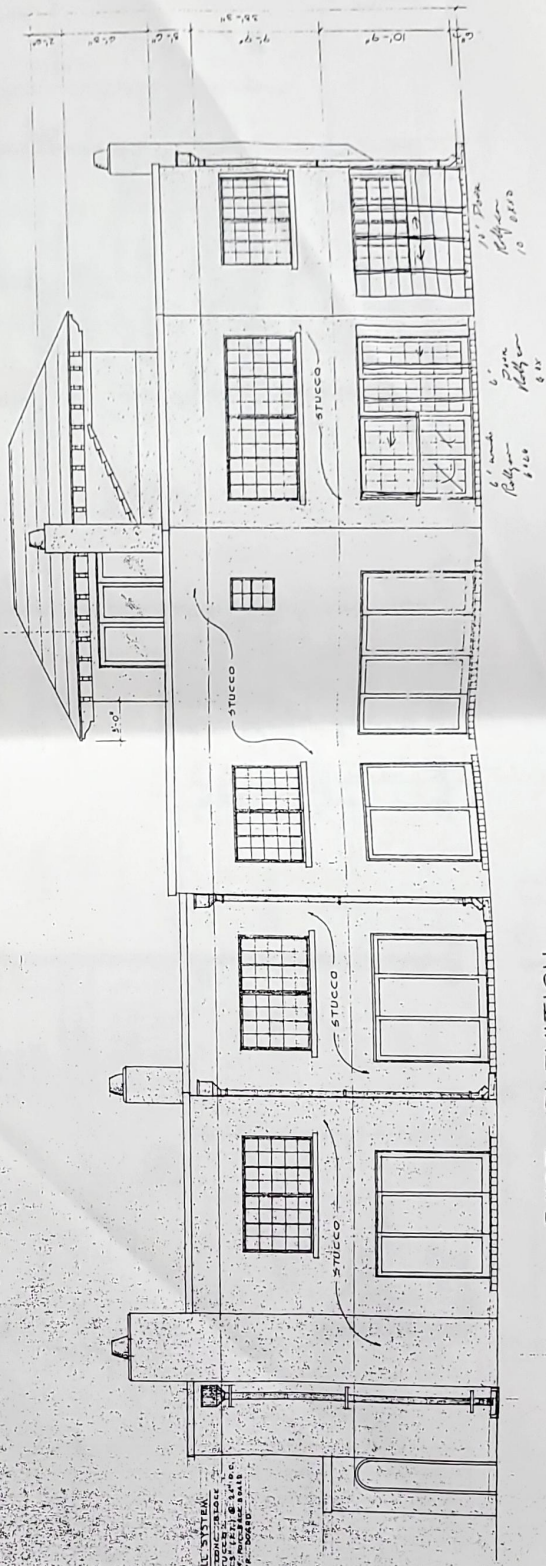

EAST ELEVATION




I. GRANGER McDANIEL
 ARCHT
 100 N. E. 10th St.
 MIAMI, FLORIDA 33132

AIA
 ARCHT
 100 N. E. 10th St.
 MIAMI, FLORIDA 33132


A FOURPLEX
 FOR MR. & MRS. D. JOSEPH
 DEL AIR DRIVE
 HIAWATHA BEACH, FLORIDA

HATT SCHNEIDER
 ARCHT
 100 N. E. 10th St.
 MIAMI, FLORIDA 33132

FIRST FLOOR
 SCALE 1/8" = 1'-0"

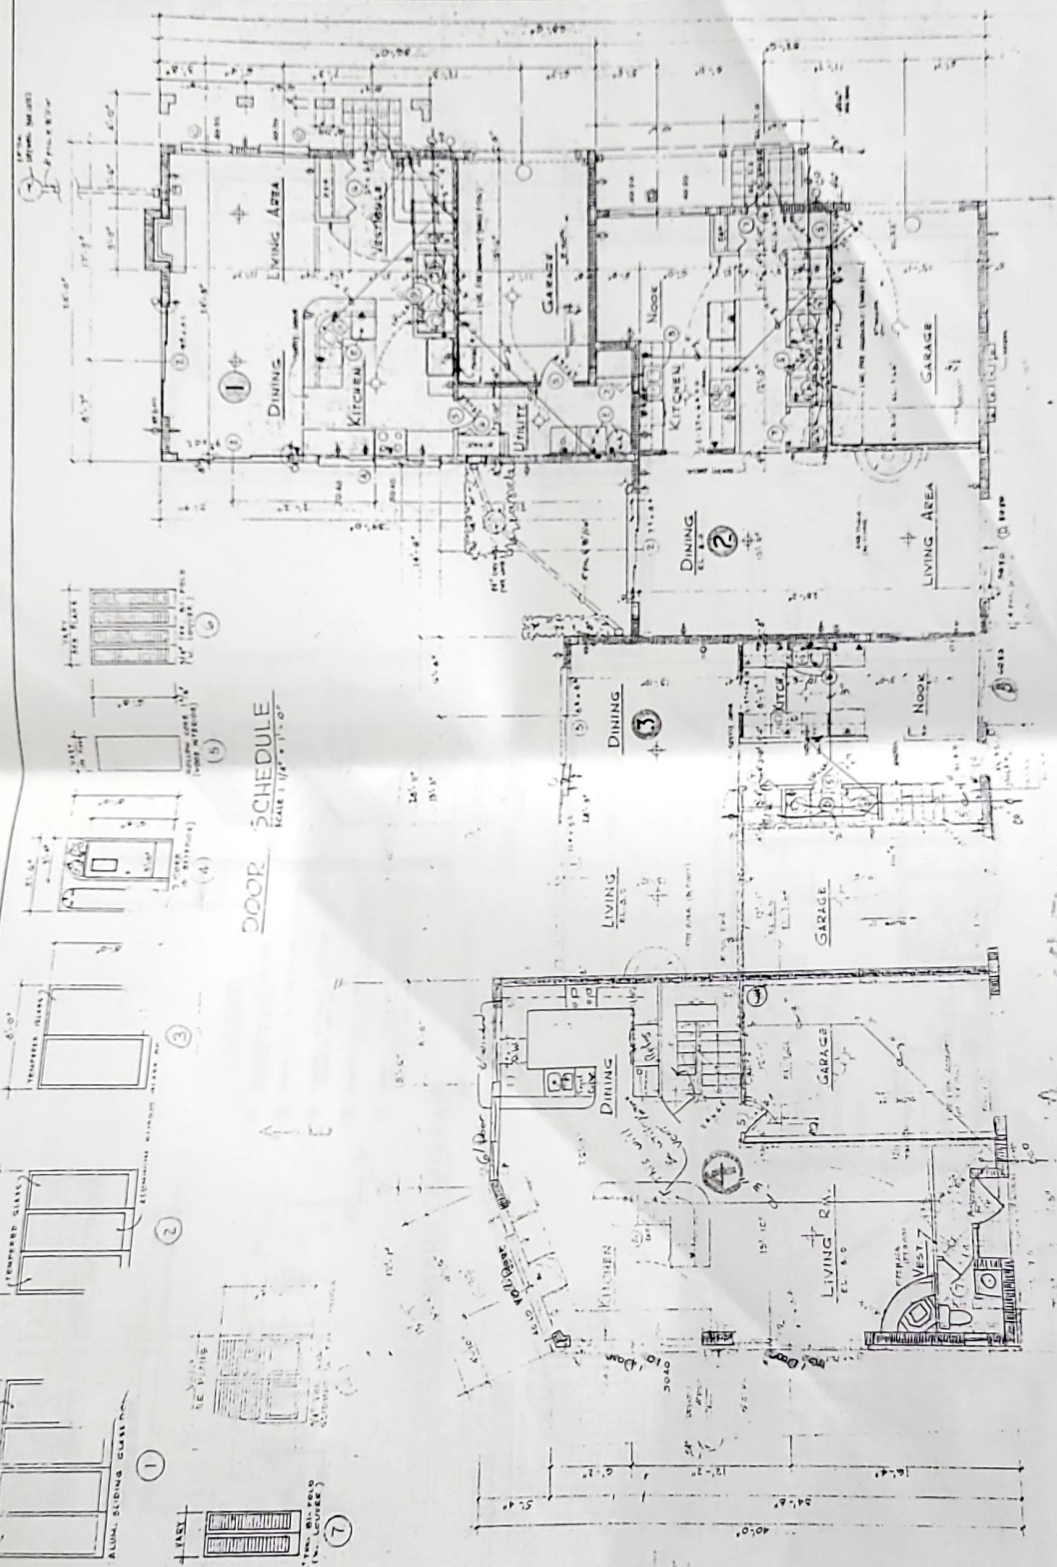


DOOR SCHEDULE
 SCALE 1/8" = 1'-0"

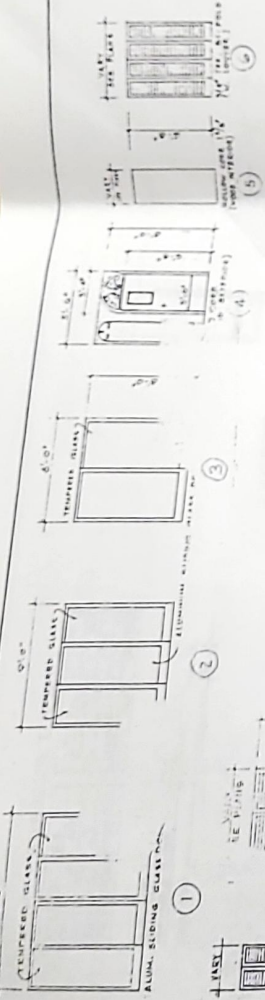

NOTE: ALL DIMENSIONS ARE IN FEET AND INCHES. ALL DIMENSIONS ARE TO FACE UNLESS OTHERWISE NOTED.

IDENT.	S.D.	N.S.D.
PNC-1	110.8 AMPs	RANGE (AVE 80V 71 AMP
PNC-2	120.9 "	AVE (6) 8-140V 17.9 "
PNC-3	110.7 "	EXPOSE (15) 840V 76 "
PNC-4	151.7 "	TOTAL SOLW AMP

C.D. - 1000
 FIRST 190, C. 100%
 REMAINING A C 99%
 Unq. Load


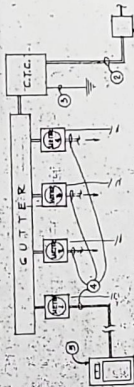


- ① WIRE-GROUND JUNCTION BOX
(CONSULT P. PL.)
- ② SERVICE: (2) 3/4" 900 KVA TAP TO 3500.
- ③ GROUND: 1" - 4/6 Cu. in 1" DIA
SECURE TO HOUSING
- ④ FEEDER: (PUL 12.5) 3" - 4/6 INCU PVC
TO 3/4" 900 KVA TAP, 115E
- ⑤ PANEL: 600 TO 115E, 1000 KVA TAP TO 115E
1" 4/6 INCU PVC TO 3/4" 900 KVA TAP
150/60E: 1" - 3/4 Cu. INCU TO PUL PANEL

ELECTRICAL RISER DIAGRAM

1.016: J.V. JAMES should be provided to
WATER OFFICIAL.

STAIR SECTION
SCALE: 1/4" = 1'-0"
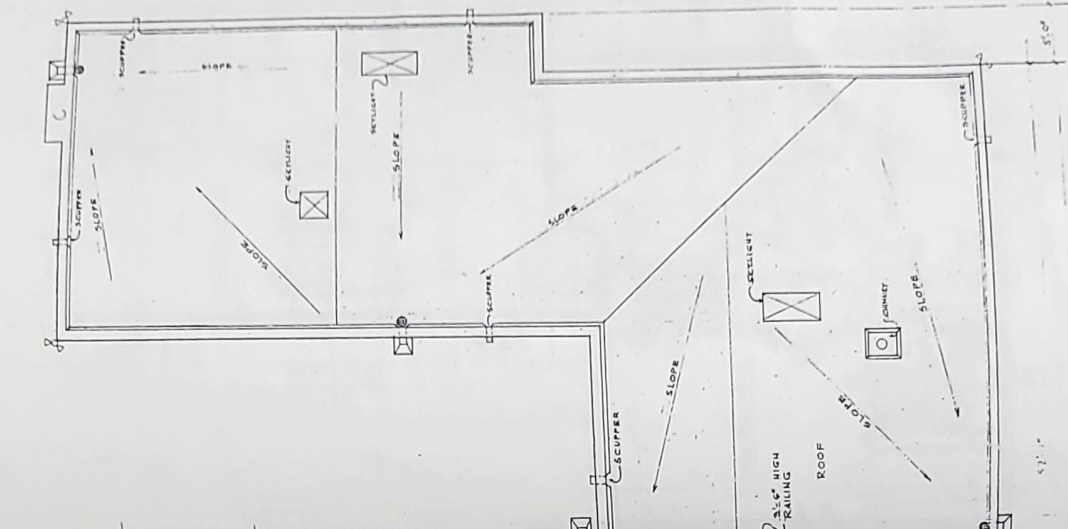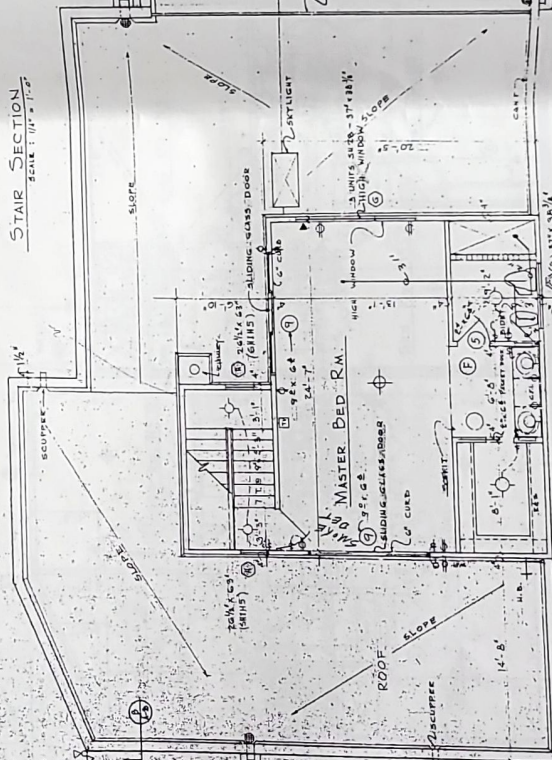
$$\Delta G_{\text{CAL}} : 114^\circ = 1' \cdot 0'$$


THIRD FLOOR & ROOF PLAN

5,16

A FOURPLEX
for Mr. & Mrs. E. Di Joseph
Bel Air Drive
HIGHLAND BEACH, FLORIDA



I. GRANGER McDANIEL
100 EAST PALMERITO PARK ROAD, SUITE 410
DOW BRISTOL, BRISTOL AVENUE
DOW BRISTOL, BRISTOL AVENUE



A-6

13300 CF

NOTE:
SINK/TOILET SYSTEM - PIPE SIZE, HEAD LOCATIONS AND STANDPIPES
AS REQUIRED BY SOUTHERN STANDARD BUILDING CODE.

SECOND FLOOR SCALE: 1/4" = 1'-0"


A 3




I. GRANGER McDANIEL ARCHITECT
100 EAST PALMETTO PARK ROAD, SUITE 200
FORT MYERS, FLORIDA 33901
TEL: 941-933-1111 FAX: 941-933-1112
WWW.GRANGER-MCDANIEL.COM

A FOURPLEX
FOR MR. & MRS. F. D. JOSEPH
DEVELOPER: HIGHLAND BEACH, FLORIDA

MATT SUMNER
ARCHITECT
DATE: 10/1/01
DRAWN: [Signature]
CHECKED: [Signature]
PROJECT NO. 01000

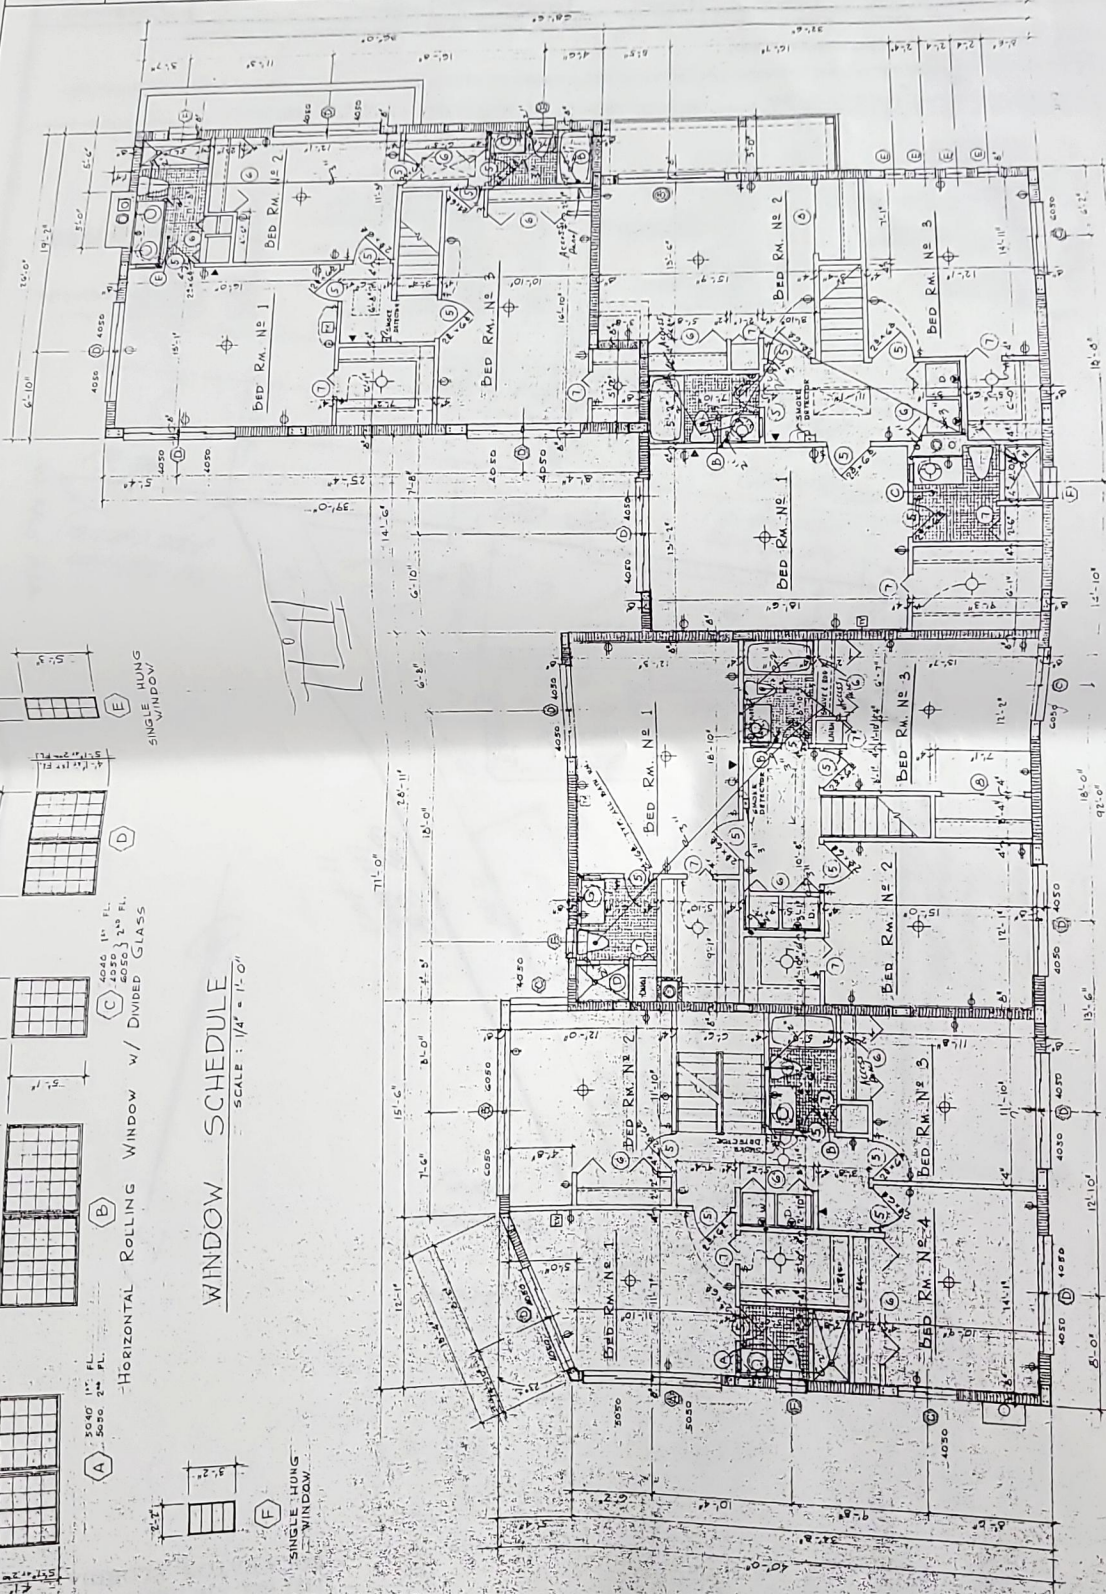

WINDOW SCHEDULE SCALE: 1/4" = 1'-0"

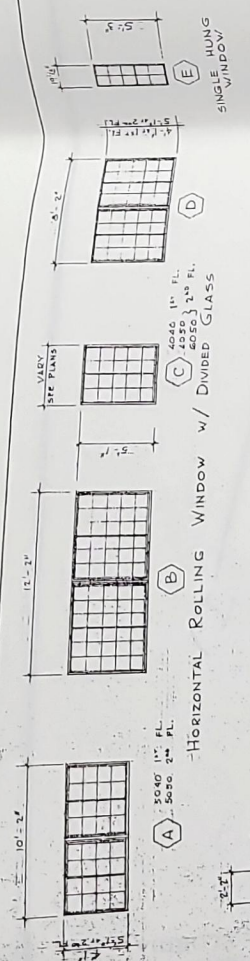

SCALE: 1/4" = 30'	DRAWN BY: <i>[Signature]</i>	CHECK BY: <i>[Signature]</i>	FB/PD: <i>[Signature]</i>	DATED: 10/26/01	REVISIONS:	JOB NO. 220610
-------------------	------------------------------	------------------------------	---------------------------	-----------------	------------	----------------


PROFESSIONAL SURVEYORS AND MAPPERS
License Number 6677

STATE OF FLORIDA
ONLY EASEMENTS, RIGHT OF WAYS ETC, READILY KNOWN ARE SHOWN. NO RESEARCH OTHERWISE HAS BEEN MADE.

MARK D. STUQUIS, P.S.M.
REGISTERED LAND SURVEYOR AND MAPPER No. 4629

— NORTH ARROW ORIENTATION, FIELD DETERMINED

1	LA	ANCHOR EASMENT
2	LA	ANCHOR EASMENT
3	LA	ANCHOR EASMENT
100	LA	ANCHOR EASMENT

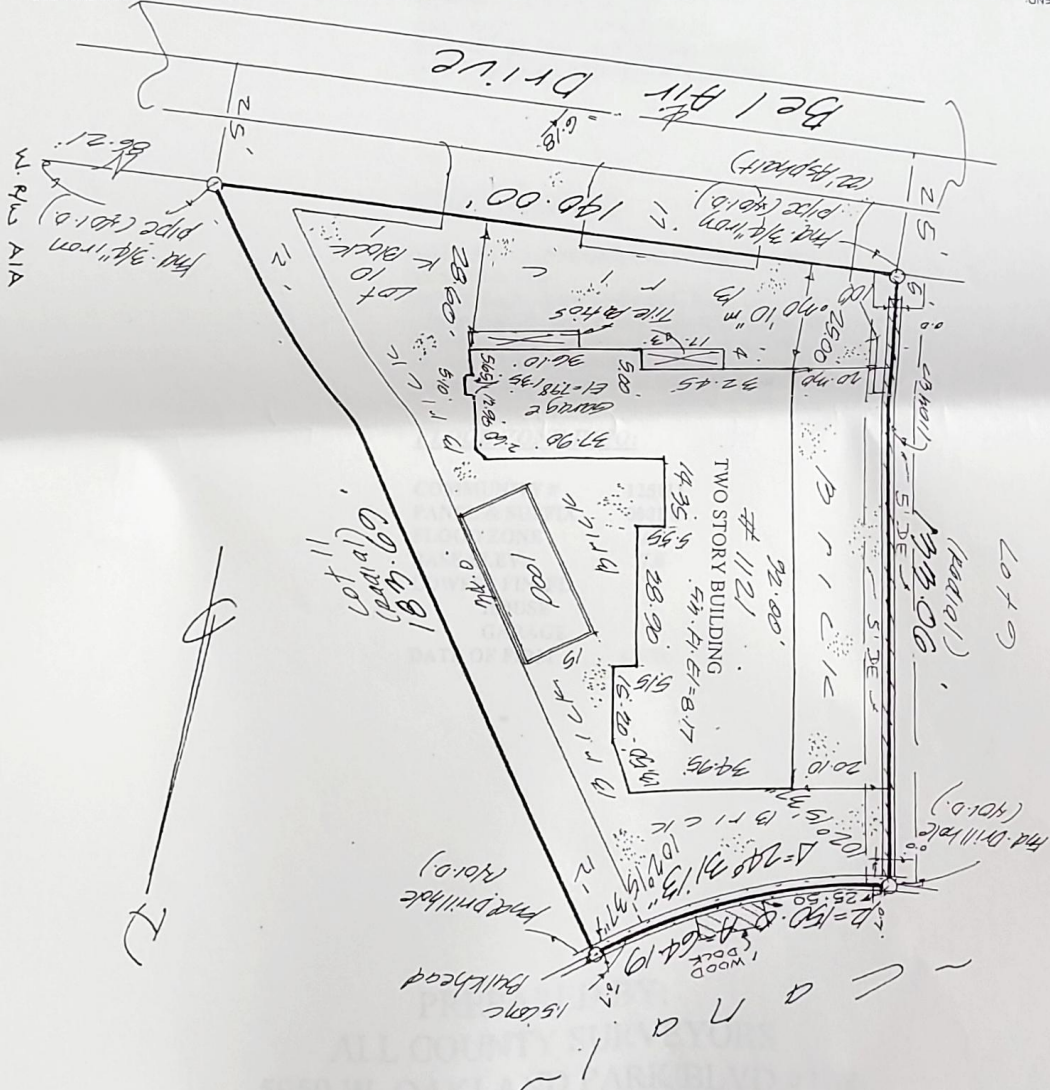

PROPERTY ADDRESS:
1121 BEL AIR DRIVE
BOCA RATON, FLORIDA

PROPERTY ADDRESS:

1121 BEL AIRE DRIVE
BOCA RATON, FLORIDA

LEGAL DESCRIPTION:

LOT 10, BLOCK 1 OF "BEL
LIDO" ACCORDING TO
THE PLAT THEREOF, AS
RECORDED IN PLAT BOOK 25,
PAGE 97 OF THE PUBLIC RECORDS
OF PALM BEACH COUNTY, FLORIDA

CERTIFICATIONS:

JOSEPH R. & DOLORES M. CANNIZZARO,
Husband & wife
DICKENSON, REX & SLOAN, P.A.
ATTORNEYS' TITLE INSURANCE FUND, INC.
WASHINGTON MUTUAL BANK, F.A. ITS
SUCCESSORS AND/OR ASSIGNS
CHAPIN, ARMSTRONG & BALLERANO, P.A.

FLOOD ZONE INFO:

COMMUNITY #	125111
PANEL & SUFFIX	0001 C
FLOOD ZONE	A5
BASE ELEV:	7.0
LOWEST FIN. FL.	
HOUSE	
GARAGE	
DATE OF FIRM	6/2/92

PREPARED BY:
ALL COUNTY SURVEYORS
5950 W. OAKLAND PARK BLVD #108
LAUDERHILL, FL 33313
1(800)860-9119