


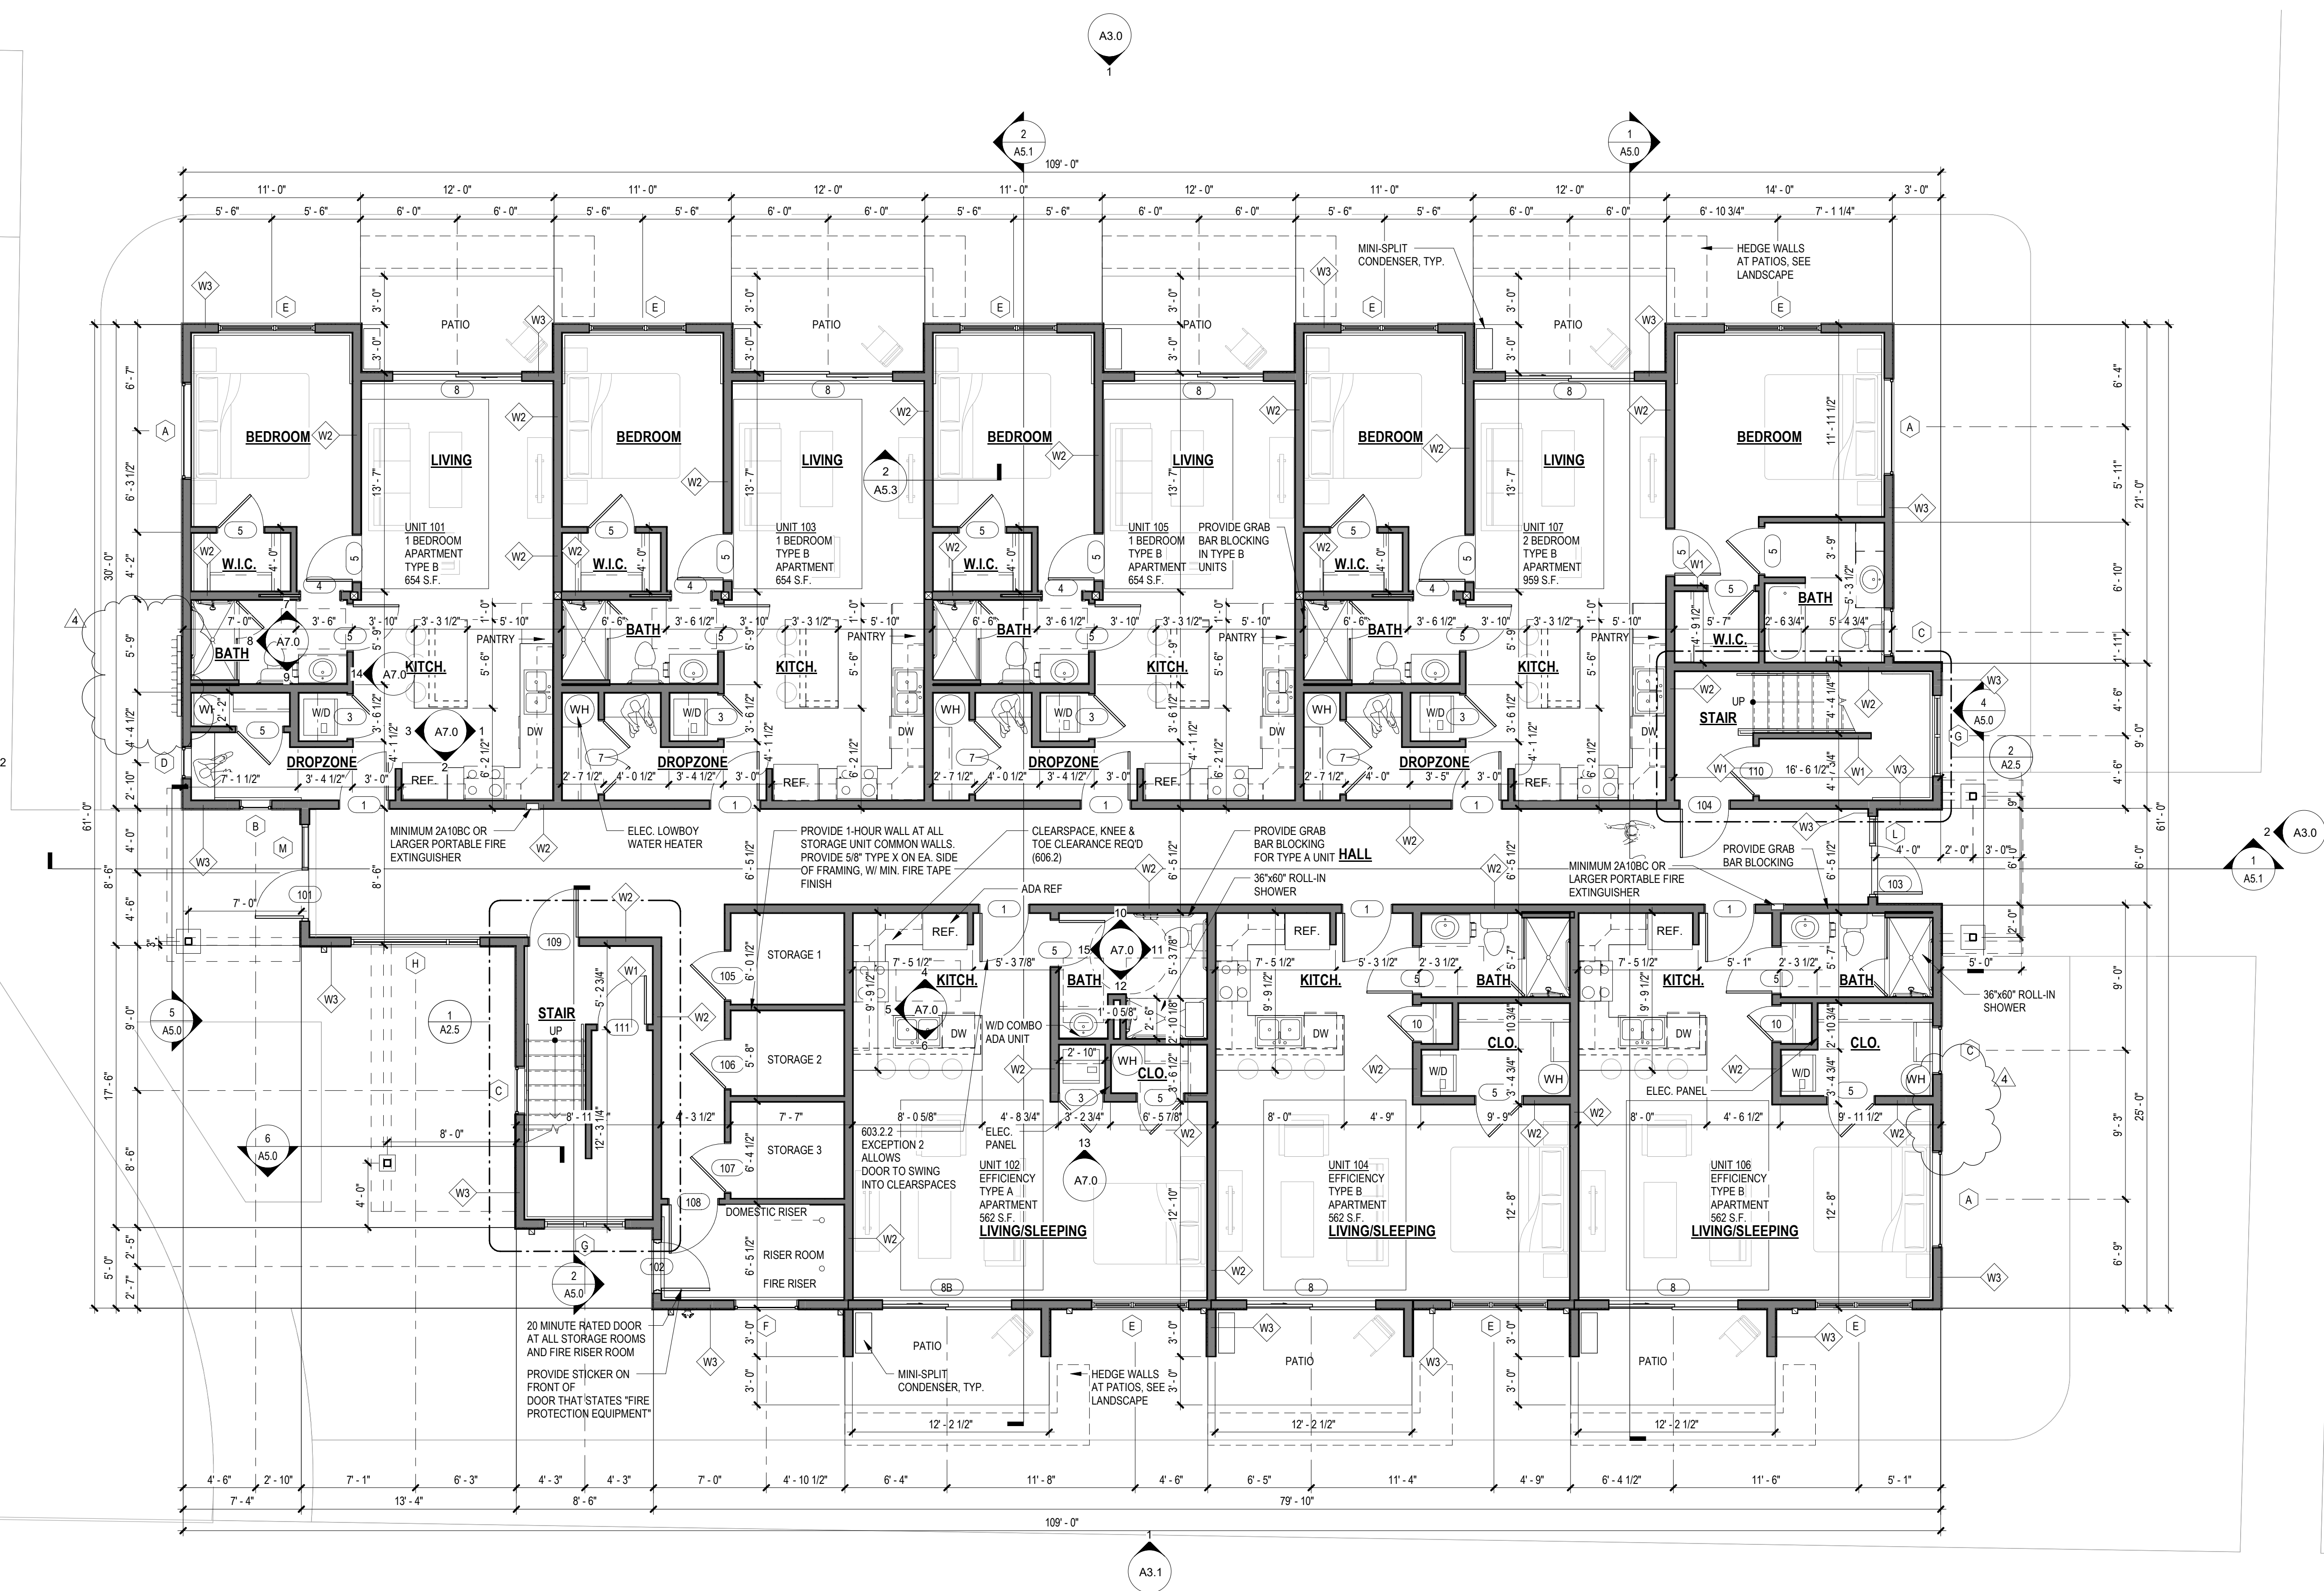

NOTES:
PENETRATIONS OF FIRE-RESISTIVE WALLS, FLOOR-CEILINGS, AND ROOF-CEILINGS SHALL BE PROTECTED AS REQ'D IN IBC SECTION 714.
THRESHOLDS IN ROLL-IN TYPE SHOWER COMPARTMENTS SHALL BE 1/2" MAX. IN HEIGHT IN ACCORDANCE WITH SECTION 303.
FIRE ALARM SYSTEM REQUIRED. SEE "FIRE SPRINKLER_HYD CALCS.PDF", "FIRE SPRINKLER_LAYOUT.PDF", AND "FIRE SPRINKLER_MATERIALS.PDF".

OCCUPANT TABULATIONS		FLOOR AREAS	
FIRST FLOOR	30 OCC.	FIRST FLOOR	5,848 S.F.
SECOND FLOOR	30 OCC.	SECOND FLOOR	5,848 S.F.
THIRD FLOOR	30 OCC.	THIRD FLOOR	5,848 S.F.
TOTAL	90 OCC.	TOTAL	17,544 S.F.


1 FIRST FLOOR PLAN
A2.1 3/16" = 1'-0"




DRAWN:	
CHECKED:	
JOB NO.: 20-051	
STATUS: PERMIT REVIEW	
REVISION SCHEDULE	NO.
	DESCRIPTION
	DATE
	BY:
	1
	2
	3
	4

ADDISON PLACE CONDOS

1242 THOMAS DRIVE
BOZEMAN, MT 59715

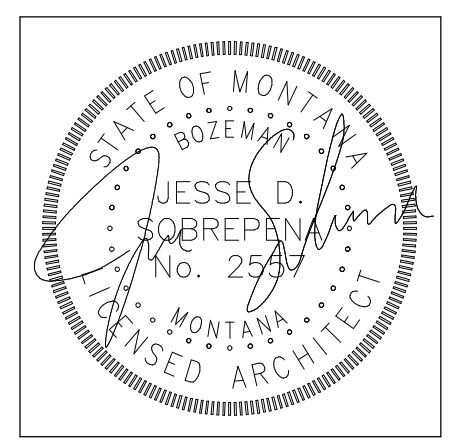

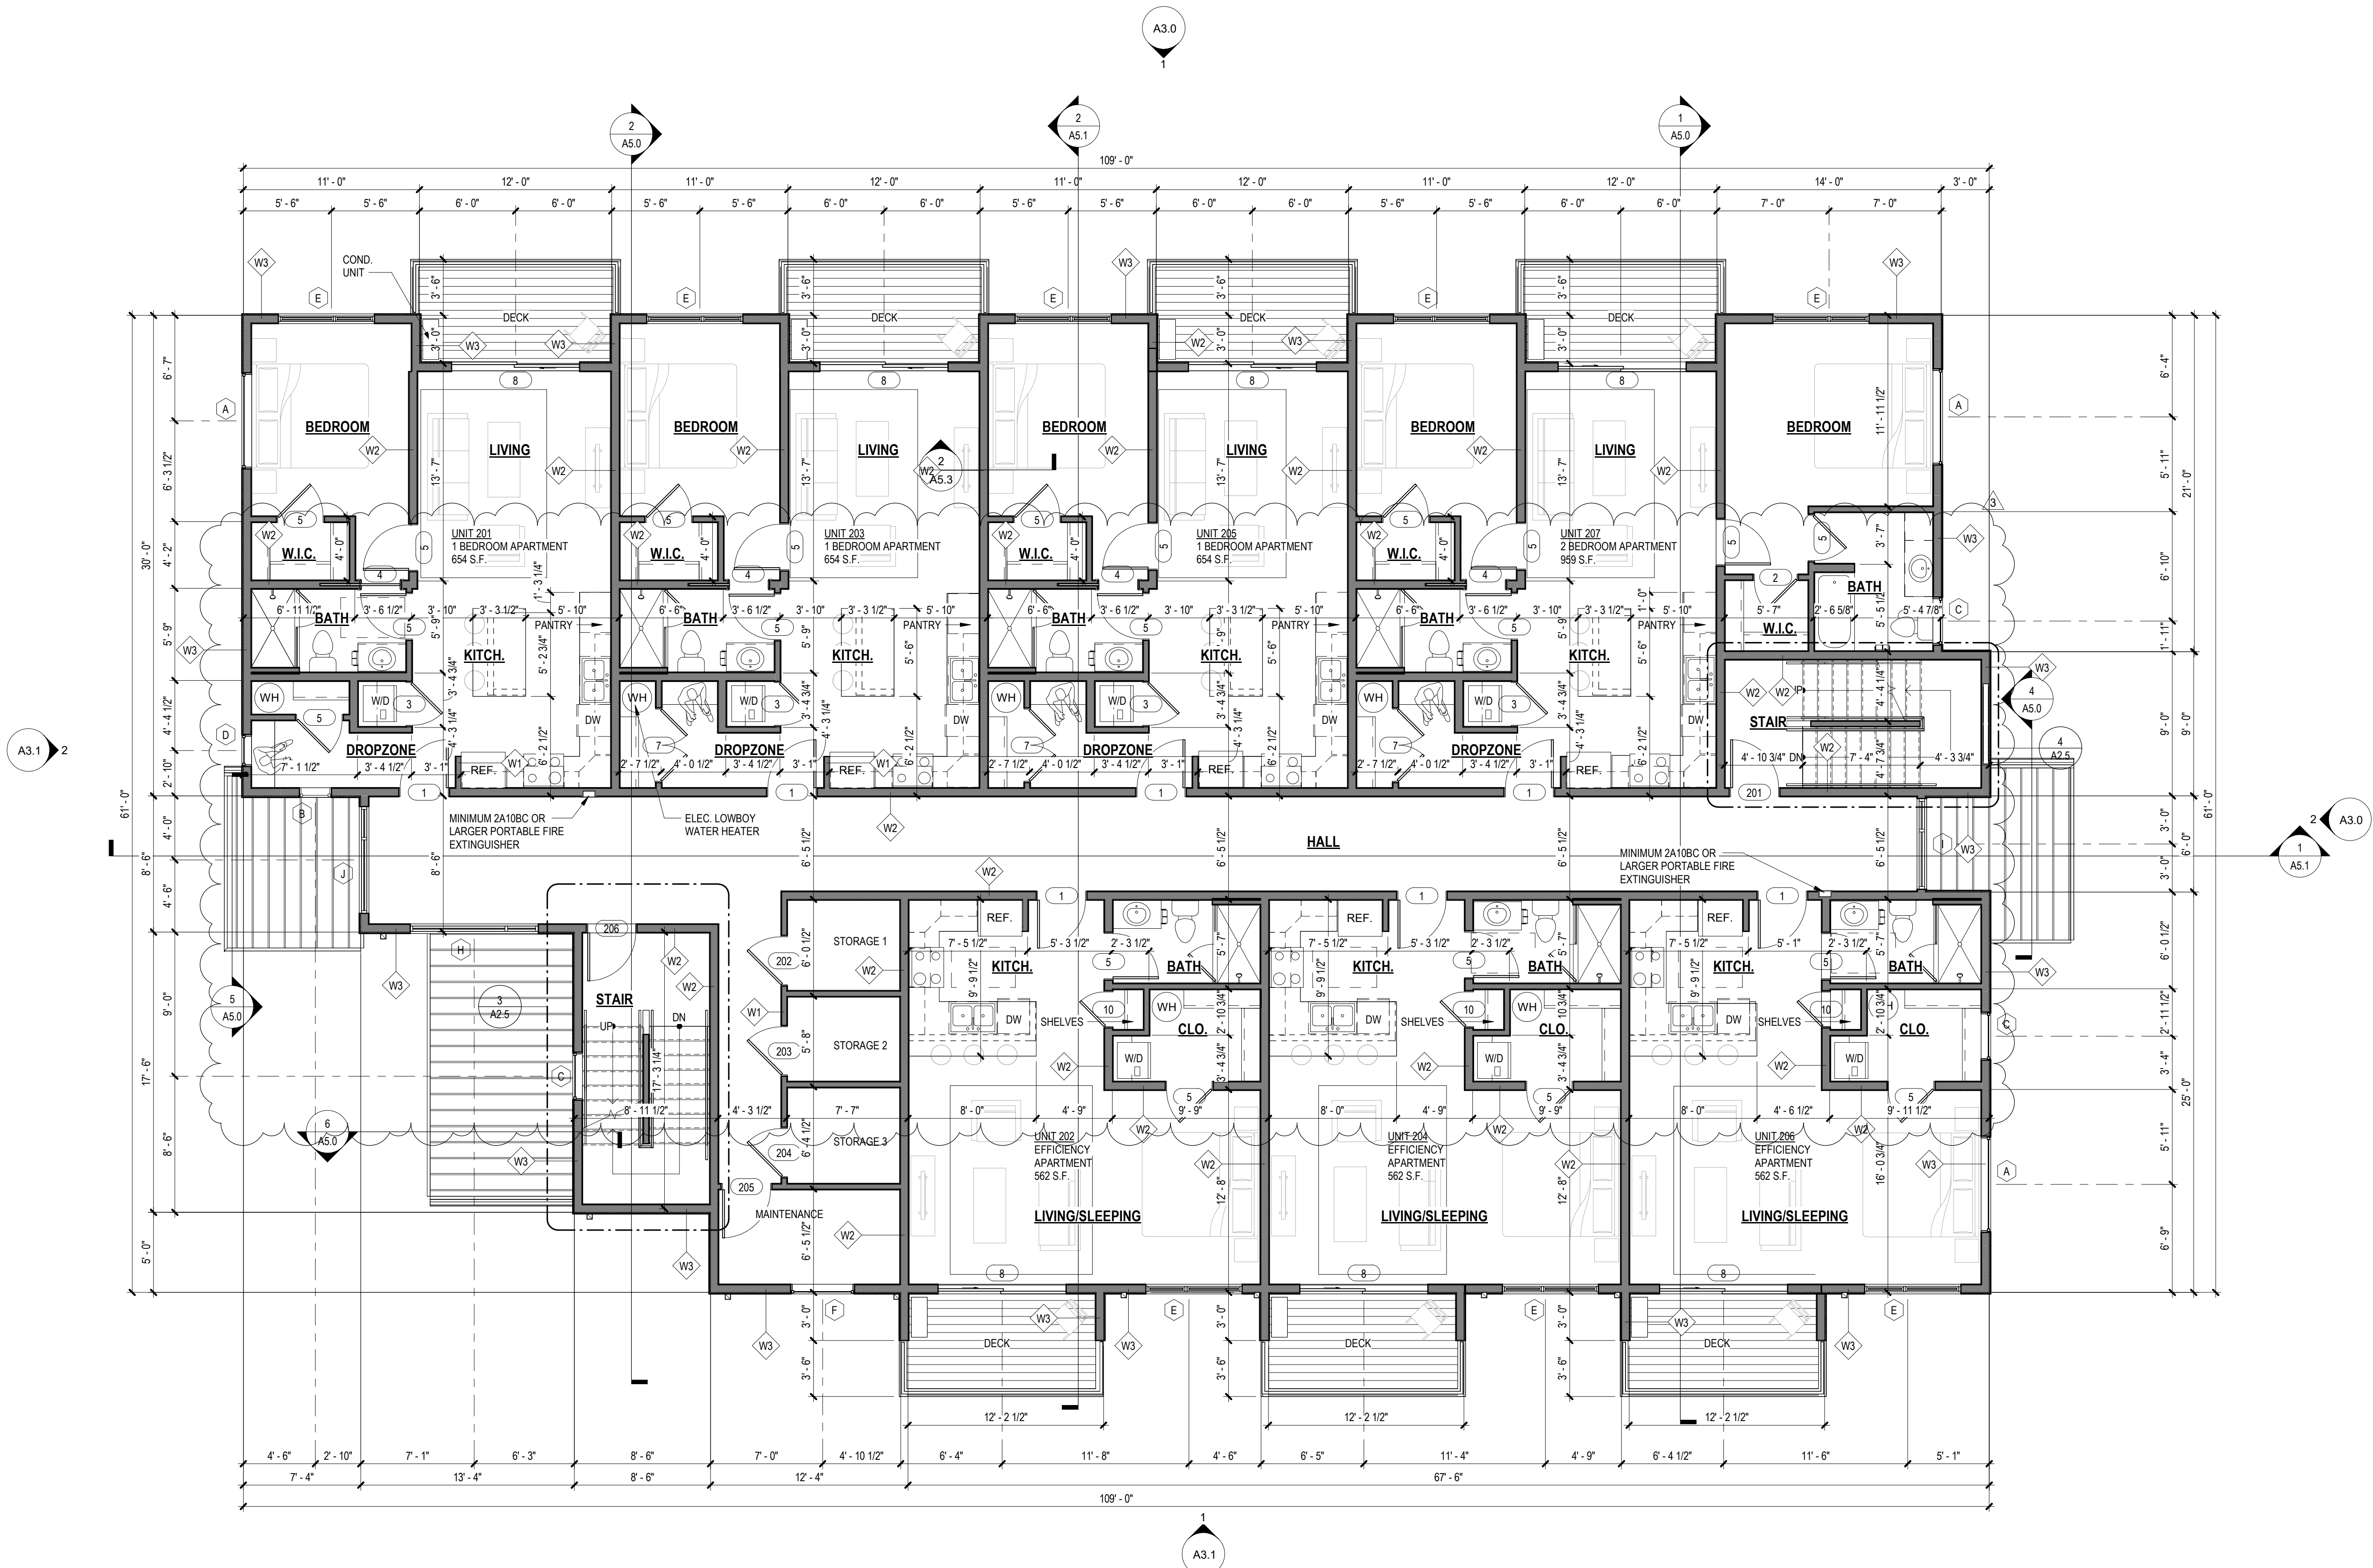

NOTES:
PENETRATIONS OF FIRE-RESISTIVE WALLS, FLOOR-CEILINGS, AND ROOF-CEILINGS SHALL BE PROTECTED AS REQ'D IN IBC SECTION 714.
THRESHOLDS IN ROLL-IN TYPE SHOWER COMPARTMENTS SHALL BE 1/2" MAX. IN HEIGHT IN ACCORDANCE WITH SECTION 303.
FIRE ALARM SYSTEM REQUIRED. SEE "FIRE SPRINKLER_HYD CALCS.PDF", "FIRE SPRINKLER_LAYOUT.PDF", AND "FIRE SPRINKLER_MATERIALS.PDF".

OCCUPANT TABULATIONS	
FIRST FLOOR	30 OCC.
SECOND FLOOR	30 OCC.
THIRD FLOOR	30 OCC.
TOTAL	90 OCC.

FLOOR AREAS	
FIRST FLOOR	5,848 S.F.
SECOND FLOOR	5,848 S.F.
THIRD FLOOR	5,848 S.F.
TOTAL	17,544 S.F.


1
A2.2
SECOND FLOOR PLAN
3/16" = 1'-0"



DRAWN:			
CHECKED:			
JOB NO.: 20-051			
STATUS: PERMIT REVIEW			
REVISION SCHEDULE			
NO.	DESCRIPTION	DATE	BY:
1	C.O.B. REVISIONS	08/10/2022	
3	C.O.B. REVISIONS	10/07/2022	

ADDISON PLACE CONDOS


1242 THOMAS DRIVE
BOZEMAN, MT 59715

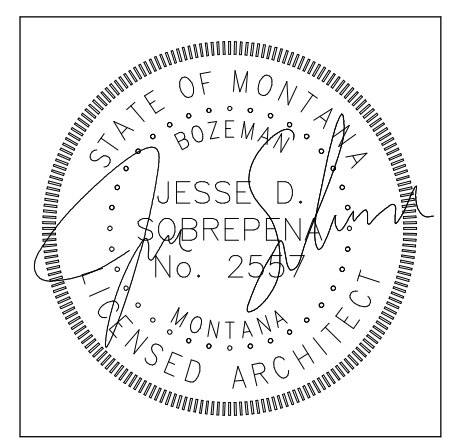

DRAWN:	
CHECKED:	
JOB NO.: 20-051	
STATUS: PERMIT REVIEW	
REVISION SCHEDULE	BY:
	DATE:
	DATE:
NO.	DESCRIPTION:
	COB REVISIONS
	COB REVISIONS

ADDISON PLACE CONDOS

1242 THOMAS DRIVE
BOZEMAN, MT 59715

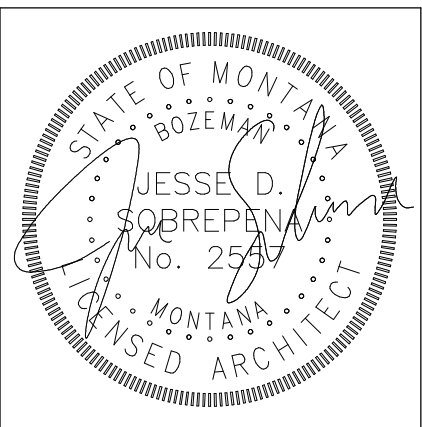

06/10/2022

A2.3

THIRD FLOOR PLAN

Copyright © 2022



NOTES:
PENETRATIONS OF FIRE-RESISTIVE WALLS, FLOOR-CEILINGS, AND ROOF-CEILINGS SHALL BE PROTECTED AS REQ'D IN IBC SECTION 714.
THRESHOLDS IN ROLL-IN TYPE SHOWER COMPARTMENTS SHALL BE 1/2" MAX. IN HEIGHT IN ACCORDANCE WITH SECTION 303.
FIRE ALARM SYSTEM REQUIRED. SEE "FIRE SPRINKLER_HYD CALCS.PDF", "FIRE SPRINKLER_LAYOUT.PDF", AND "FIRE SPRINKLER_MATERIALS.PDF".

OCCUPANT TABULATIONS	
FIRST FLOOR	30 OCC.
SECOND FLOOR	30 OCC.
THIRD FLOOR	30 OCC.
TOTAL	90 OCC.

FLOOR AREAS	
FIRST FLOOR	5,848 S.F.
SECOND FLOOR	5,848 S.F.
THIRD FLOOR	5,848 S.F.
TOTAL	17,544 S.F.

1 THIRD FLOOR PLAN
A2.3 3/16" = 1'-0"